


PLAN	SURVEYED	DATE
	NOTE BOOK	BY
	ALIGNMENT CHECKED	
	RT. OF WAY CHECKED	

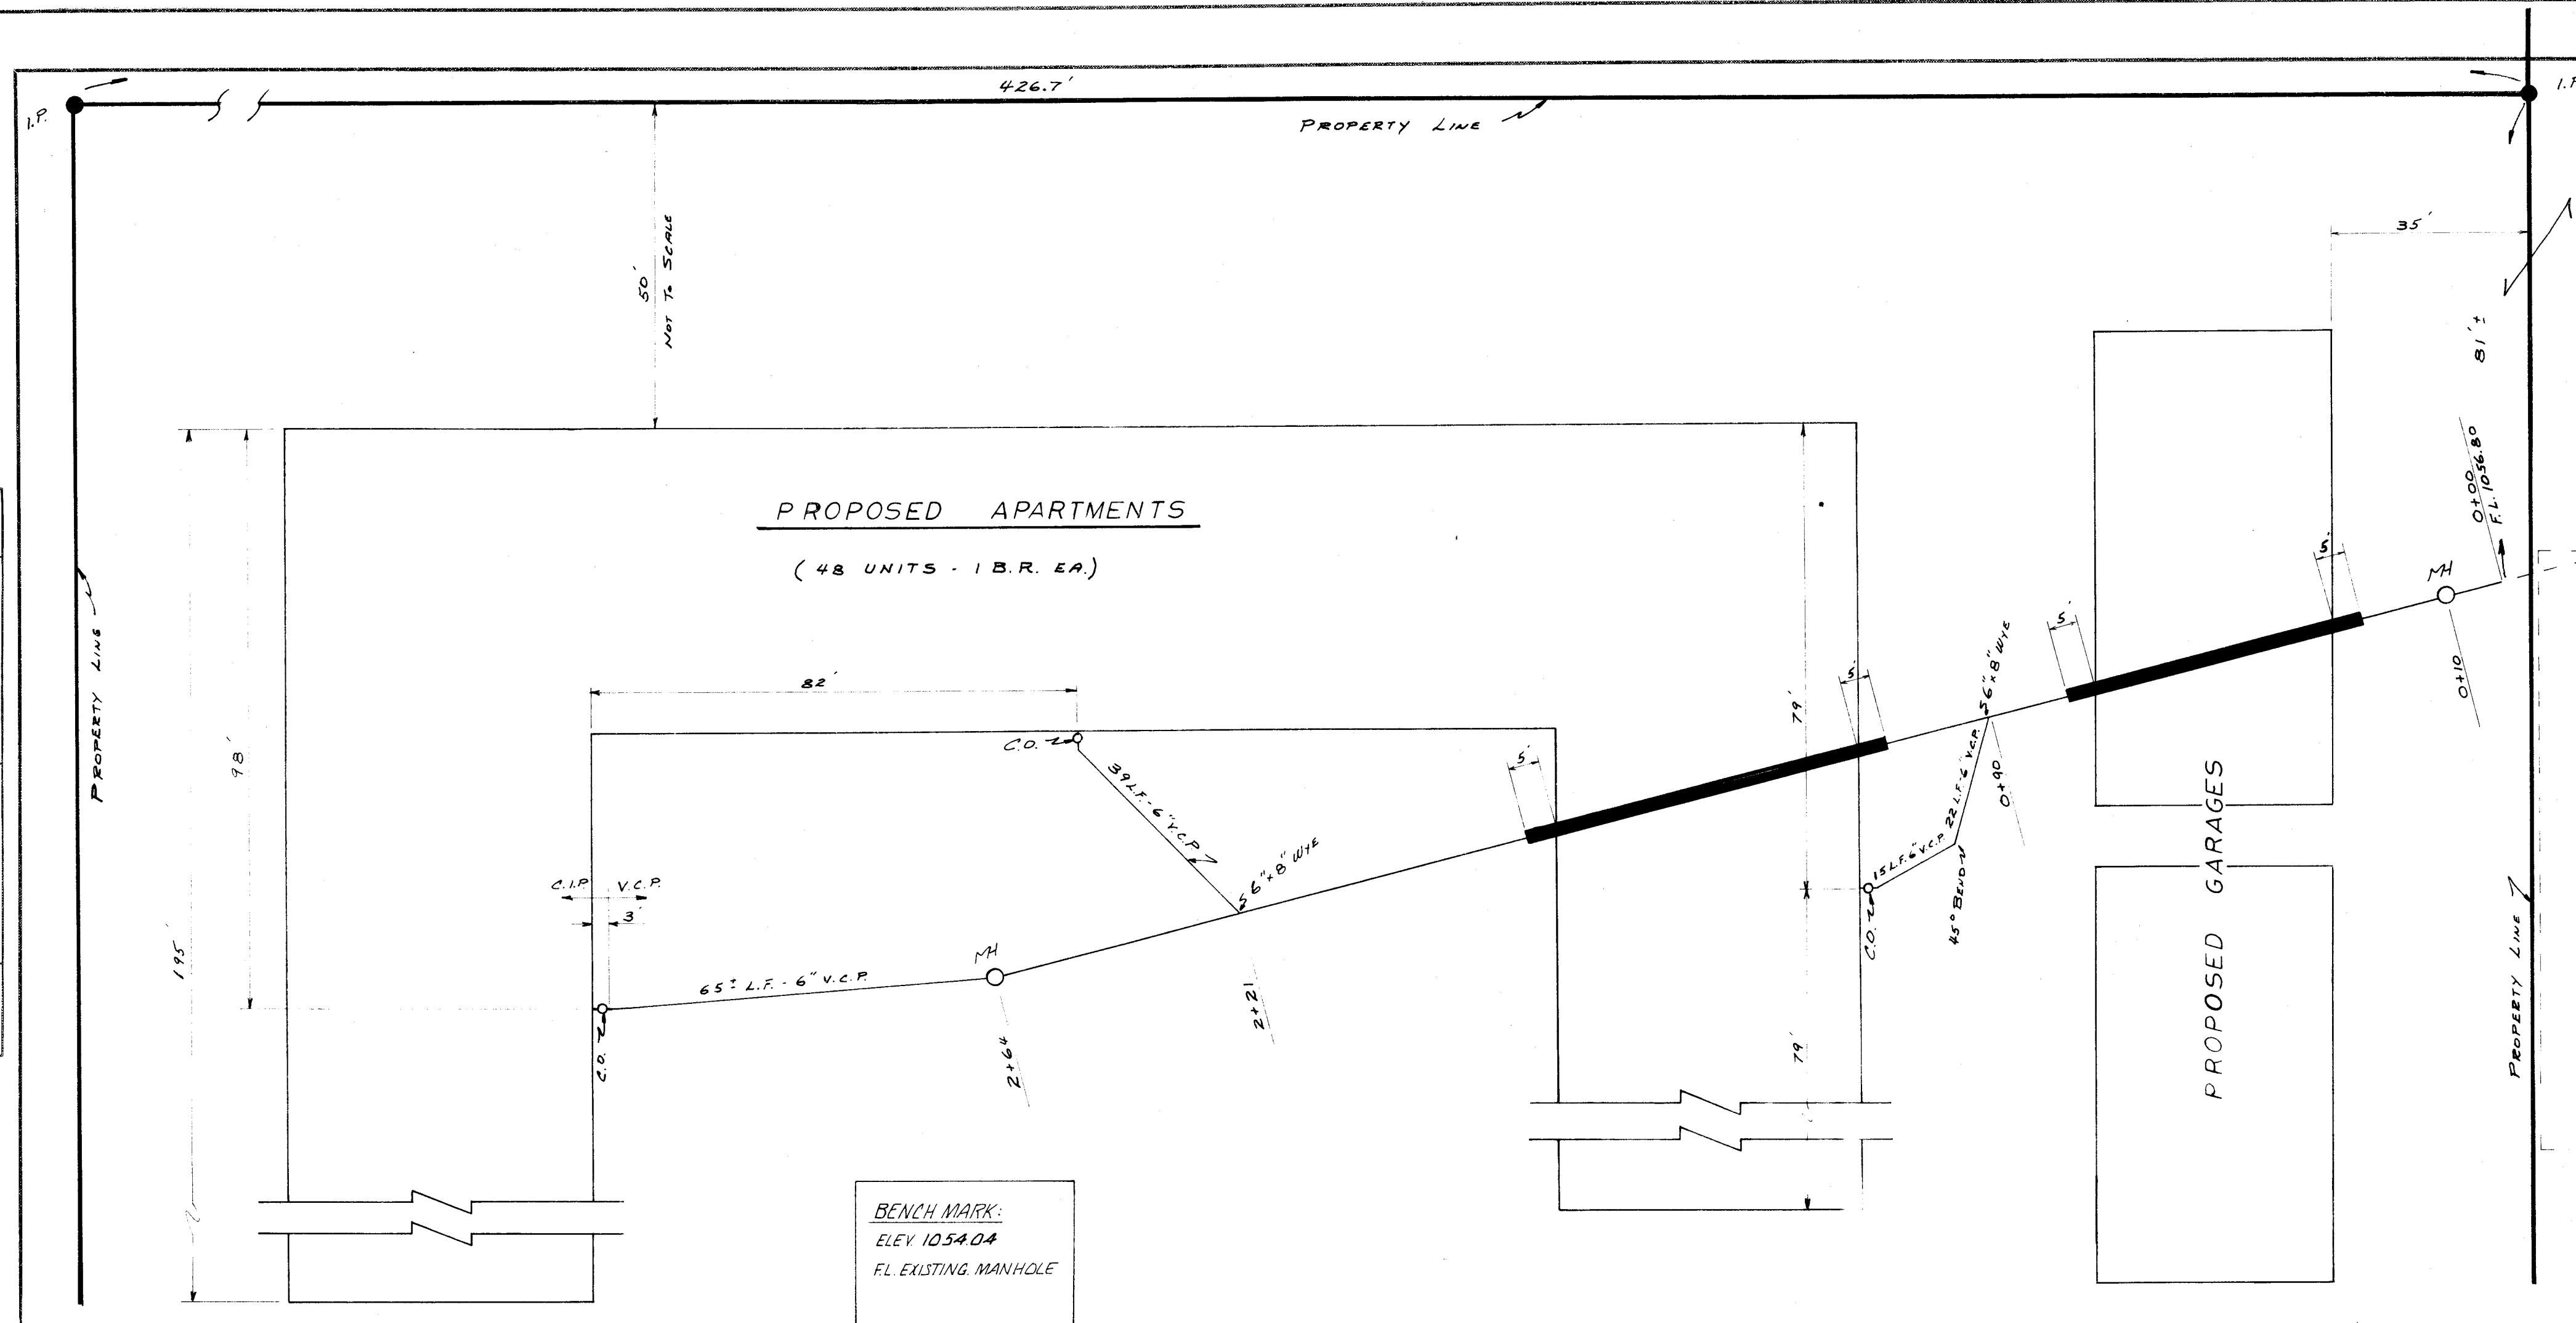


APPROVED THIS _____ DAY OF _____ 1972


MASSILLON CITY ENGINEER

APPROVED THIS _____ DAY OF _____ 1972

STARK COUNTY SANITARY ENGINEER

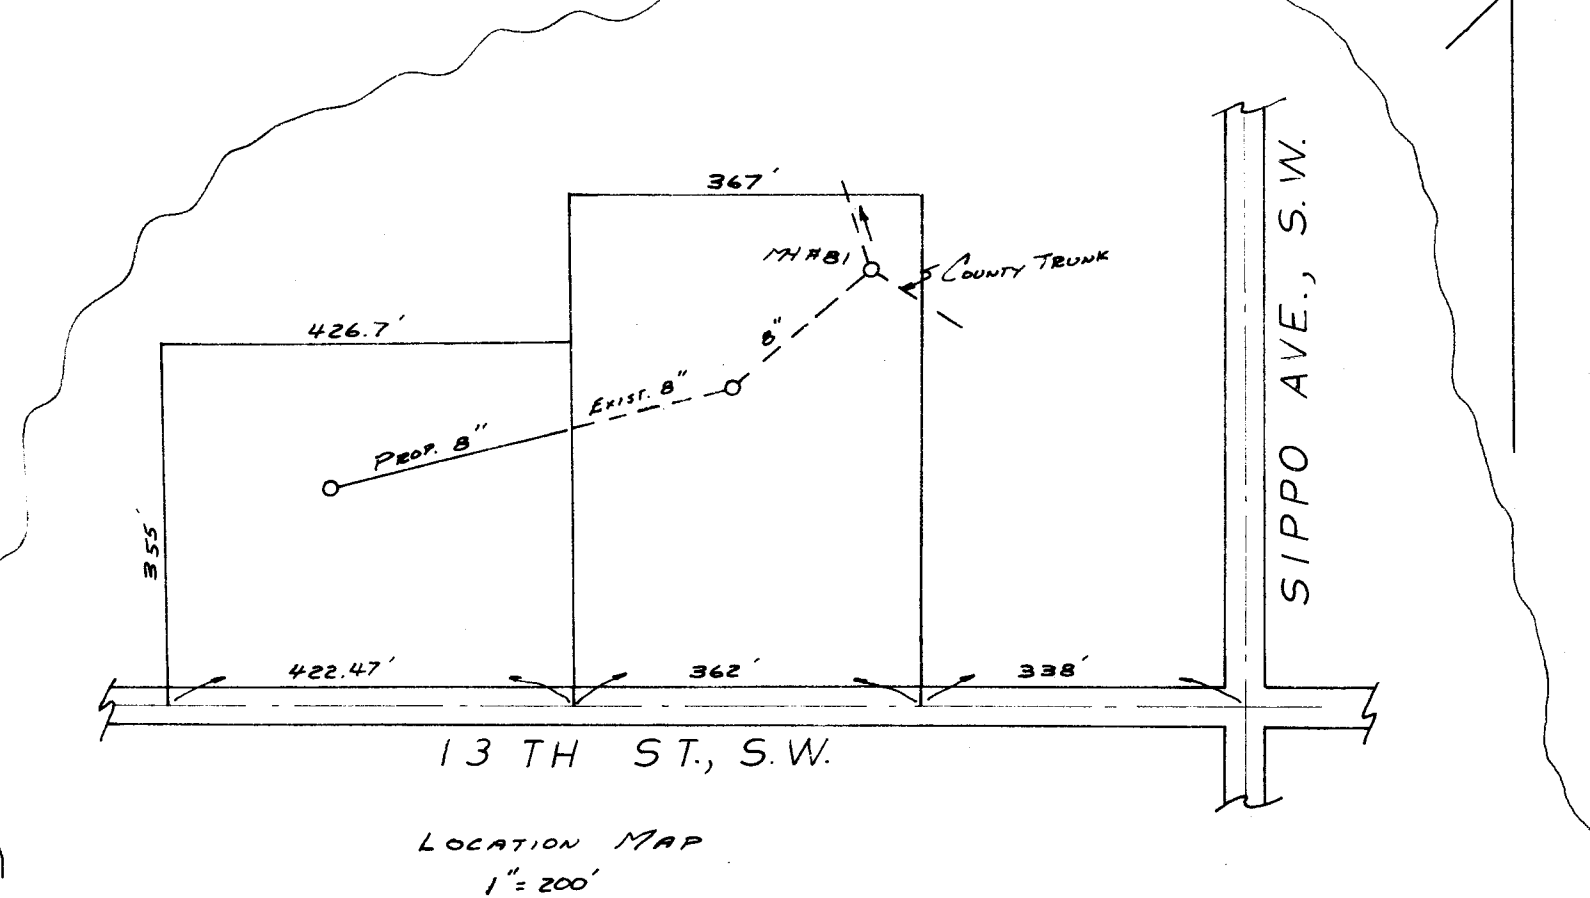

PROFILE	SURVEYED	DATE
	NOTE BOOK	BY
	GRADES CHECKED	
	STRUCTURE NOTATIONS CHKD.	

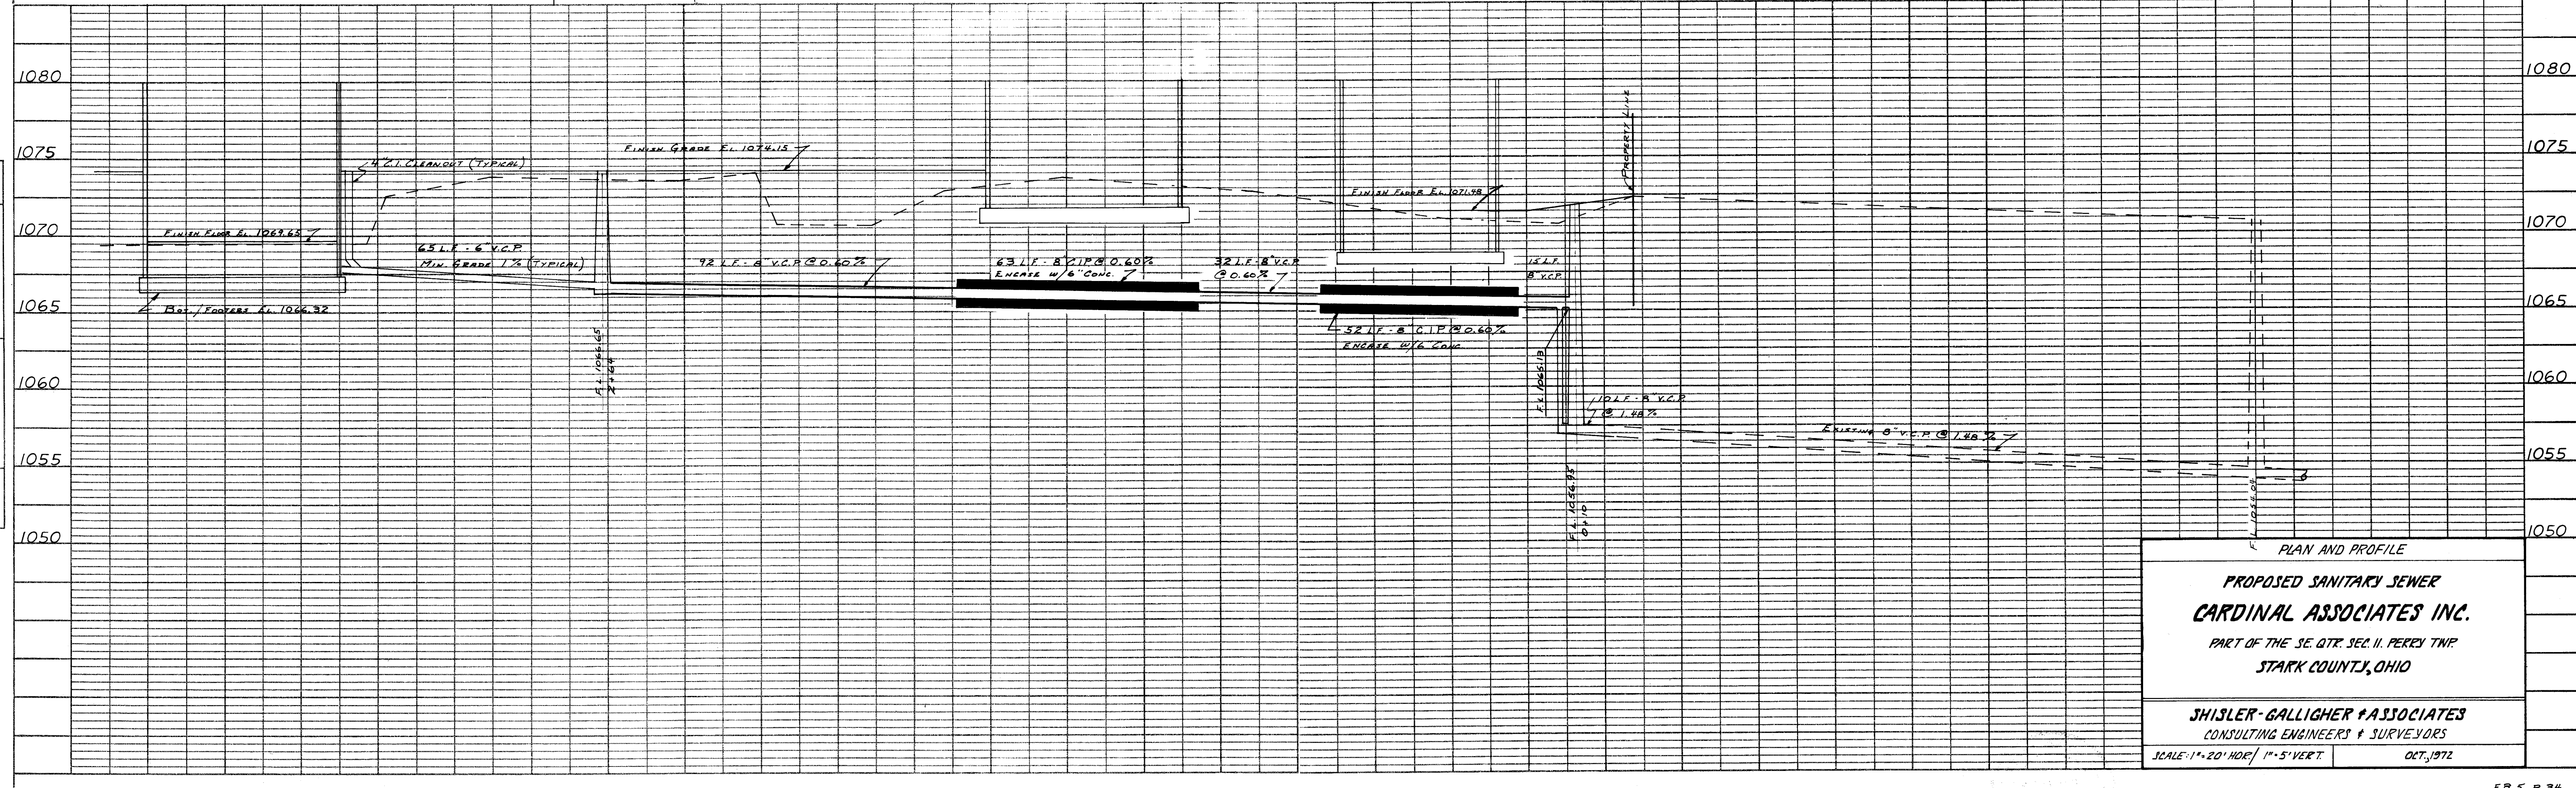

PLAN AND PROFILE
PROPOSED SANITARY SEWER
CARDINAL ASSOCIATES INC.
 PART OF THE SE. QTR. SEC. 11, PERRY TWP.
 STARK COUNTY, OHIO
SHISLER-GALLIGHER & ASSOCIATES
 CONSULTING ENGINEERS & SURVEYORS
 SCALE: 1"=20' HOR. / 1"=5' VERT. OCT, 1972

Richard G. Hunsinger 10/24/72