

GENERAL NOTES

THE LOCATIONS AND DEPTHS OF ALL UNDERGROUND UTILITIES SHOWN WERE OBTAINED FROM THE RESPECTIVE UTILITY OWNERS RECORDS AND SHISLER-HUNSINGER & ASSOC. DOES NOT GUARANTEE THEIR ACCURACY OR COMPLETENESS.

THE BACKFILLING OF ALL TRENCHES SHALL CONFORM TO STARK COUNTY STANDARDS.

FLOW IN EXISTING SANITARY SEWERS SHALL BE MAINTAINED AT ALL TIMES.

PRIOR TO CONSTRUCTION THE CONTRACTOR SHOULD CONTACT THE OHIO BELL TELEPHONE CO. (216-456-0946) AND THE EAST OHIO GAS CO. (216-456-0535 & 456-8151) FOR ASSISTANCE IN VERIFYING THEIR RESPECTIVE UTILITY LOCATIONS.

FIRE HYDRANT TO BE LOCATED AT STA 3+80 TO BE FURNISHED BY CITY OF CANTON.

MAINTAIN 4' 3\"/>

ESTIMATED QUANTITIES

QUANTITY	UNIT	DESCRIPTION
SANITARY SEWER		
459	L.F.	8\"/>
90	L.F.	6\"/>
6	EA.	8\"/>
6	EA.	6\"/>
1	EA.	8\"/>
2	EA.	STD. SAN. MANHOLES (16 V.F.)
WATER		
440	L.F.	12\"/>
1	EA.	12\"/>
1	EA.	12\"/>
2	EA.	12\"/>
1	EA.	12\"/>
1	EA.	INSTALL FIRE HYDRANT

BENCH MARK
TOP OF CASTING OF SANITARY SEWER MANHOLE EAST SIDE OF WOODLAWN AVE. AT 4TH ST.
ELEV. 1103.34

PLANS PREPARED BY SHISLER-HUNSINGER & ASSOC.

Richard G. Hunsinger
REGISTERED ENGINEER & SURVEYOR

APPROVED BY:


MASSILLON CITY ENGINEER

APPROVED BY:

CANTON CITY ENGINEER

APPROVED BY:

STARK COUNTY, SANITARY ENGINEER

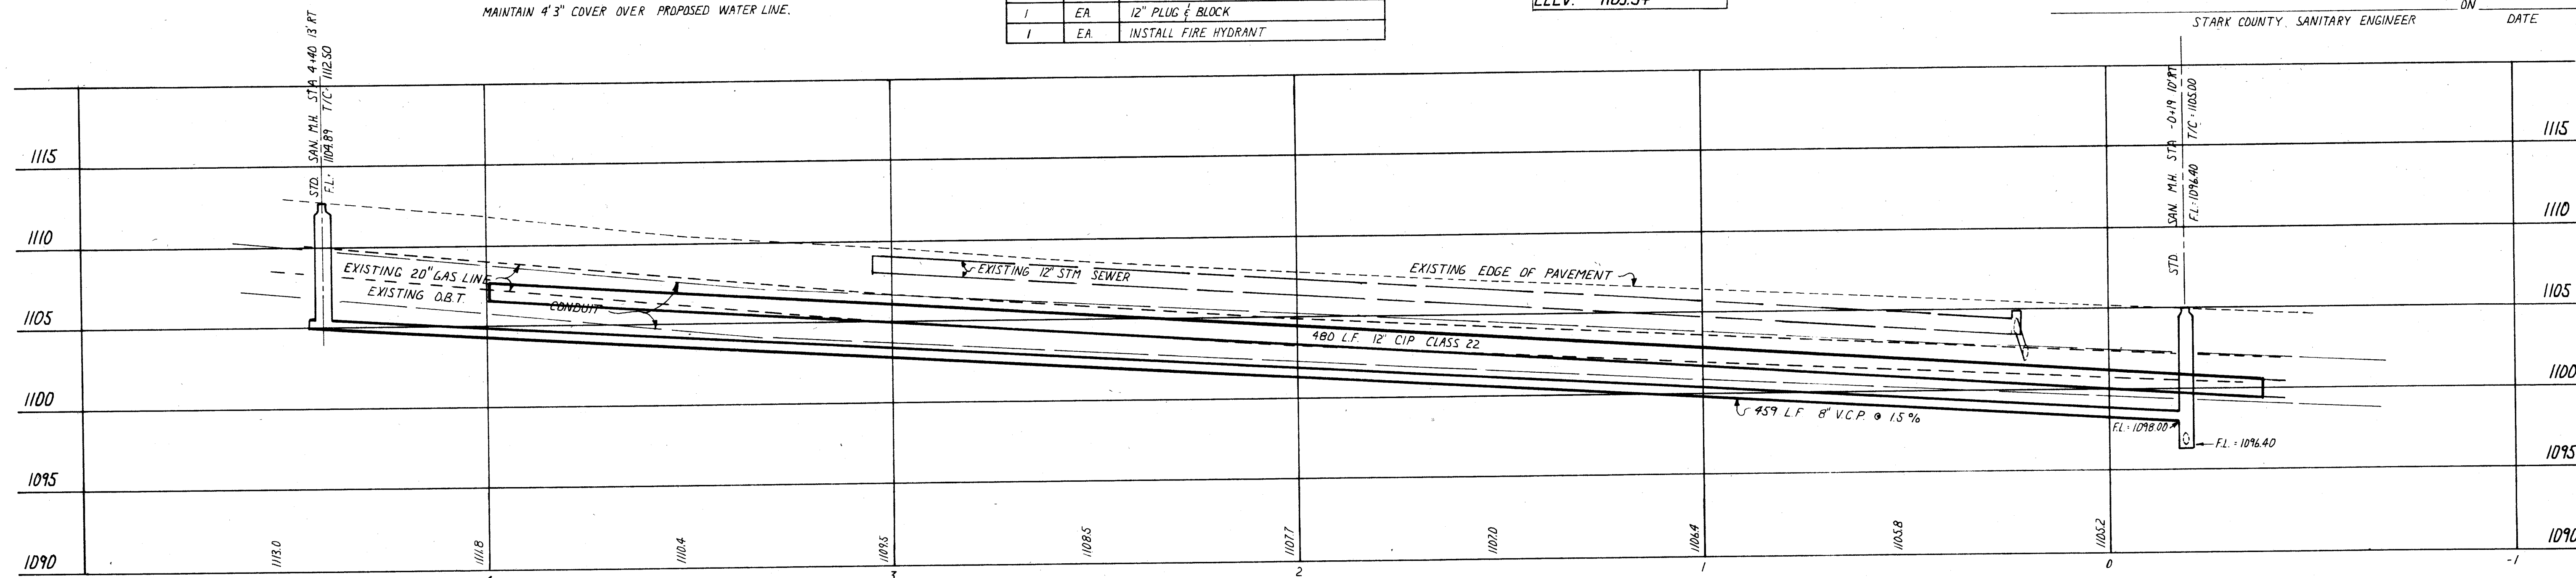

PLAN and PROFILE-WATER and SEWER
WOODLAWN AVE. N.W., CANTON, OHIO
IN
THE
NORTHWEST QTR., SECTION 12
PERRY TOWNSHIP

SHISLER-HUNSINGER and ASSOCIATES
CONSULTING ENGINEERS and SURVEYORS
2011 FULTON ROAD, N.W., CANTON, OHIO 44709

SCALE: 1"=20' HOR. 1"=5' VER. **APRIL, 1974** **SHEET 1 OF 1**

DRAWN **CS-93**

SHEET No.