



PLAN	BY	
	CHECKED	
	DATE	
	NO.	

PROFILE	BY	
	CHECKED	
	DATE	
	NO.	

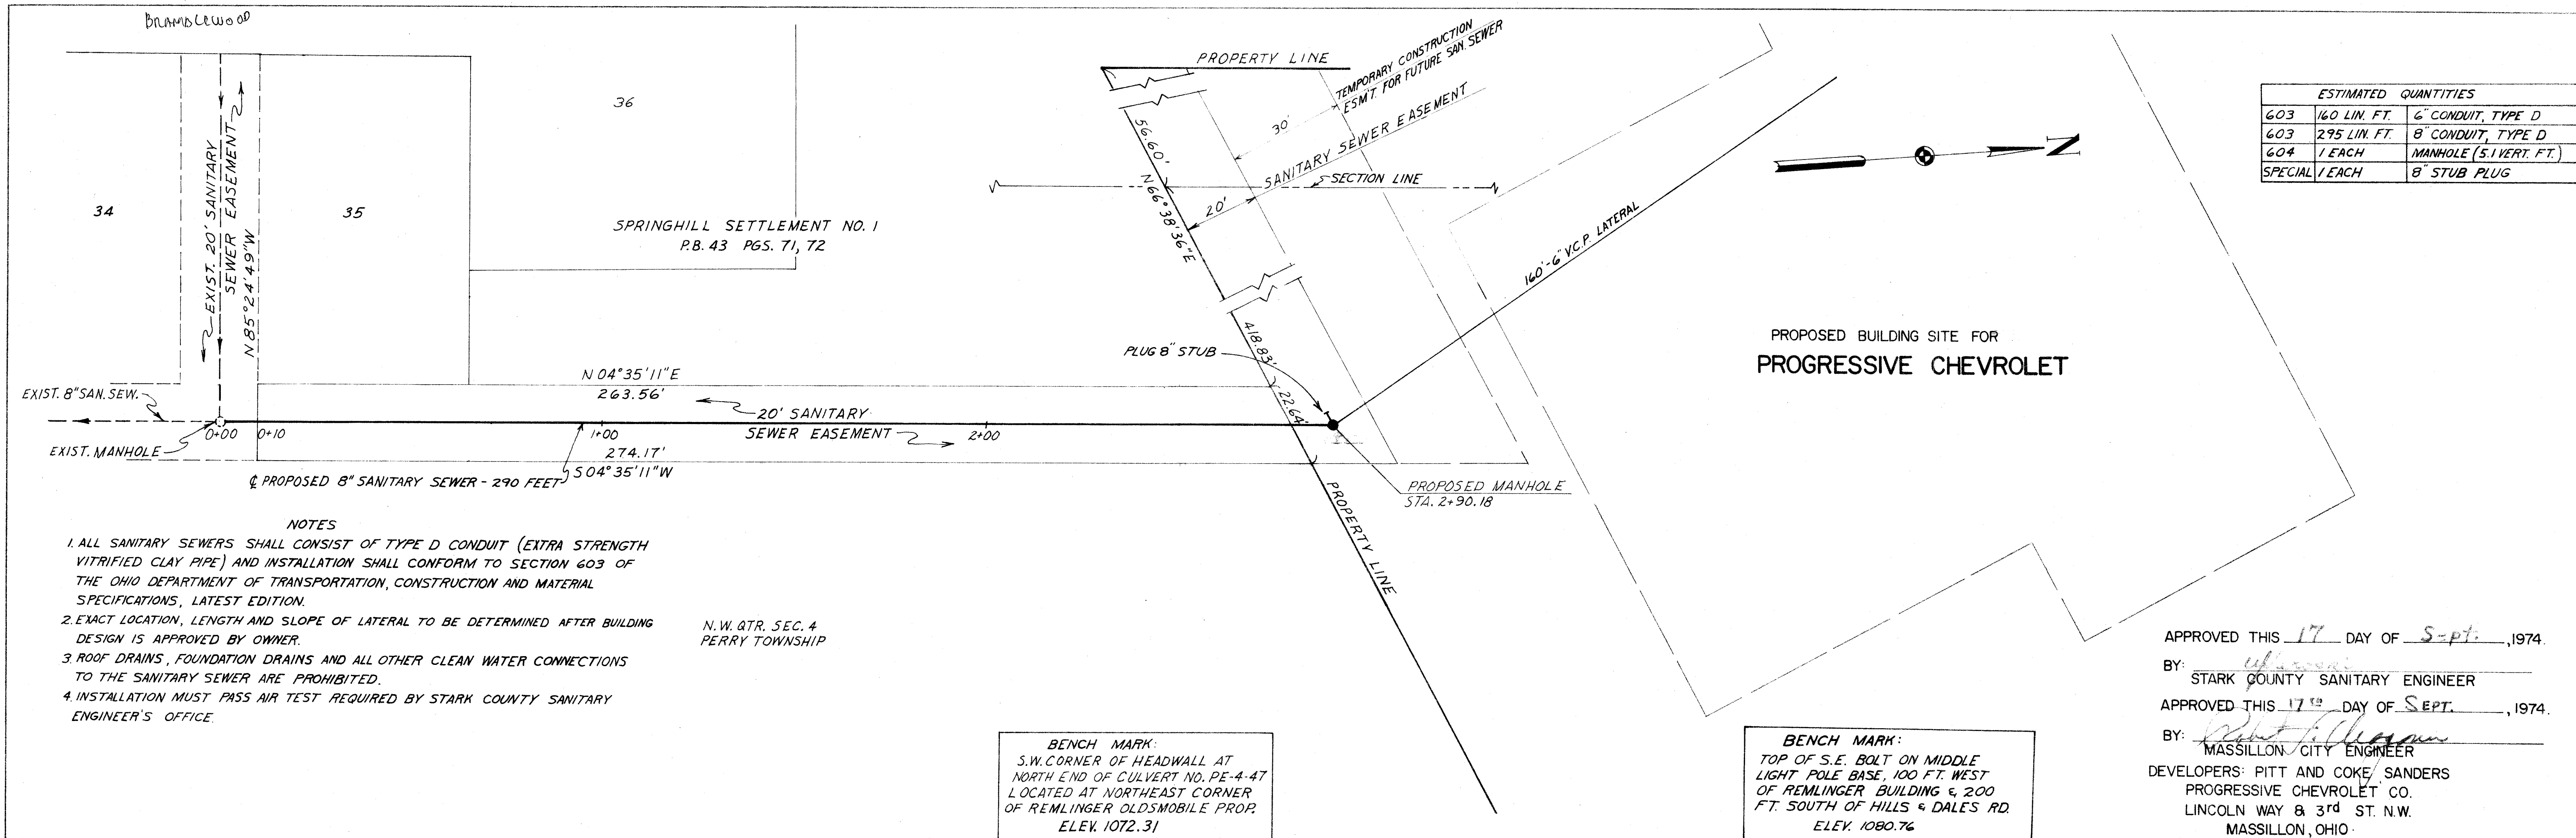

ESTIMATED QUANTITIES		
603	160 LIN. FT.	6" CONDUIT, TYPE D
603	295 LIN. FT.	8" CONDUIT, TYPE D
604	1 EACH	MANHOLE (5.1 VERT. FT.)
SPECIAL	1 EACH	8" STUB PLUG

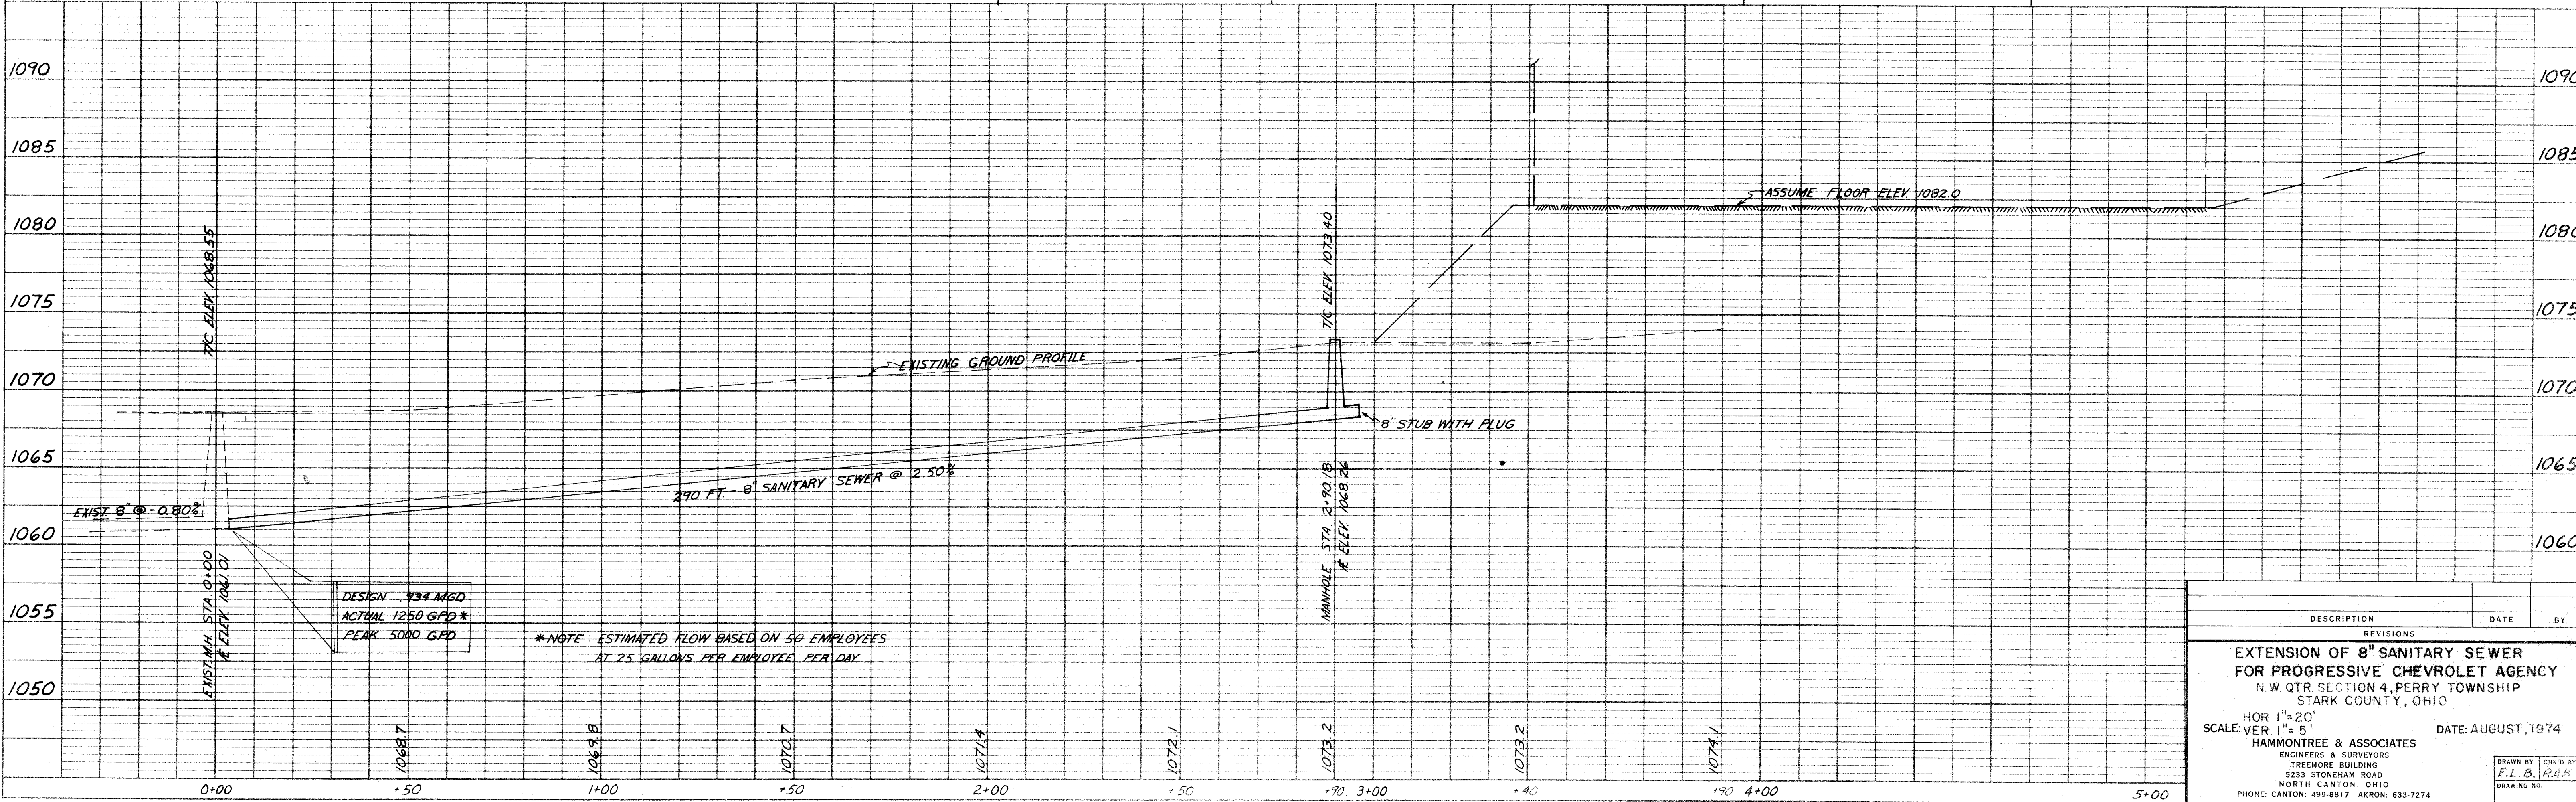

DESCRIPTION	DATE	BY
EXTENSION OF 8" SANITARY SEWER FOR PROGRESSIVE CHEVROLET AGENCY N.W. QTR. SECTION 4, PERRY TOWNSHIP STARK COUNTY, OHIO		
HOR. 1"=20' SCALE: VER. 1"=5'		DATE: AUGUST, 1974
HMMONTREE & ASSOCIATES ENGINEERS & SURVEYORS TREMONTRE BUILDING 3233 STONEHAM ROAD NORTH CANTON, OHIO PHONE: CANTON: 499-8817 AKRON: 633-7274		

PLATE 1-SINGLE PLAN AND PROFILE-FULL LINE
TELETYPE NATIONAL TRACING PAPER
INDIANAPOLIS, INDIANA
PRINTED IN U.S.A.

SANDERS-PROGRESSIVE CHEVROLET