

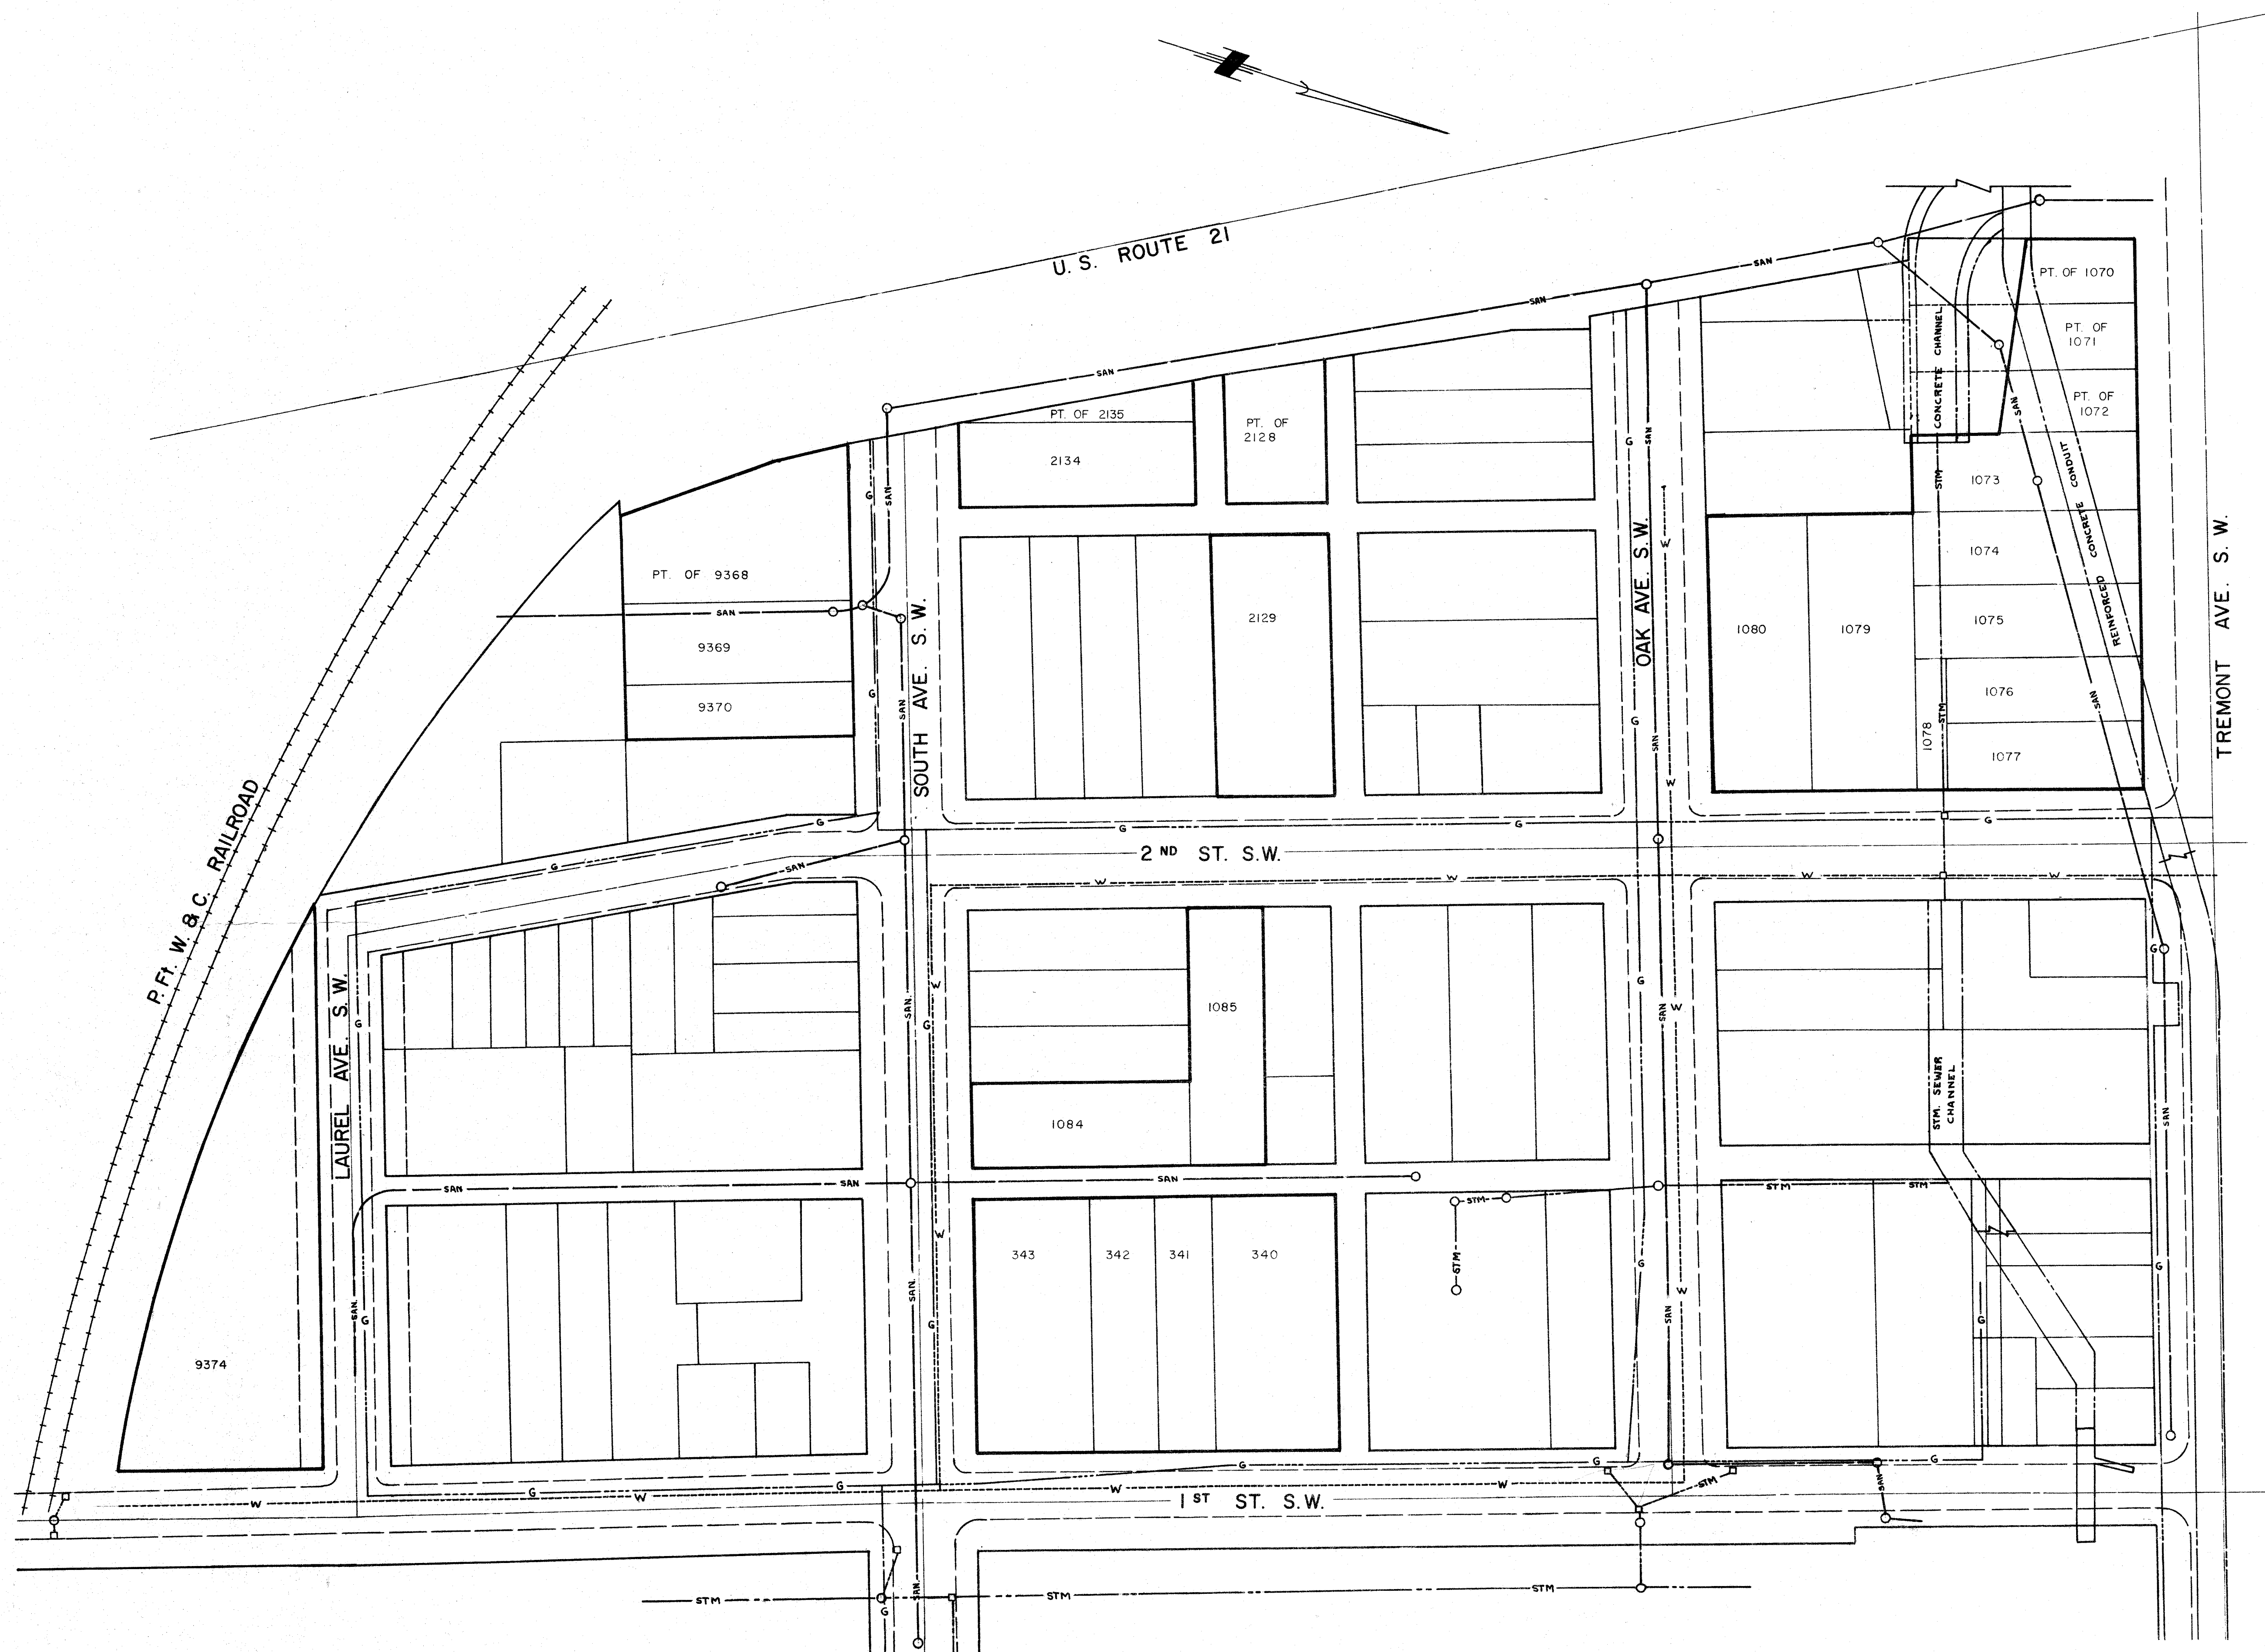


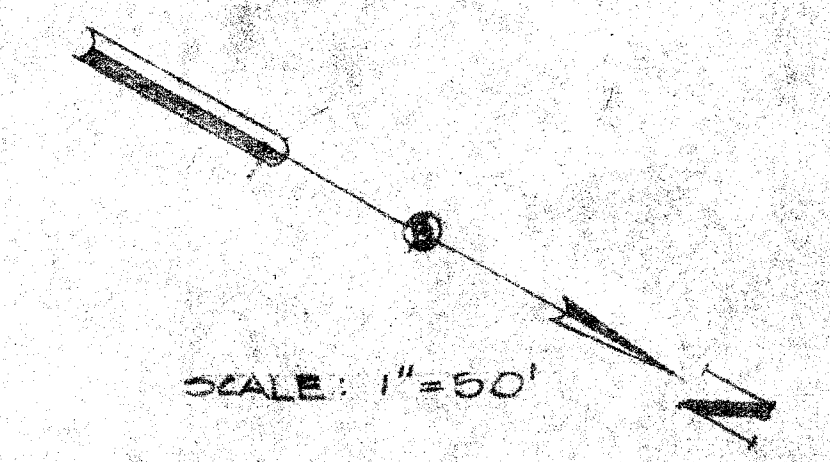

LEGEND	
	GAS LINE
	WATER LINE
	STORM SEWER
	SANITARY SEWER
	CURB LINE


CITY OF MASSILLON, OHIO	
LOWRY PRICE	
NEIGHBORHOOD DEVELOPMENT PROGRAM	
DR BY T. L. RIDGLEY	DEPT. OF PUBLIC SERVICE
CITY ENG. ROBERT WAGONER	ENGINEERING DIVISION
SCALE 1" = 50'	DATE 11/21/75
FILE NO. 15-237	ASS. NO. 15-237

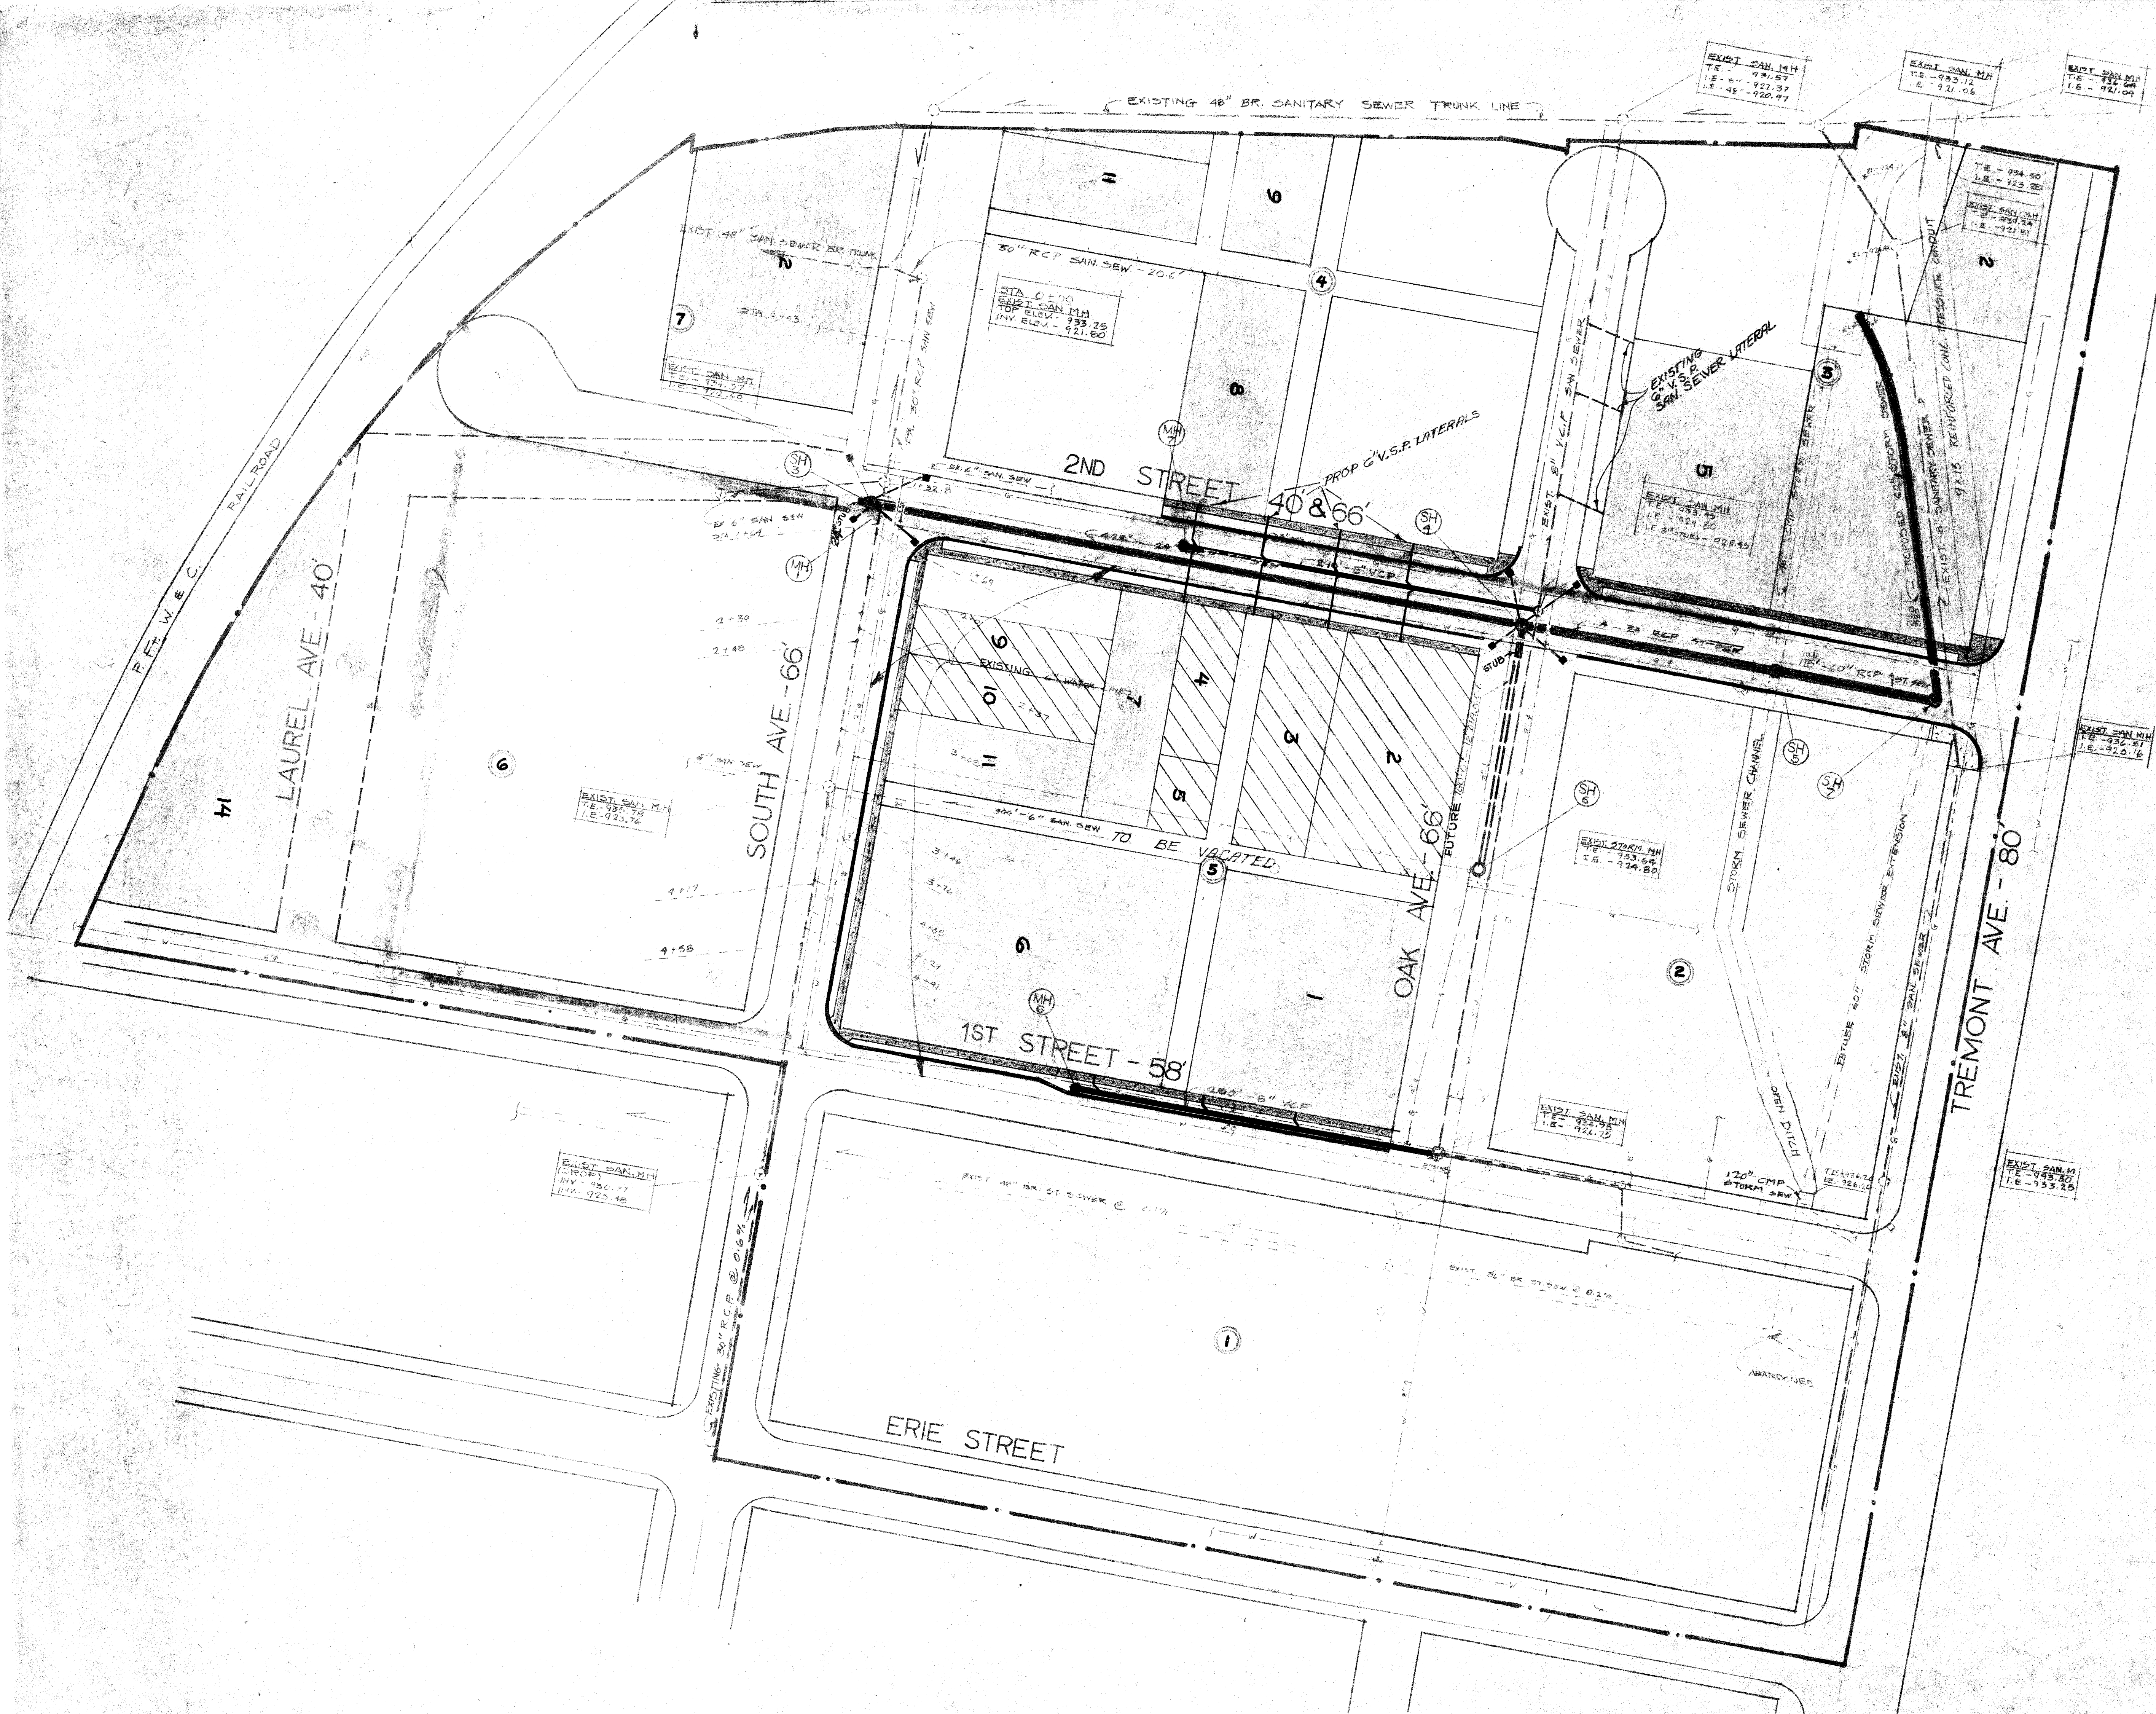

- LEGEND**
- SANITARY SEWER & MANHOLE - PROPOSED
 - SANITARY SEWER & MANHOLE - EXISTING
 - STORM SEWER & MANHOLE - PROPOSED
 - STORM SEWER & MANHOLE - EXISTING
 - W-W-W WATER LINE - PROPOSED
 - W-W-W WATER LINE - EXISTING
 - G-G-G GAS LINE - EXISTING
 - CATCH BASIN - PROPOSED
 - CATCH BASIN - EXISTING
 - CONTRACT LIMITS


- SHADED PARCELS = ACQUIRED BY PROJECT
- HATCHED PARCELS = BEING REQUESTED TO ADD TO MADE SALEABLE TRACT
- IMPROVEMENTS
RED - STML SEWER
ORANGE - SAN. SEWER
GREEN & YELLOW - STREET

SITE PLAN - UTILITIES	
CITY OF MASSILLON 2	
LOWRY-PRICE	
NEIGHBORHOOD DEVELOPMENT PROGRAM	
URBAN RENEWAL AREA OHIO PROJECT	
NOV 1972	REV NO NATURE OF REVISION
FILE NO P-297	ACQ NO 2608

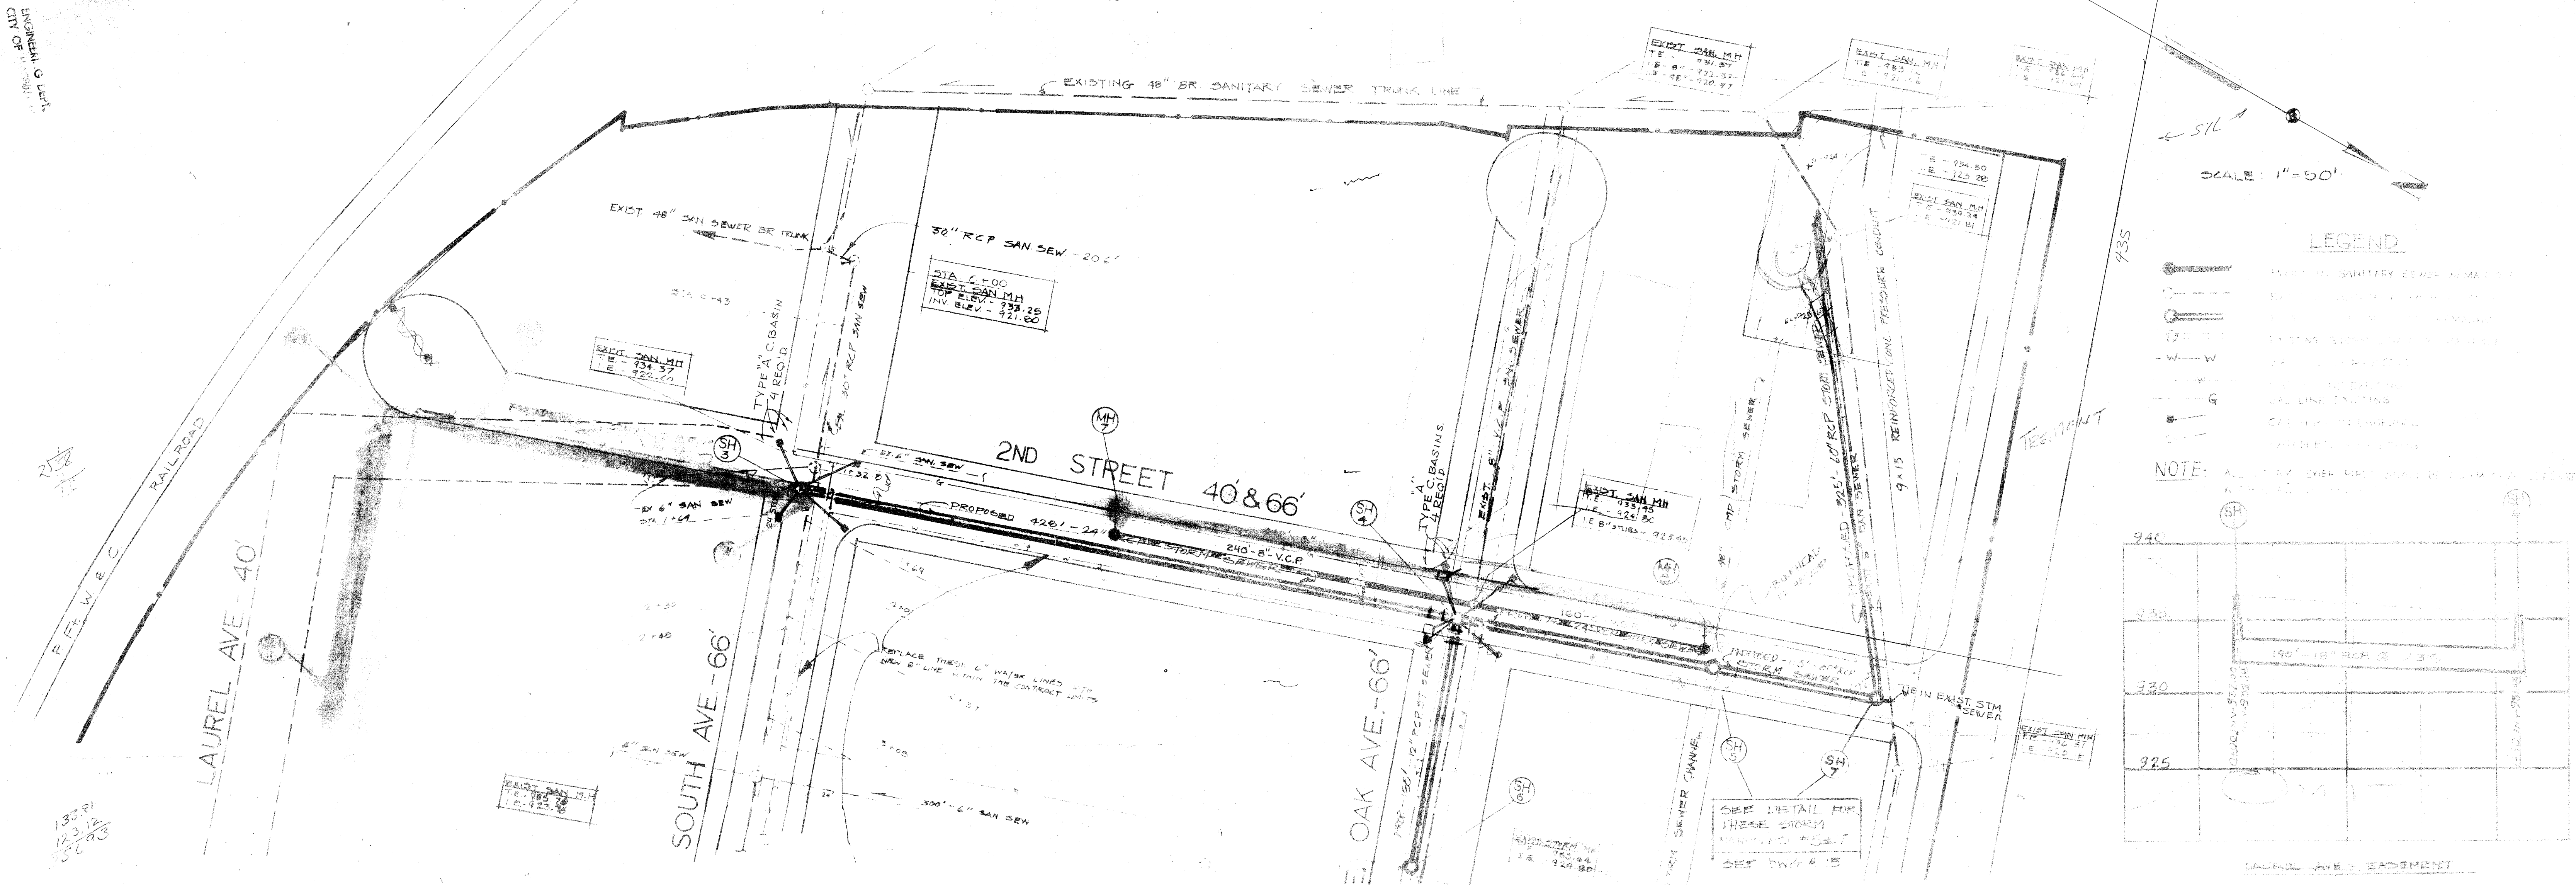

STORM SEWER PLAN AND PROFILE

HOR. SCALE: $1'' = 50'$
VERT. SCALE: $1'' = 5'$

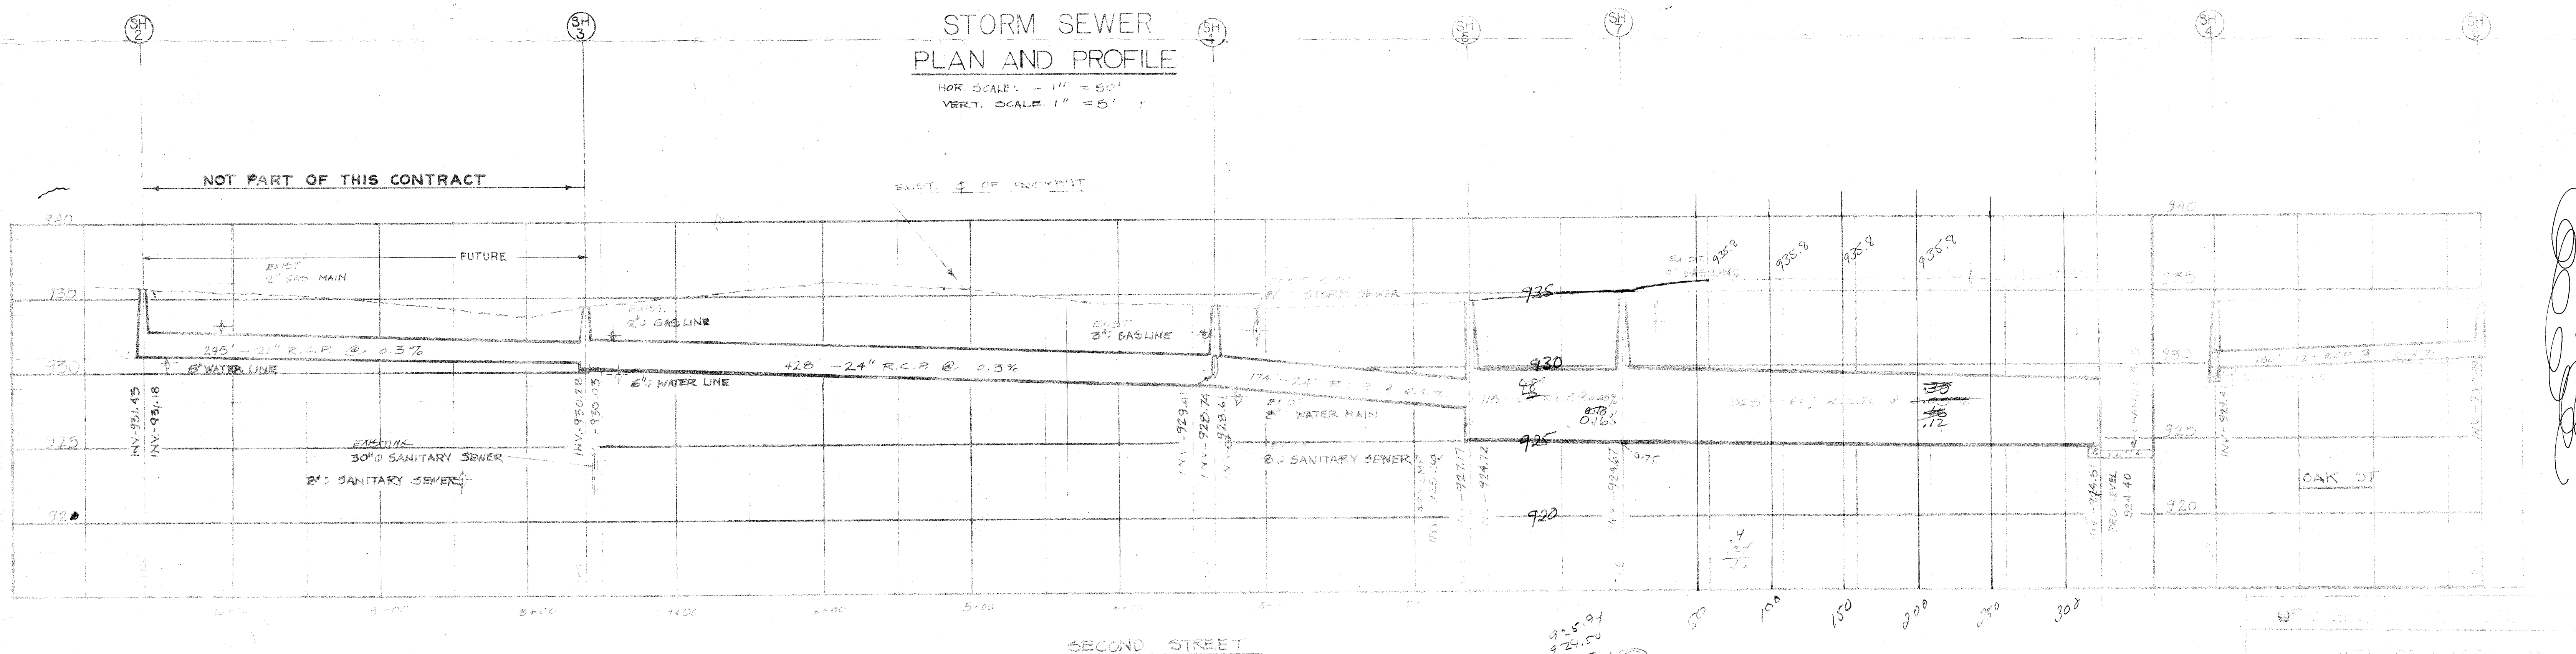

NEIGHBORHOOD DEVELOPMENT PROGRAM
URBAN RENEWAL AREA CDD PROJECT
NOV 1972 REV. NO. 1 USE OF REVISION NO.

