


CITY OF MASSILLON, OHIO

MUNICIPAL GARAGE FOR STREET AND PAINT DEPT'S.

WILLIAM KEEN - MAYOR RAYMOND MARCHAND - SAFETY SER. DIRECTOR

PREPARED BY CITY ENGINEER'S OFFICE, H.M. PIPER - CITY ENGINEER
ROBERT F. WAGONER - ARCHITECT H.R. RAUBER - BUILDING INSPECTOR
JANUARY, 1963


REVISED BY DRAFTING ASSOCIATES
APRIL, 1965

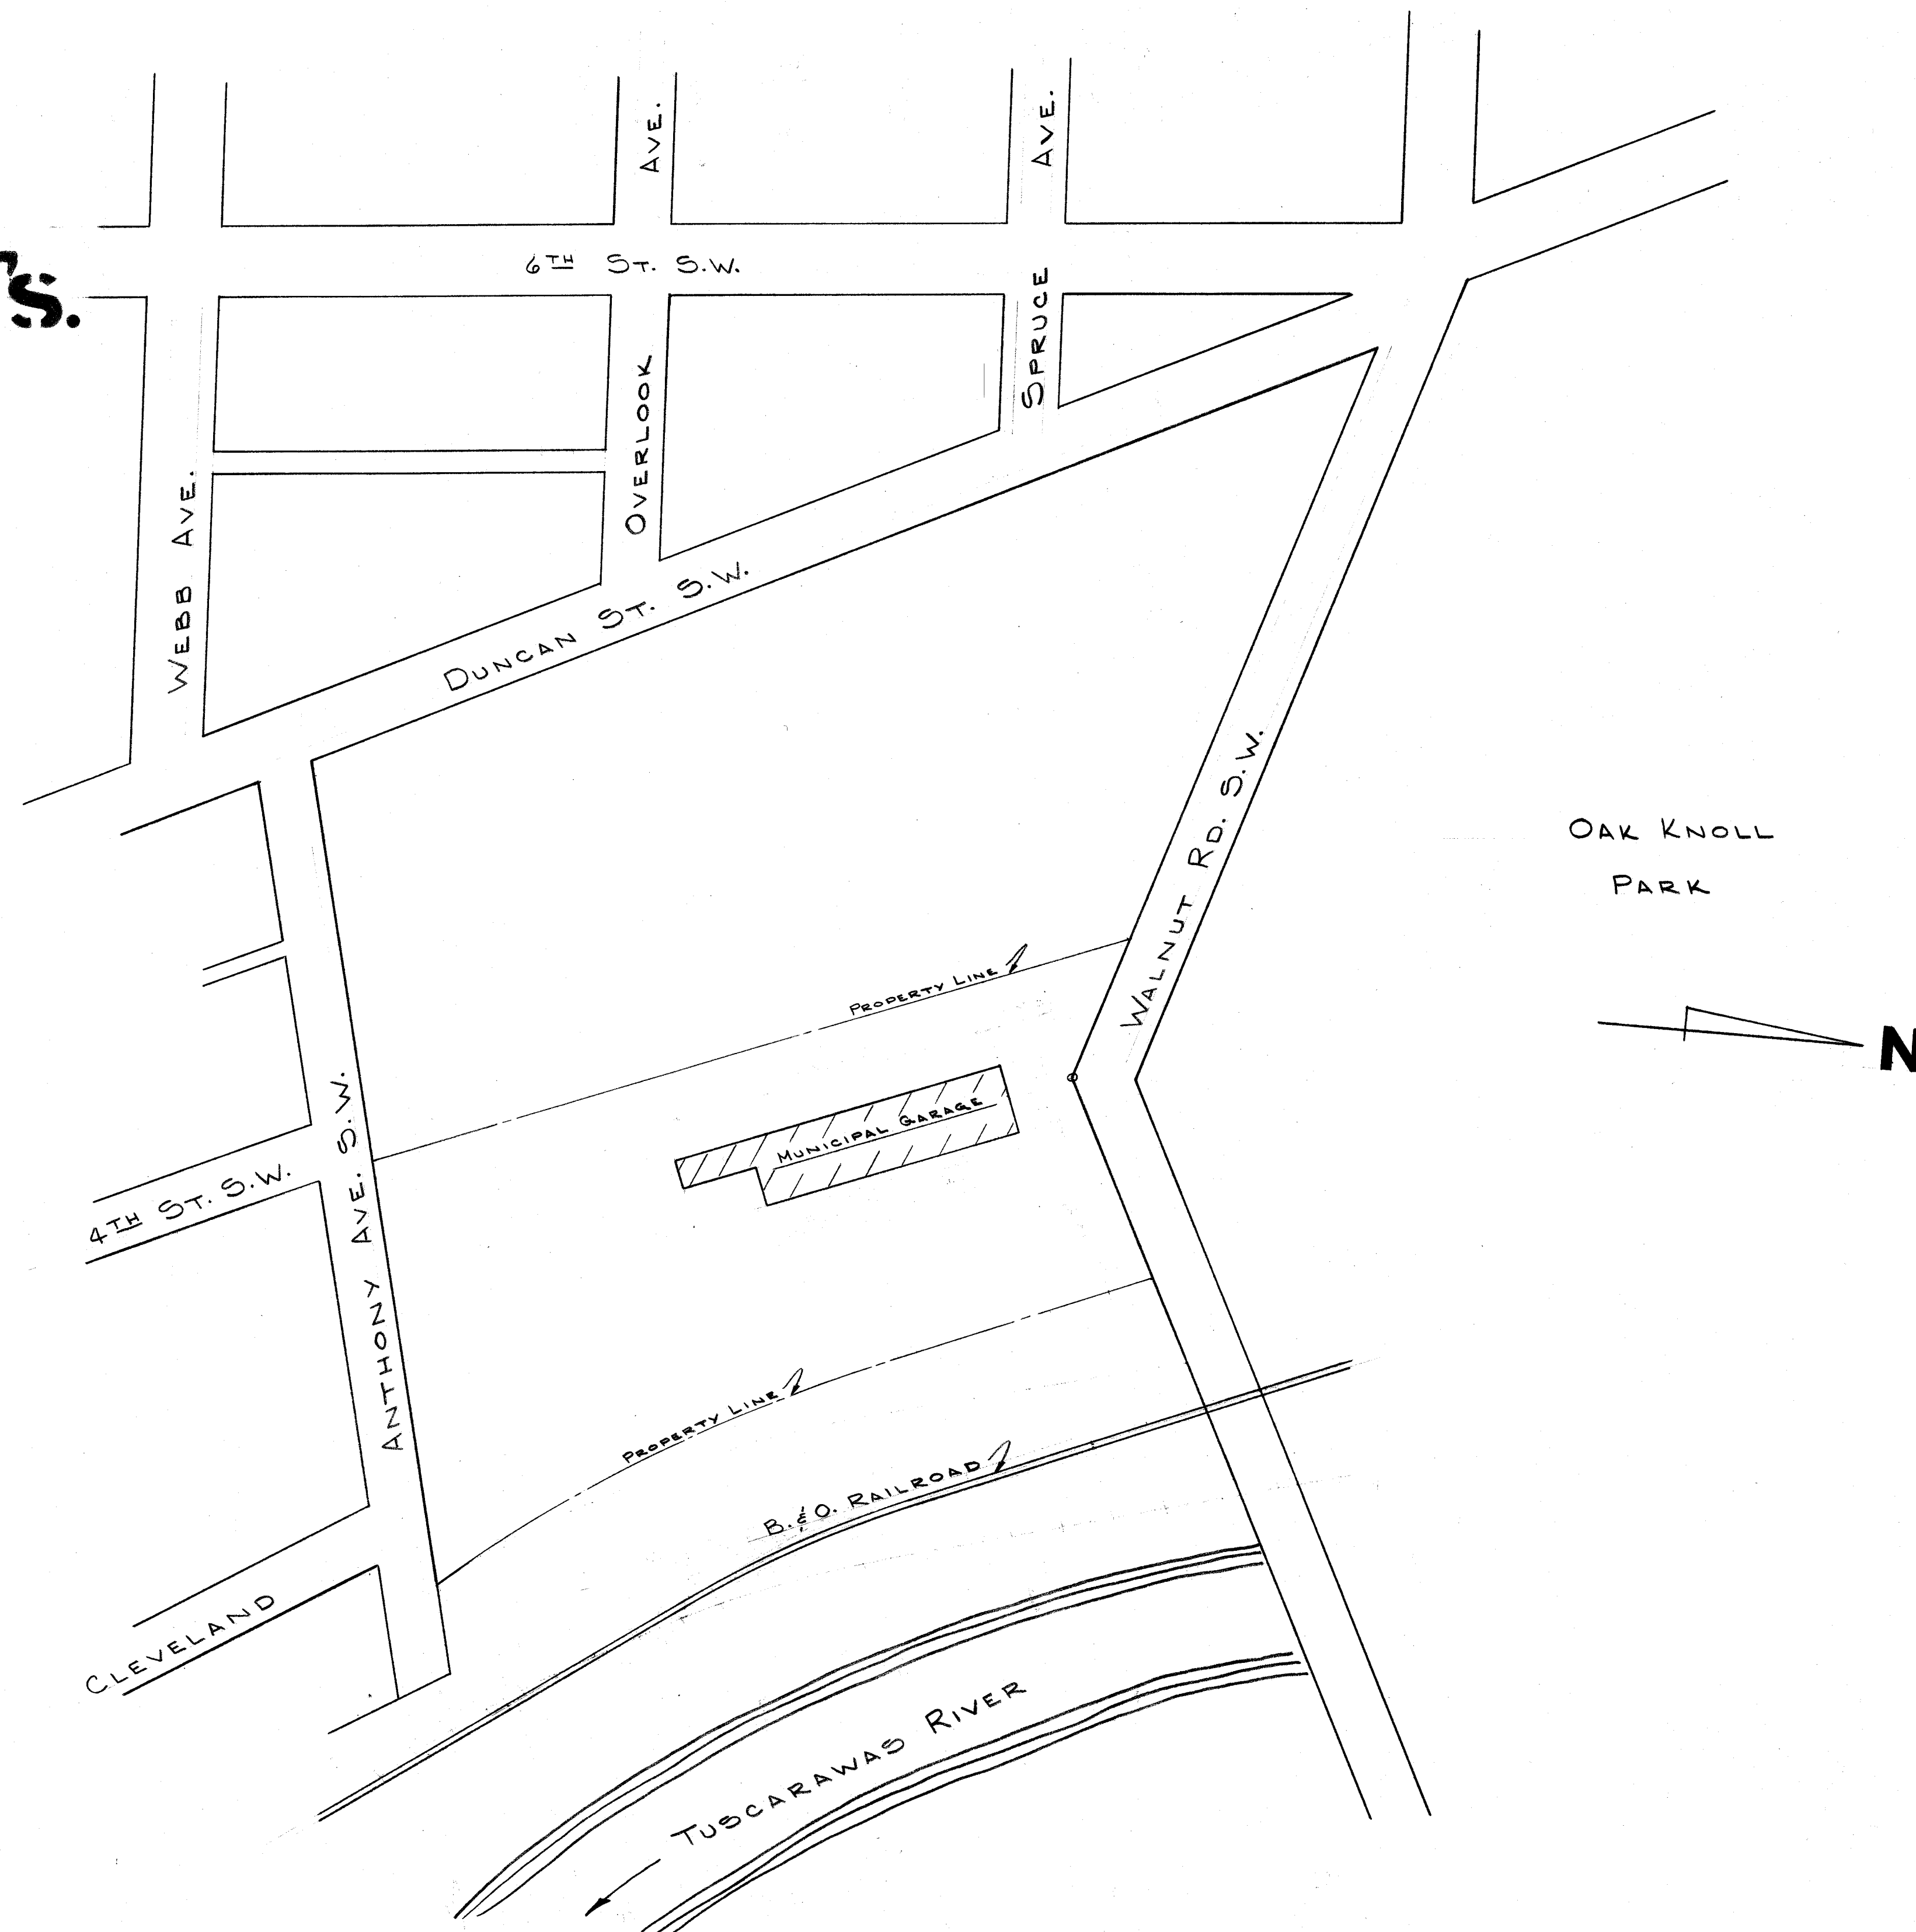


SITE MAP

SCALE: 1"=100'-0"


DRAFTING ASSOCIATES CANTON, OHIO		SITE MAP	
FRED E. BERENS	DAVID A. SZINK		
DRAWN BY: F.E. BERENS 3/65		SHEET	13
FILE NO. M 534		ACC. NO. 2249	

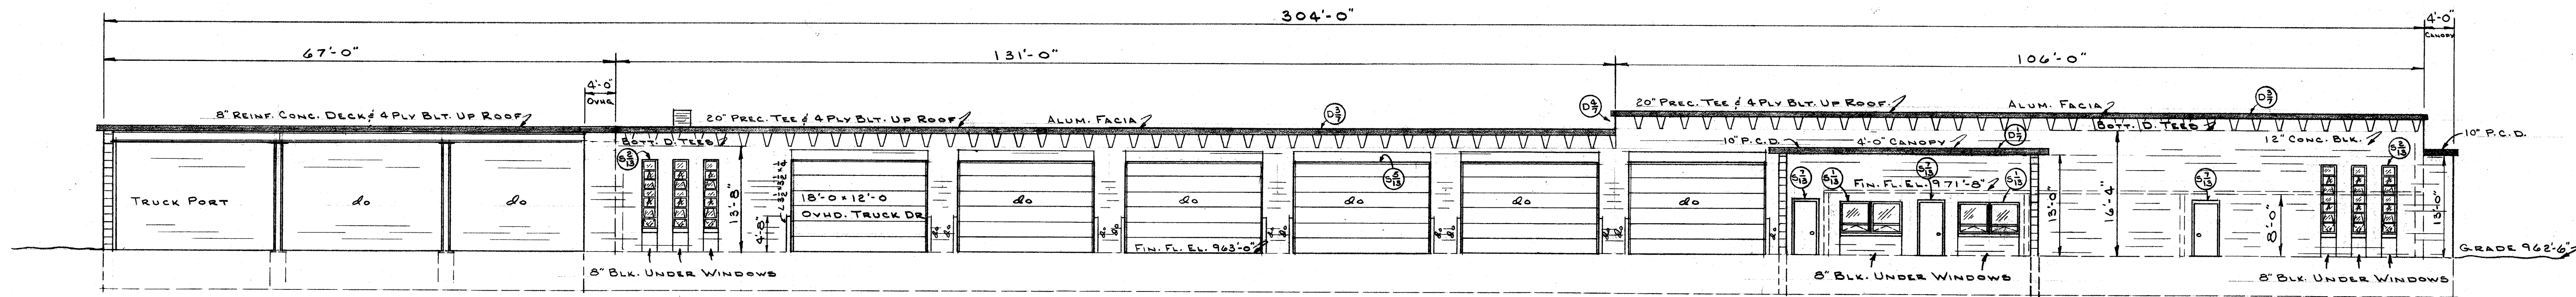


EAST ELEVATION
SCALE 1"=10'-0"

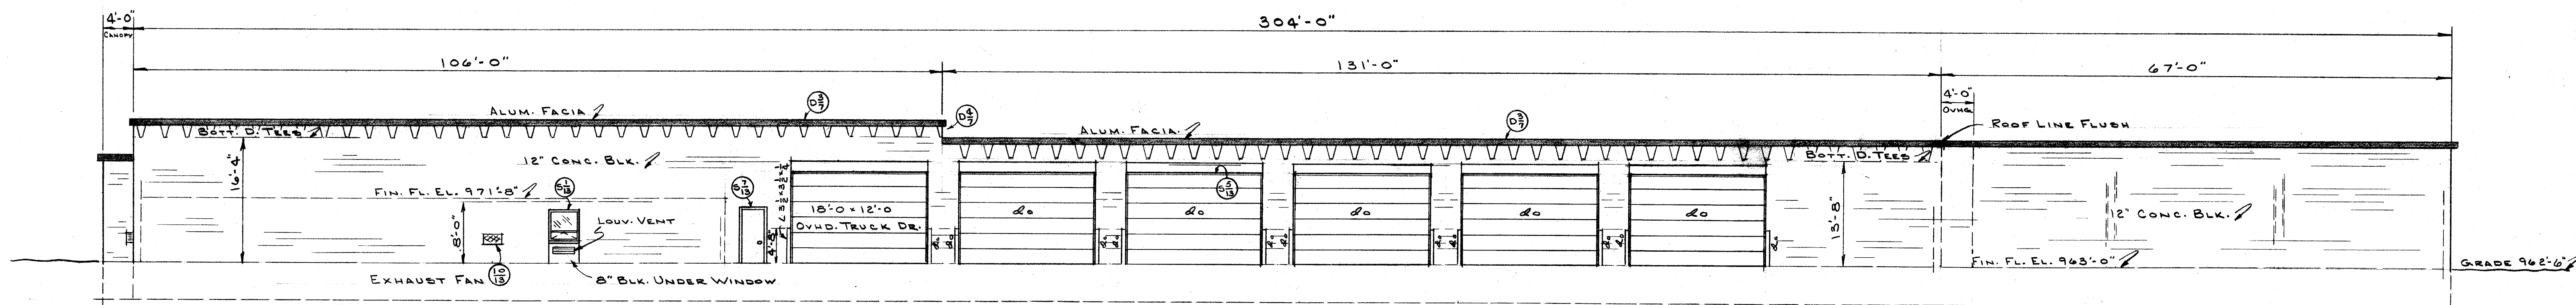



WEST ELEVATION
SCALE 1"=10'-0"


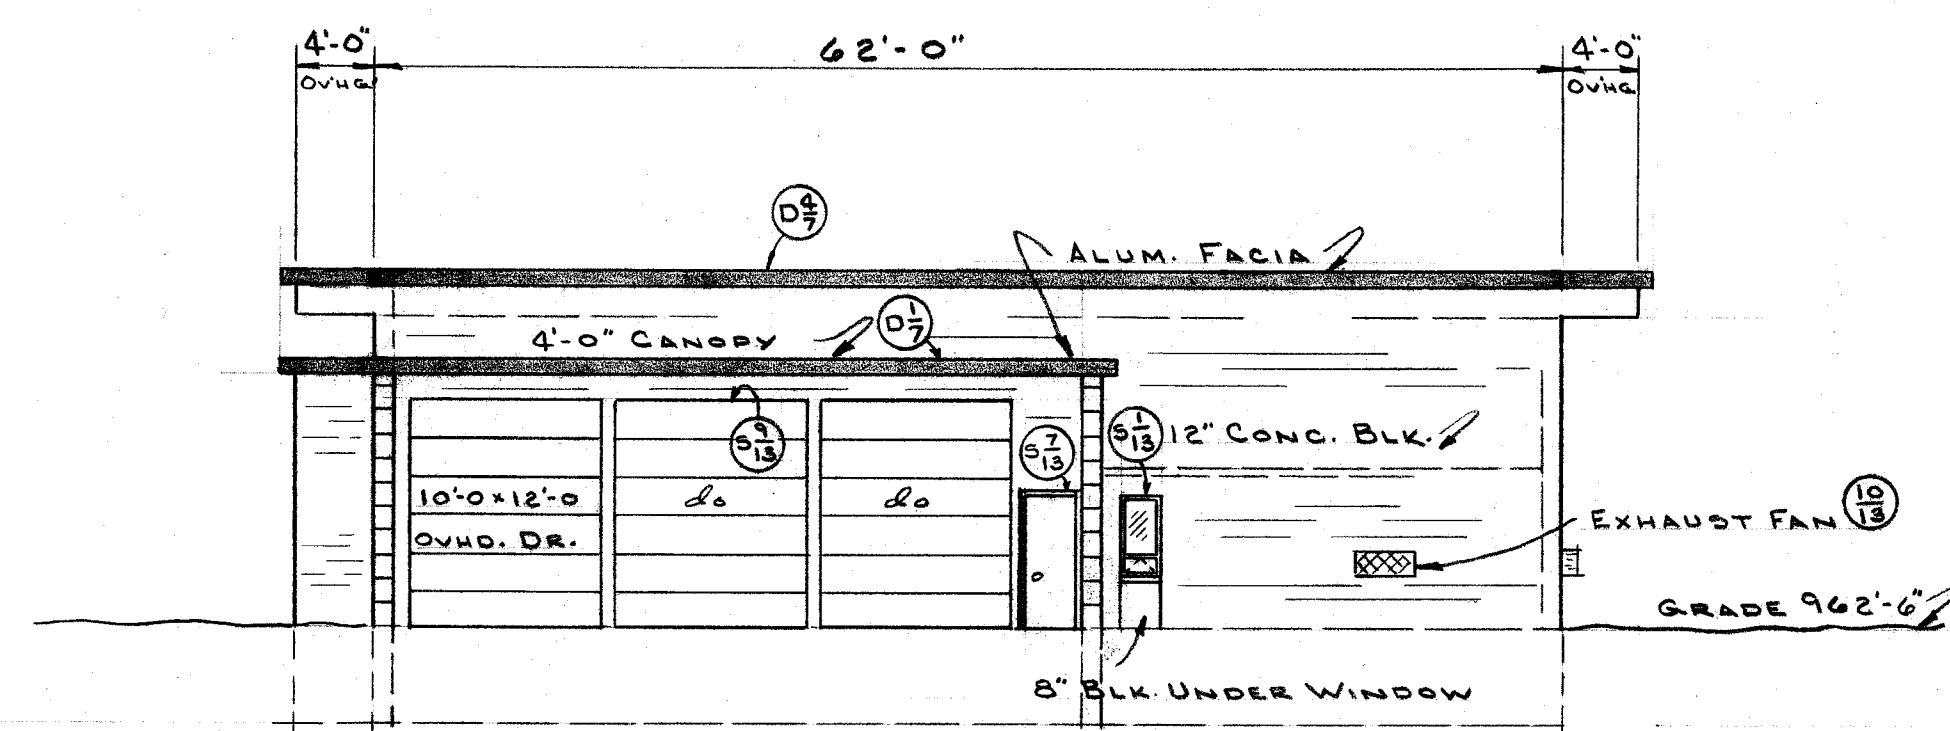


NORTH ELEVATION
SCALE 1"=10'-0"

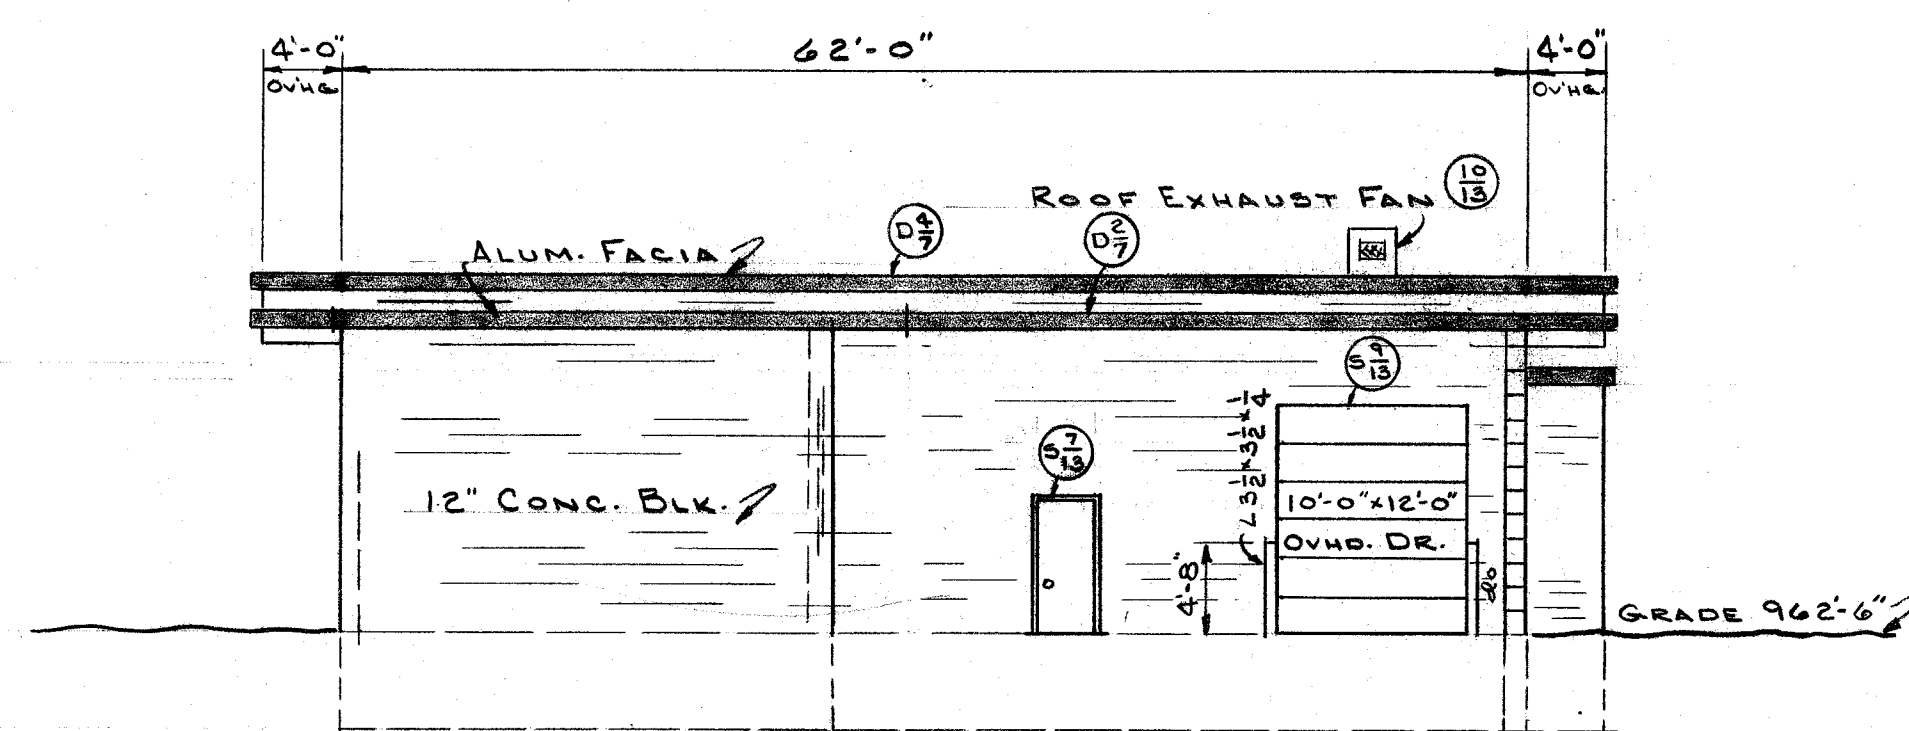


SOUTH ELEVATION
SCALE 1"=10'-0"

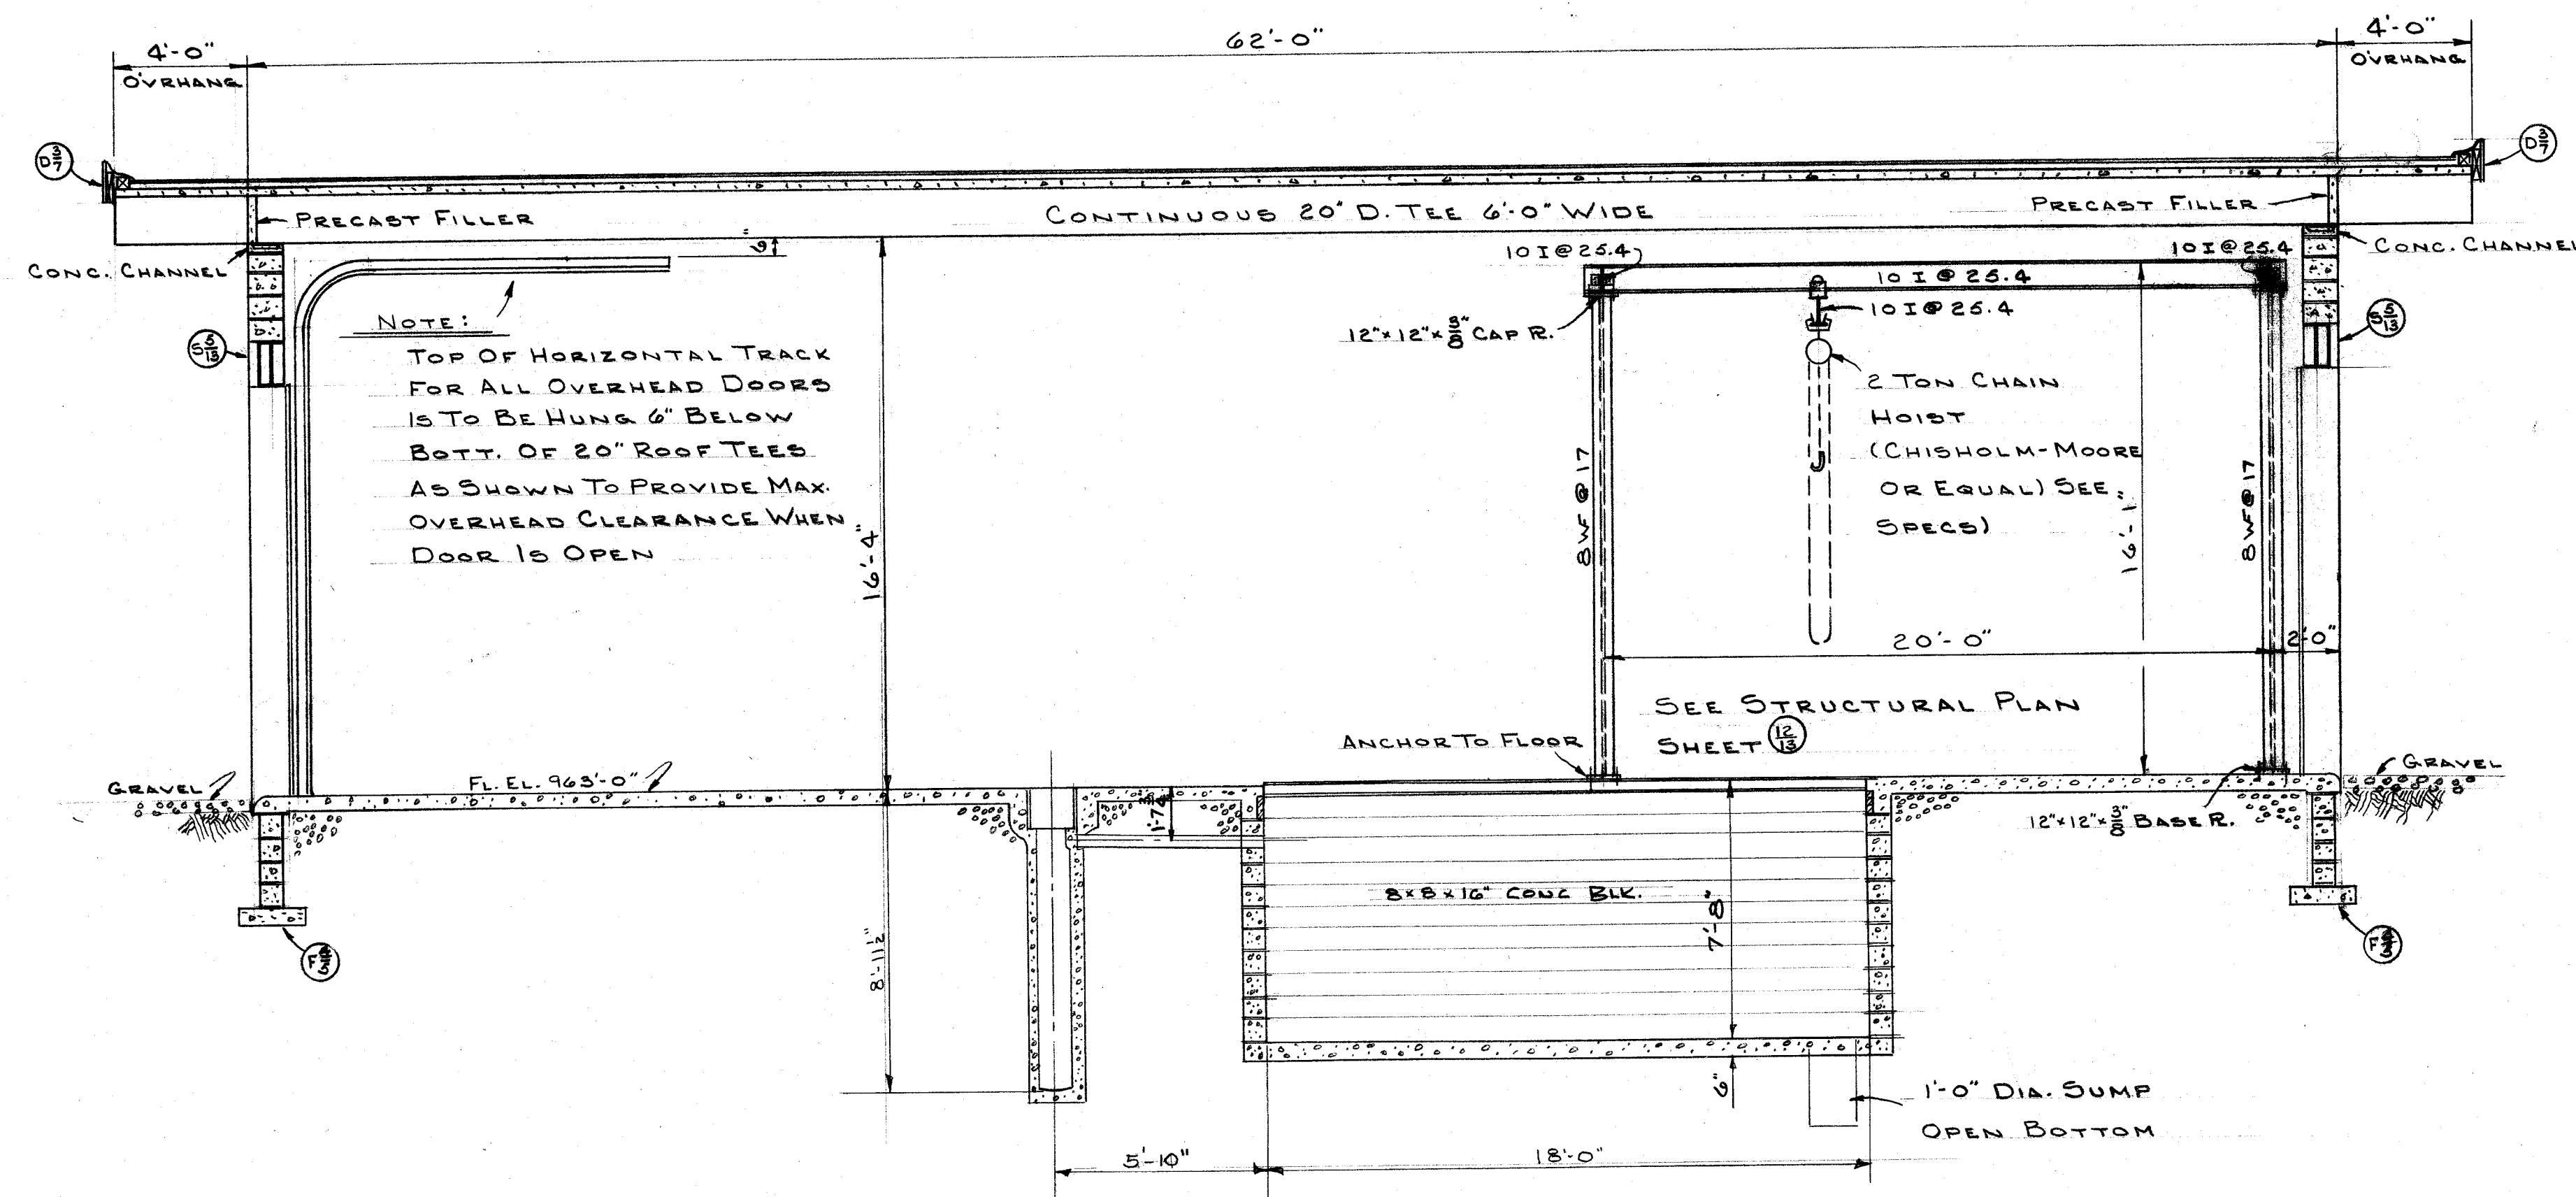
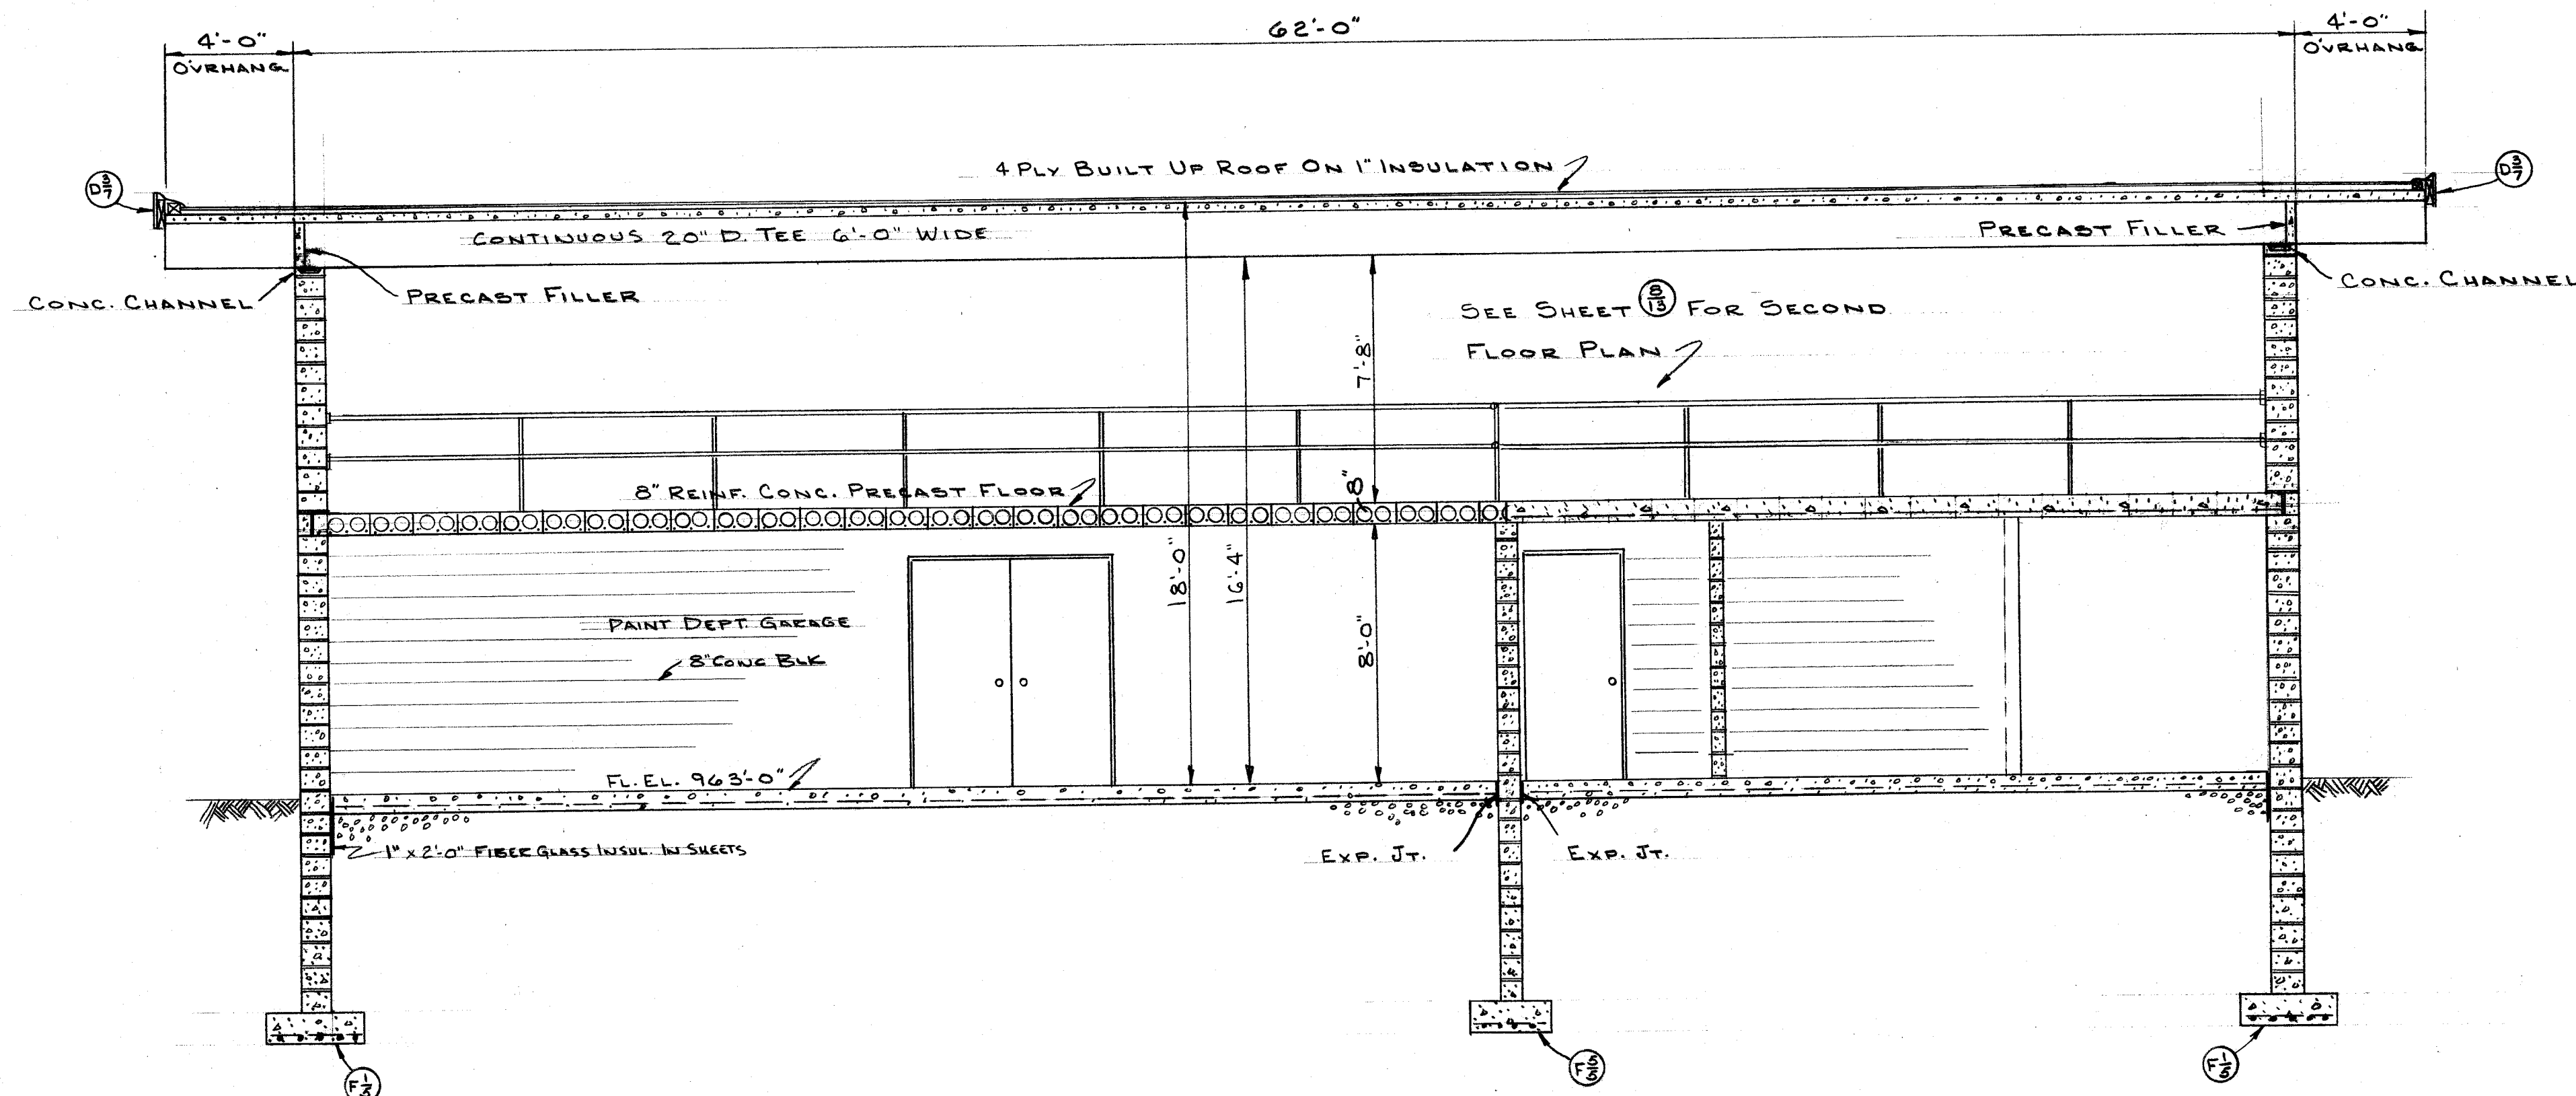


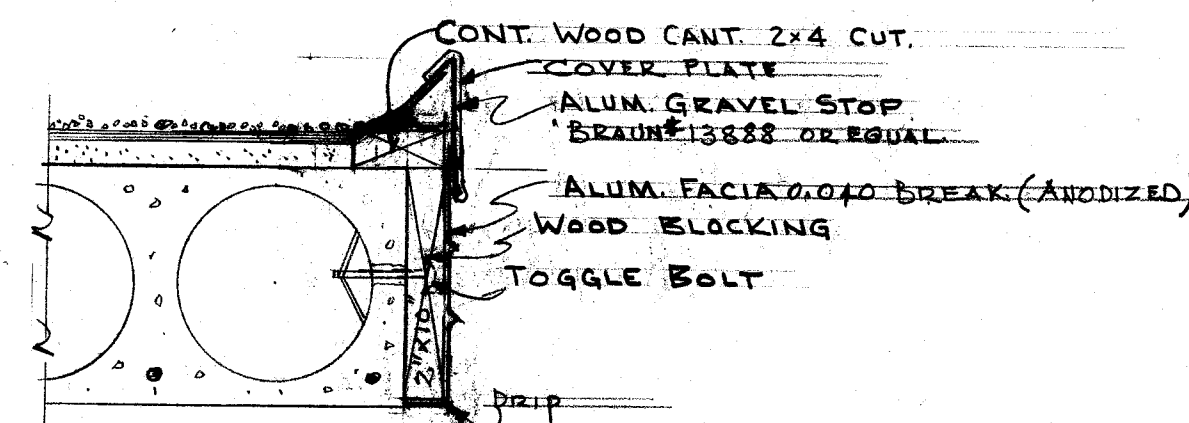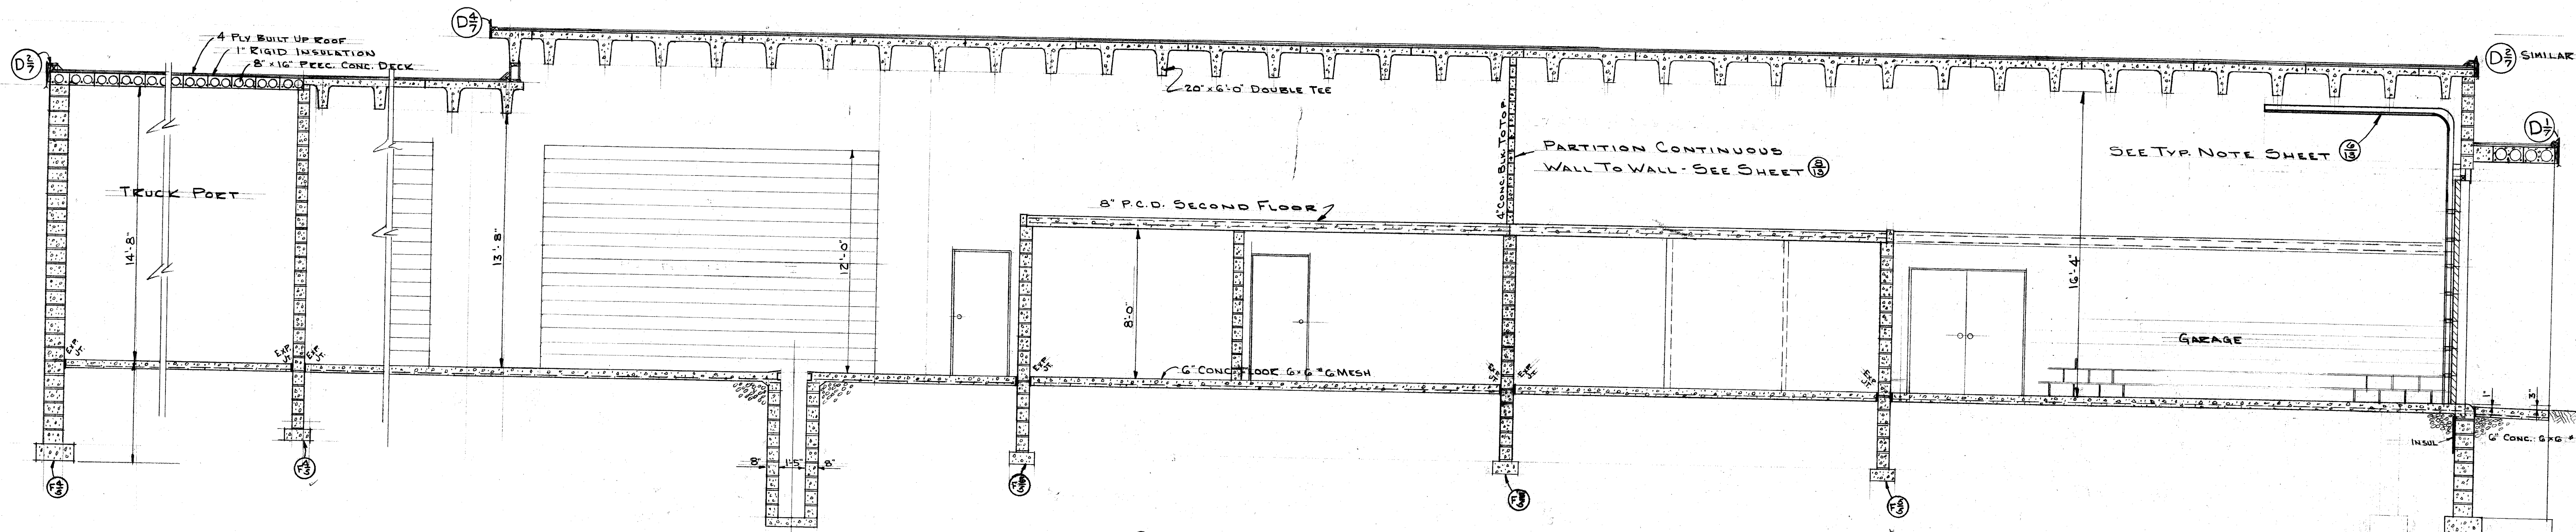

D7 FACIA DETAIL - 10 x 20 PREC. REINF. CONC. DECK
CANOPIES
SCALE 1 1/2" = 1'-0"

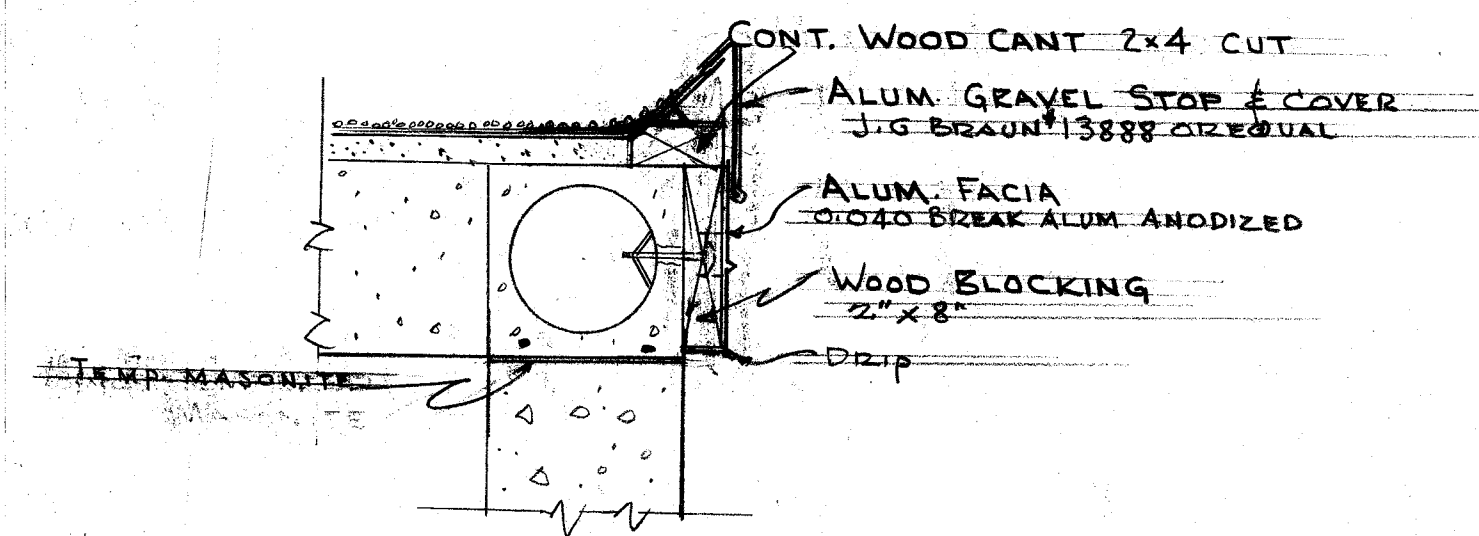


D7 FACIA DETAIL - SOUTH WALL
SCALE 1 1/2" = 1'-0"

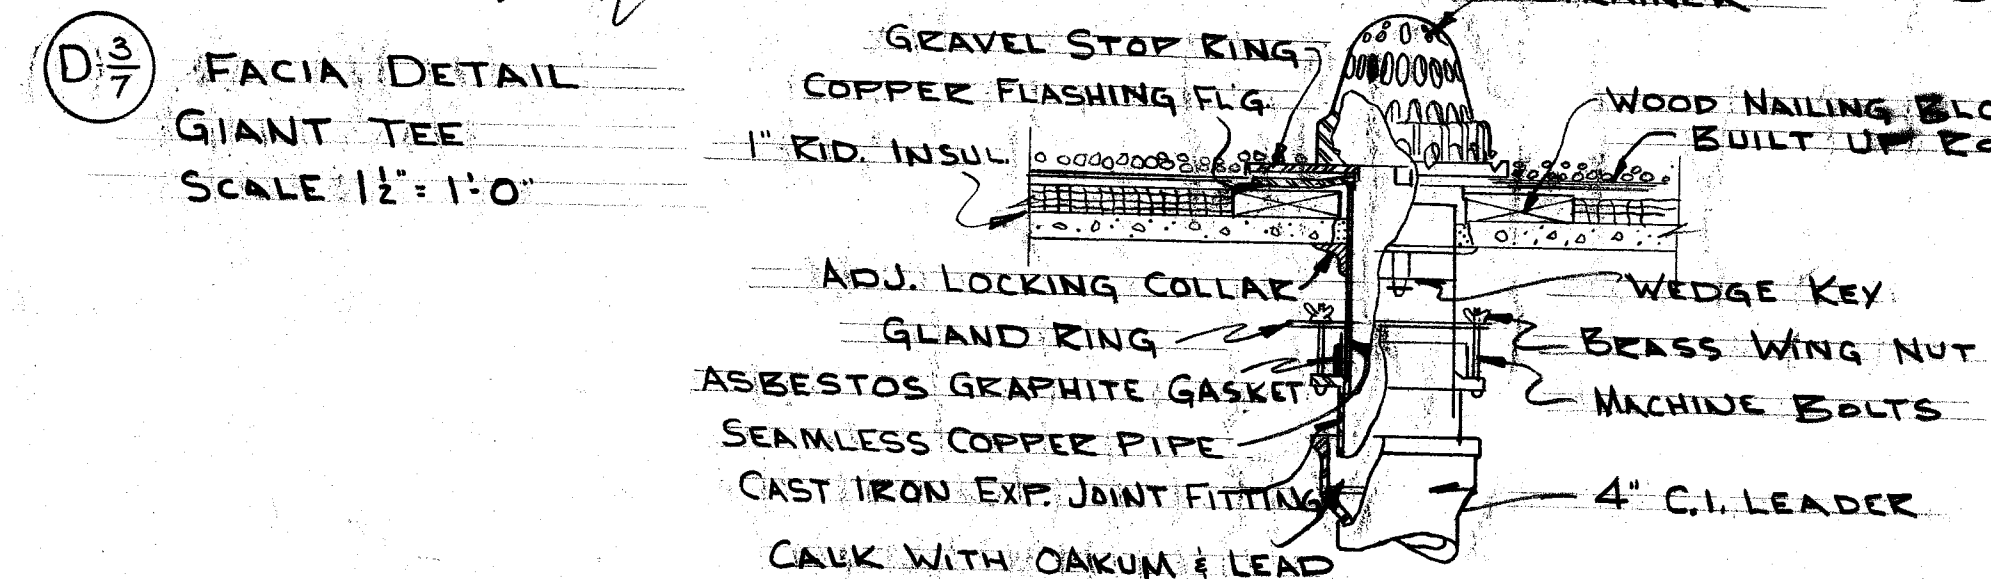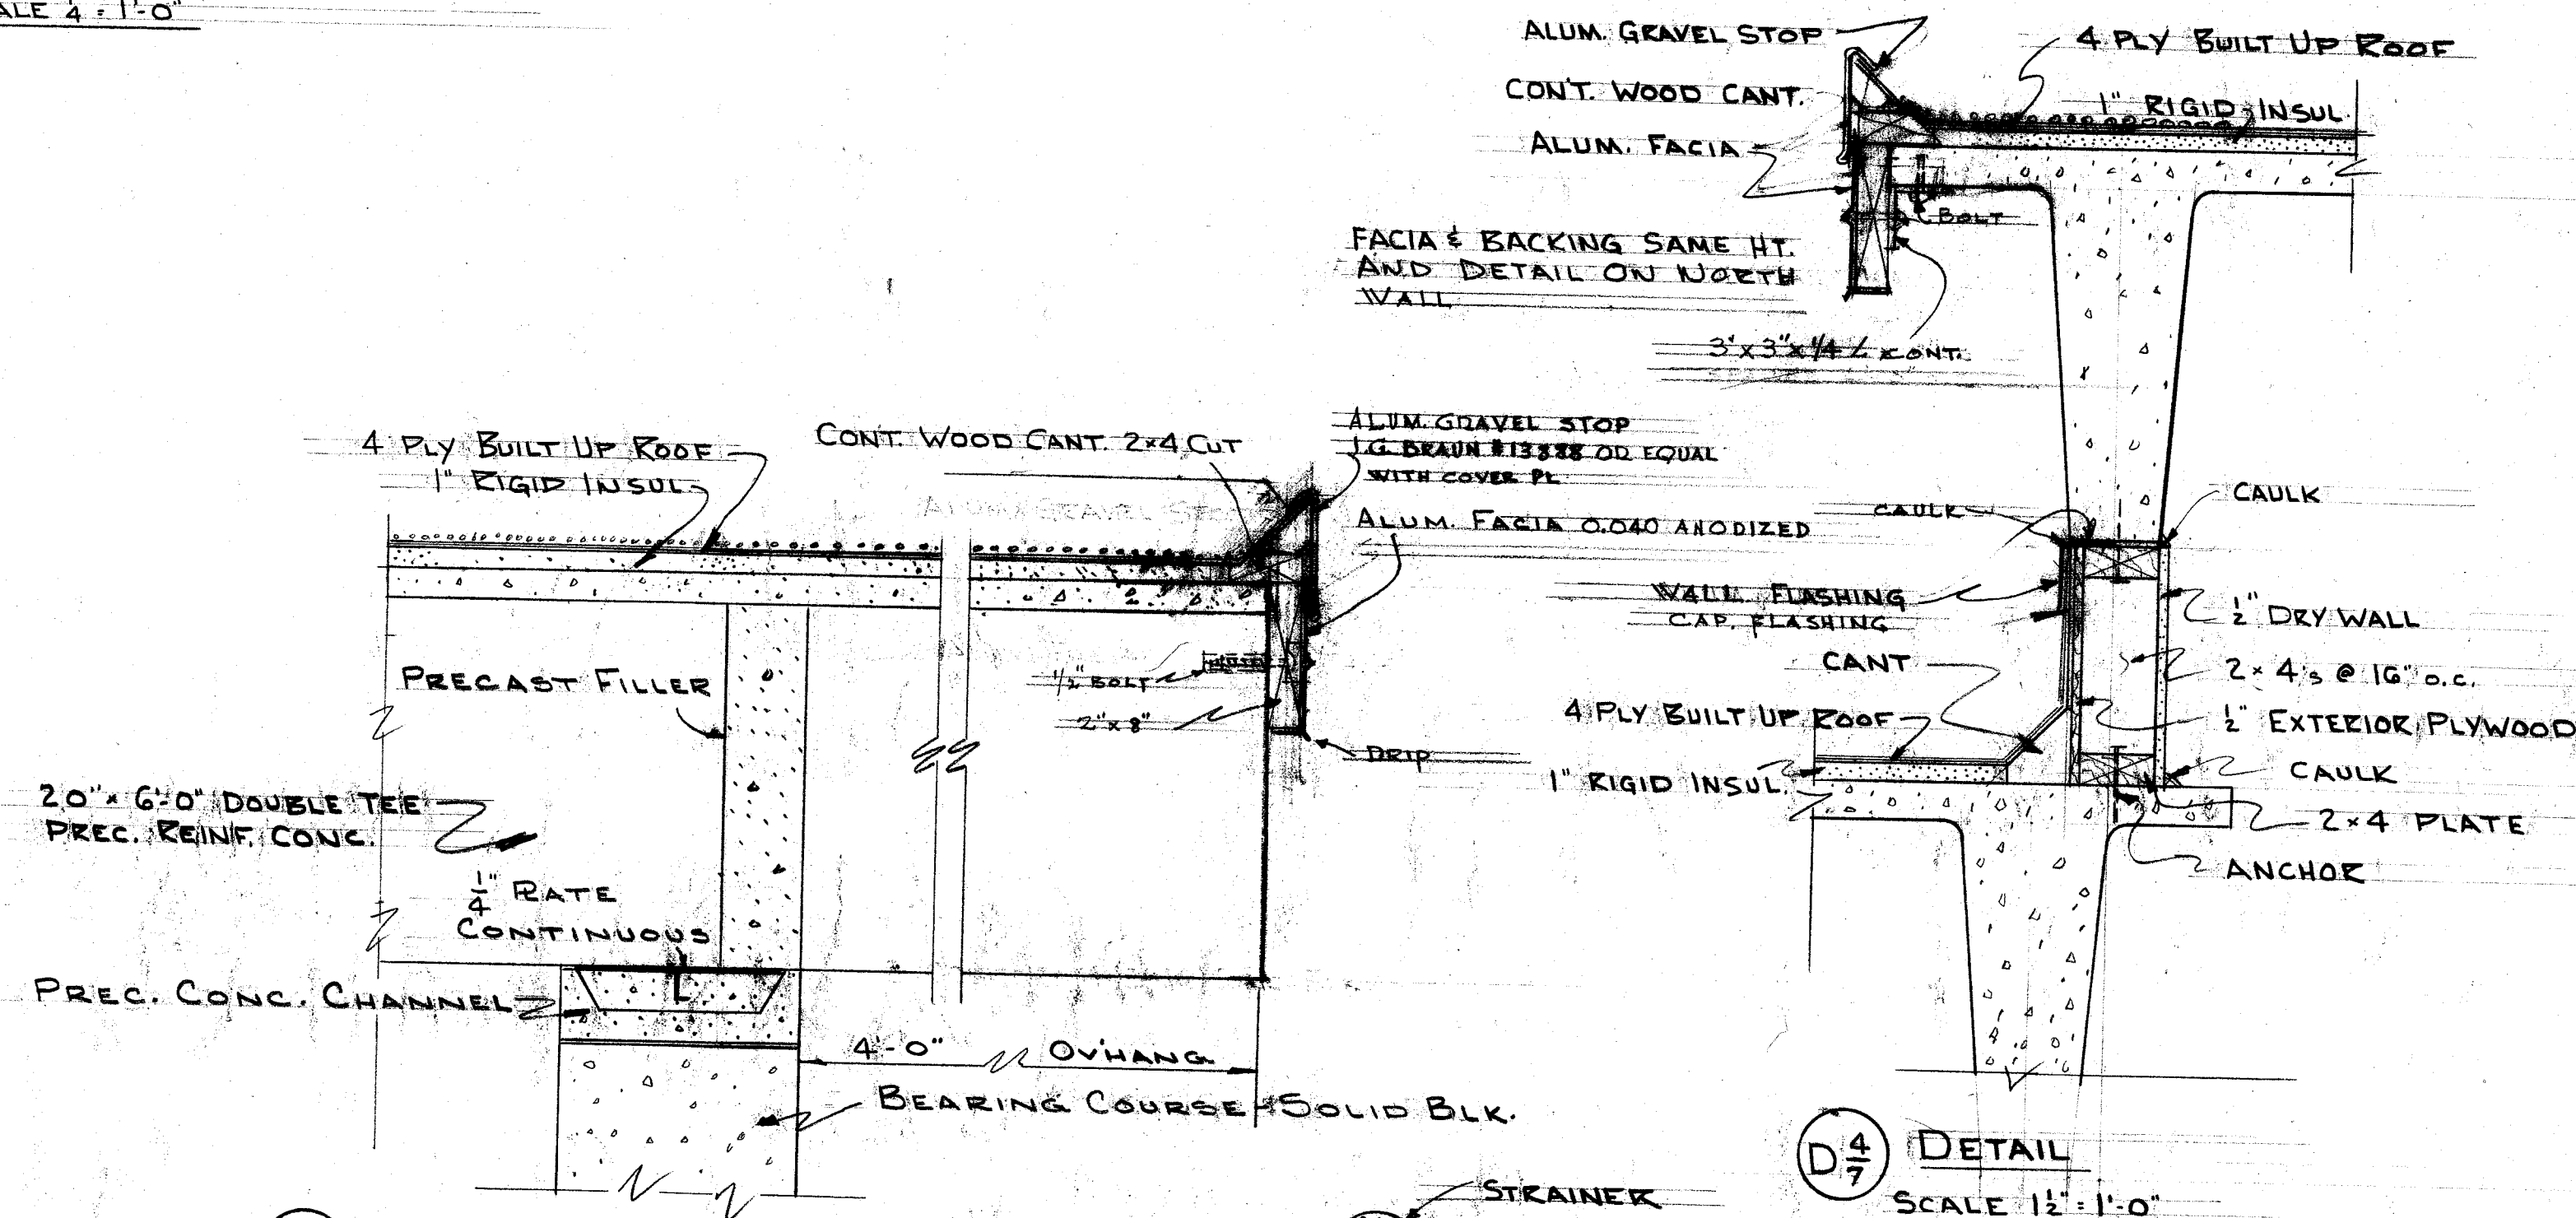

D3 FACIA DETAIL
GIANT TEE
SCALE 1 1/2" = 1'-0"


BARRETT-HOLT ROOF LEADER CONNECTION
TYPE 1-LG
SCALE 1 1/2" = 1'-0"

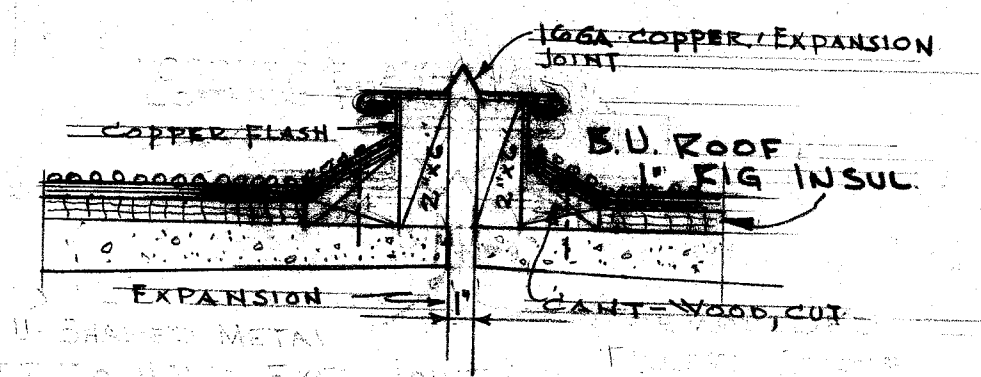

EXPANSION JOINT
SCALE 1 1/2" = 1'-0"



SCALE: $\frac{1}{2}" = 1'-0"$

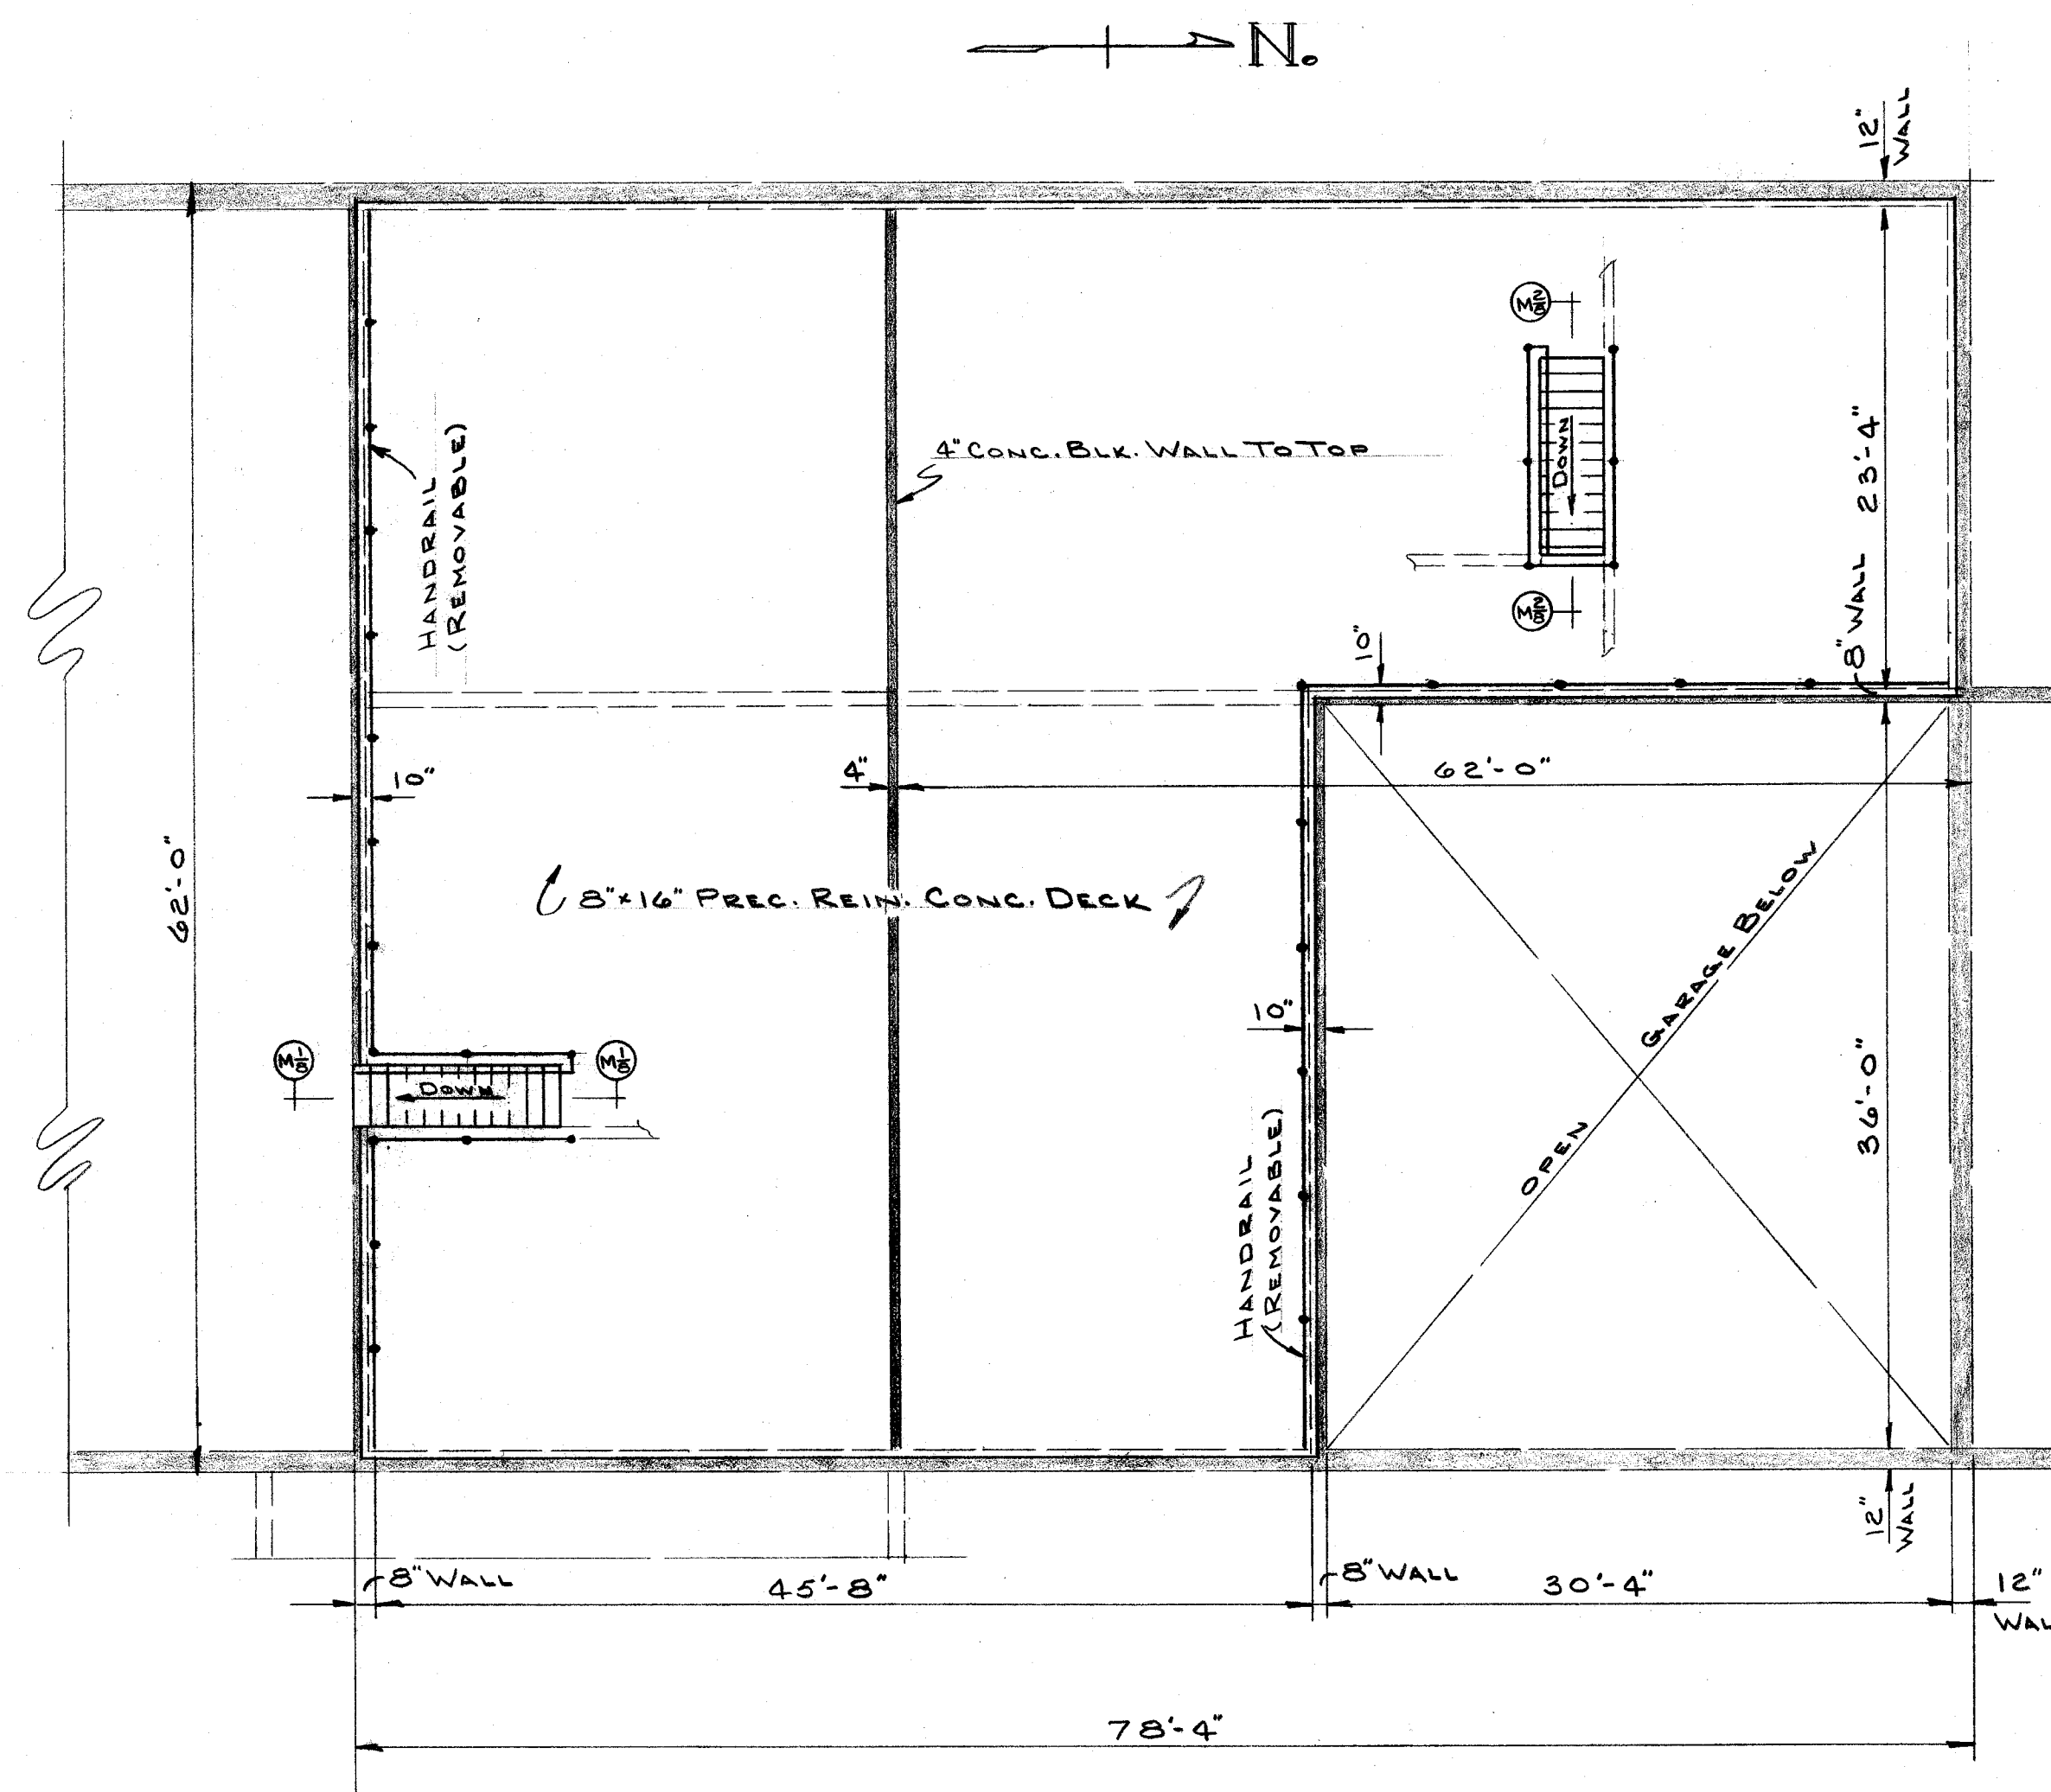


SECOND FLOOR PLAN


SCALE: $\frac{1}{8}'' = 1'-0''$

NOTE:

 
NOTE: SEE FIRST FLOOR PLAN SHEET (4/13) FOR STRUCTURES BELOW & FOR EXACT STAIRWAY LOCATIONS



 
NOTE:
INFORMATION & DIMENSIONS NOT
GIVEN ARE SAME AS ABOVE



SCALE: $\frac{1}{2}'' = 1'-0''$

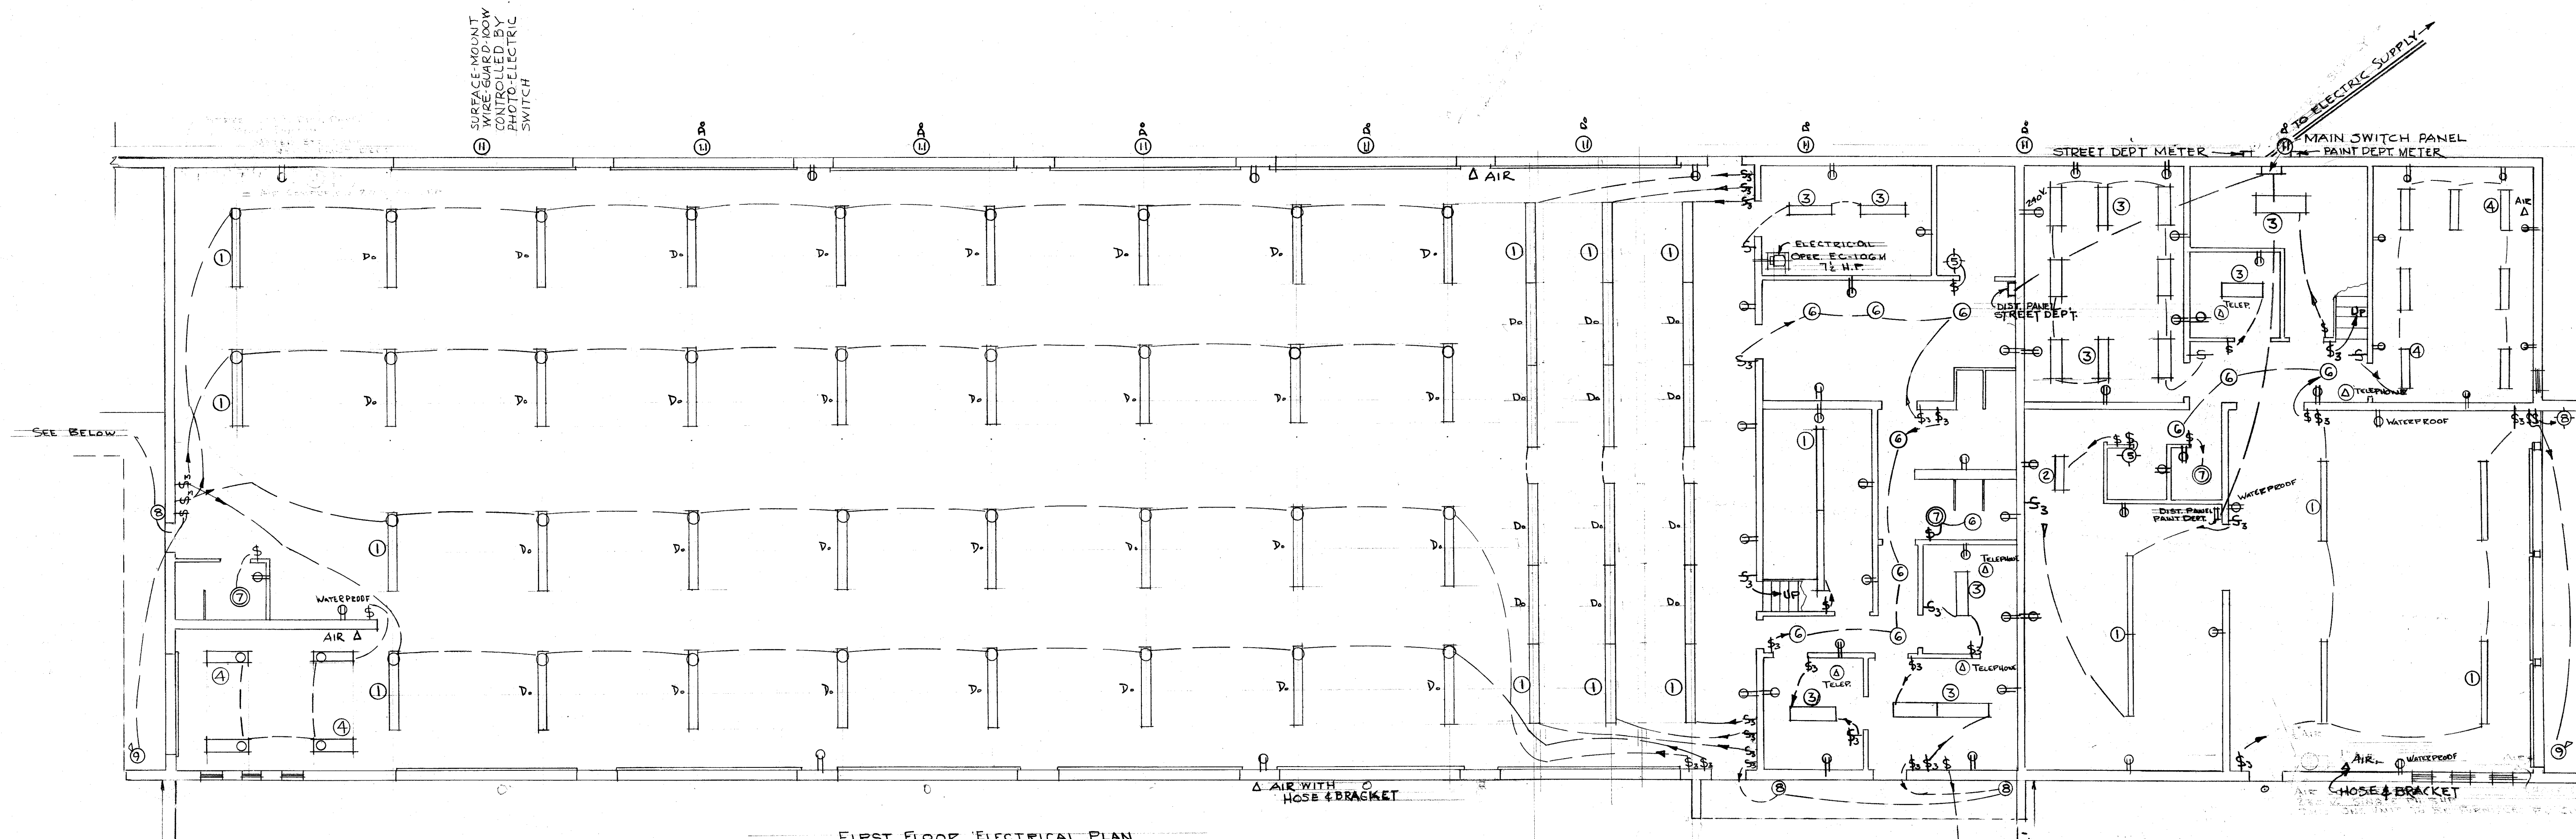

2-#10 WIRES DIRECT
BURIED IN RIGID CONDUIT
FIXTURE AND POLE SAME AS
POLE 184' NORTH - CONNECT TO STREET
DISTRIBUTION PANEL

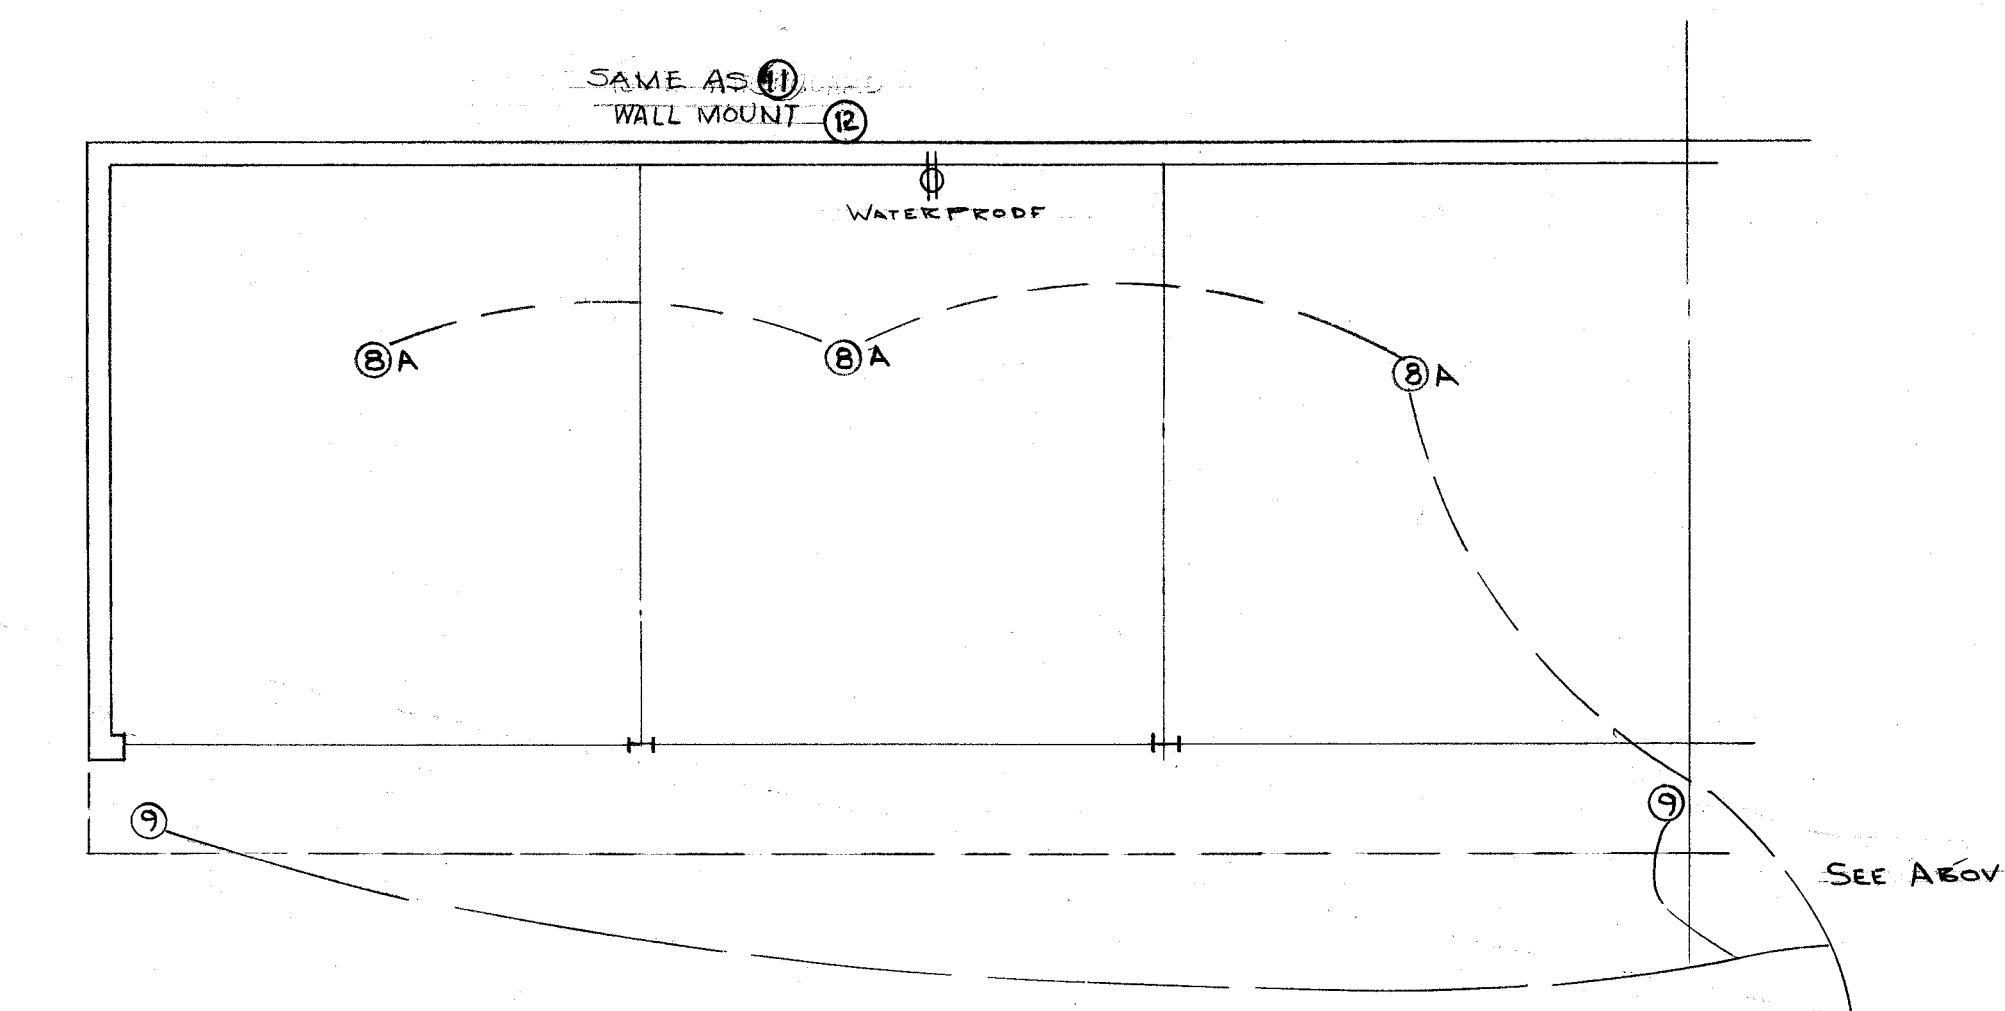


NOTE: ALL COMPRESSOR (AIR) PIPING TO BE
INSTALLED BY PLUMBING CONTR.

3/4" STEEL POLES
8" DIA. BOTTOM - 4" DIA. CONC
8" DIA. TOP - 4" DIA. CONC
AIR COMPRESSOR - INGERSOLL-RAND 25 HP OR EQUAL - SHP
2-STAGE AIR COOLED ELECTRIC DRIVEN 1/4" INLET - 3/4" DISCH.
TO BE FURNISHED & INSTALLED BY PLUMBING CONTR.


2" TO WIRES DIRECT
BURIED IN RIGID CONDUIT


FIXTURE
INDUSTRIAL INDUSTRIAL
STYLAR 18" TM OR STYLAR 18" TM OR EQUAL CONTROLLED BY PHOTO ELECTRIC SWITCH
CONNECT TO STREET DIST. PANEL

TO PUMP STATION

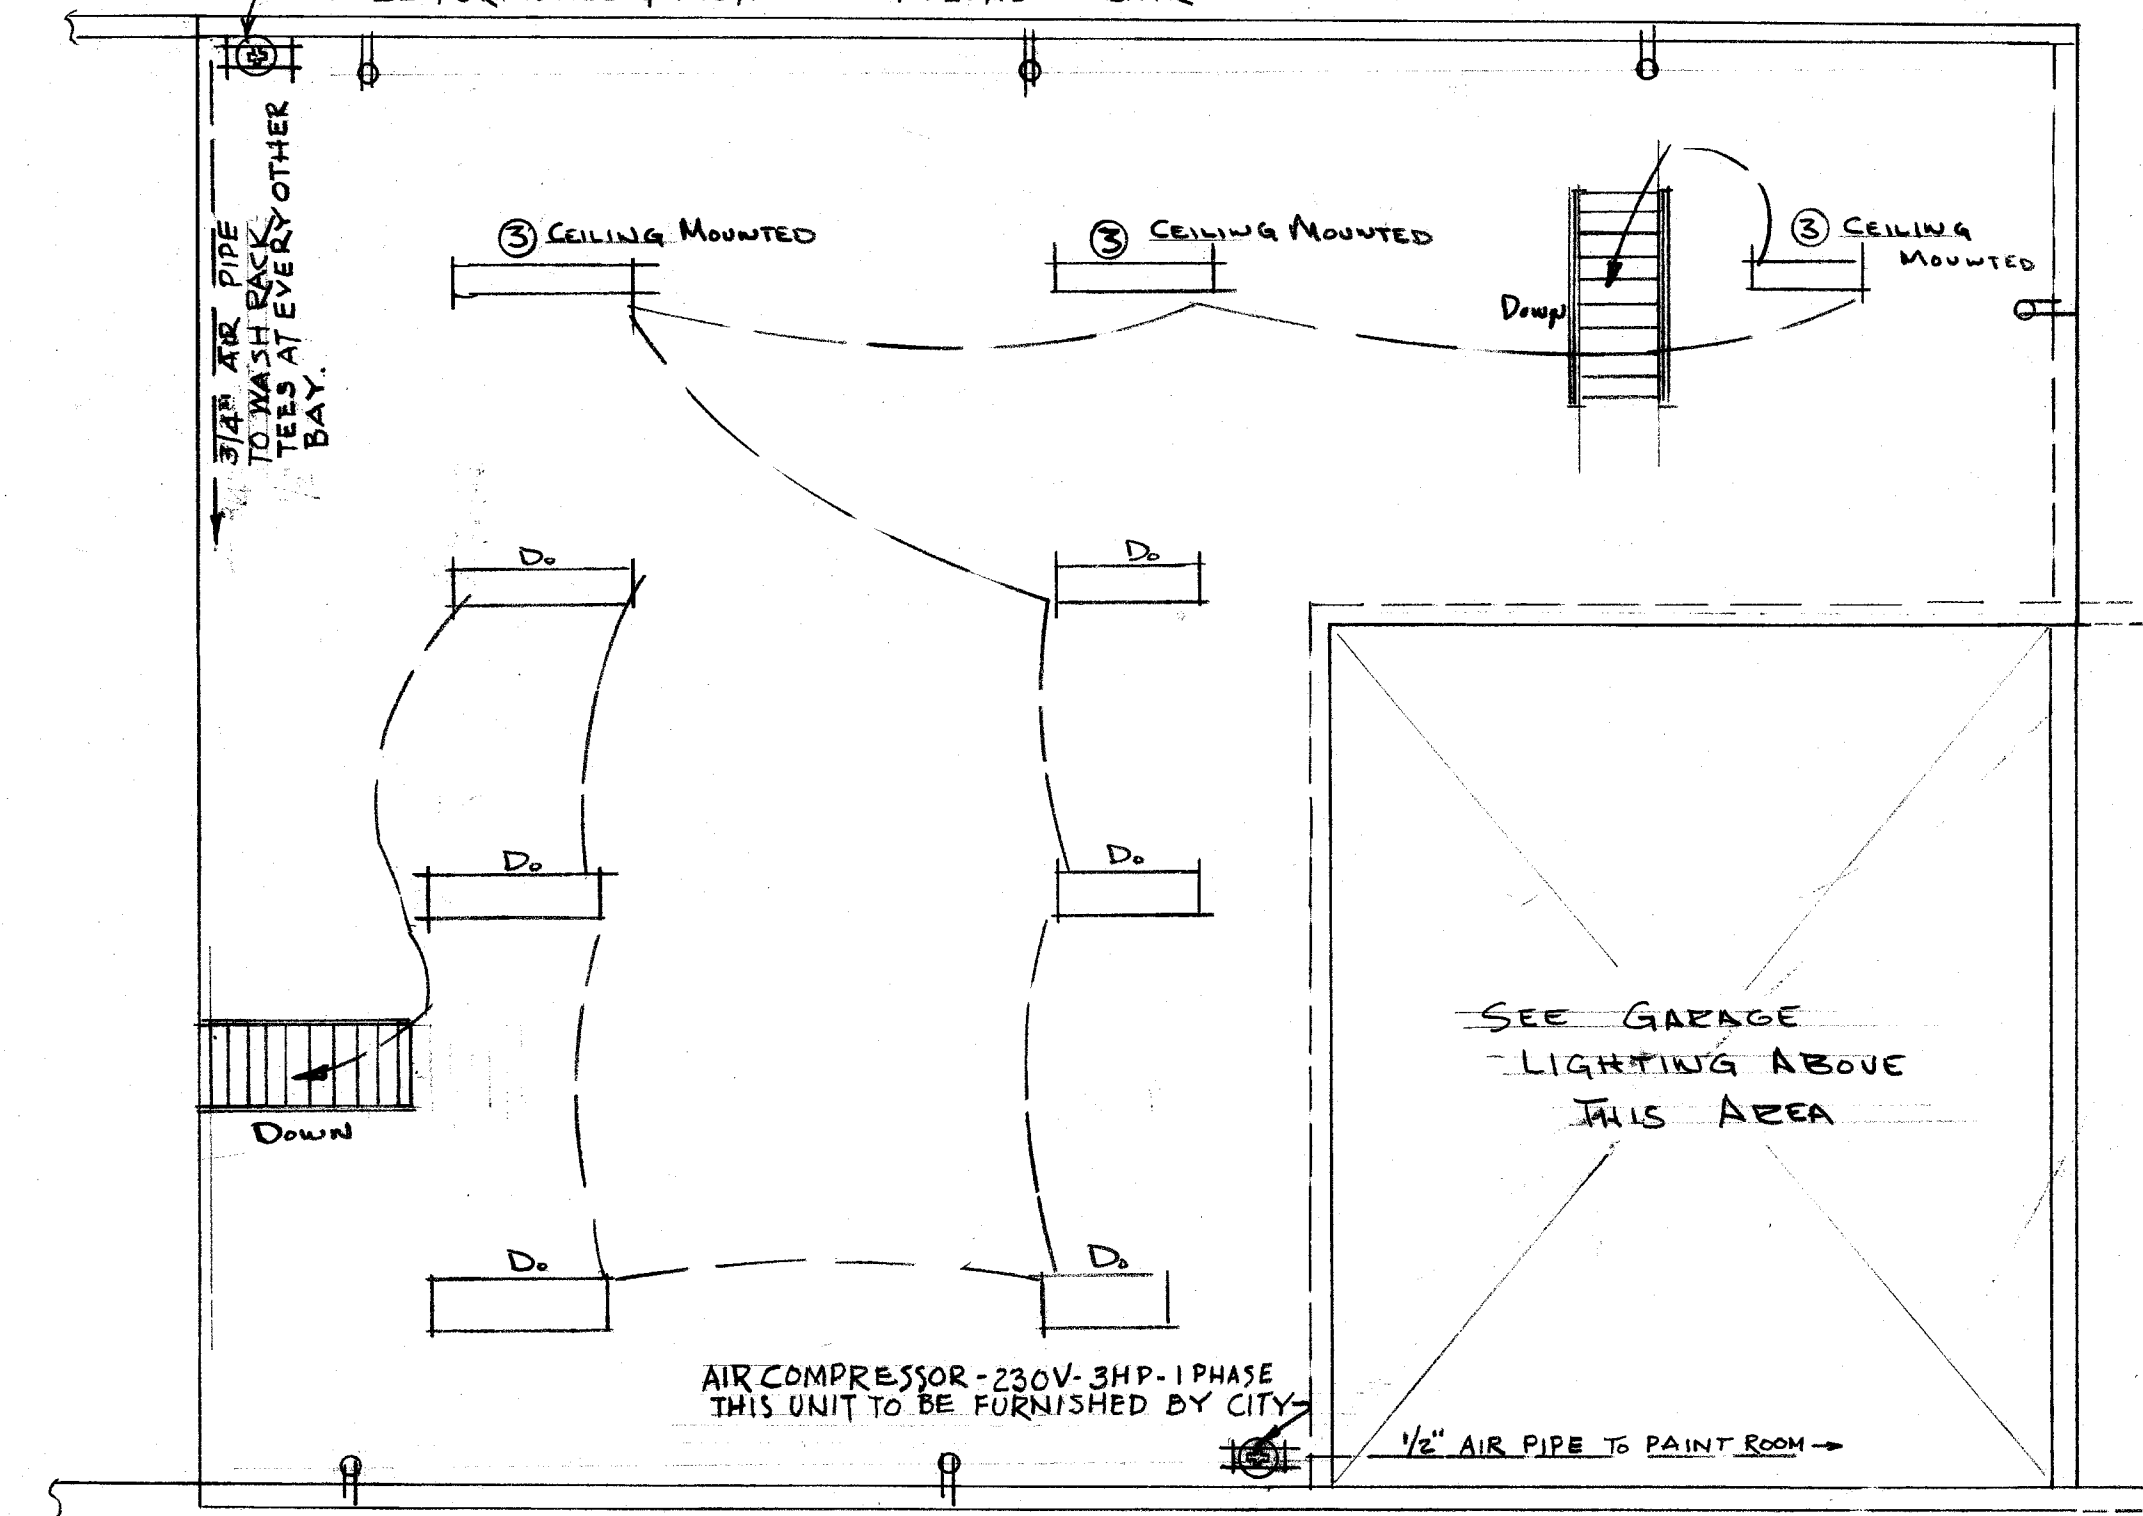


LIGHTING FIXTURE SCHEDULE			
MK	CAT. NO.	DESCRIPTION	MOUNT HT.
①	M-4298	INDIVIDUAL LAMP HOLDERS - SLIMLINE, 2LT. 8FT. LG	SURFACE
②	M-4290	Do " " " " 4FT. LG	Do
③	FL1024-4	40 WATT RAPID-START 4FT. - SUSPENDED	SURFACE PARTS
④	FV2124-4	VAPOR TITE UNITS - SUSPENDED	Do
⑤	T663-BY	EXPLOSION PROOF UNIT - WALL MOUNTED	9'-0"
⑥	4321	LIGHTOLIER, SURFACE CALCULITE	SURFACE
⑦	NL-1	ANEMOSTAT, COMB. VENTILATER & DIRECT LIGHT 15 C.F.M.	BOXED IN
⑧	6805	VAPOR - TIGHT UNIT 200 WATT	WALL @ SURF
⑨	R-40	FLOOD HOUSING - 300 WATT	SURFACE
⑩	N-5681	COLUMN LITE	14'-0"
⑪		100 WATT - WIRE GUARD - CONTR BY PHOTO ELEC. SWITCH	SURFACE

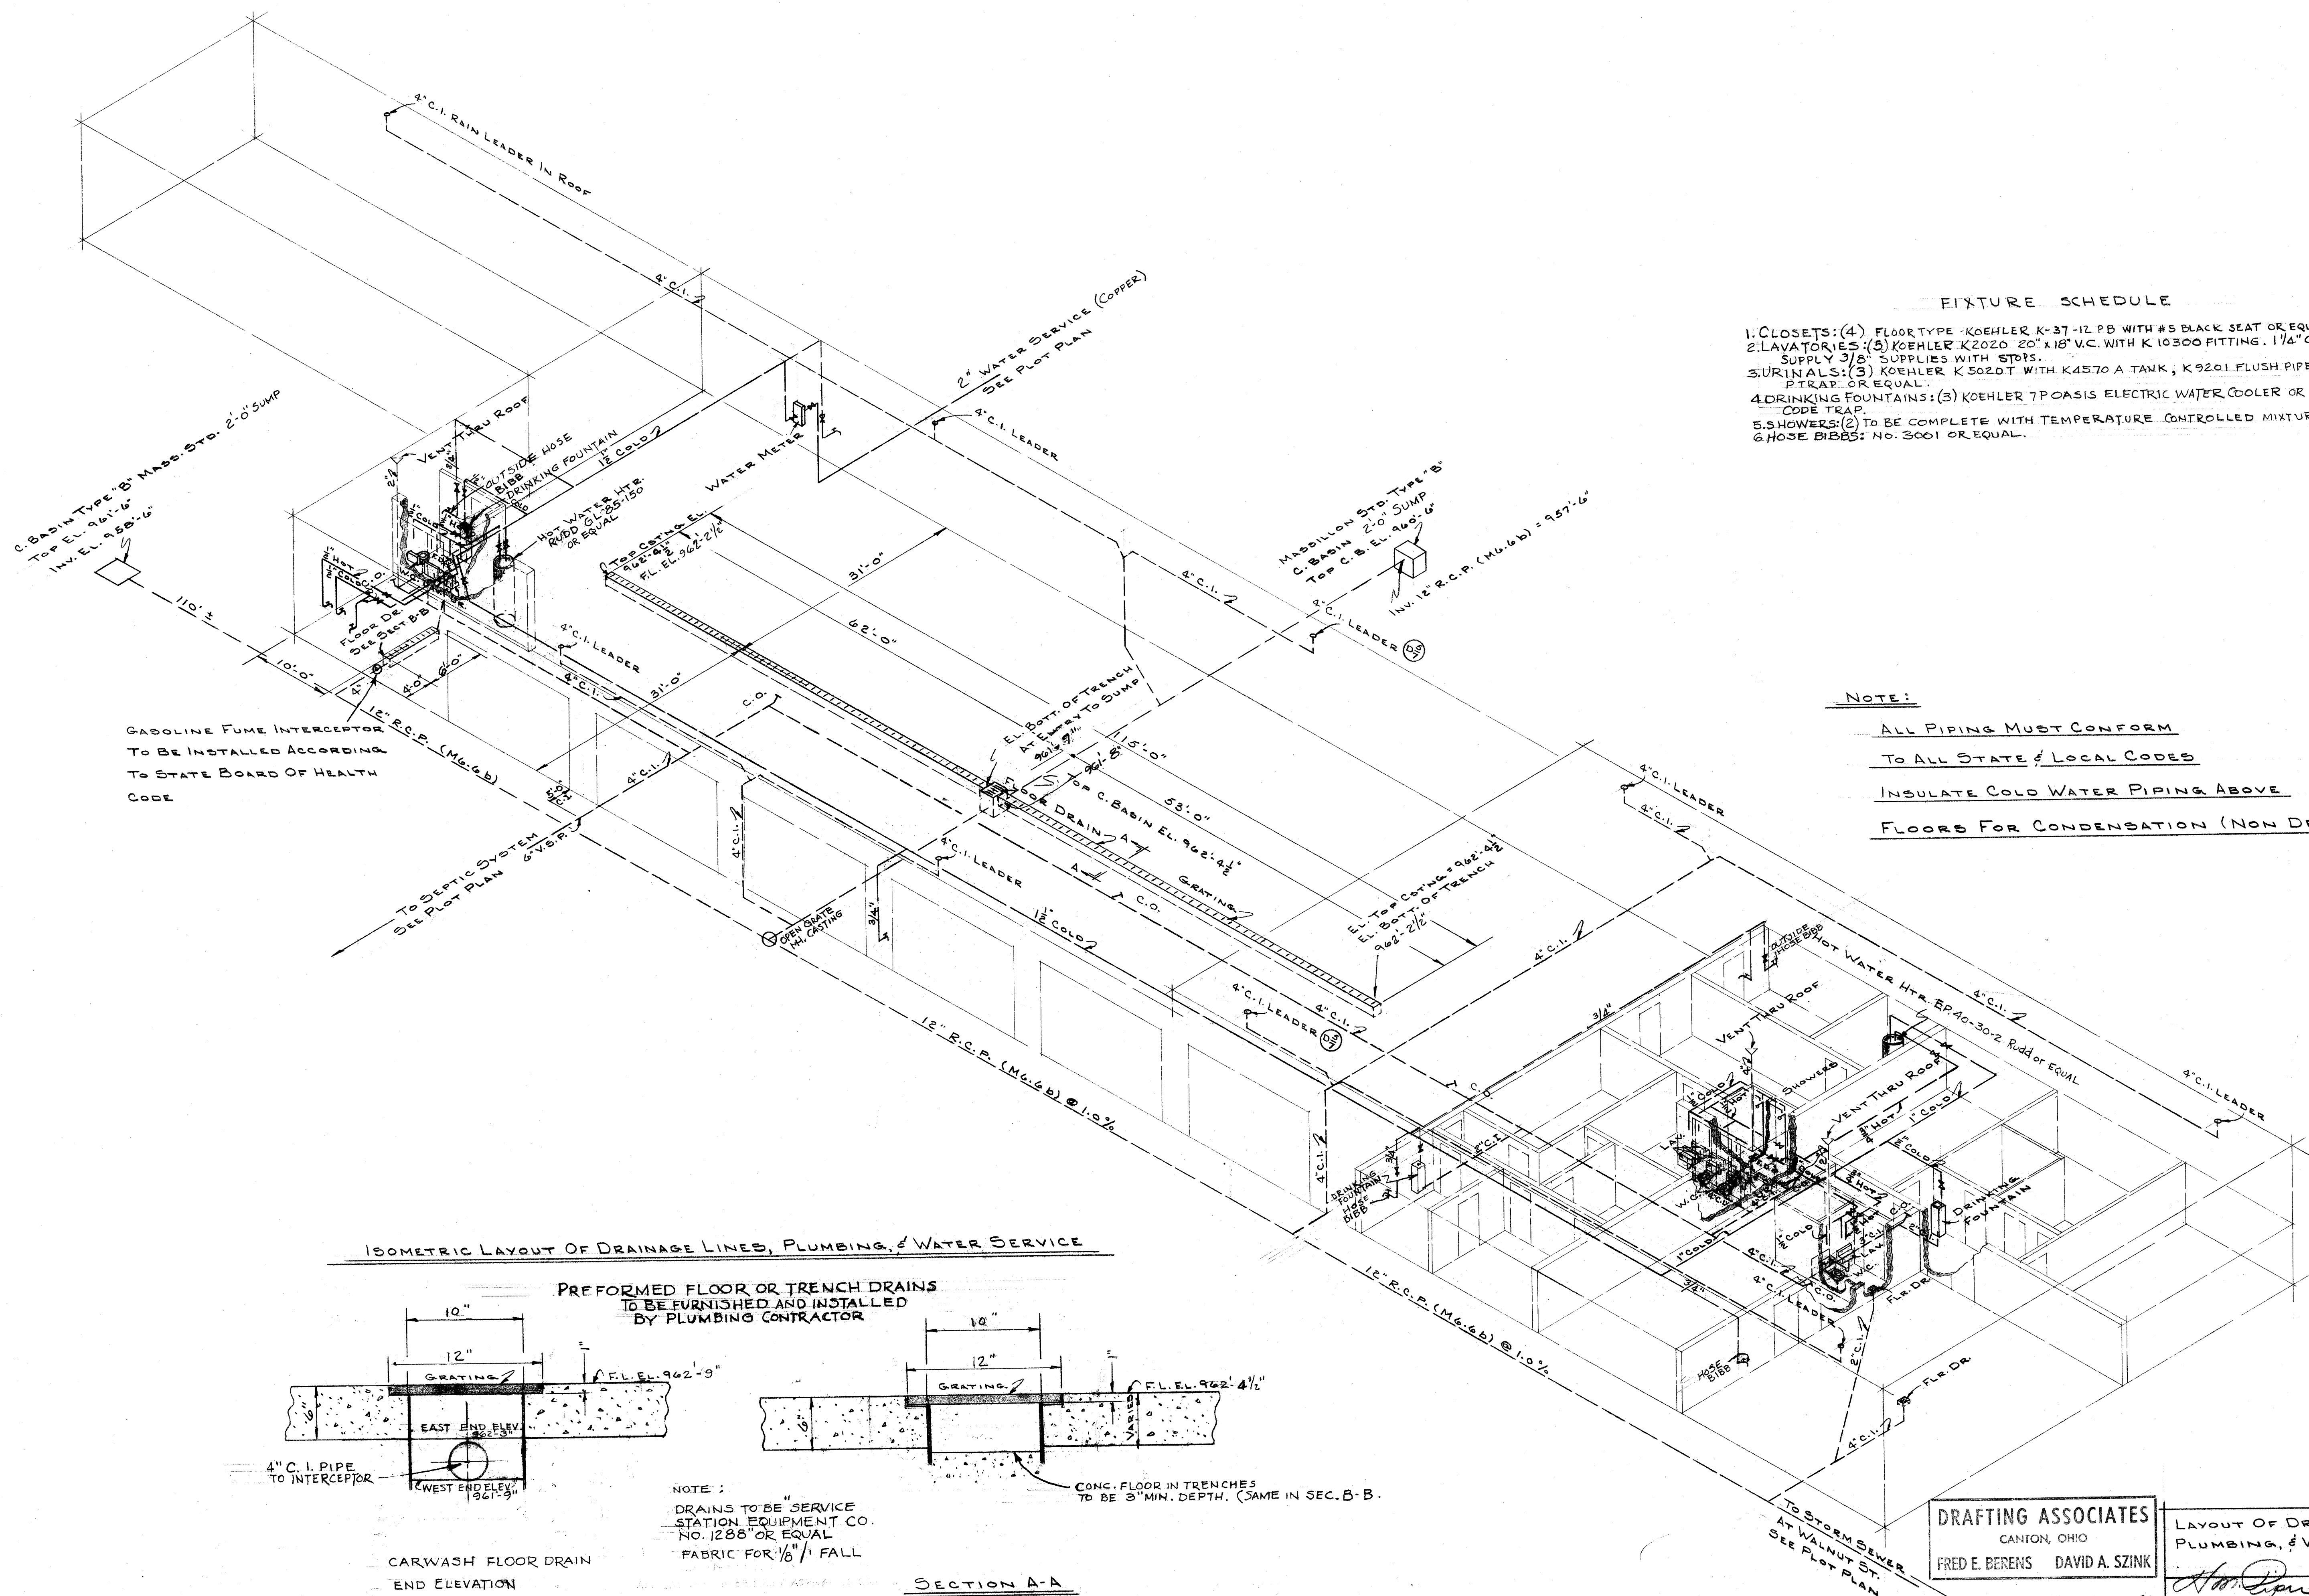

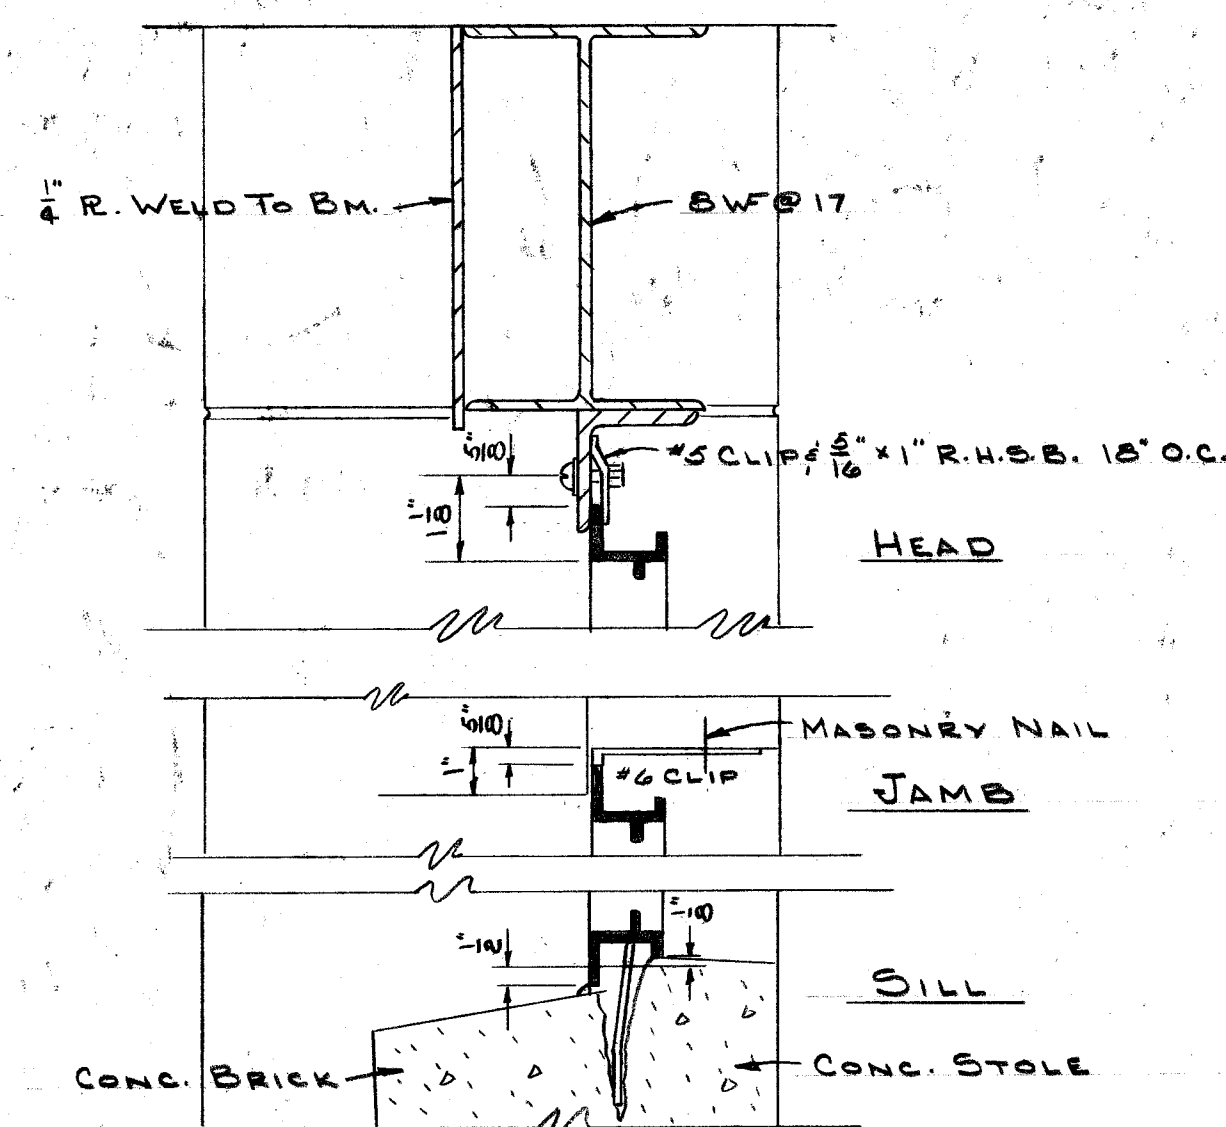



WINDOW DETAIL ①

SCALE: 3" = 1'-0"

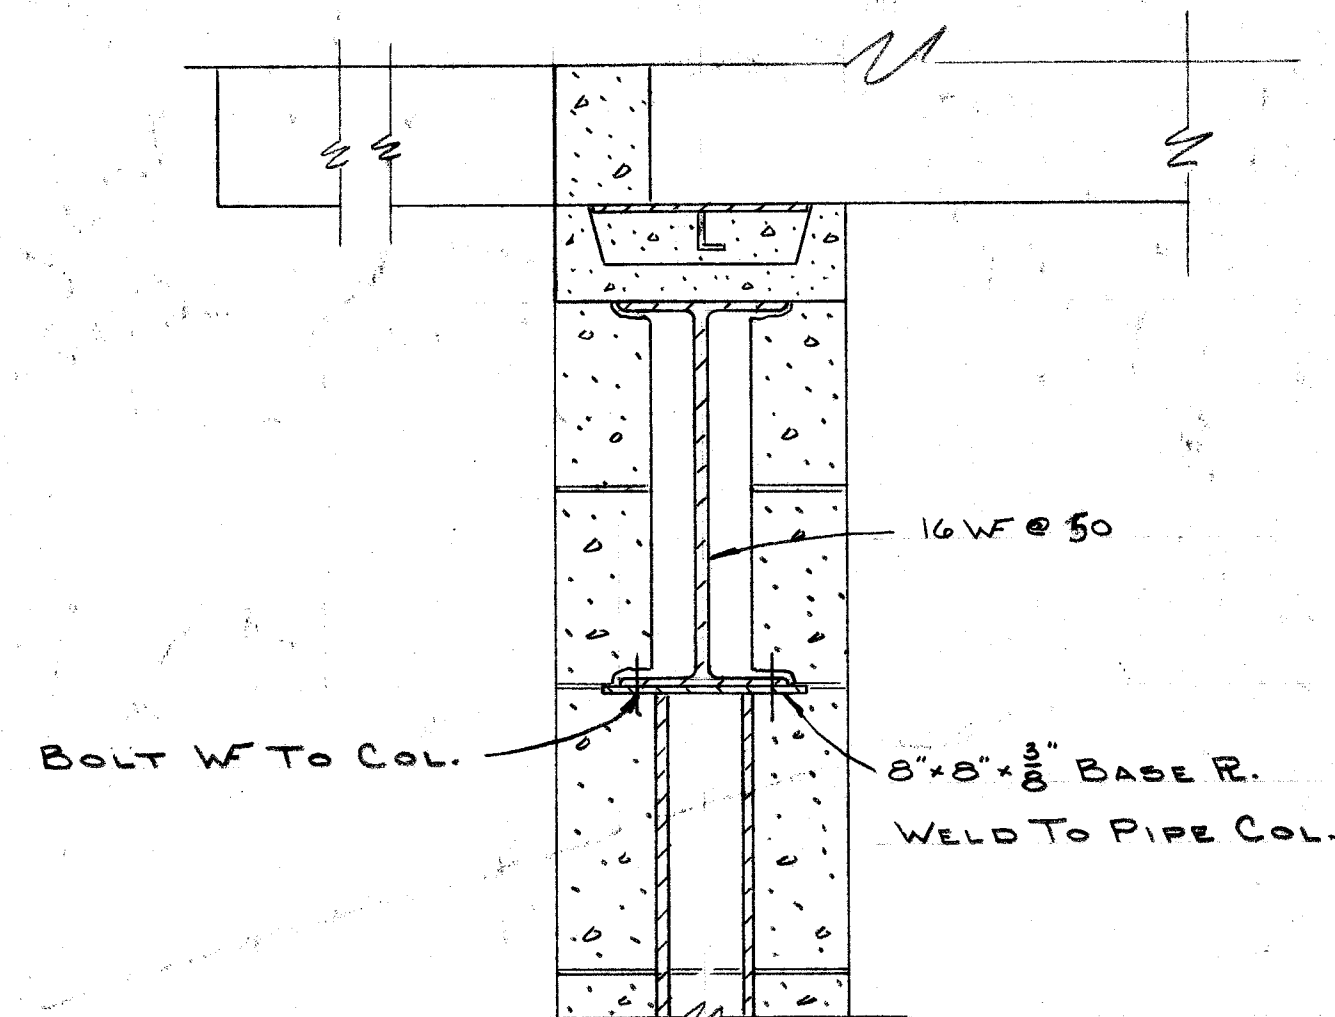


COLUMN ①

SCALE: 1 1/2" = 1'-0"

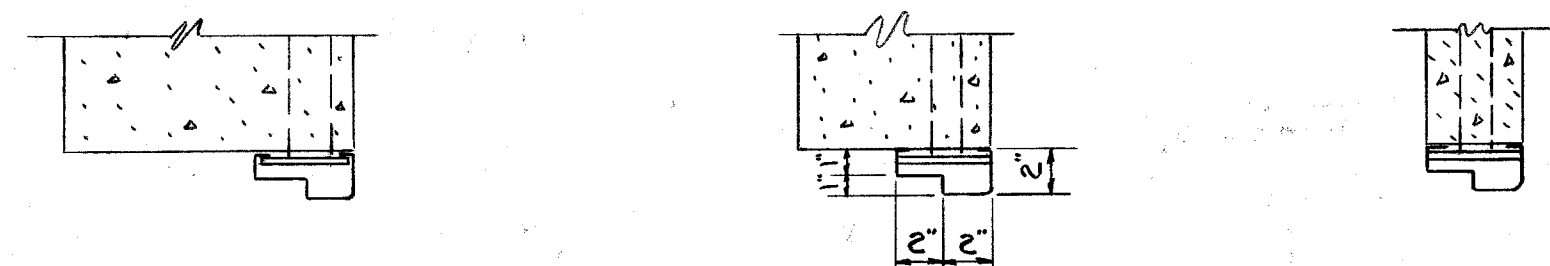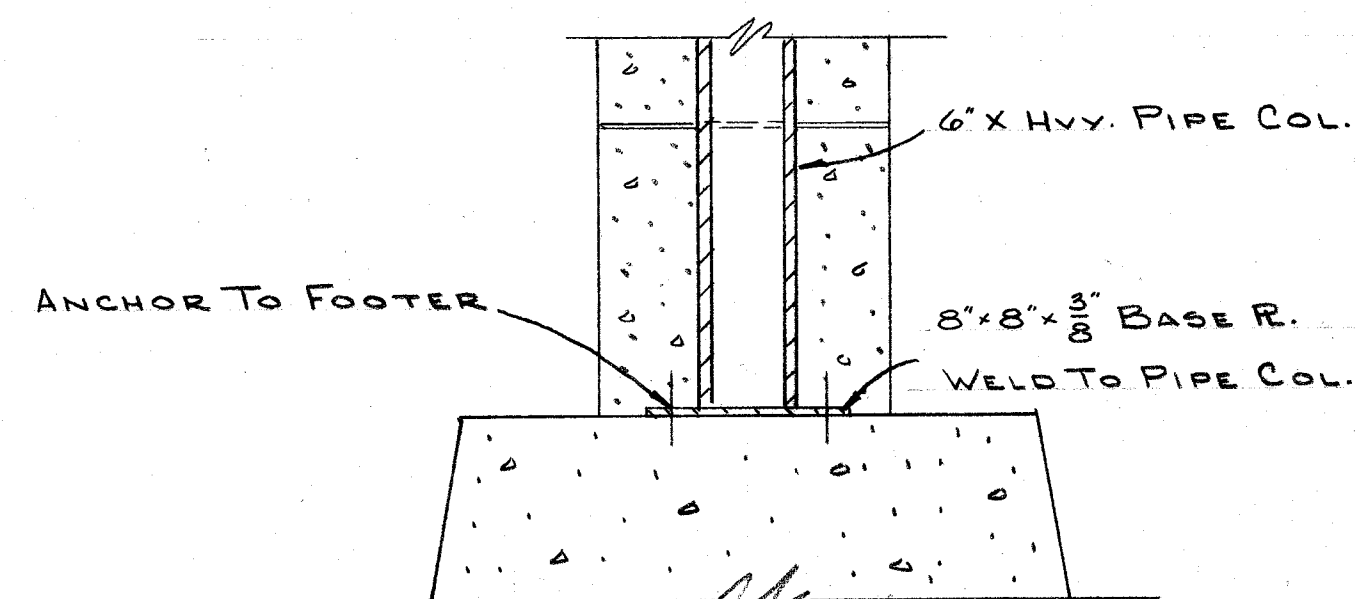


DOOR FRAME TYPICAL METAL ①

SCALE: 1 1/2" = 1'-0"

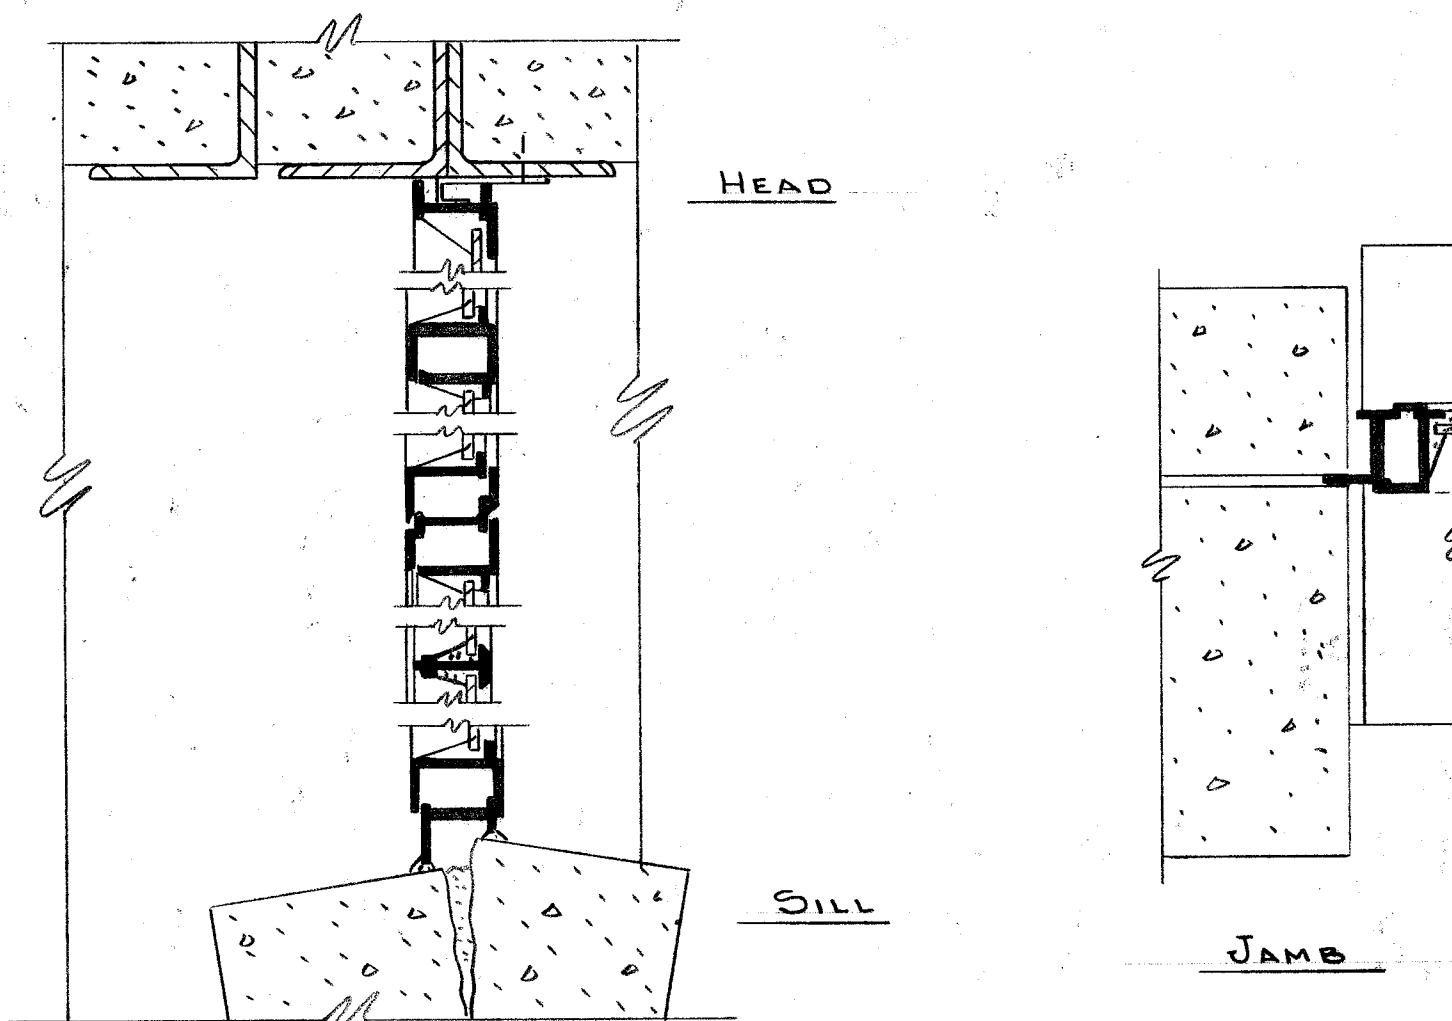

WINDOW DETAIL ②

SCALE: 3" = 1'-0"

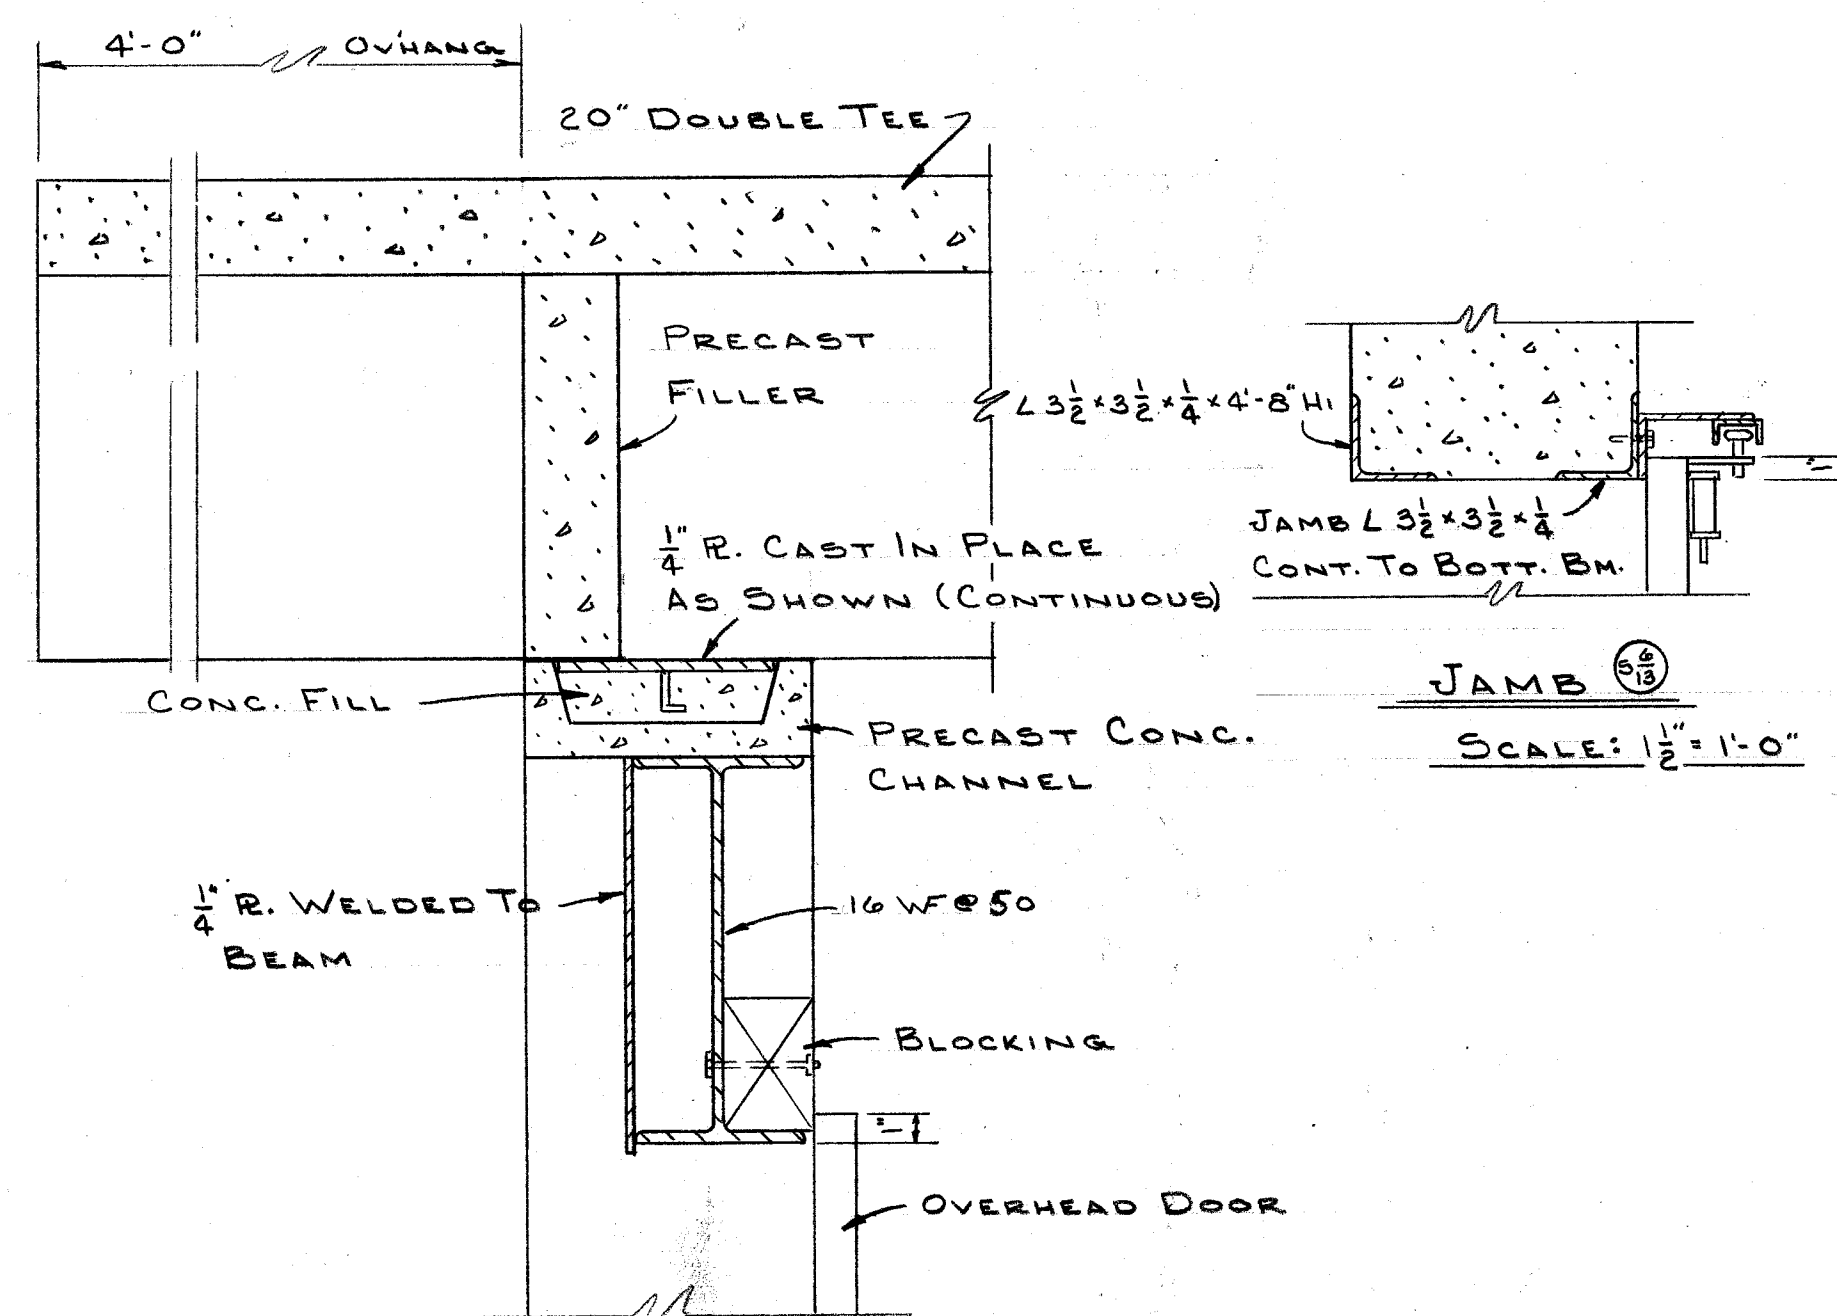


OVERHEAD DOOR HEAD ①

SCALE: 1 1/2" = 1'-0"


JAMB ①

SCALE: 1 1/2" = 1'-0"

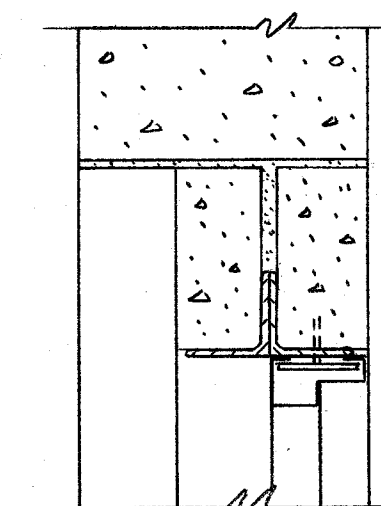


DOOR HEAD ①

SCALE: 1 1/2" = 1'-0"

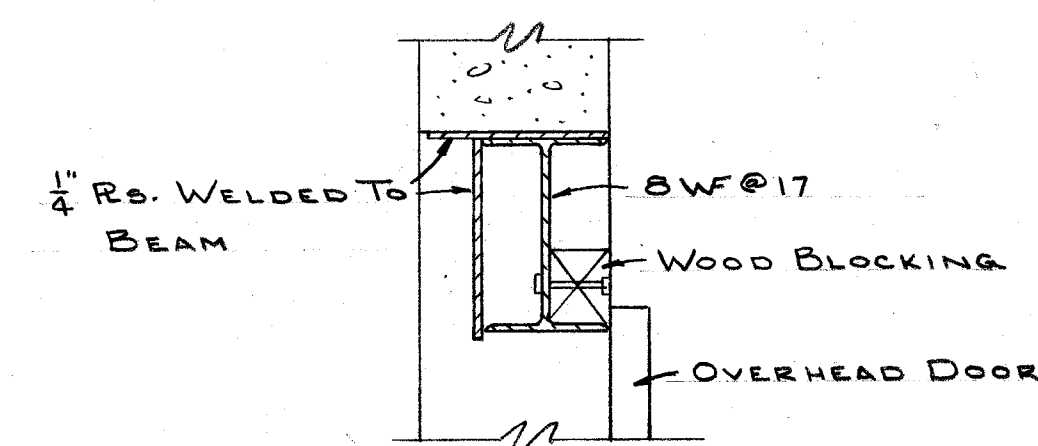

OVERHEAD DOOR HEAD ②

SCALE: 1 1/2" = 1'-0"

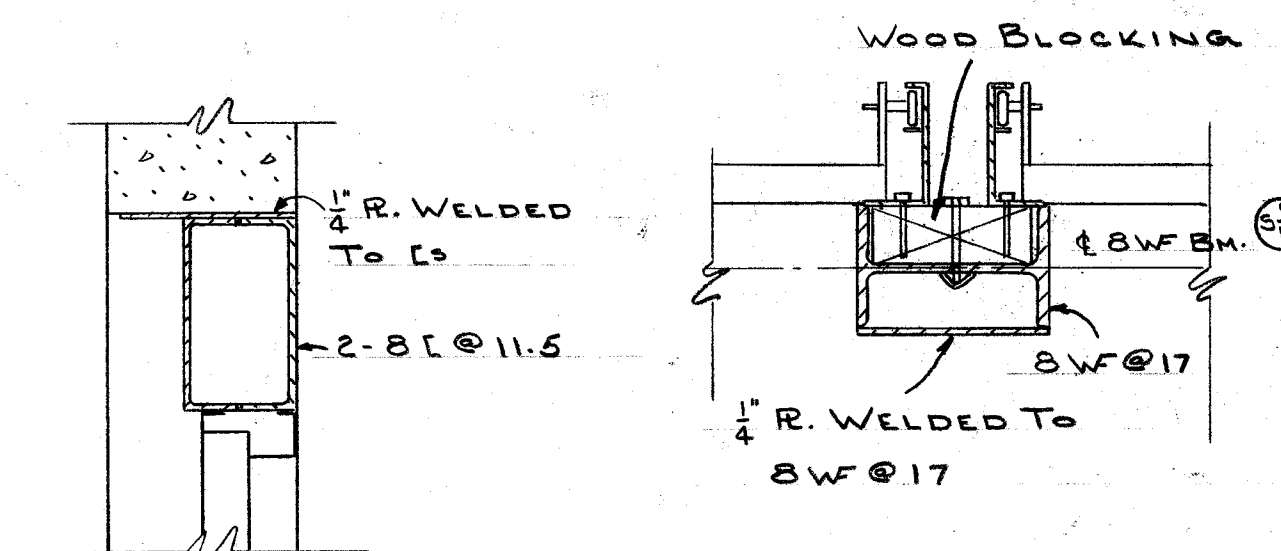


DOOR HEAD ②

SCALE: 1 1/2" = 1'-0"

COLUMN ②

SCALE: 1 1/2" = 1'-0"

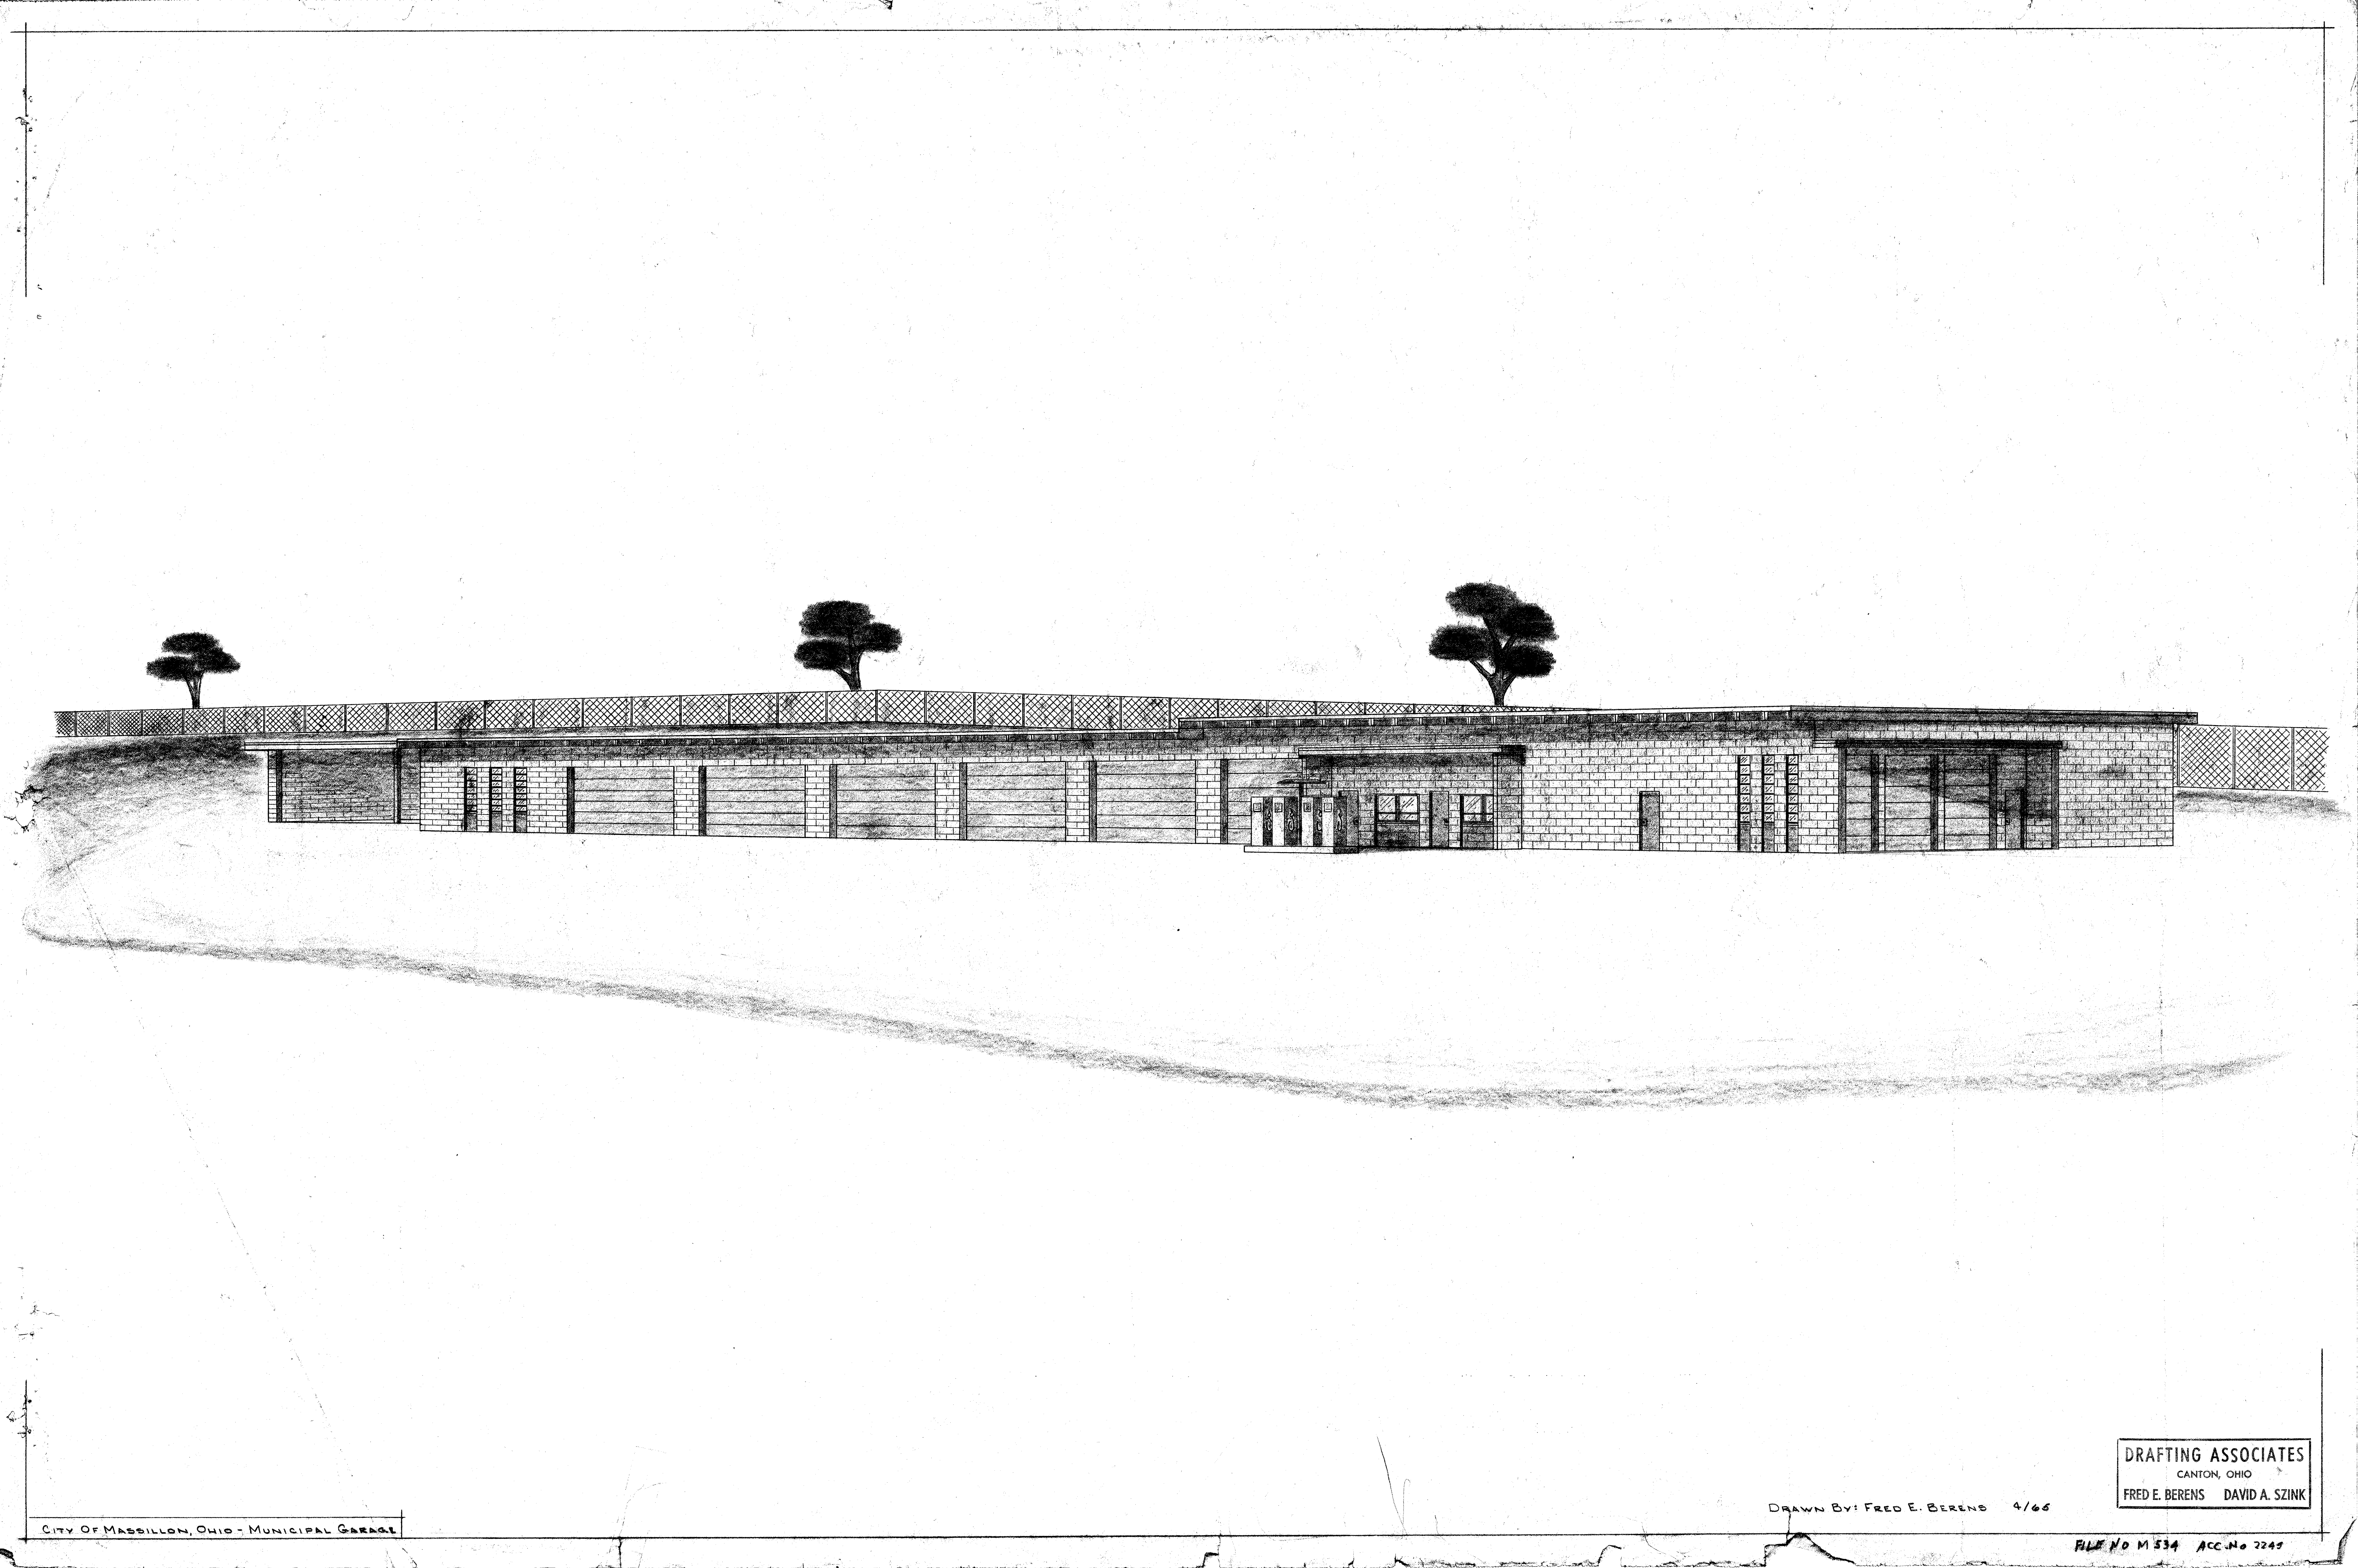


CITY OF MASSILLON, OHIO
MUNICIPAL GARAGE FOR
STREET AND PAINT DEPT'S

WILLIAM KEEN - MAYOR


RAYMOND MARCHAND, SAFETY-SER. DIRECTOR

PREPARED BY CITY ENGINEER'S OFFICE, H.M. PIPER - CITY ENGINEER
ROBERT F. WAGNER - ARCHITECT HAROLD R. RAUBER - BUILDING INSPECTOR


JANUARY, 1963

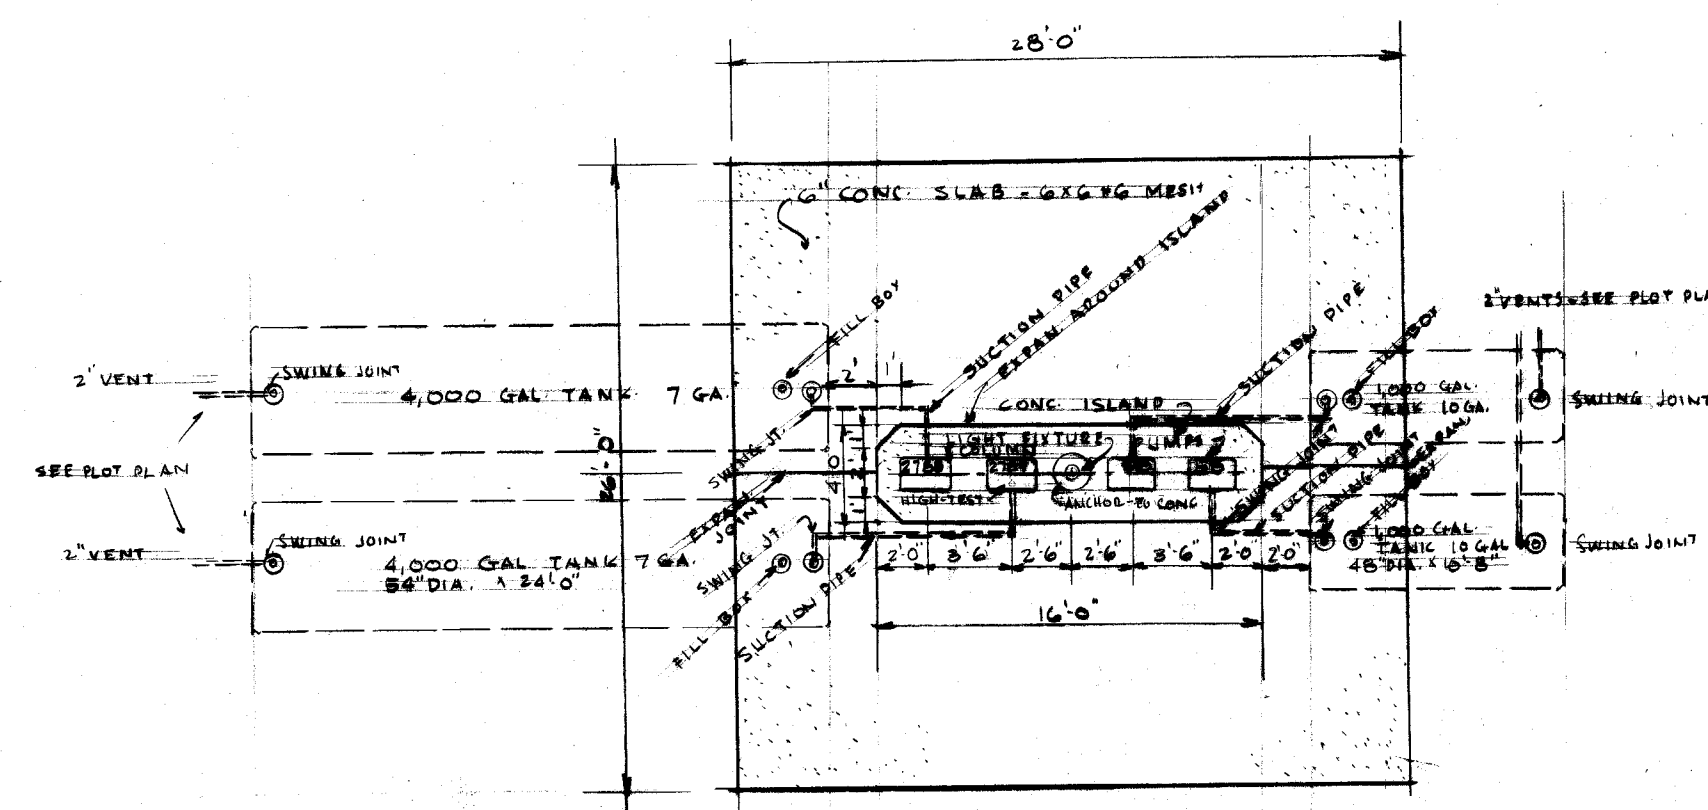

PUMP ISLAND PLAN
SCALE 1/8" = 1'-0"

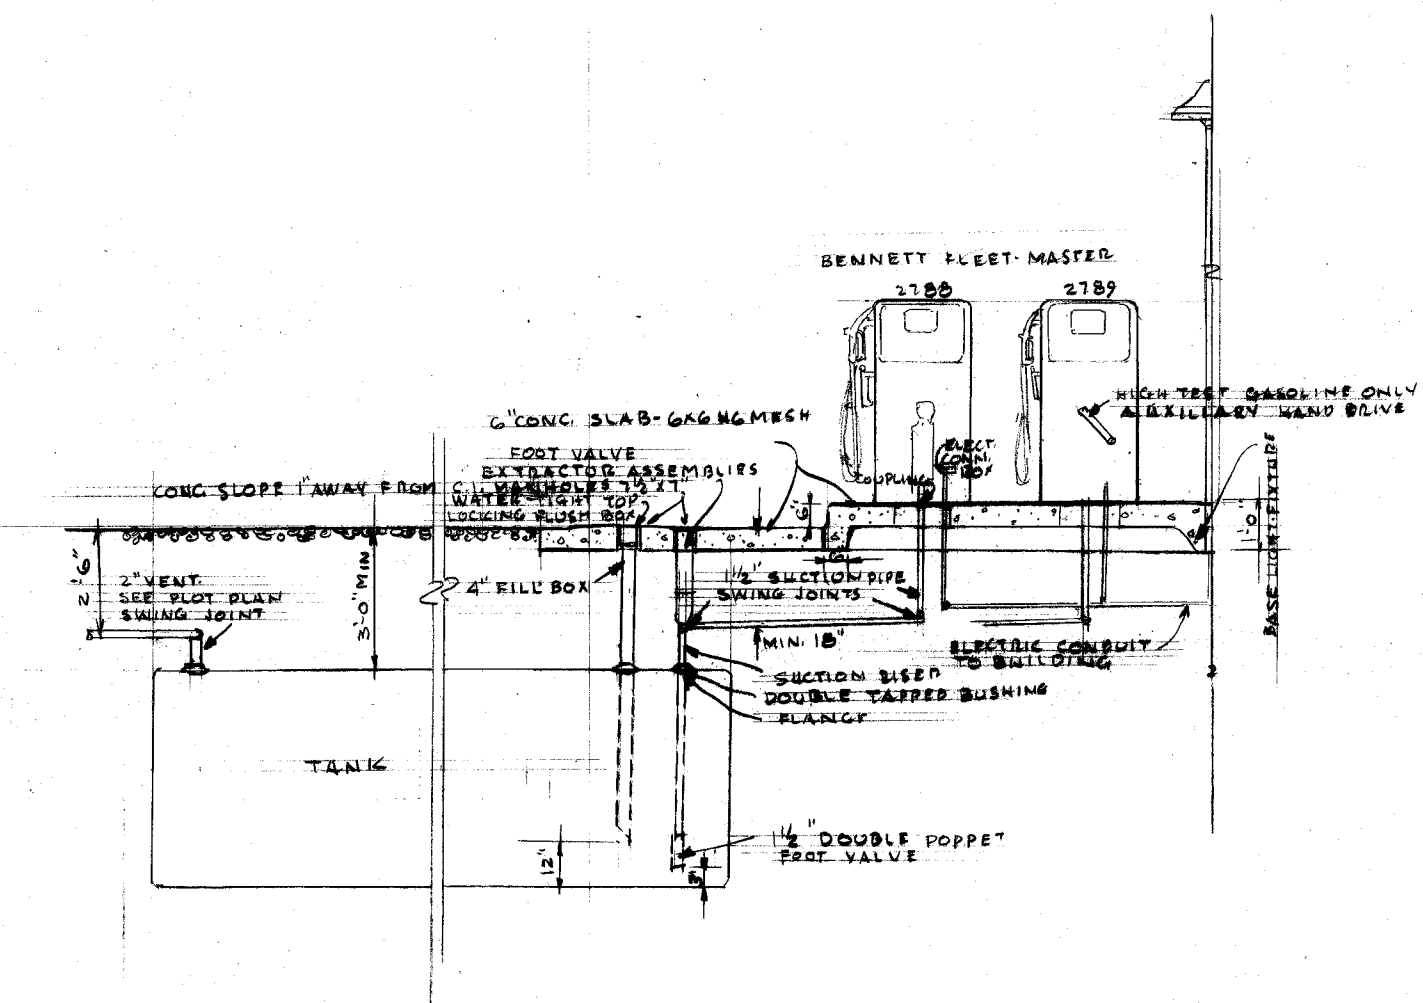

PUMP ISLAND SECTION
SCALE 1/4" = 1'-0"

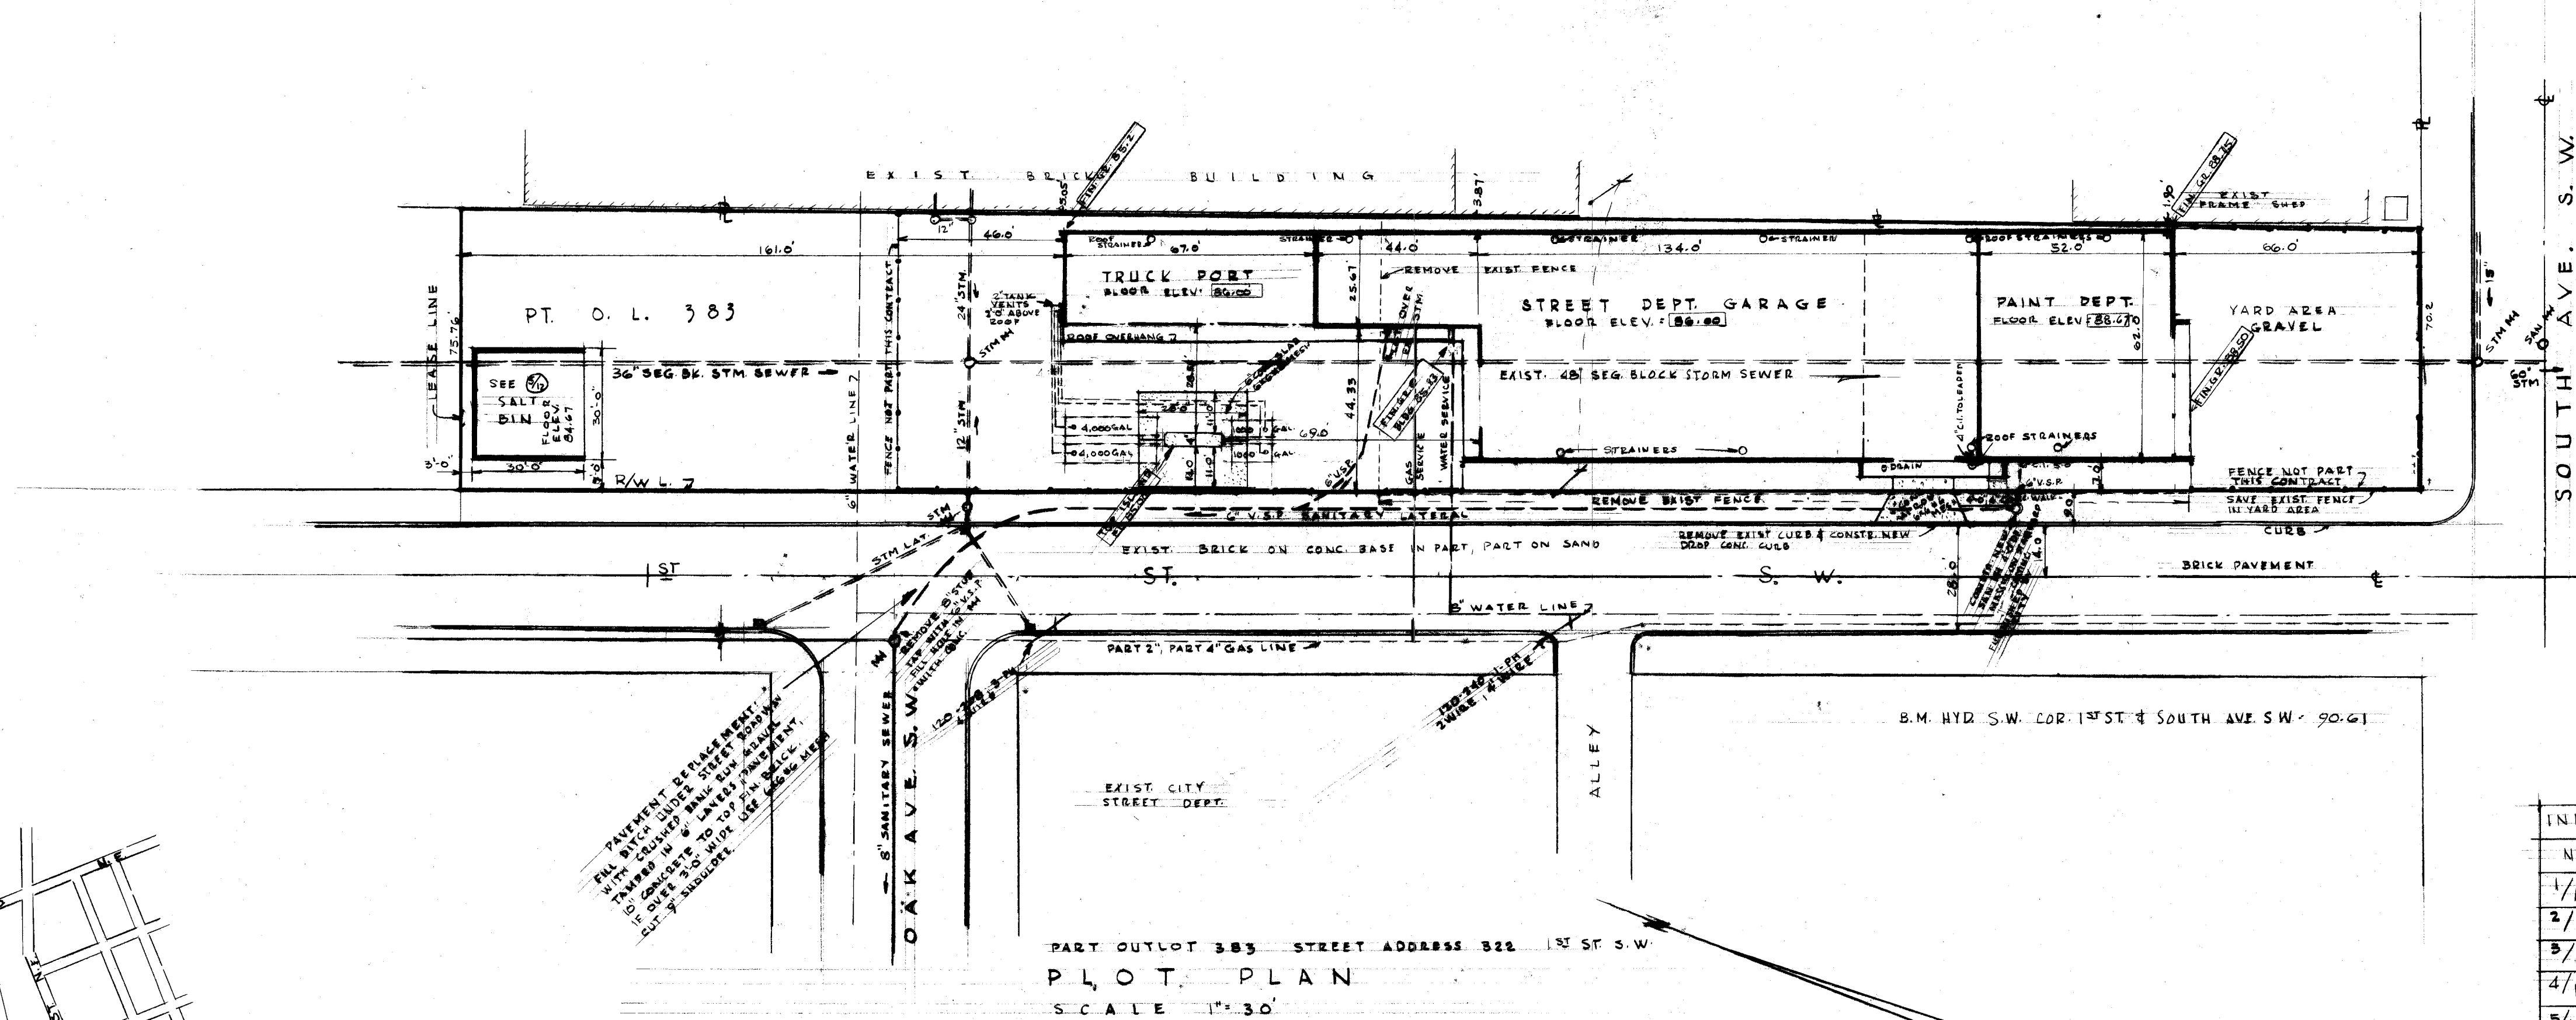

S I T E M A P S C A L E 1" = 500'

INDEX TO SHEETS	
NO	DESCRIPTION
1/12	1. PLOT PLAN, SITE MAP, INDEX, TITLE, GASOLINE & FUEL SYSTEM
2/12	2. FOUNDATION PLAN, X-SECTIONS FOOTING (64) (65)
3/12	3. FIRST FLOOR PLAN - TYPICAL DOOR- (66) (67)
4/12	4. SECOND FLOOR PLANS, STEEL STAIRS, CONC. STEPS (68) (69) (70)
5/12	5. WEST & NORTH ELEVATIONS SALT BIN, PLAN, S ELEVATIONS
6/12	6. EAST & SOUTH ELEVATIONS
7/12	7. BUILDING SECTIONS A-A & B-B
8/12	8. SECTIONS C-C & D-D DOOR & WINDOW DETAIL (71) (72) (73)
9/12	9. SECTION E-E FACIA DETAILS (74) (75) (76) (77) (78) (79)
10/12	10. STRUCTURAL PLAN HEAD DETAILS (80) to (89)
11/12	11. HEATING & PLUMBING PLANS
12/12	12. ELECTRICAL PLAN


DETAIL SYMBOL **SHEET SYMBOL**

DETAIL NO.
SHEET NO.


SHEET NO.
TOTAL SHEETS

M = MISC.
F = FOOTING
D = GENERAL DETAILS
S = STRUCTURAL


PLOT PLAN SITE MAP INDEX, TITLE GASOLINE & FUEL SYSTEM	
FILE NO. 534 ACC. NO. 2249	SHEET NO.

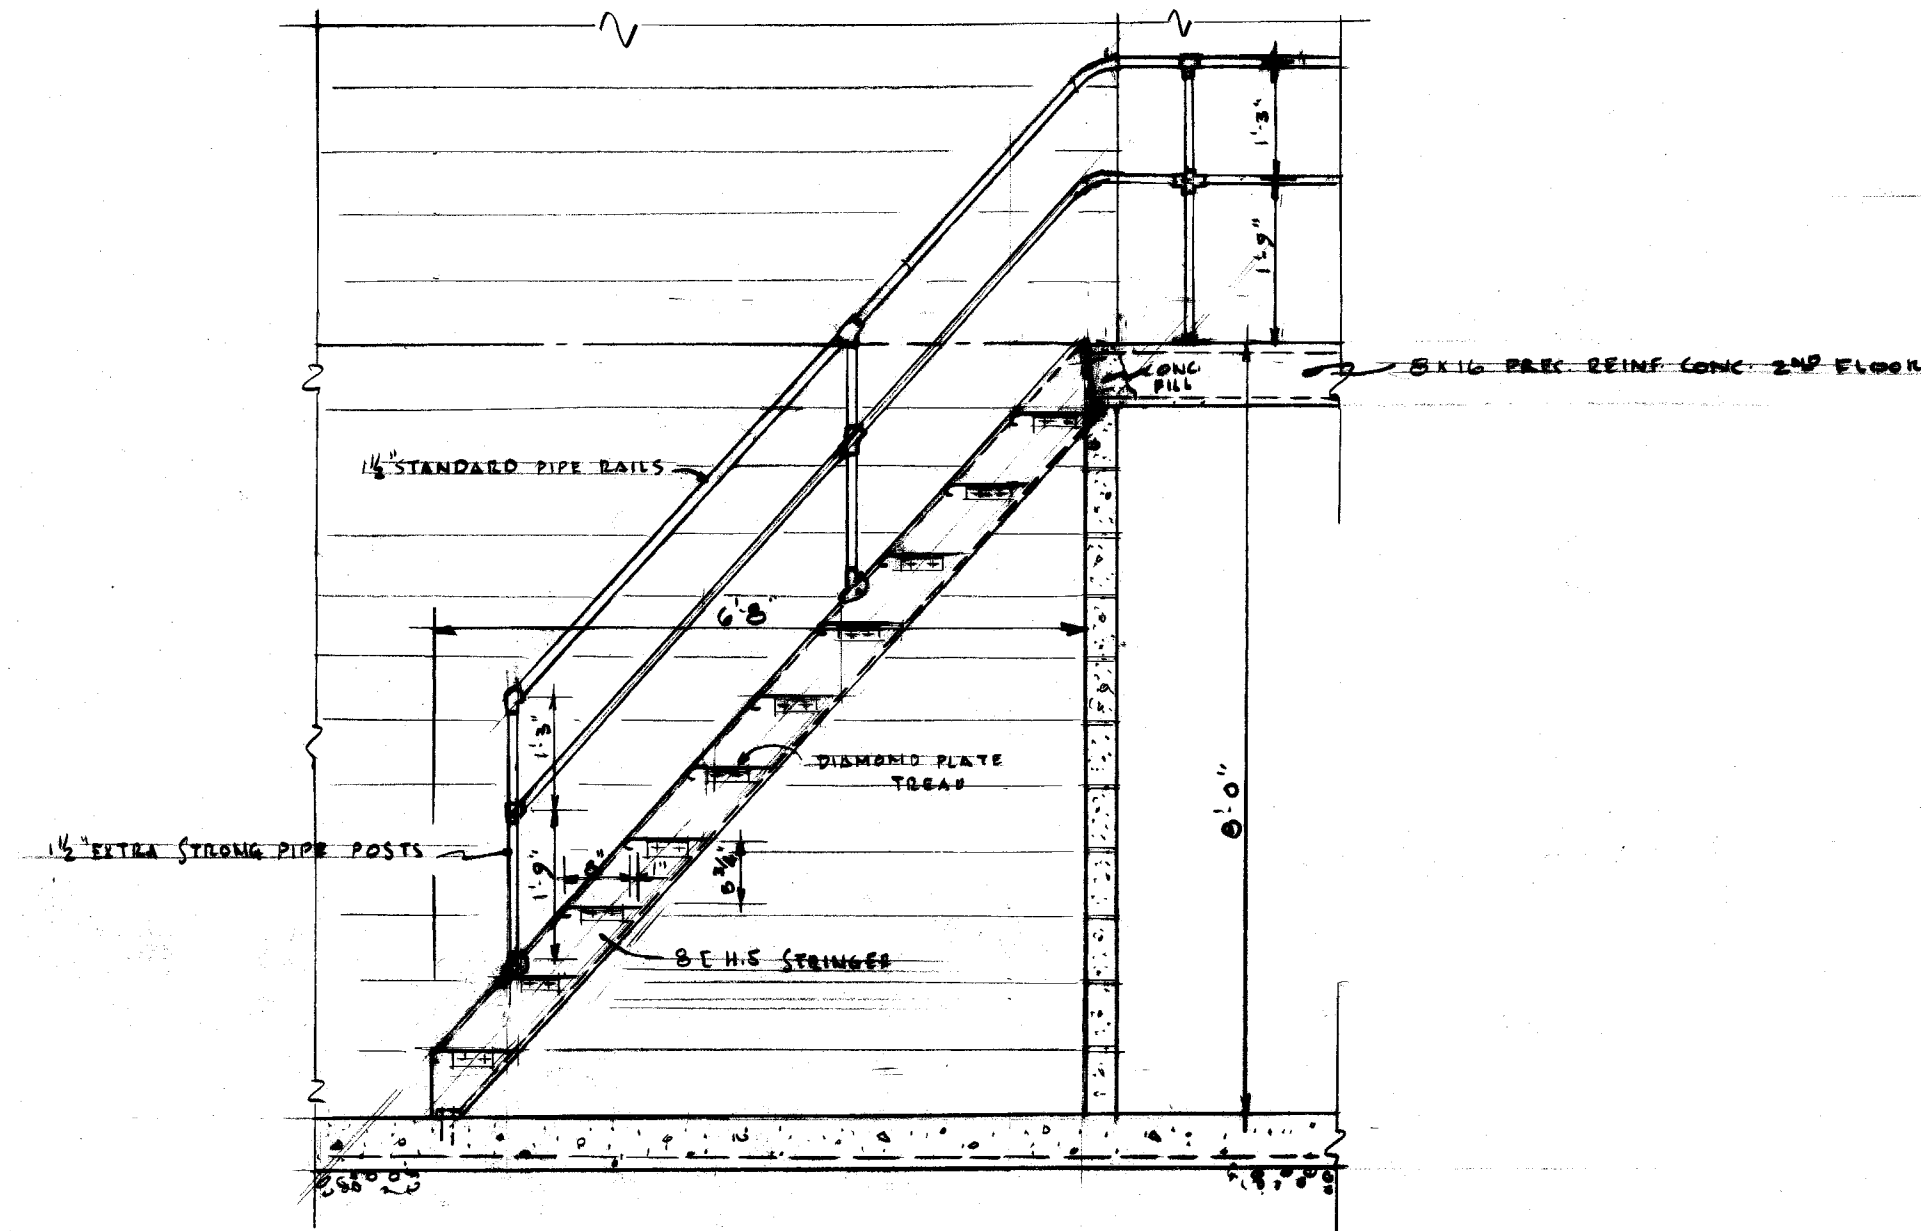


STEEL STAIR TO 2ND FLOOR STREET DEPT. (M)
SCALE 1/2" = 1'-0"

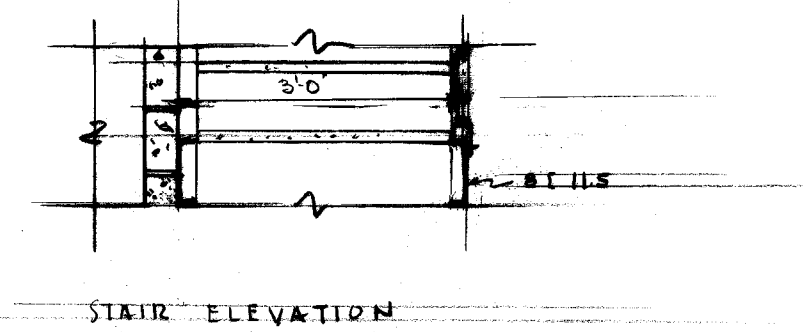


STAIR ELEVATION

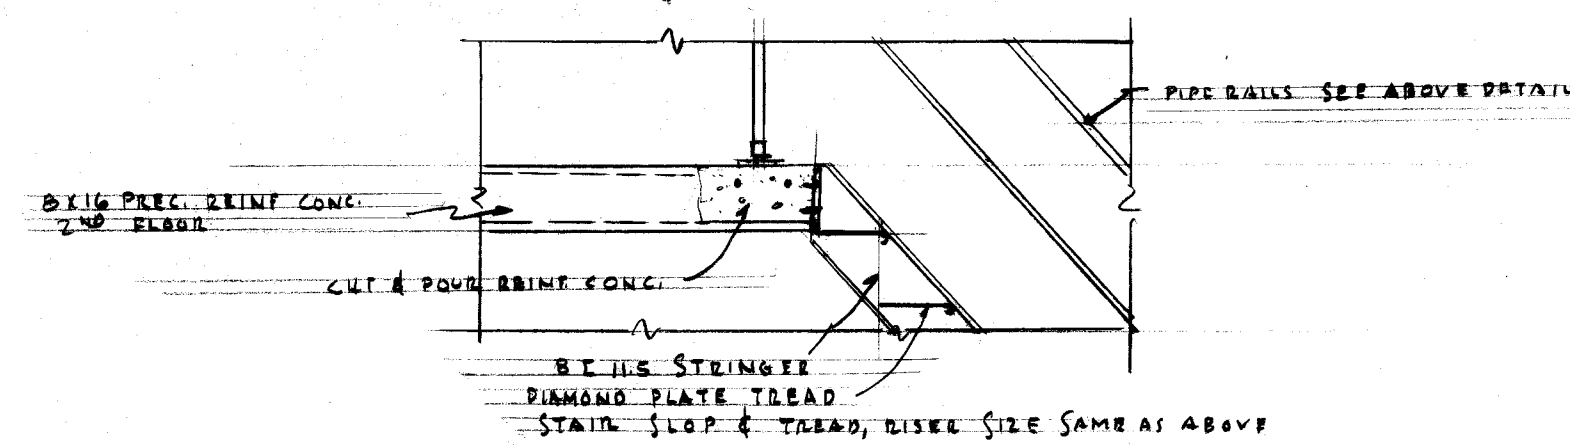


STEEL STAIR TO 2ND FLOOR PAINT DEPT. (M)
SCALE 1/2" = 1'-0"

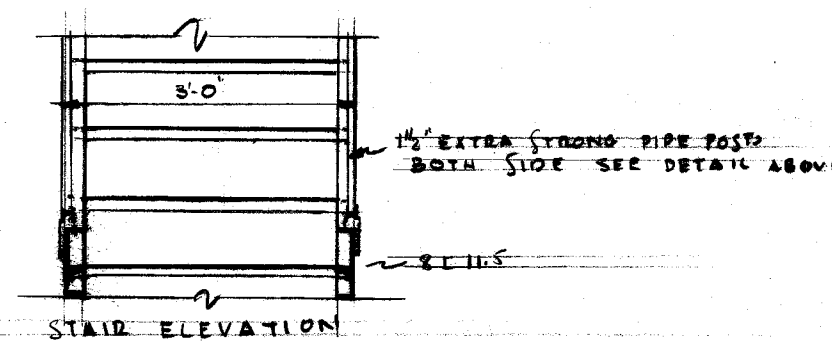


STAIR ELEVATION

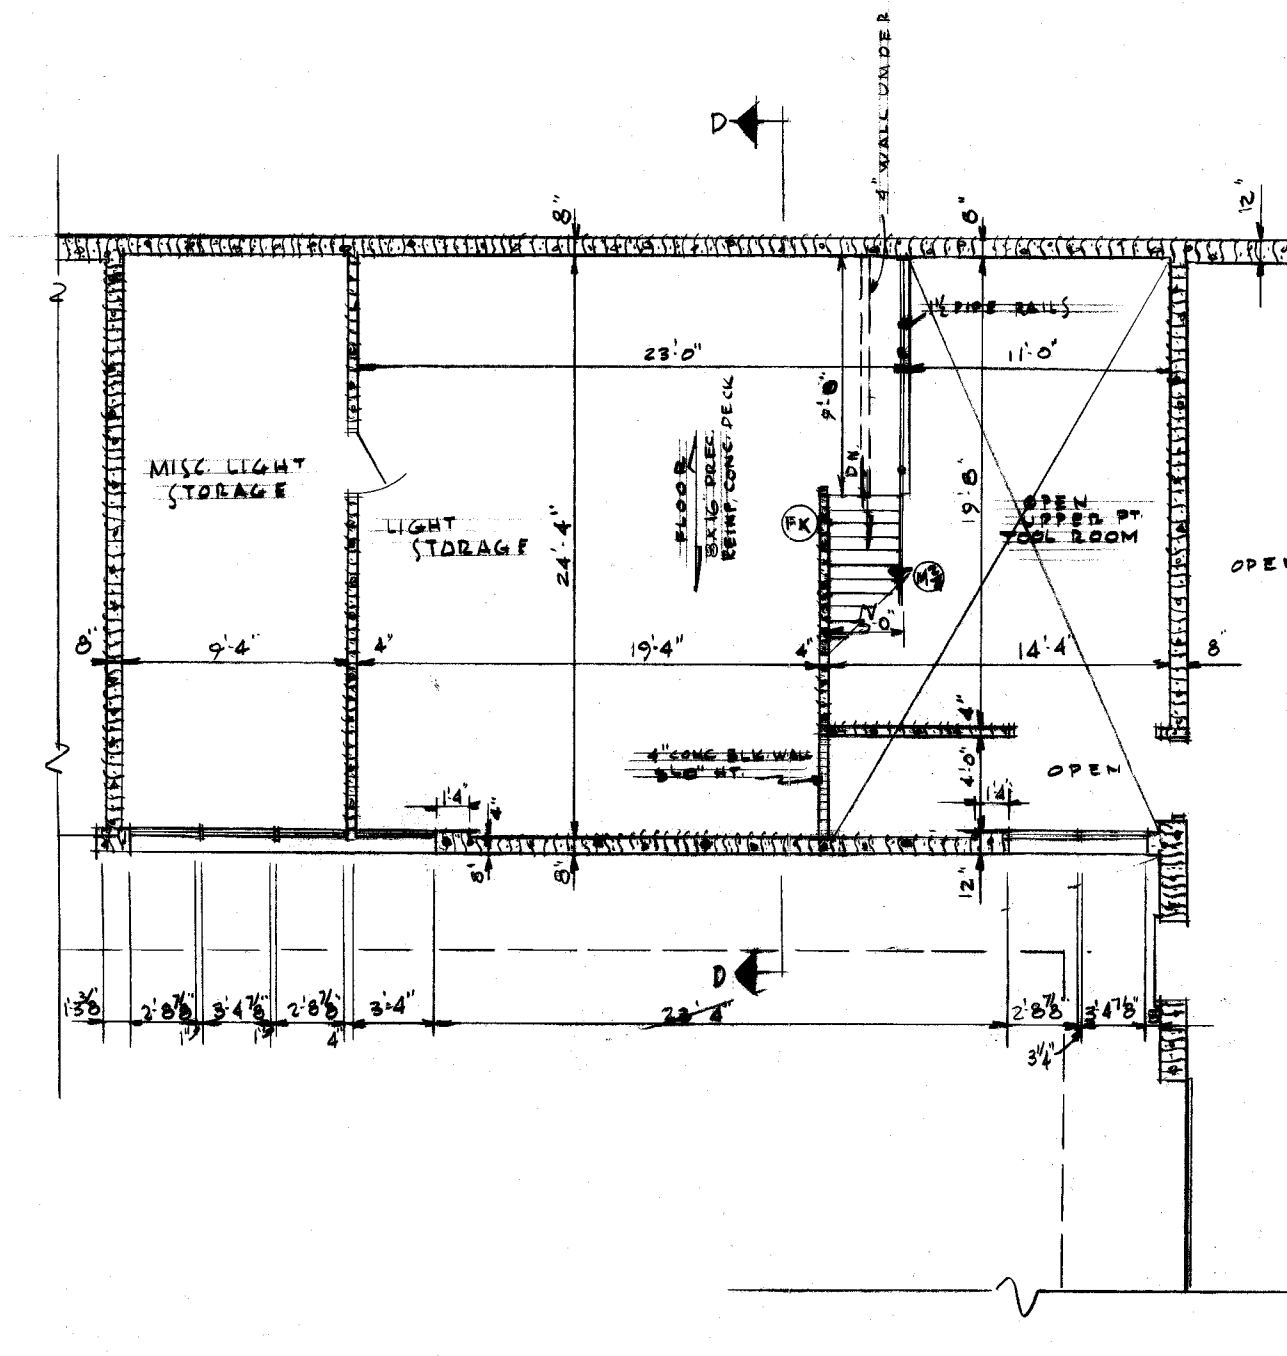


SECOND FLOOR - STREET DEPT.
SCALE 1/8" = 1'-0"

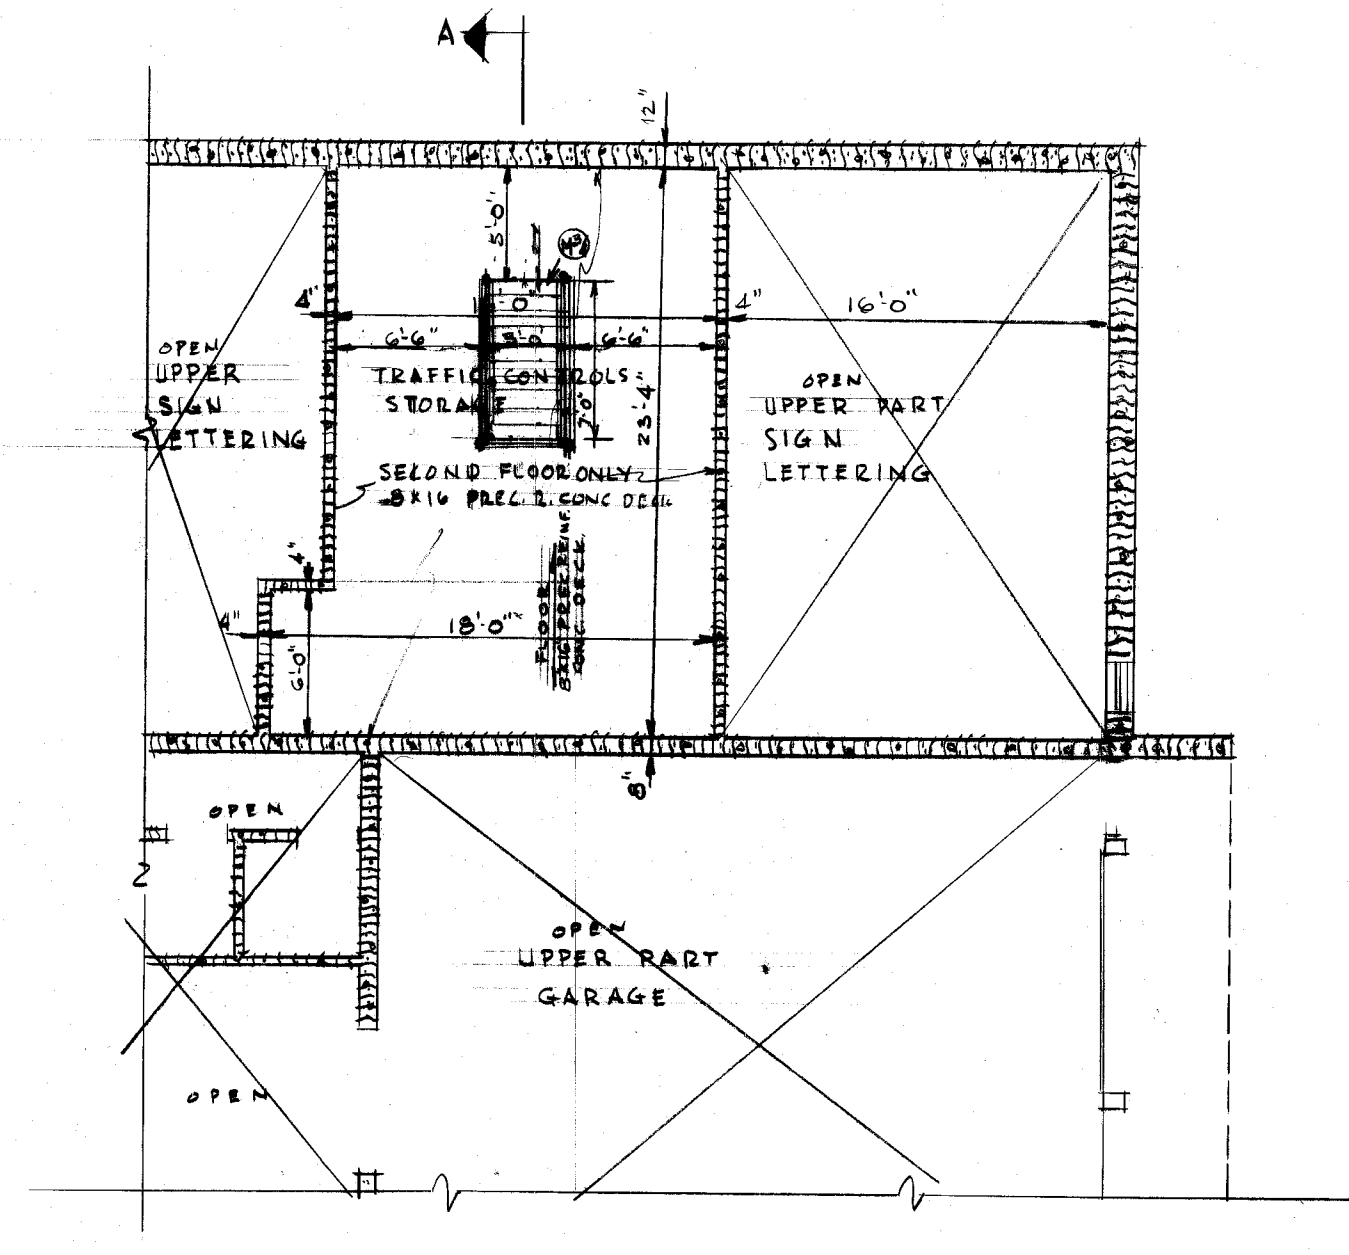


SECOND FLOOR PAINT DEPT.
SCALE 1/8" = 1'-0"

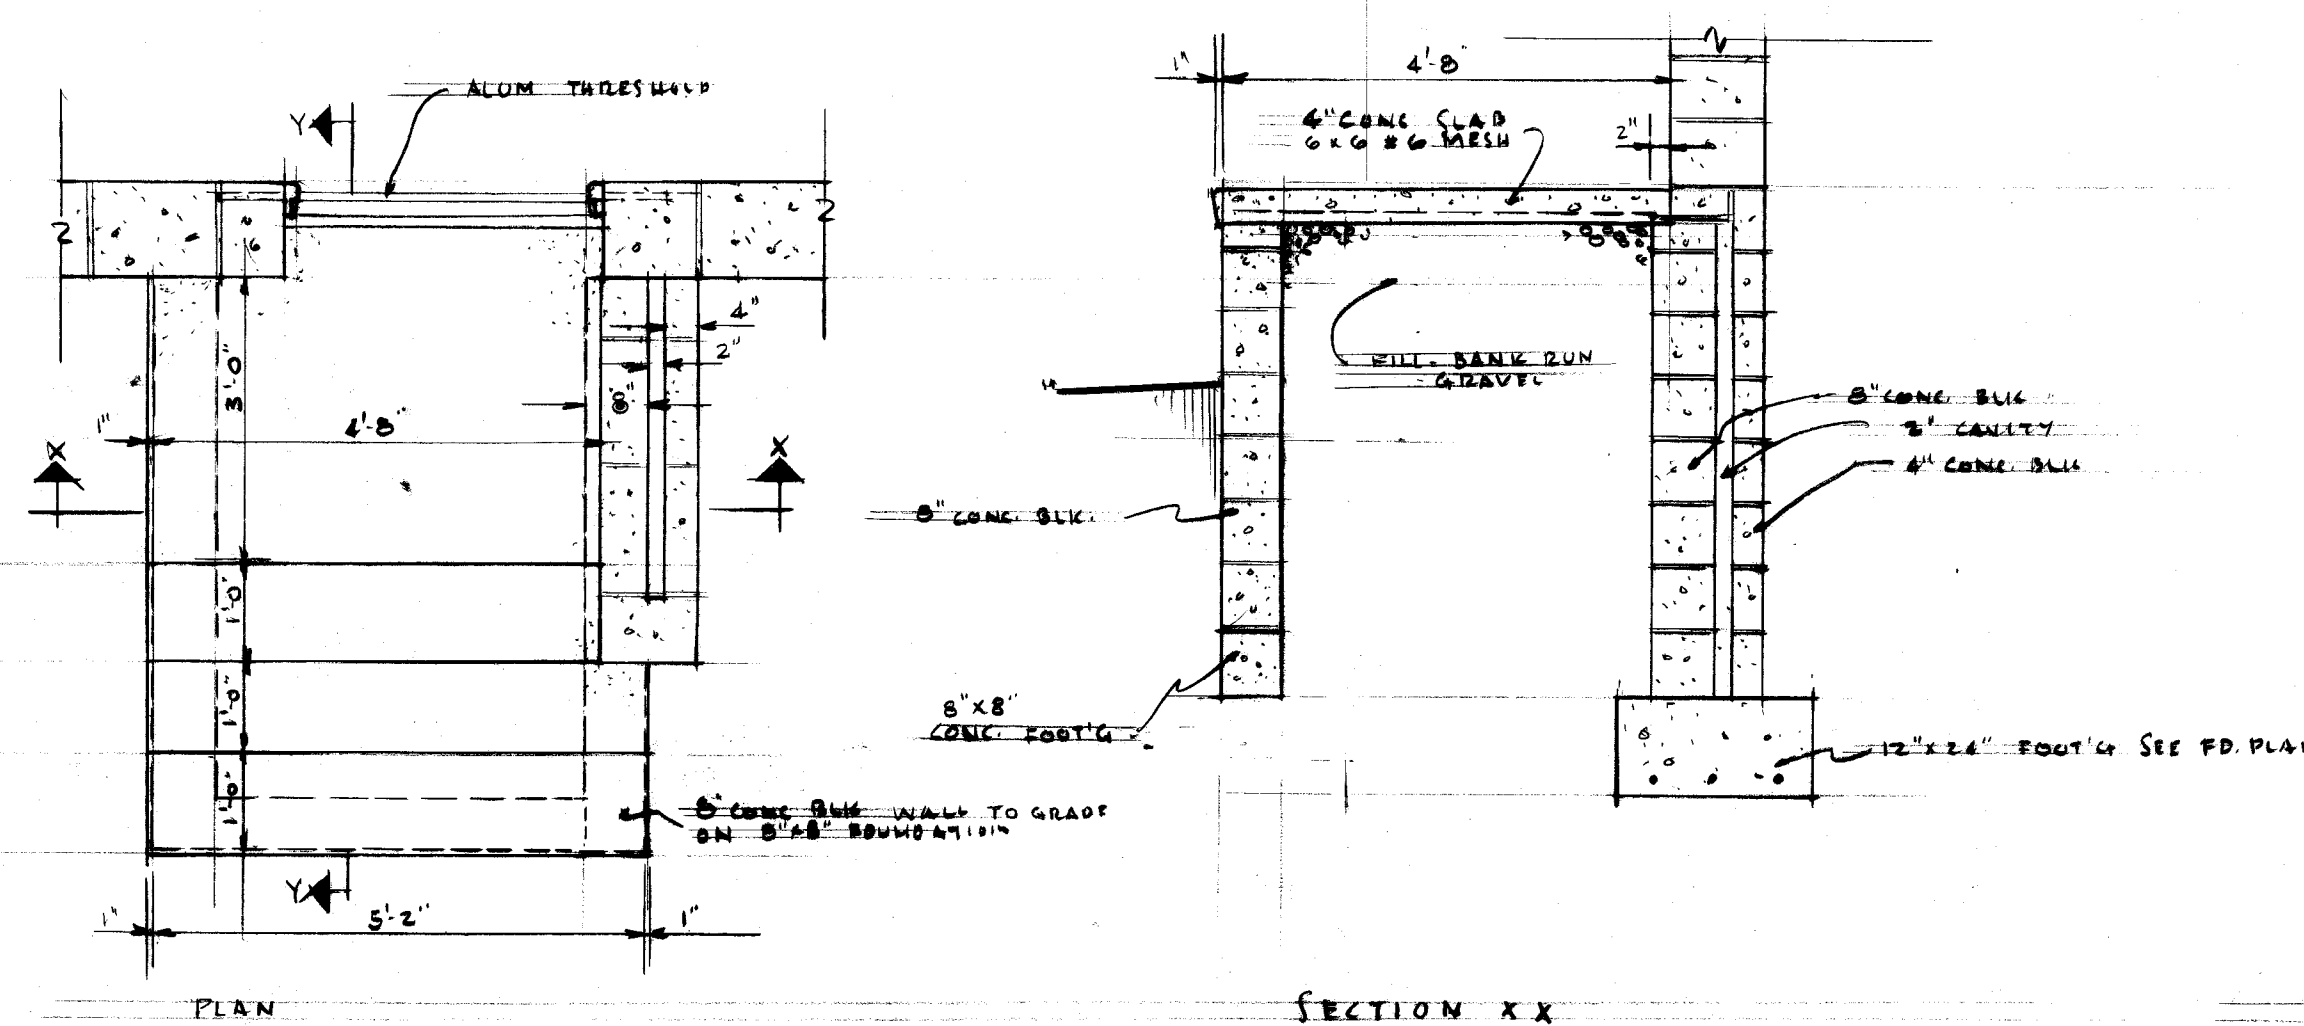


CONCRETE STEPS - PAINT DEPT. WEST EXIT. (M)
SCALE 1/2" = 1'-0"

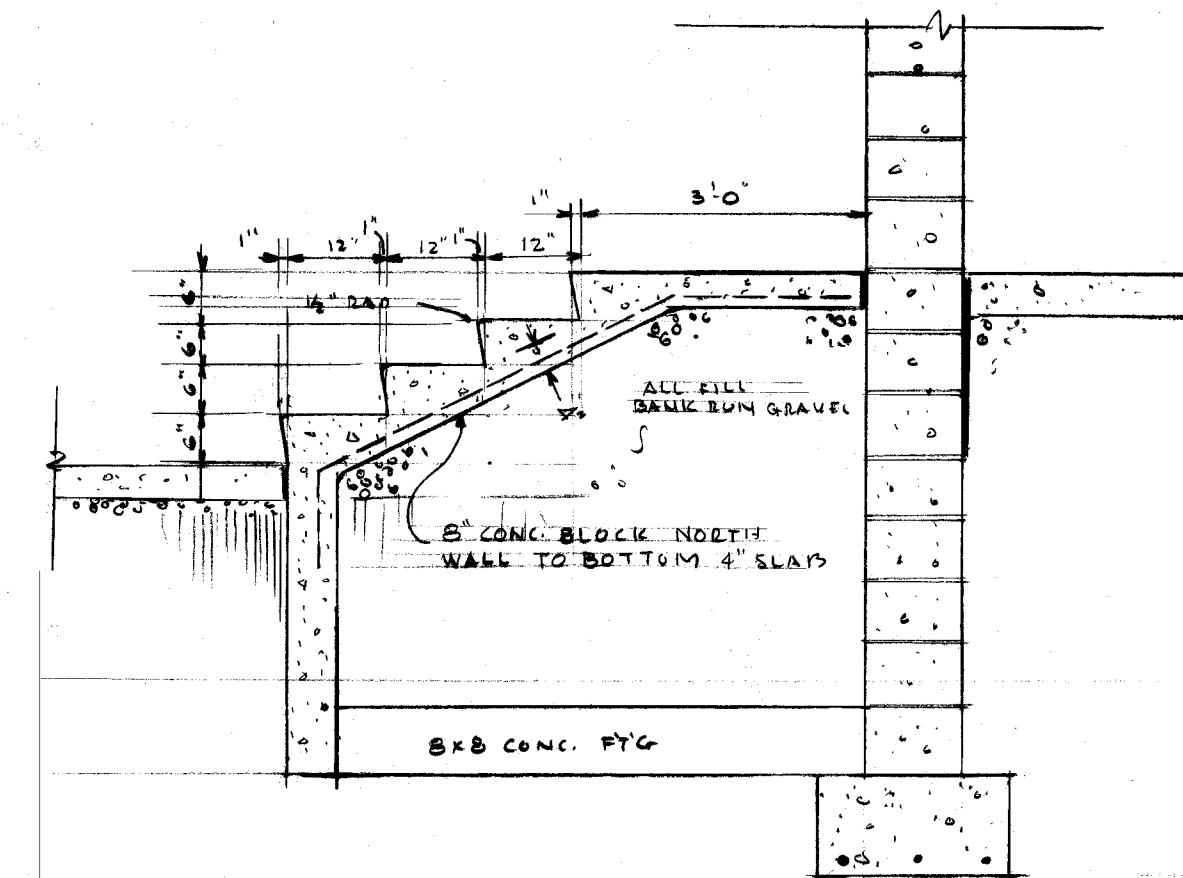

SECTION YY

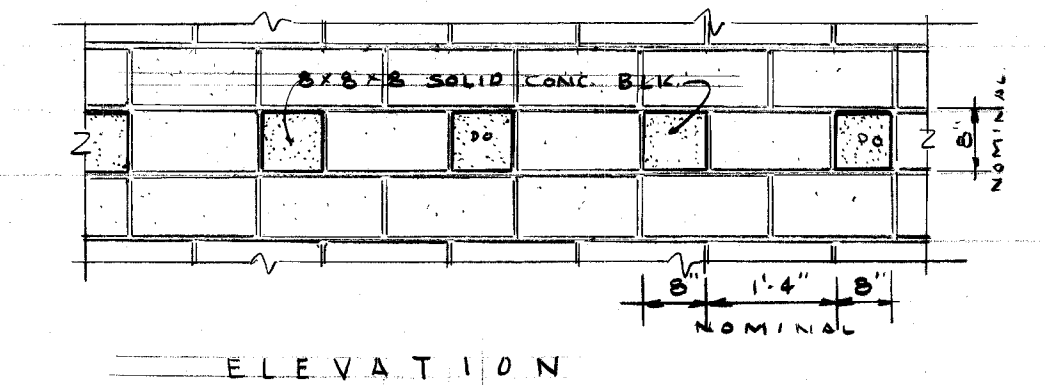


ELEVATION

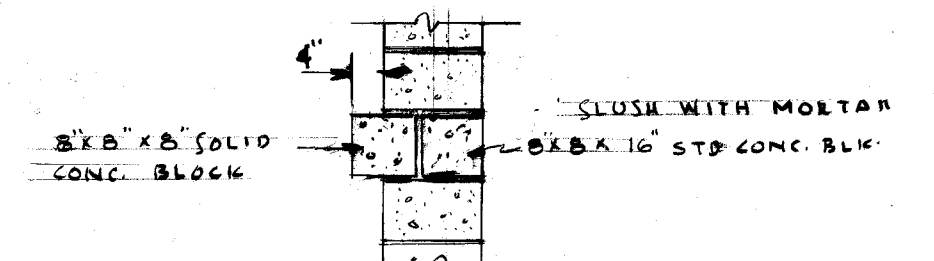


SECTION


SHADOW BLOCK DETAIL (M)
SCALE 1/2" = 1'-0"

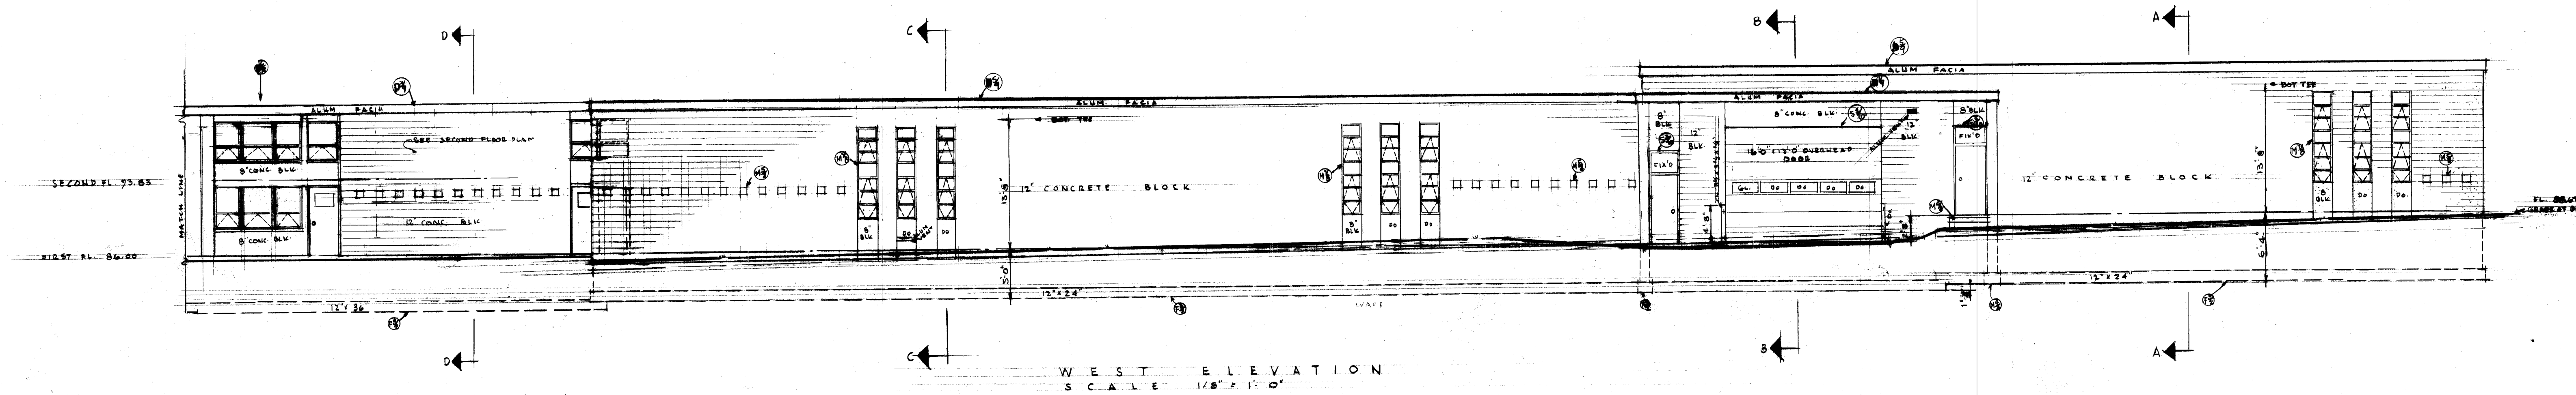


WEST ELEVATION
SCALE 1/8" = 1'-0"

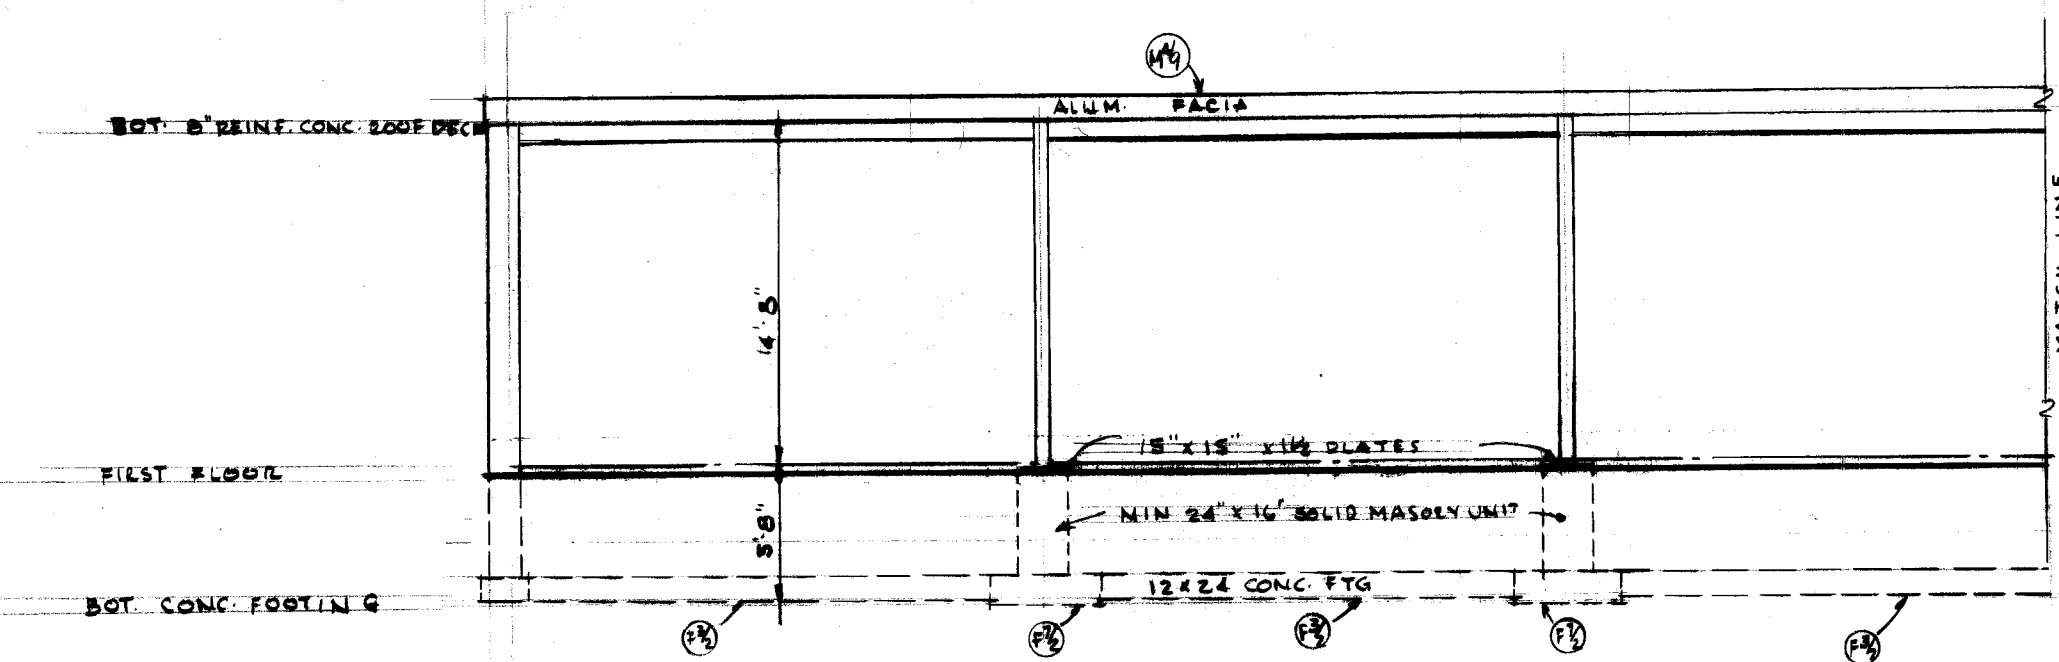


NORTH ELEVATION
SCALE 1/8" = 1'-0"

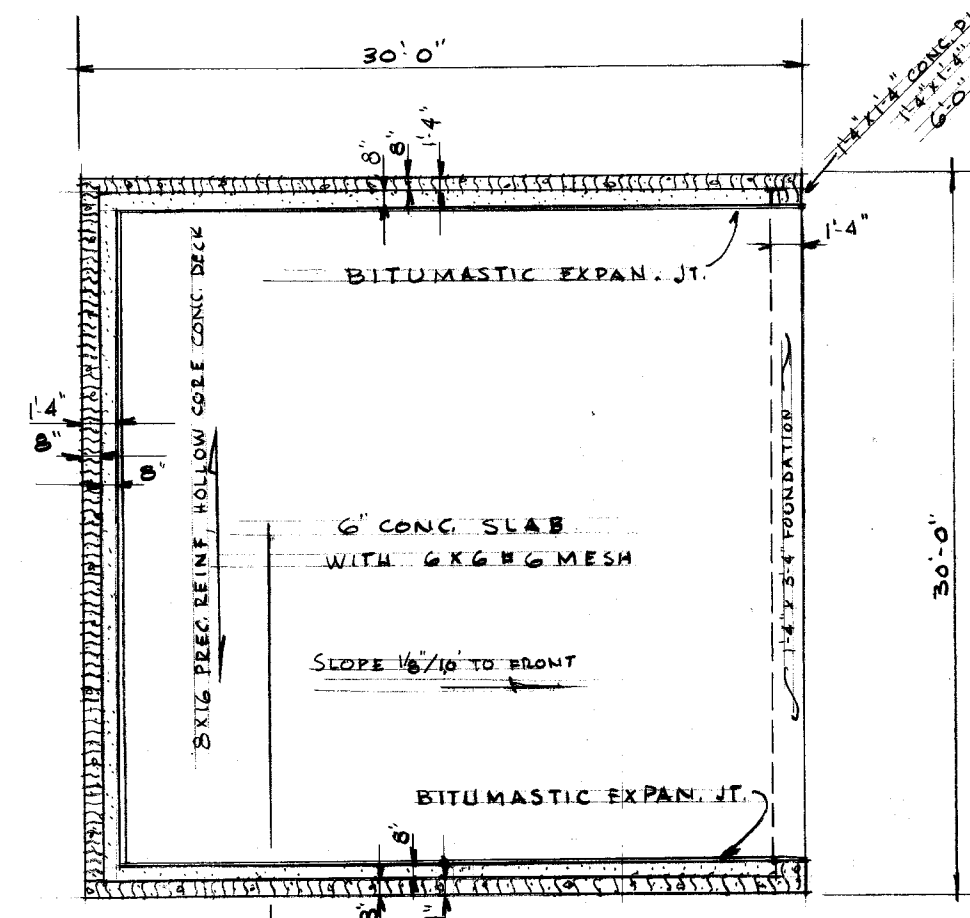


PLAN - SALT BIN
SCALE 1/8" = 1'-0"

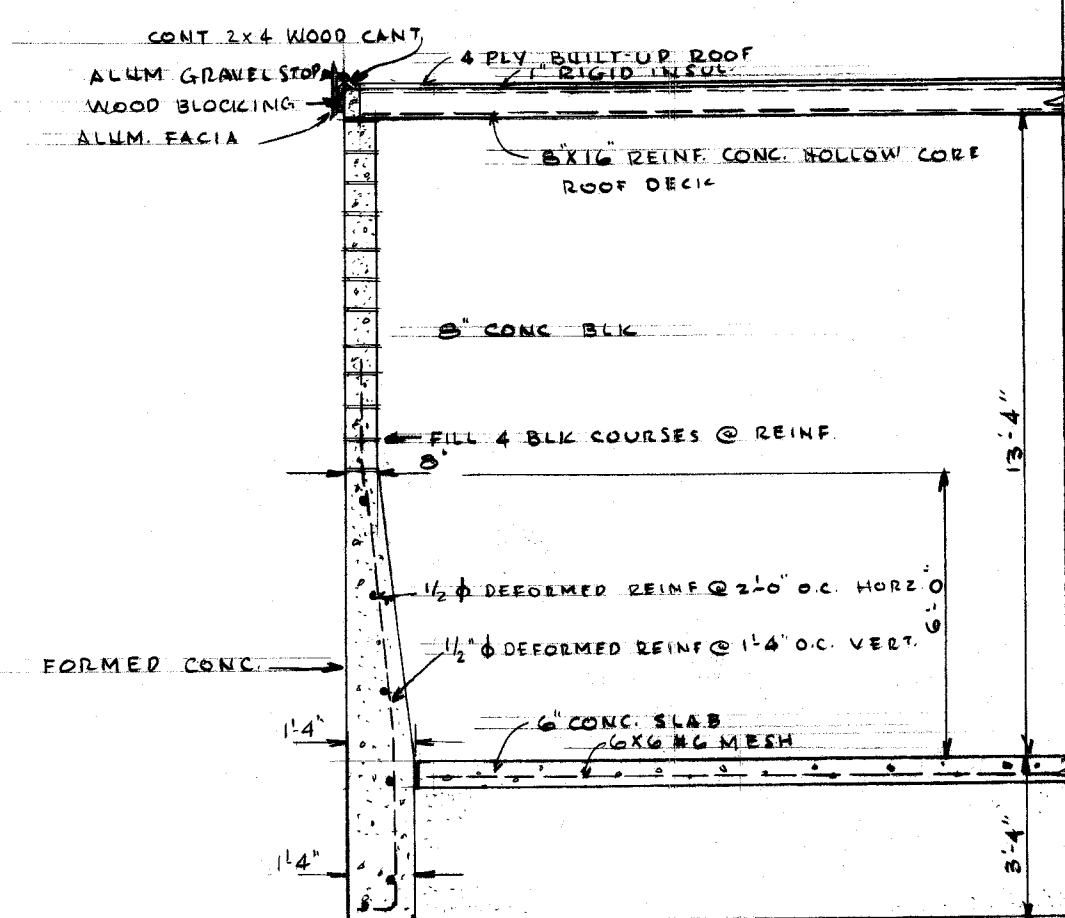


SECTION X - SALT BIN

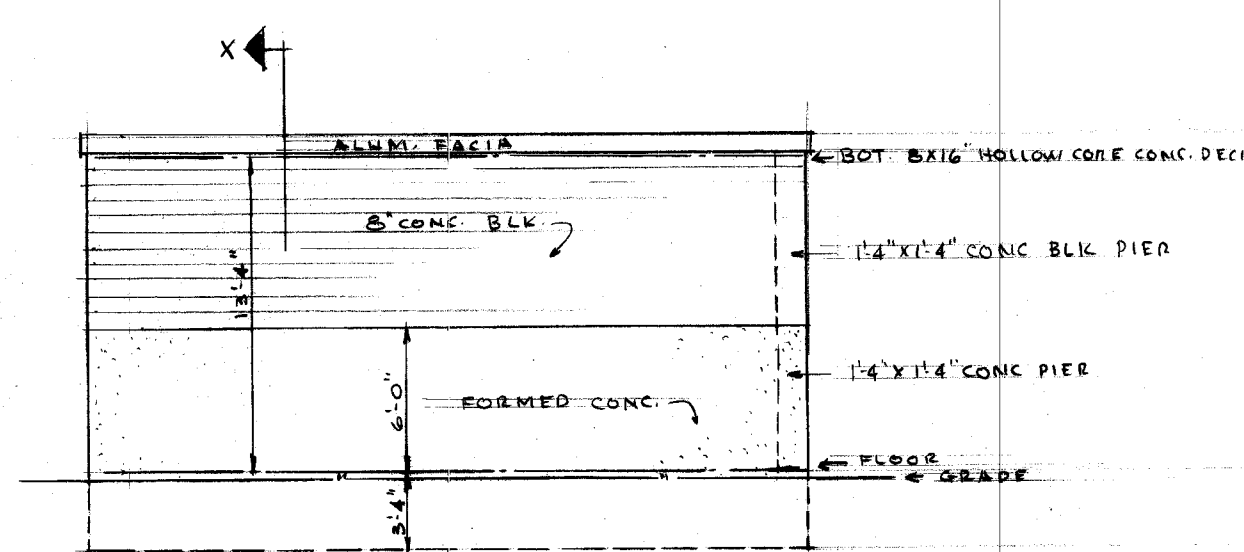


WEST ELEVATION - SALT BIN
SCALE 1/8" = 1'-0"

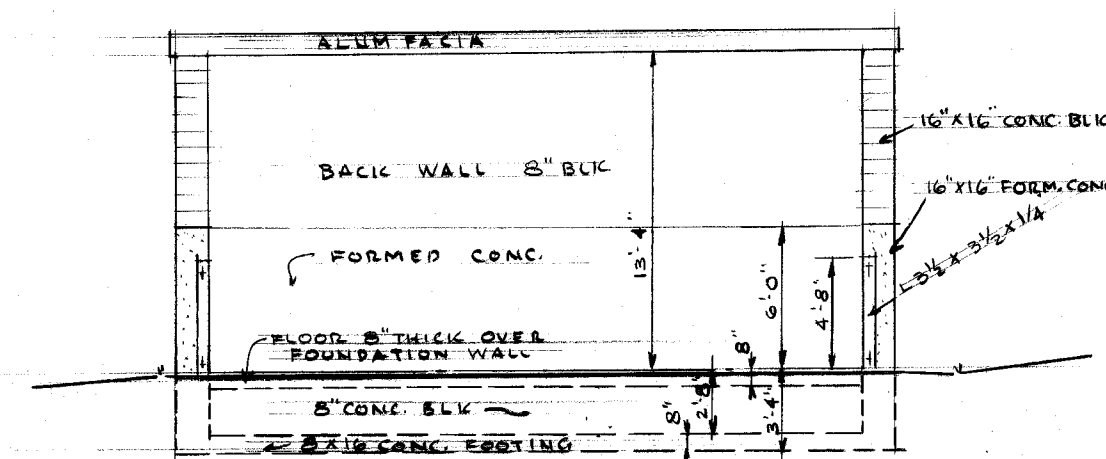


SOUTH ELEVATION - SALT BIN
SCALE 1/8" = 1'-0"


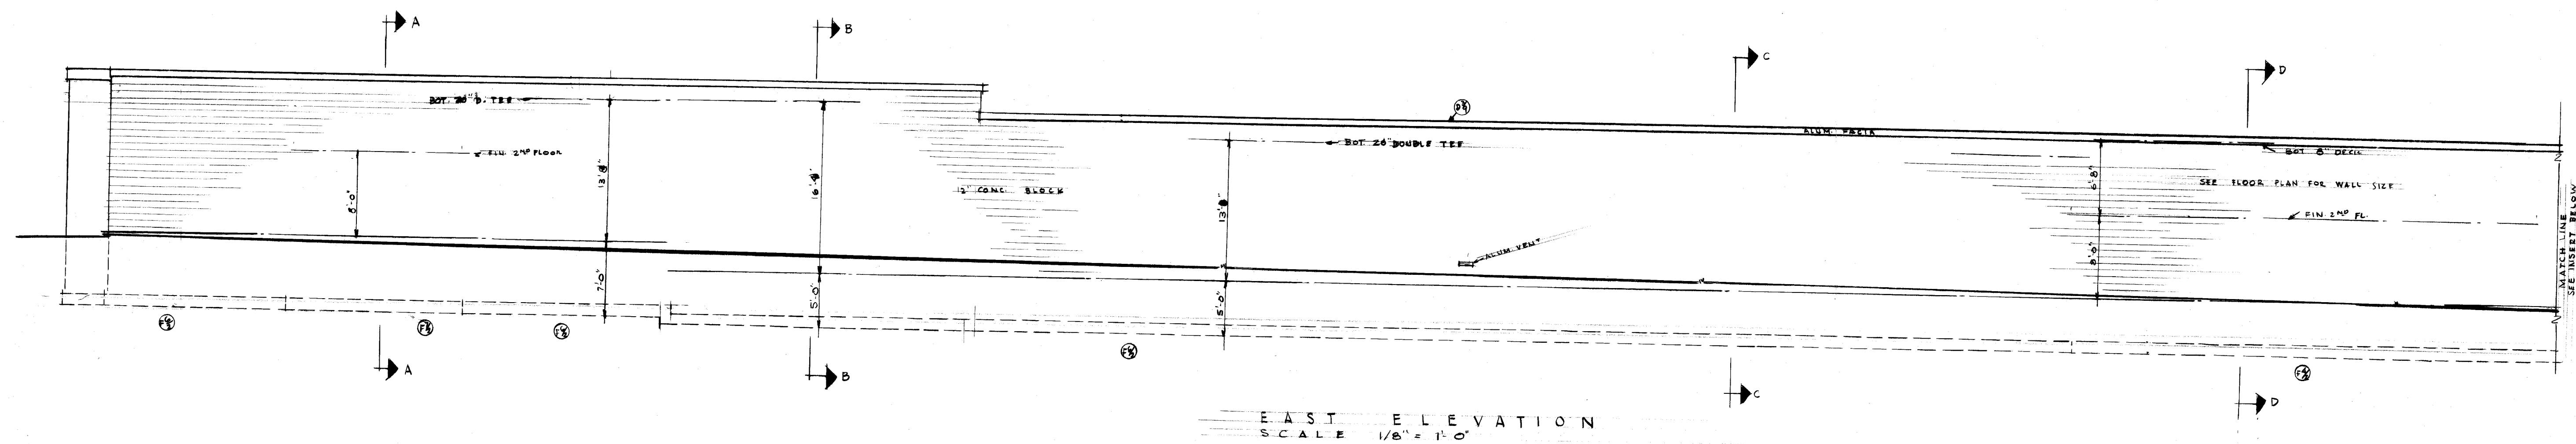



EAST ELEVATION
SCALE 1/8" = 1'-0"

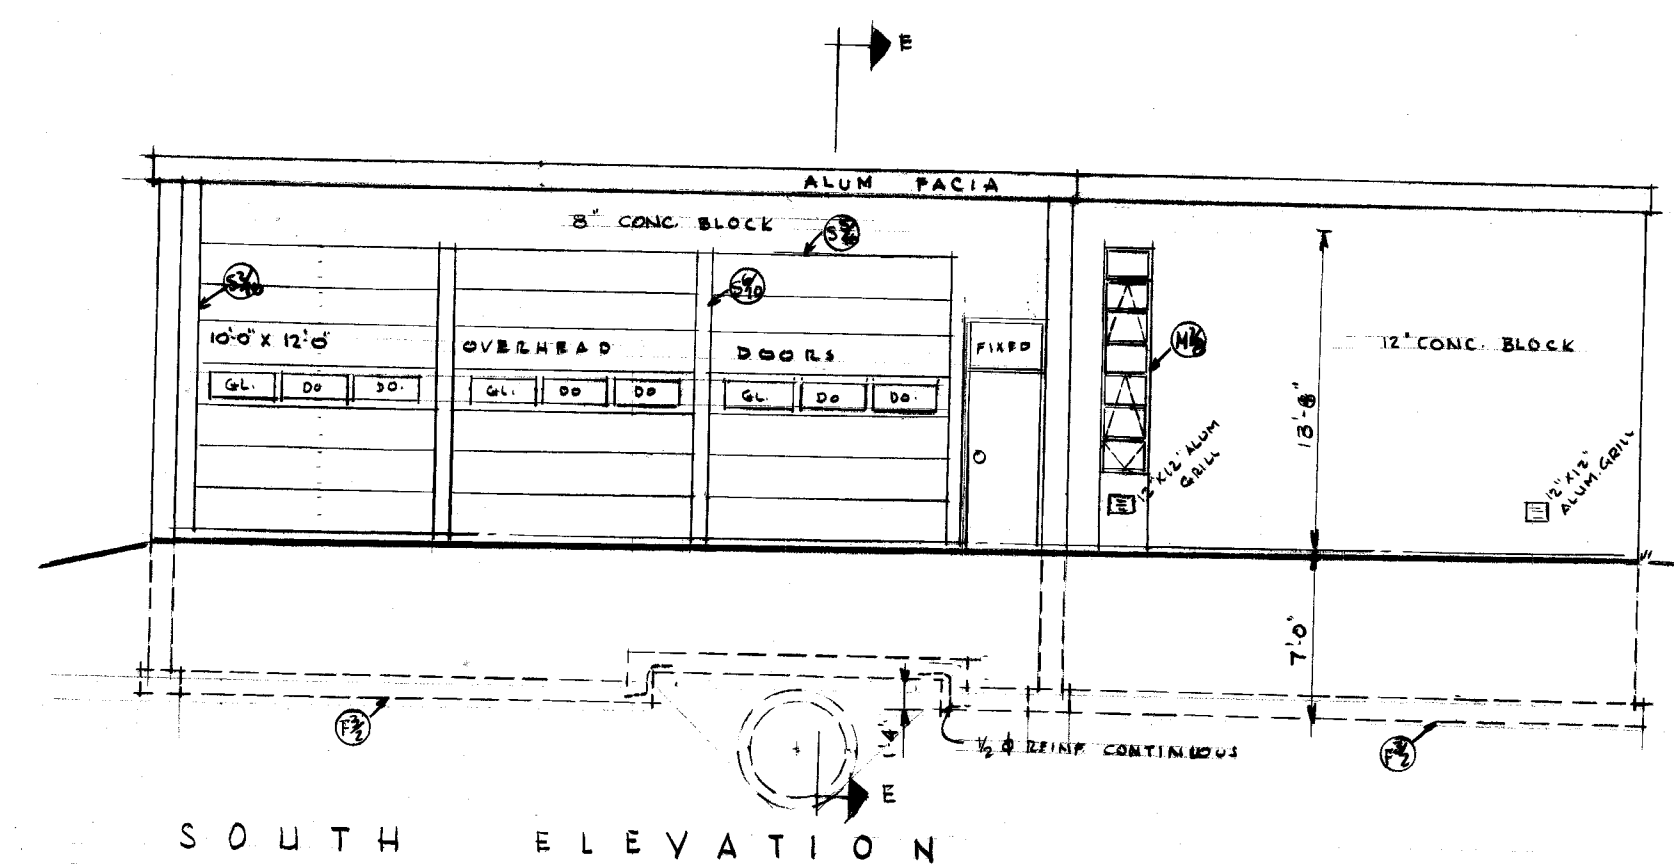


SOUTH ELEVATION

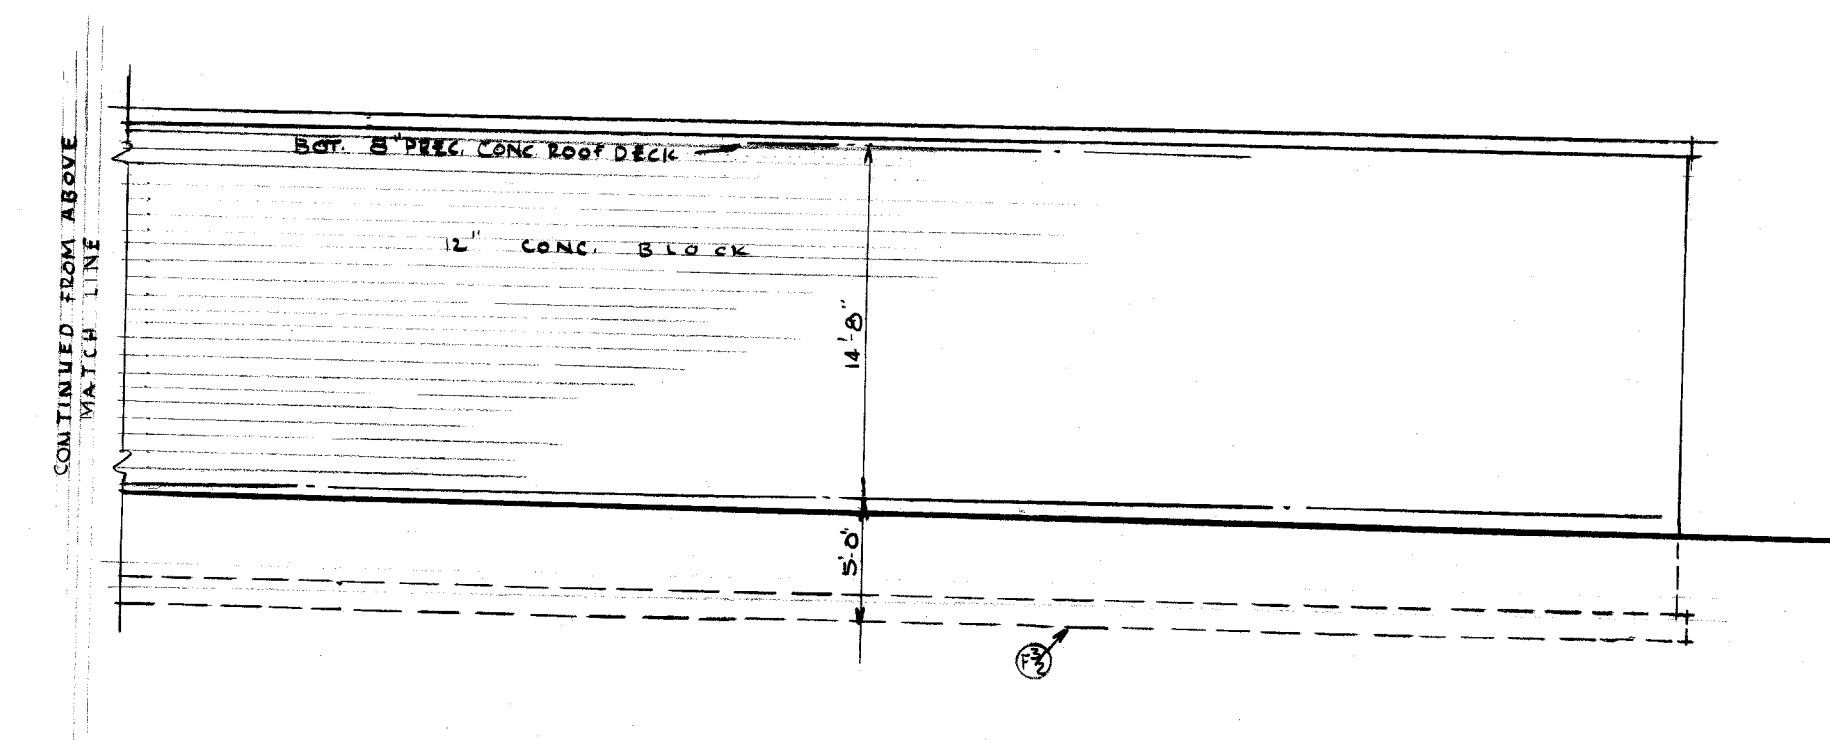

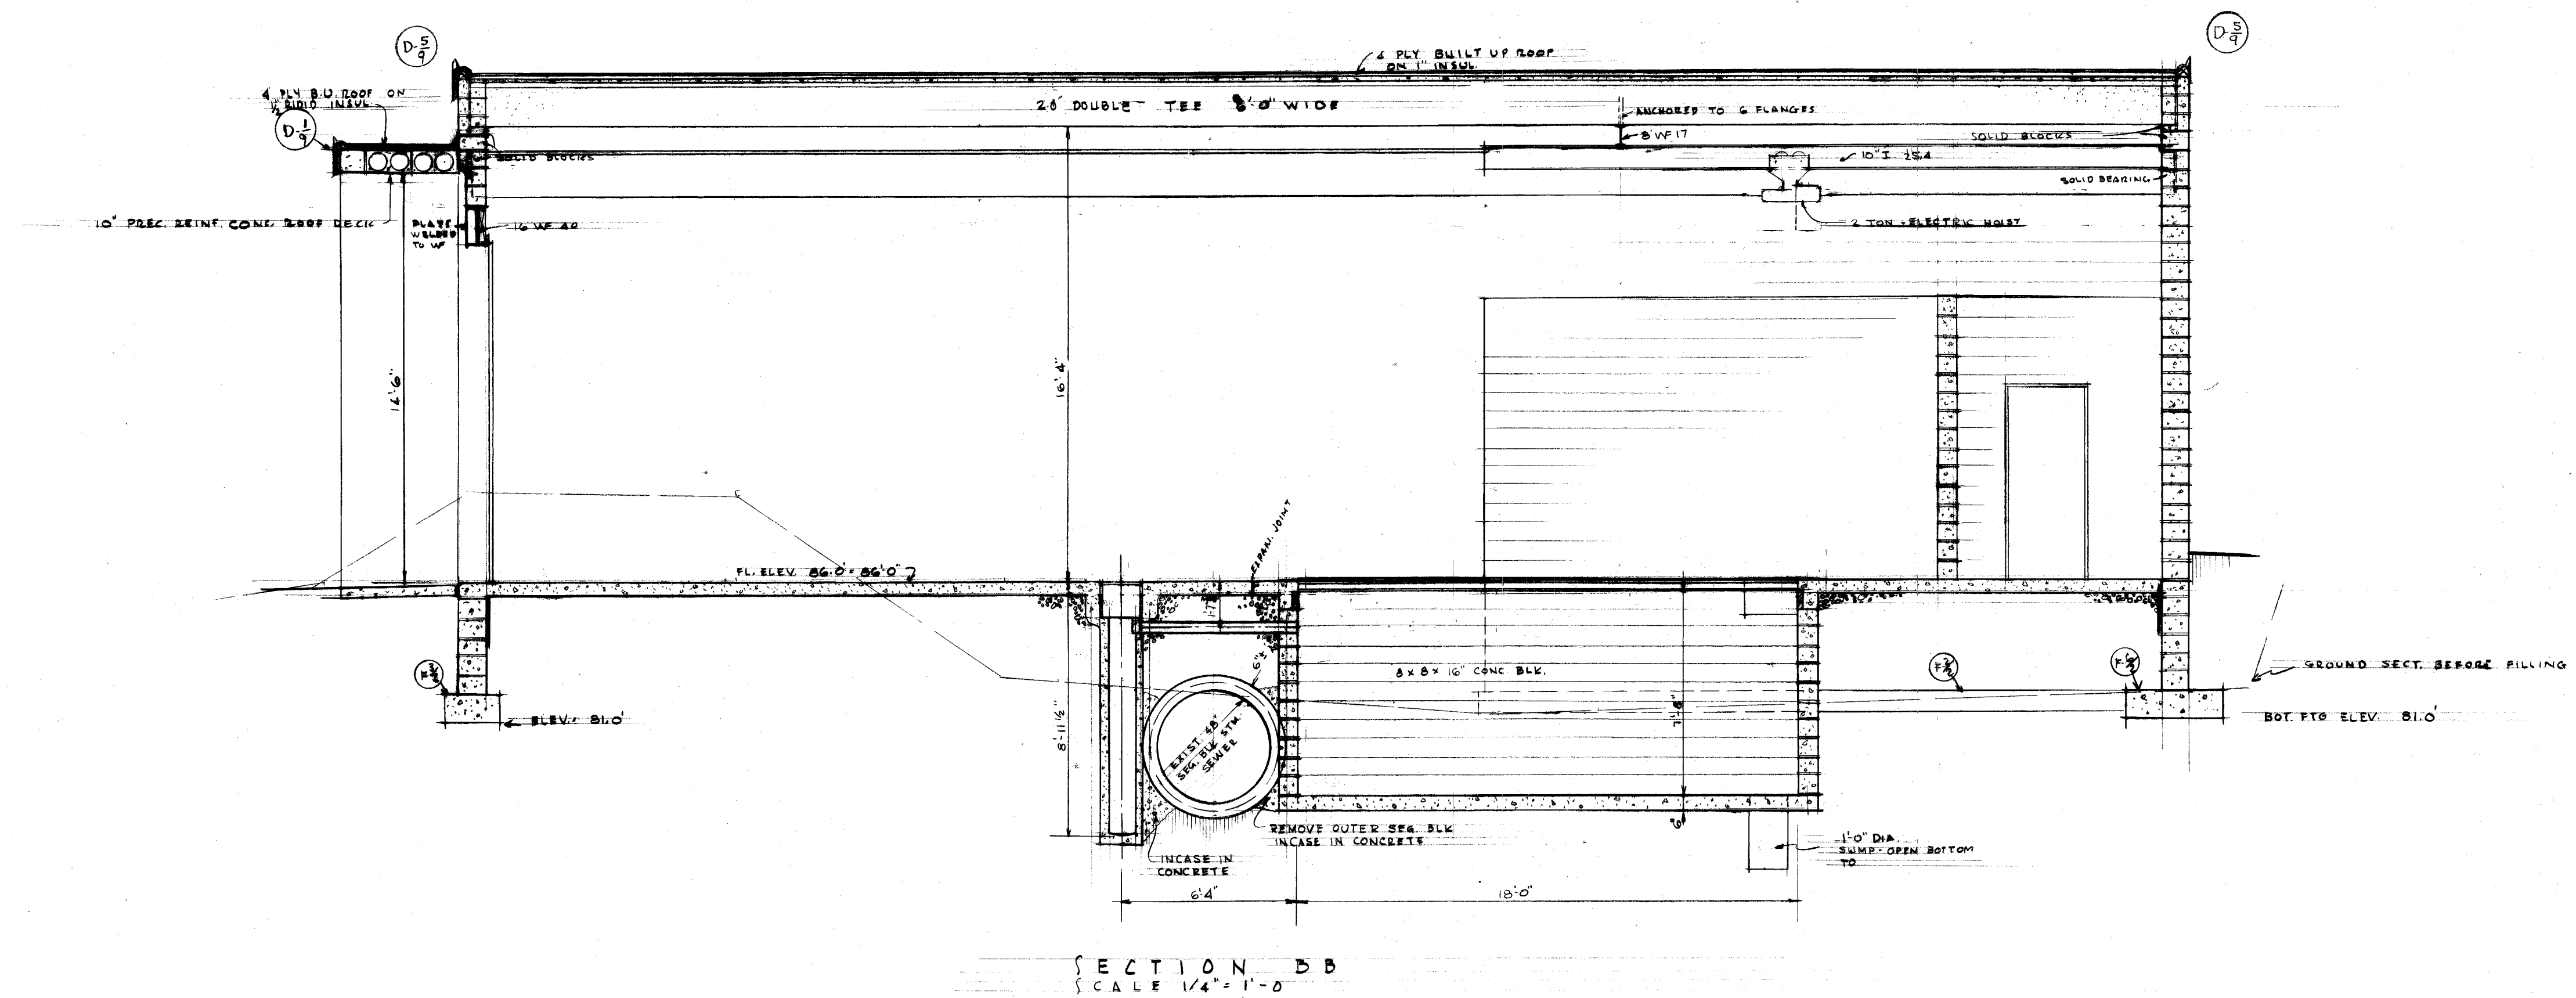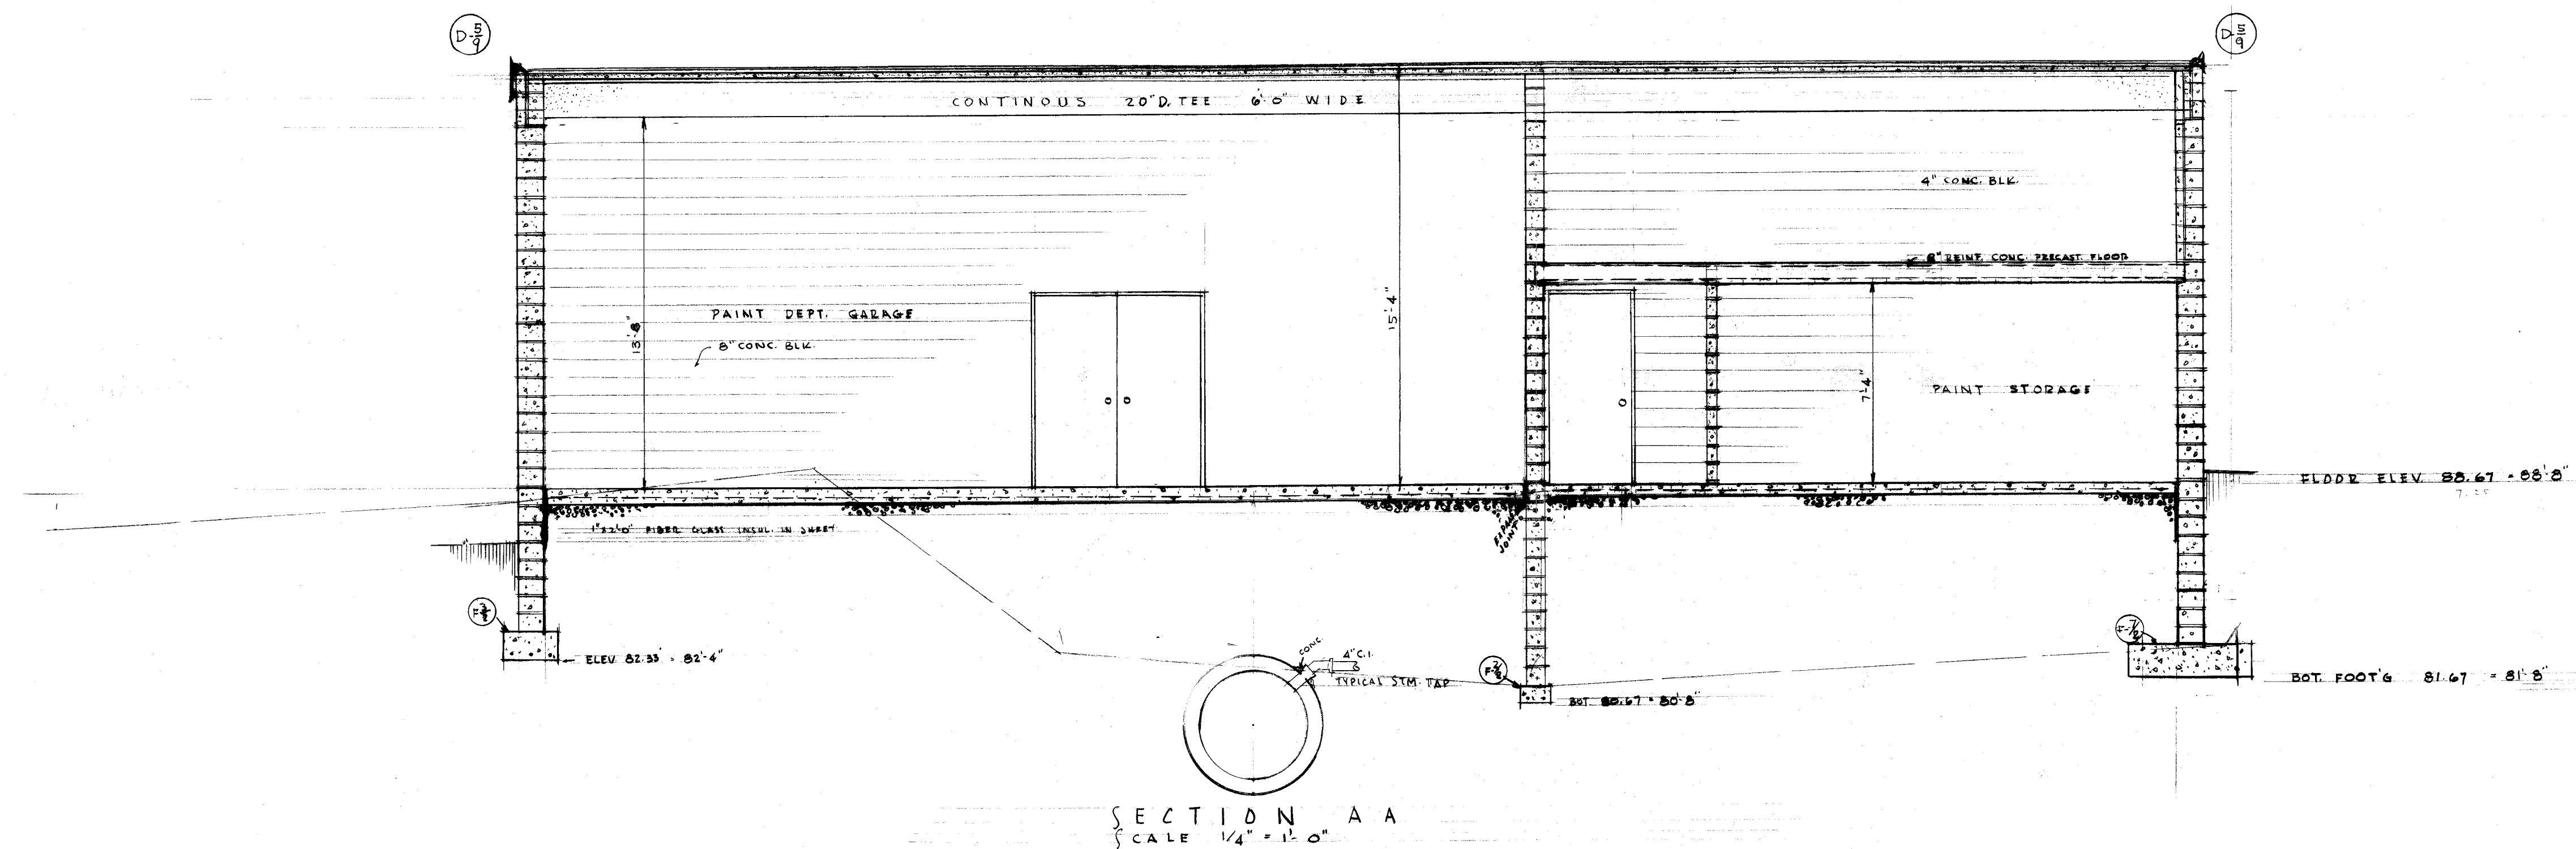


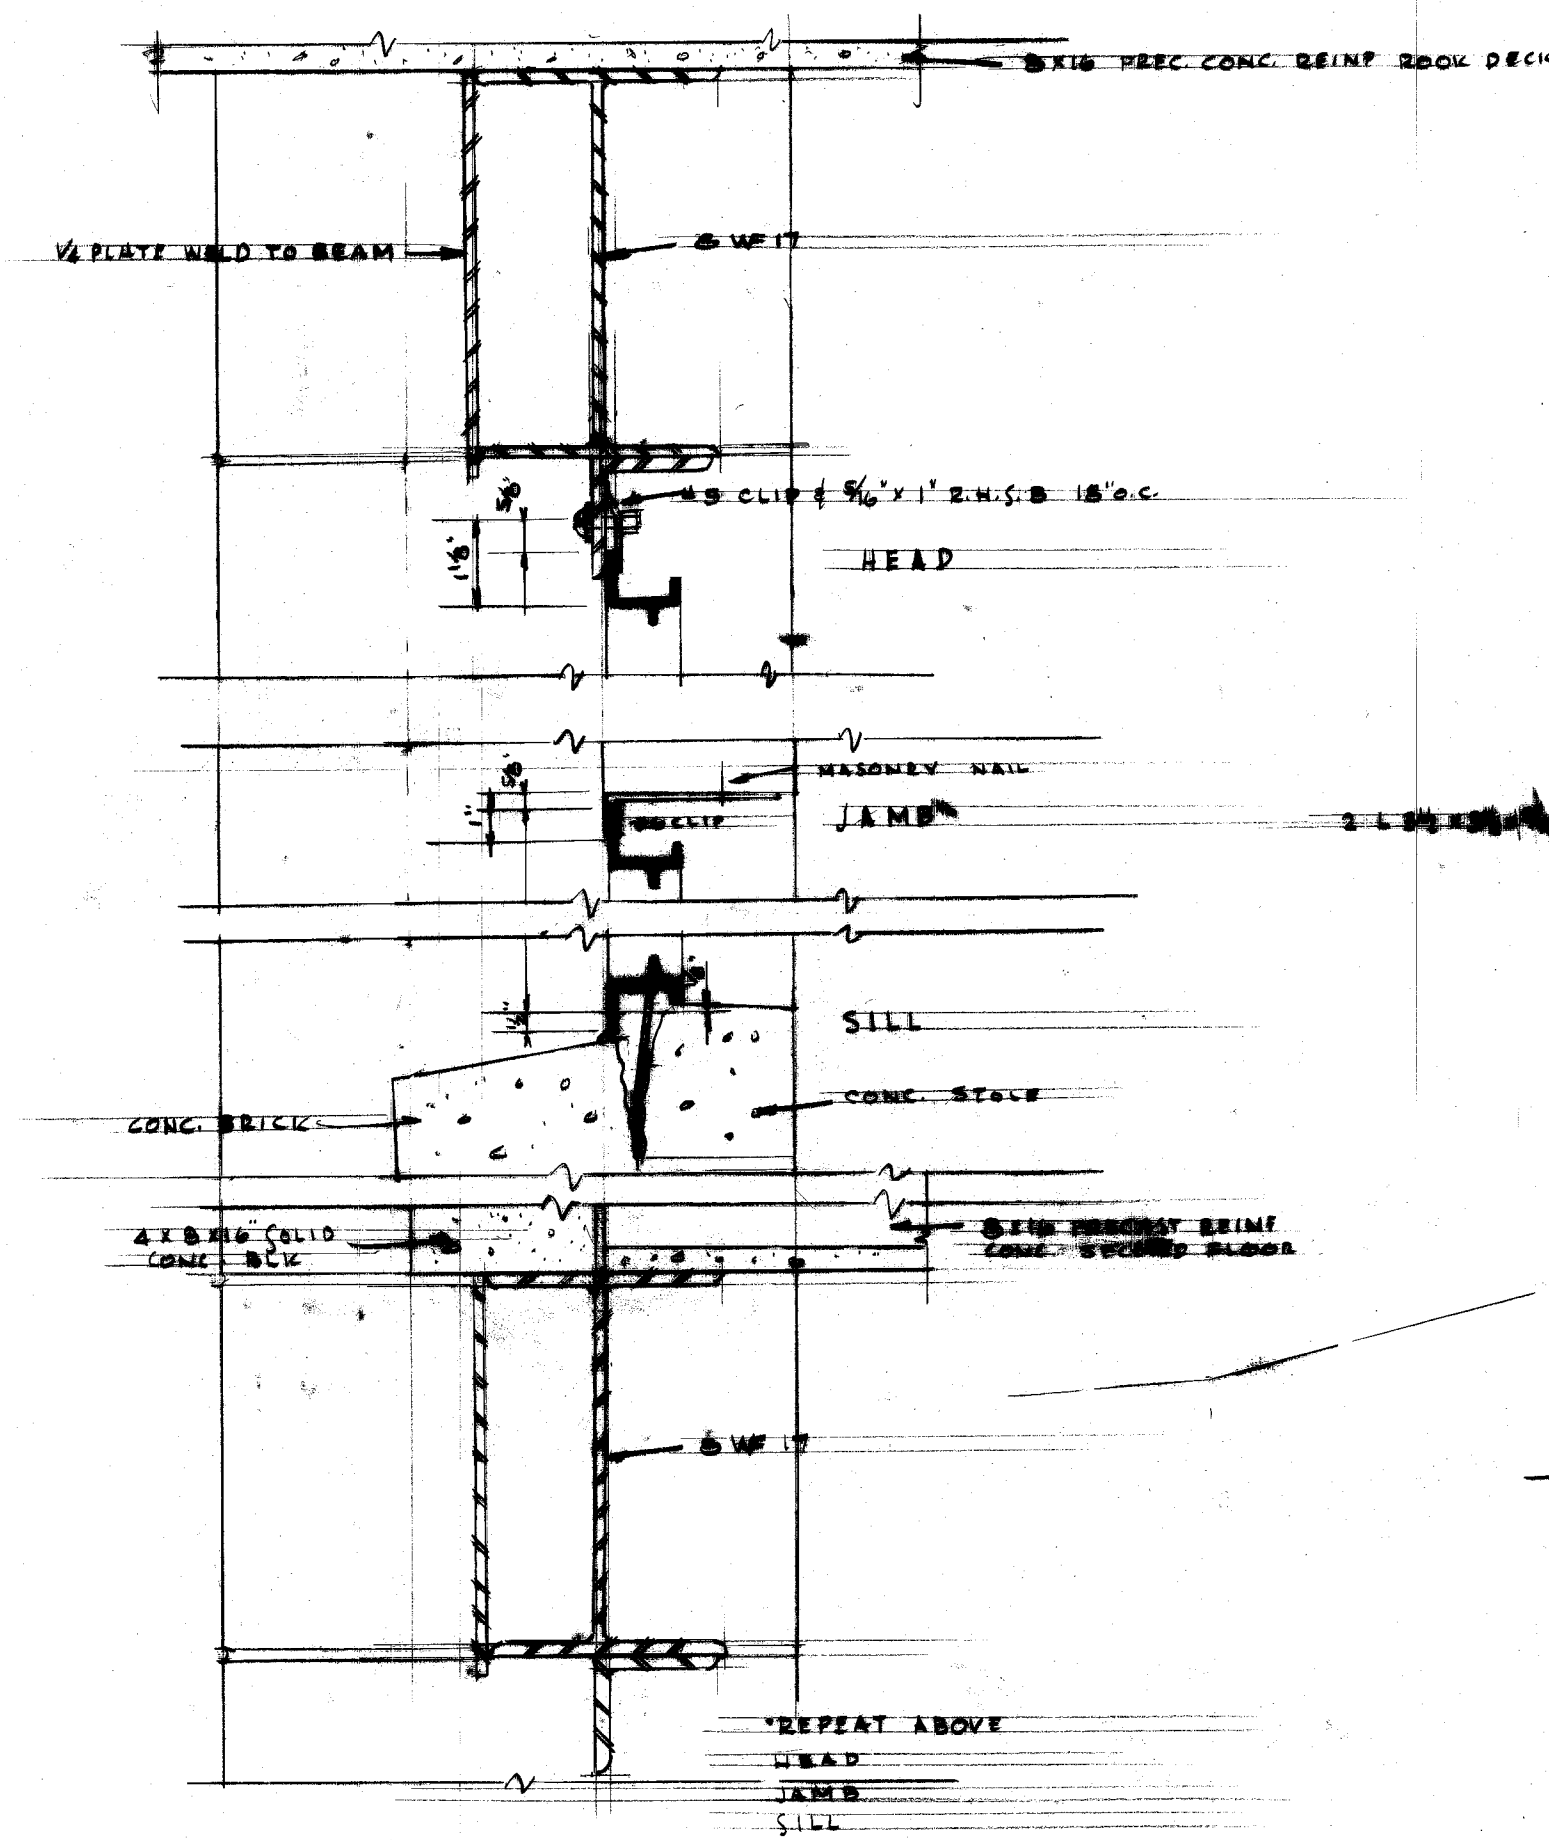


WINDOW DETAIL @ OFFICE & HALL
SCALE 3/4" = 1'-0"

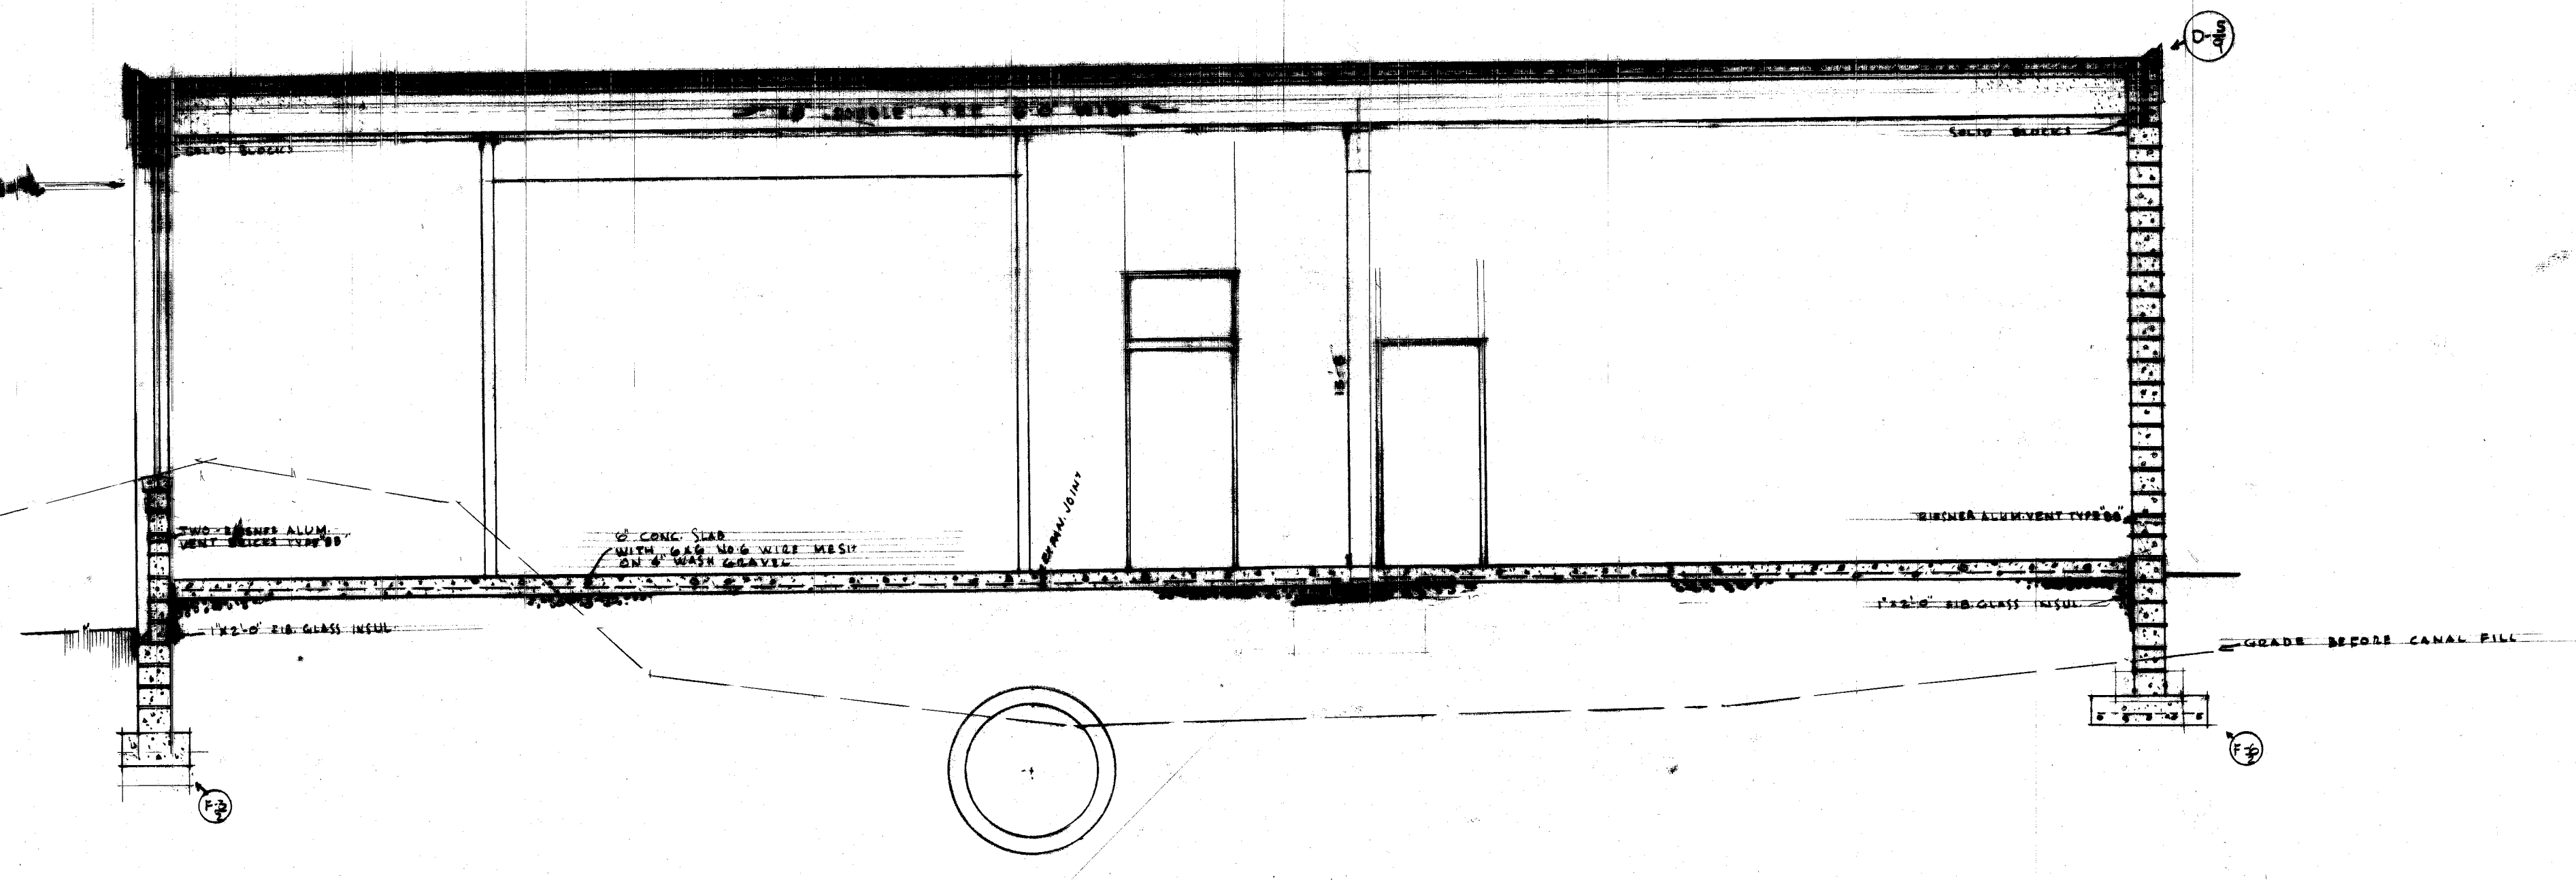


SECTION C-C
SCALE 1/4" = 1'-0"

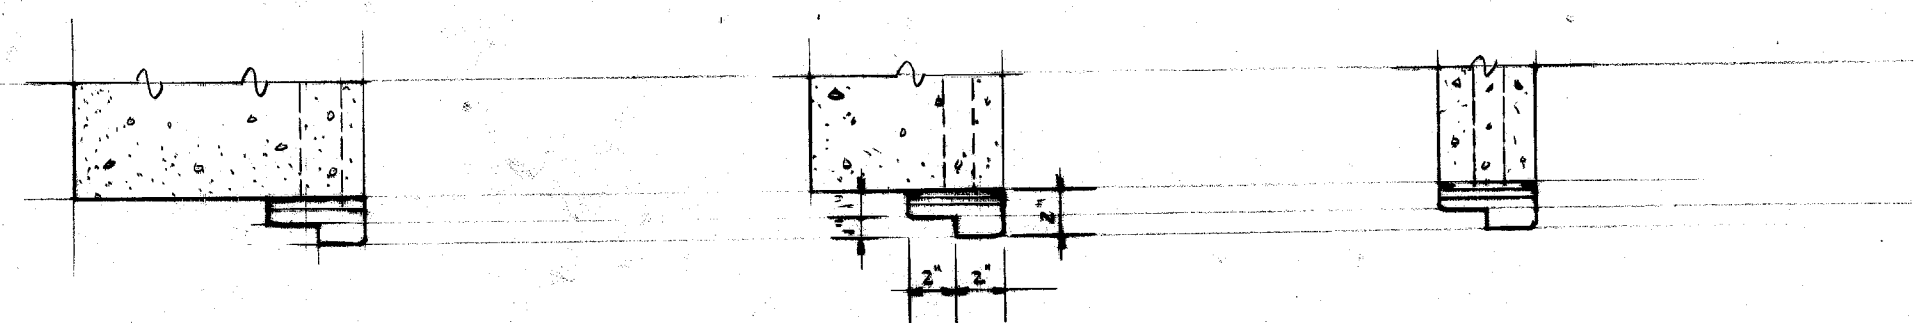








DOOR FRAME TYPICAL METAL
SCALE 1/4" = 1'-0"


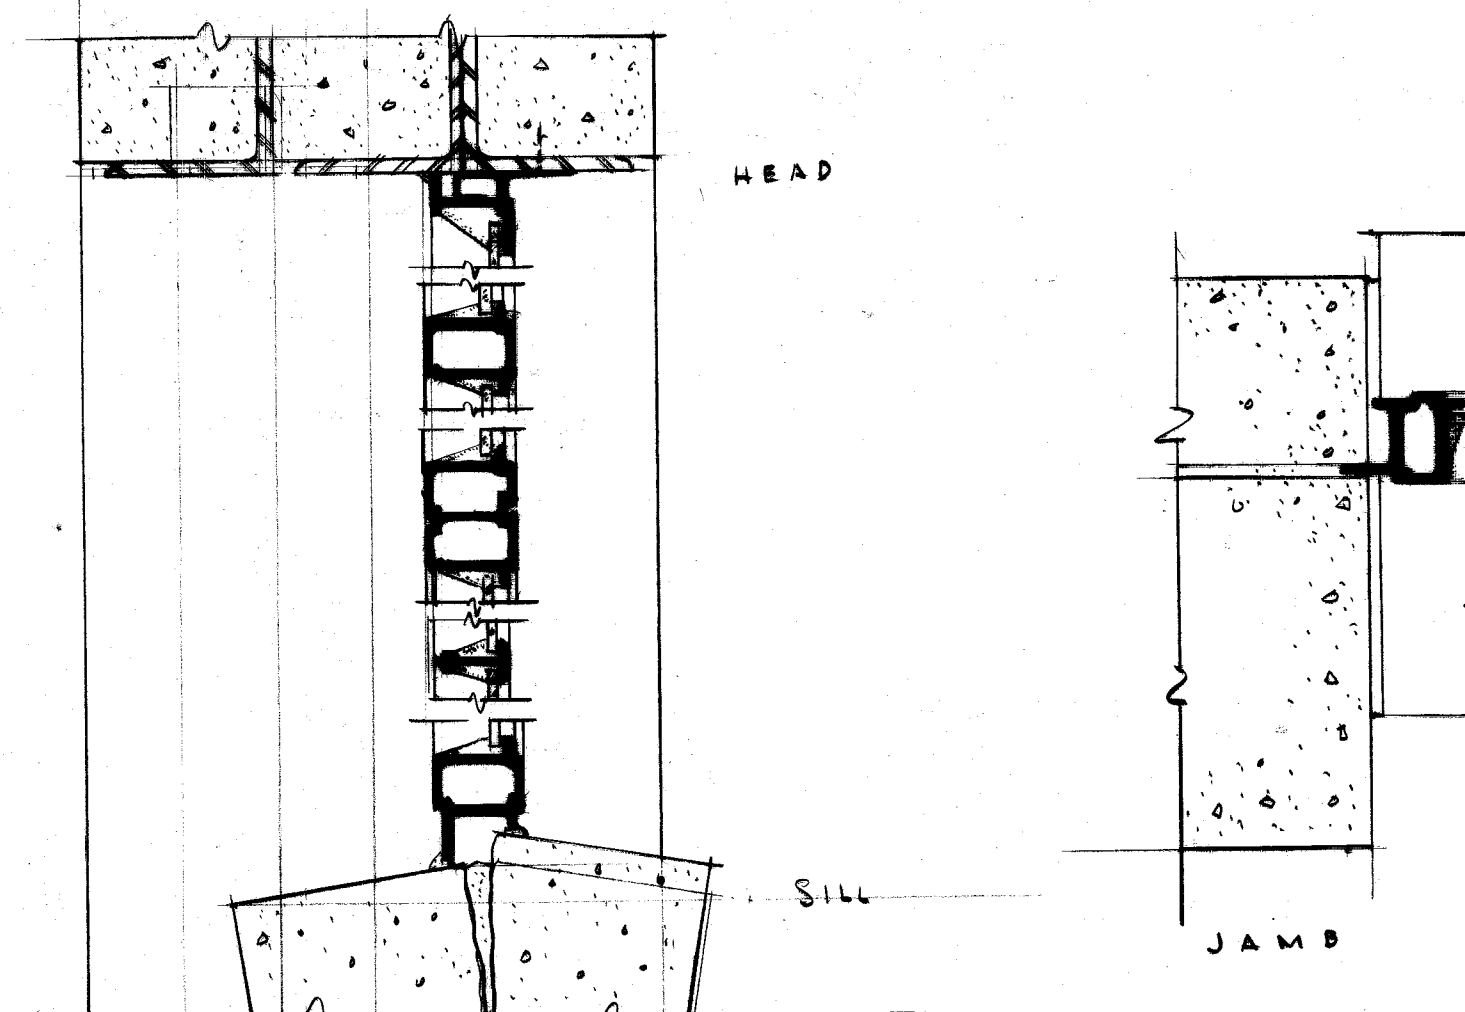


WINDOW DETAIL IN GARAGE & PAINT DEPT.
SCALE 3/4" = 1'-0"

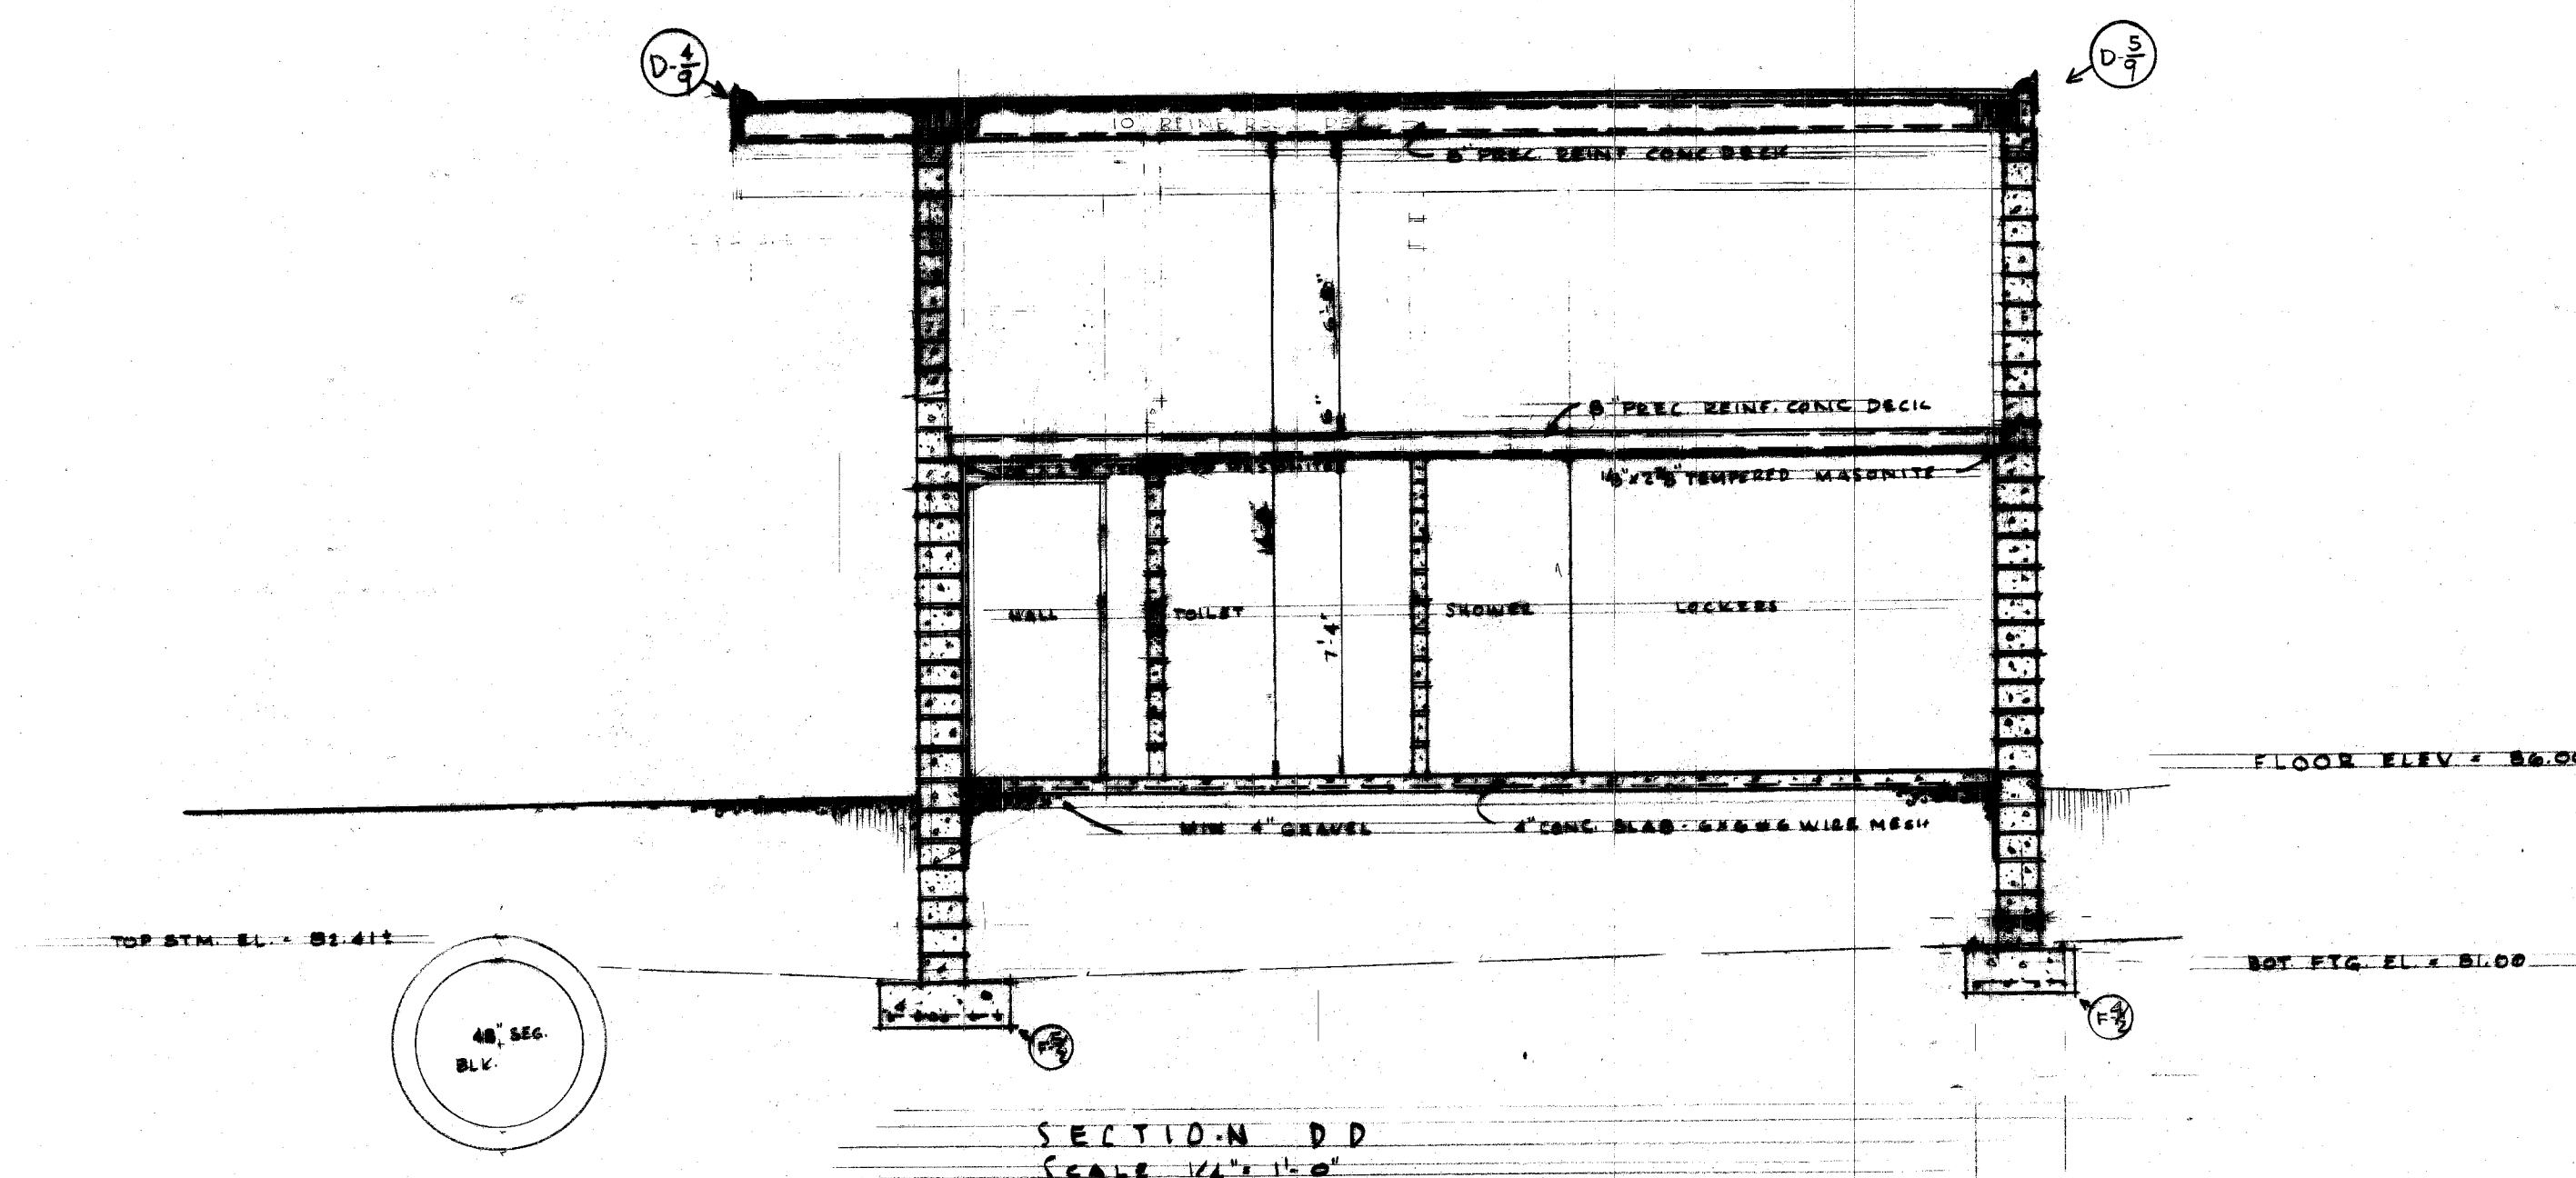

SECTION D-D
SCALE 1/4" = 1'-0"

 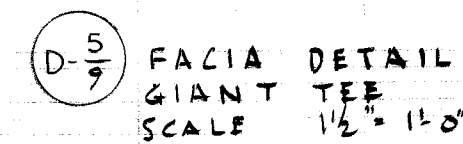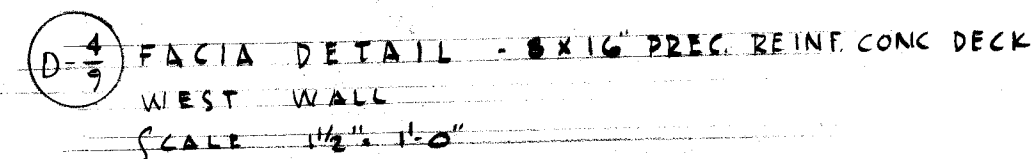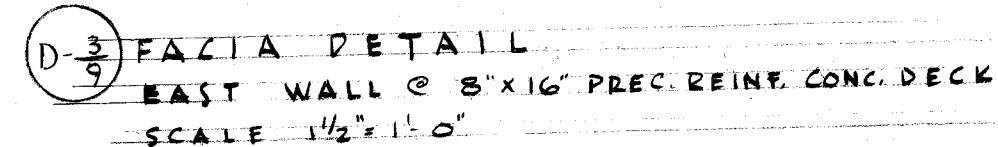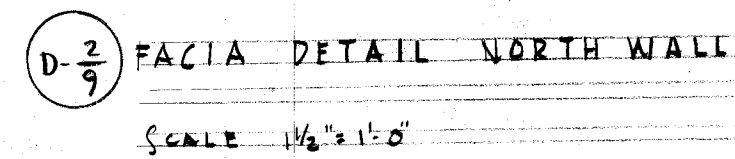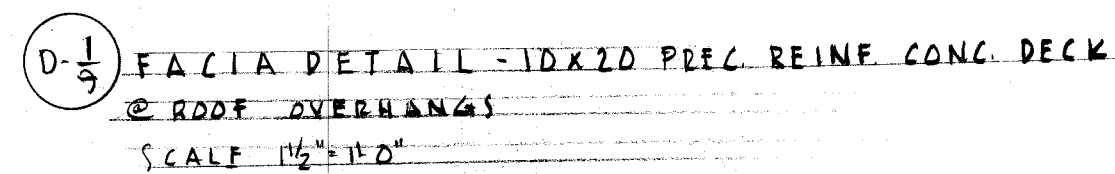 


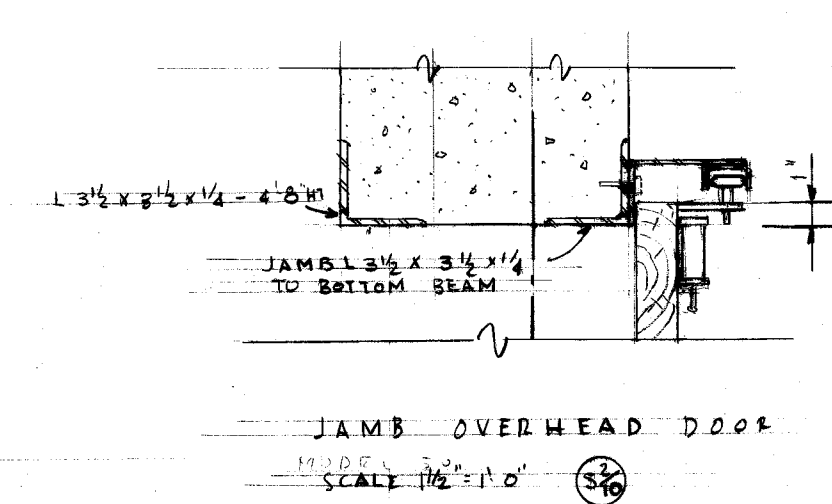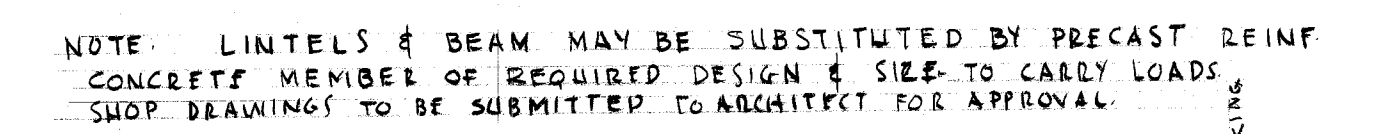


A hand-drawn cross-section diagram of a building facade. On the left, there is a window with a curved top and a small square detail. To the right of the window is a vertical section of the wall. Further right is a door, which is labeled '2 L' and '2 R' on its right side. The diagram shows various structural details, including a horizontal line across the middle and a vertical line on the right side. There are also some small circles and dots scattered throughout the drawing, possibly representing fasteners or material details.

Hand-drawn architectural details of a door frame and its connection to a wall. The left detail shows a side view of a door frame with a 1/4 inch plate welded to the wall and a 2x8x11.5 inch post welded to the plate. The right detail shows a top-down view of the door frame with a 1/4 inch plate welded to the wall and a 2x8x11.5 inch post welded to the plate. The drawings are labeled with dimensions and material specifications.


COLUMN SOUTH OVERHEAD
SCALE 1 1/2" = 1'-0" (34%)

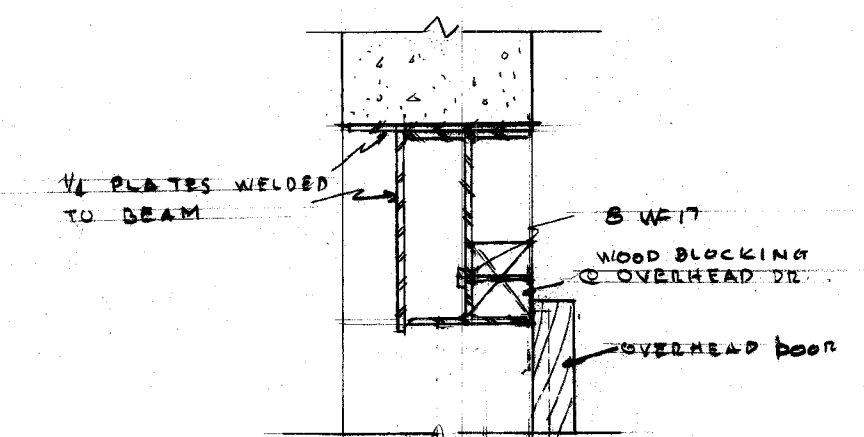


OVHD DOOR HEAD $\frac{5}{16}$ "
SCALE $1\frac{1}{2}" = 1'-0"$

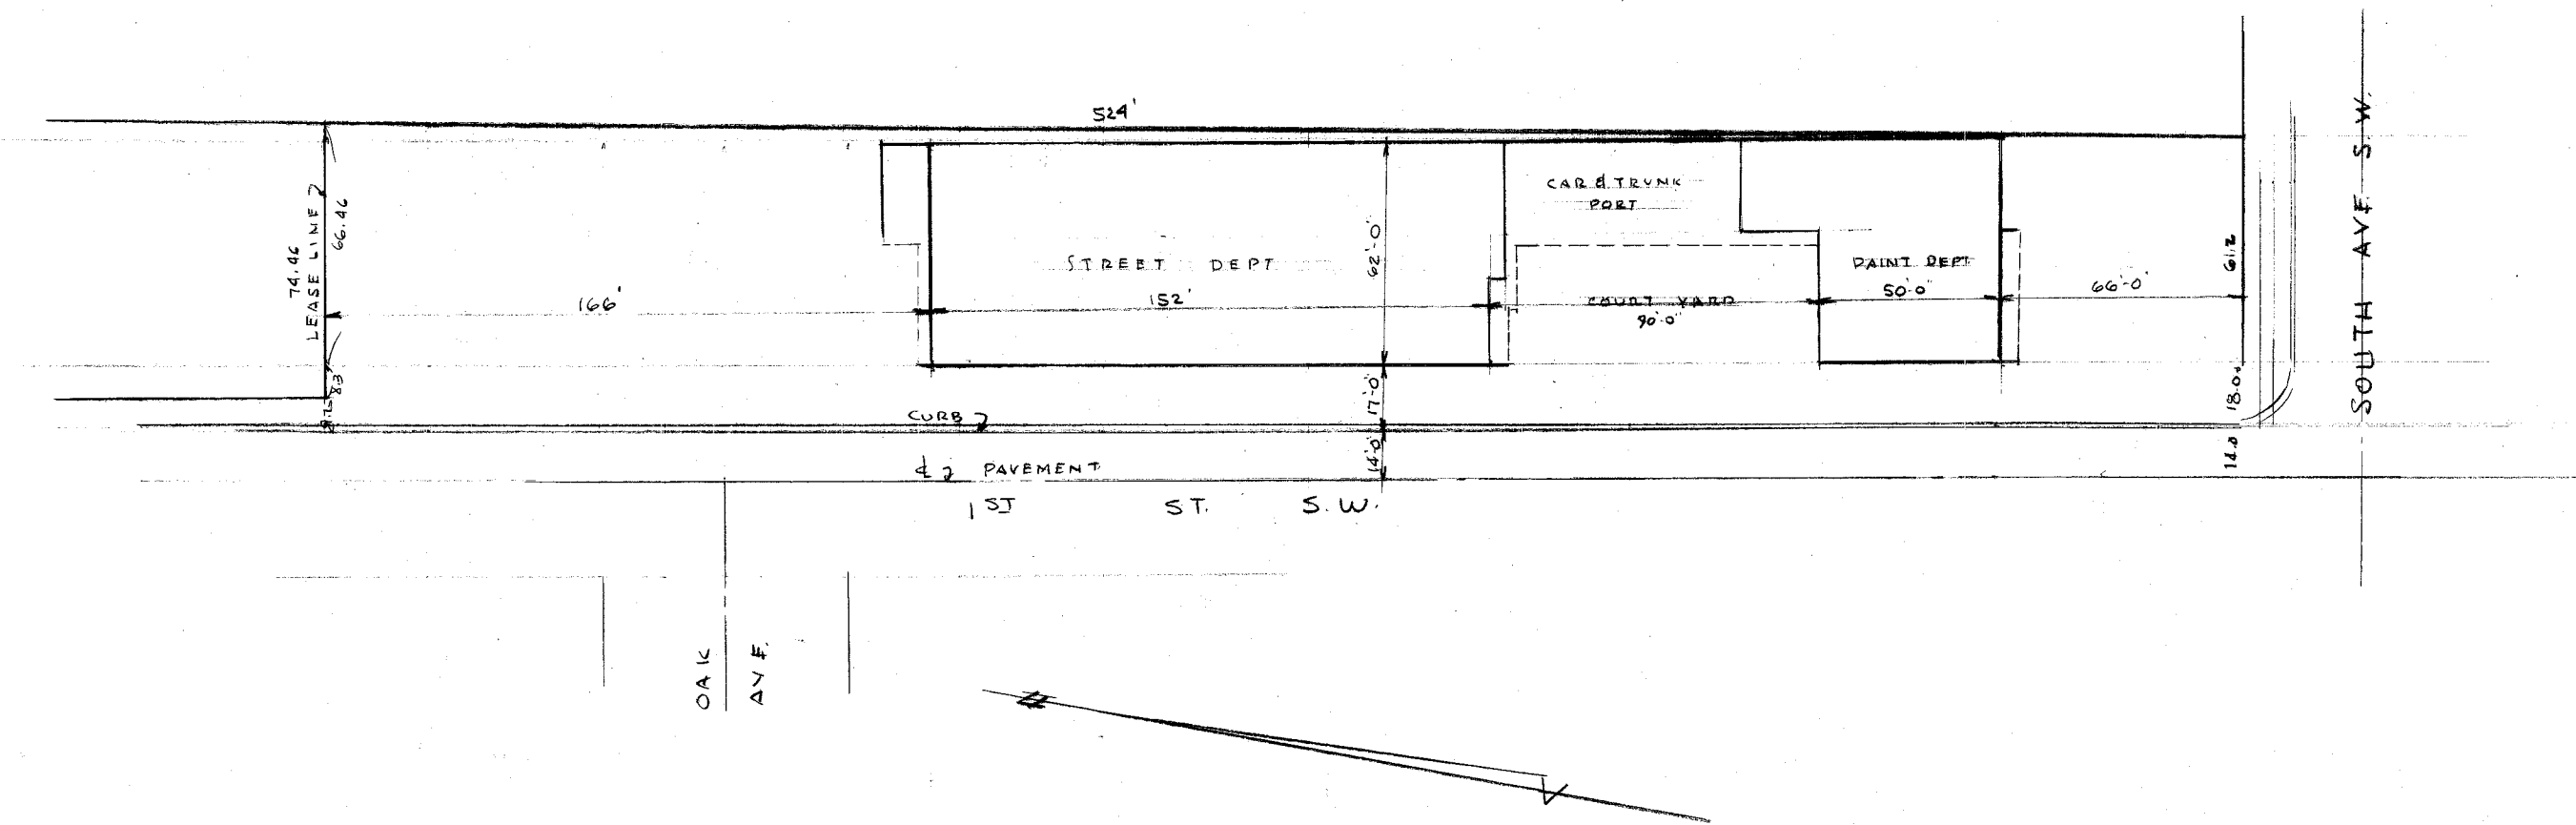


PLOT PLAN
1" = 20'

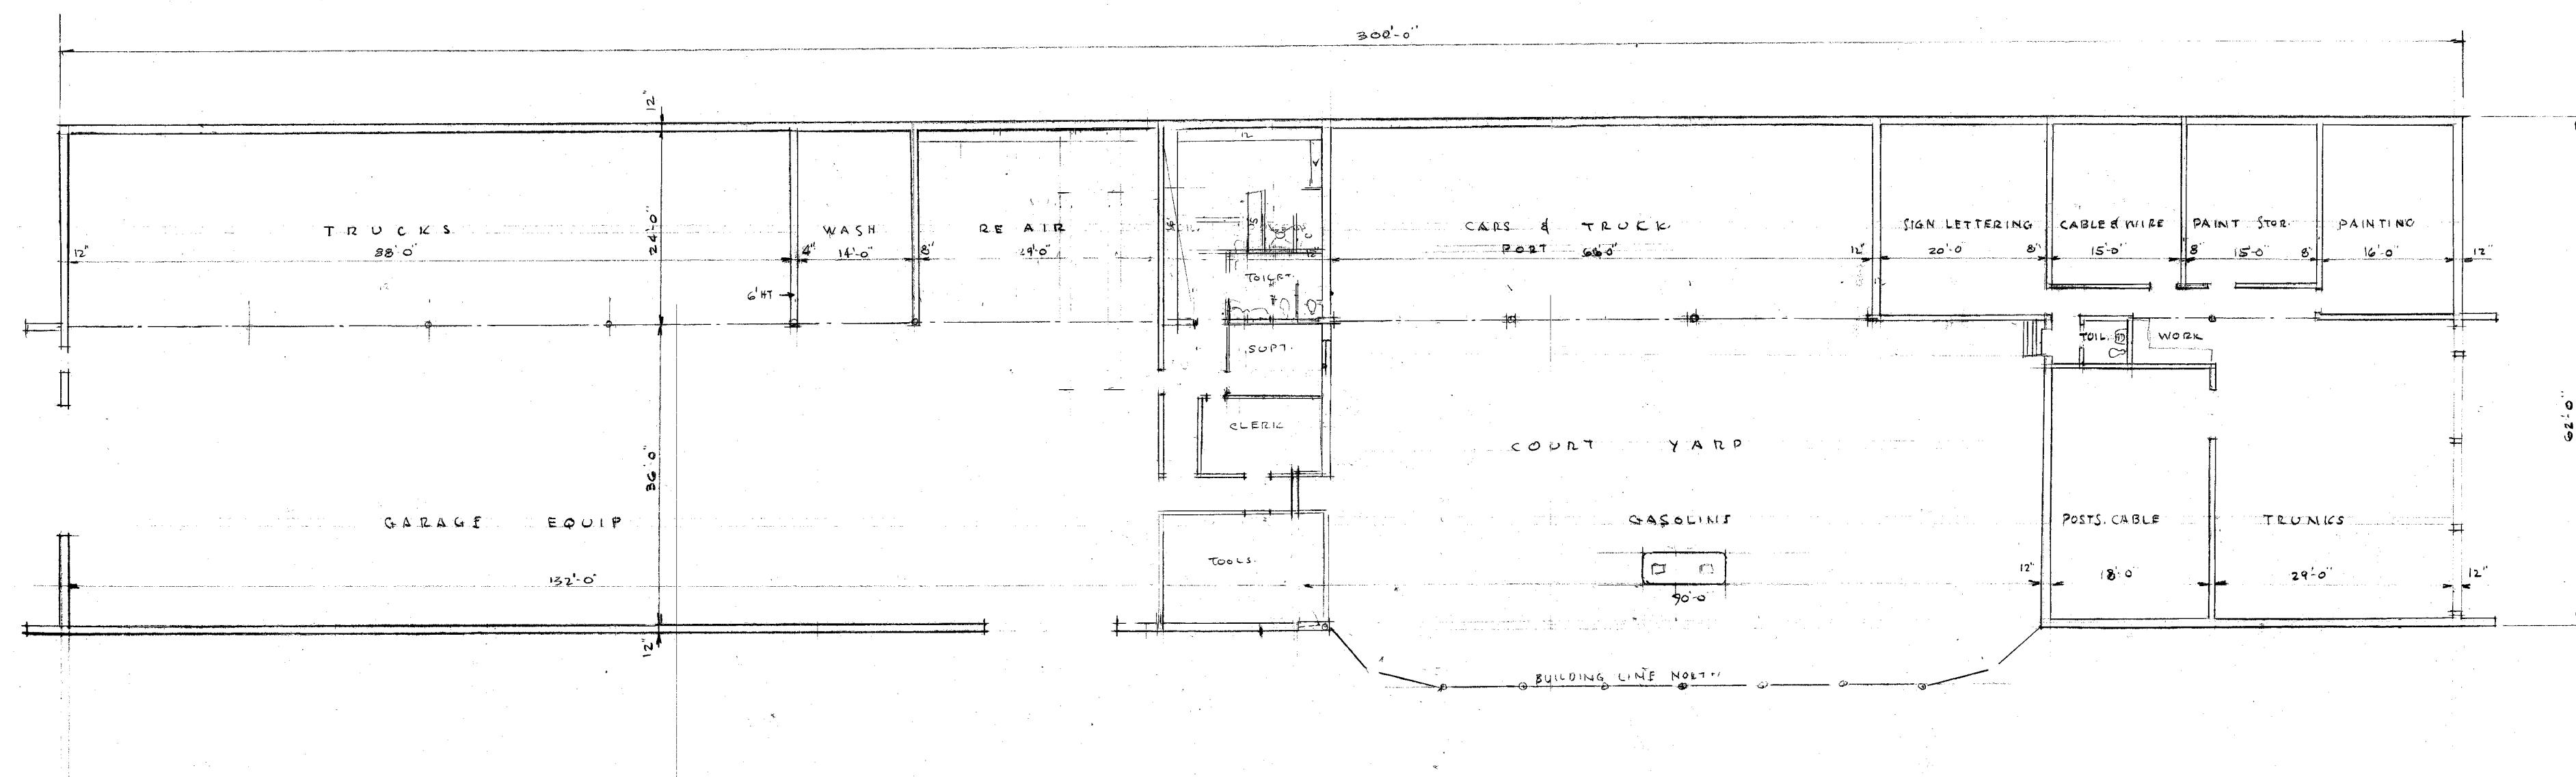


FLOOR PLAN
1/16" = 1' - 0"

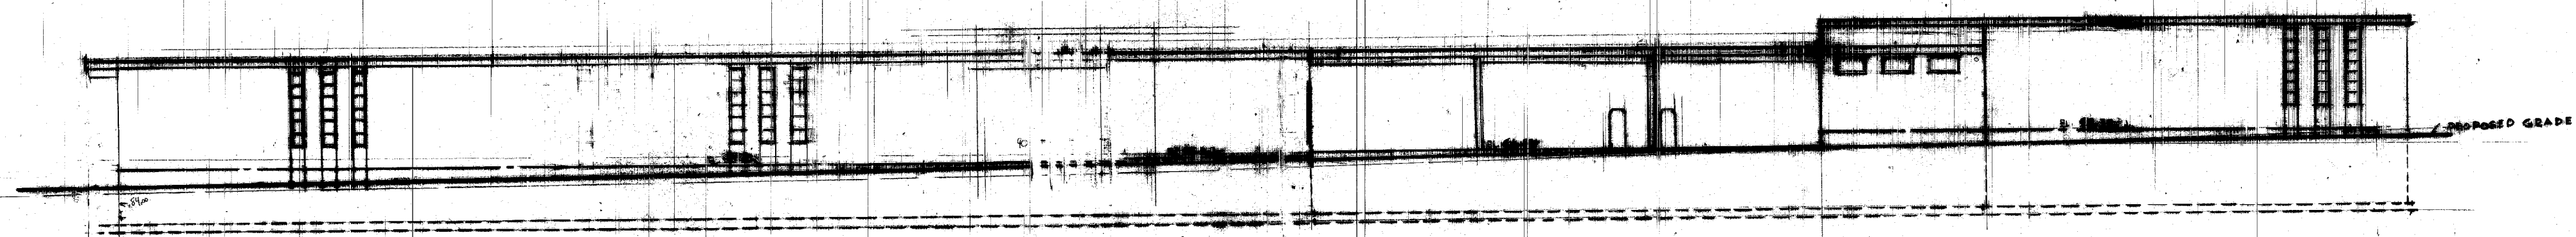


WEST ELEVATION

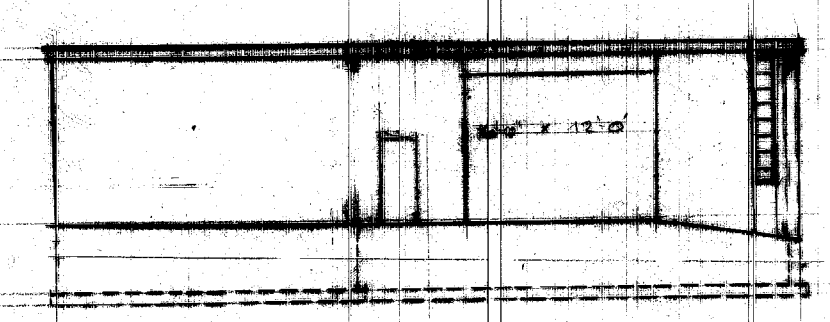

NORTH ELEVATION

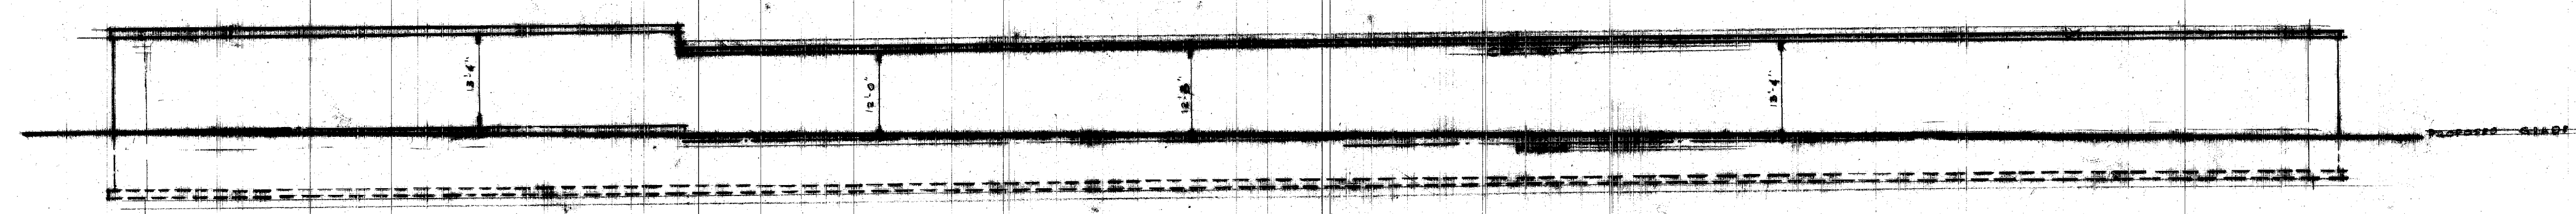

EAST ELEVATION

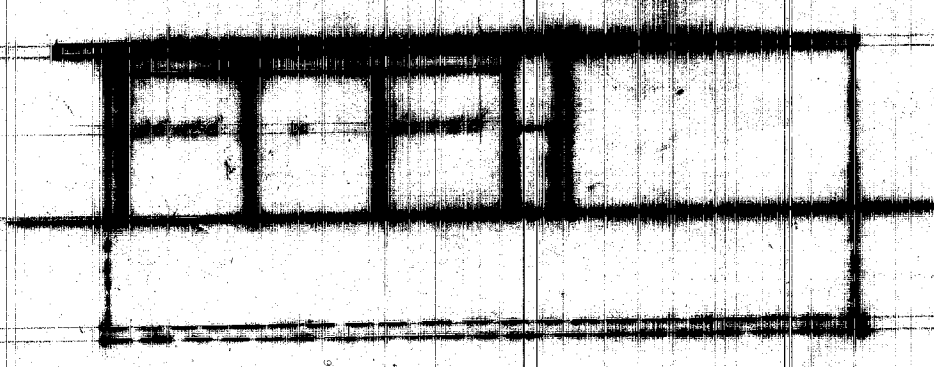

SOUTH ELEVATION