

GENERAL NOTES:

PLOT PLAN & CONTROL MAP (24"x36" SHEETS, 1"=50') FROM PREVIOUS CONTRACT ARE INCLUDED FOR LOCATIONS & DIMENSIONS OF EXISTING IMPROVEMENTS.

PLOT PLAN & FLOOR PLAN OF CONCESSION-REST ROOM BUILDING, THAT IS TO BE CONSTRUCTED IN MAY, 1984, ARE INCLUDED TO SHOWN LOCATION OF PANEL BOARDS & TRANSFORMER. THIS WORK SHALL BE COORDINATED WITH THE BUILDING CONSTRUCTION.

CAUTION SHALL BE TAKEN AS TO LOCATIONS OF LIGHT POLES, UNDERGROUND WIRING & TRANSFORMER AS TO CONFLICTS WITH EXISTING IMPROVEMENTS.


IF ADDITIONAL LOCATIONS OR MEASUREMENTS ARE REQUIRED, THE CITY ENGINEER'S OFFICE WILL ASSIST.

ALL IMPROVEMENTS SHALL BE LOCATED WITHIN BOUNDRIES OF THE PARK, AND THEY SHALL NOT ENCROACH INTO PUBLIC ROAD RIGHT OF WAYS.

NO ACCESS IS PERMITTED WITHIN THE STATE ROUTE 21 LIMITED ACCESS LINE, SHOWN AS L/A ON DRAWINGS.

LIGHTING PLAN SHOWN HEREON, IS ONLY A SUGGESTED LAYOUT.

ALL ELECTRICAL WIRING SHALL BE INSTALLED BY AN ELECTRICAL CONTRACTOR LICENCED BY THE CITY OF MASSILLON.

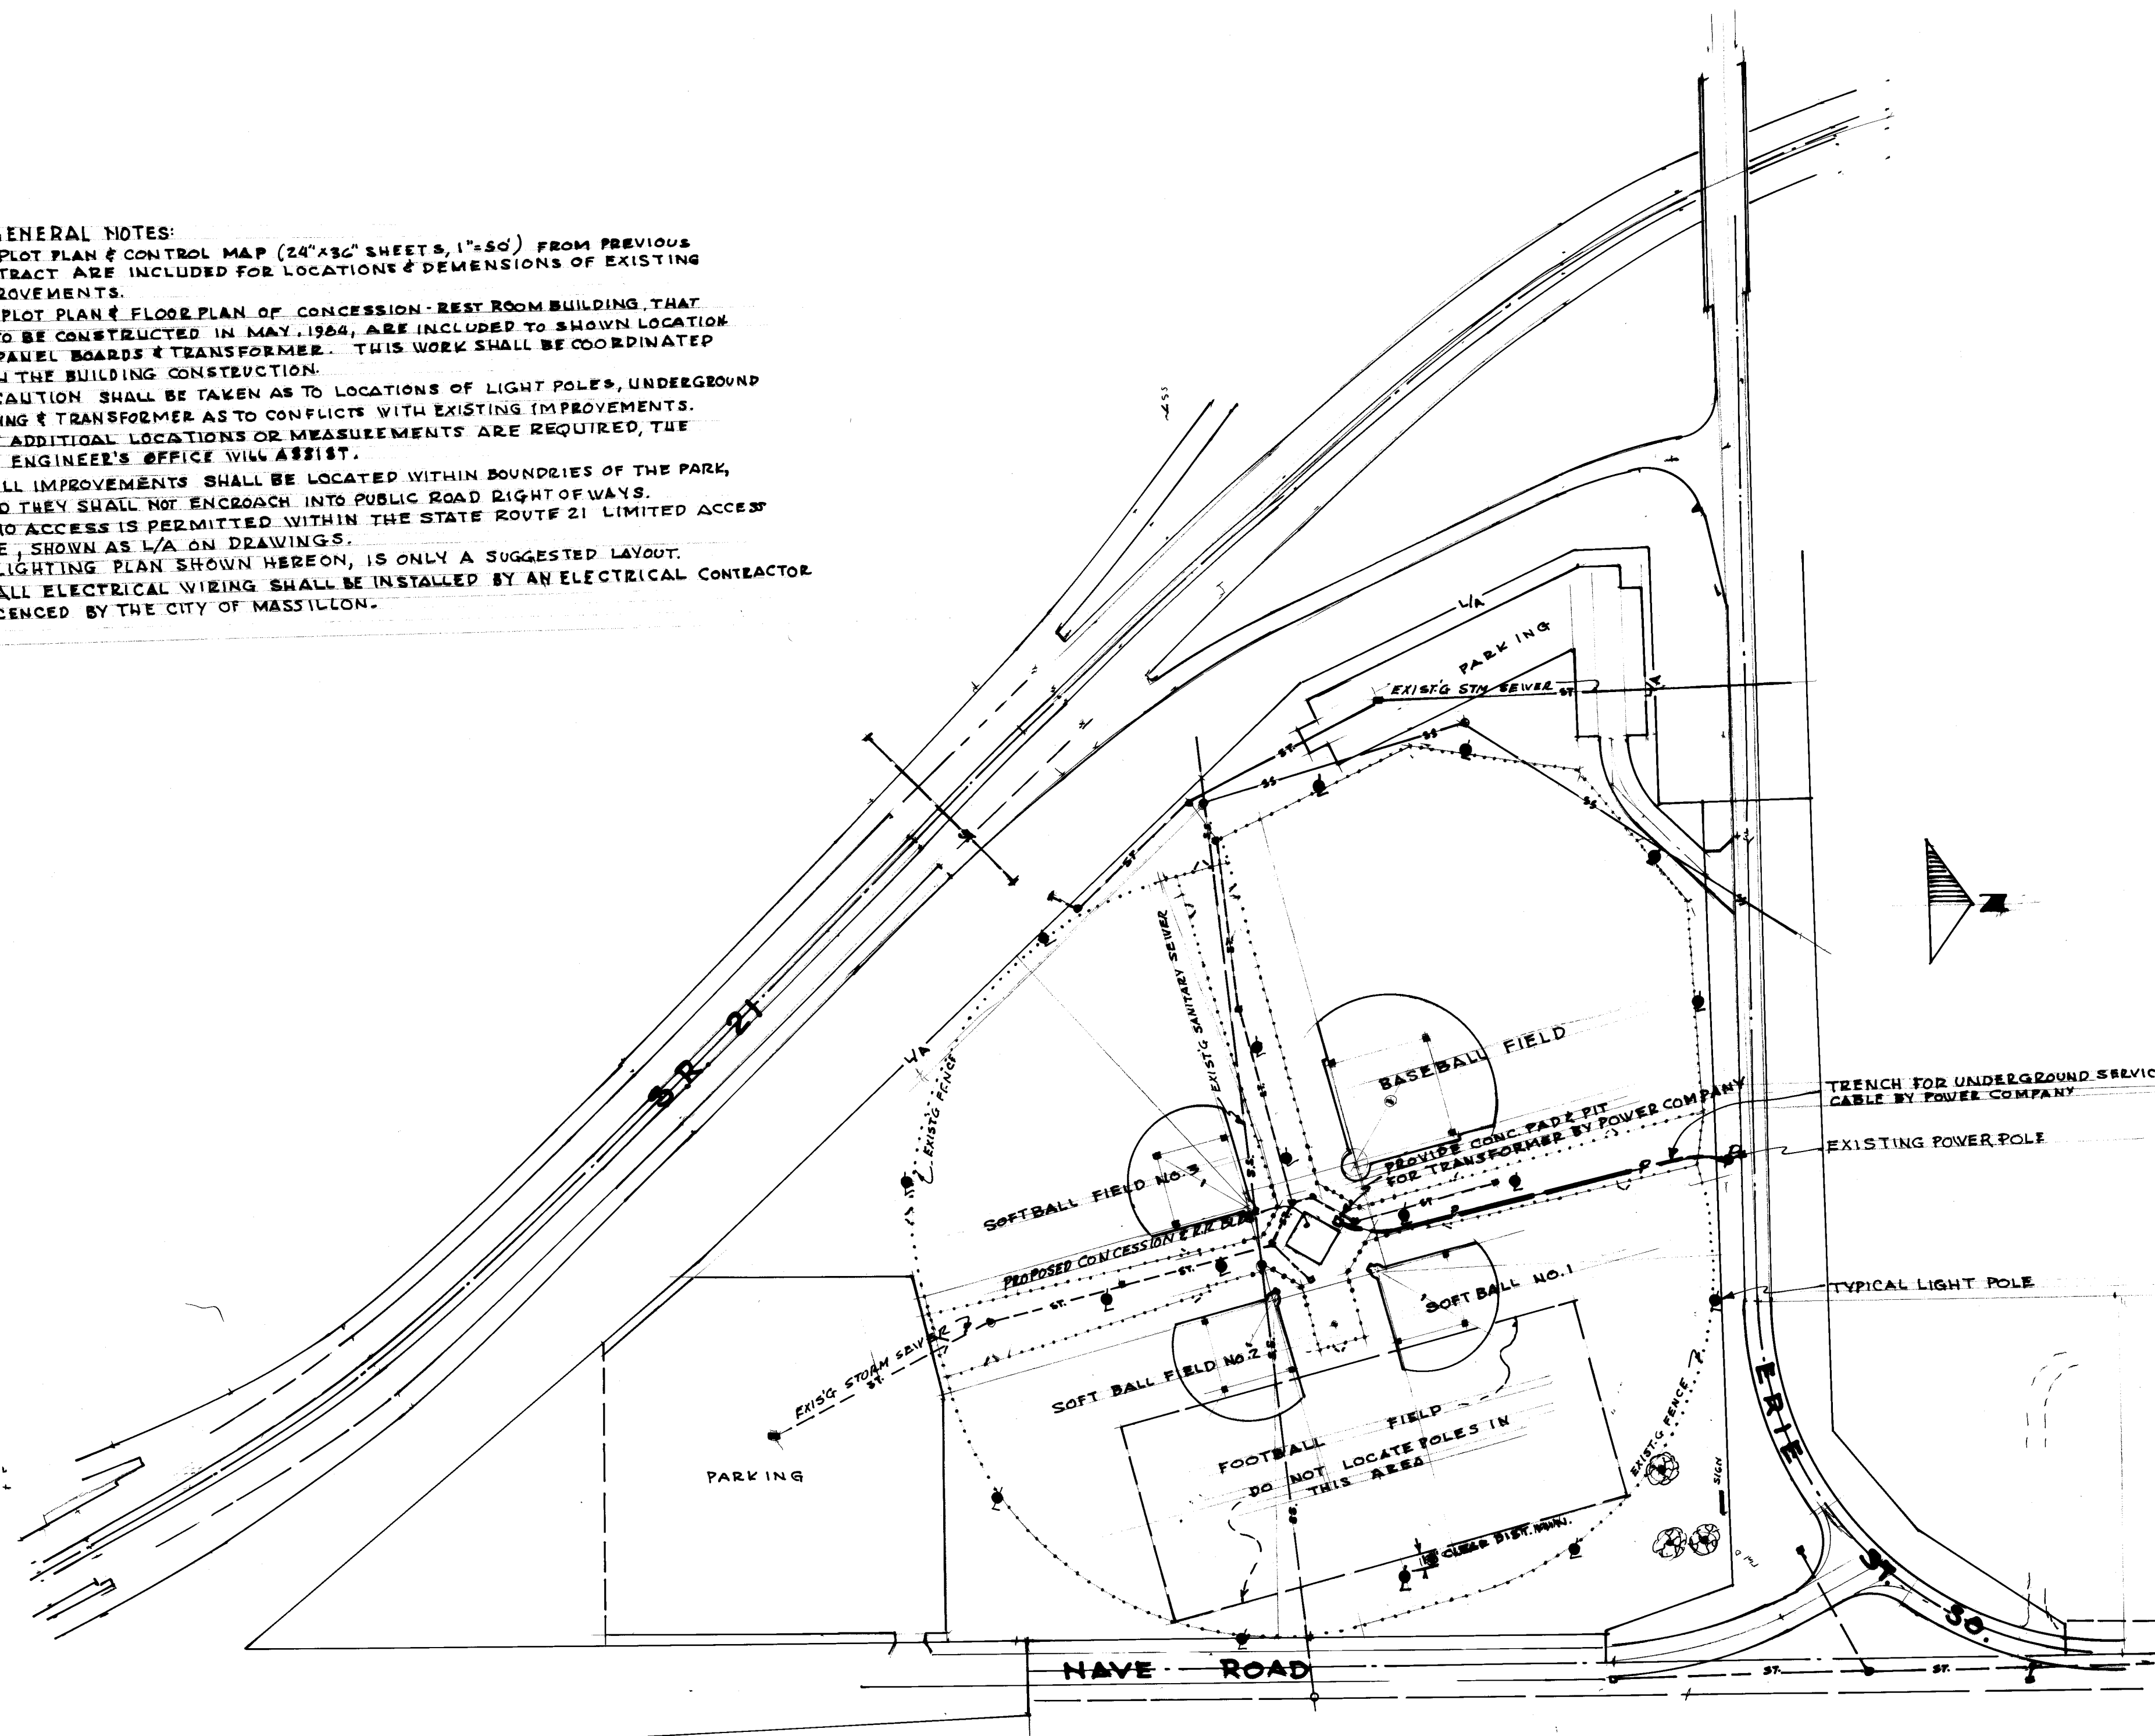

ARTHUR GENSHAFT MEMORIAL PARK

APRIL 1984

SCALE 1"=100'

SITE PLAN:

CITY OF MASSILLON, OHIO, DEPT. PUB. SERVICE, ENG. DIV.

AS BUILT

M-150A

