



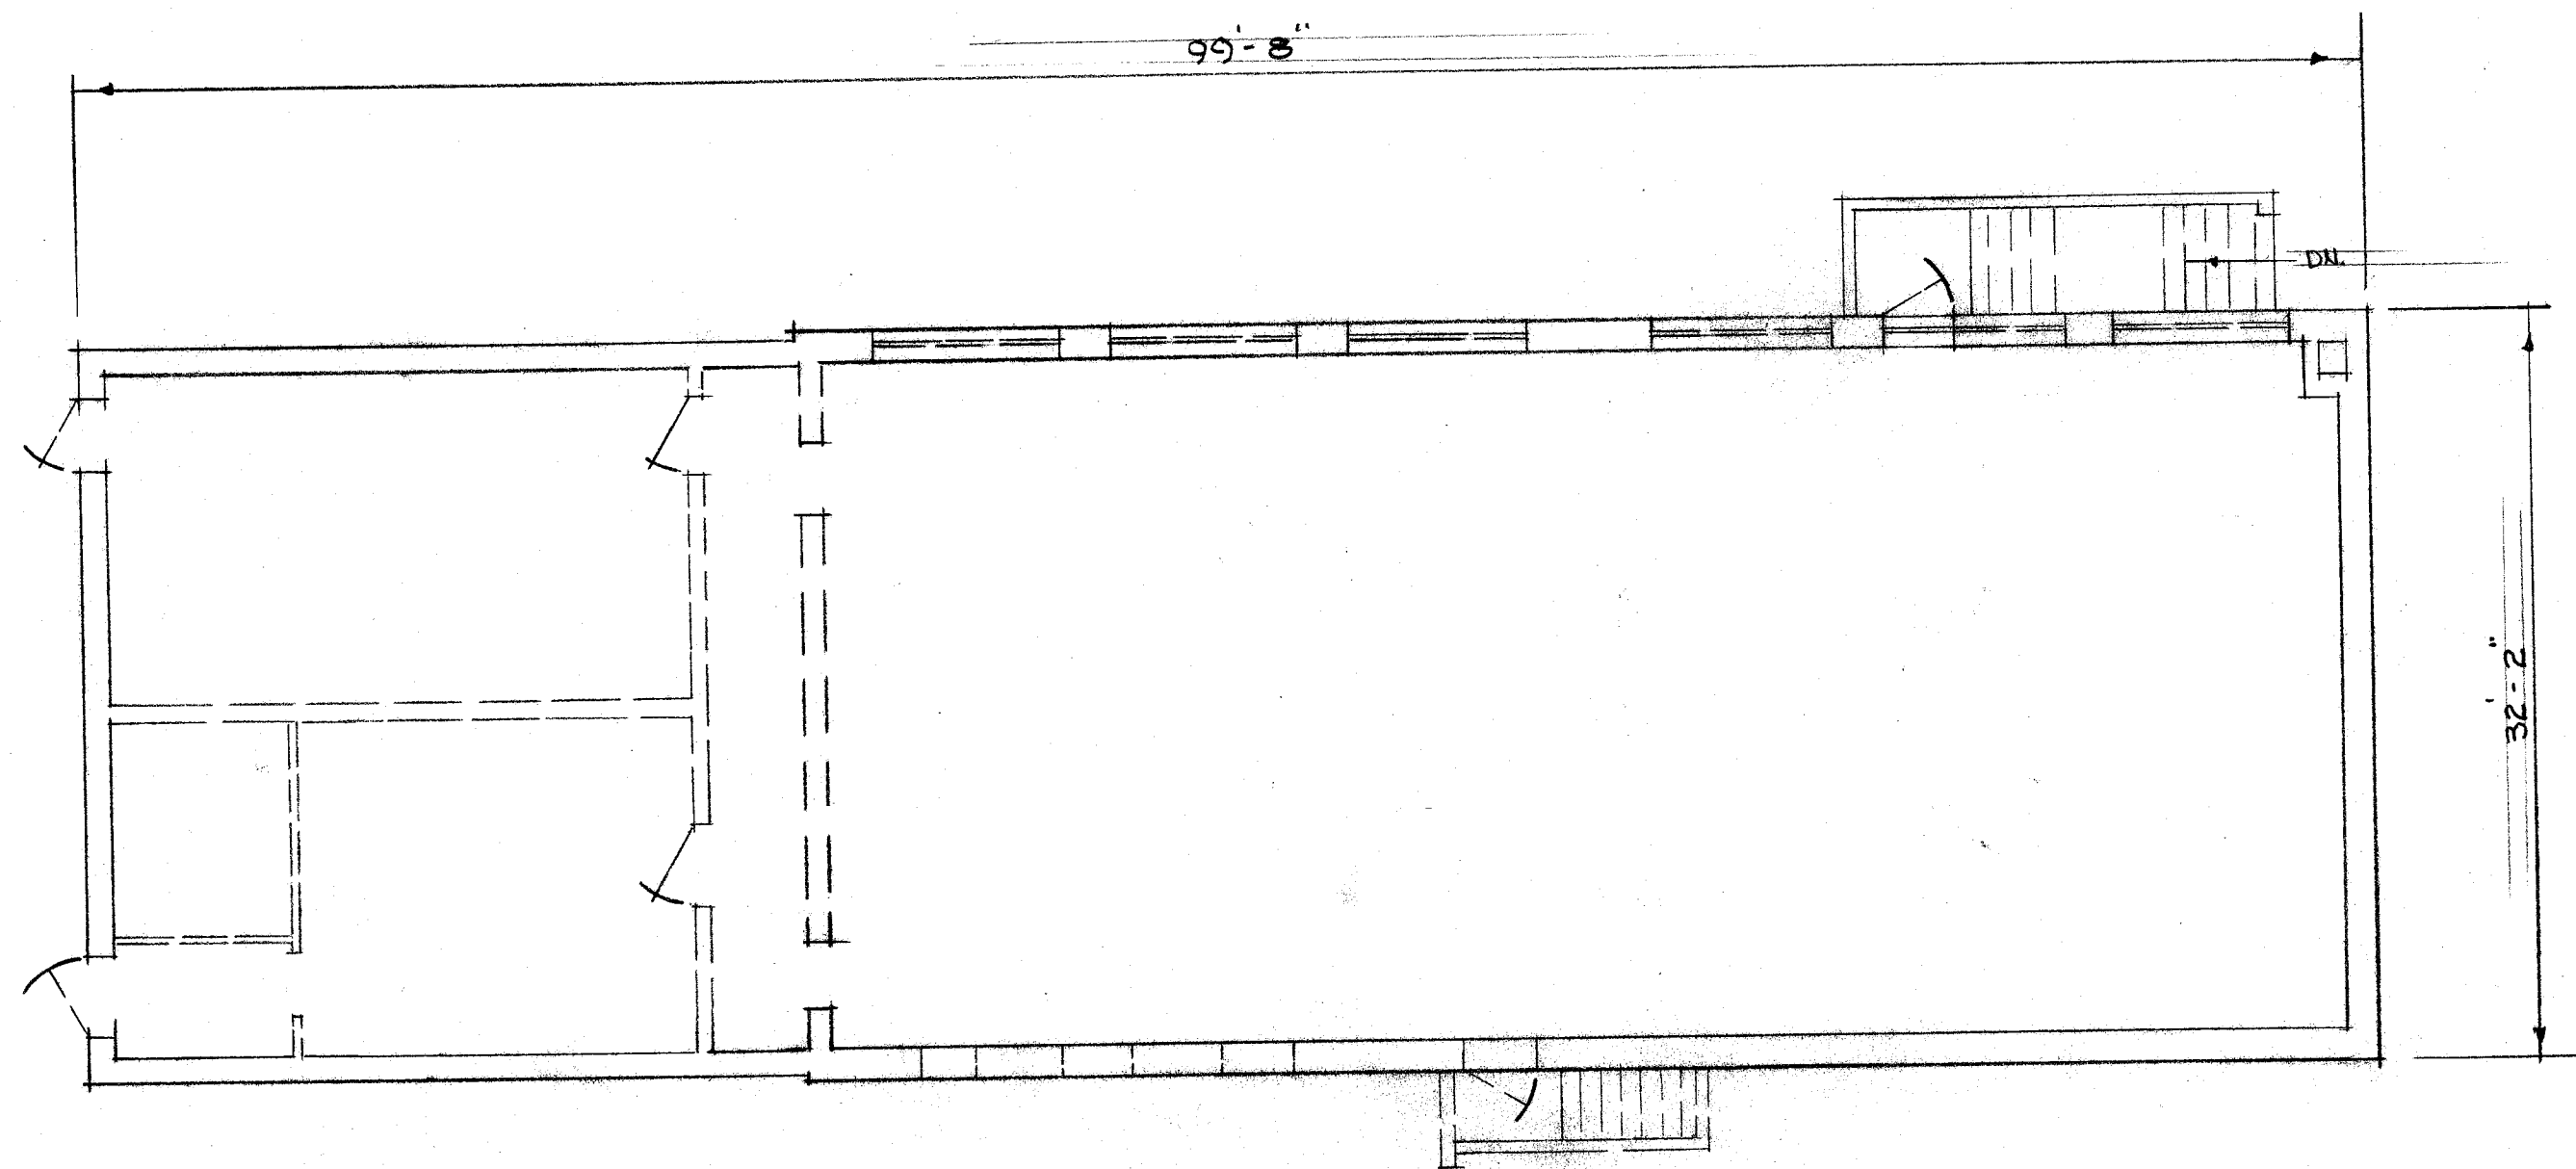

FLOOR PLAN
EX. RECREATION ROOM - HARVEY
SCALE 1/8" = 1'-0"

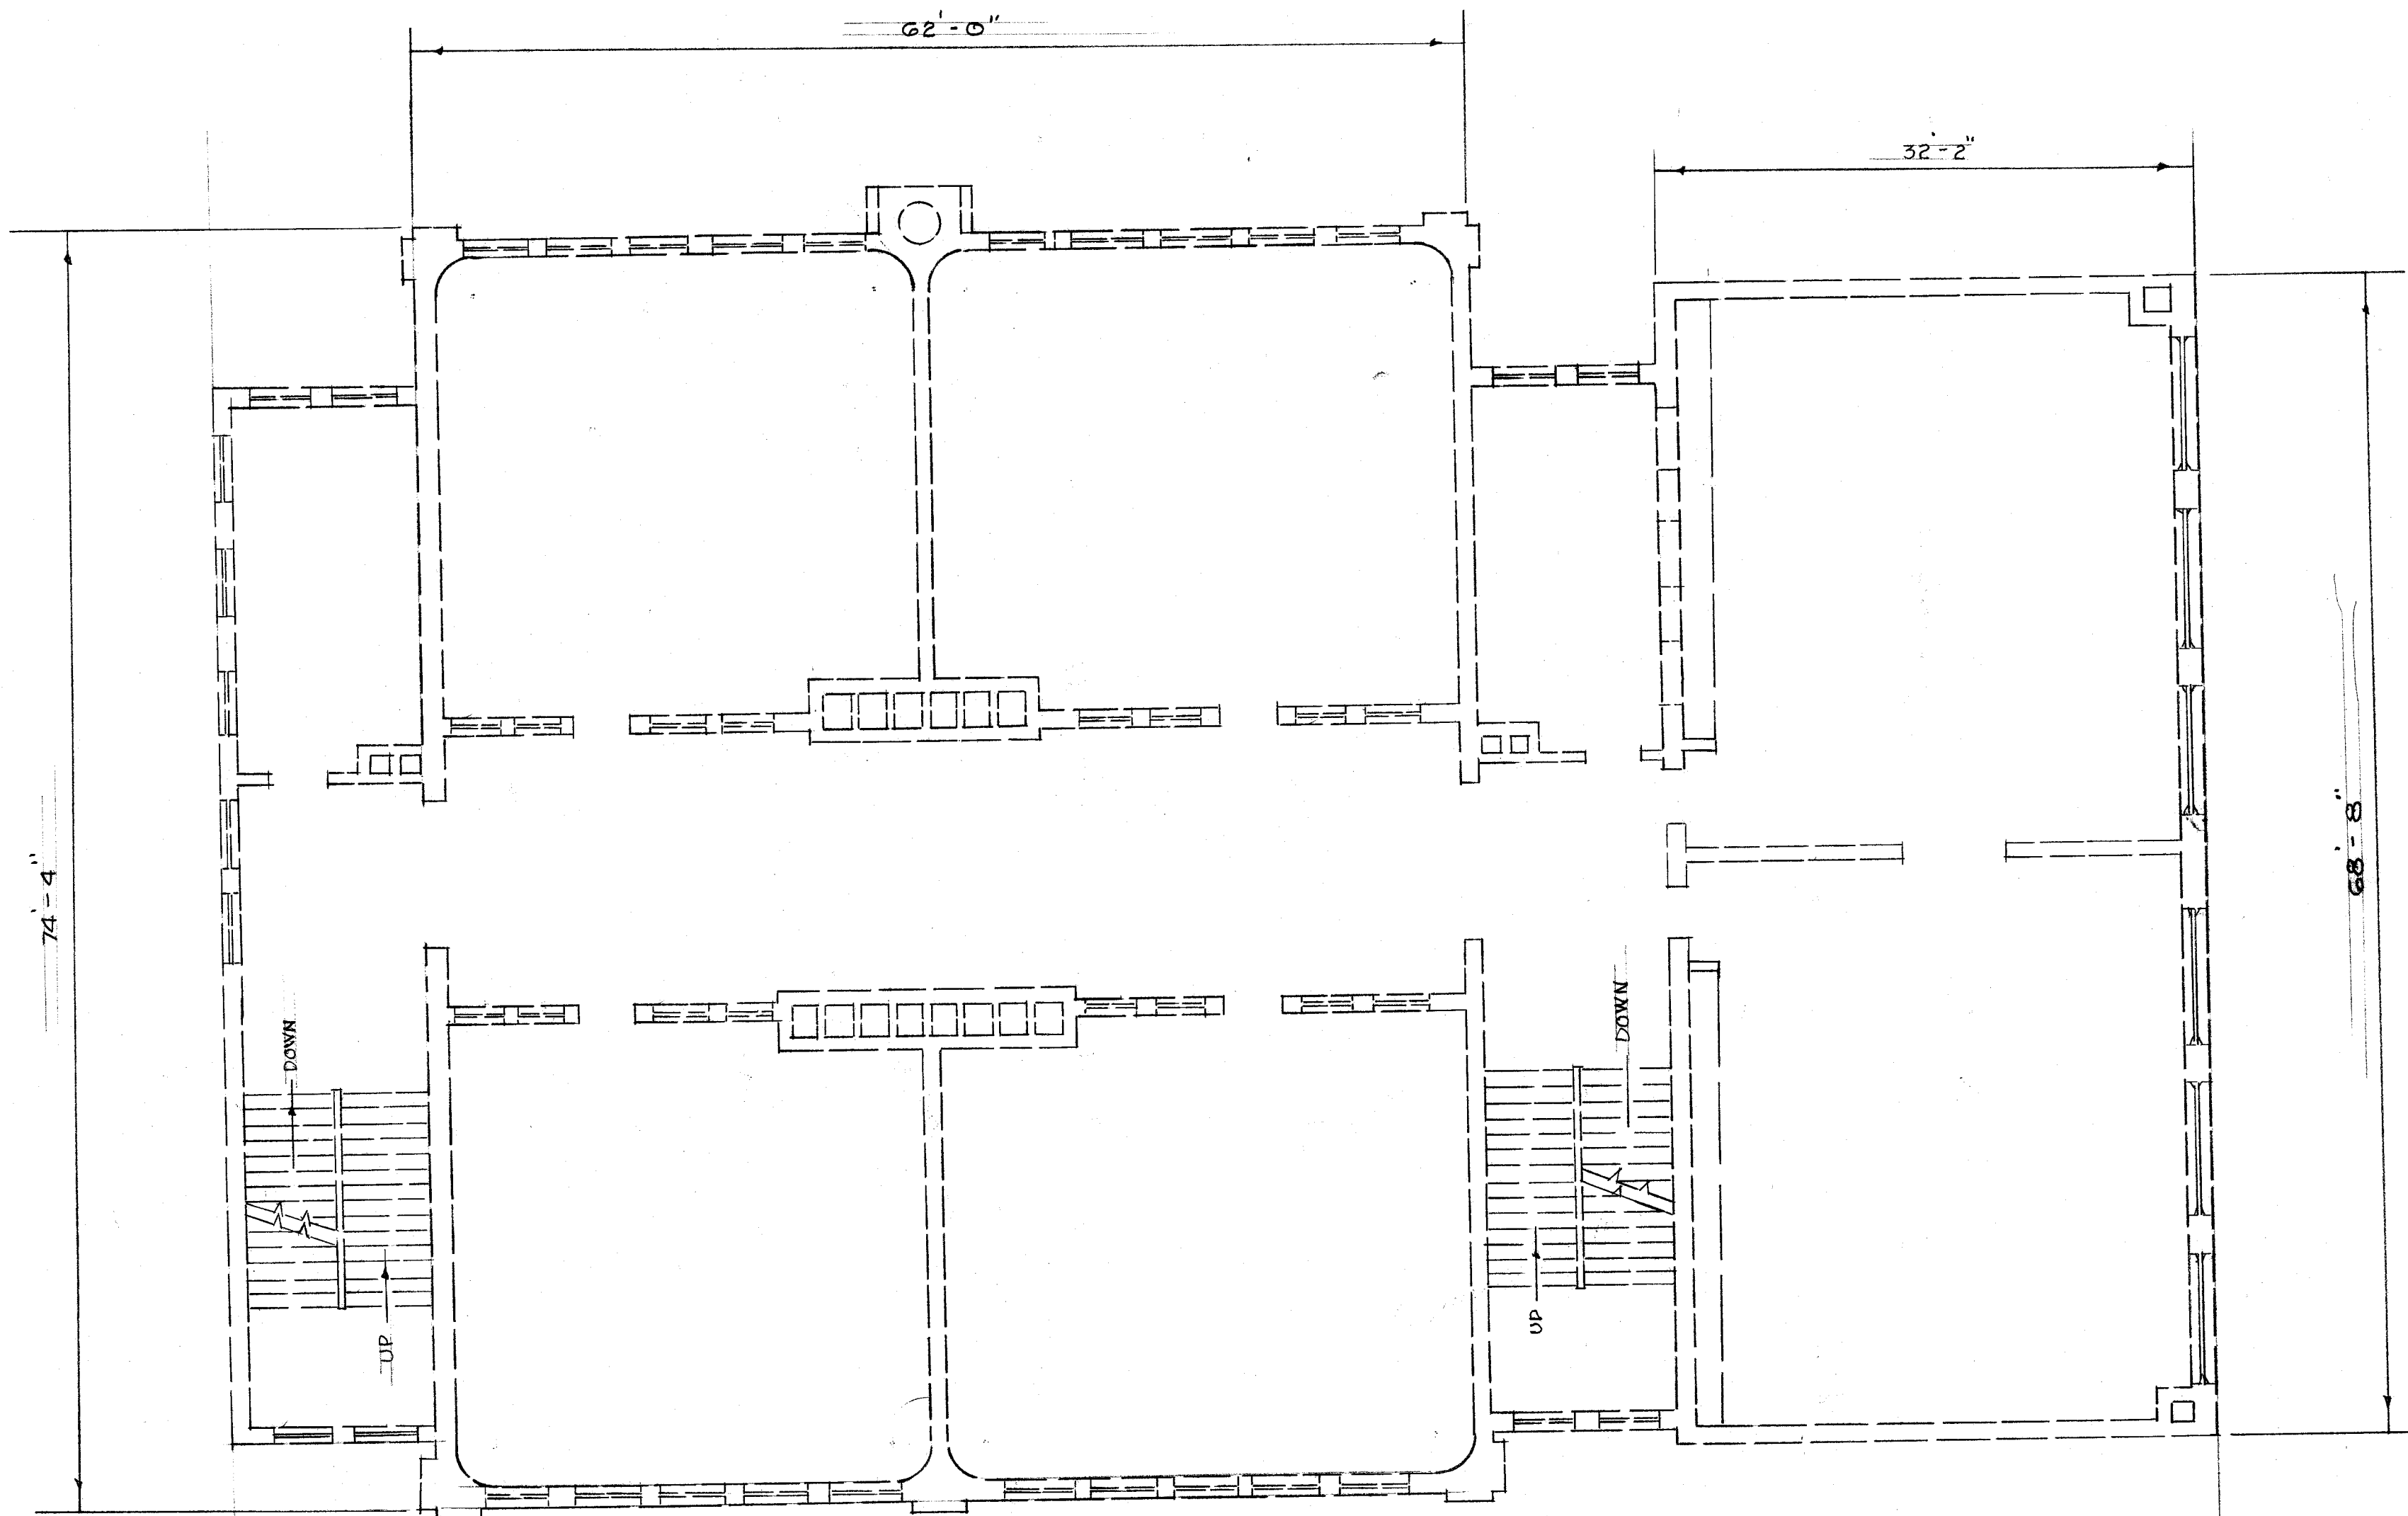

FIRST FLOOR PLAN HARVEY GRADE SCHOOL

SCALE $\frac{1}{8}" = 1'-0"$


HEATING & ELECTRICAL LAYOUT

DR BY RON MCPHERSON
CITY ENG. ROBT. WAGONER
SCALE $\frac{1}{8}" = 1'-0"$

DEPT. OF PUBLIC SERVICE
ENGINEERING DIVISION

DATE 5-2-83

M-758

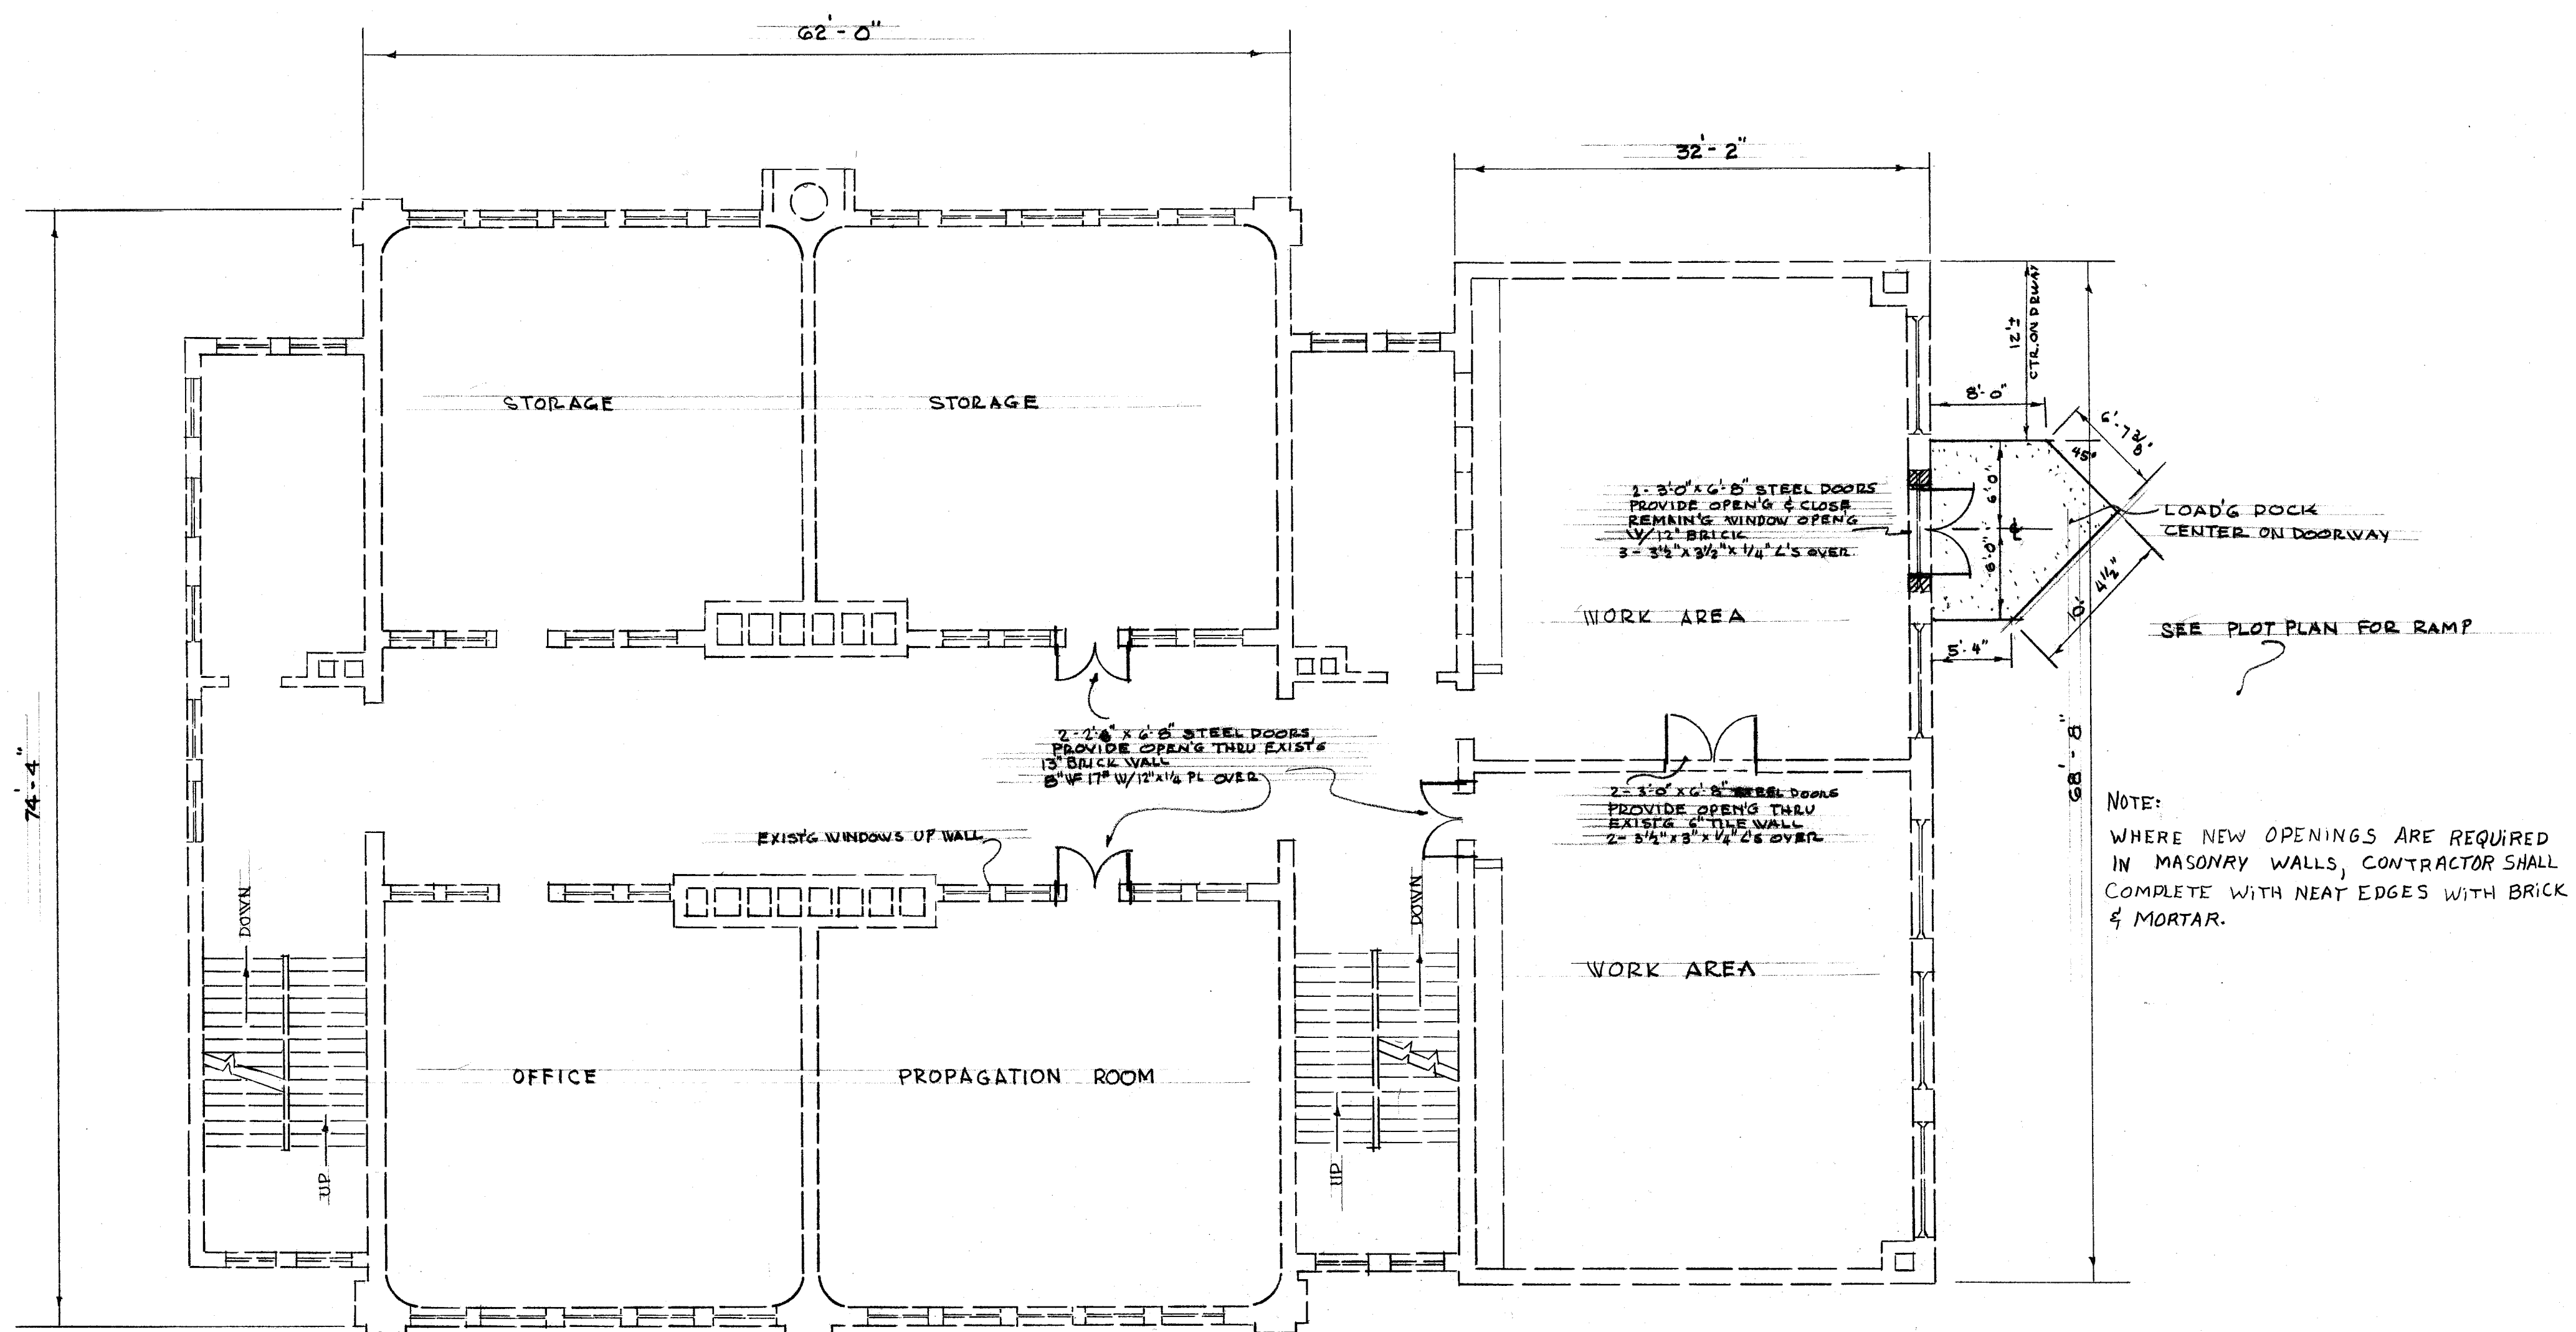

FIRST FLOOR PLAN HARVEY GRADE SCHOOL

SCALE $\frac{1}{8}'' = 1'-0''$

PARK DEPT.


FIRST FLOOR LAYOUT PLAN

DR BY RON MCPHERSON
CITY ENG. ROBT. WAGONER
SCALE $\frac{1}{8}'' = 1'-0''$

DEPT. OF PUBLIC SERVICE
ENGINEERING DIVISION

DATE 5-2-83

M-758 Acc.No. 3003

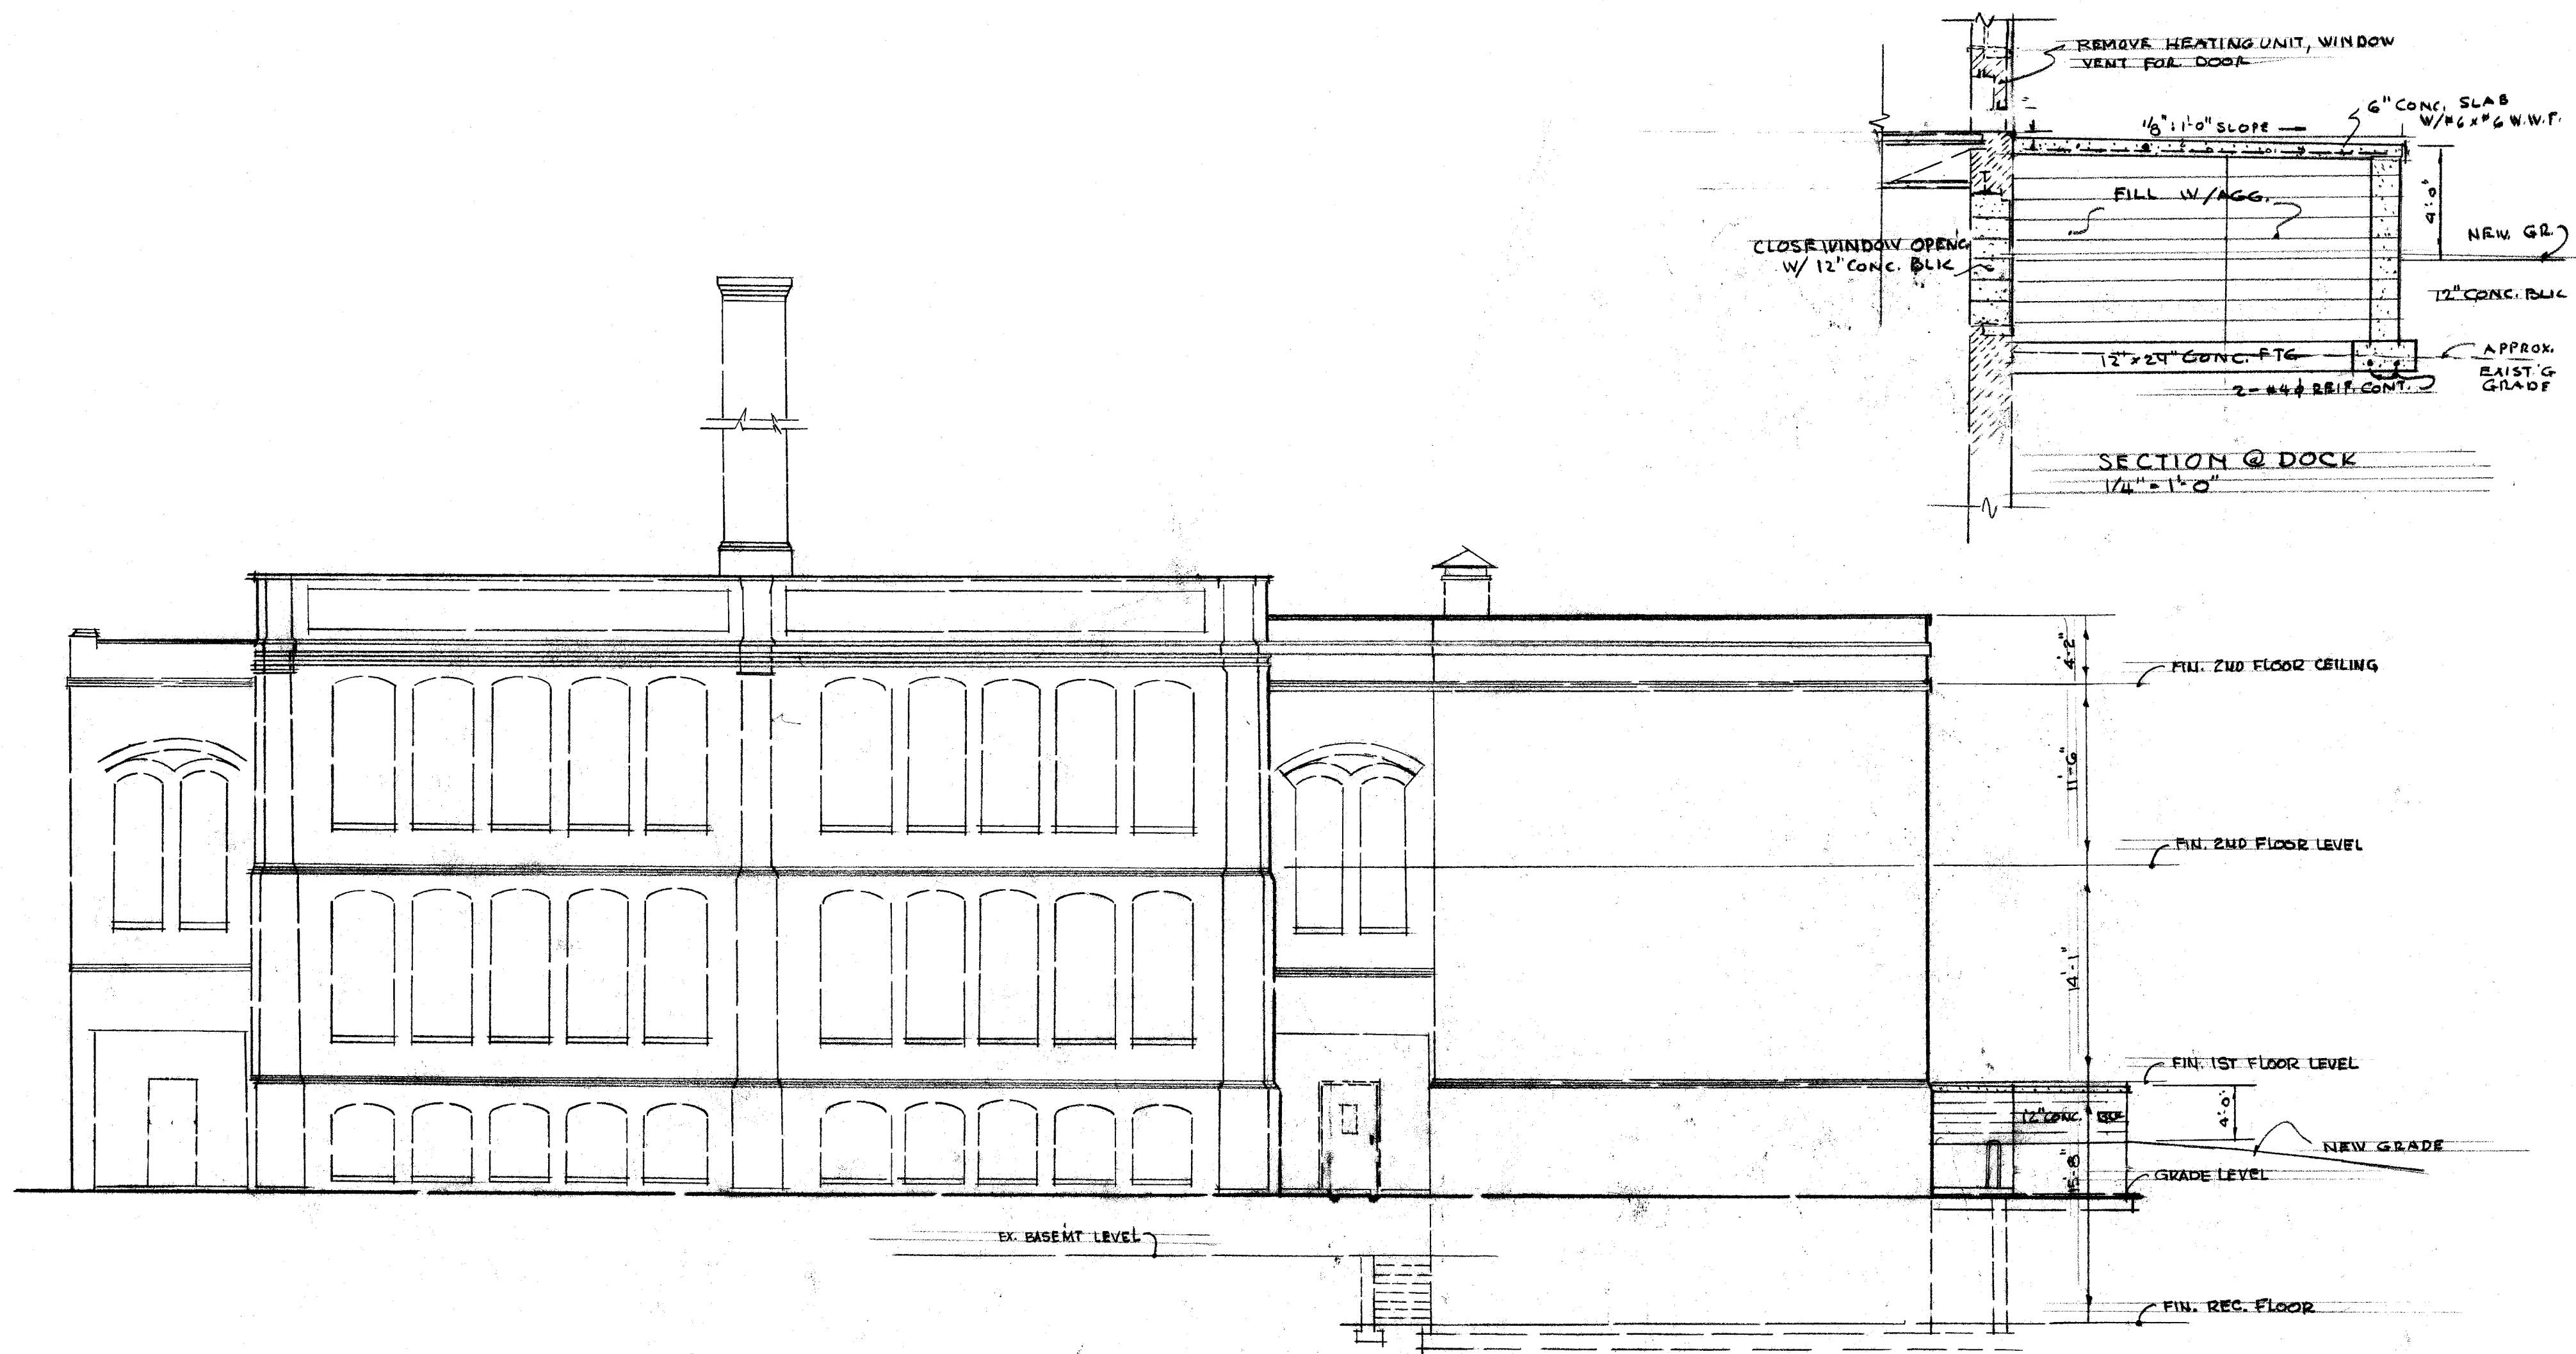

EX. SOUTH ELEVATION OF HARVEY GRADE SCHOOL

SCALE 1/8" = 1'-0"


PARK DEPT



EX. NORTH ELEVATION OF HARVEY GRADE SCHOOL


SCALE $\frac{1}{8}'' = 1'-0''$

PARK DEPT.

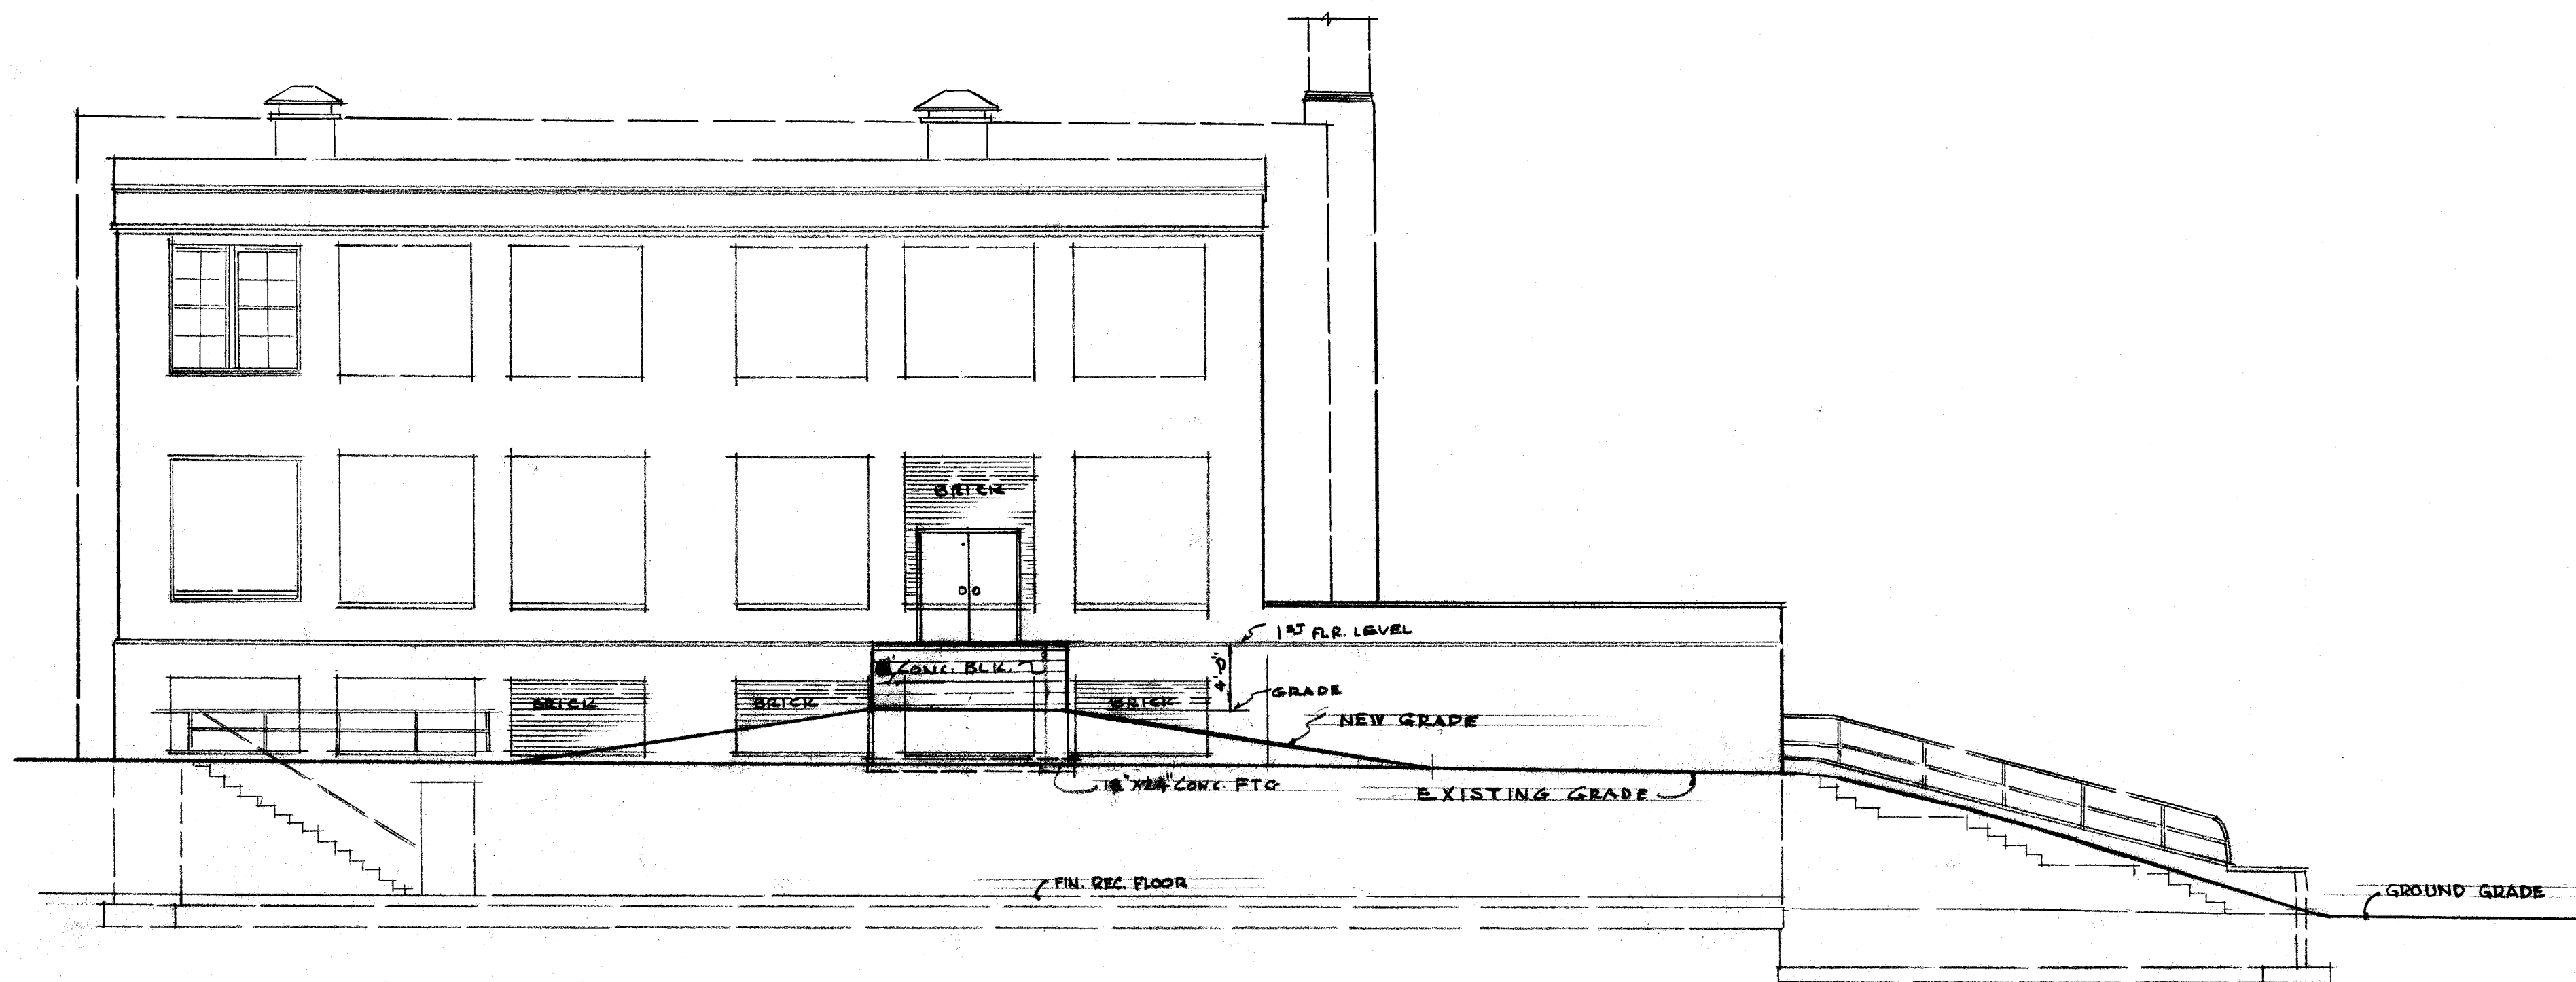

EAST ELEVATION


SCALE 1/8" = 1'-0"

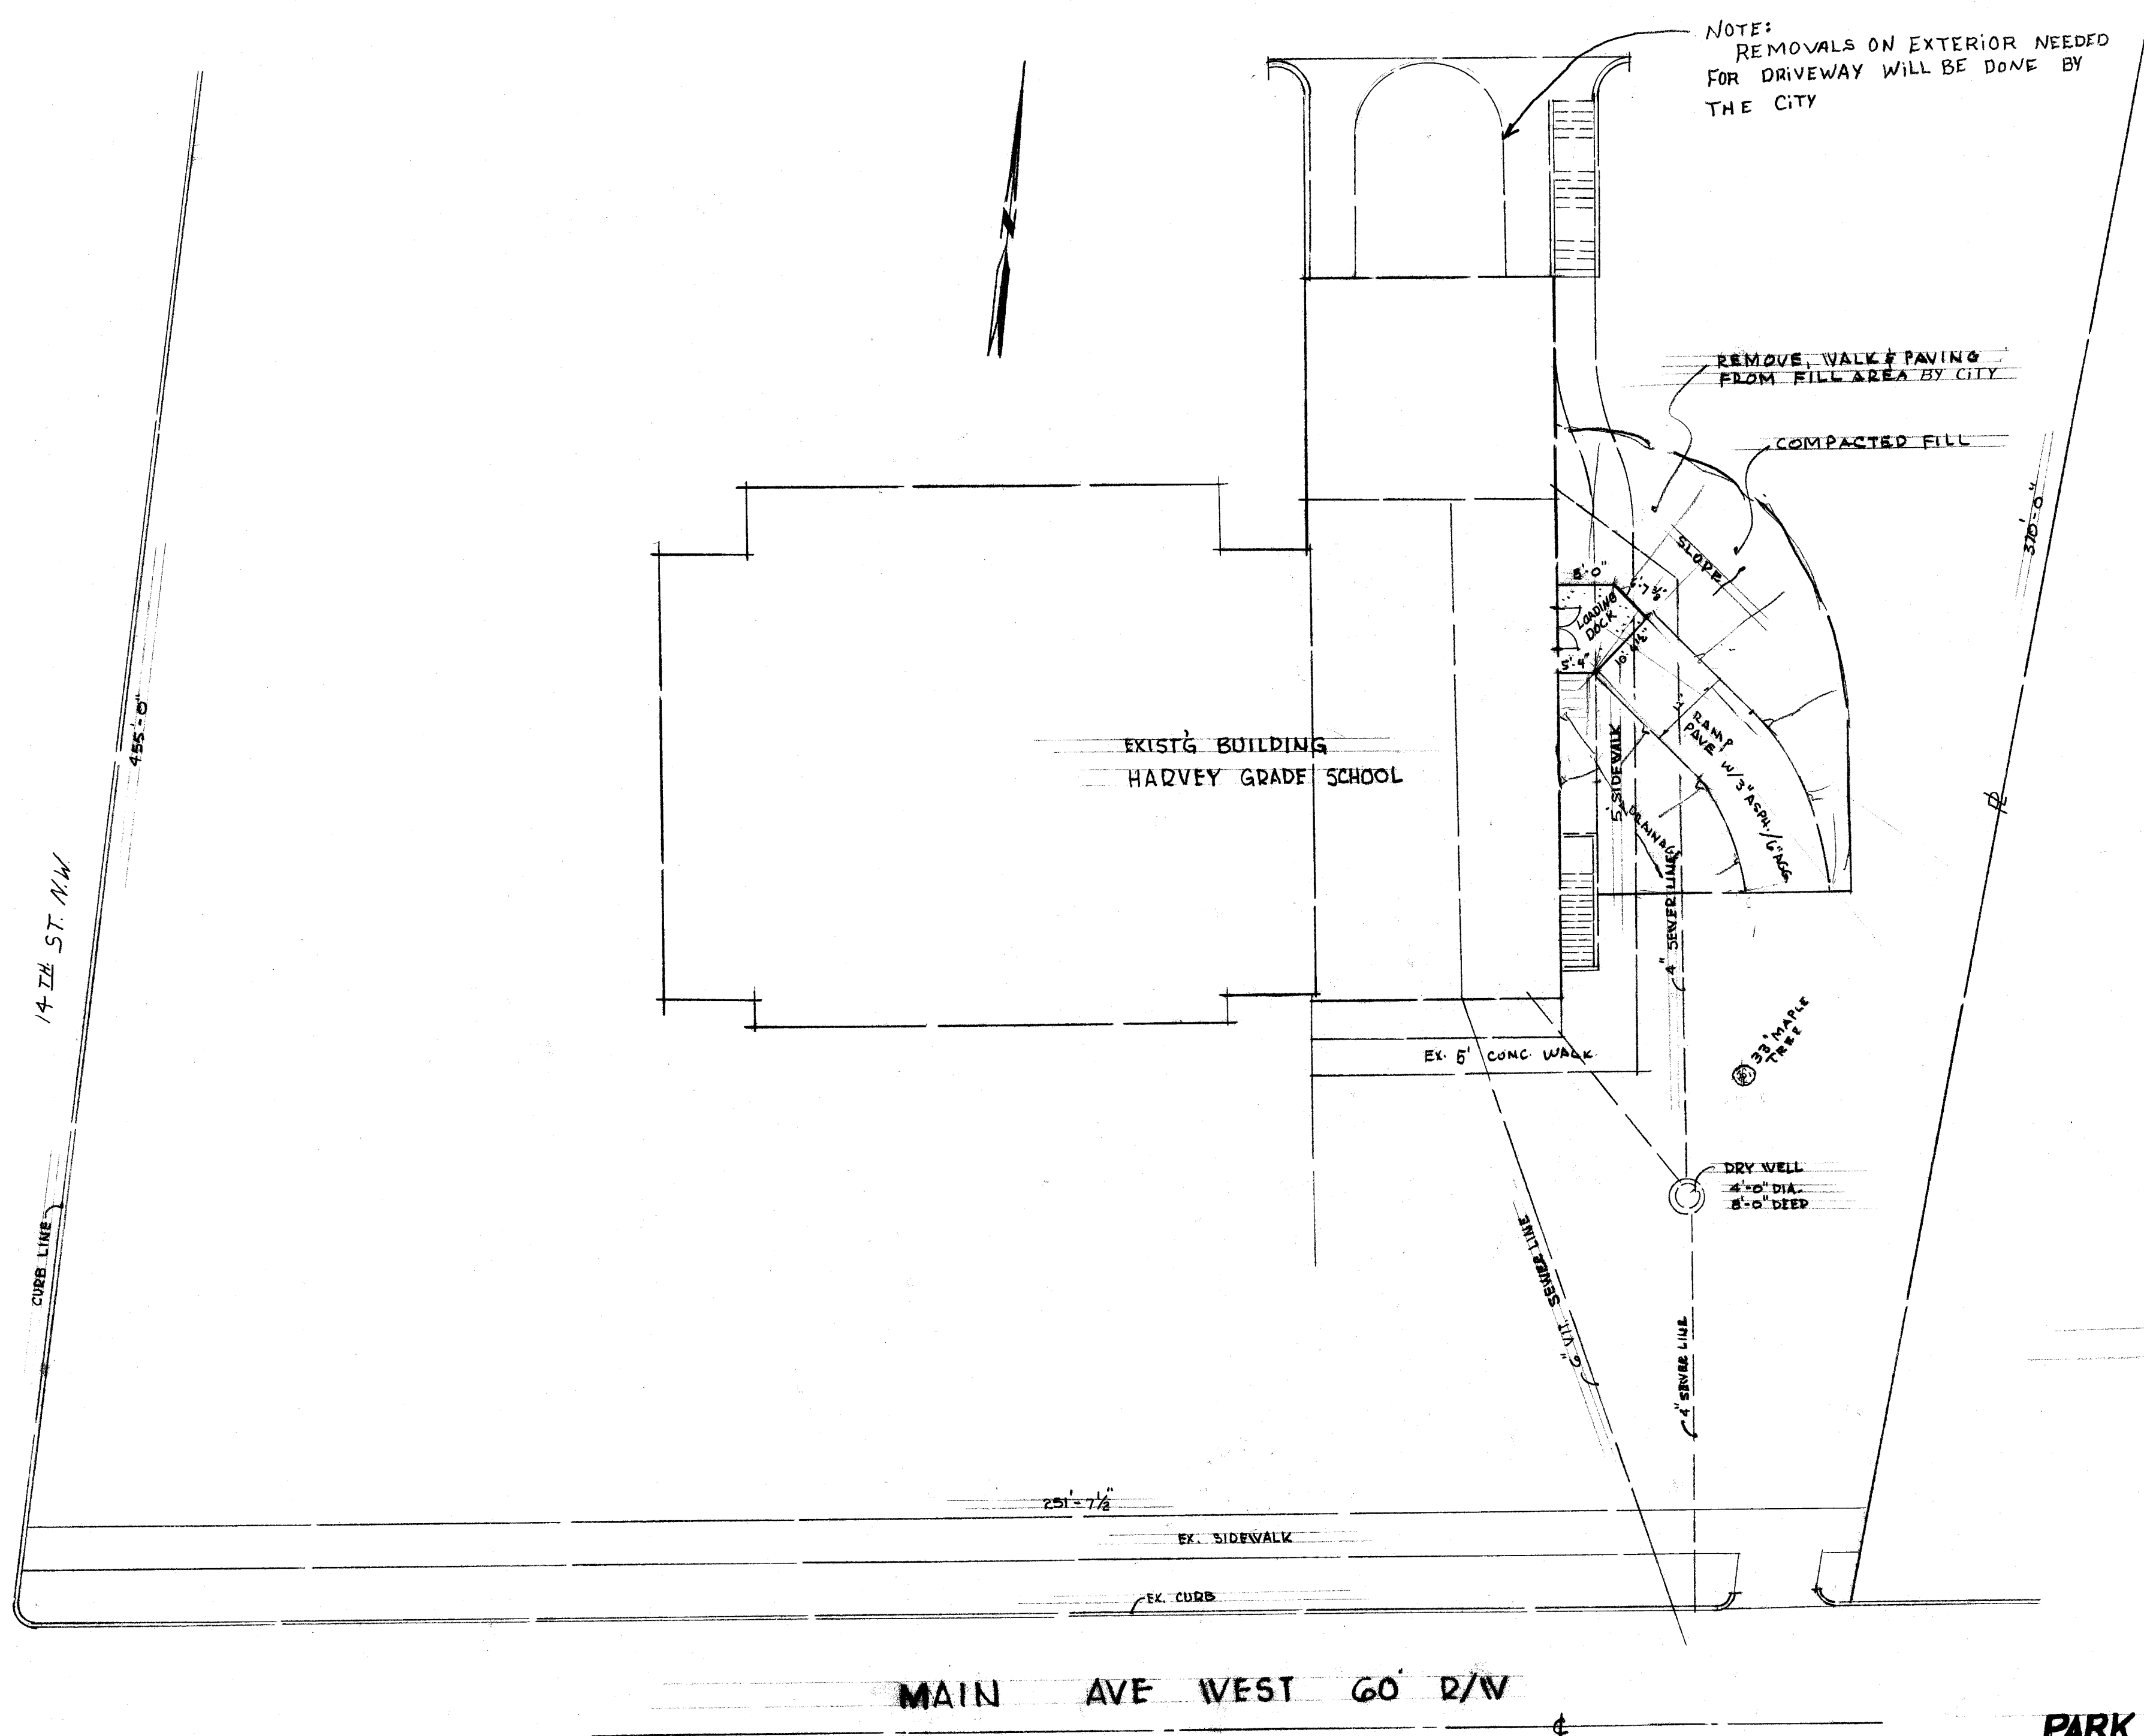

SITE MAP

PARK DEPT. BUILDING
EXIST'G HARVEY GRADE SCHOOL
DR BY RON MCPHERSON
SCALE 1/8" = 1'-0" DATE 3-4-82

20 GAUGE STEEL DOOR WITH POLY STYRENE INSULATION HARD BOARD BACK UP
OVERHEAD DOOR CORR. SERIES 423 OR EQUAL

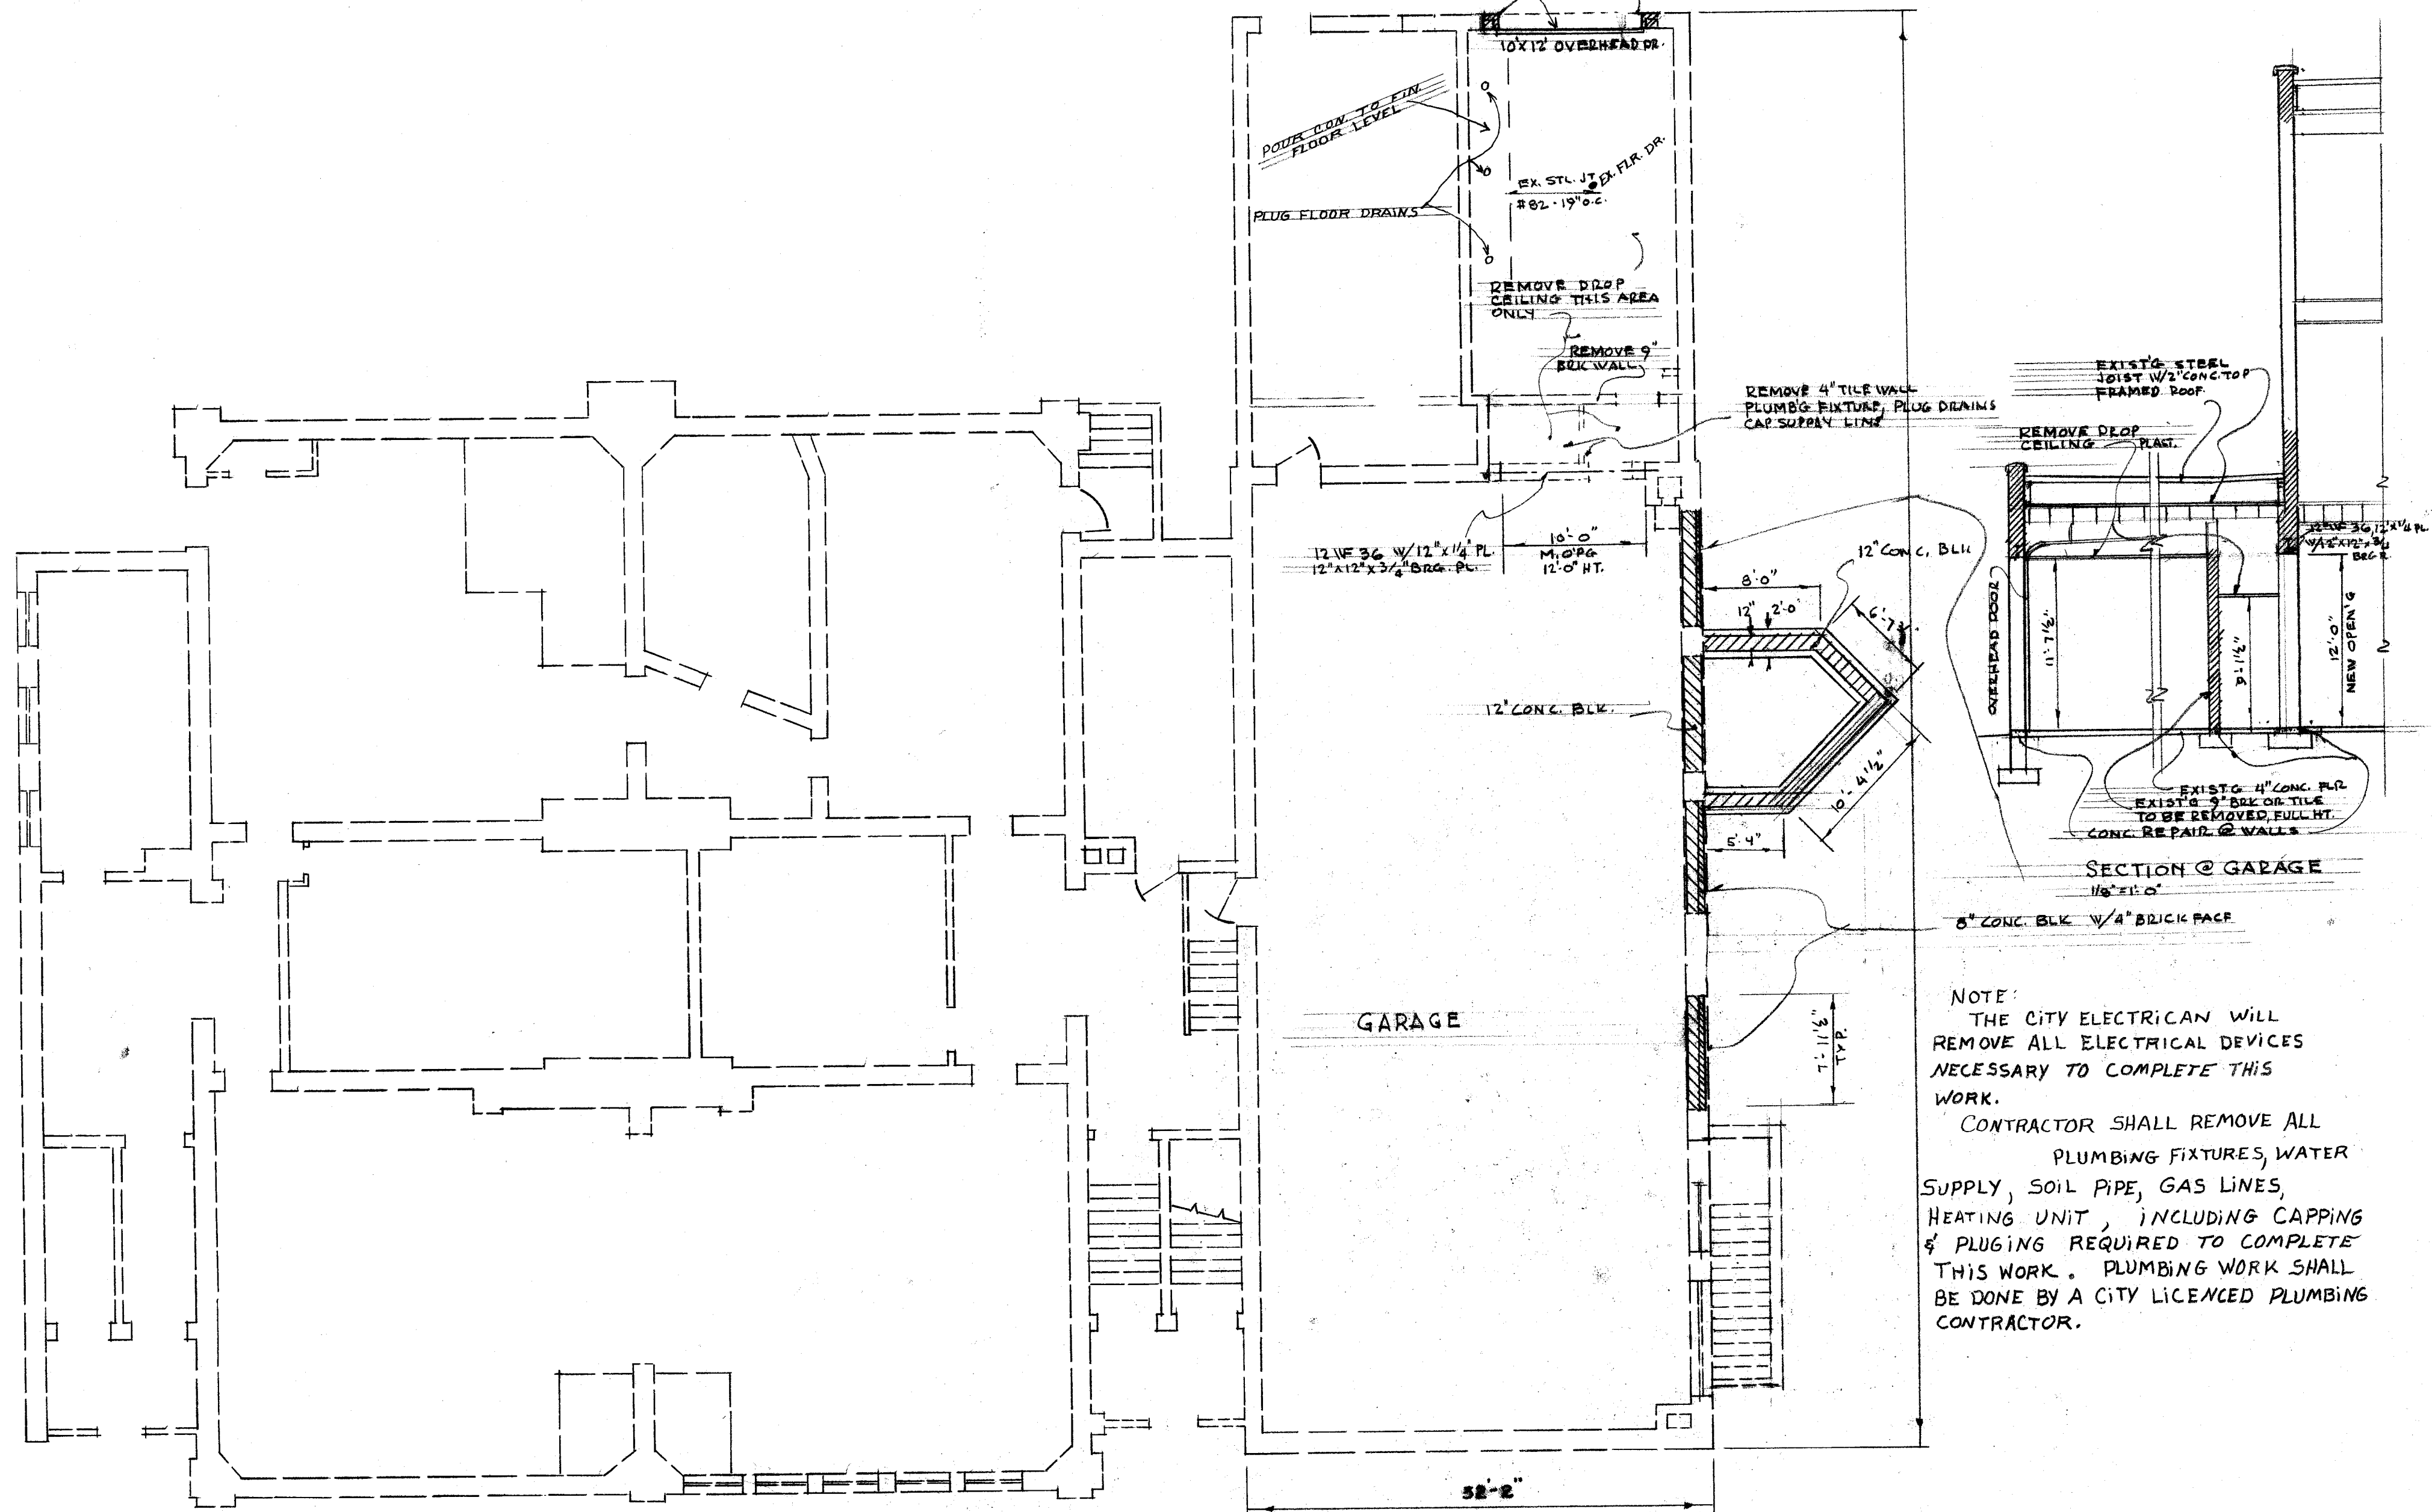

BASEMENT FLOOR PLAN HARVEY GRADE SCHOOL

SCALE 1/8" = 1'-0"

PARK DEPT.

BASEMENT FLOOR LAYOUT PLAN

DR BY RON MCPHERSON
CITY ENG. ROBT. WAGONER
SCALE 1/8" = 1'-0"

DEPT. OF PUBLIC SERVICE
ENGINEERING DIVISION
DATE 5-2-83

