
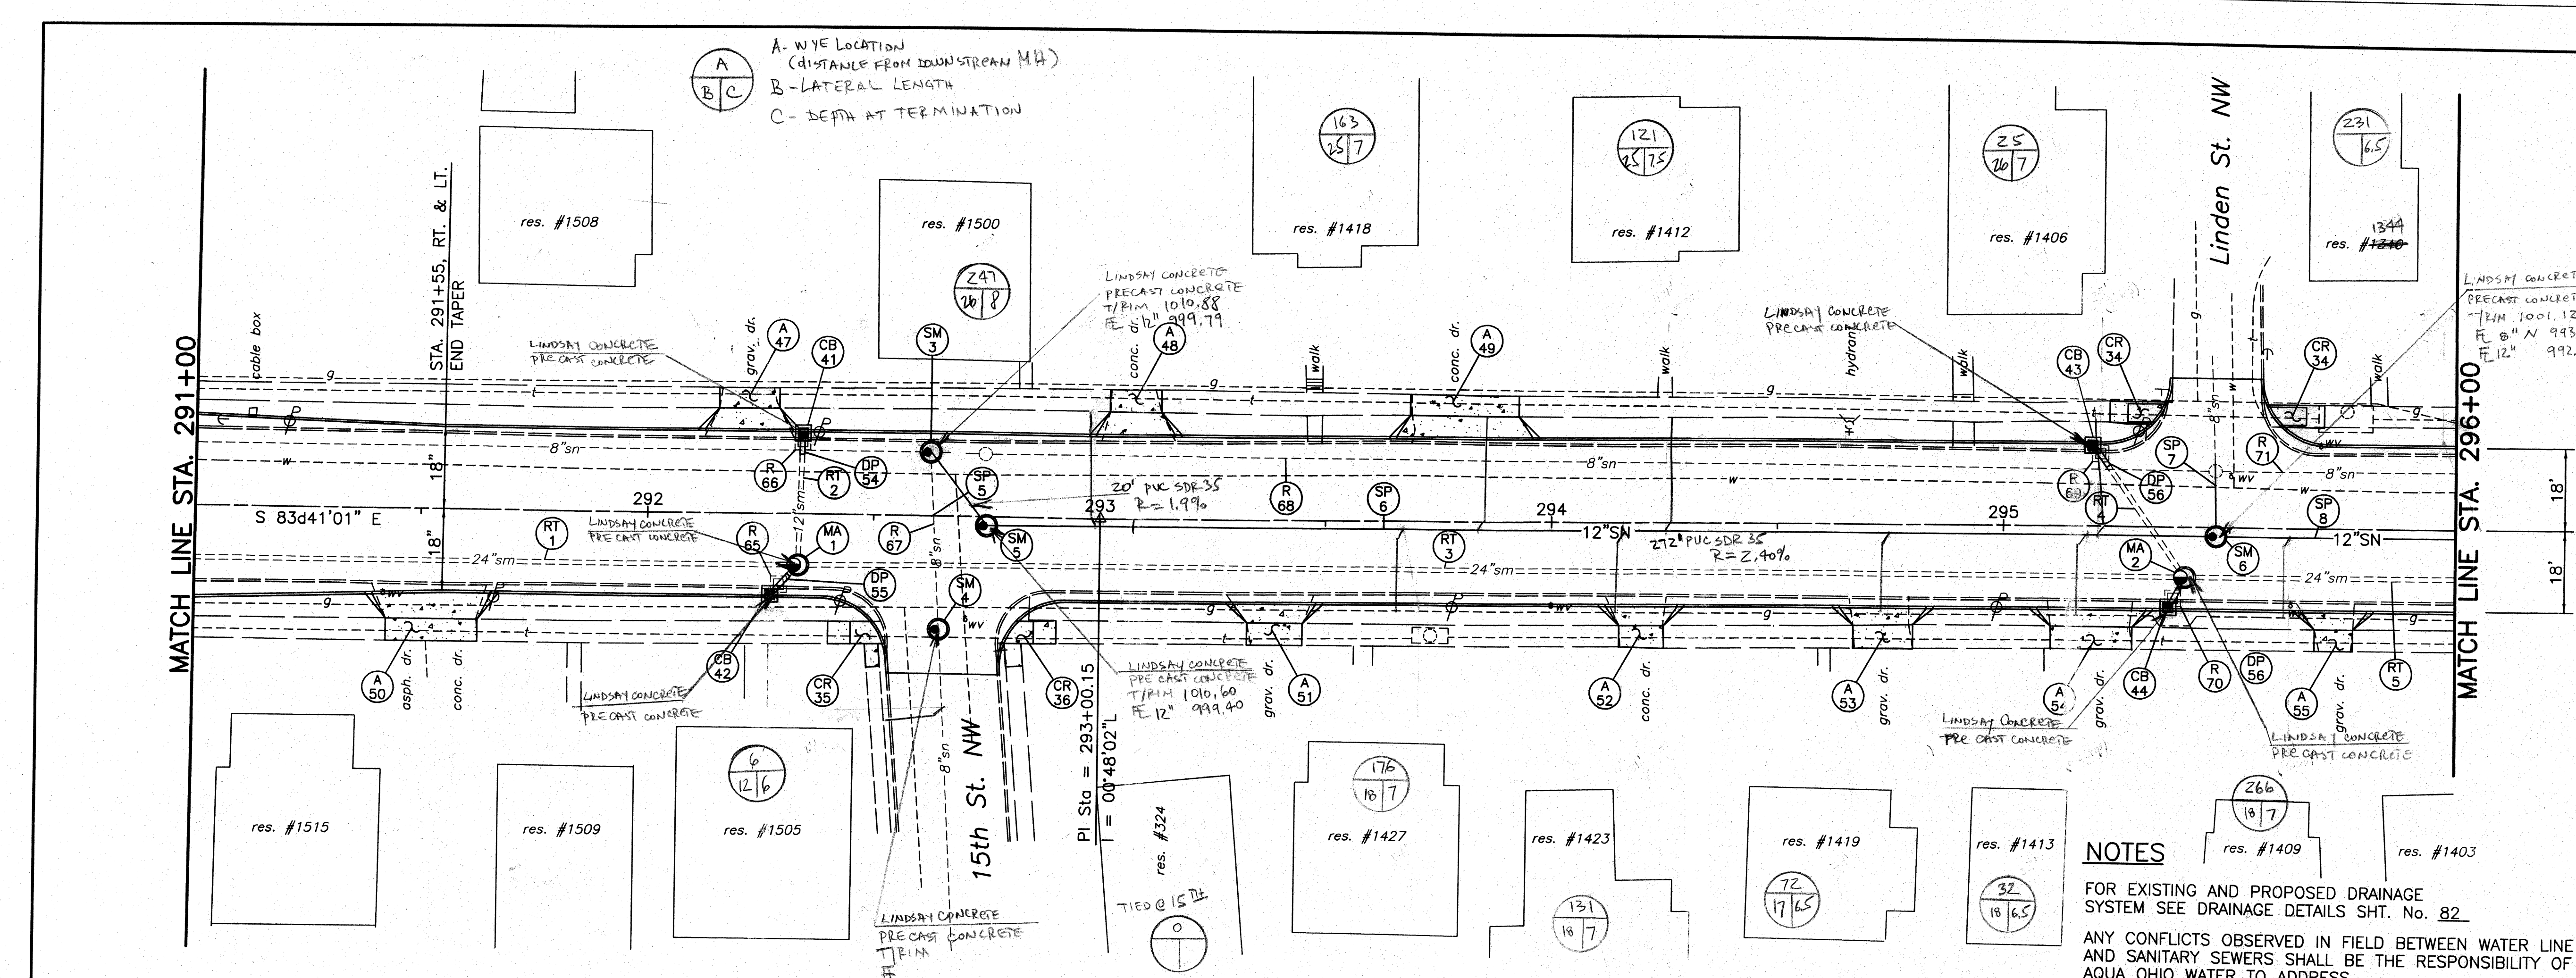


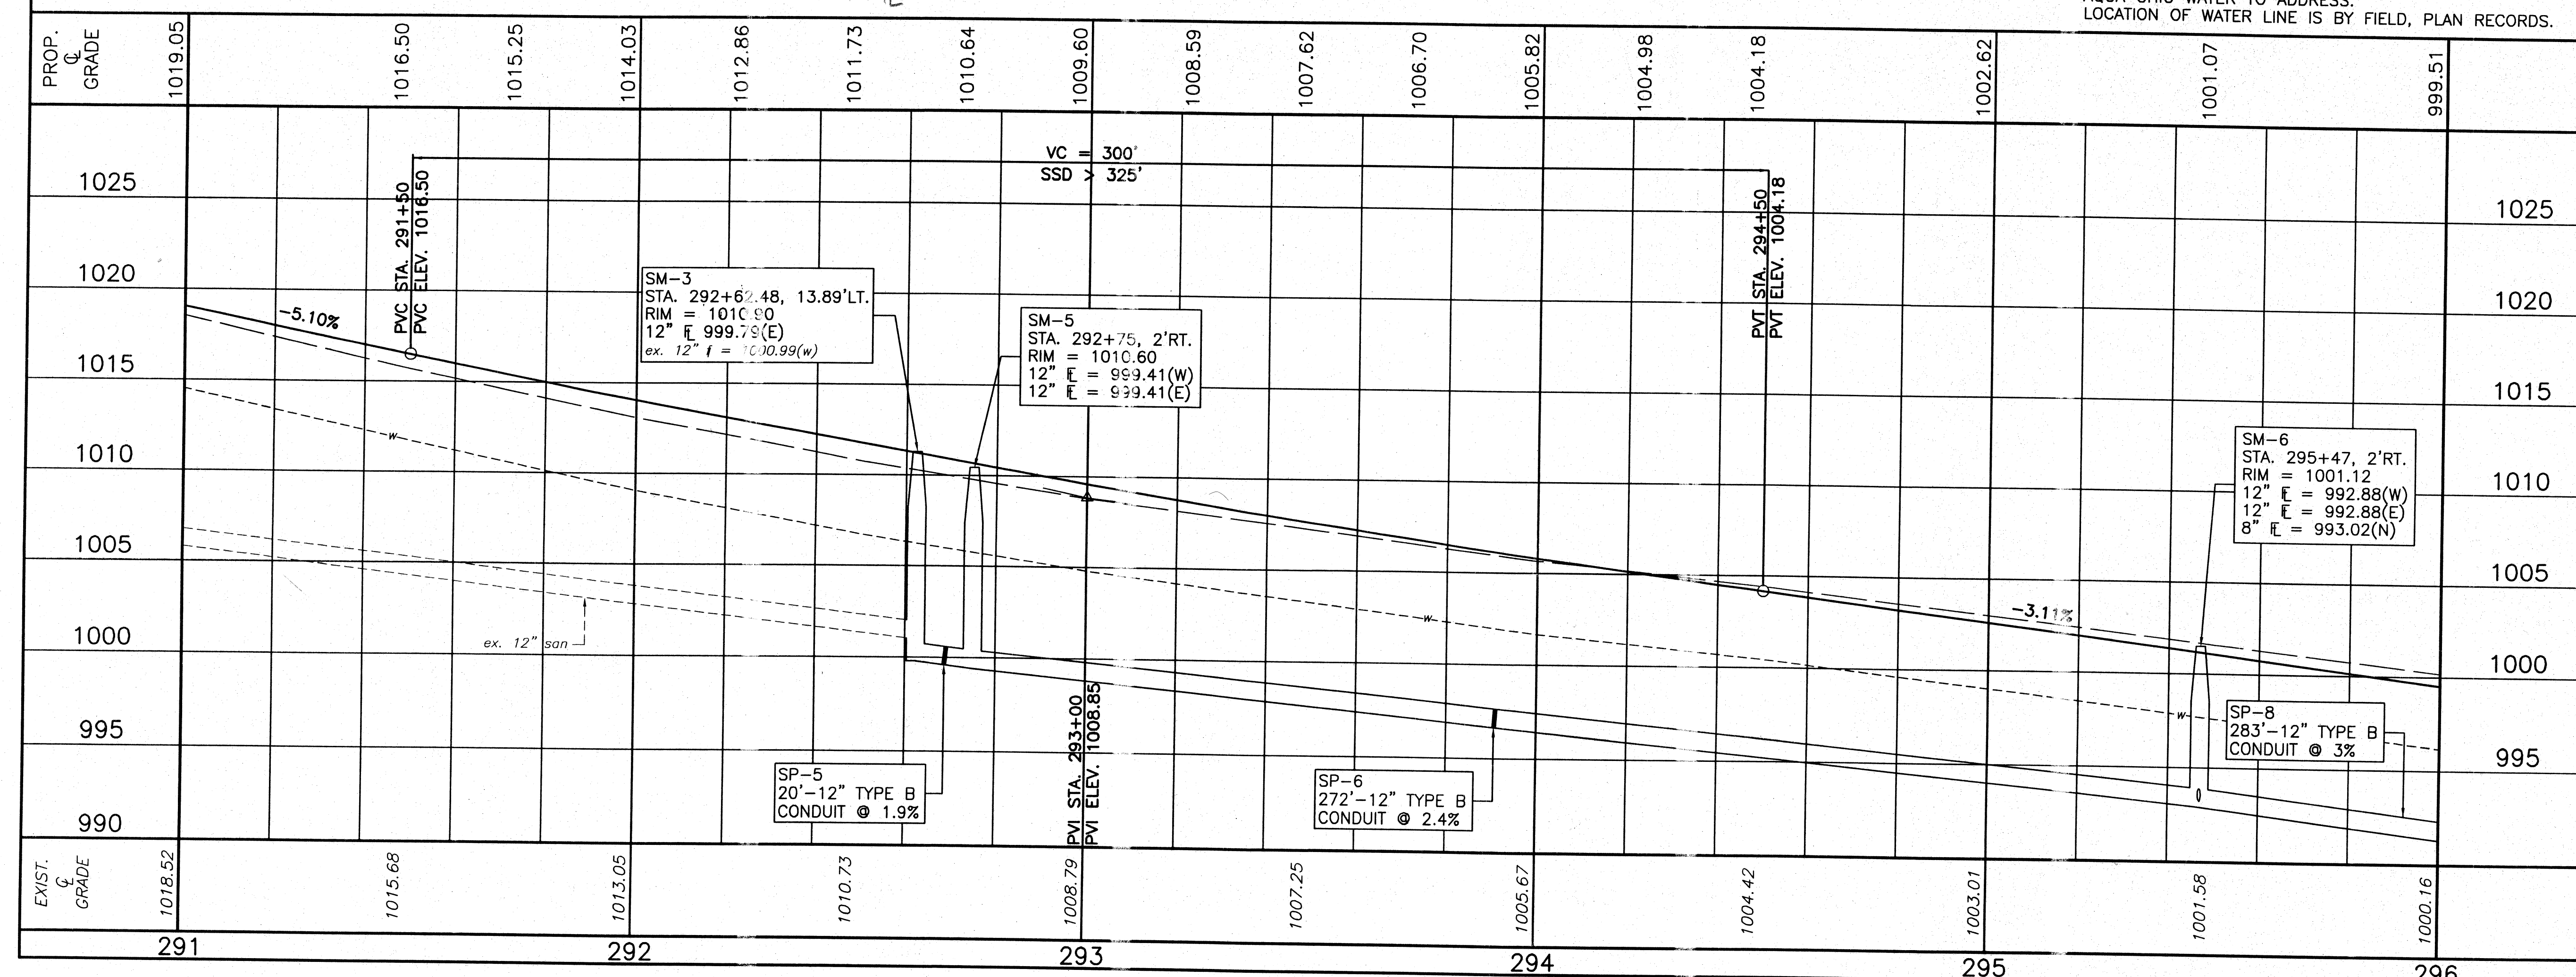

NOTES

FOR EXISTING AND PROPOSED DRAINAGE SYSTEM SEE DRAINAGE DETAILS SHT. NO. 82

ANY CONFLICTS OBSERVED IN FIELD BETWEEN WATER LINE AND SANITARY SEWERS SHALL BE THE RESPONSIBILITY OF AQUA OHIO WATER TO ADDRESS. LOCATION OF WATER LINE IS BY FIELD, PLAN RECORDS.

Lincoln Way West Rehabilitation
Plan and Profile Sta. 291+00 to Sta. 296+00
City of Massillon
Stark County, Ohio



Francis H. Cicchinelli, Jr.
Massillon Means More!

REVISIONS:	
DATE	DESCRIPTION

FILE NAME: 02SS0228.DWG

ACCOUNT NUMBER: 02SS02

28
90

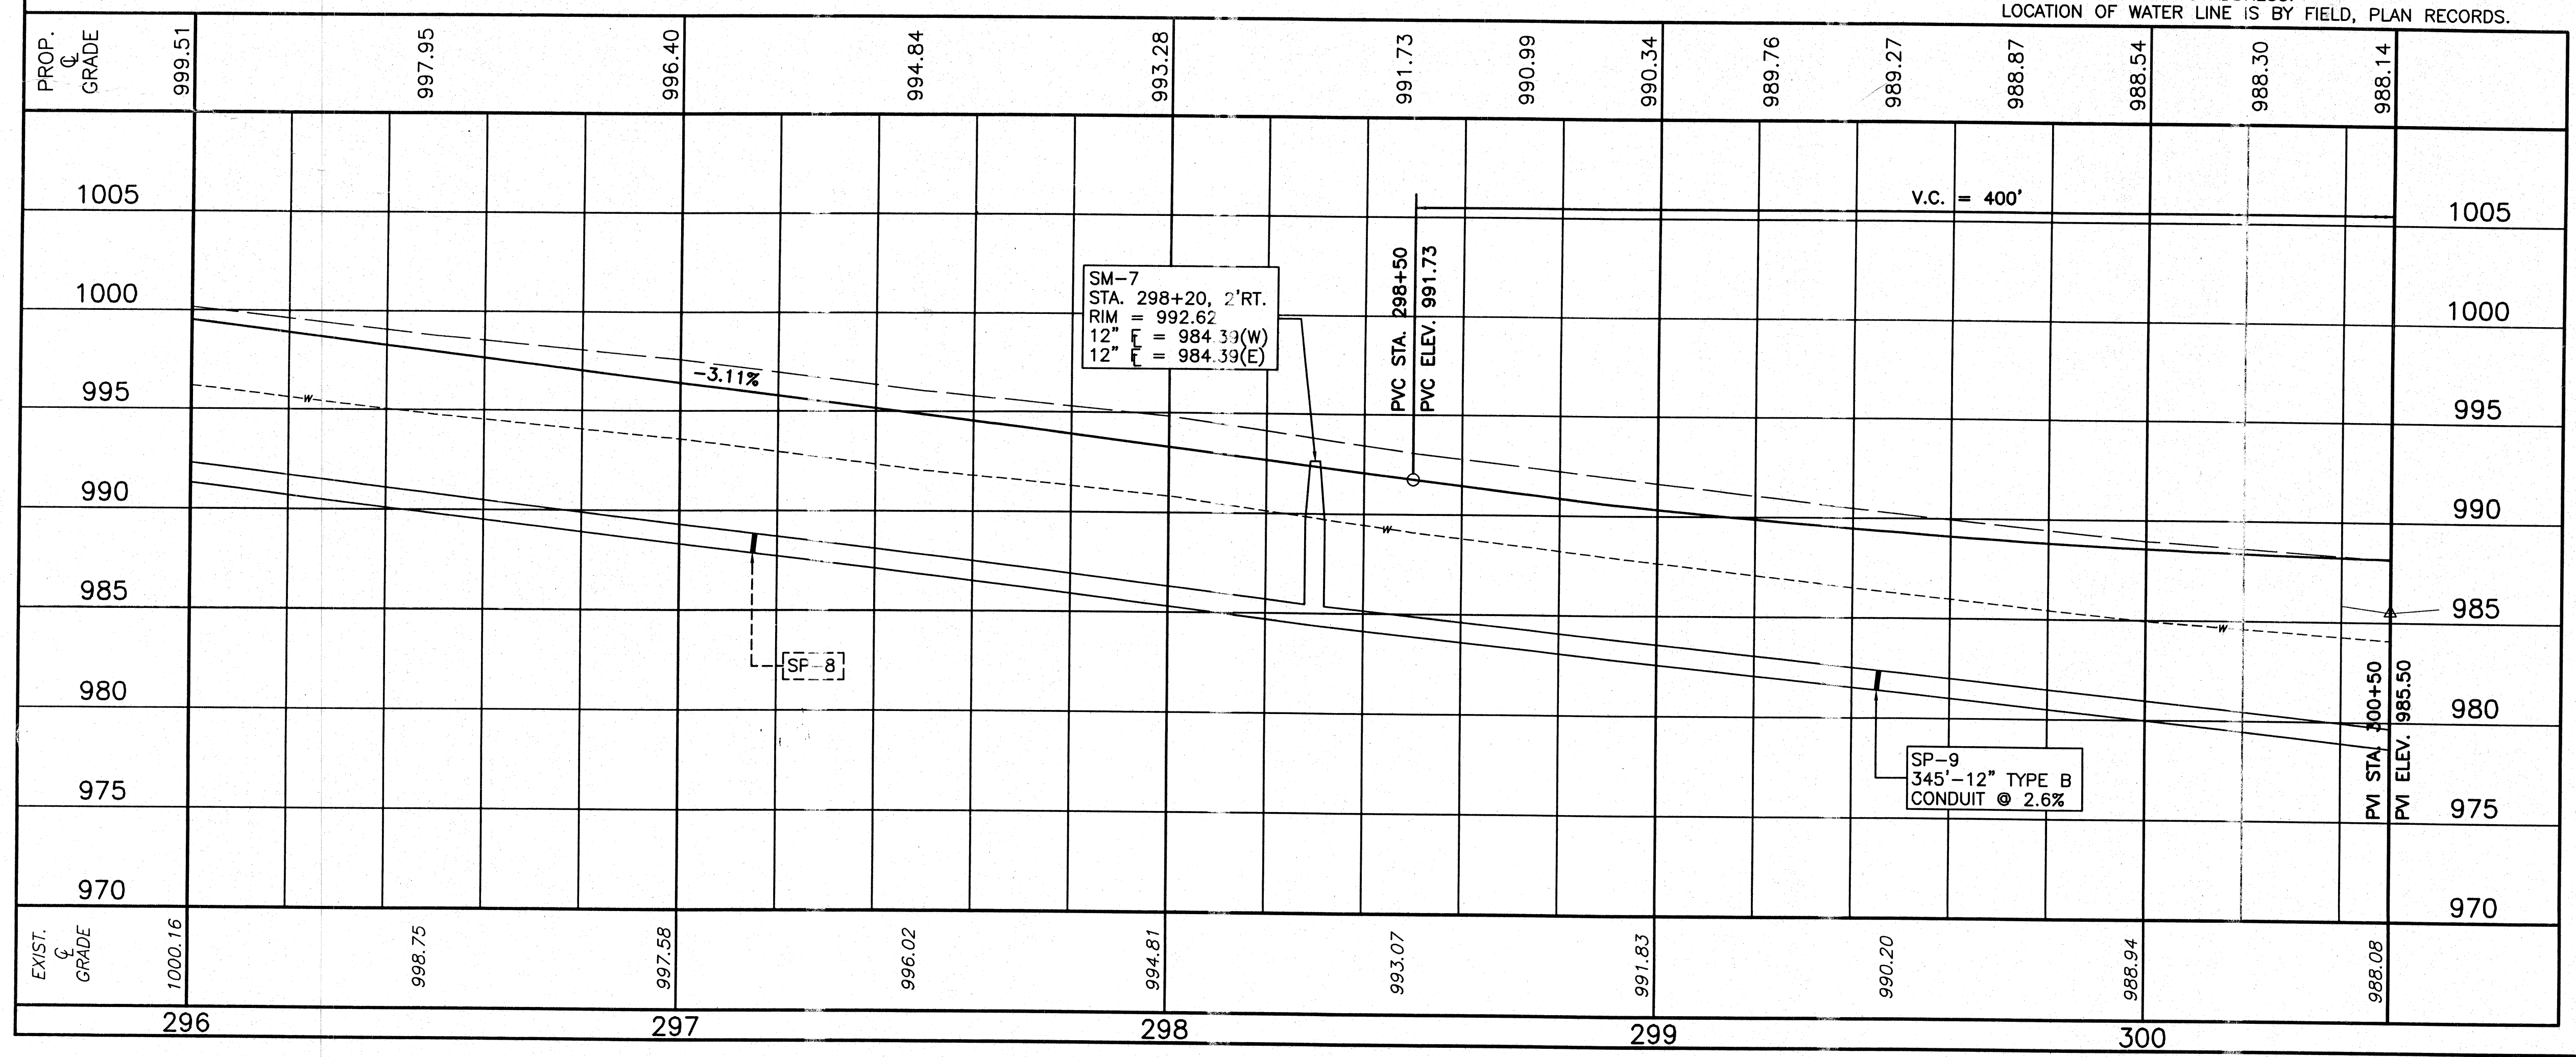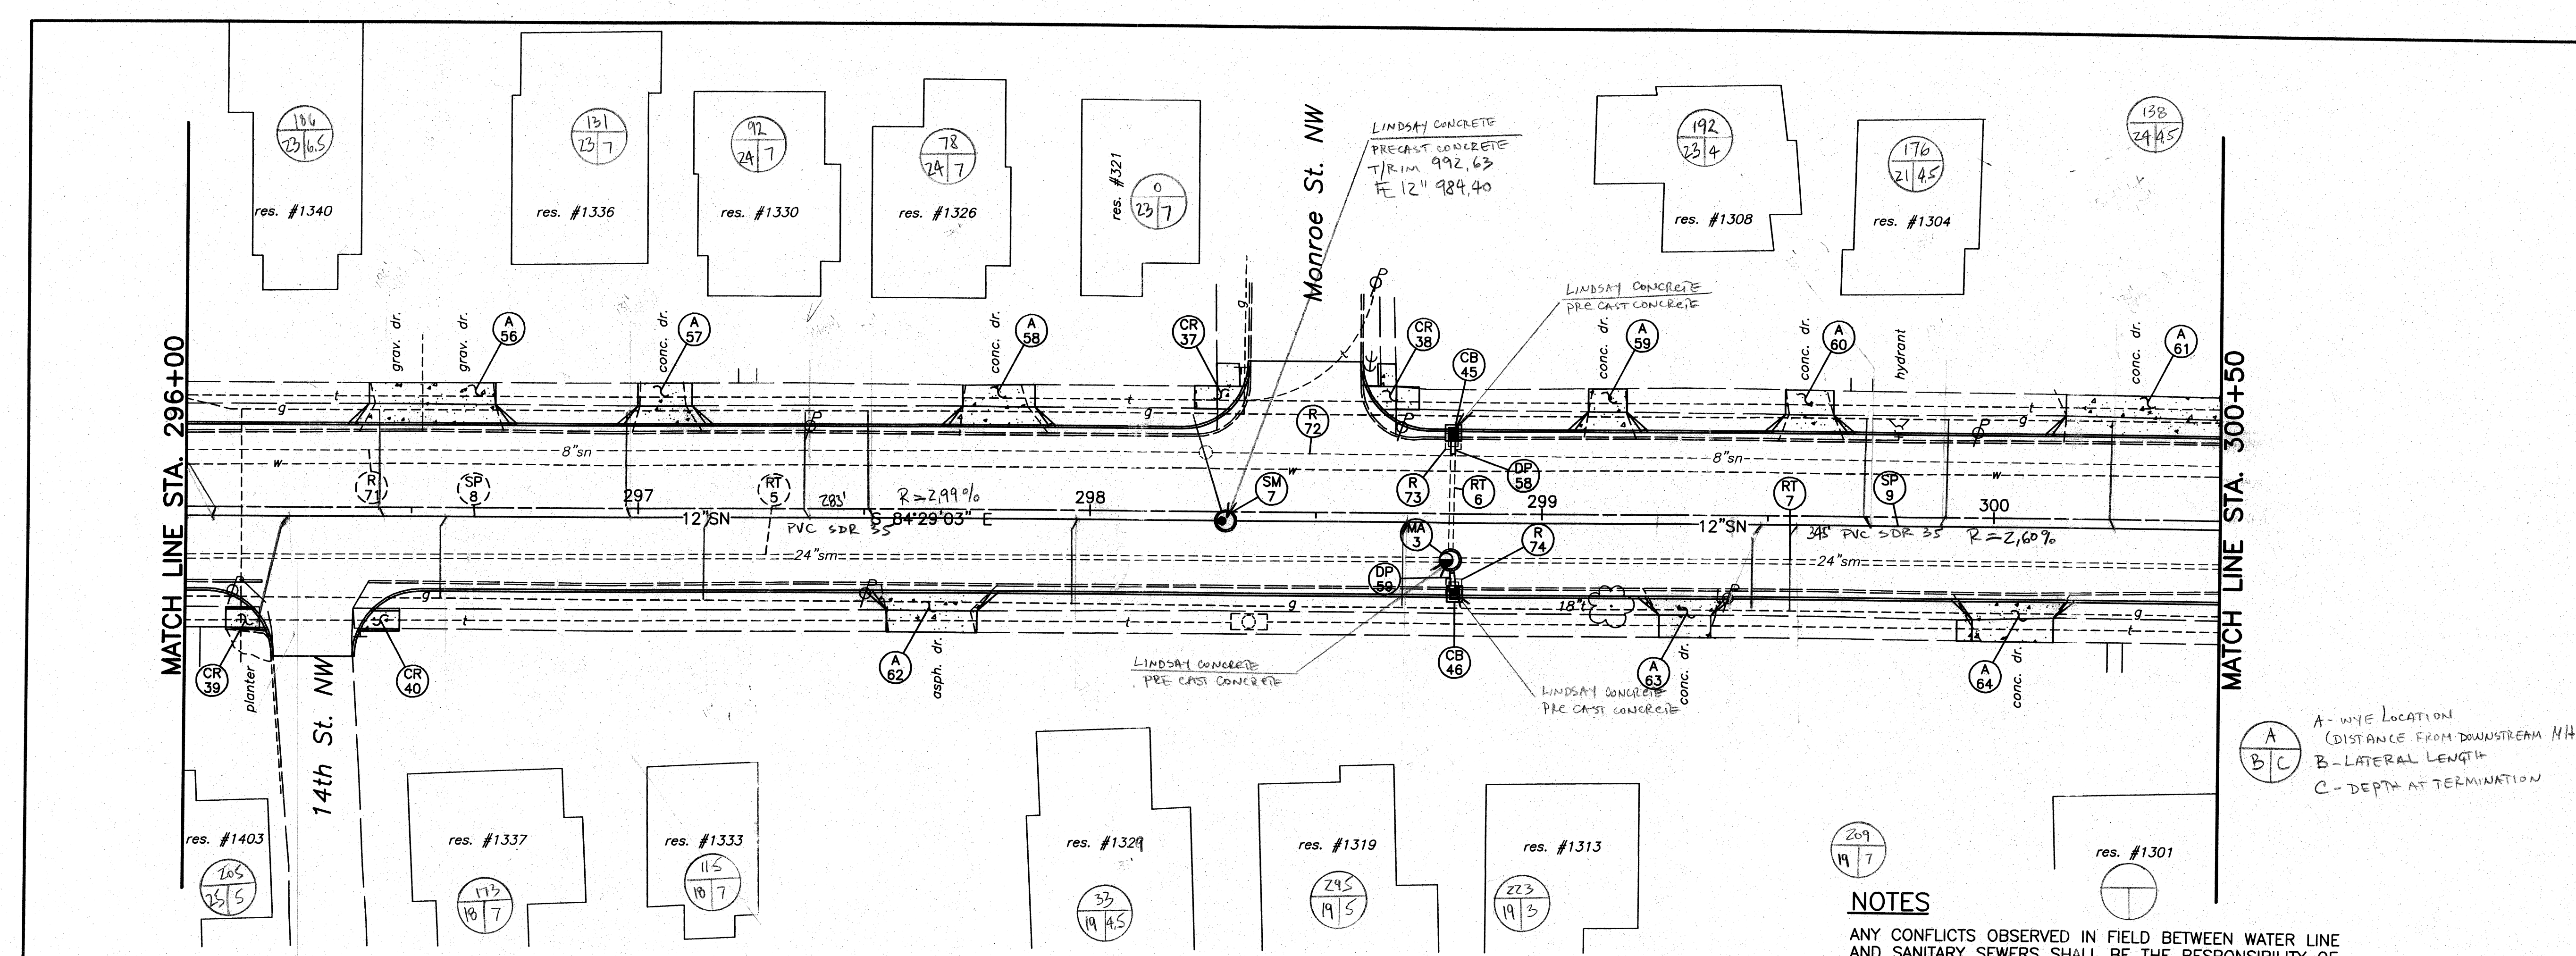

Lincoln Way West Rehabilitation

Plan and Profile Sta. 296+00 to Sta. 300+50

City of Massillon
Stark County, Ohio

Francis H. Cicchinelli, Jr.

Massillon

Means More!

REVISIONS:



DATE	DESCRIPTION

FILE NAME: 02SS0229.DWG

ACCOUNT NUMBER: 02SS02

29 / 90

29 / 90

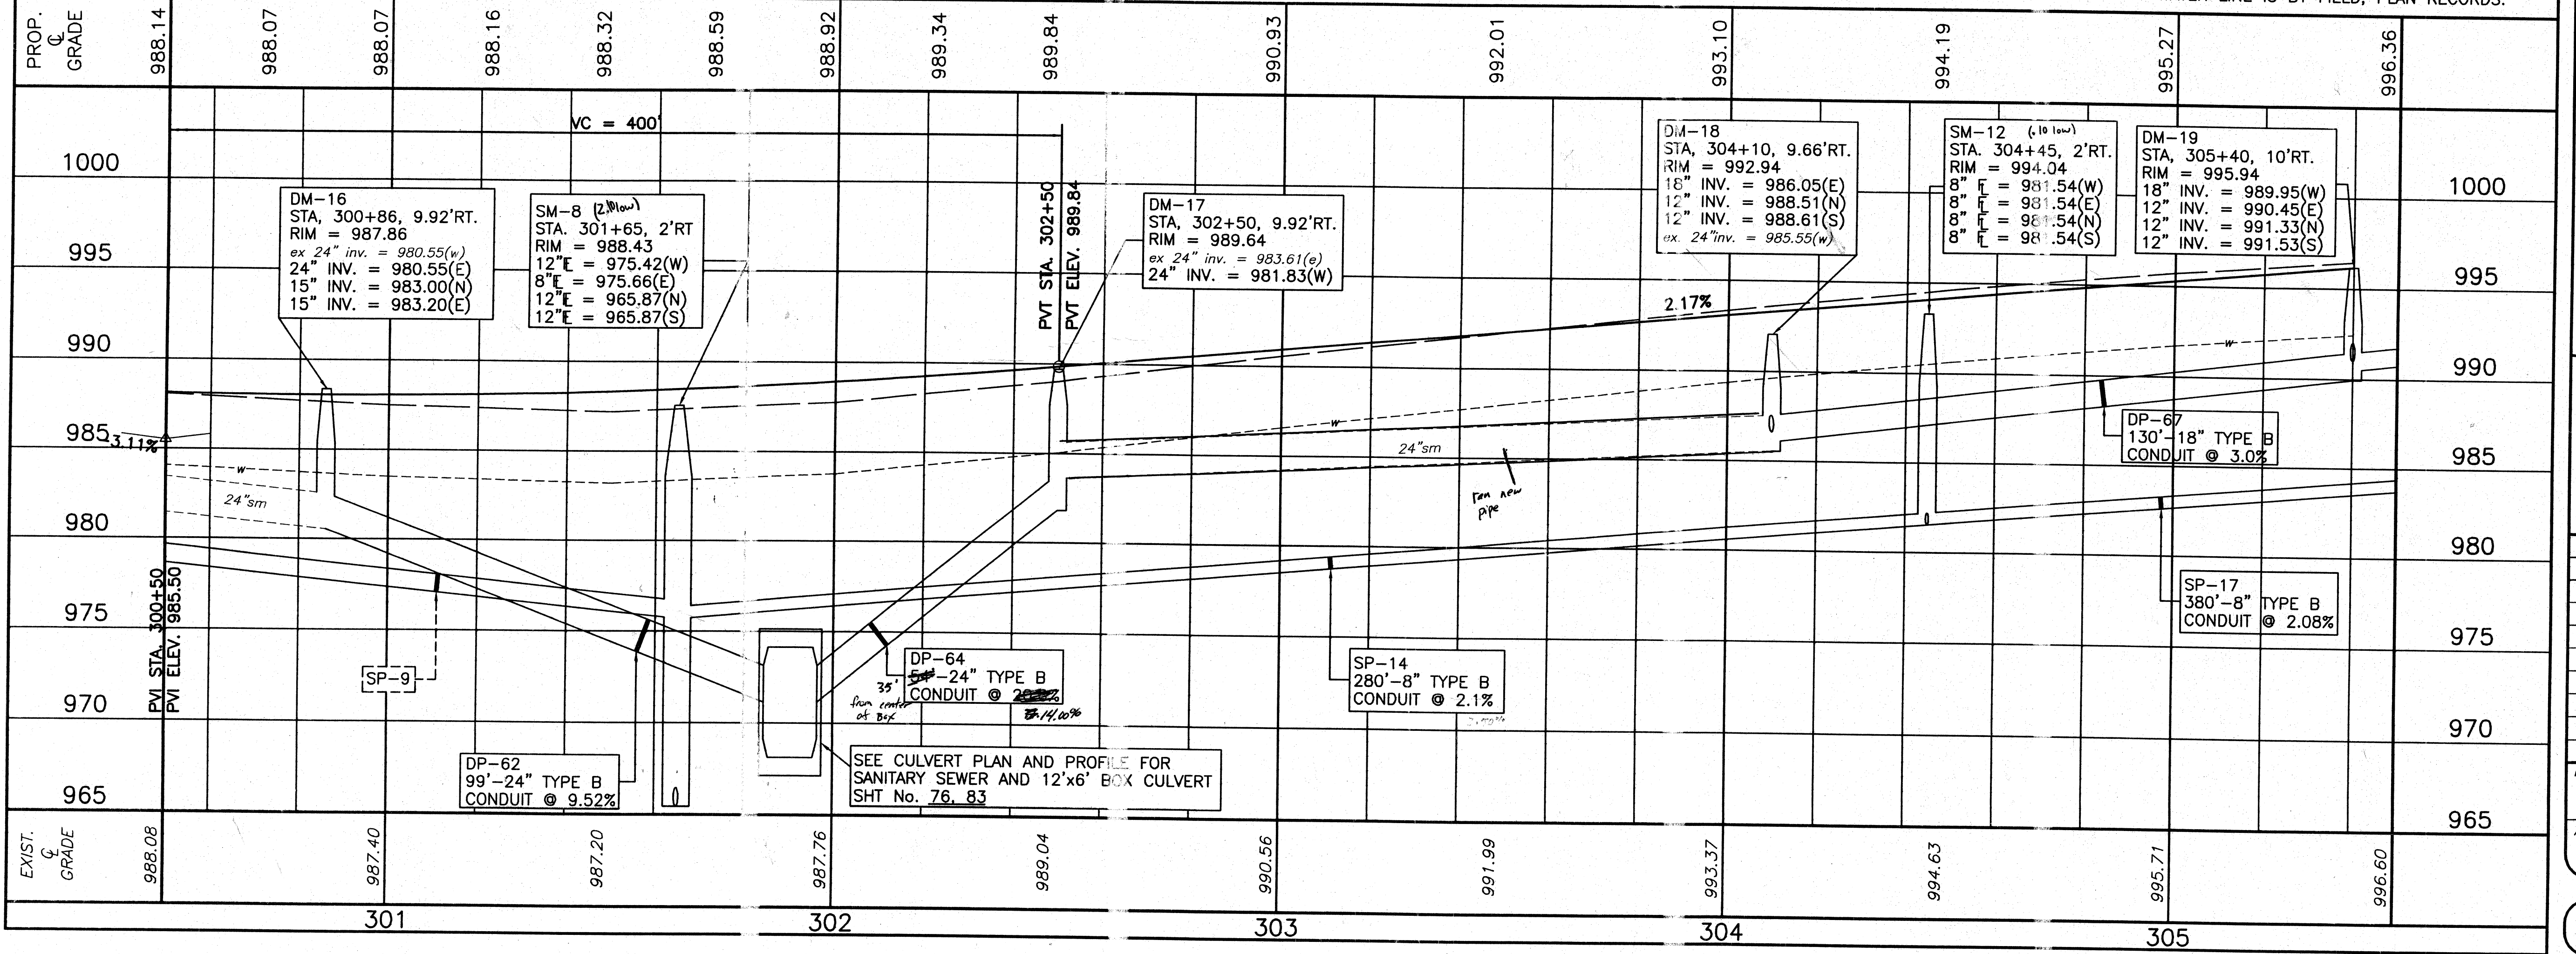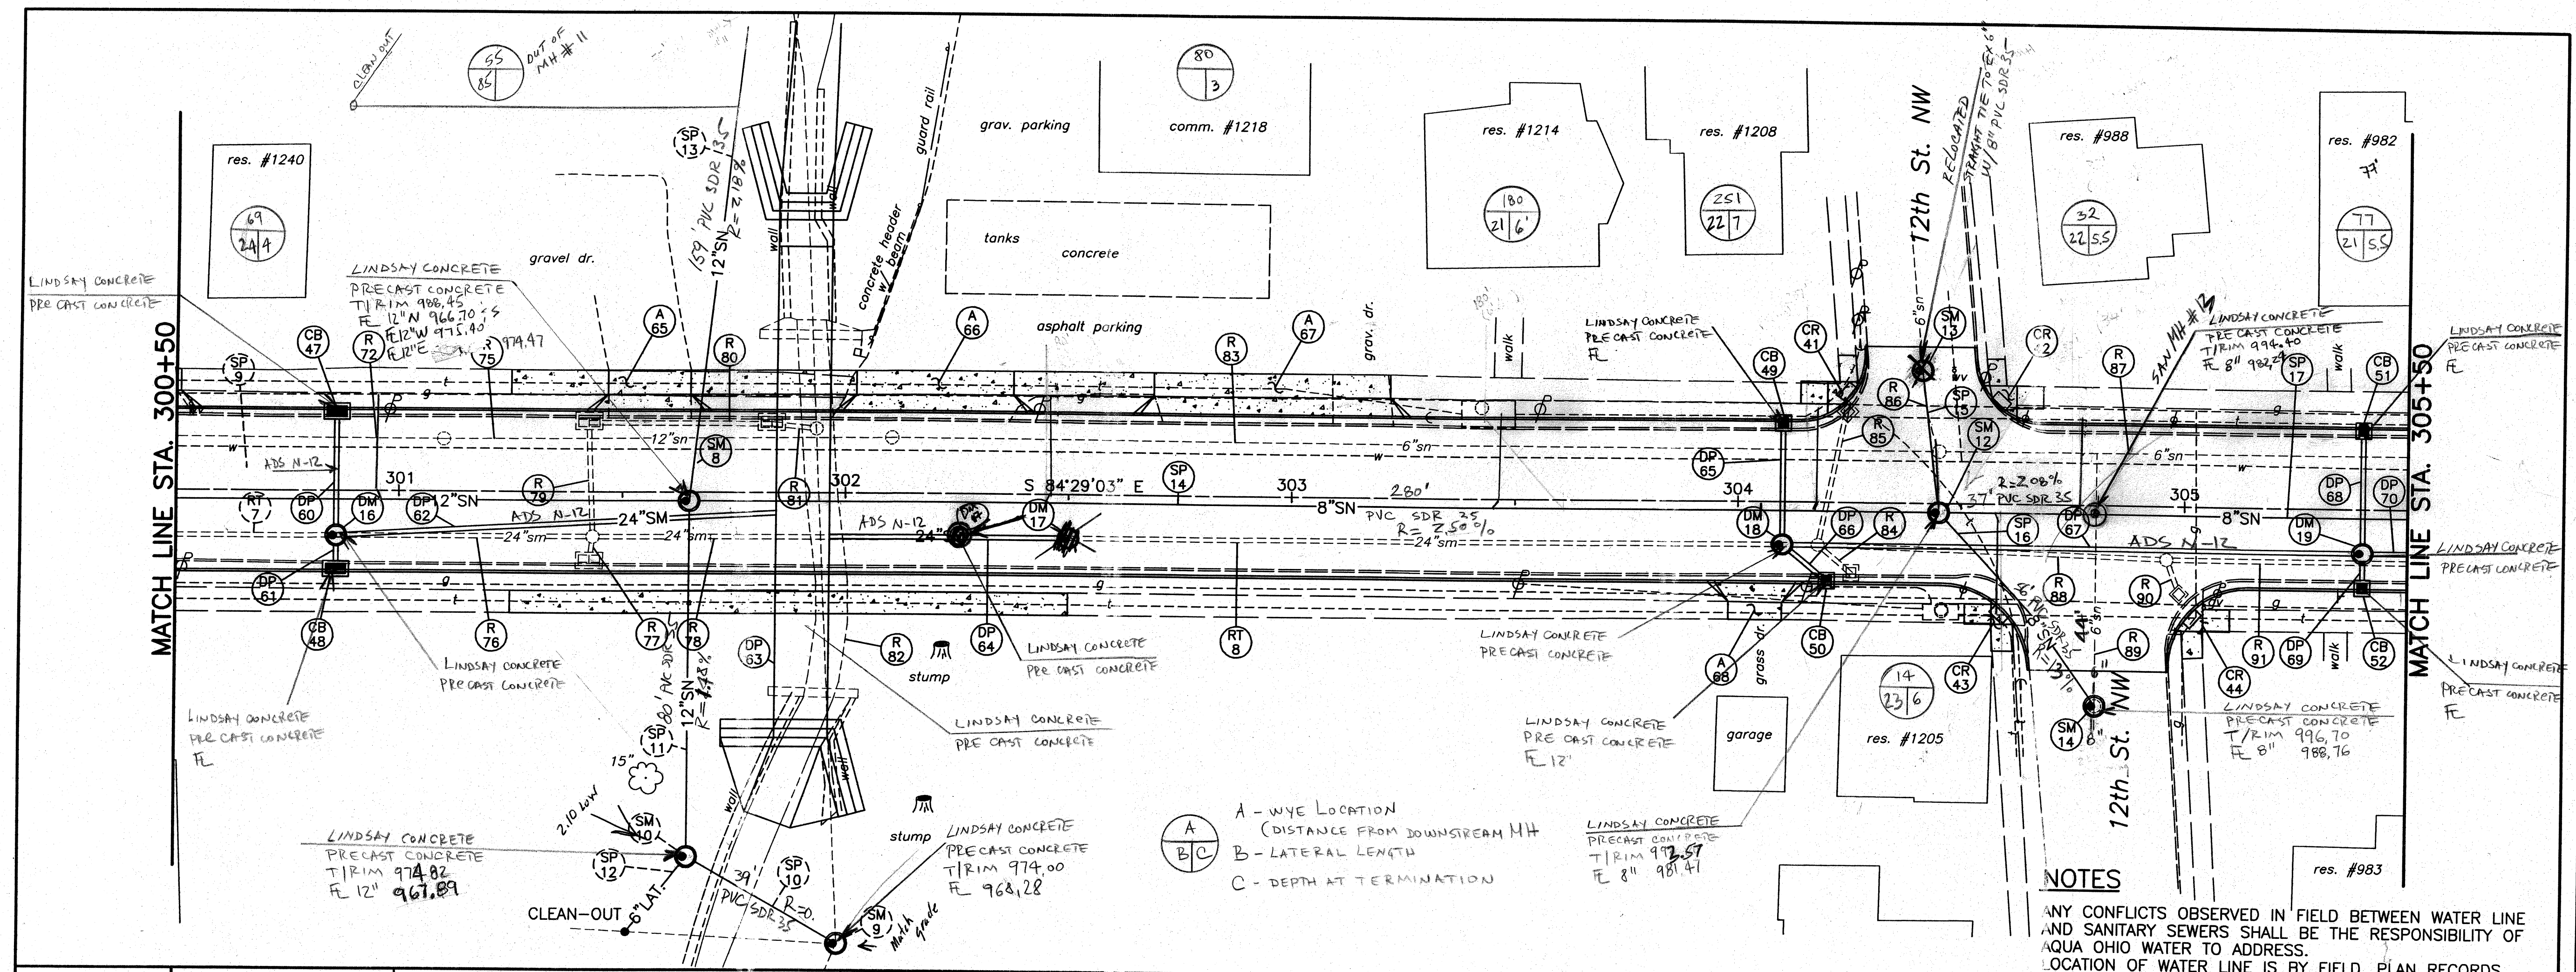

HORIZONTAL SCALE IN FEET

20 10 0 10 20

DRAWN BY: FPW

CHECKED BY: SDH

DATE: July, 2004

DATE: July, 2004

Lincoln Way West Rehabilitation

Plan and Profile Sta. 300+50 to Sta. 305+50

City of Massillon
Stark County, Ohio


Francis H. Cicchinelli, Jr.
Mayor

REVISIONS:	
DATE	DESCRIPTION

FILE NAME: 02SS0230.DWG


ACCOUNT NUMBER: 02SS02


30
90

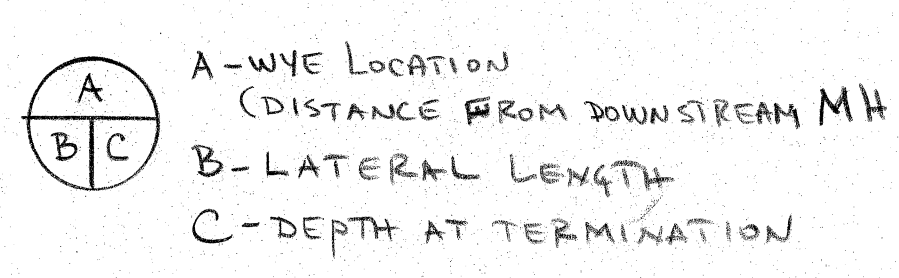

DRAWN BY: FPW	CHECKED BY: SDH
DATE: July, 2004	DATE: Aug., 2004

Francis H. Cicchinelli, Jr. Mayor	
 Massillon <i>Means More!</i>	
REVISIONS:	
DATE	DESCRIPTION
FILE NAME: 02SS0231.DWG	
ACCOUNT NUMBER 02SS02	

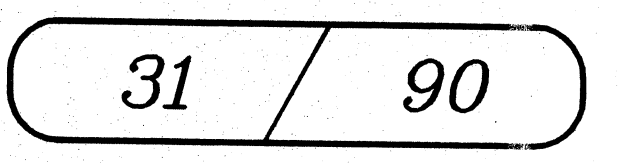

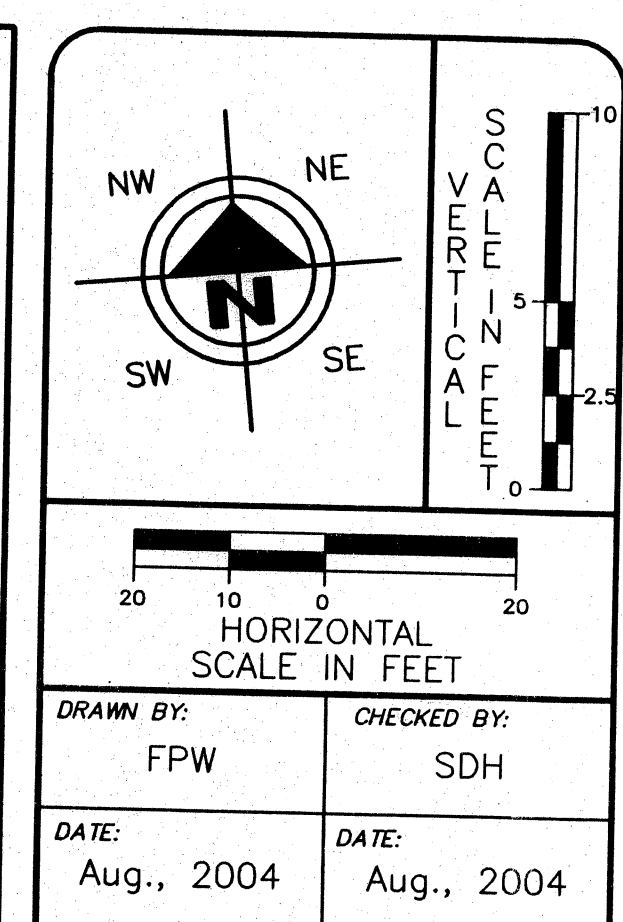

Francis H. Cicchinelli, Jr.
Mayor



REVISIONS:	
DATE	DESCRIPTION


FILE NAME: _____

02SS0232.DWG

ACCOUNT NUMBER _____

02SS02


32 / 90


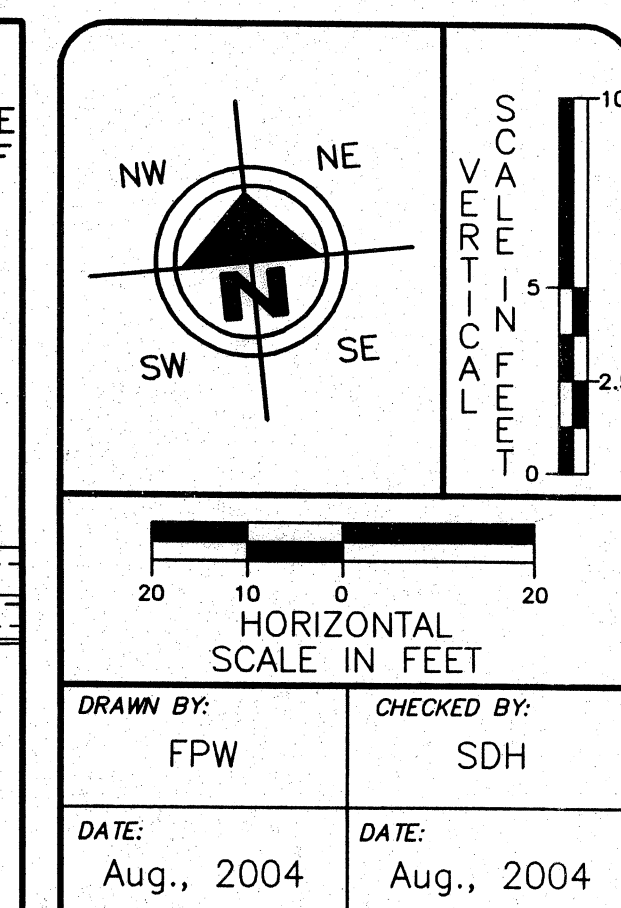


Francis H. Cicchinelli, Jr.
Mayor

Massillon
Means More!

REVISIONS:	
DATE	DESCRIPTION
FILE NAME:	
02SS0233.DWG	
ACCOUNT NUMBER	
02SS02	

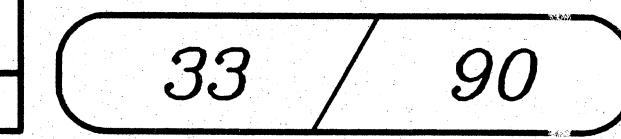

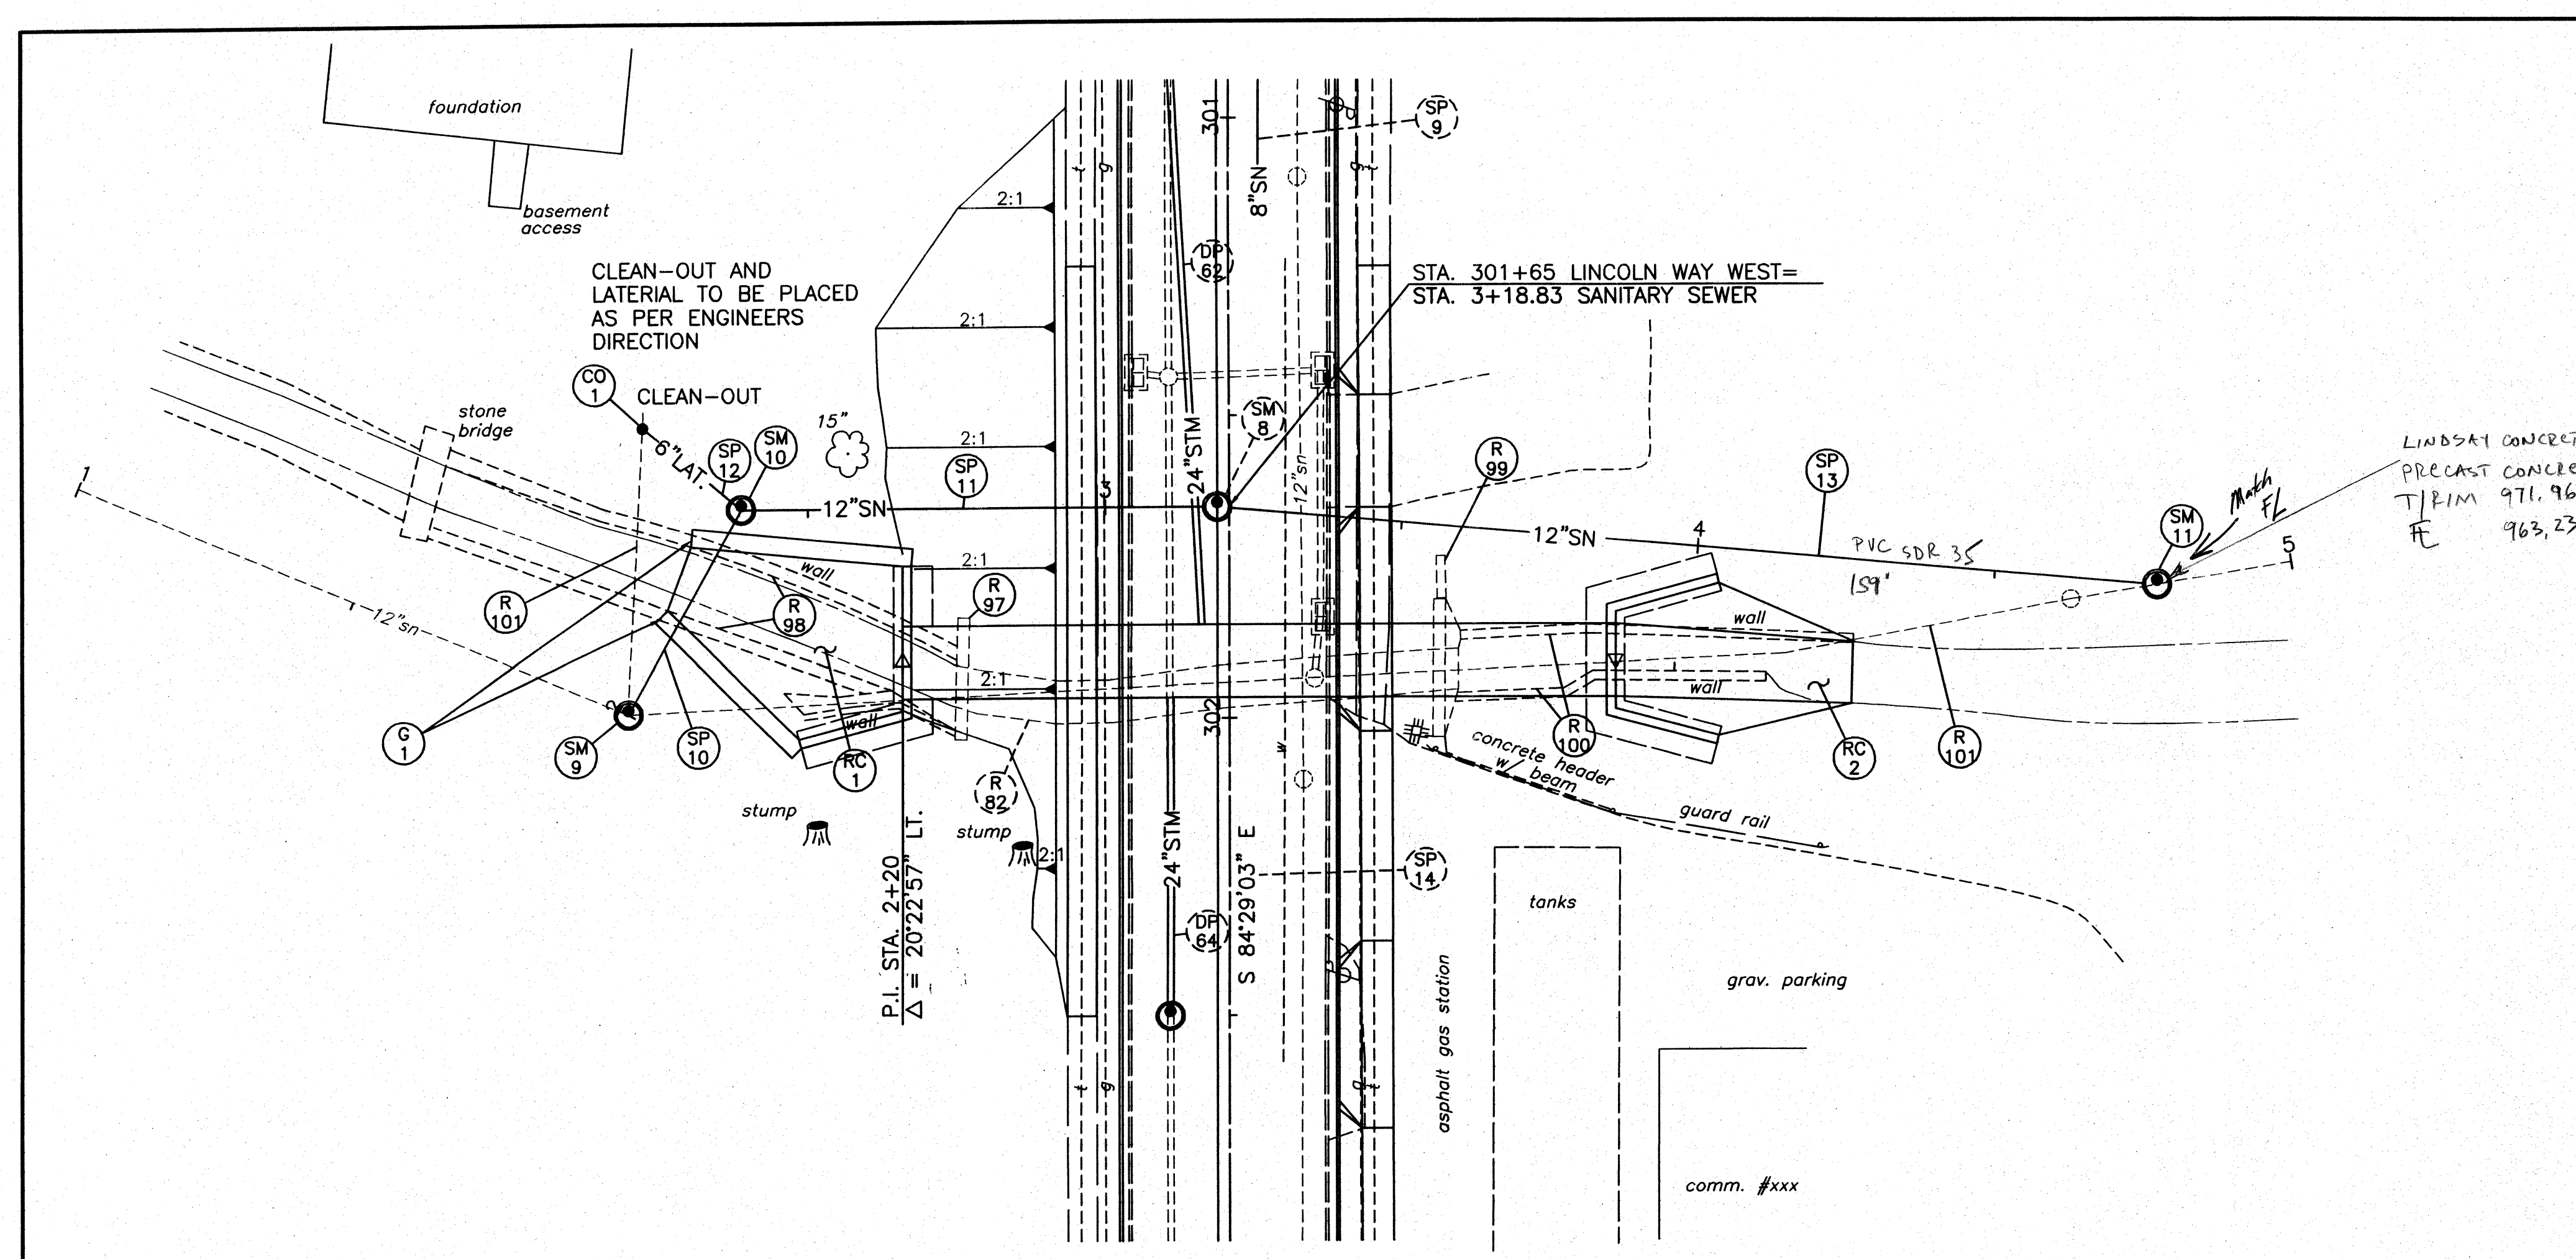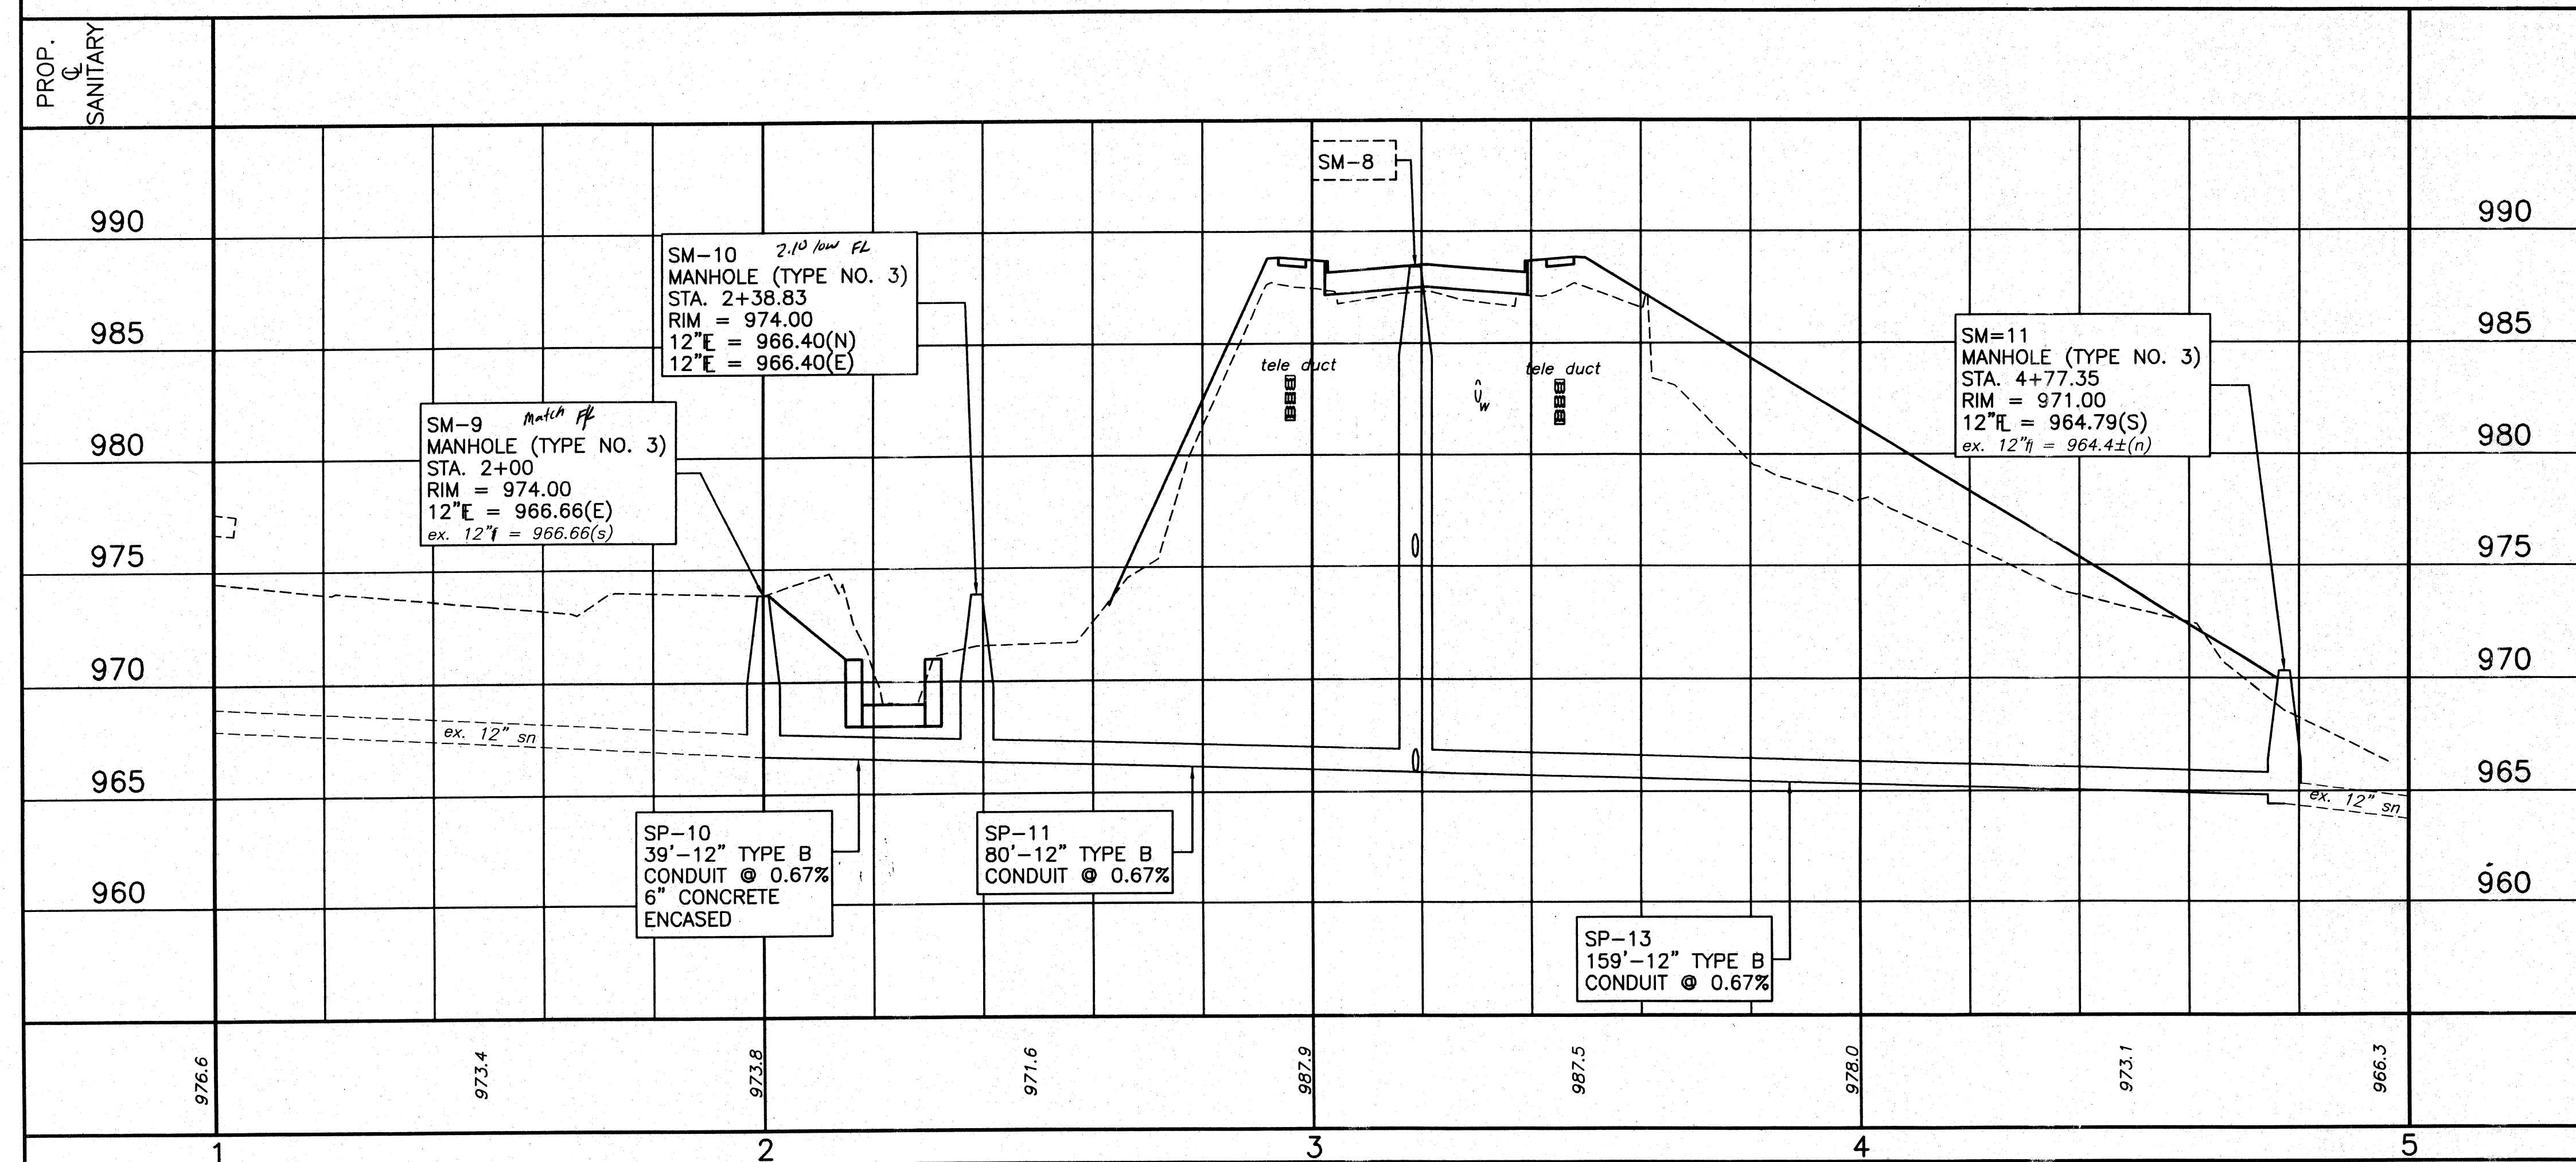

SCALE IN FEET
0 5 10

HORIZONTAL SCALE IN FEET
0 10 20

DRAWN BY: FPW

DATE: July, 2004

CHECKED BY: SDH

DATE: Aug., 2004

Lincoln Way West Rehabilitation

Sanitary Plan and Profile Sta. 1+00 to Sta. 5+00
City of Massillon
Stark County, Ohio

Francis H. Cicchinelli, Jr.
Mayor

MASSILLON
MEANS MORE!

REVISIONS:

DATE	DESCRIPTION

FILE NAME: 02SS0283.DWG

ACCOUNT NUMBER: 02SS02

83

90