


ANY INFORMATION OR DATA ON THIS DRAWING IS NOT INTENDED TO BE SUITABLE FOR REUSE BY ANY PERSON, FIRM OR CORPORATION OR ANY OTHERS ON EXTENSIONS OF THIS PROJECT OR FOR ANY USE OR ON ANY OTHER PROJECT. ANY REUSE WITHOUT WRITTEN VERIFICATION AND ADAPTATION BY THE ENGINEER, ARCHITECT OR SURVEYOR FOR THE SPECIFIC PURPOSE INTENDED WILL BE AT THE USER'S SOLE RISK AND WITHOUT LIABILITY OR LEGAL EXPOSURE TO THE ENGINEER, ARCHITECT OR SURVEYOR.




POGGE MEYER DESIGN GROUP, INC.
ARCHITECTS + ENGINEERS + PLANNERS

DATE	10/9/92
BY	CPB
CHECKED	
APPROVED	
REVISIONS	

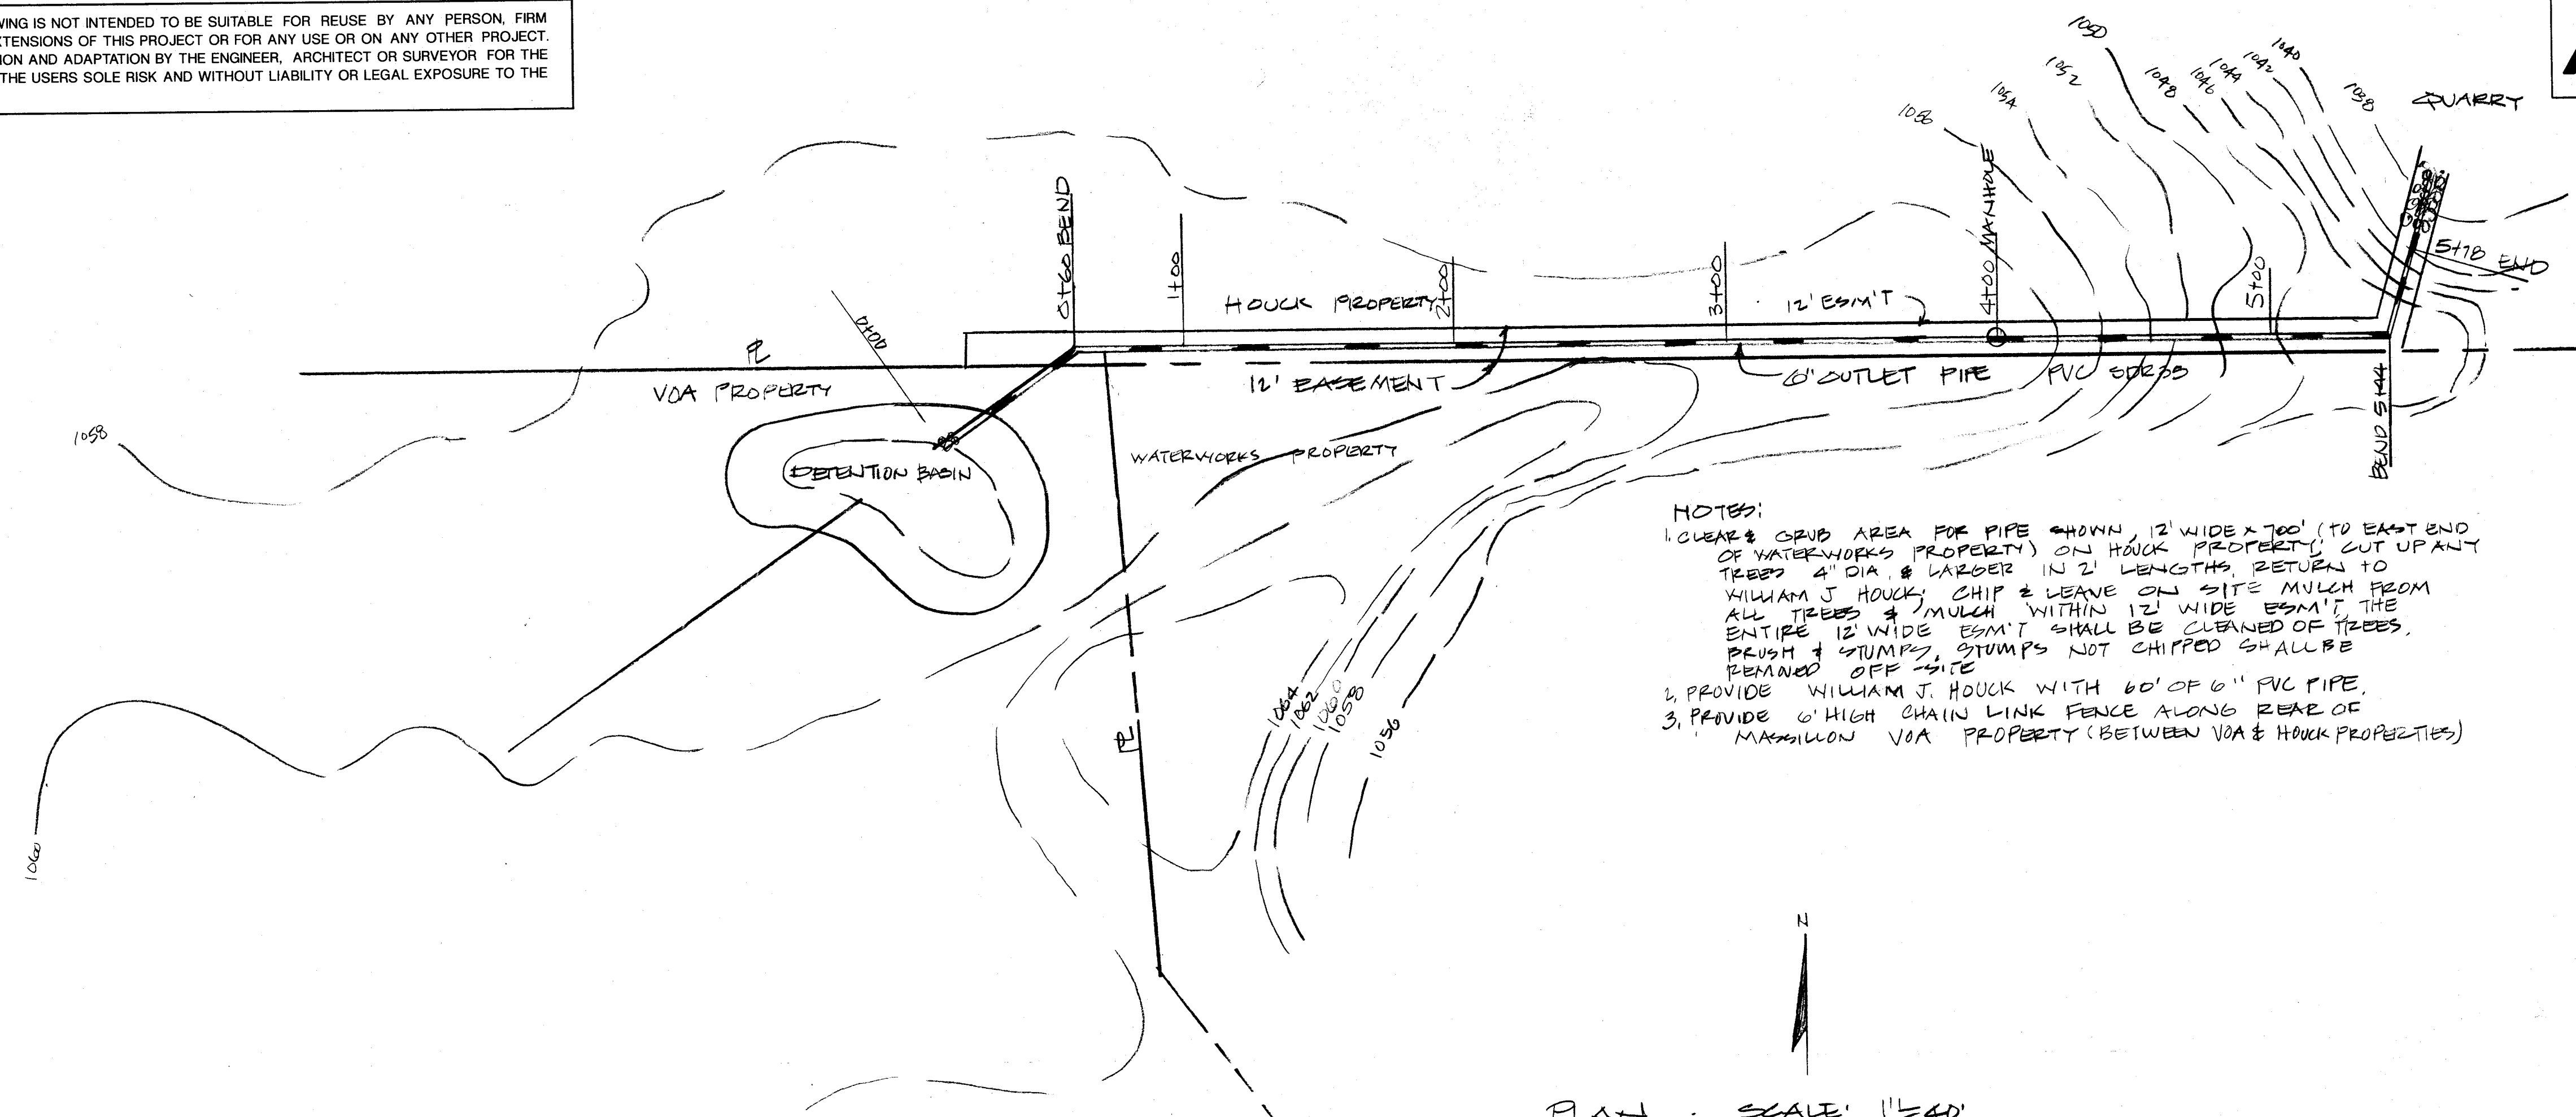

- NOTES:
1. CLEAR & GRUB AREA FOR PIPE SHOWN, 12' WIDE X 700' (TO EAST END OF WATERWORKS PROPERTY) ON HOOK PROPERTY. CUT UP ANY TREES 4" DIA. & LARGER IN 2' LENGTHS, RETURN TO WILLIAM J. HOOK. CHIP & LEAVE ON SITE MULCH FROM ALL TREES & MULCH WITHIN 12' WIDE ESM'T. THE ENTIRE 12' WIDE ESM'T SHALL BE CLEANED OF TREES, BRUSH & STUMPS. STUMPS NOT CHIPPED SHALL BE REMOVED OFF SITE.
 2. PROVIDE WILLIAM J. HOOK WITH 60' OF 6" PVC PIPE.
 3. PROVIDE 6' HIGH CHAIN LINK FENCE ALONG REAR OF MAXILLON VOA PROPERTY (BETWEEN VOA & HOOK PROPERTIES).

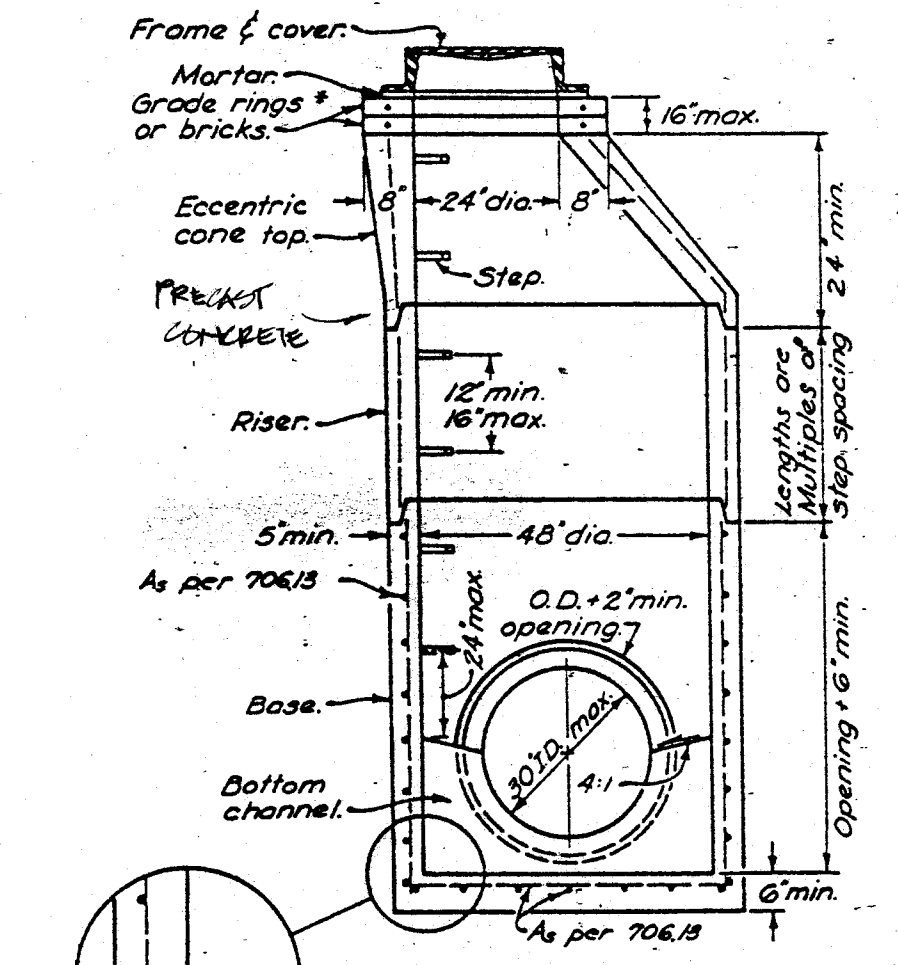


48" PRECAST BASE FOR 30" AND SMALLER PIPE
PRECAST MANHOLE


PLAN SCALE: 1"=40'

DATE	
BY	
FINAL SURVEY	
NO.	

DATE	
BY	
ORIGINAL SURVEY	
NO.	

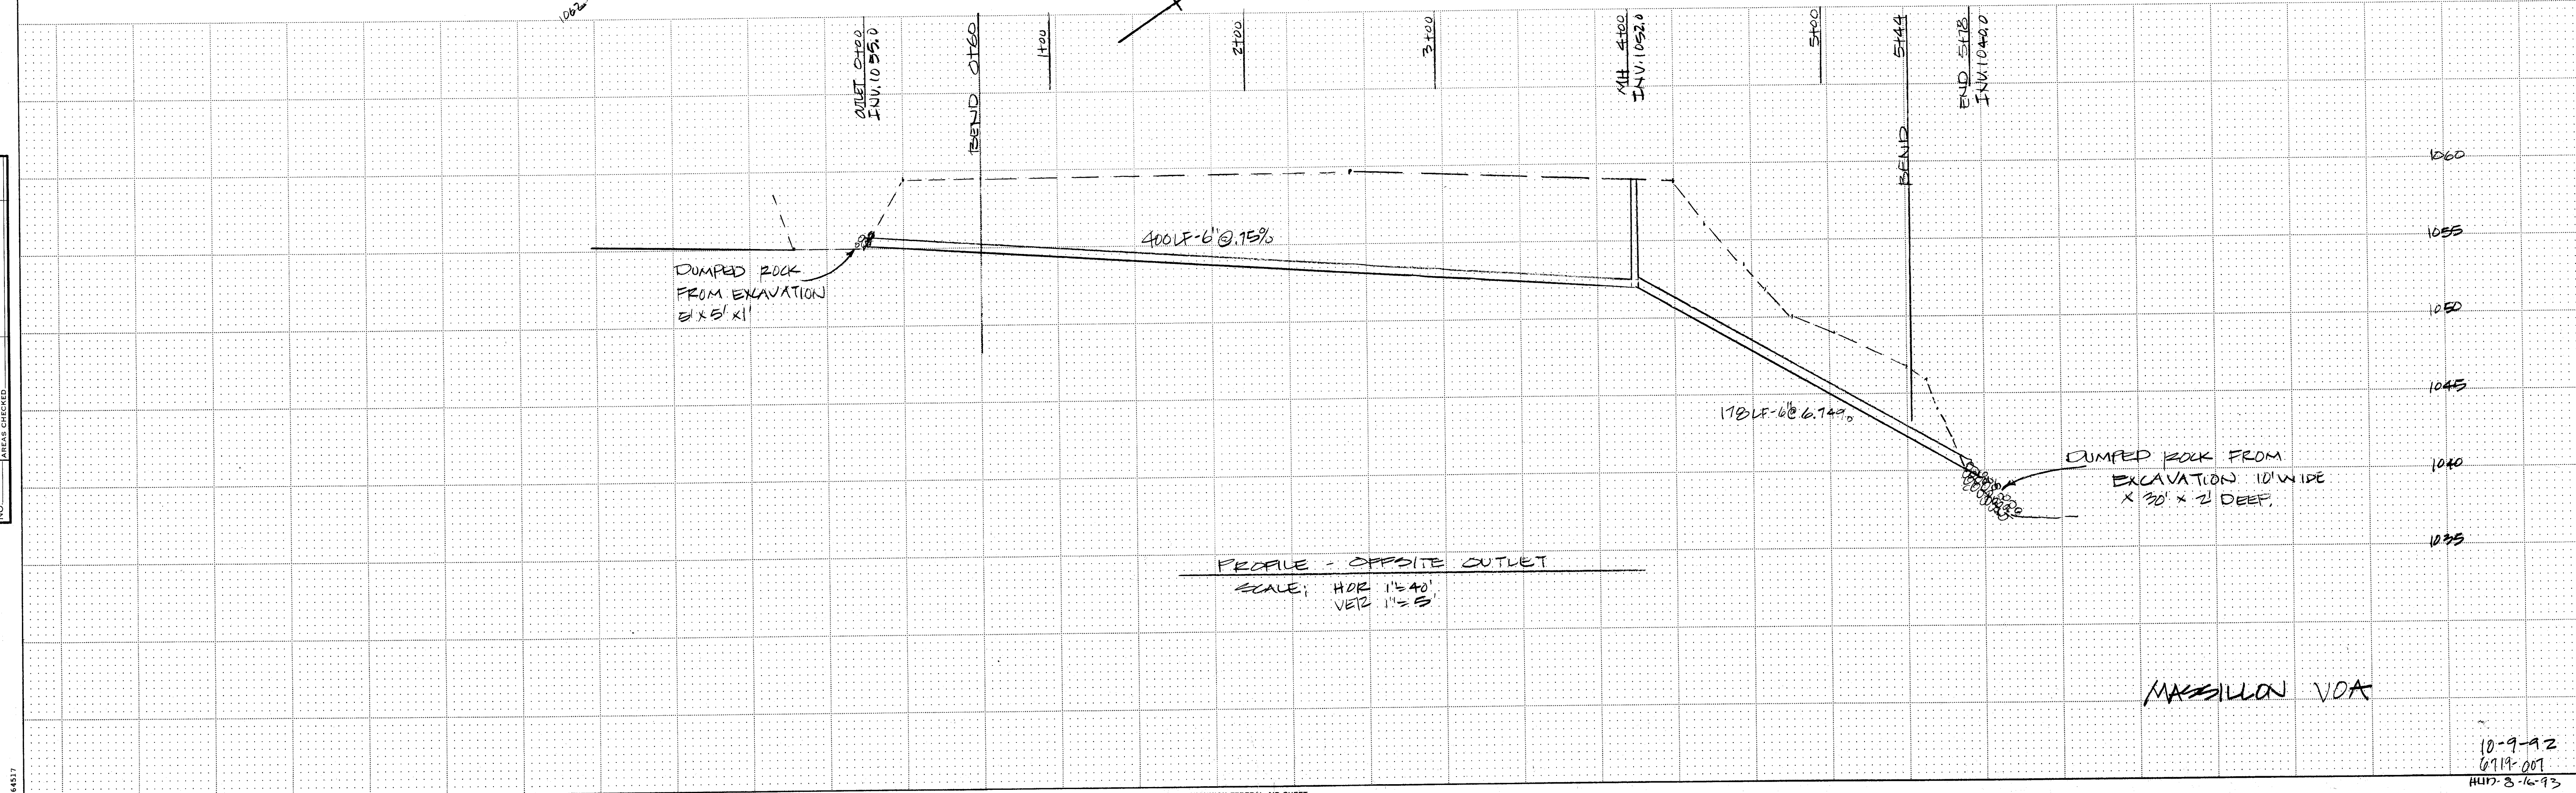


10-9-92
6719-001
HUT-8-16-93

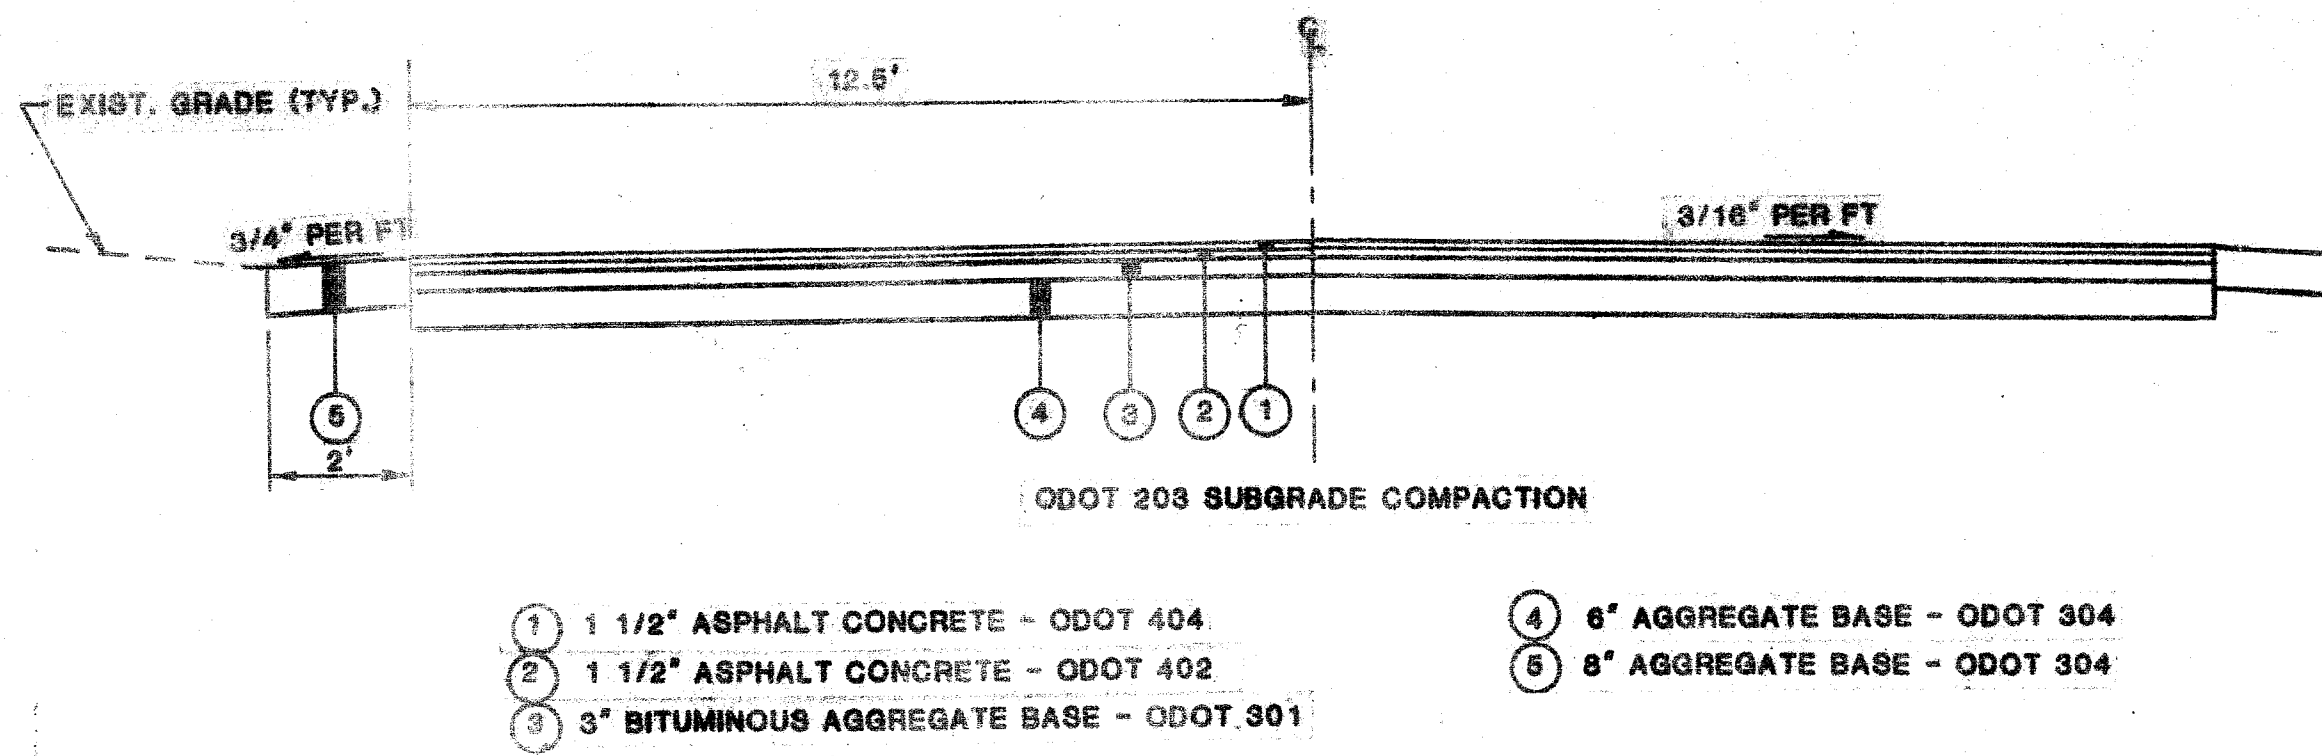


TYPICAL SECTION - ENTRANCE DRIVE DETAIL

SCALE: NONE

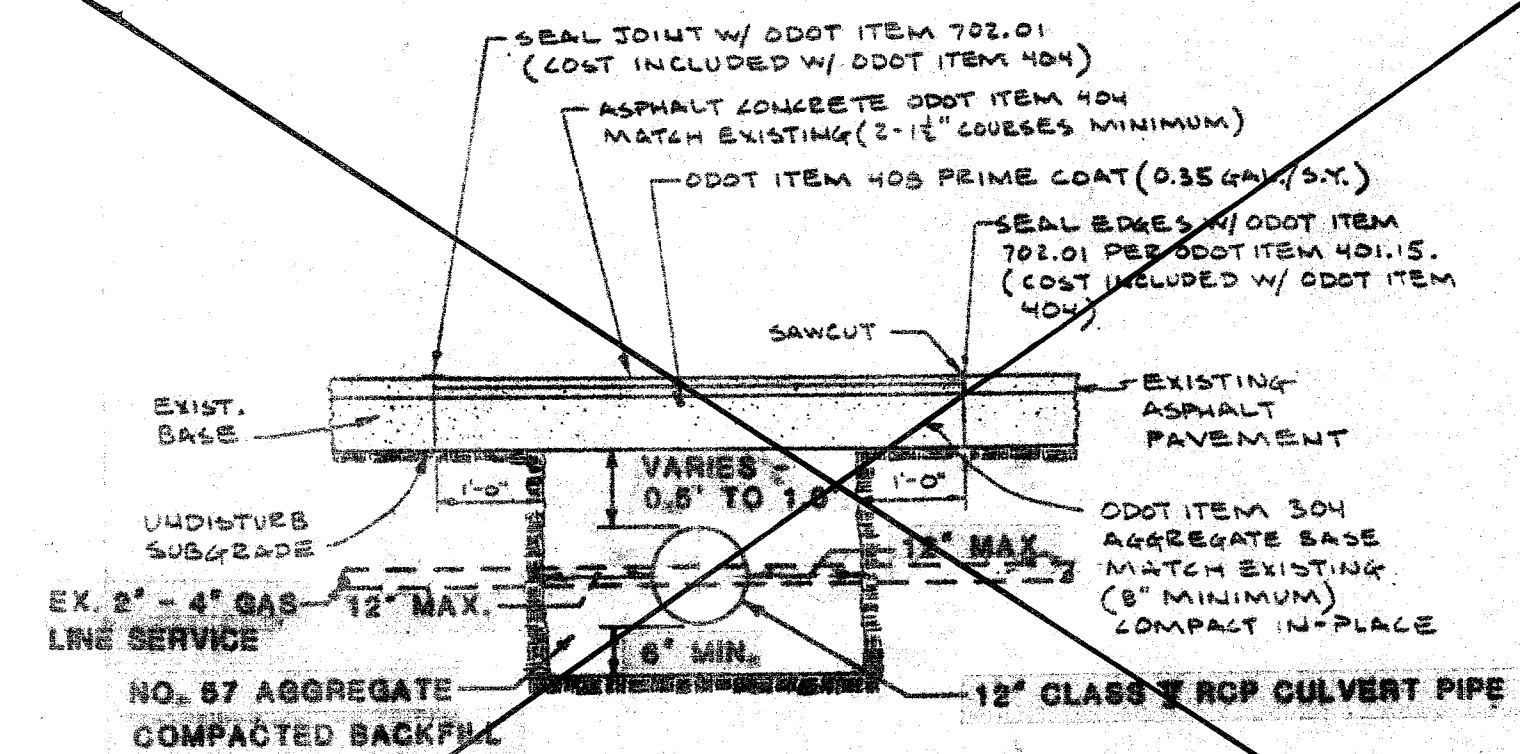

NOTE: THE EAST OHIO GAS COMPANY SHALL PROVIDE A GAS LINE LOWERING FOR THE SERVICE SHOWN ABOVE, AS NEEDED

NOTE: ALL CATCH BASINS SHALL BE ODOT NO. 2-2-B WITH THE SINUSOIDAL GRATE.


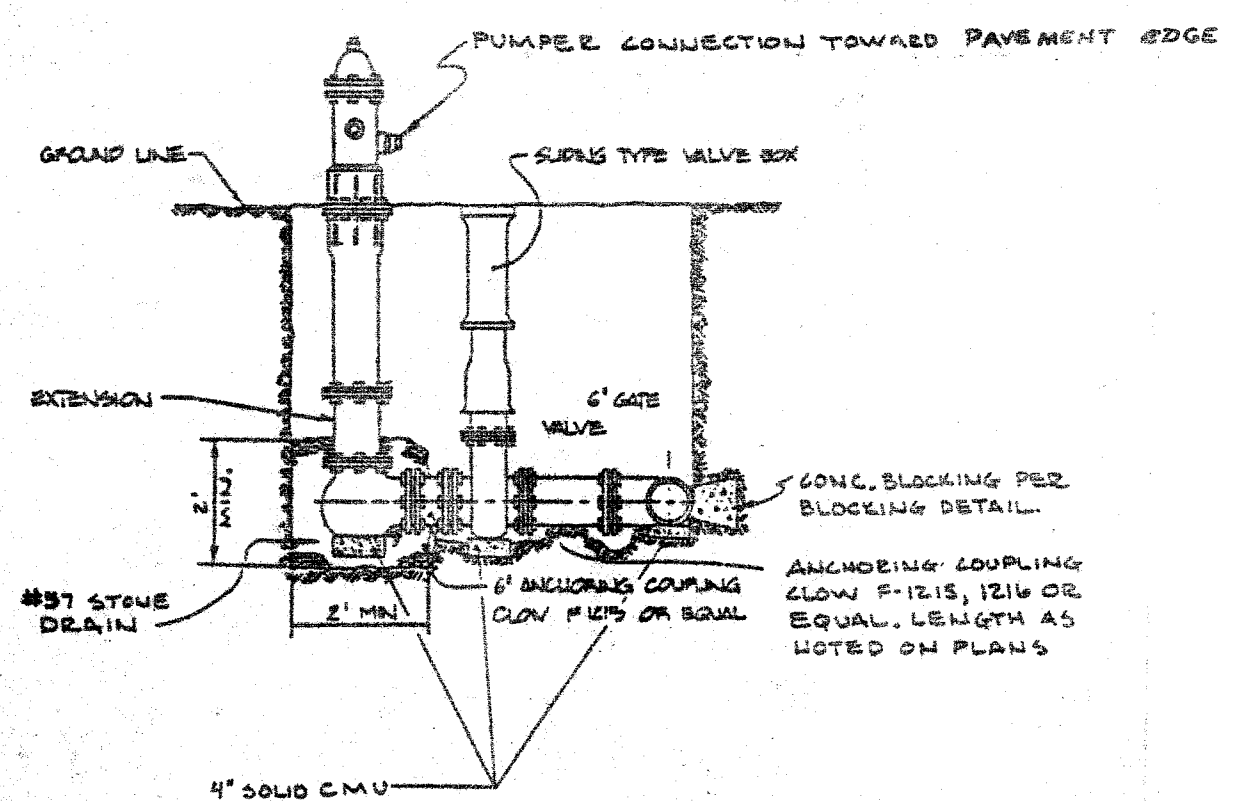


TYPICAL HYDRANT INSTALLATION PERPENDICULAR TO LINE

NEW TYPE 2-2-B C.B.
INV. 15' NW (EX) 412' SE (NEW) 1040.8
TIE EX. 15' CMP INTO NEW C.B.

OUTLET INVERT - 1040.5


B.M.
TOP BOLT @ 90' OF HYDRANT
S. SIDE CHERRY RD 90' SOUTH OF PROPERTY
ELEV. 1043.26

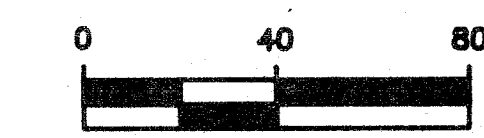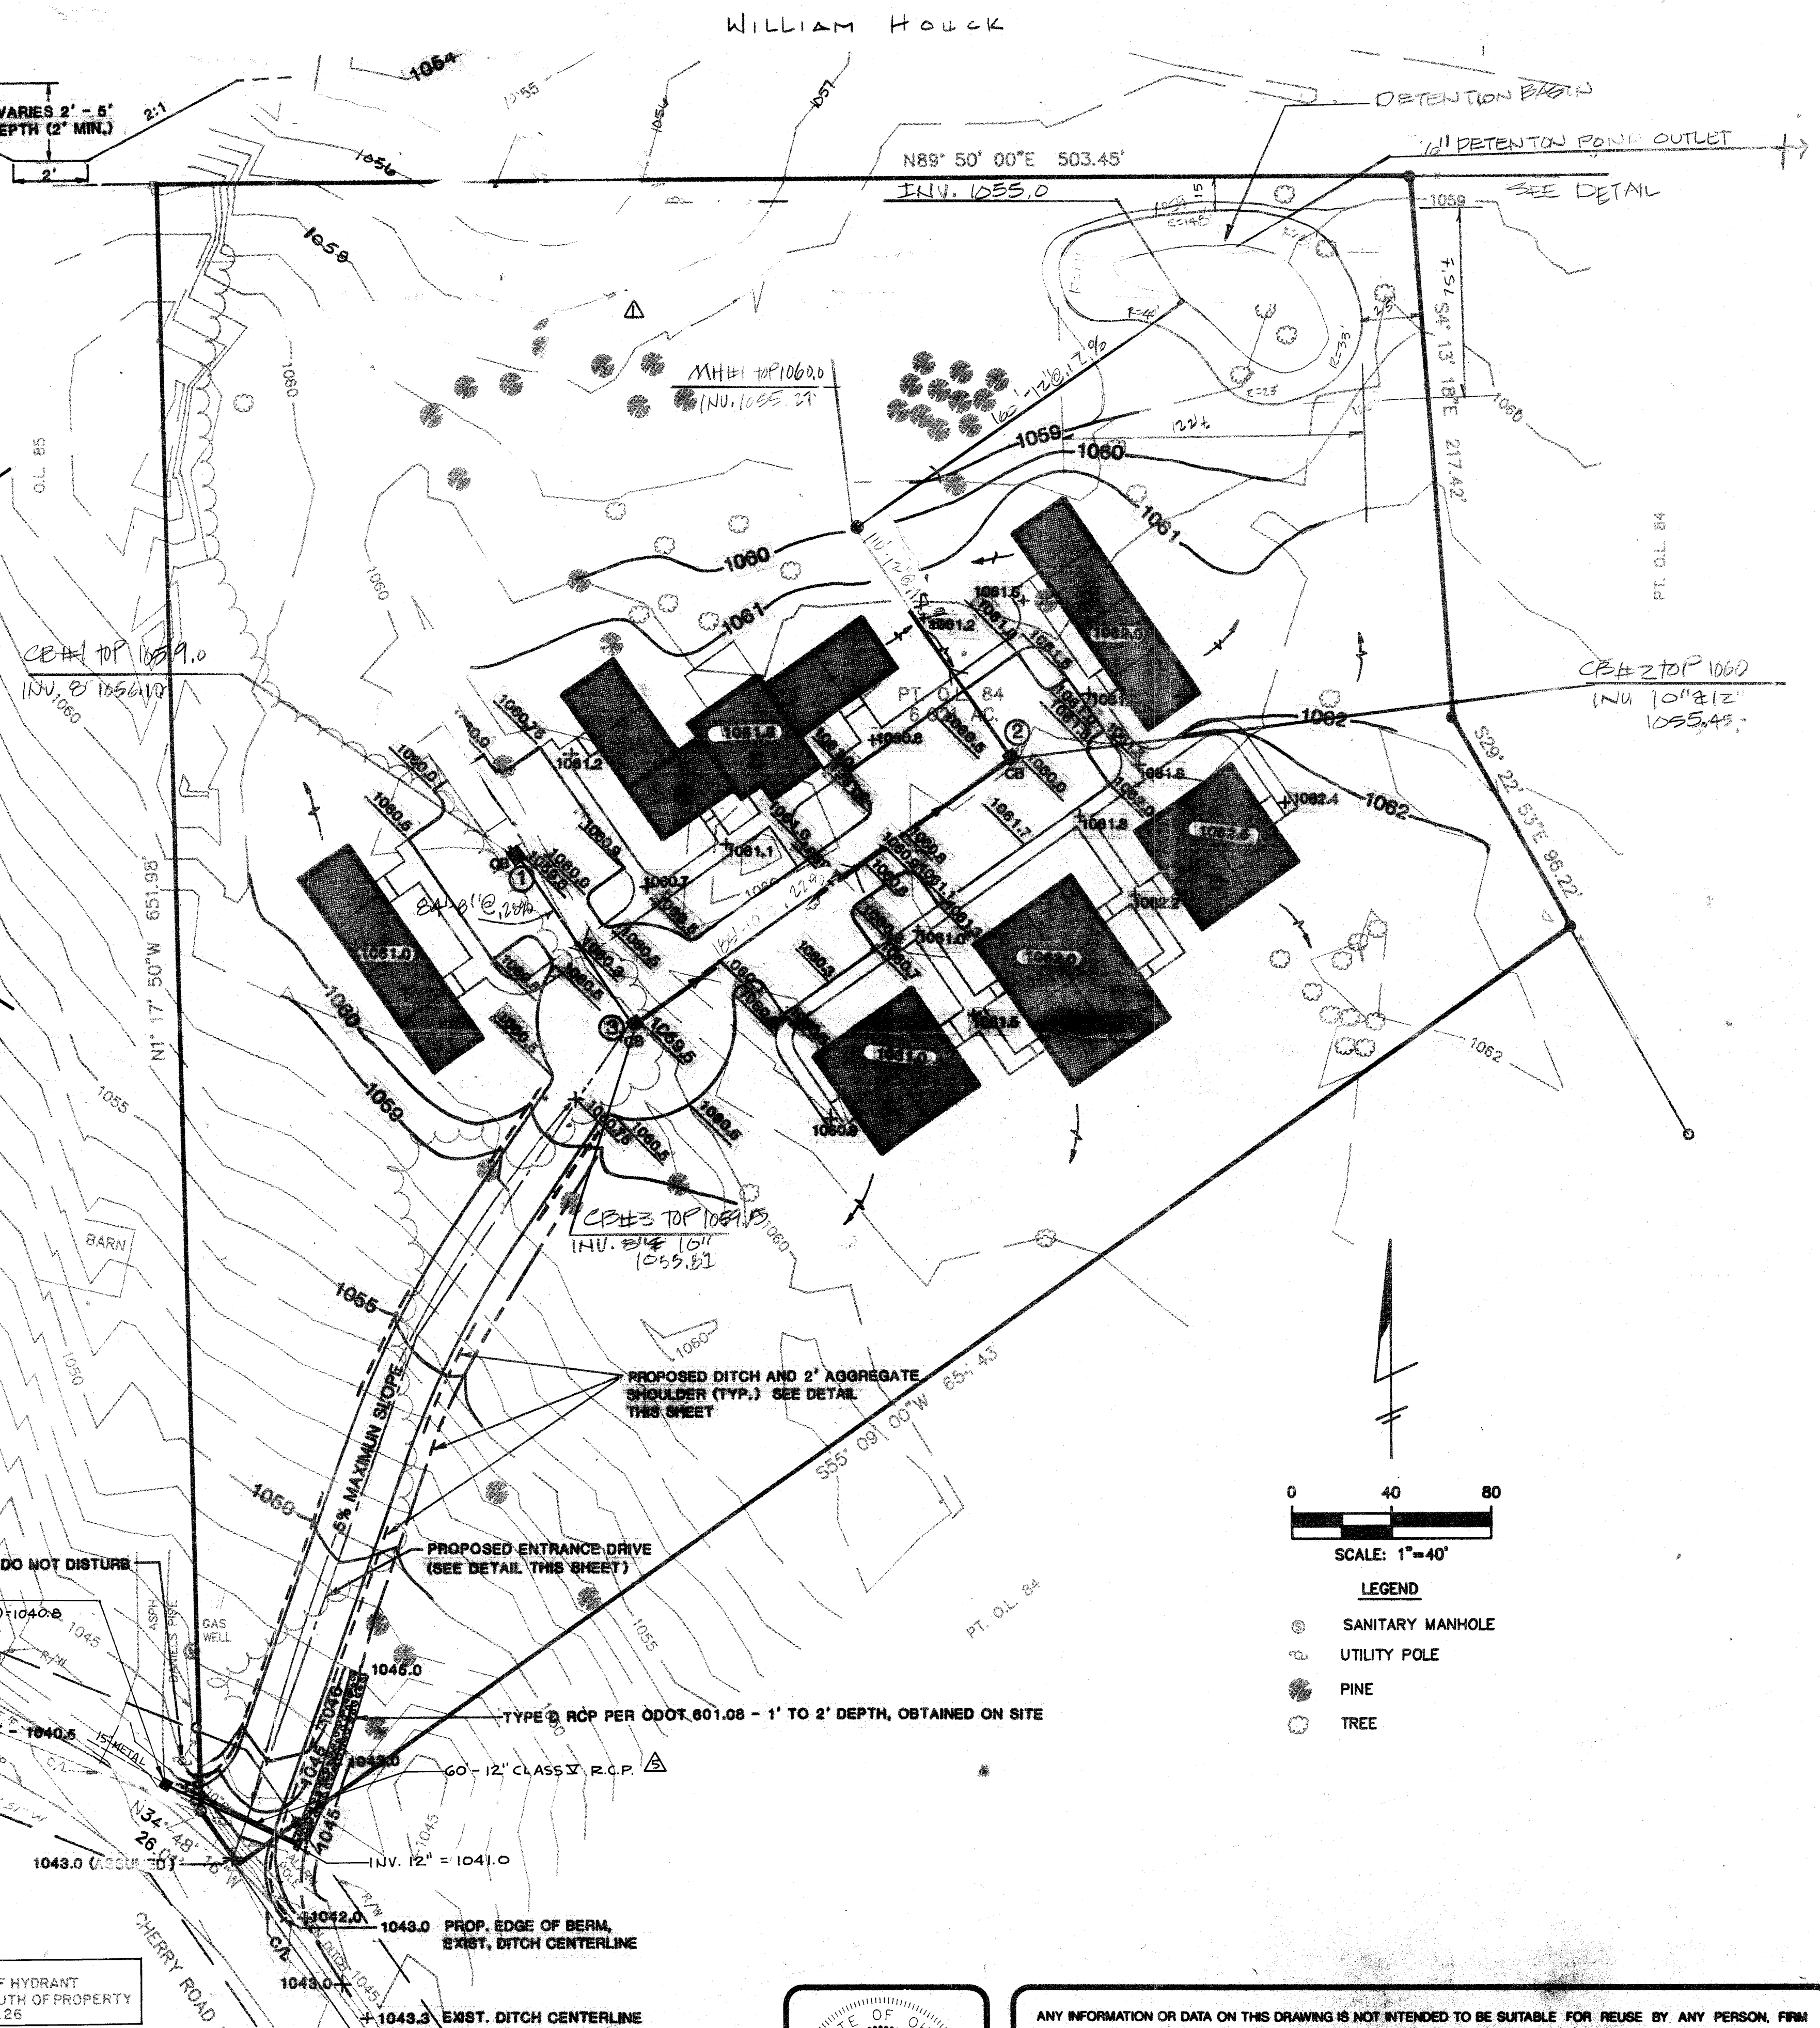

SCALE: 1"=40'

LEGEND

- SANITARY MANHOLE
- UTILITY POLE
- PINE
- TREE

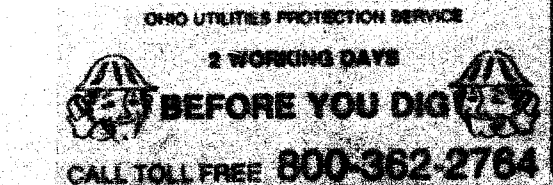

ANY INFORMATION OR DATA ON THIS DRAWING IS NOT INTENDED TO BE SUITABLE FOR REUSE BY ANY PERSON, FIRM OR CORPORATION OR ANY OTHERS ON EXTENSIONS OF THIS PROJECT OR FOR ANY USE OR ON ANY OTHER PROJECT. ANY REUSE WITHOUT WRITTEN VERIFICATION AND ADAPTATION BY THE ENGINEER, ARCHITECT OR SURVEYOR FOR THE SPECIFIC PURPOSE INTENDED WILL BE AT THE USER'S SOLE RISK AND WITHOUT LIABILITY OR LEGAL EXPOSURE TO THE ENGINEER, ARCHITECT OR SURVEYOR.

SITE GRADING PLAN & STORM SEWER LAYOUT

POGGEMEYER DESIGN GROUP, INC.
PLANNERS
ARCHITECTS
ENGINEERS

VOA
MASSILLON, OHIO
PROJECT #042-HH012

DATE	DEC 91
DRAWN BY	T.J.R.
CHECKED BY	MES
REVISION	1. CHANGED FROM 12\"/>

SP 5
8
JOB NUMBER
8710-007