


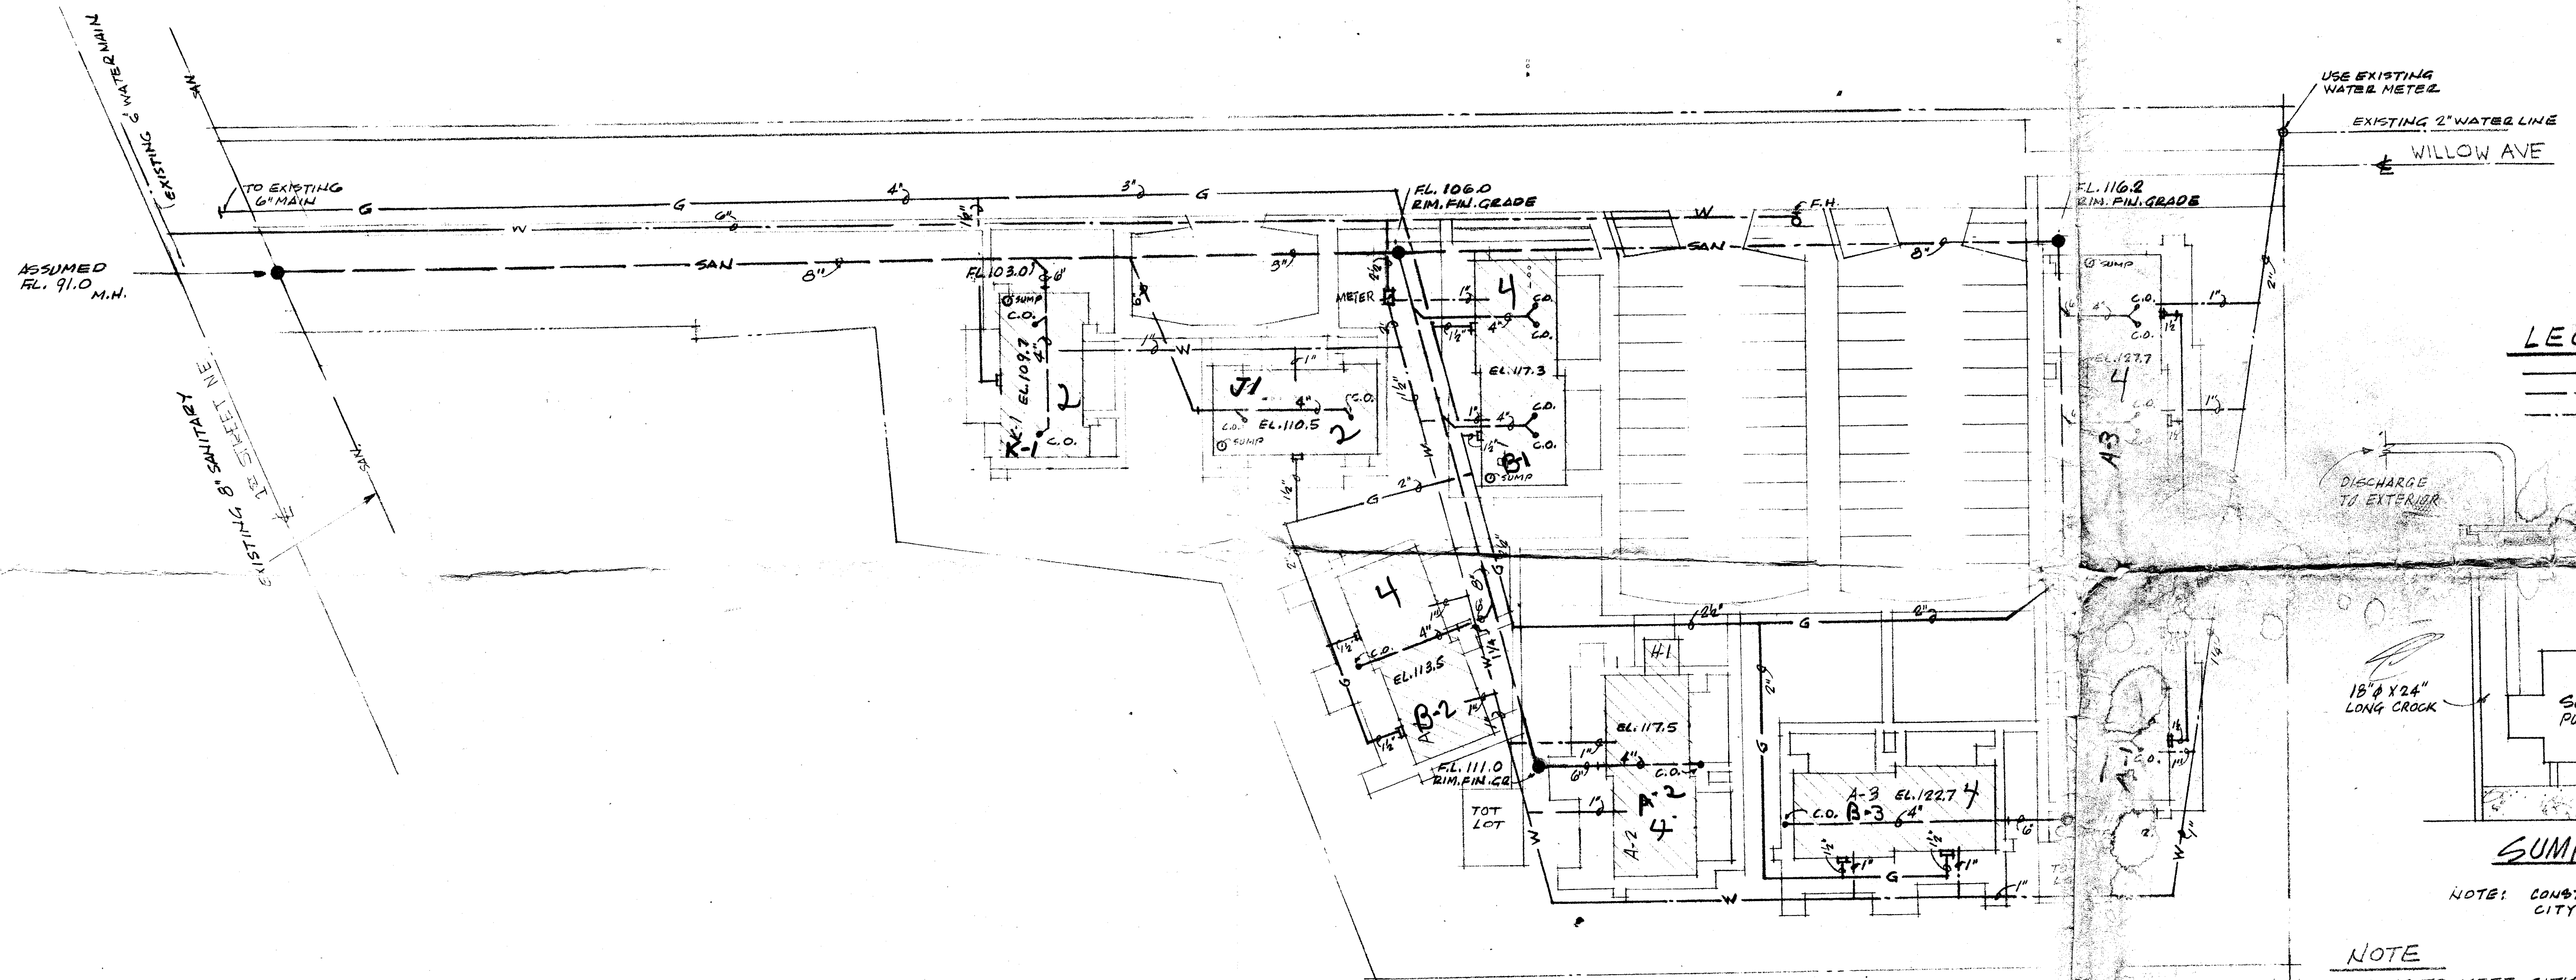

SITE #1 — UTILITY PLAN
SCALE 1" = 10'

- NOTE**
1. ALL PIPING TO MEET CITY CODE AS FAR AS DISTANCE FROM BUILDINGS, PIPE MATERIAL, PRESSURE REGULATORS WHERE NECESSARY.
 2. INSTALL A SUMP PUMP IN ALL BUILDINGS WITH FOOTING DRAINS, IN PROTECTED PIT - DISCHARGE AT LEAST 10' FROM BUILDING FOUNDATION TO POSITIVE DRAINAGE SWALE. FOR LOCATION - SEE THIS DWG.

DATE 2-18-72 3-10-72 4-72		SITE #1 UTILITY PLAN FAMILY HOUSING STARK METROPOLITAN HOUSING AUTHORITY CANTON, OHIO George S. Heinrich ARA - NCARB - ARCHITECT CLEVELAND, OHIO 44115 216/771-0943		STATE OF OHIO GEORGE STEVE HEINRICH 2395 REGISTERED ARCHITECT	18-11 P-1
------------------------------------	--	---	--	--	--------------