

ARCHITECT OF RECORD
JOHN F. FOTIMETER
NO. 6551

mkc
ASSOCIATES, INC.

ARCHITECTURE

ENGINEERING

PLANNING

104 FAIR AVENUE NE
NEW PHILADELPHIA, OHIO 44663

PHONE : 330-364-8871
FAX: 330-343-3075

COLUMBUS
MANSFIELD
NEW PHILADELPHIA

www.mkcinc.com

CONSTRUCTION MANAGER
**SCAPAROTTI
CONSTRUCTION GROUP**

5910 LANDERBROOK DRIVE, SUITE 230
CLEVELAND, OHIO 44124-4031
PH: 440-753-5200
FAX: 440-753-5201

CONSULTANTS
LEE S. GOOD, P.E., INC.
MECHANICAL ENGINEERS
& CONSULTANTS


10483 CLEVELAND AVENUE, N.W.
P.O. BOX 608
UNIONTOWN, OHIO 44685
PH: 330-494-1574
FAX: 330-494-5167

TEK SYSTEMS DESIGN
132 SOUTH MILL STREET
FREDERICKSBURG, OHIO 44627
PH: 330-695-2515

Civil Design Associates, Inc.
CONSULTING ENGINEERS * SURVEYORS

1760 BRIGHTWOOD ROAD S.E.
NEW PHILADELPHIA, OHIO 44663
PH: 330-339-4242

EARLY SITE WORK
FOR
NEW PK-4
ELEMENTARY SCHOOL
TUSLAW
LOCAL SCHOOL
DISTRICT

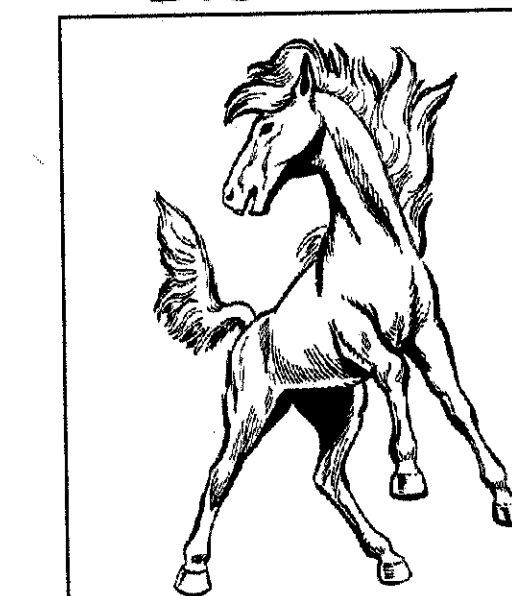

MASSILLON
OHIO



SUBMITTED : AUGUST 26, 2009

REVISIONS		
MARK	DATE	DESCRIPTION
△	10-23-09	REVISED UTILITIES
△		
△		
△		
△		


DRAWN BY: PROJ. MGR:
SHEET CONTENT

STORM & UTILITY PLAN

JOB NO. SHEET
08-ED2-081 2.07

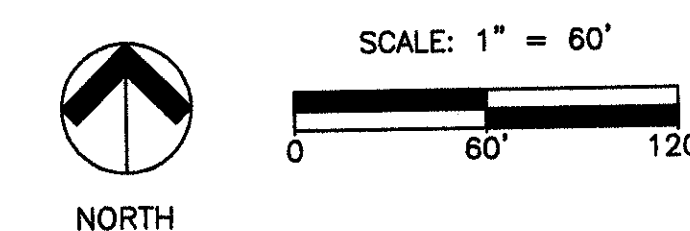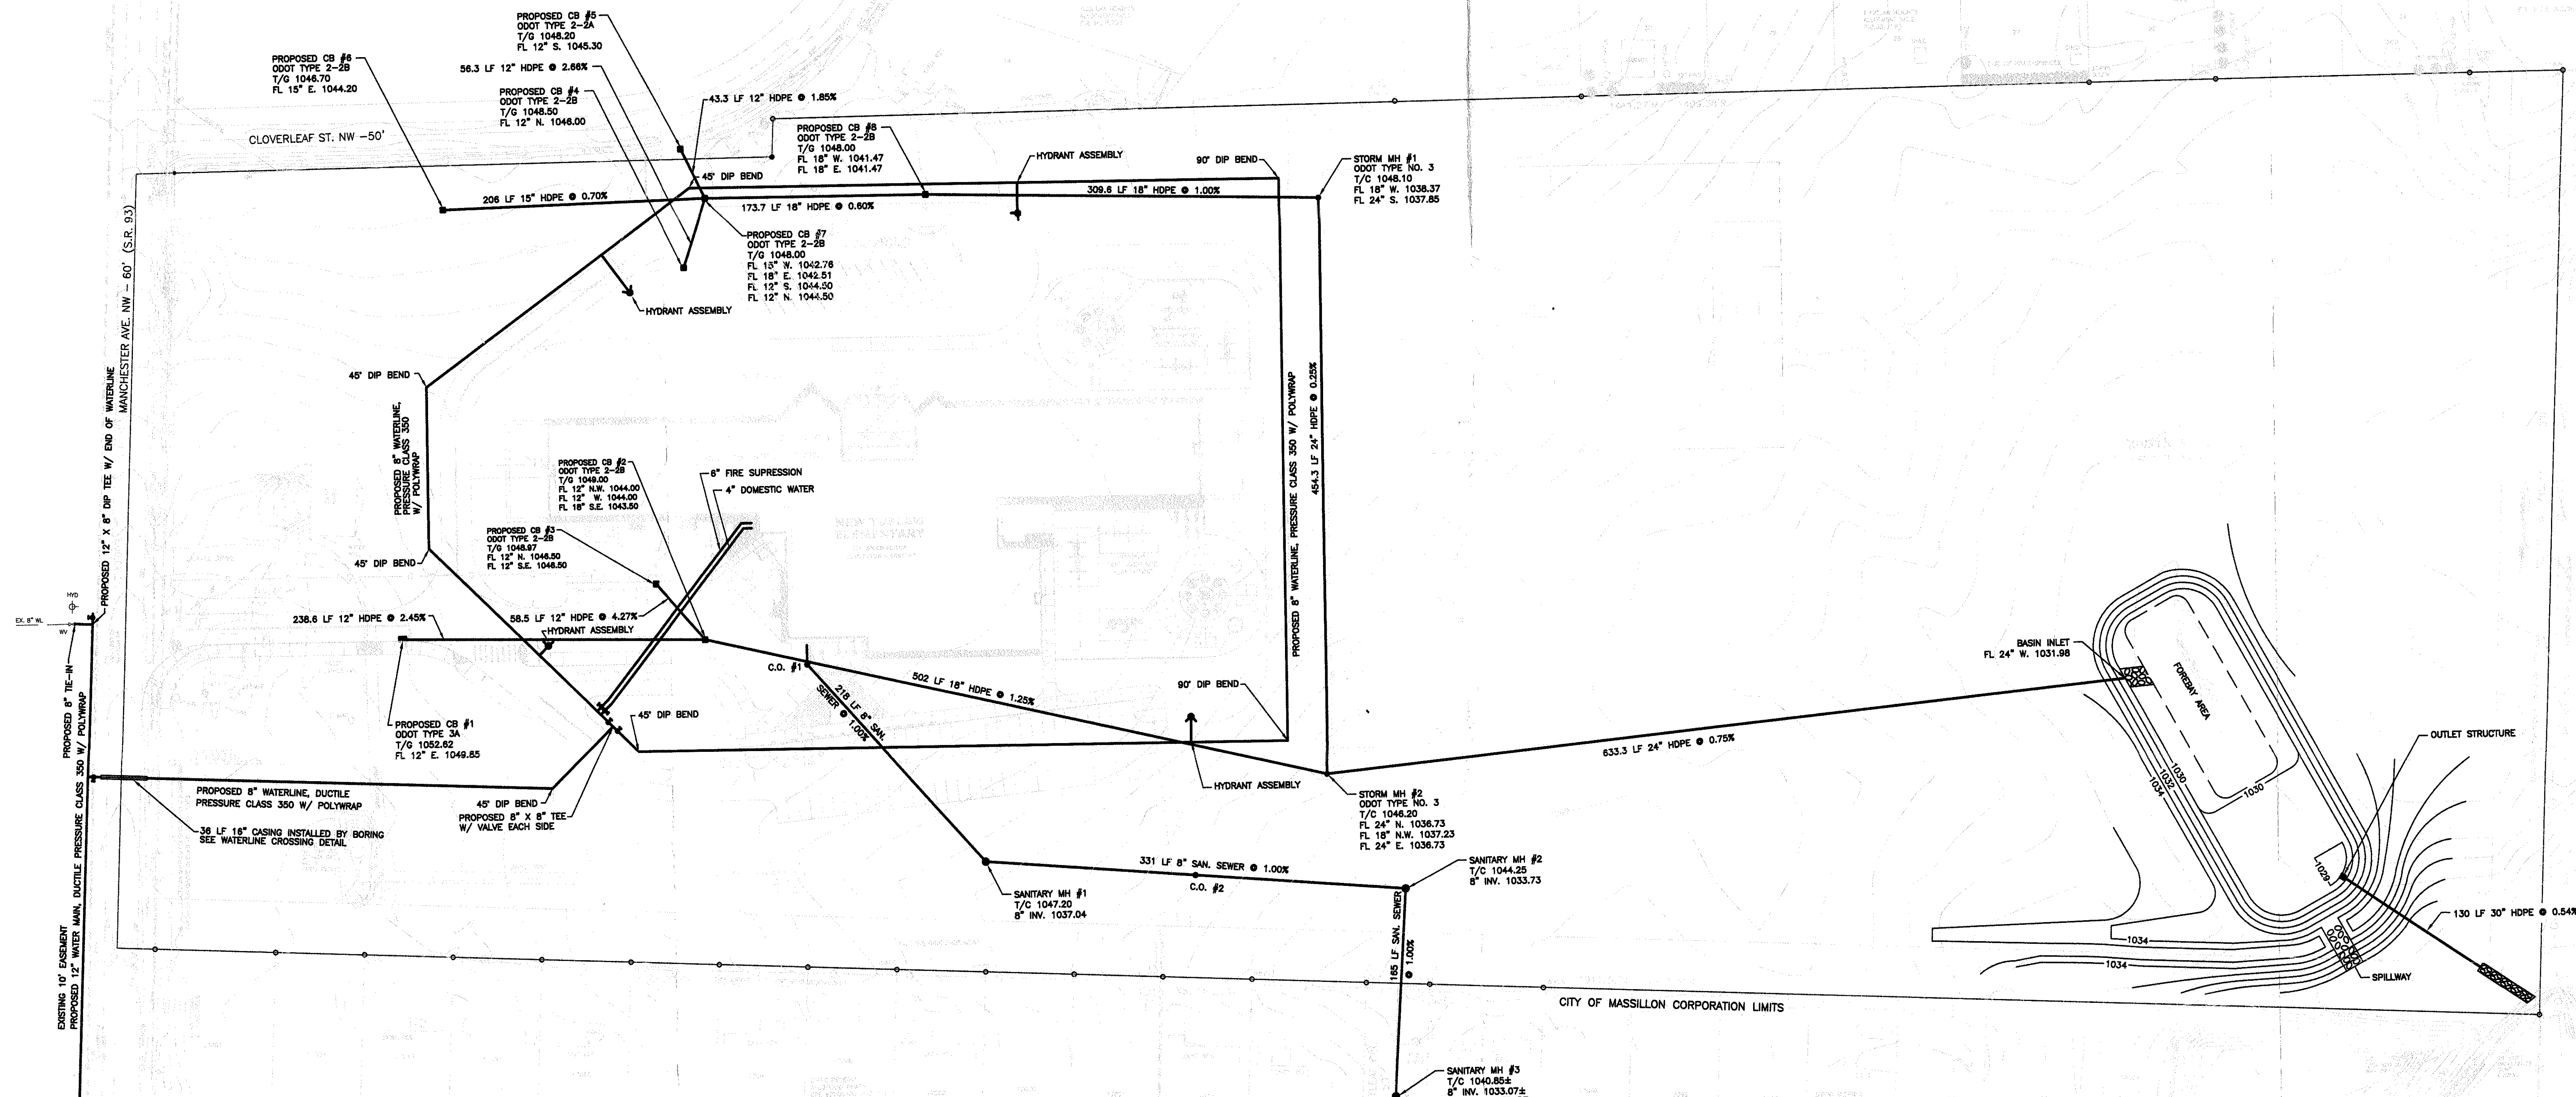

COORDINATE LIST		
DESCRIPTION	NORTHING	EASTING
STORM MH #1	418708.503	2218126.311
STORM MH #2	418254.194	2218126.311
C.B. #1	418372.291	2217398.770
C.B. #2	418368.060	2217637.338
C.B. #3	418412.581	2217599.164
C.B. #4	418661.616	2217625.116
C.B. #5	418755.119	2217624.400
C.B. #6	418710.384	2217436.173
C.B. #7	418716.049	2217643.134
C.B. #8	418716.049	2217816.821
BASIN INLET	418319.010	2218756.274
OUTLET STRUCTURE	418159.977	2218926.660
SAN. MH #1	418189.589	2217856.168
SAN. MH #2	418162.921	2218186.664
SAN. MH #3	417999.059	2218176.362
C.O. #1	418347.209	2217717.390
C.O. #2	418176.258	2218021.381

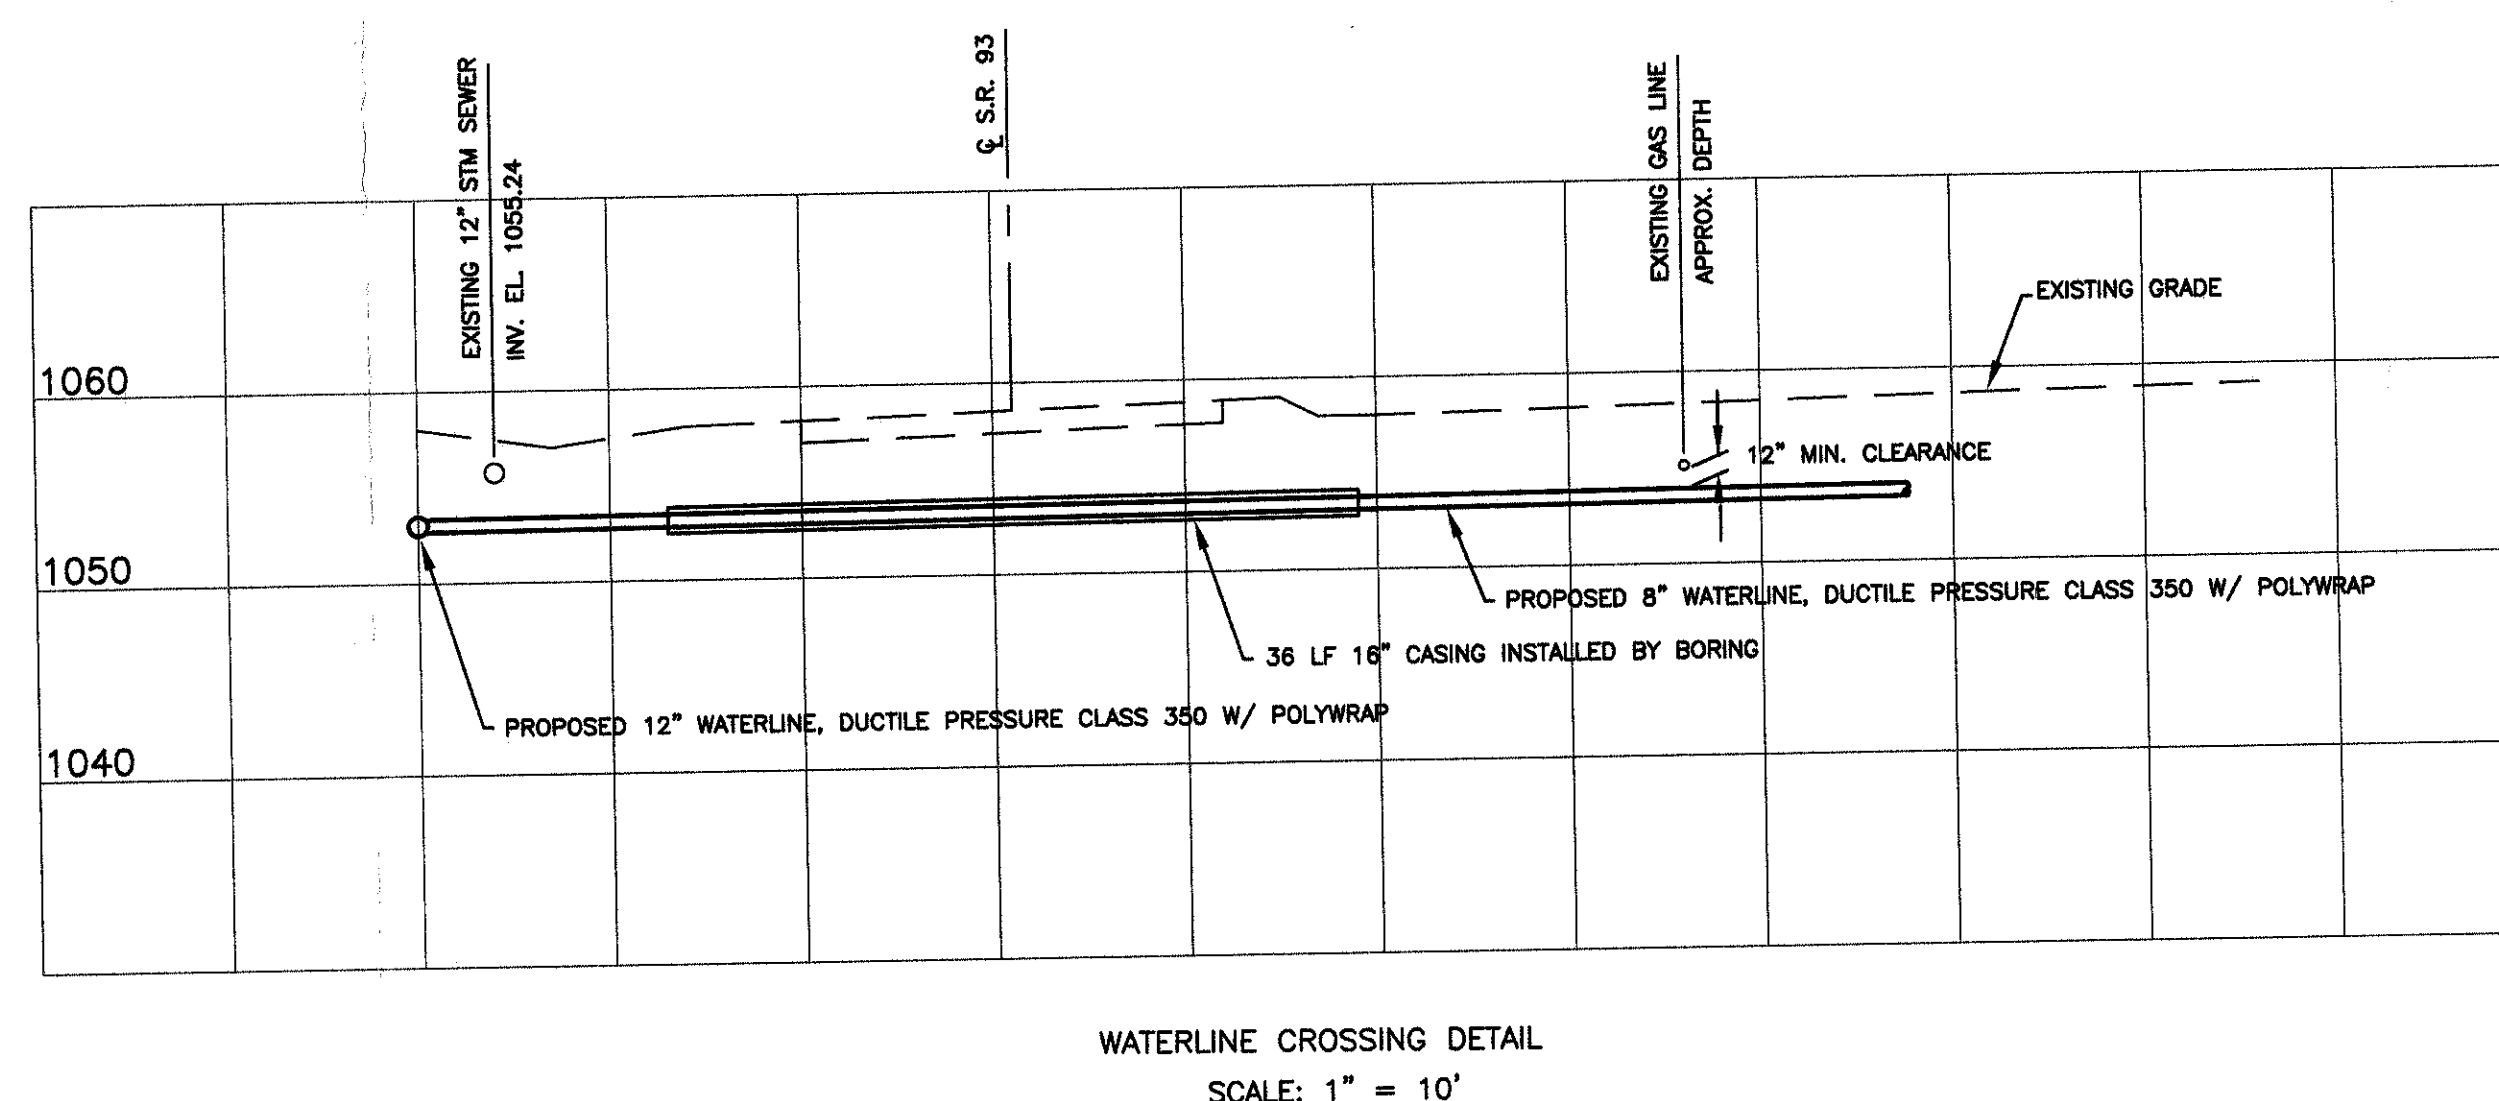

WATERLINE CROSSING DETAIL
SCALE: 1" = 10'