
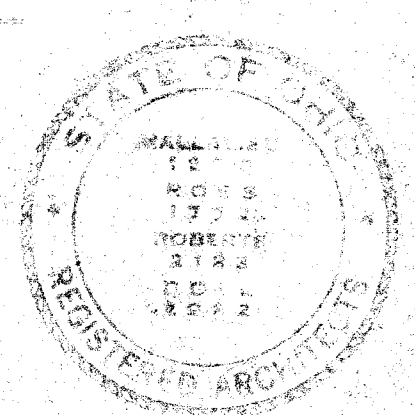


2/7/16 RECEIVED
F.A.
ARCH.
R.W.

BULLETIN B-29 KEY TO DRAWINGS

- B-1 FINISHED SITE PLAN
- B-2 ORIGINAL SITE PLAN W/STORM DRAINAGE & NEW GRADING
- B-3 FOUNTAIN & SUNKEN PLAZA DETAILS, STORM DRAIN S.C. & DETAILS
- B-4 FIRST STREET SIDEWALK & RETAINING WALLS
- B-P1 FOUNTAIN PLUMBING
- B-E1 ELECTRICAL SITE PLAN
- B-E2 ELECTRICAL DIAGRAMS & SCHEDULES
- B-L1 PARKING LOT LAYOUT
- B-L2 PLAZA PAVING PATTERN VERBA DELETED
- B-L3 SITE DRAINAGE SLOPES, CATCH BASINS & STORM SEWERS

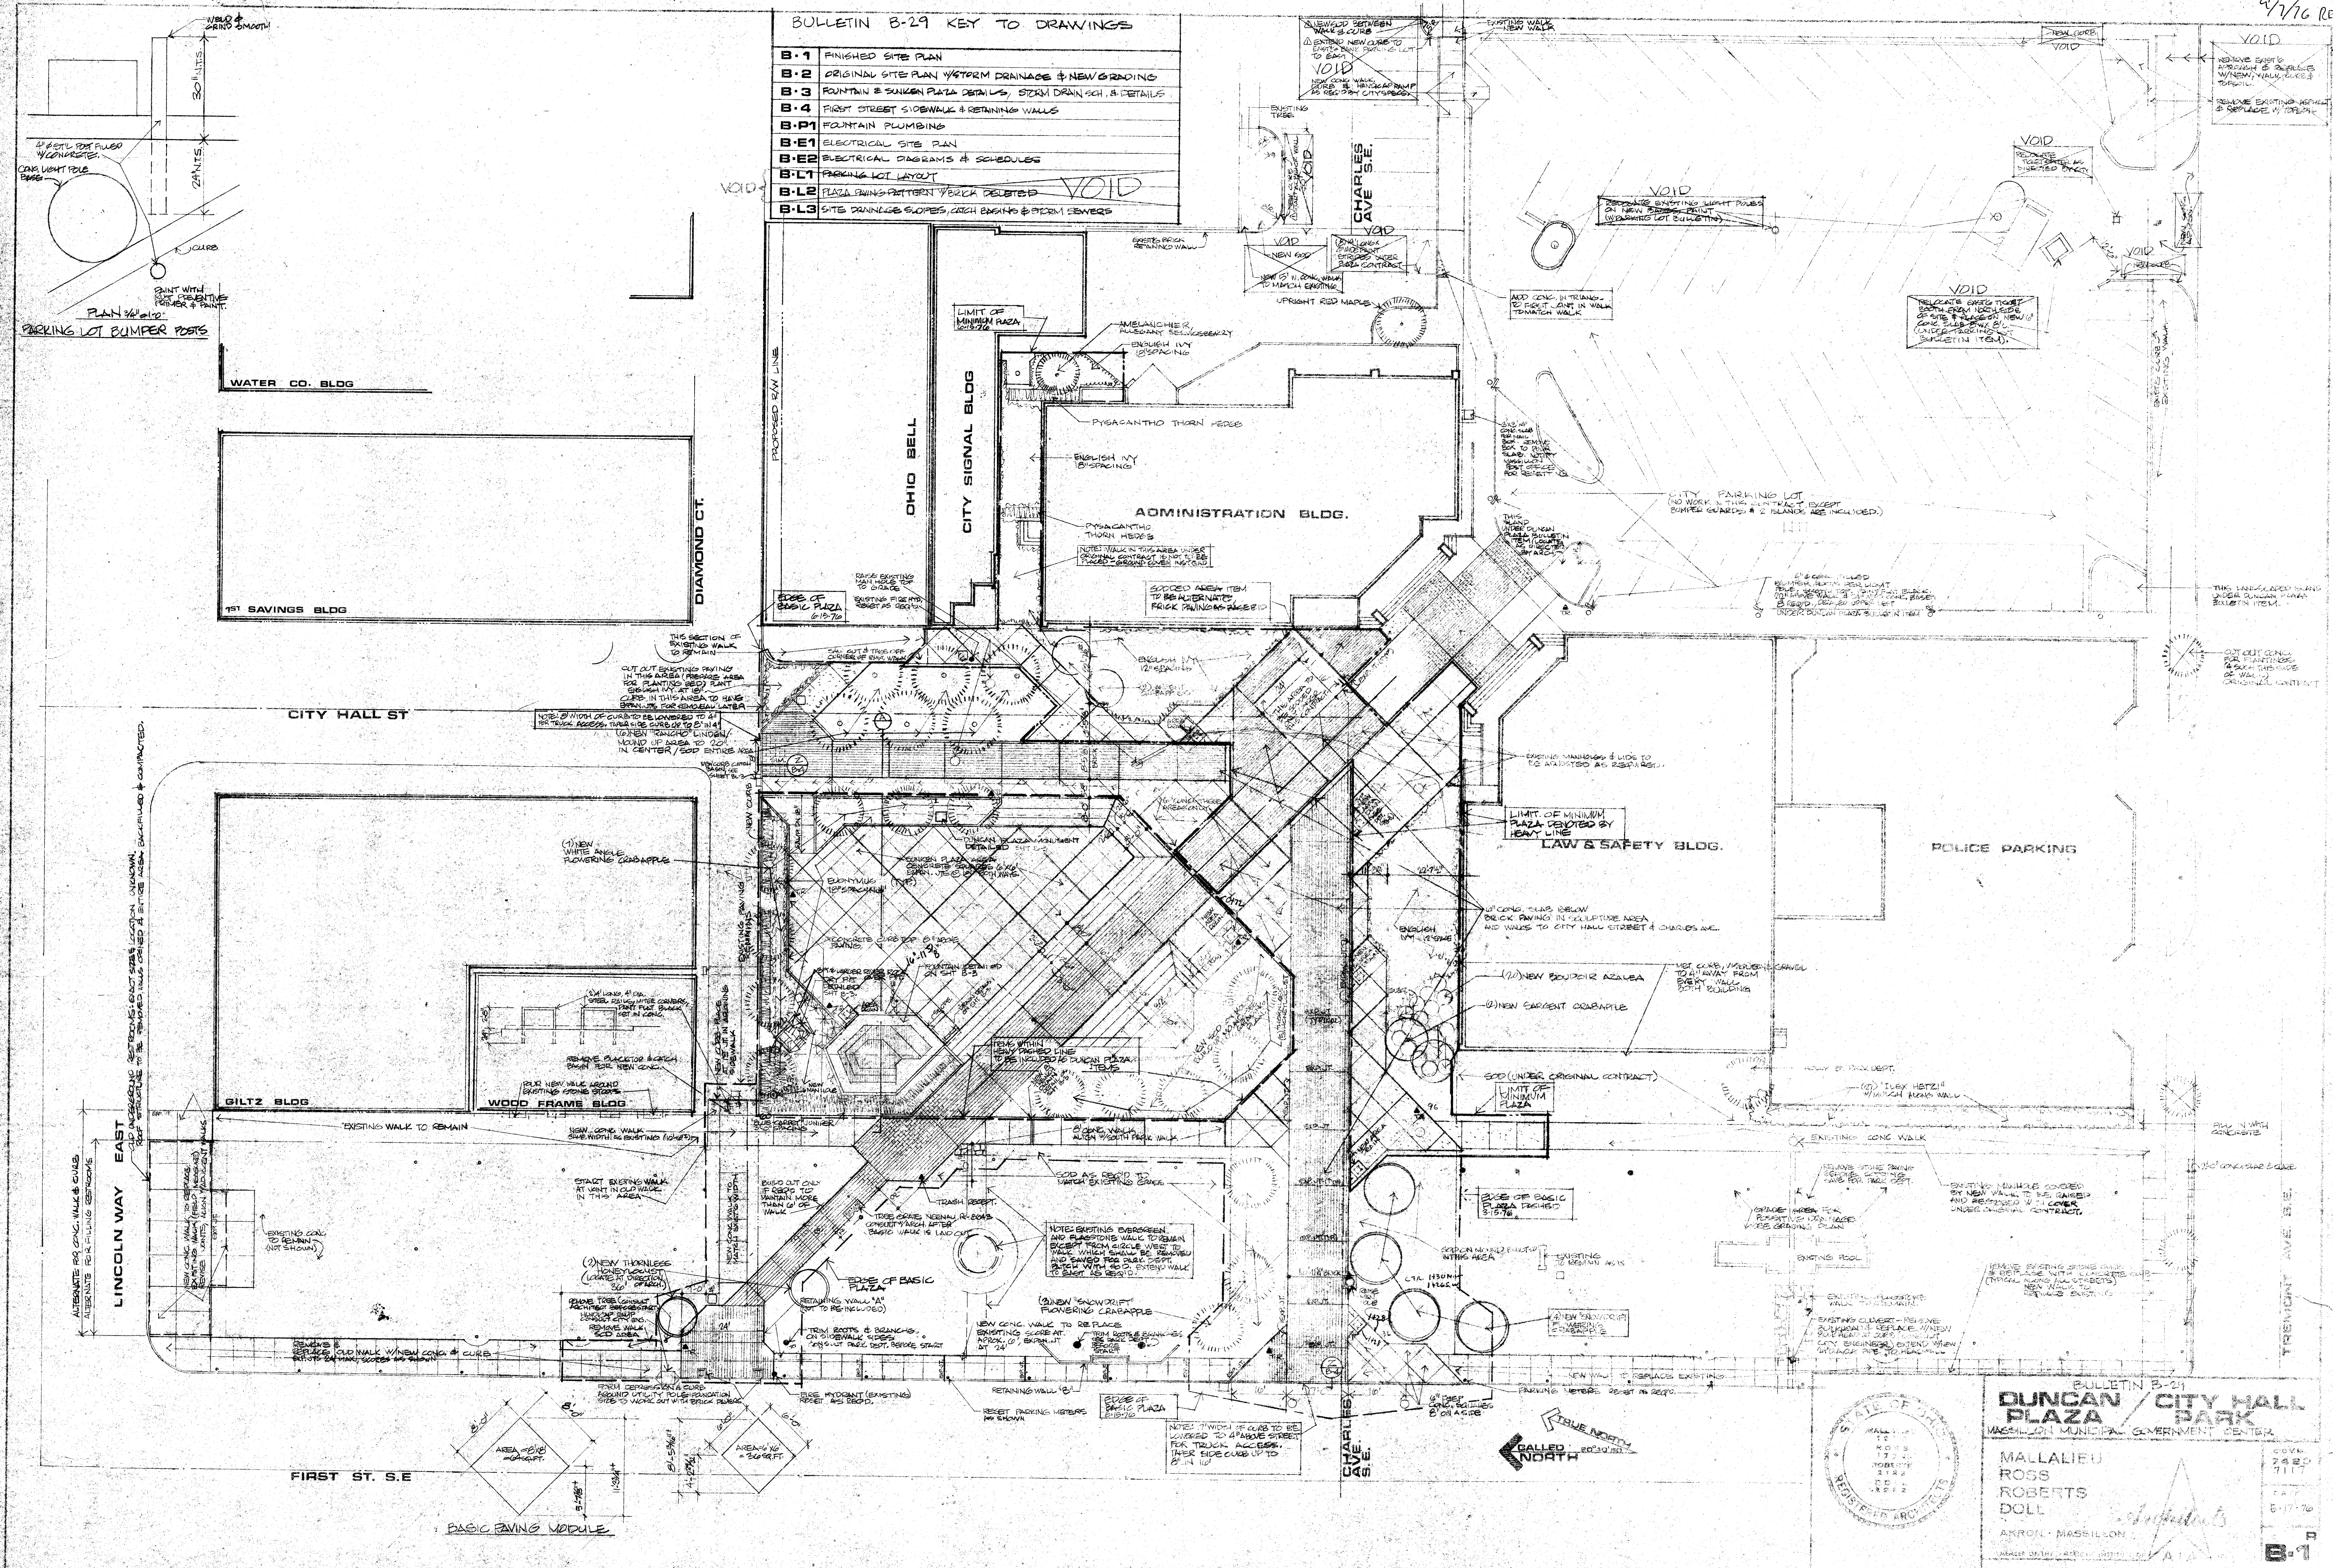









BULLETIN B-29
DUNCAN PLAZA / CITY HALL PARK
MASON OHIO MUNICIPAL GOVERNMENT CENTER

MALLALIEU
ROSS
ROBERTS
DOLL








AKRON - MASON OHIO

PLAN 1"=20'

LOCATE AS DIRECTED BY ARCH
TRASH RECEPT 10' DIA

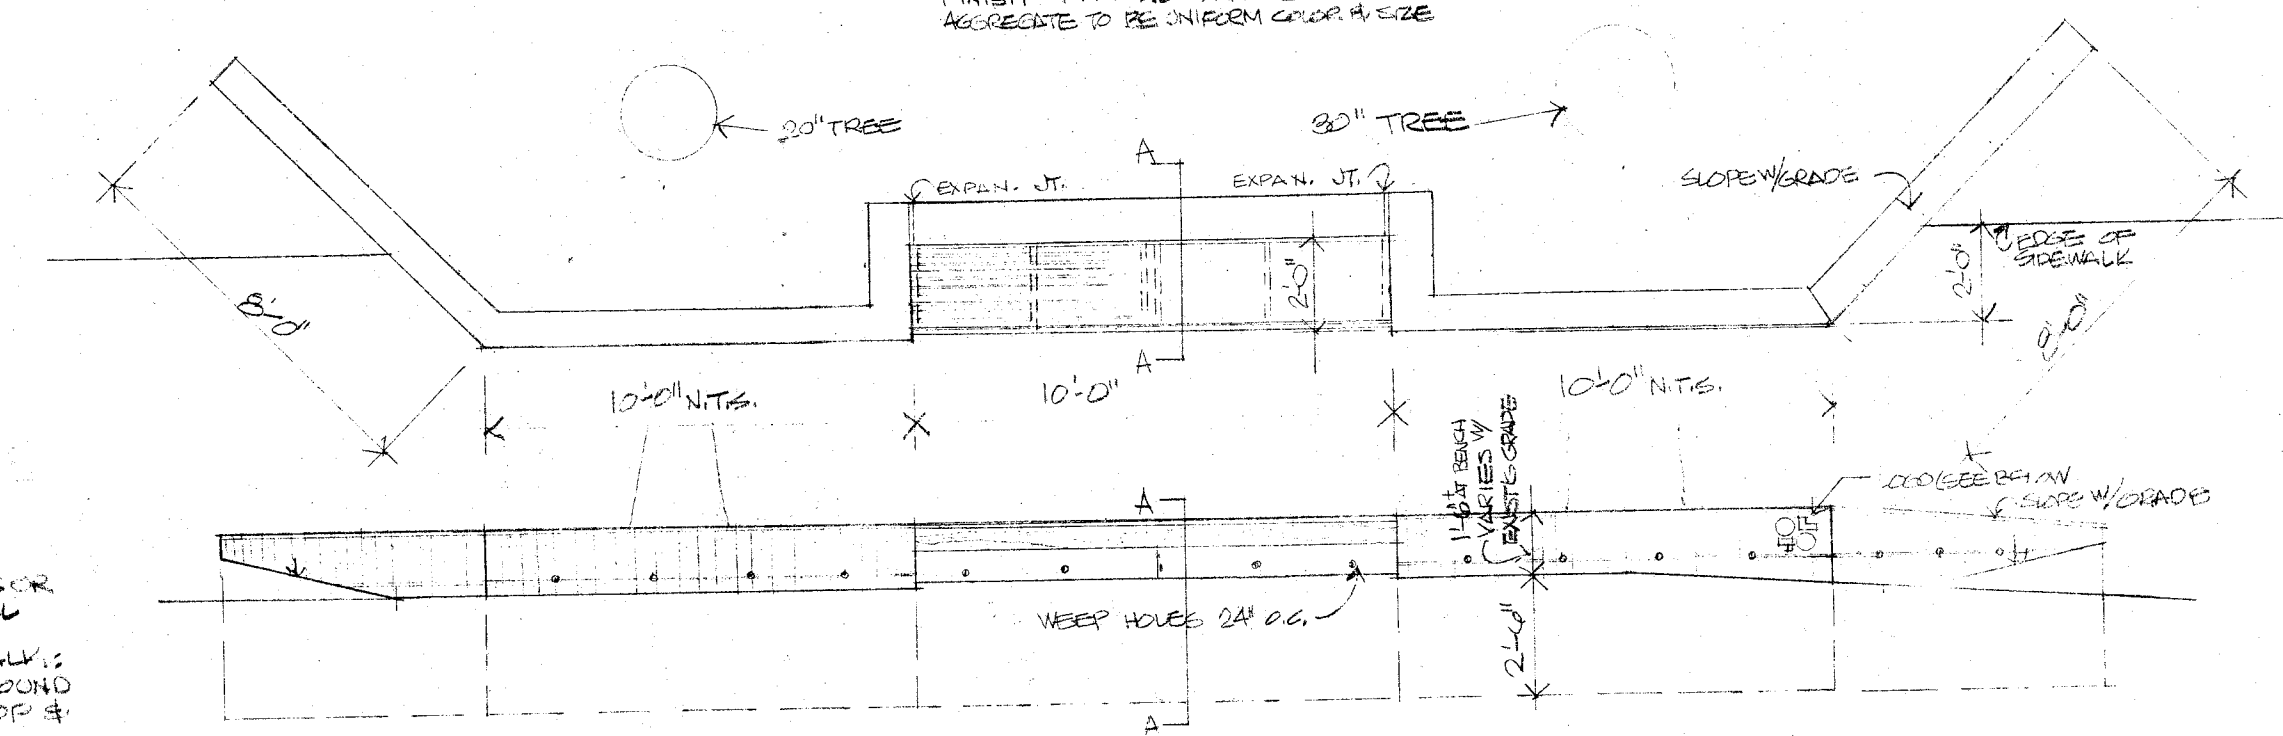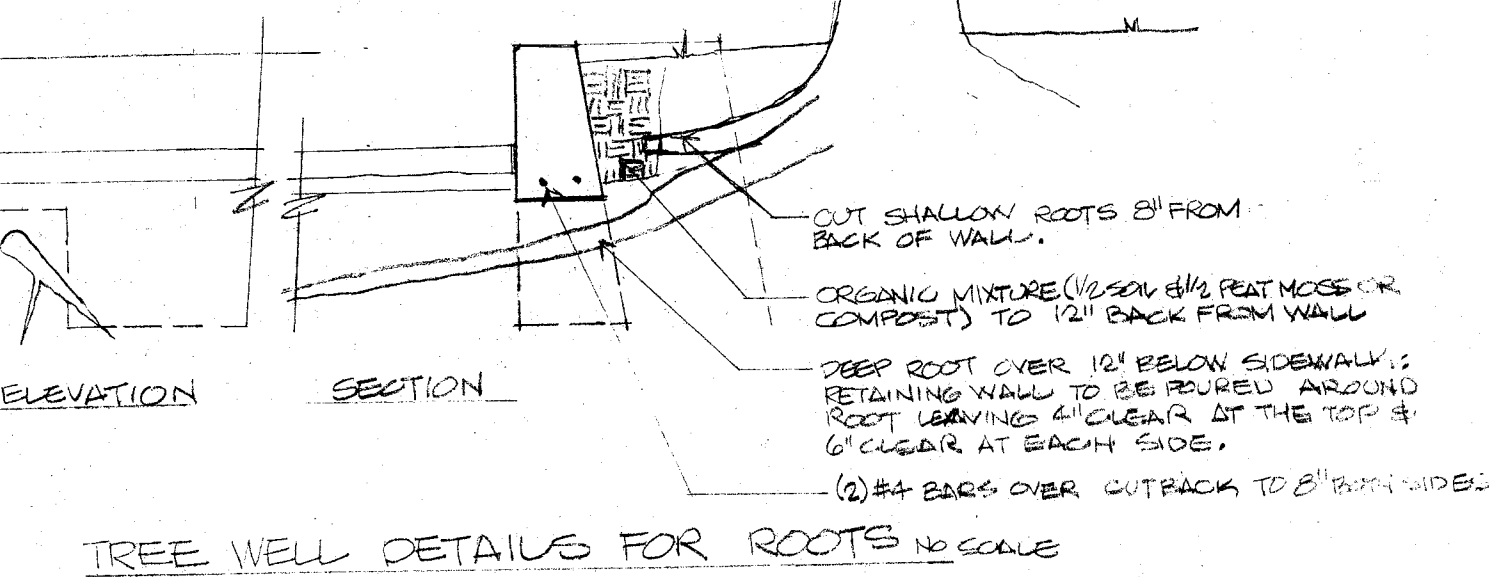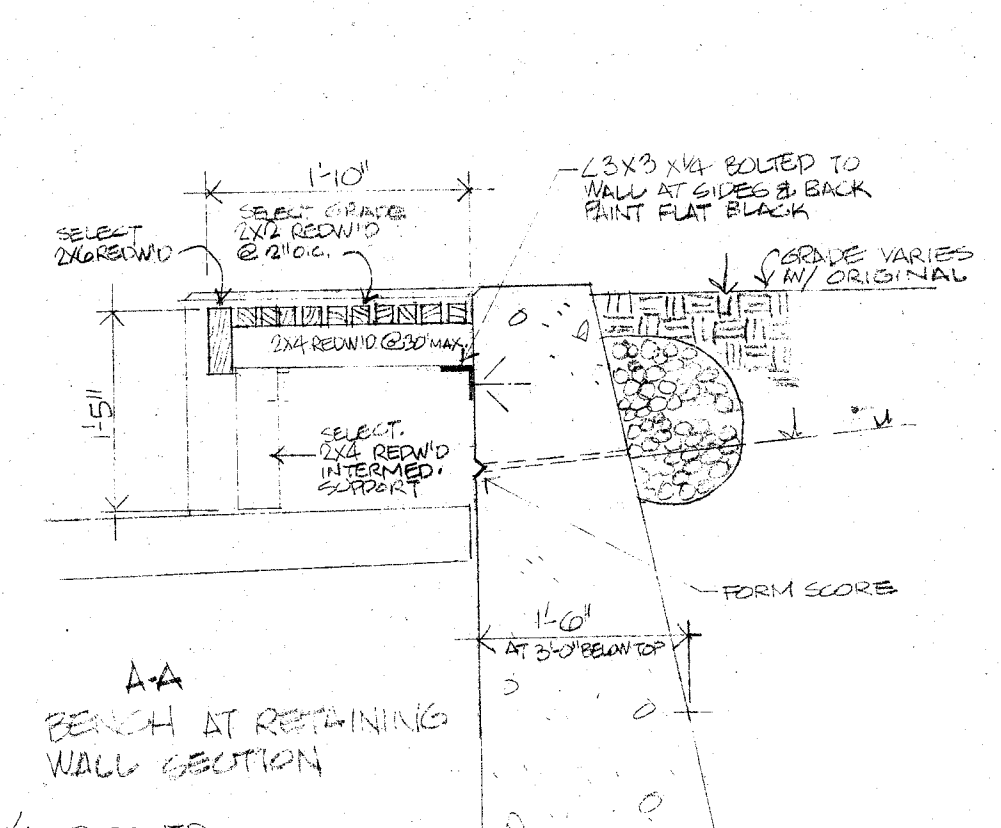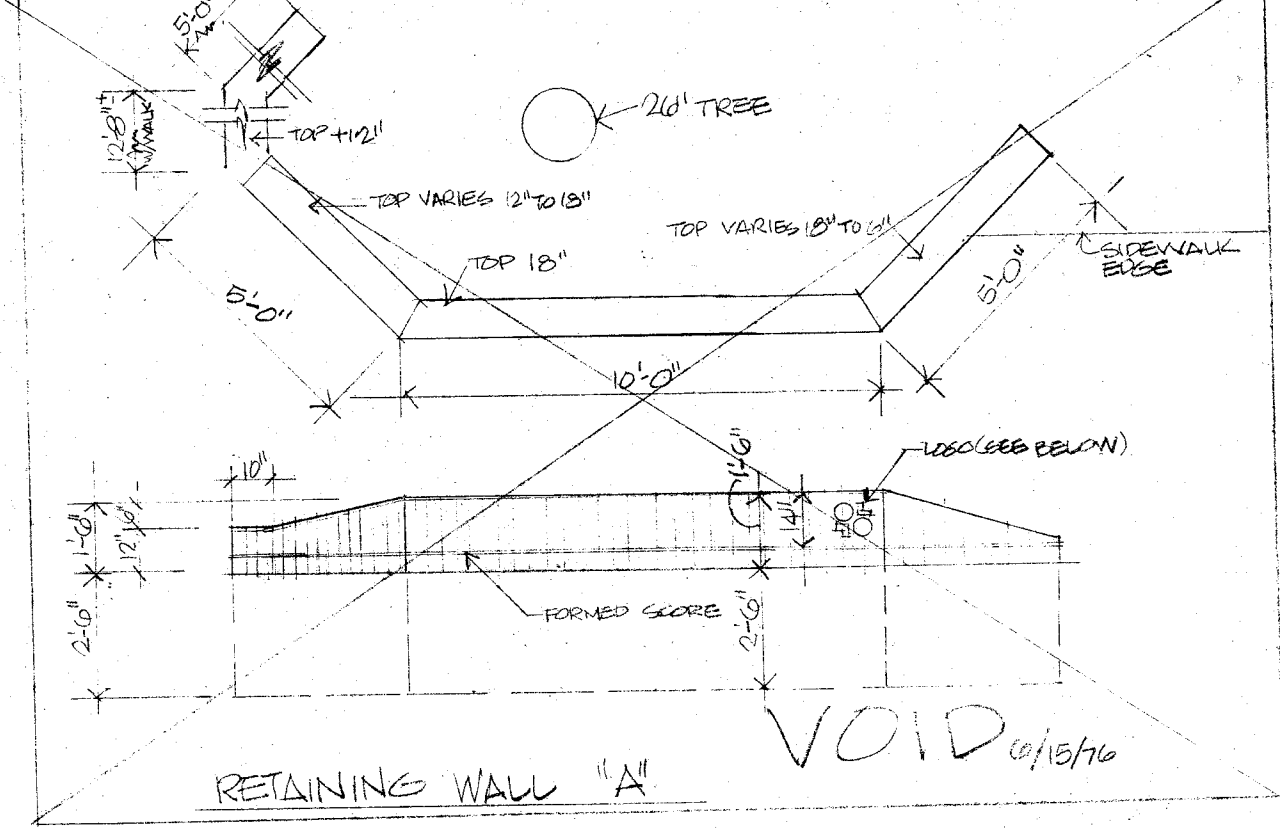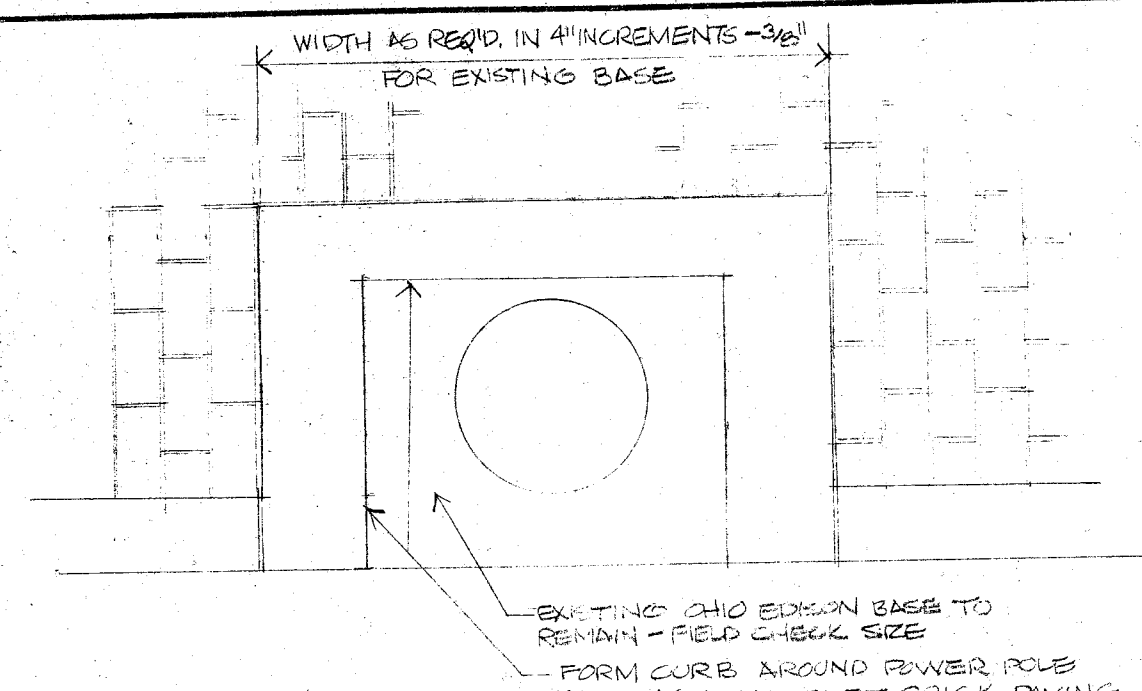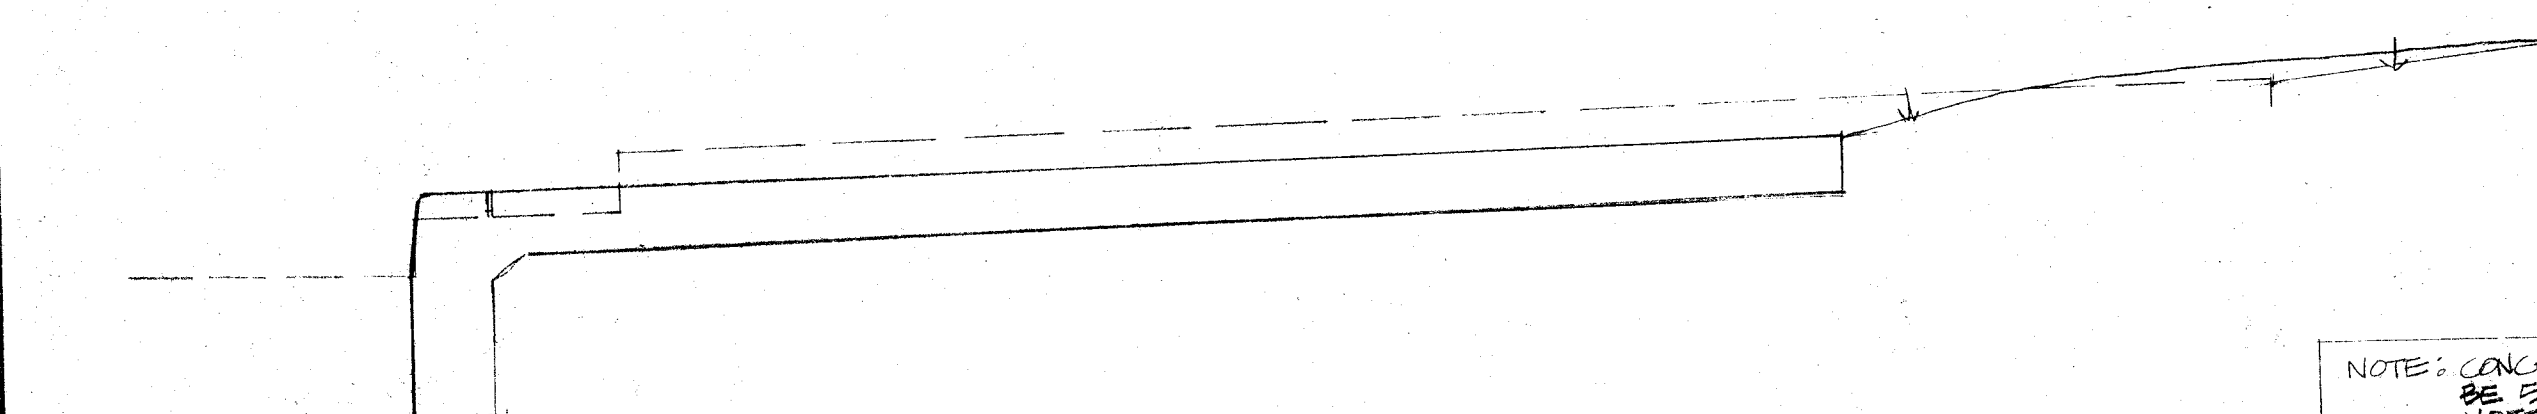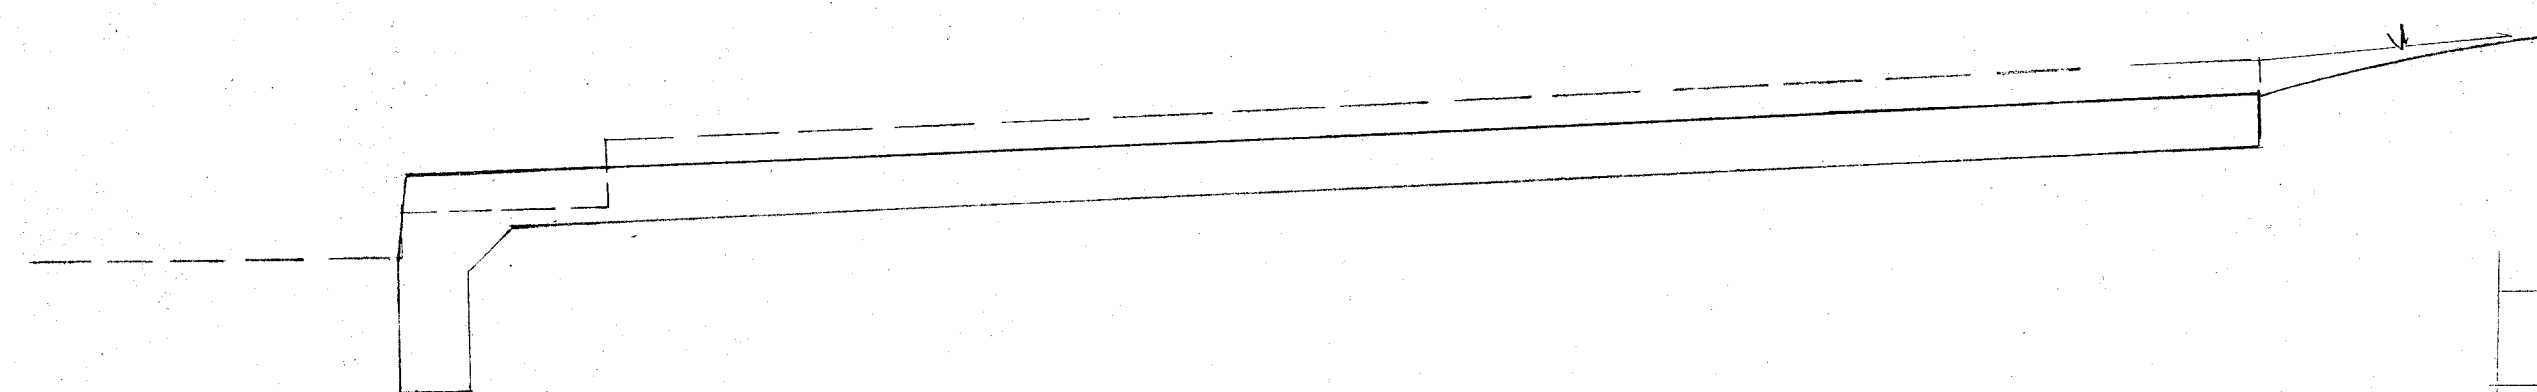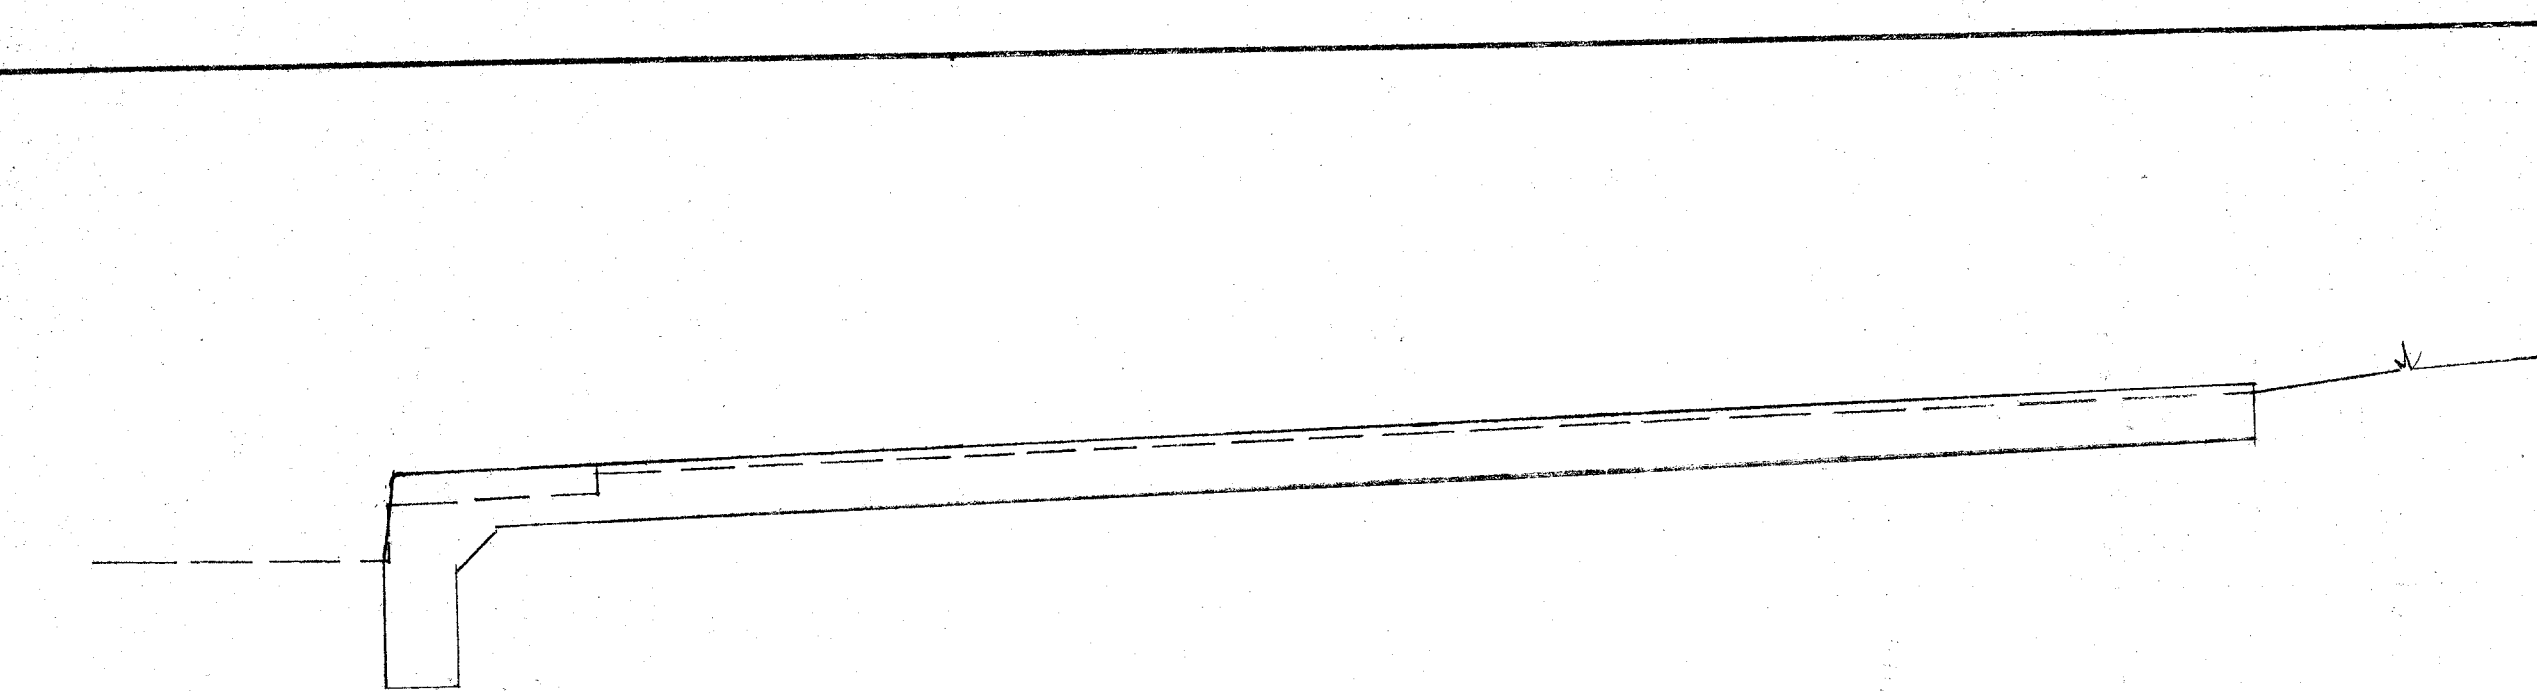

NOTE: CONCRETE SIDEWALKS TO BE 5" MIN. DEPTH - CONDT AREAS WHERE NOTED ON PLAN TO BE 10" MIN. DEPTH (WHERE REQ'D FOR OCCASIONAL TRUCK TRAFFIC)
6/16/76

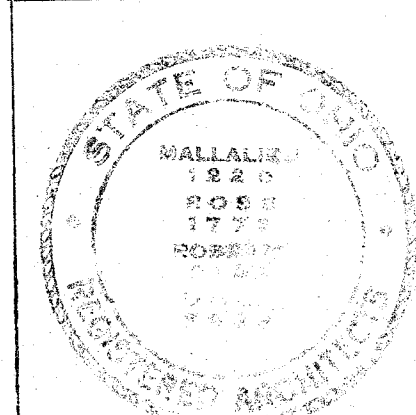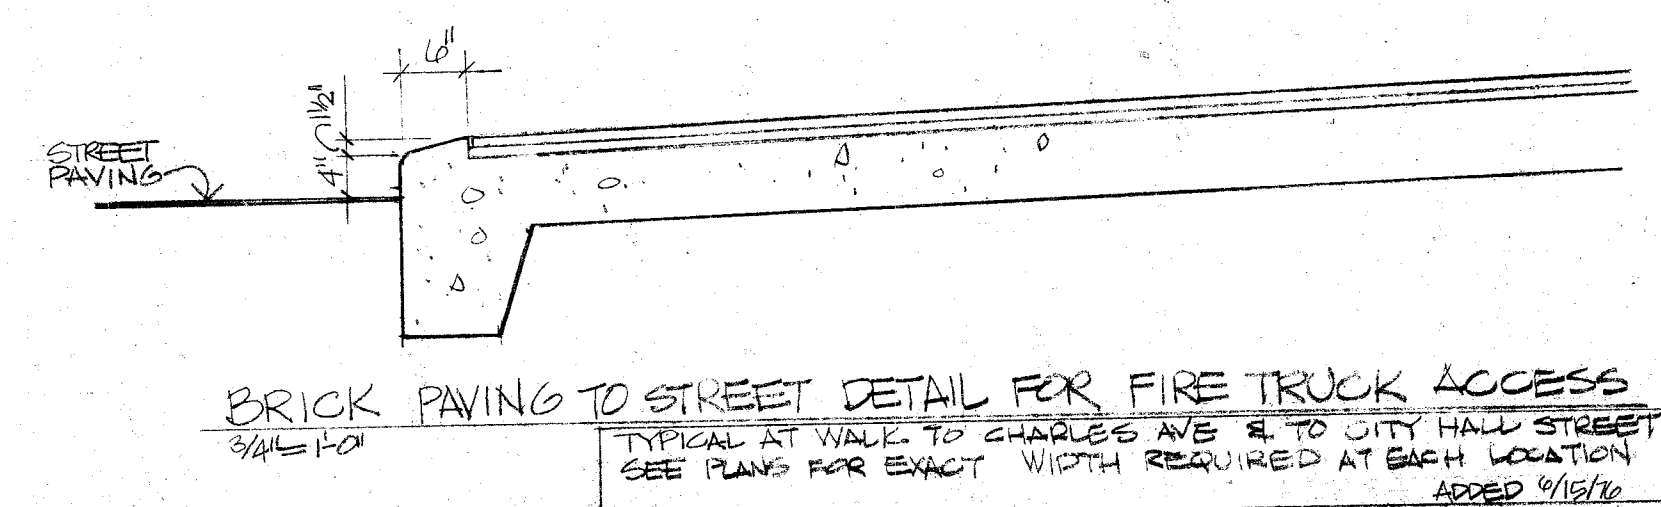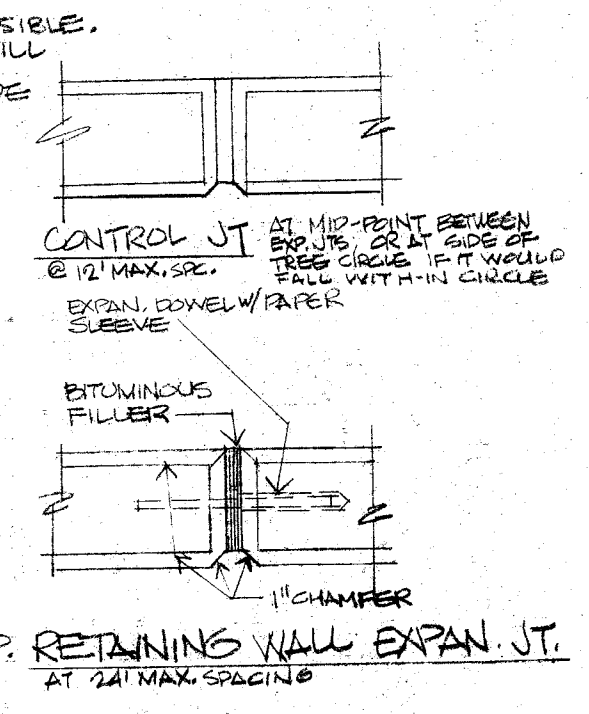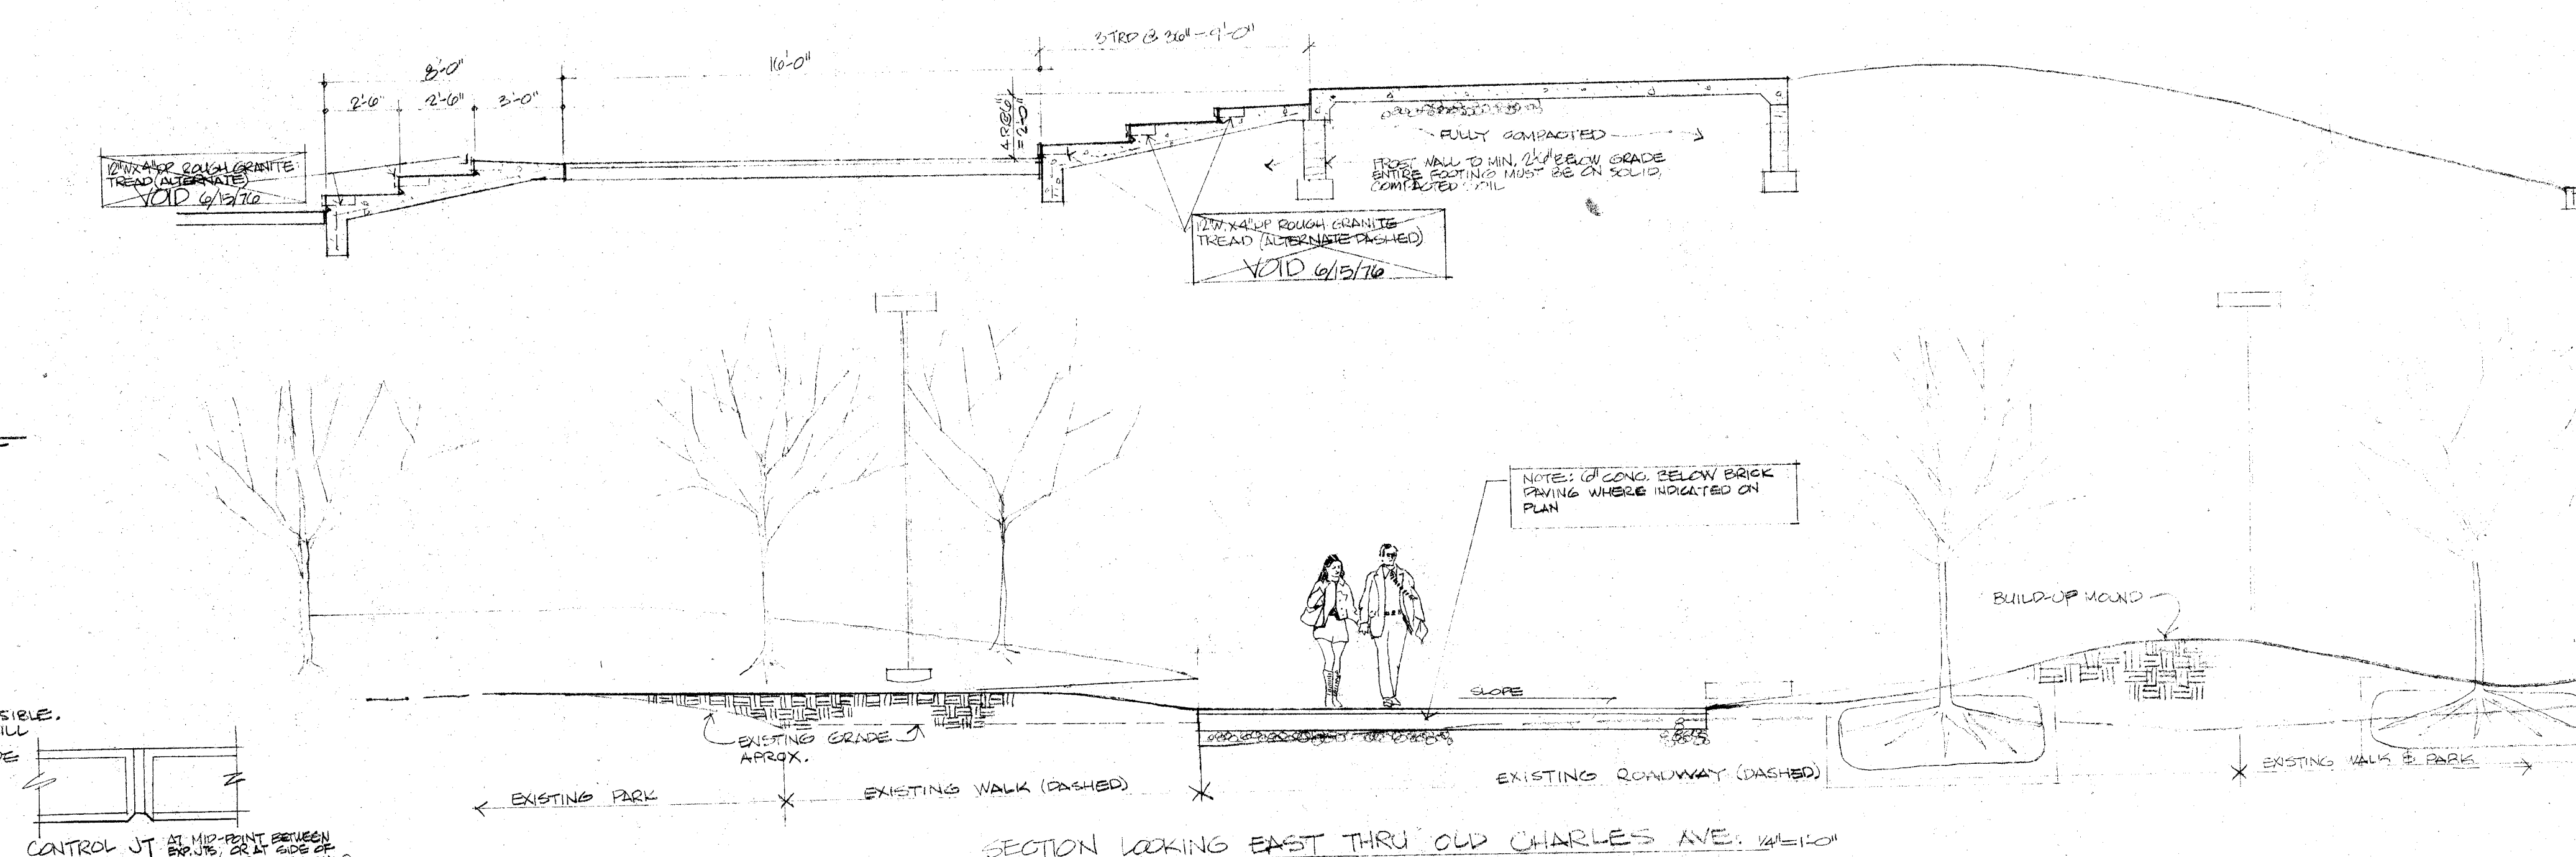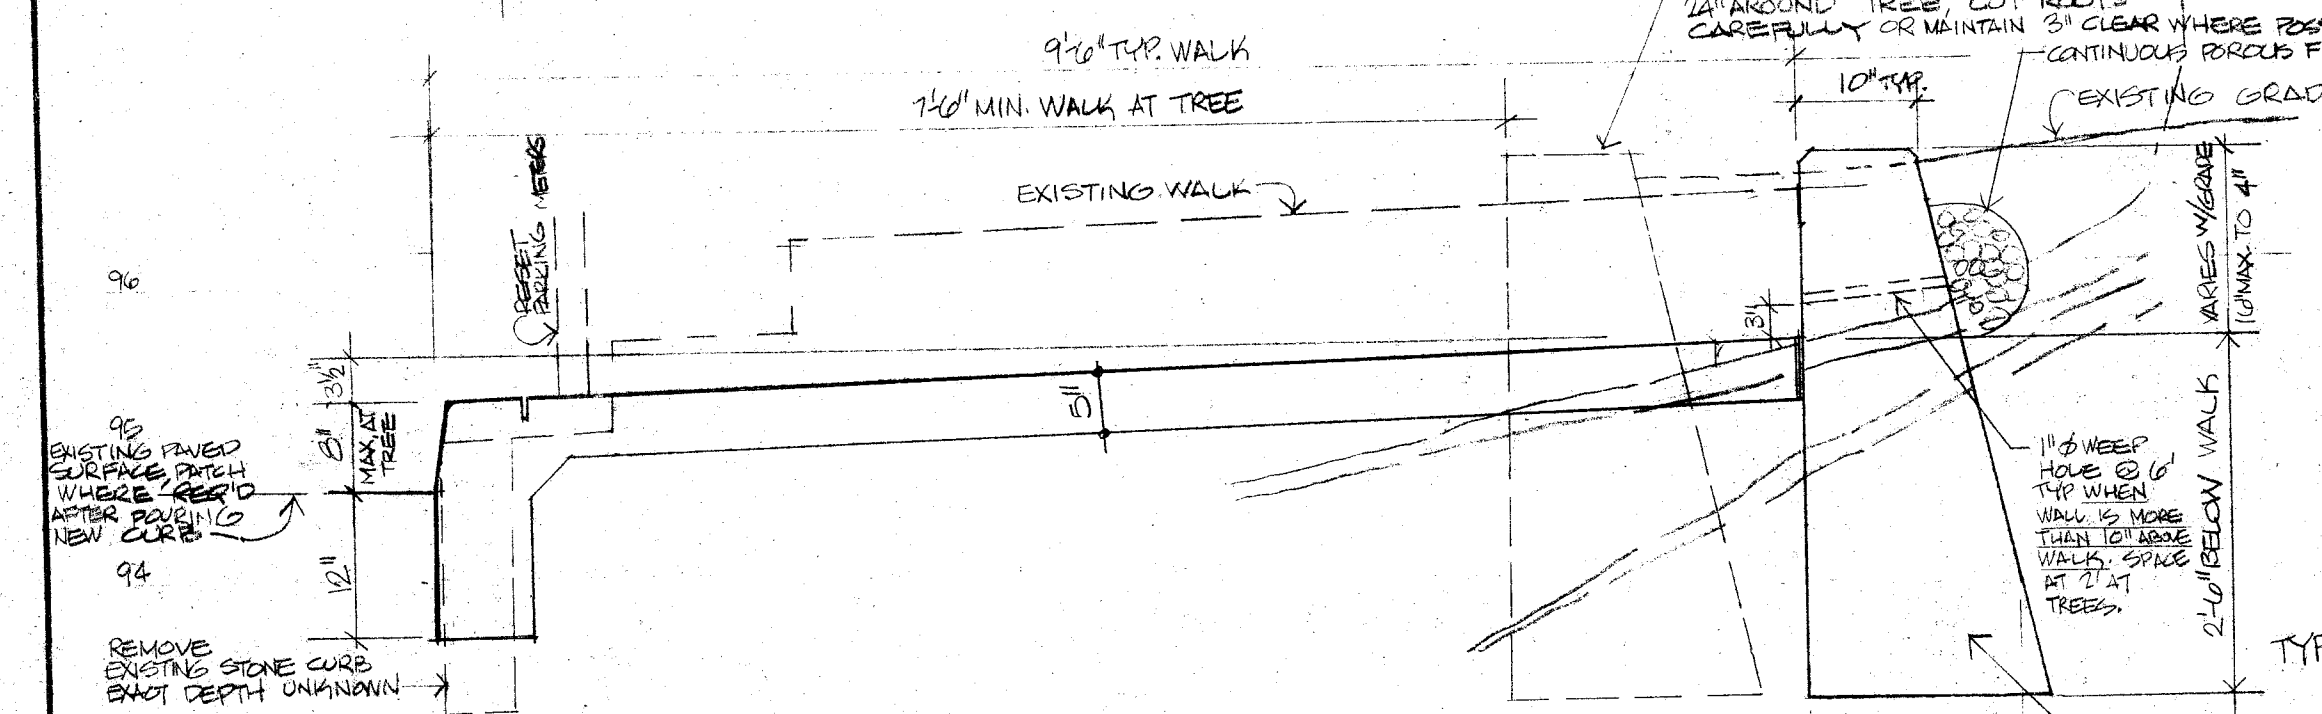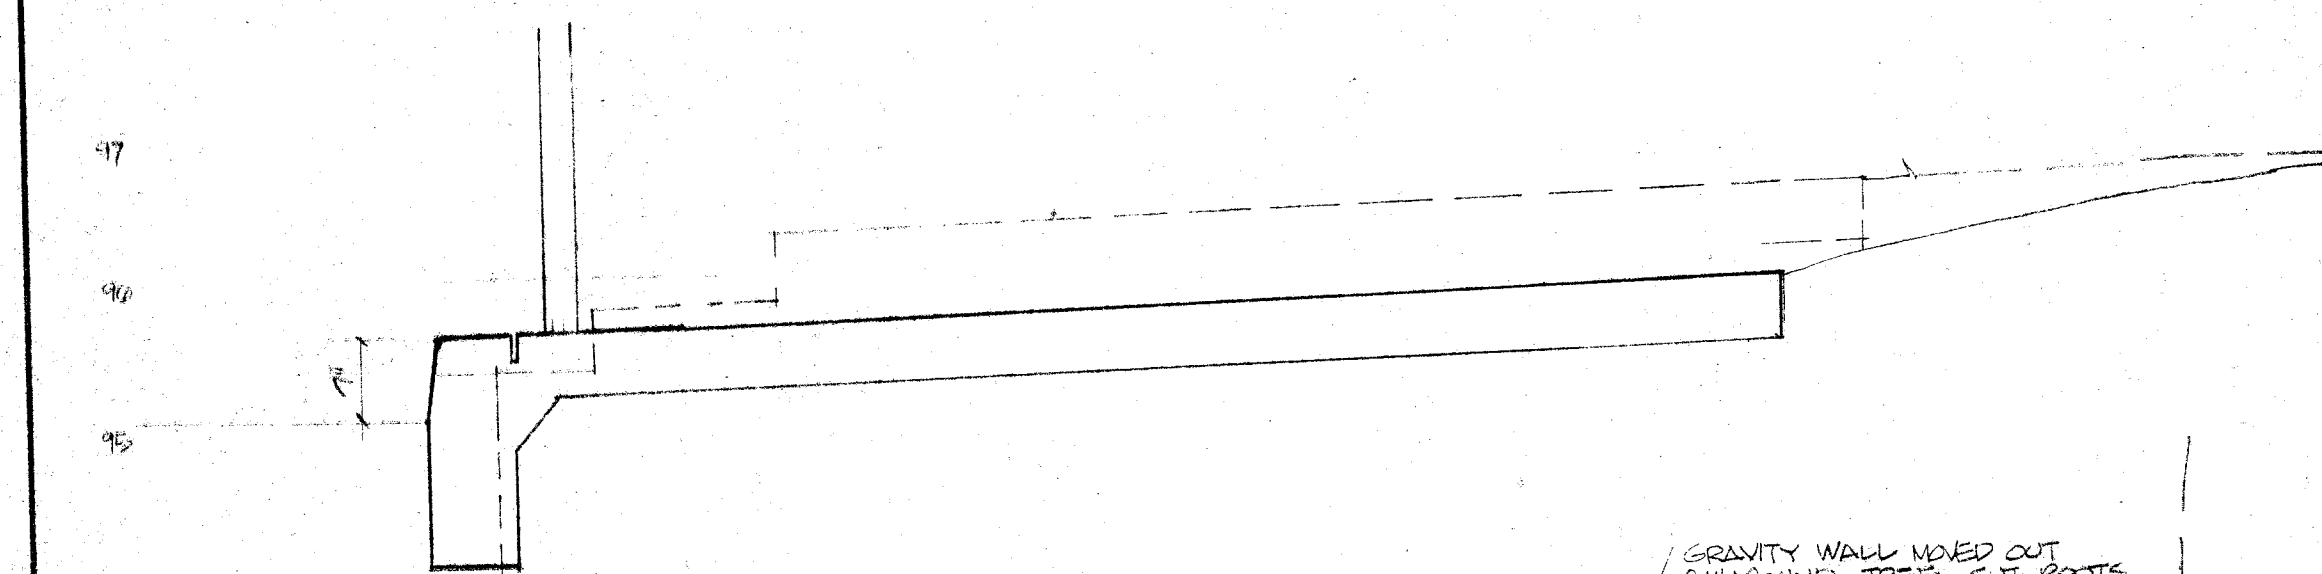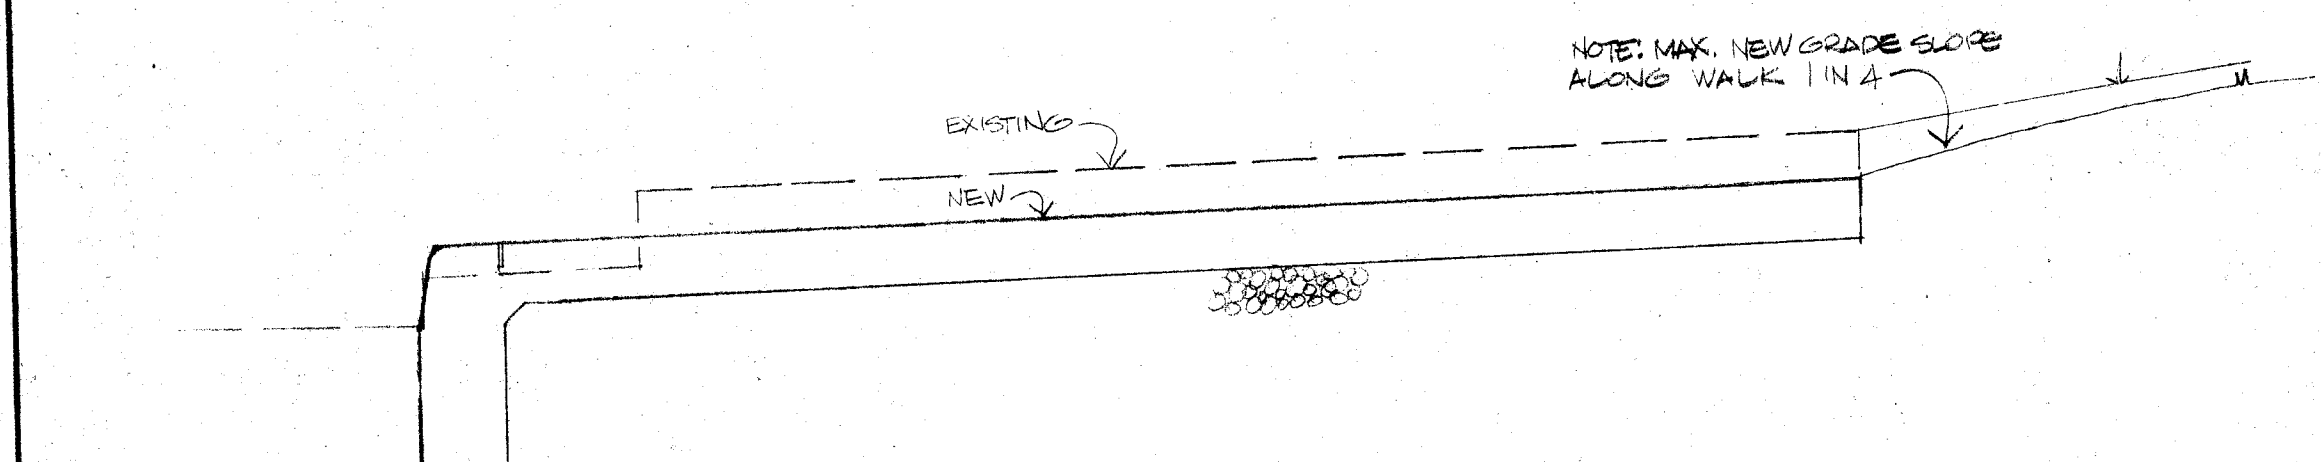

BULLETIN B-39
DUNCAN PLAZA CITY HALL PARK
MASSILLON MUNICIPAL GOVERNMENT CENTER


MALLALIEU
ROSS
ROBERTS
DOLL
AKRON - MASSILLON OHIO

Architects
AIA


COMM. 7420
7117
DATE 5-17-76
SHEET B-4

General Notes


- 1- ALL CIRCULATING SUPPLY & RETURN LINES AND FILTER SUPPLY & RETURN LINES TO PITCH FROM FOUNTAIN TO BUILDING FOR DRAINAGE
- 2- SUPPLY & RETURN PIPING TO BE "4040" SCHEDULE #40 GALVANIZED STEEL OR PVC SCHEDULE 80
- 3- WASTE LINES FROM DRAINS AT FOUNTAIN TO BE CAST IRON

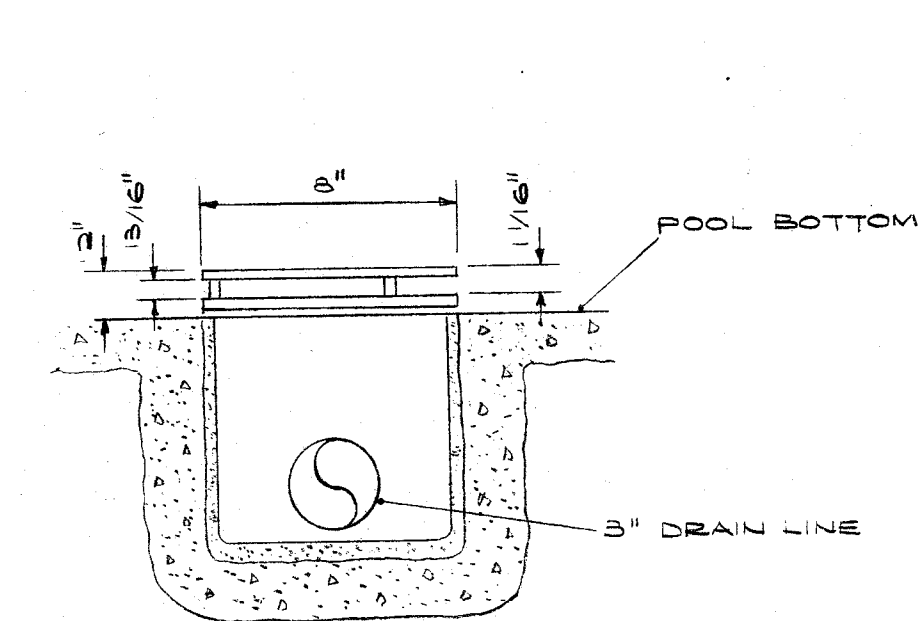


**Main Sump For
Circulating Pump**
NO SCALE

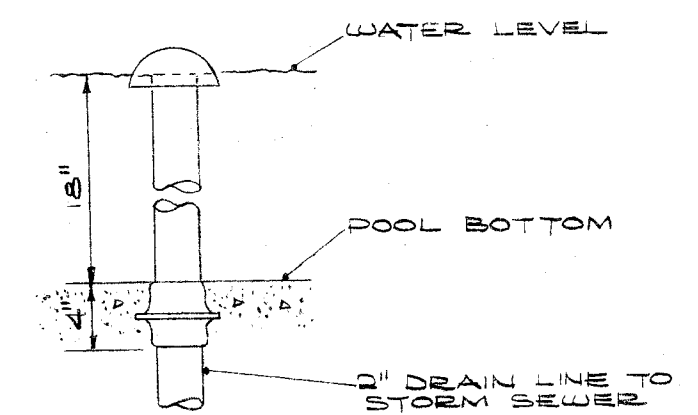


**Overflow
Drain**
NO SCALE

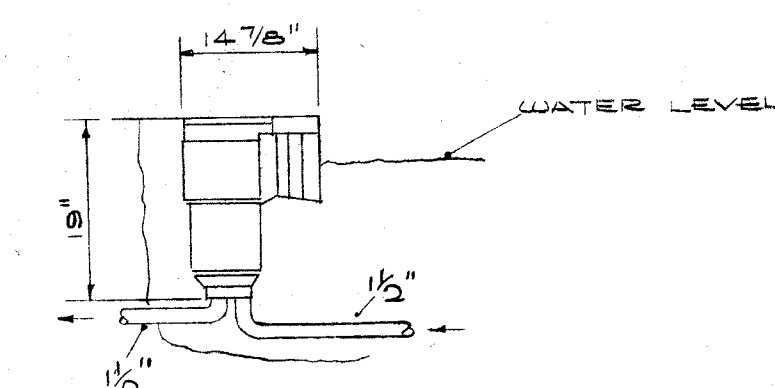

**Surface Skimmer
Filter System**
NO SCALE

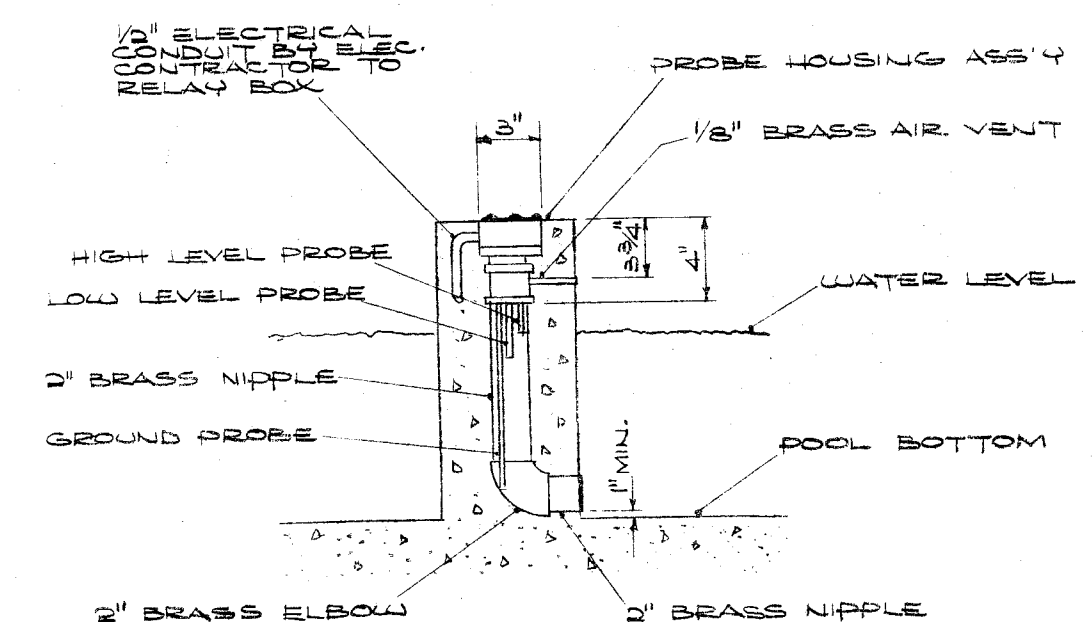


**Electric Water Level
Sensing System**
NO SCALE

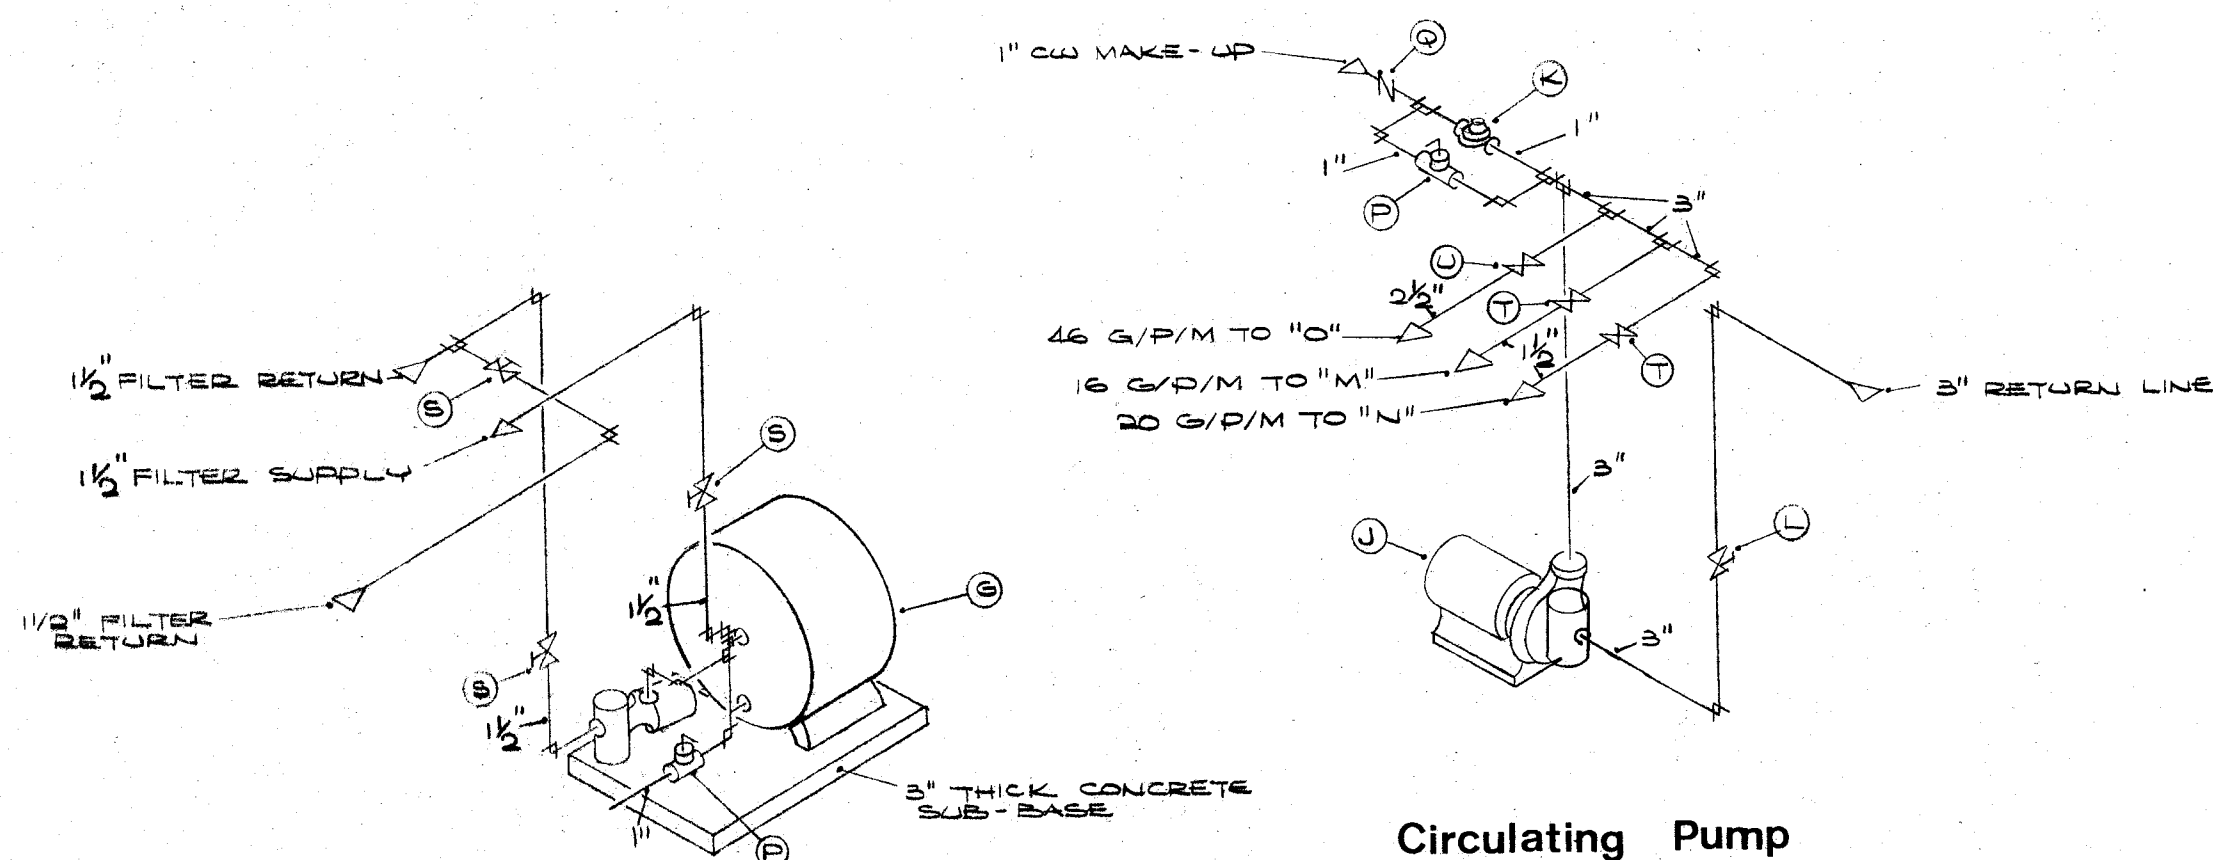



**Filter Piping
Detail**
NO SCALE

**Circulating Pump
Piping Detail**
NO SCALE

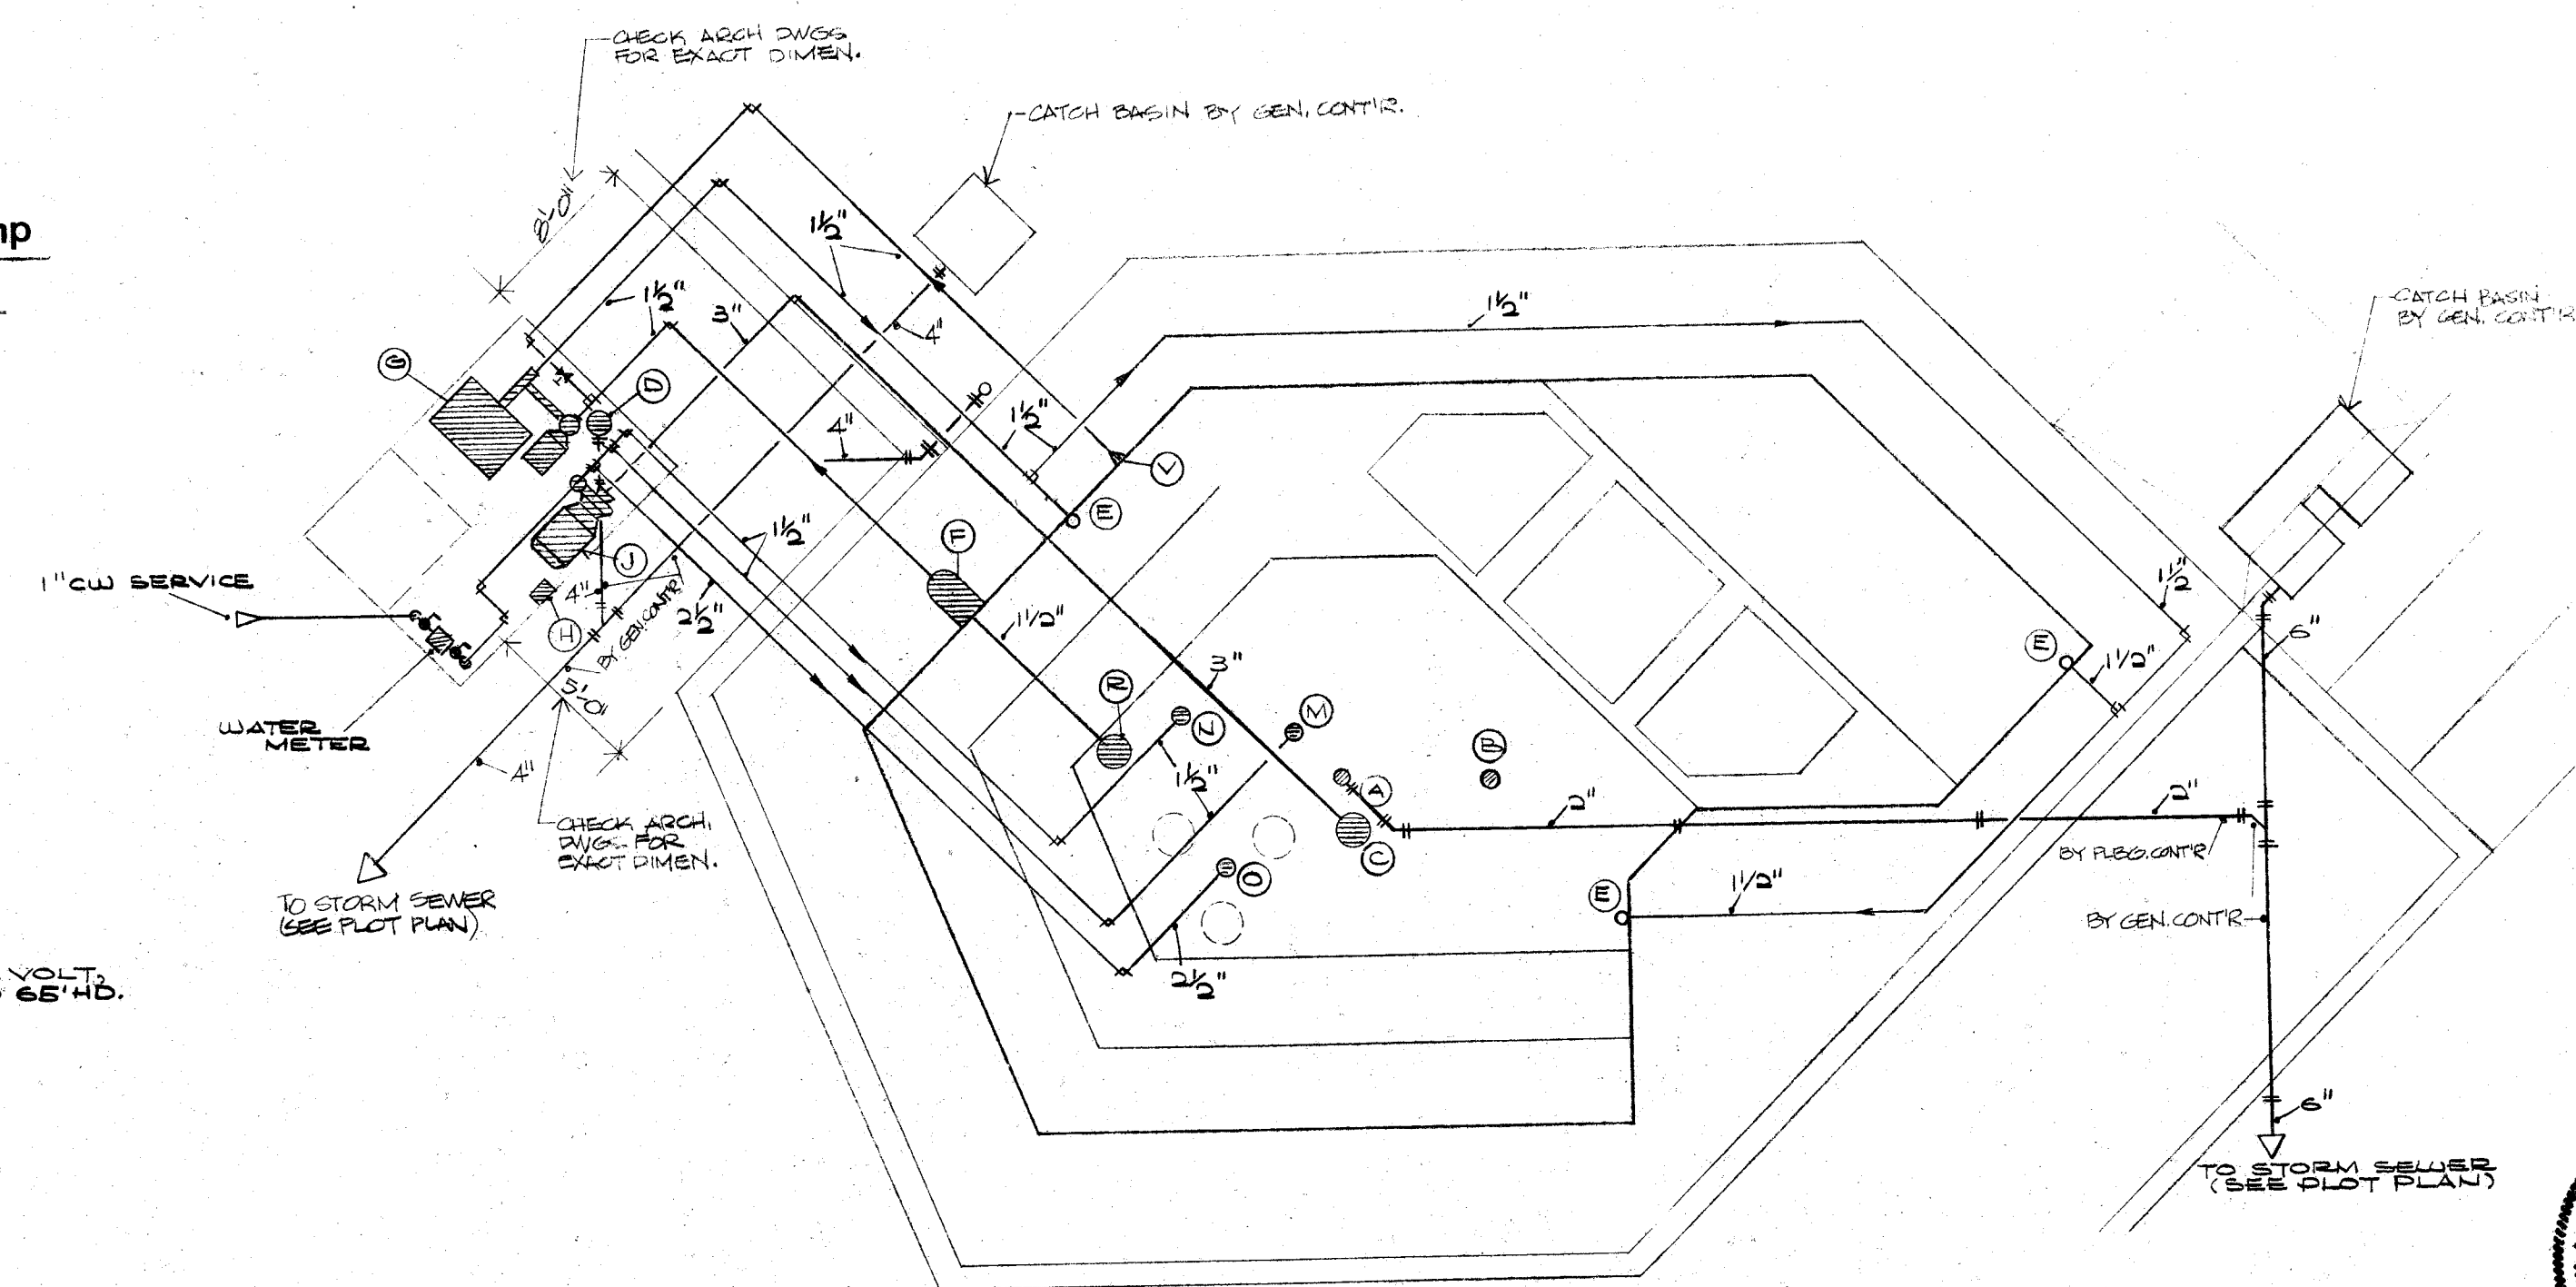

Fountain Plan
SCALE 1/4" = 1'-0"

SEE ARCHITECTURAL DETAILS FOR EXACT
LOCATIONS AND DIMENSIONS OF EQUIP-
MENT, FIXTURES, OPENINGS, AND OUTLETS

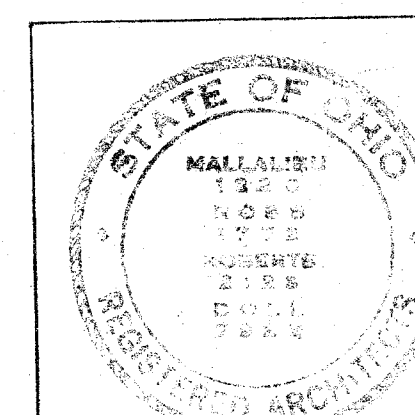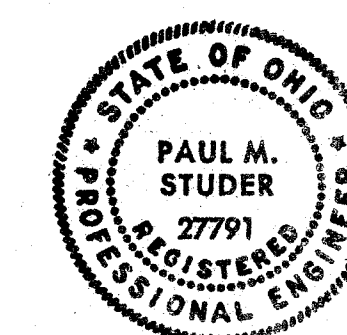

BULLETIN 3-29
DUNCAN CITY HALL
PLAZA PARK
MASSILLON MUNICIPAL GOVERNMENT CENTER

MALLALIEU
ROSS
ROBERTS
DOLL
AKRON - MASSILLON OHIO

Architects
MEMBER OF THE AMERICAN INSTITUTE OF ARCHITECTS AIA

DATE 5-7-70
SHEET 18
P.1

WATER CO. BLDG

1ST SAVINGS BLDG

OHIO BELL

CITY SIGNAL BLDG

ADMINISTRATION BLDG

CHARLES
AVE. S.E.

CITY HALL ST

GILTZ BLDG

WOOD FRAME BLDG

LAW & SAFETY BLDG.

POLICE PARKING

LINCOLN WAY EAST

FIRST ST. S.E.

TREMONT AVE. S.E.

EXTEND TO EXISTING UNDERGROUND
2" D. TO ROOM 8-013.

FIXTURES TO BE INSTALLED AFTER
SCULPTURE IS PLACED. LOCATE
AS DIRECTED BY ARCHITECT.

8" X 8" X 4" JUNCTION BOX
FOR P/S SYSTEM, IN B-022,
AS DIRECTED.

TO REMOVE
DALLASTS
ROOM B-002
(ORIGINAL
CONTRACT)

NOTE: MINIMUM PLAZA
FINISHES IDENTIFIED WITH
HEAVIER OUTLINE. REPLACE
AS DIRECTED WITH (SEE)

AREA OUTLINED TO BE
INCLUDED AS A SEPARATE
ITEM

EDGE OF
DUNCAN
PLAZA ITEMS

LOCATING
DIRECTED BY ARCH

MOUNT IN CONCRETE
POLE BASE
DIRECTED (TYPICAL)

NEW TIME CLOCKS 9,10,11,12
NEW CONTACTORS CON-6,7,8,
9,10,11
EXIST. "DP-1"
NEW PANEL "K"




POLICE CONTROL
CABINET
STUB IN VICINITY
OF CONTROL CAB.

12" X 12" X 3"
PULL BOX.

1/2" CONDUIT (FUTURE)
36" BURY D.P.I.

RISE UP TRAFFIC POLE
APPROX. 20 FT. AND
APPROX. 10 FT. WITH
APPROX. 10 FT. ENTRANCE CAB.

CHARLES
AVE. S.E.

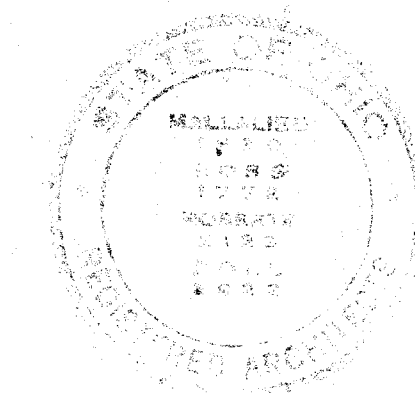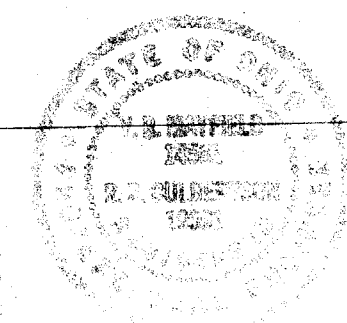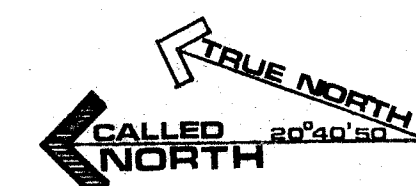

BULLETIN B-24
**DUNCAN / CITY HALL
PLAZA / PARK**

MALLALIEU
ROSS
ROBERTS
DOLL




AKRON - MASSILLON


MEMBER OF THE AMERICAN INSTITUTE OF ARCHITECTS

PLAN 1" = 20'

COMM: 7420
DATE: 05-1-79
SHEET: 15

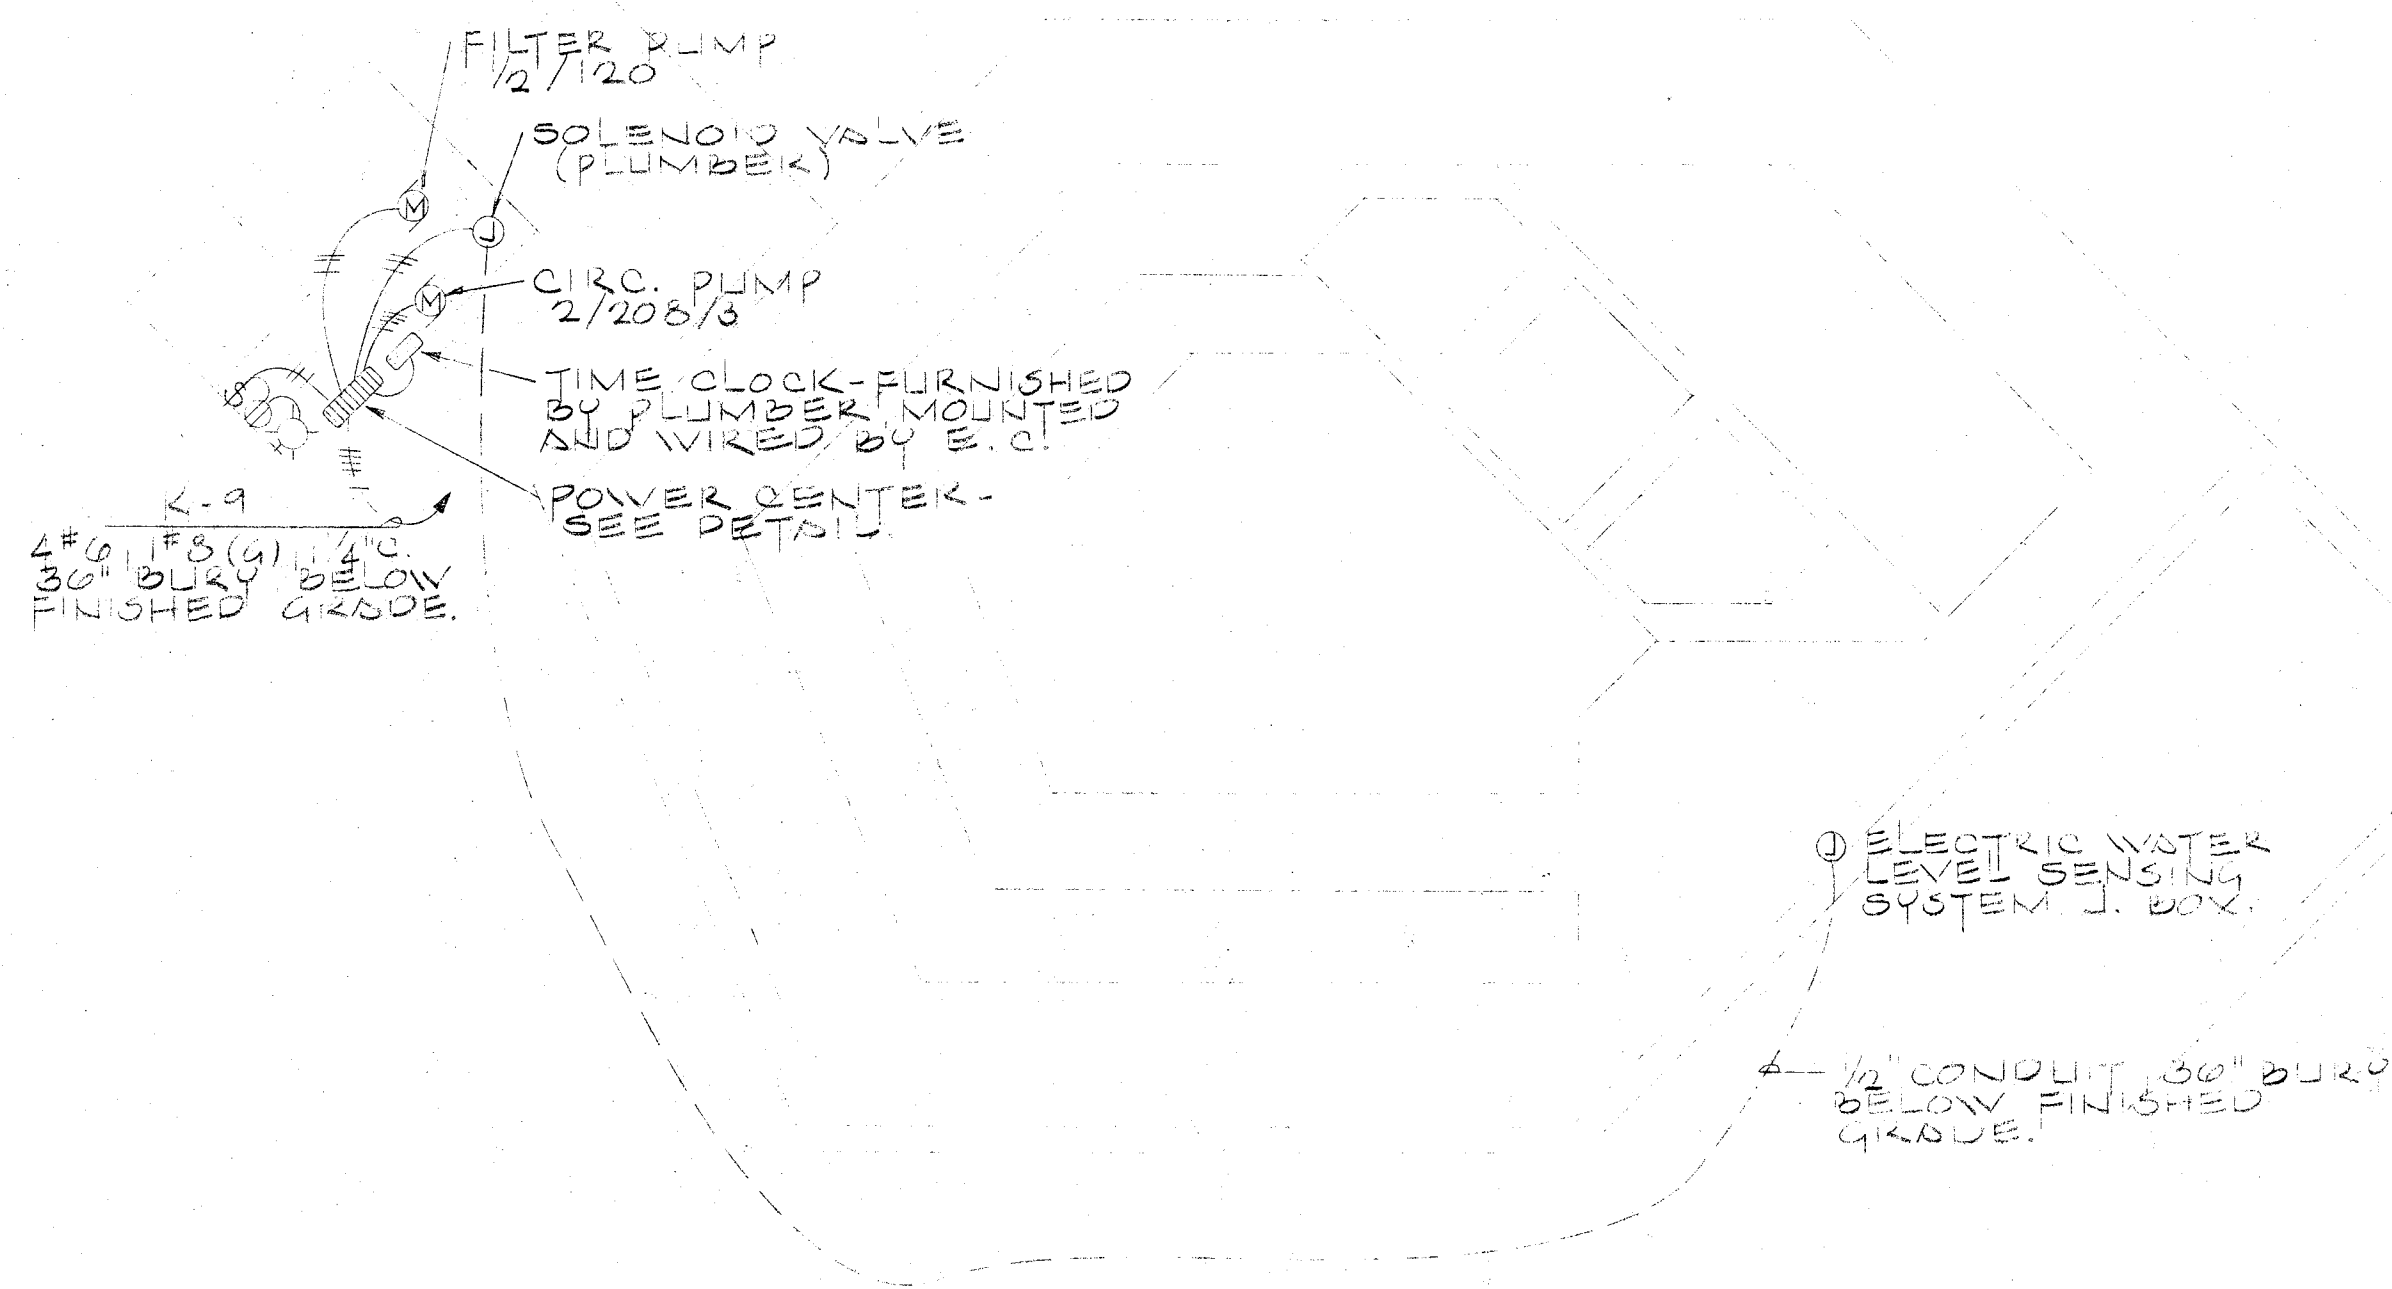

FOUNTAIN PLAN
SCALE 1/4" = 1'-0"

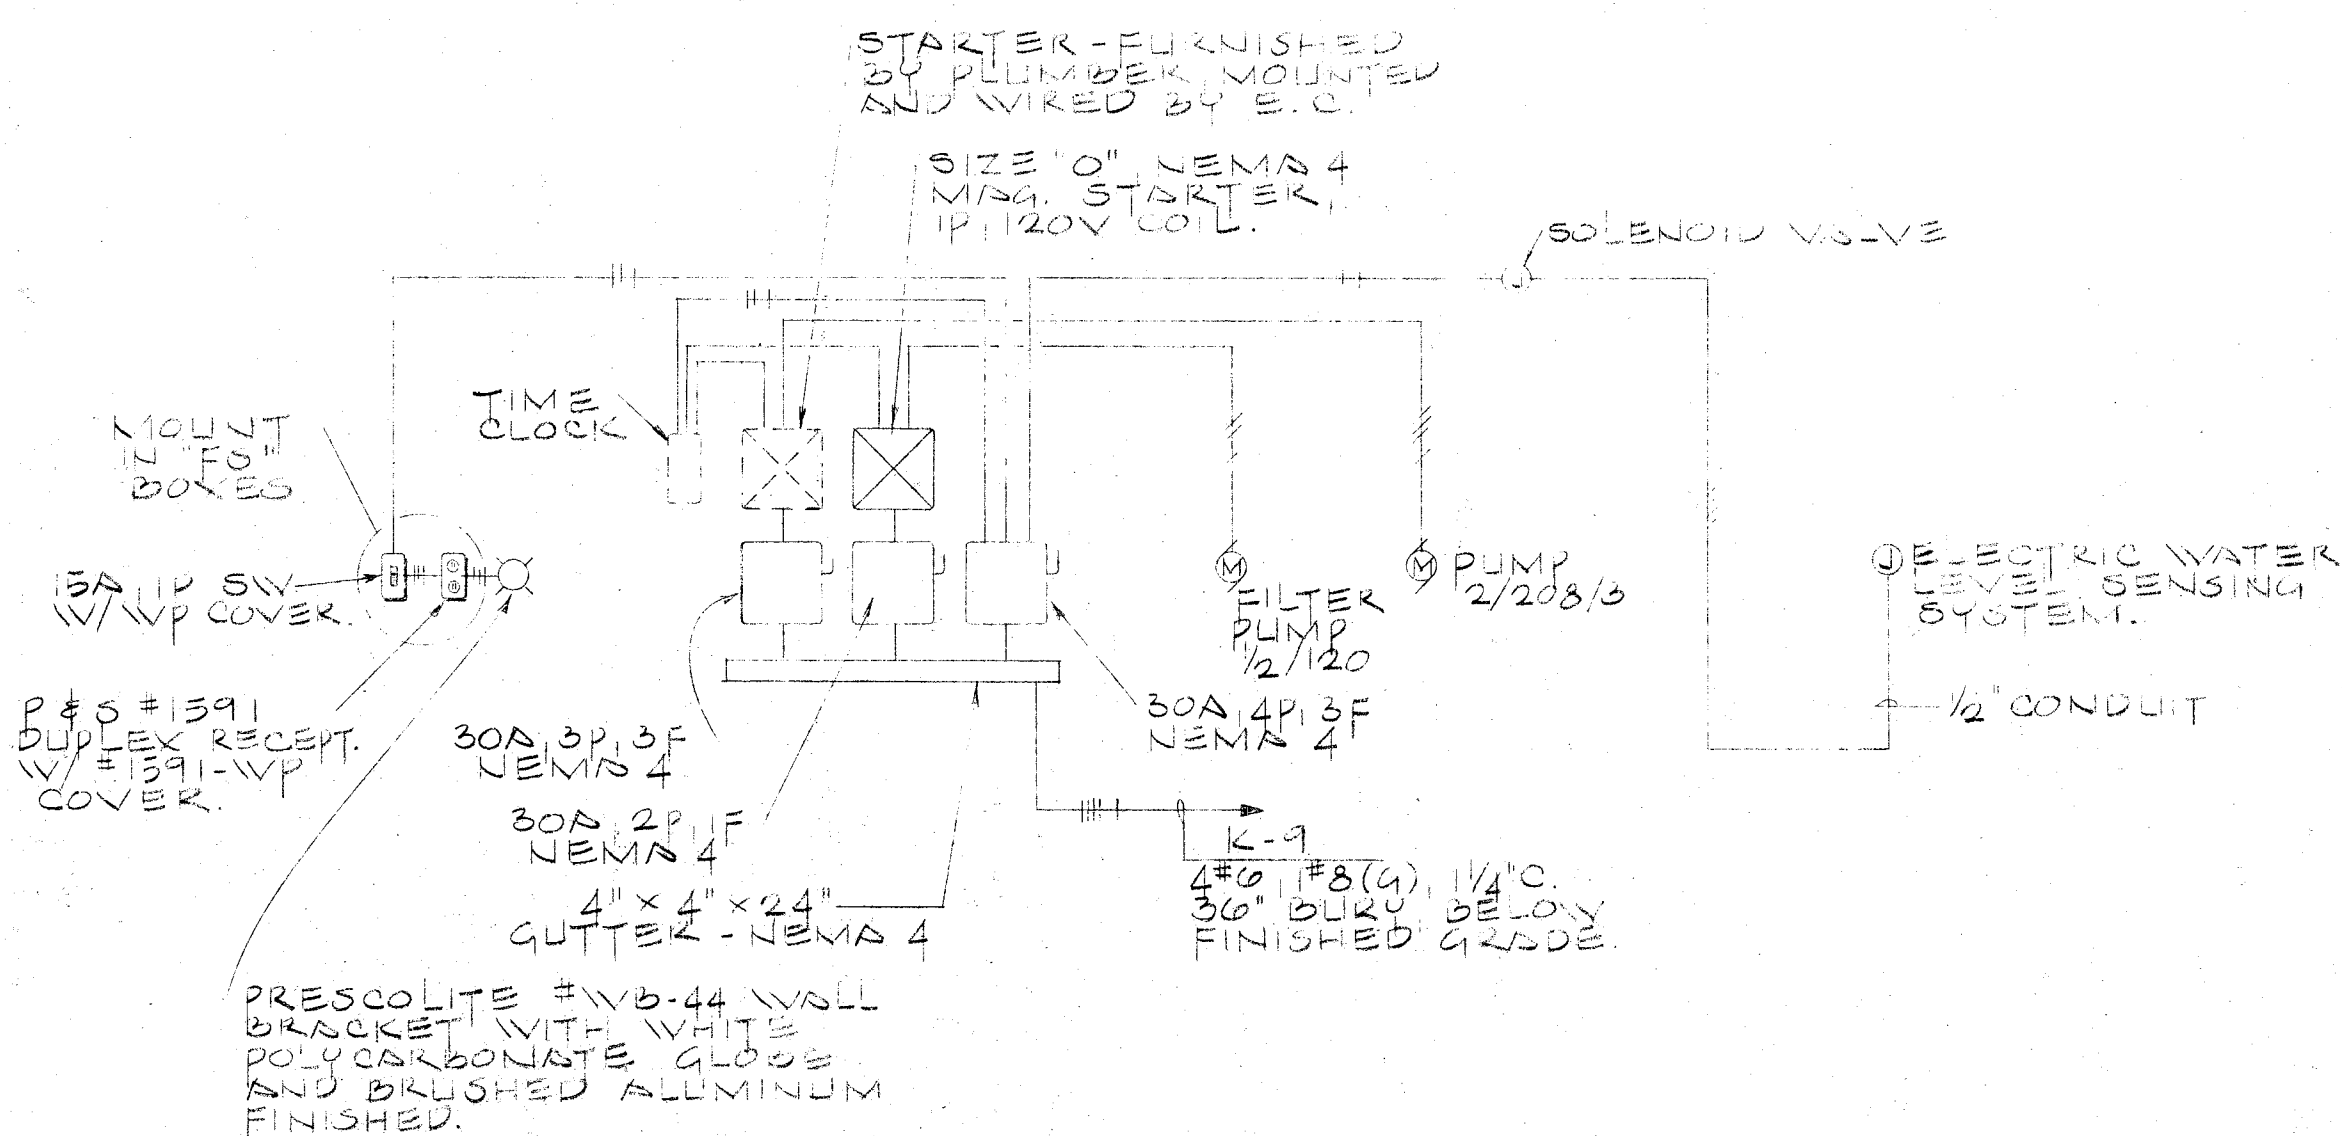


POWER CENTER FOR FOUNTAIN
NO SCALE

PANELBOARD SCHEDULE												*
LINE	TYPE	DESCRIPTION	PHASE	WIRING	NOTES	MOINS	BR. CT.	BK.	REMARKS			
1	INT. LBS. SUP.	120/208	3	4	ROOM 223	223	10	3	0	15	20	1 (3 GFI BKRS.)
2							4	0	0	4	20	2
3							0	0	0	1	30	3


ELECTRICAL SYMBOLS	
SYM.	DESCRIPTION
① MIKE	RASS AND SEYMOUR #4000/MSJ-40 VANDALPROOF ENCLOSURE WITH MIKE AND SPEAKER JACK.
① V/P 9-1	RUSSELL AND STOLL #REV2322 WEATHER-TIGHT DUPLEX RECEPTACLE MOUNTED ON CONDUIT STUD. PROVIDE GROUND TO PANELBOARD CIRCUIT BREAKERS BRANCH CIRCUIT.
★	PARAGON #4003-5 TIME CLOCK.
★	ALLEN-BRADLEY #702L-AD94, 4P, 120V COIL, ELECT. HELD.
★	ALLEN-BRADLEY #702L-AD92, 2P, 120V COIL, ELECT. HELD.

★ REQUIRED IDENTIFICATION TAGGING, SEE SPECS.


LIGHTING FIXTURE SCHEDULE			
SYM.	CAT. NUMBER	DESCRIPTION	LAMPS
DDD	2425-208-12-KG-A-FH 6	MOLDCAST LANDSCAPE CHANDELIERS, SQUARE WITH CLEAR COLORLESS ENCLOSURE WITH GOLD DISTRIBUTION REFLECTOR ON 1/2" POLE WITH ANODIZED ALUMINUM FINISH AND FLUSH HINGED BASE.	SEE DETAIL SHEET #E-7 1-H39-22 9P/DX (175W)
EEE	2425-208-12-KG-FH 6	MOLDCAST LANDSCAPE CHANDELIERS, SQUARE WITH CLEAR COLORLESS ENCLOSURE WITH GOLD DISTRIBUTION REFLECTOR ON 1/2" POLE WITH ANODIZED ALUMINUM FINISH AND FLUSH HINGED BASE.	SEE DETAIL SHEET #E-7 1-H39-22 9P/DX (175W)

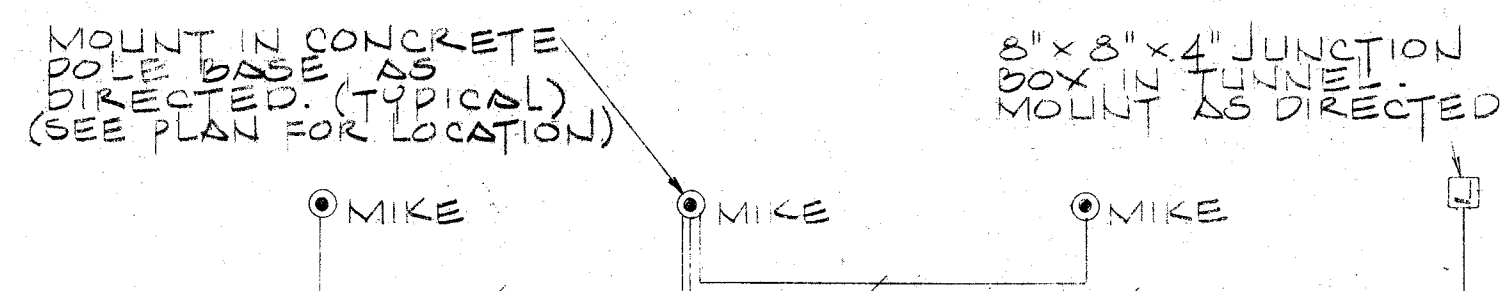



PUBLIC ADDRESS SYSTEM RISER DIAGRAM
NO SCALE

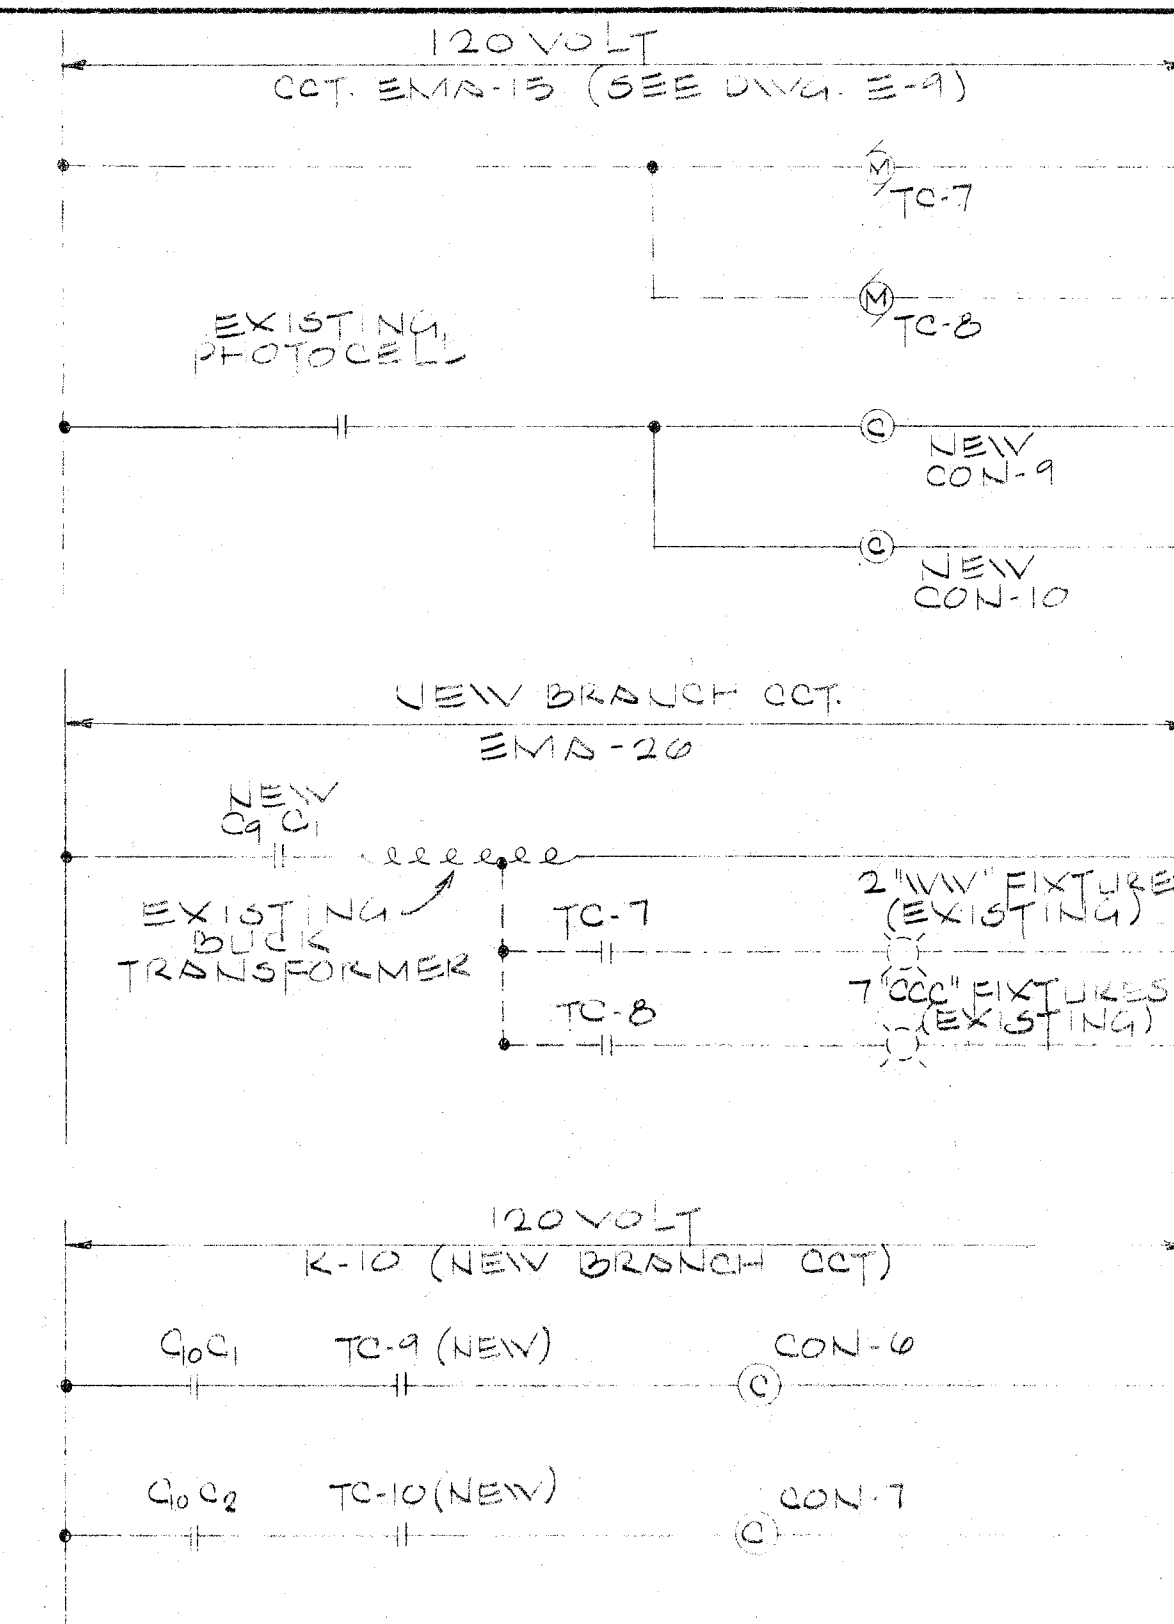

OUTSIDE LIGHTING CONTROL DIAGRAMS
NO SCALE

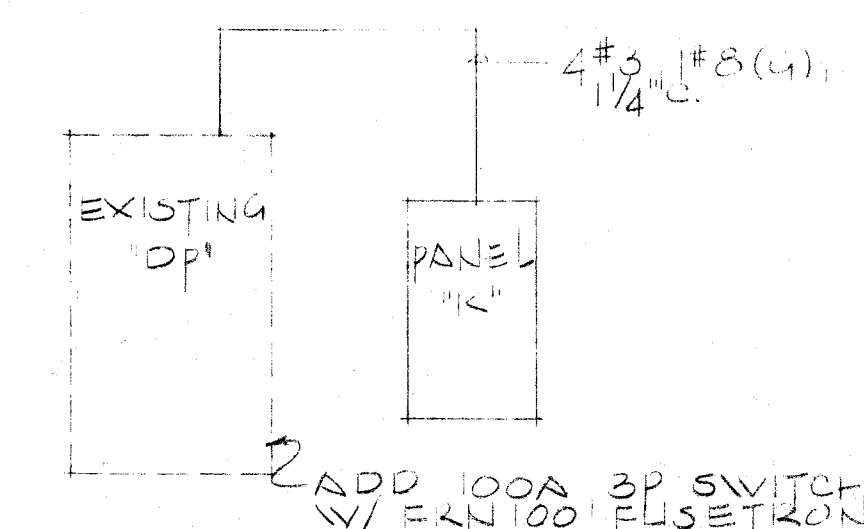

POWER RISER DIAGRAM
NO SCALE

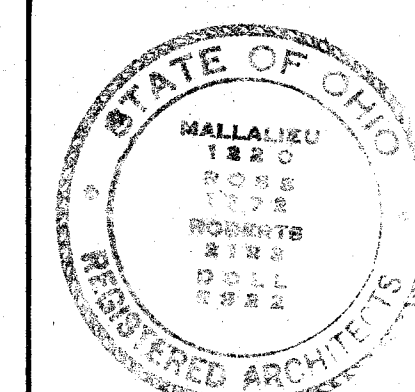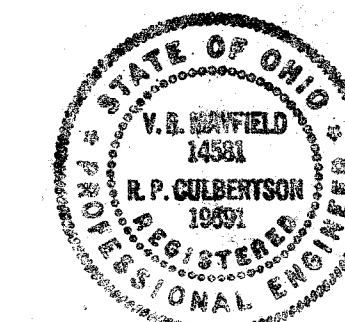

BULLETIN E-29
DUNCAN CITY HALL PLAZA / PARK

MALLALIEU ROSS ROBERTS DOLL
AKRON • MASSILLON OHIO
MEMBER OF THE AMERICAN INSTITUTE OF ARCHITECTS
ELECTRICAL SCHEDULES & DIAGRAMS

COMM. 14-20 7117
DATE 5.17.70
SHEET **RB E-2**

SEE ARCHITECTURAL DETAILS FOR EXACT LOCATION AND DIMENSIONS OF EQUIPMENT, FIXTURES, CONDUITS AND OTHERS.

NOTE: MINIMUM SIZE CONDUIT 3/4" AND MINIMUM SIZE WIRE #12 AWG UNLESS NOTED OTHERWISE.

