



DRAWING INDEX	
NO.	DESCRIPTION
PP-1	PLOT PLAN
A-1	FLOOR AND FOUNDATION PLAN
A-2	EXTERIOR ELEVATIONS
A-3	ROOF ELEVATION
A-4	SECTION THROUGH BUILDING
E-1	ELECTRICAL PLAN
P-1	INTER-LOCK TRUSS DATA

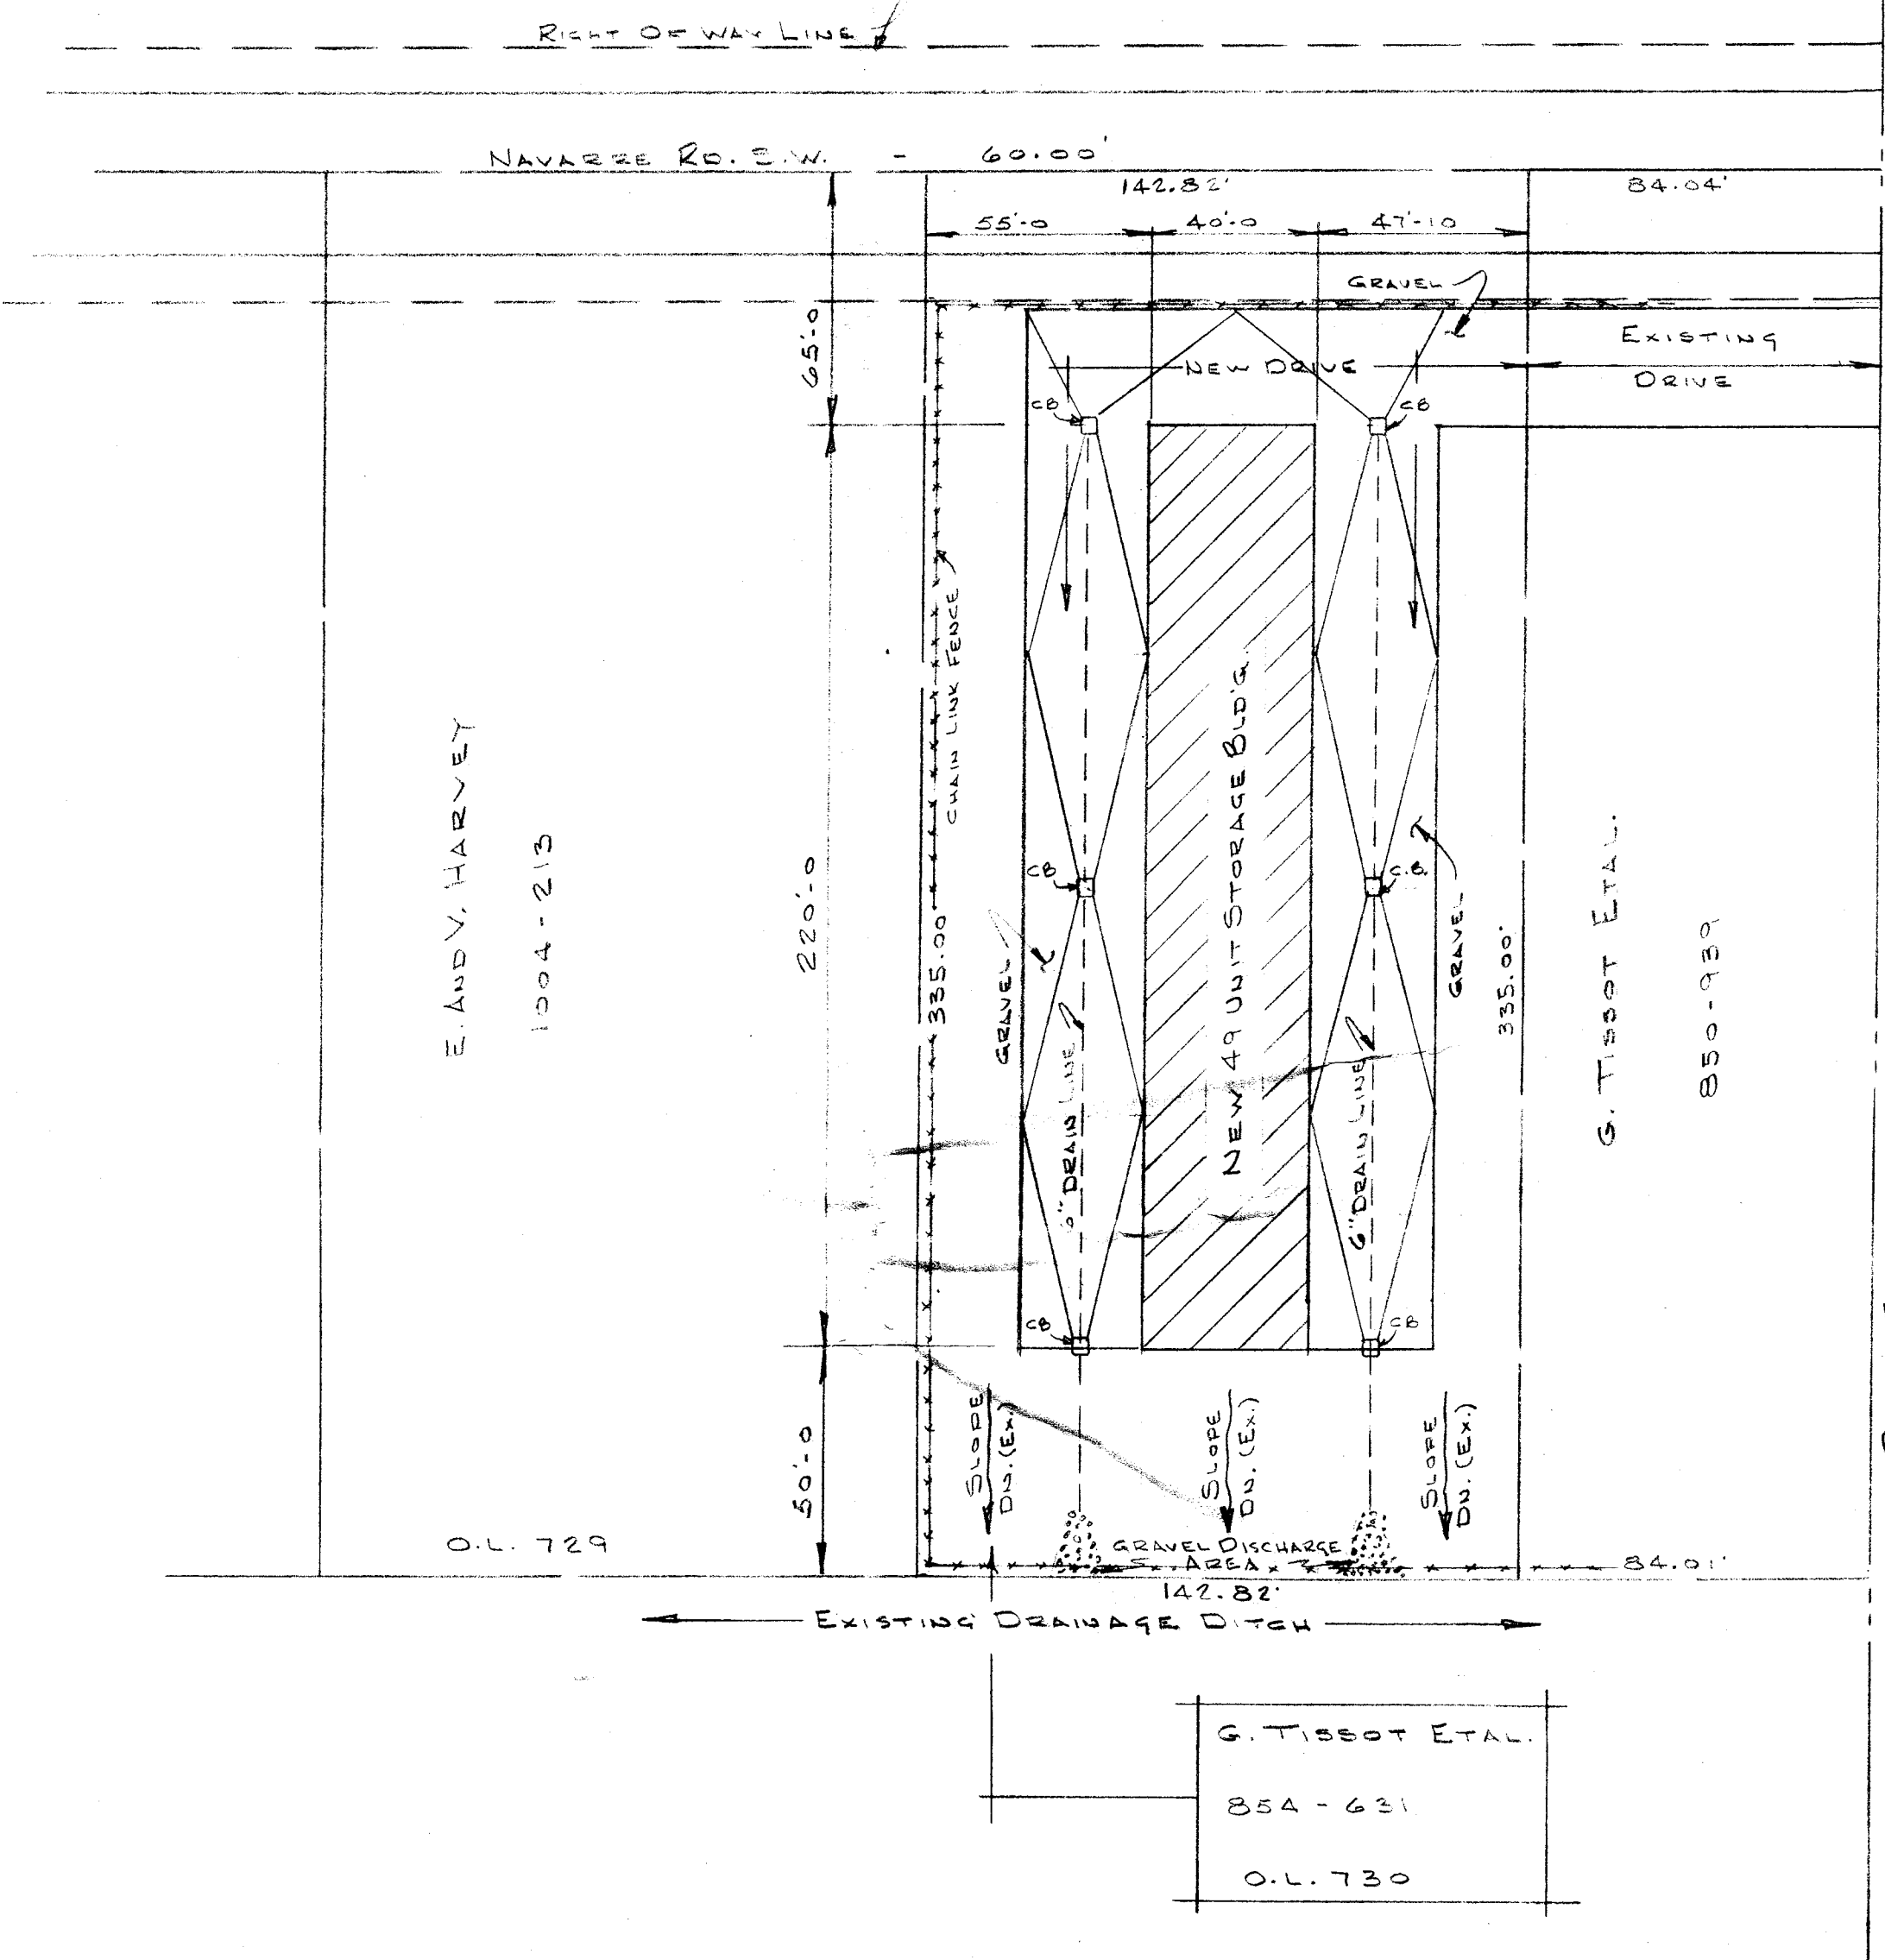


O.L. 727
S.39 AC.

PLOT PLAN
SCALE: 1"=40.0'


DESIGN LOADS AND GENERAL NOTATIONS	
1. CODE 2002 BOCA	4. ONE STORY BUILDING 8,800 S.F. - NEW
2. GRAVITY LOADS	5. USE GROUP S-2
A. DEAD LOADS	6. CONSTRUCTION TYPE B-2
1. ROOF 20 P.S.F.	7. ALL CONCRETE 3,000 P.S.I. @ 28 DAYS
B. LIVE LOADS	8. MEAN ROOF HGT. 15'-11"
1. ROOF 25 P.S.F.	9. 3,000 P.S.F. NET ALLOWABLE SOIL BEARING PRESSURE IS USED IN THE DESIGN OF THE FOUNDATIONS.
2. SLAB ON GRADE 100 P.S.F.	
3. SNOW LOAD	
1. GROUND SNOW LOAD 25 P.S.F.	
2. IMPORTANCE FACTOR 1.0	
3. EXPOSURE (Ce) 0.70	
4. THERMAL FACTOR (Ct) 1.00	
3. LATERAL LOADS	
A. WIND LOADS	
1. WIND SPEED 90 M.P.H.	
2. IMPORTANCE FACTOR 1.0	
3. EXPOSURE C	
B. SEISMIC LOADS	
1. SEISMIC USE GROUP 1	
2. SITE CLASS D	
3. BASIC SEISMIC FORCE RESISTANCE 0.14	
4. SDS 0.2	
5. SD 1.1	
6. ANALYSIS PROCEDURE DBDC 1617.4	
7. V = CSW	

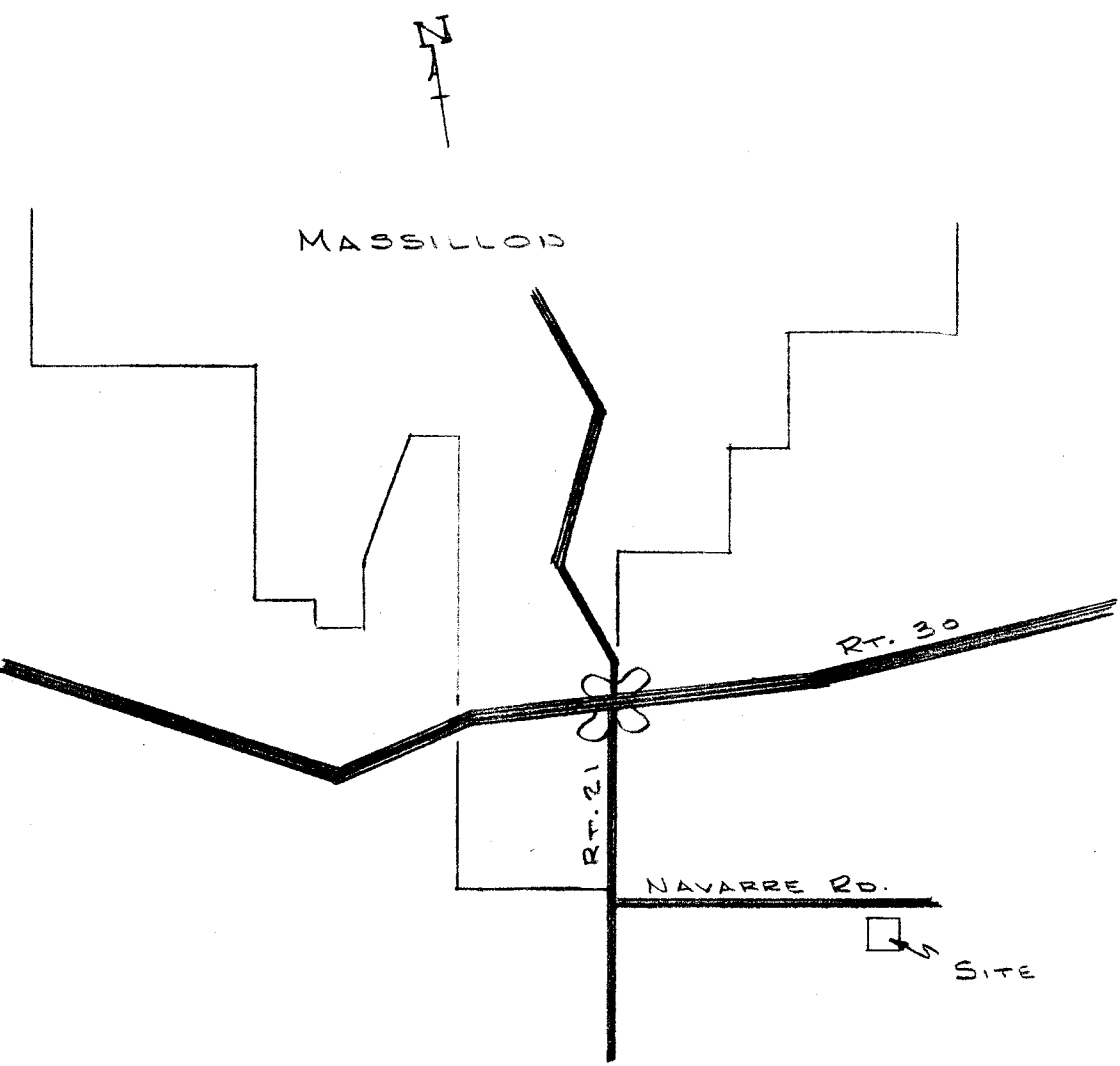


LOCATION MAP
N.T.S.

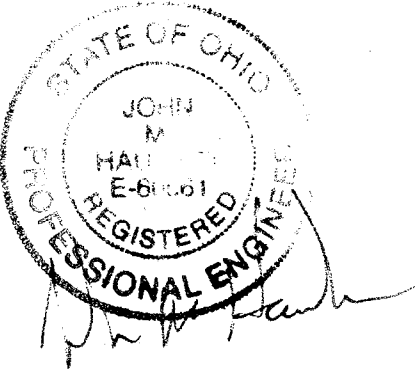


GENERAL ENTERPRISES - 1220 1 ST ST. N.E. MASSILLON, OHIO 44646 - (330) 837-4400	
NAVARRE ROAD STORAGE	
49 UNIT MINI STORAGE BUILDING	
PLOT PLAN	
DRAWN BY: R.E. GREENS DATE: 7.27.04 APP'D: [Signature]	
SCALE: 1"=40.0'	
MATERIAL: [Blank]	
DRAWING NO: PP-1	

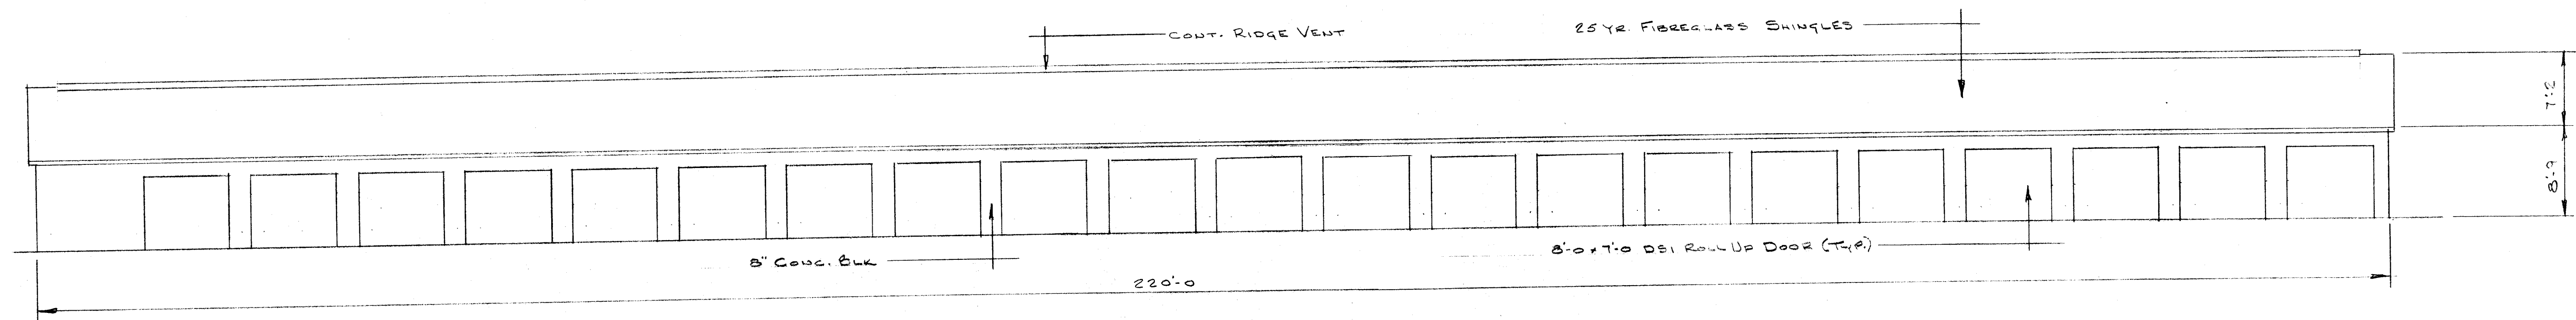


WEST ELEVATION
SCALE: $\frac{1}{8}'' = 1'-0''$

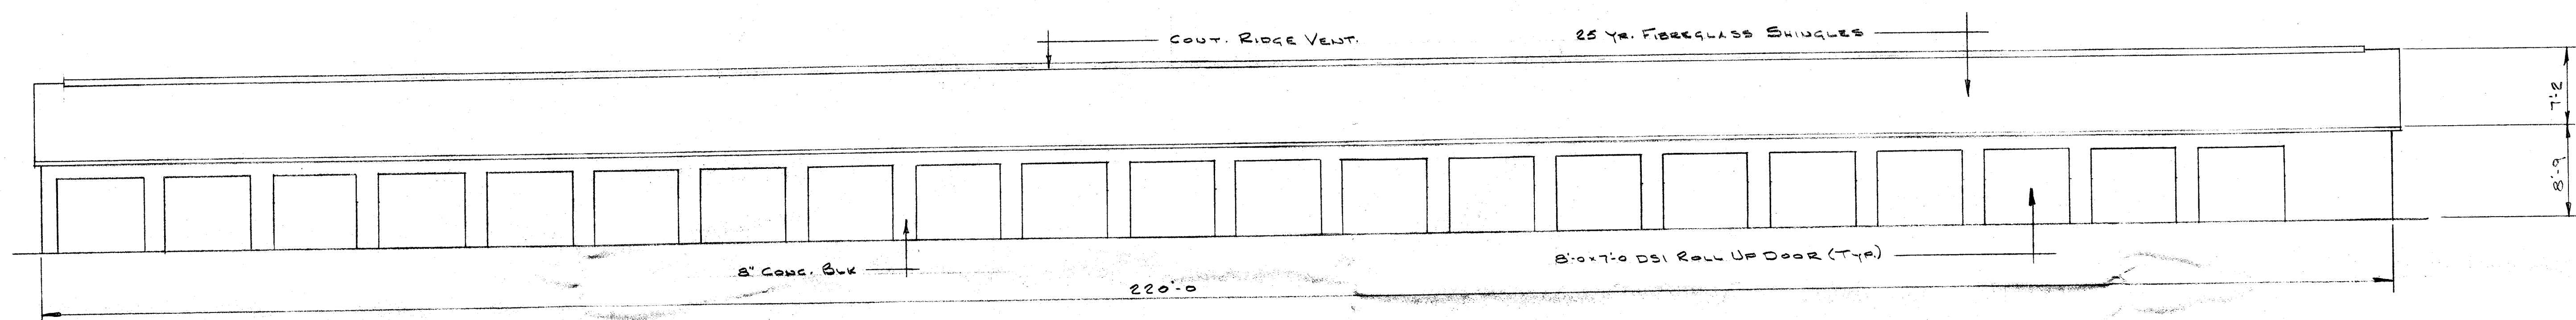


EAST ELEVATION
SCALE: $\frac{1}{8}'' = 1'-0''$

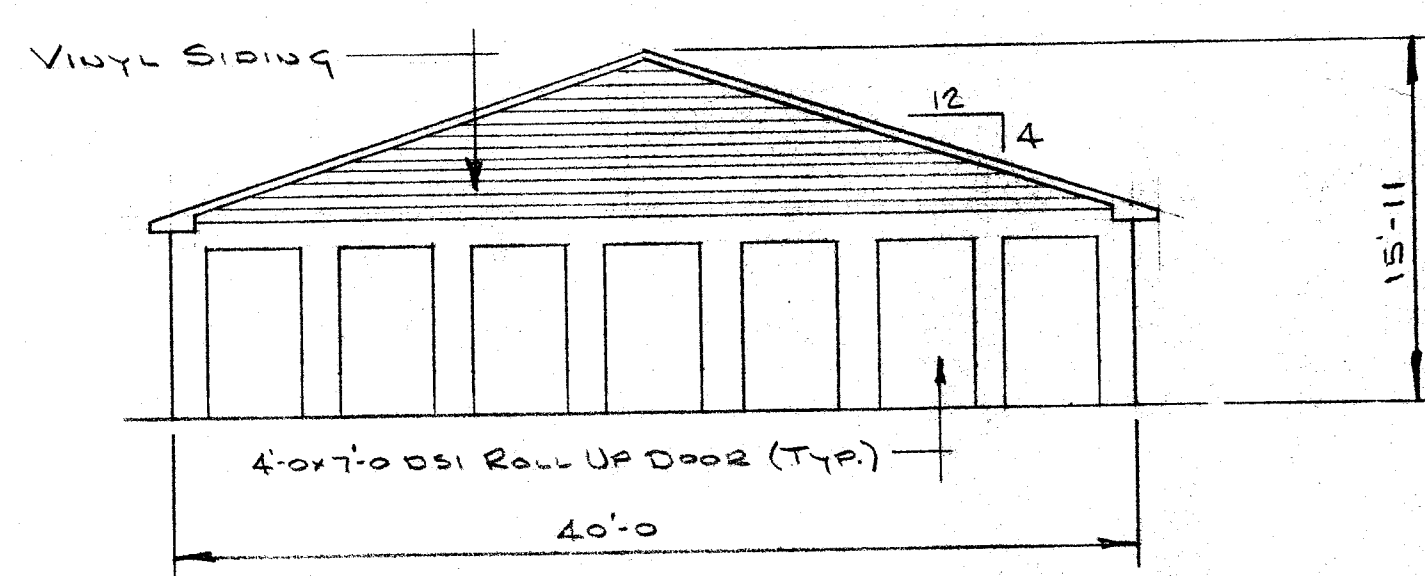


NORTH ELEVATION
SCALE: $\frac{1}{8}'' = 1'-0''$

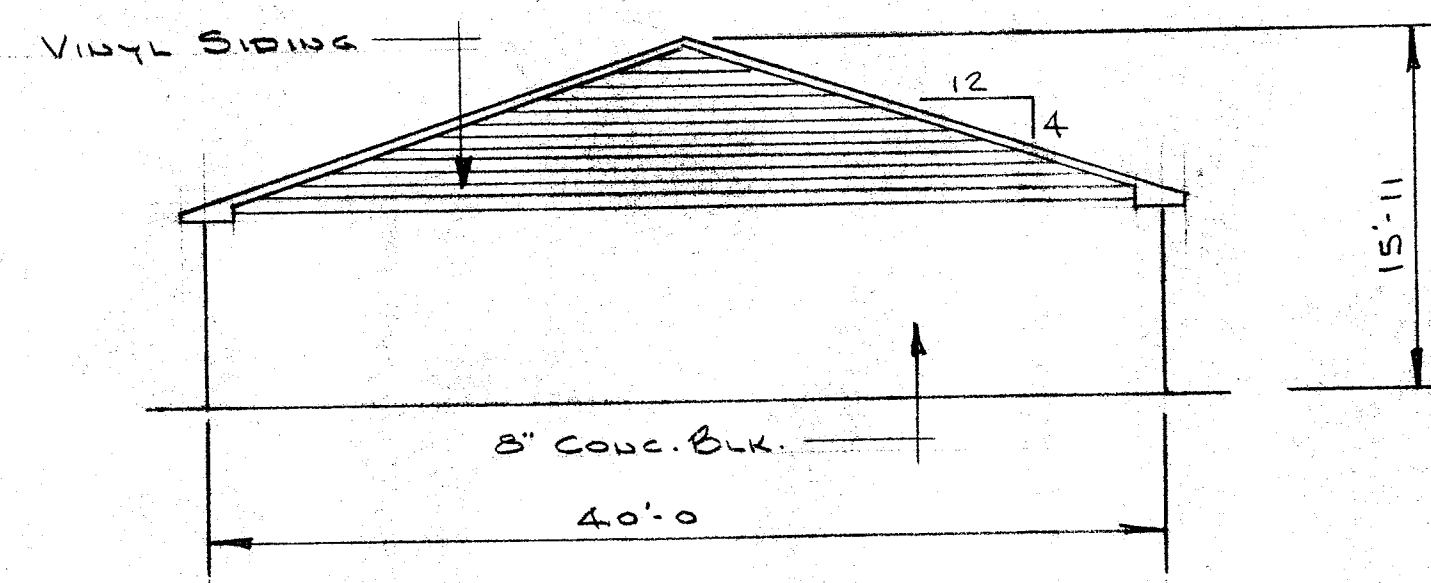


SOUTH ELEVATION
SCALE: $\frac{1}{8}'' = 1'-0''$

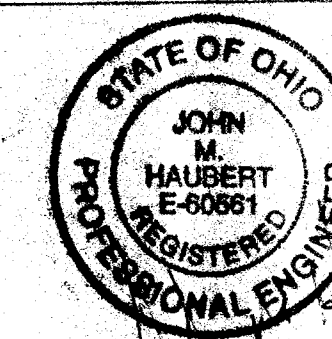

BENGAL ENTERPRISES - 1320 1 ST ST. N.E. MASSILLON, OHIO 44646 - (330) 837-4400				
TOLERANCES (EXCEPT AS NOTED)		REVISIONS		
NO.	DATE	BY	NAVARRE ROLD STORAGE 1558 NAVARRE RD. - MASSILLON, OHIO	
DECIMAL	1		49 UNIT MINI STORAGE BUILDING	
FRACTIONAL	2		EXTERIOR ELEVATIONS	
±	3		DRAWN BY E.E. BEERUS	SCALE $\frac{1}{8}'' = 1'-0''$
±	4		CHK'D 7-30-04	DATE
±	5		TRACED	APP'D
				DRAWING NO. A-2

 


NOTE:
5/8" x DRYWALL - TIGHT TO
STRUCTURE - TAPE JOINTS
TYP. ALL DRAFT STOPS

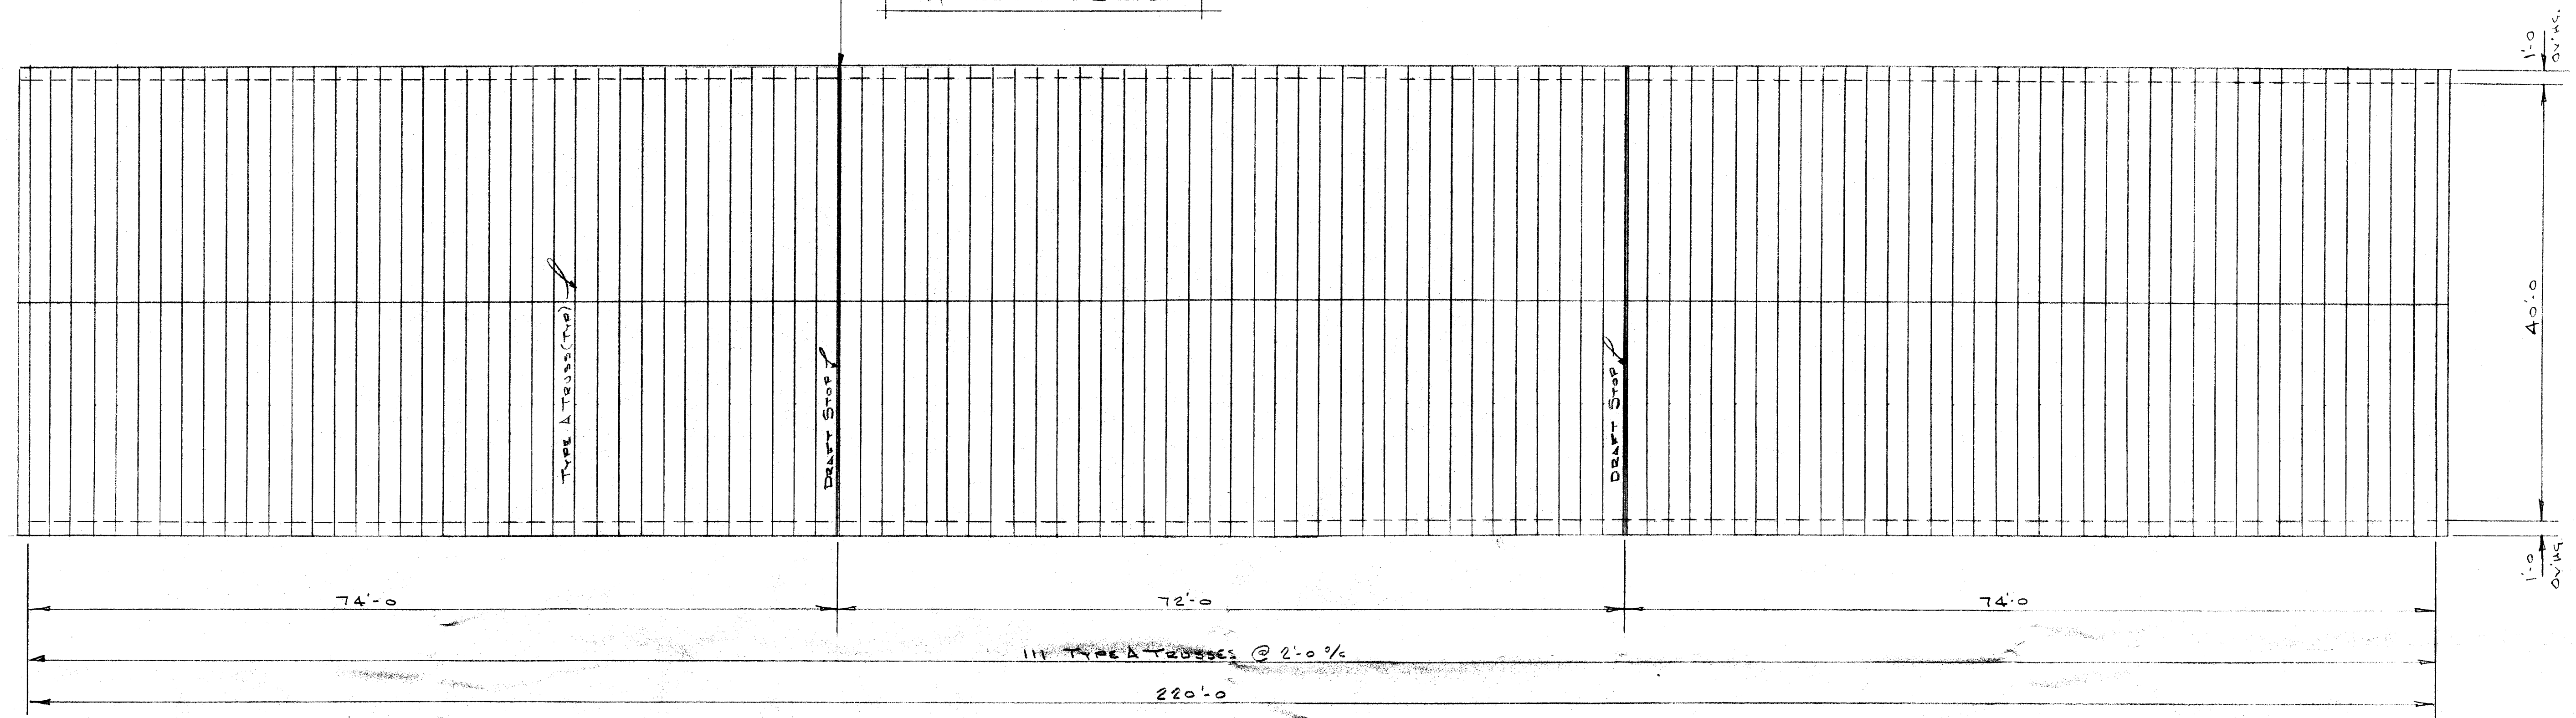


ROOF FRAMING PLAN

SCALE: 1/8" = 1'-0"

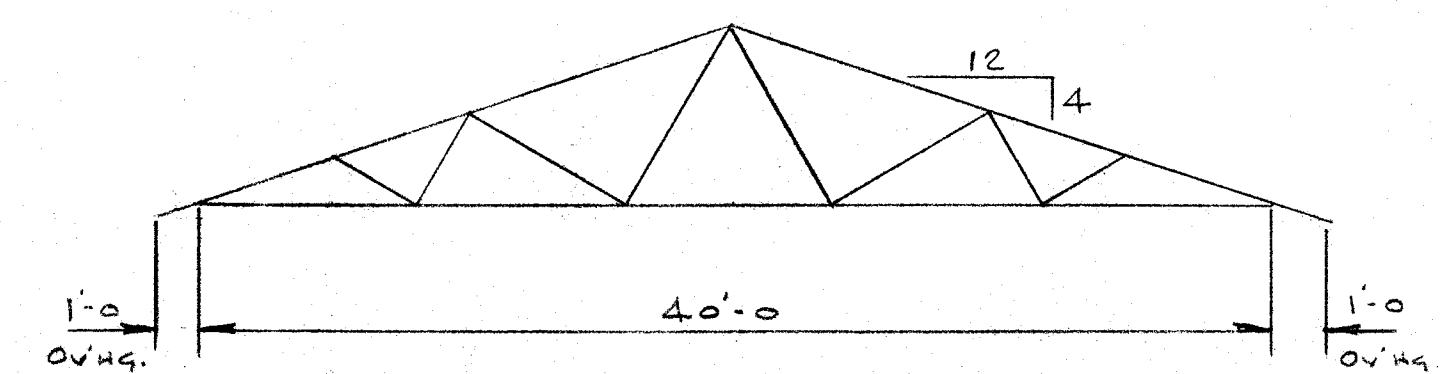


TRUSS (TYPE A)


N.T.S.
(111 REQUIRED)

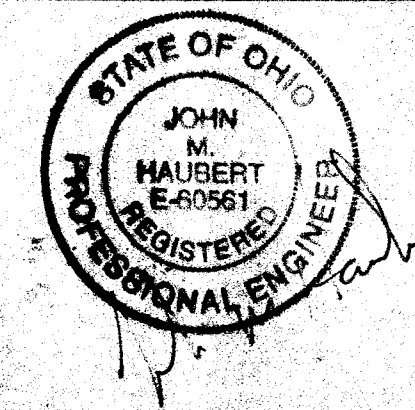


BENGAL ENTERPRISES - 1520 1ST ST. N.E. MANSFIELD, OHIO 44906 - (330) 837-4400			
TOLERANCES (EXCEPT AS NOTED)		REVISIONS	
DECIMAL	1	NO.	DATE
FRACTIONAL	2	BY	DATE
ANGULAR	3	DATE	DATE
	4	DATE	DATE
	5	DATE	DATE
	6	DATE	DATE
	415	DATE	DATE

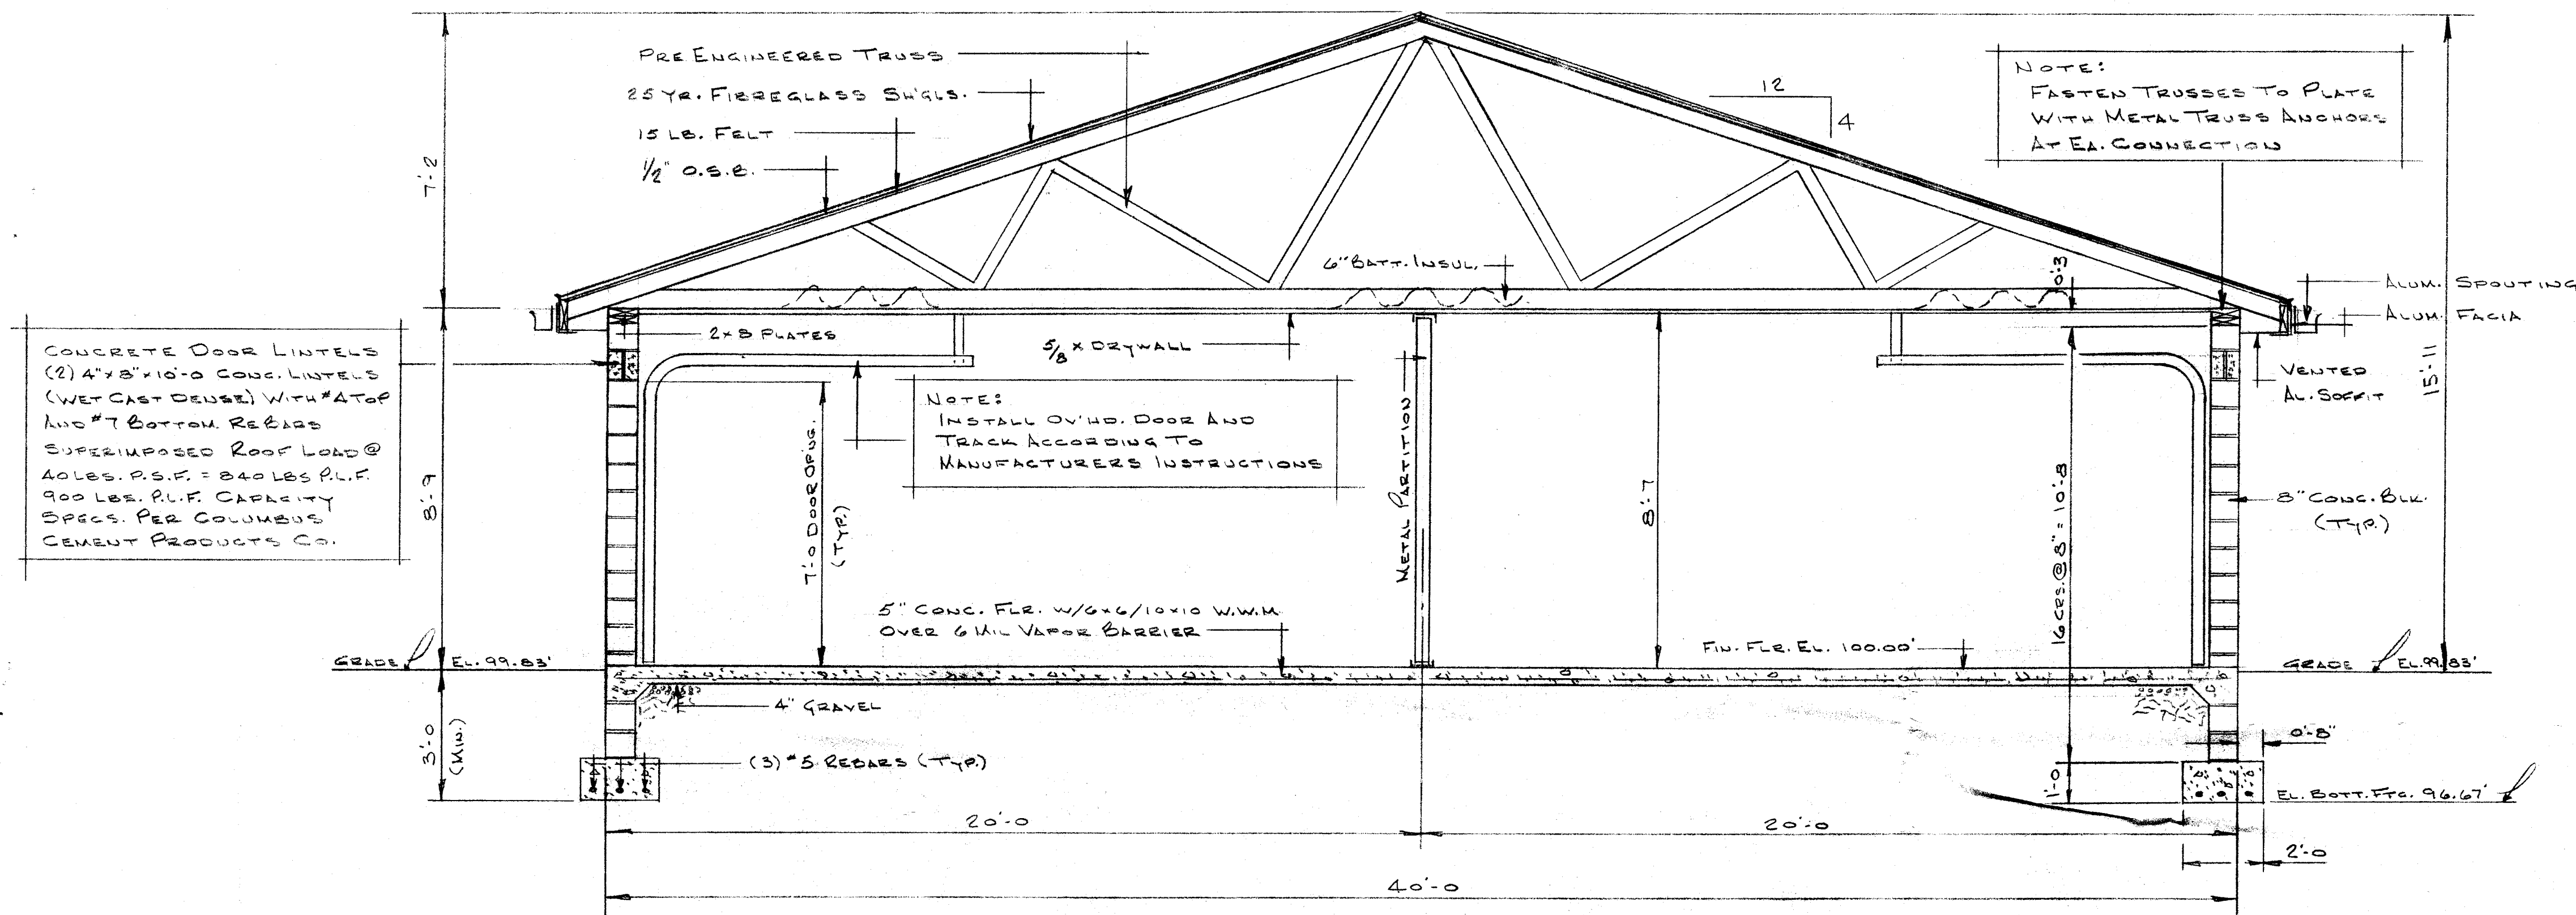

SECTION A-A (SHEET A-1)
SCALE: 3/8" = 1'-0"

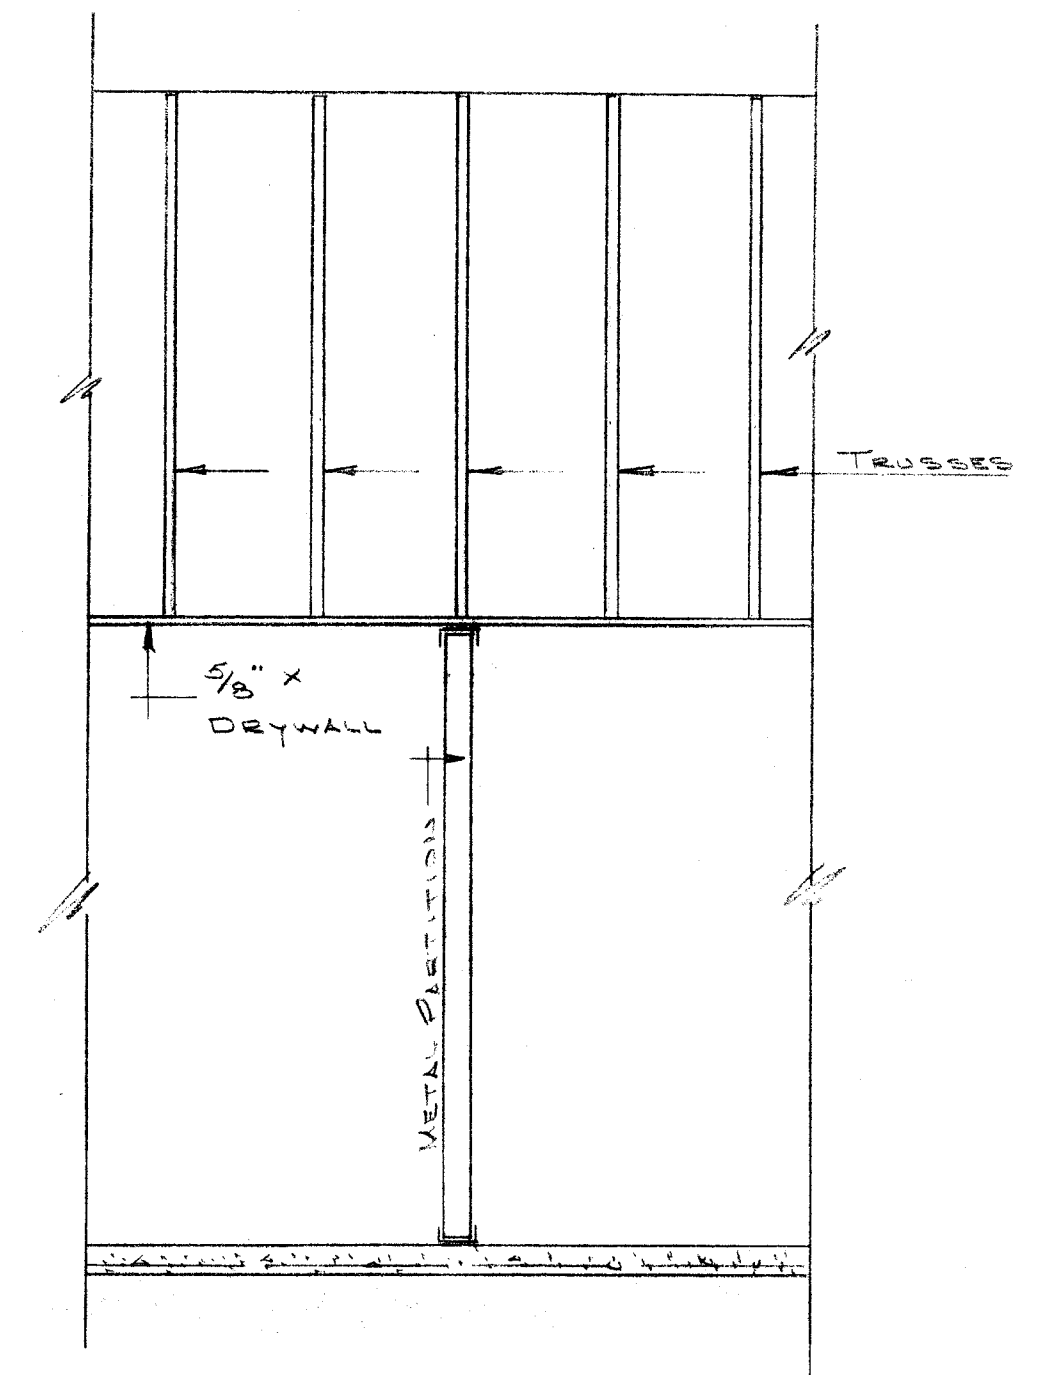


SECTION B-B (SHEET A-1)
SCALE: 3/8" = 1'-0"

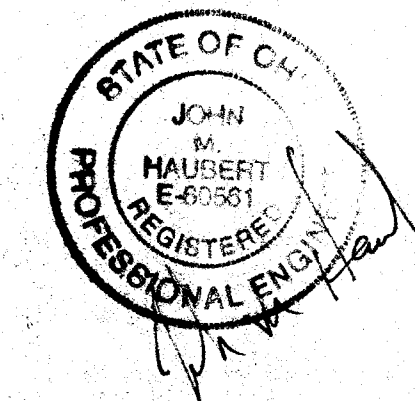

BENGAL ENTERPRISES - 1320 1ST ST. N.E. MASSILLON, OHIO 44646 - (330) 837-4400					
TOLERANCES (EXCEPT AS NOTED)		REVISIONS			
DECIMAL	1	NO.	DATE	BY	NAVARRE ROAD STORAGE 1558 NAVARRE RD. - MASSILLON, OHIO
FRACTIONAL	2				49 UNIT MINI STORAGE BUILDING SECTIONS TWO, BLDG.
ANGULAR	3				DRAWN BY F.E. GREGG
	4				SCALE 3/8" = 1'-0"
	5				DATE
					DRAWING NO.
					A-4

N

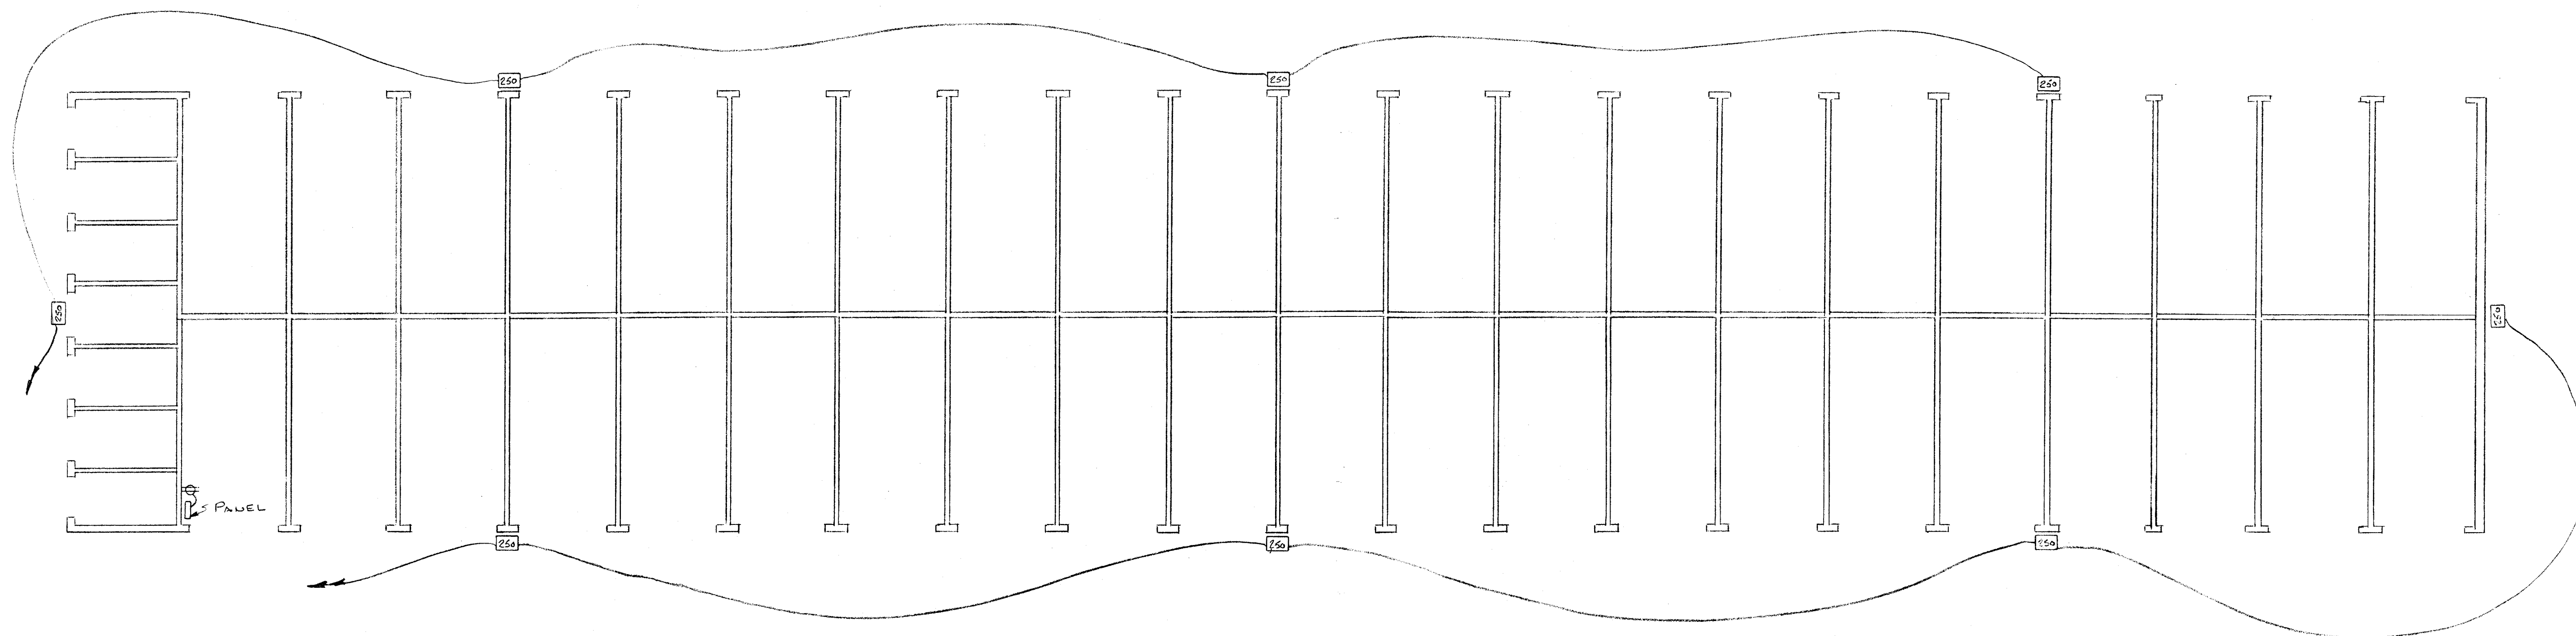

ELECTRICAL PLAN


SCALE: 1/8" = 1'-0"

FIXTURE SCHEDULE

- 250 WATT MH WALL PACK W/ PHOTO CELL
- DUPLEX RECEPTACLE @ PANEL ONLY


WIRING METHODS

- EMT ALL AREAS
- ALL WIRE TO BE #12 GA. COPPER UNLESS NOTED

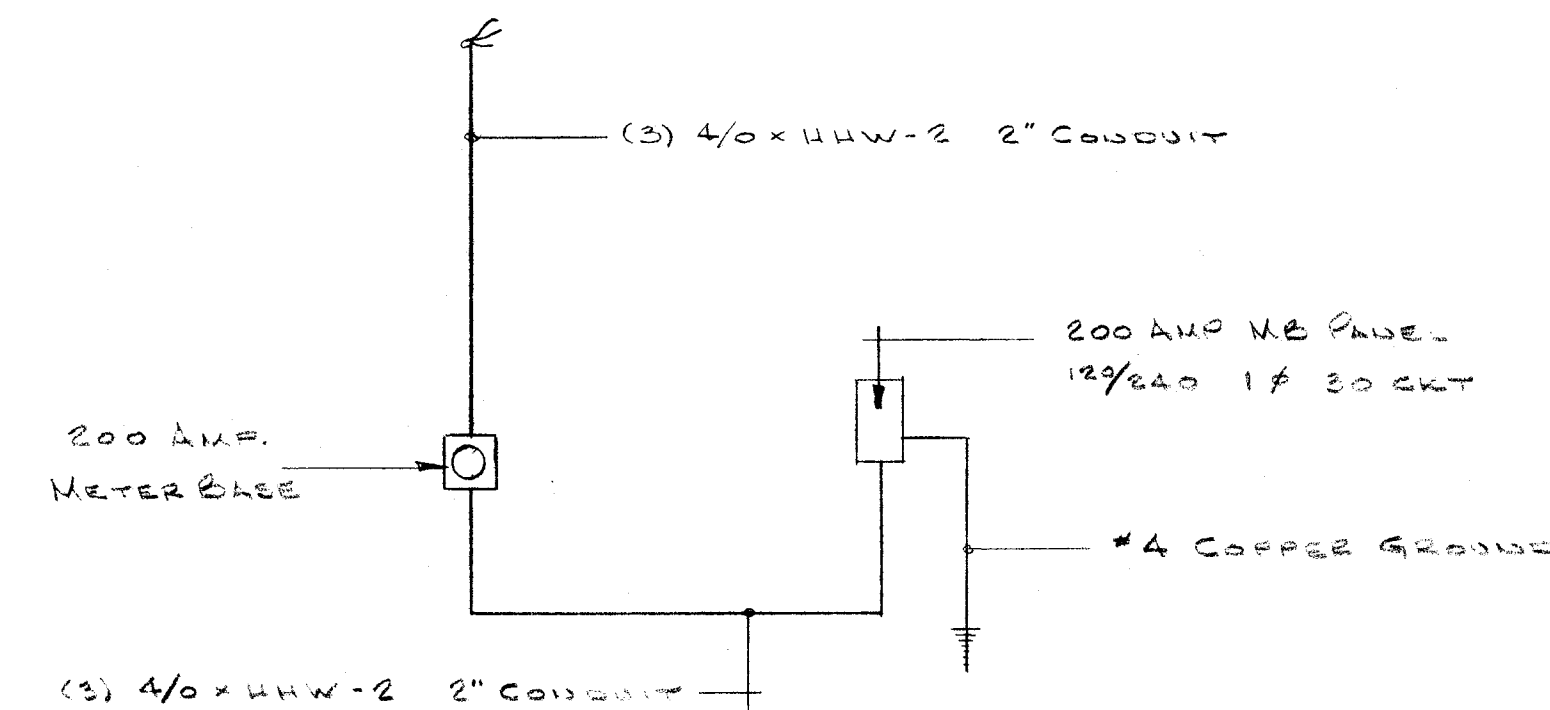

SERVICE DIAGRAM

N.T.S.

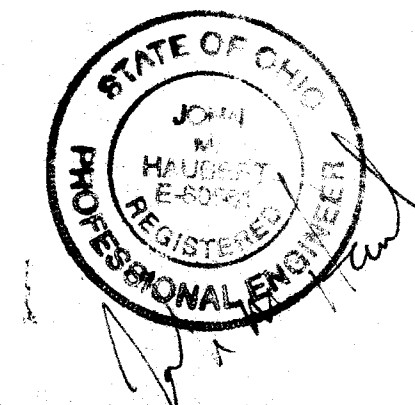

BEUGAL ENTERPRISES - 1320 1 ST ST. N.E. MASSILLON, OHIO 44646 - (330) 837-4400				
TOLERANCES (EXCEPT AS NOTED)		REVISIONS		
DECIMAL	1	NO	DATE	BY
FRACTIONAL	2			
ANGULAR	3			
	4			
	5			
DRAWN BY J.M. HAUGHEY		SCALE 1/8" = 1'-0"		MATERIAL
DATE 3-2-04		TRACED		DRAWING NO. E-1