


PEPSI AMERICAS MASSILLON PARKING IMPROVEMENTS

OUTLOTS NO. 1045 & 1046, MASSILLON, OHIO

MARCH, 2008

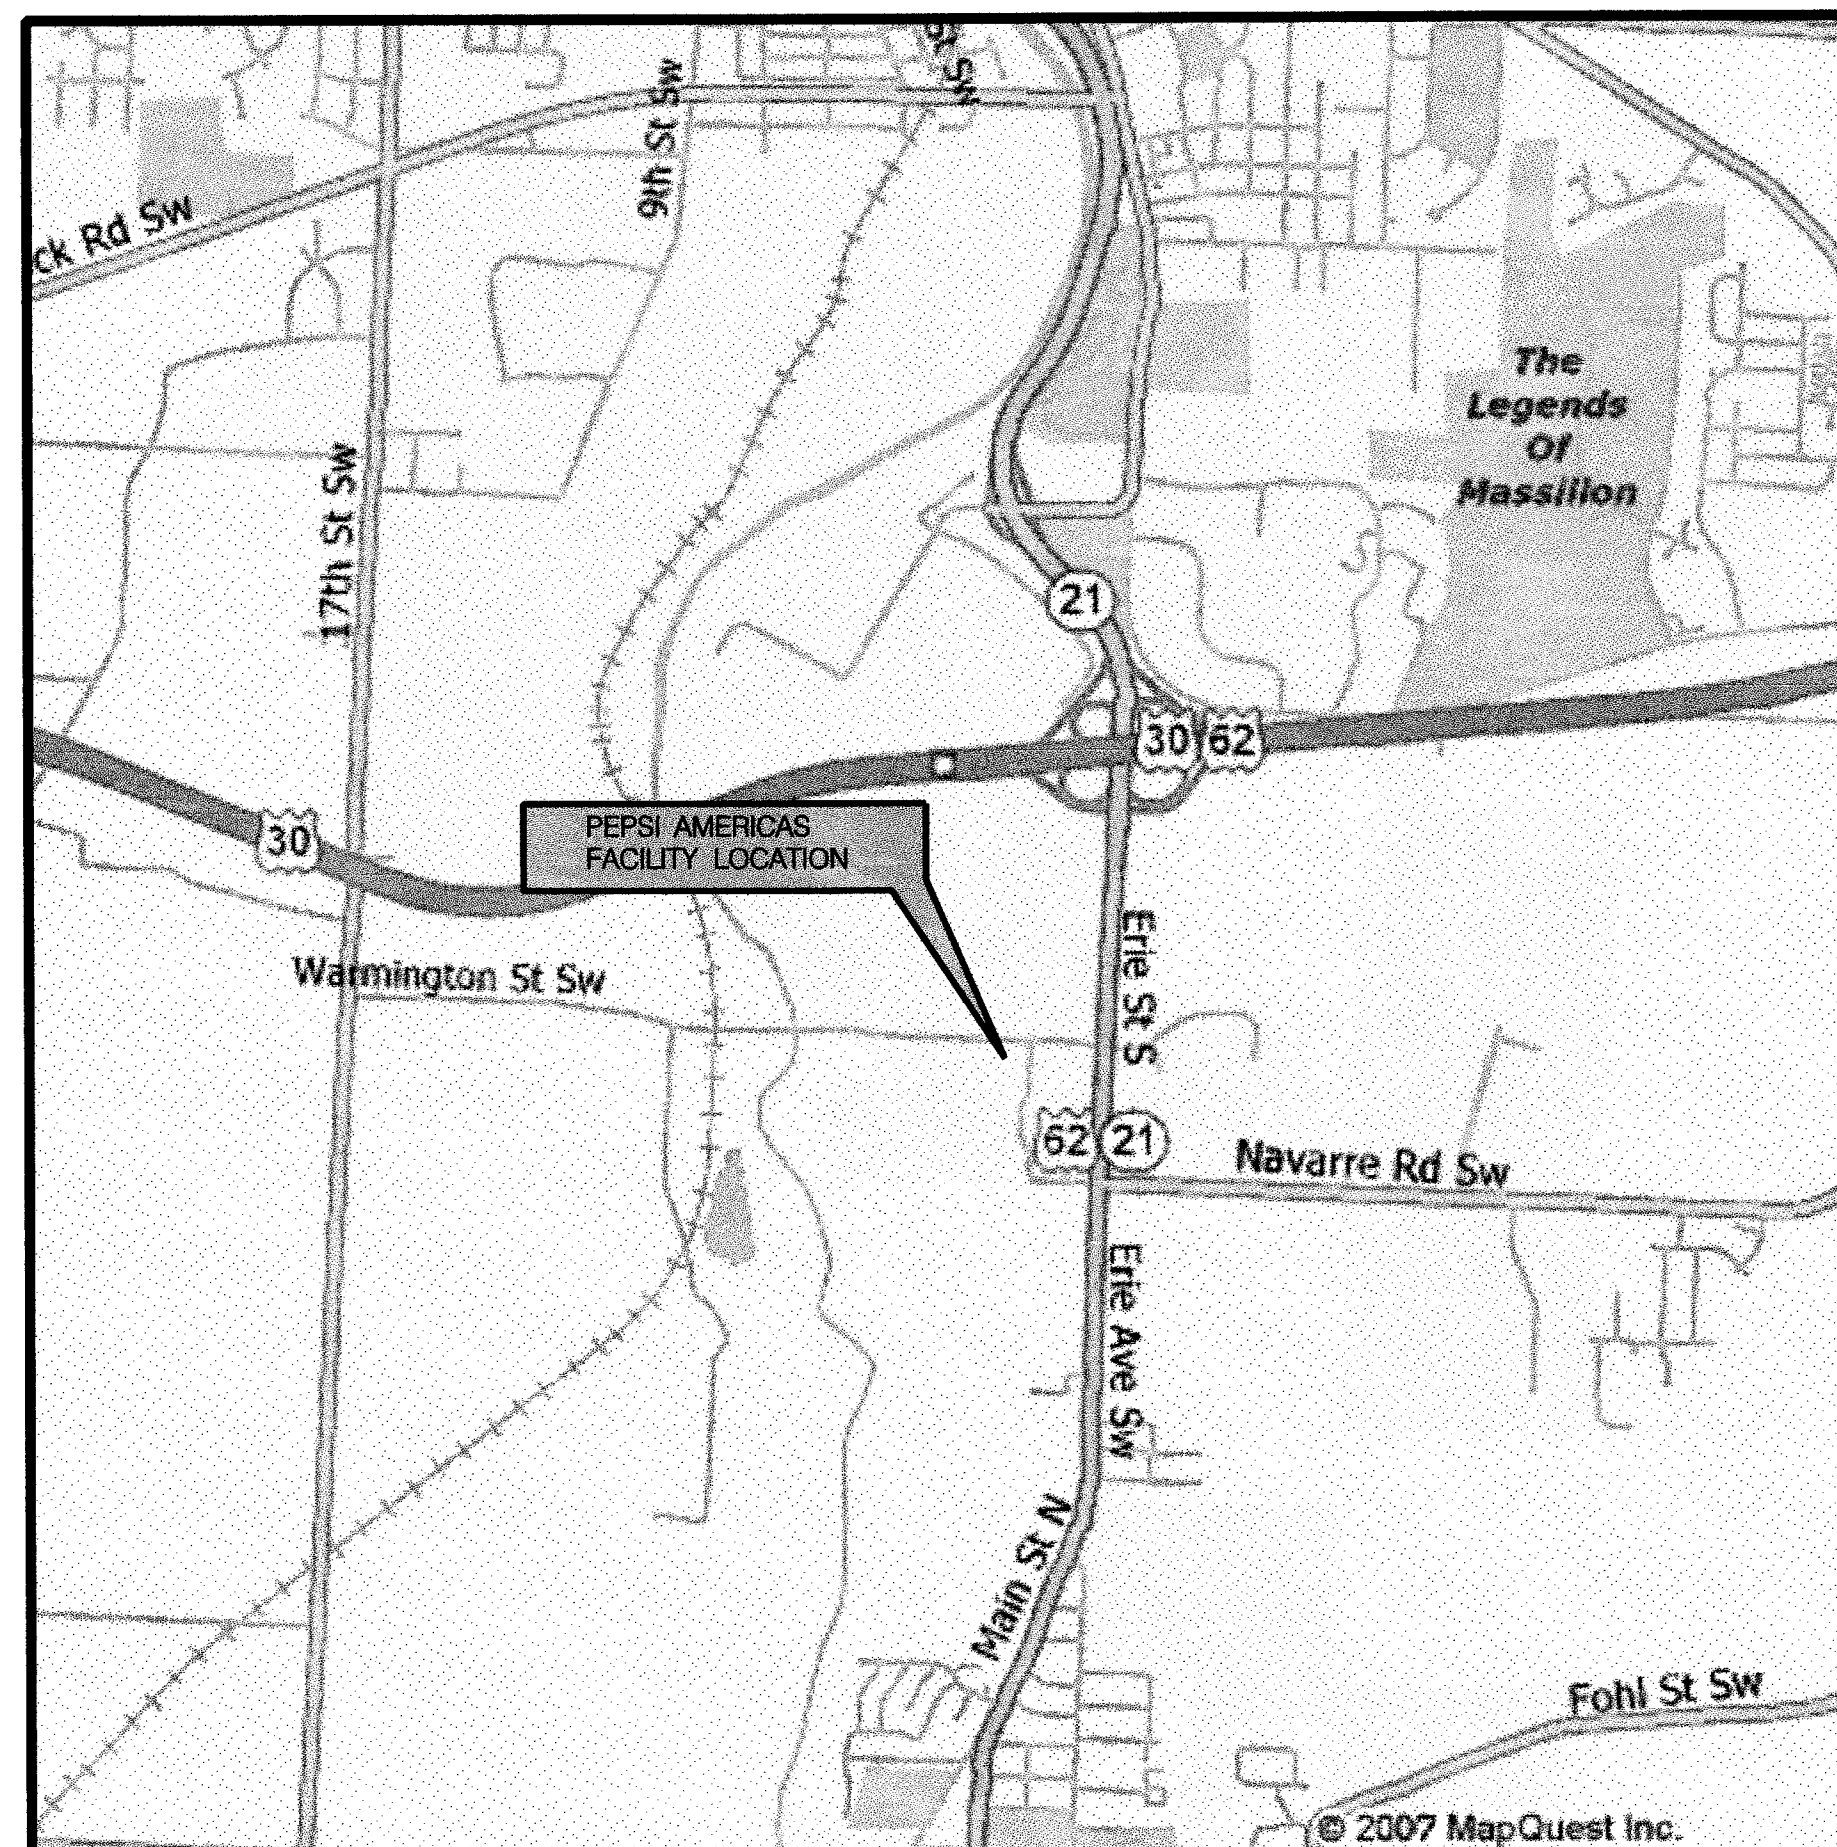

SITE MAP

NTS



PROJECT AERIAL

NTS

DRAWING INDEX

- 1 COVER SHEET
- 2 EXISTING CONDITIONS
- 3 SITE PLAN
- 4 GRADING PLAN
- 5 UTILITY PLAN
- 6 EROSION CONTROL PLAN
- 7 DETAIL SHEET
8. DETAIL SHEET
- 8A. DETAIL SHEET
9. STORM PIPE PROFILES
10. FENCE PLAN
11. GUARD HOUSE AREA PLAN
12. GUARD HOUSE DETAILS
13. OVERHEAD PARKING LOT LIGHTS
14. SIGNAGE PLAN AND DETAILS

SITE OWNER


PEPSI-COLA GENERAL BOTTLERS
OF MANSFIELD, INC. AN OHIO CORPORATION
ROB SCHLAER
2351 EDISON BLVD
TWINSBURG, OH 44087
(330) 963-5506

SITE DEVELOPER

HARD HAT SERVICES
TOM BLAIR
940 E. DIEHL ROAD, STE 150
NAPERVILLE, IL 60563
(630) 637-9470

APPROVED BY THE MASSILLON CITY ENGINEER THIS 14
DAY OF MARCH, 2008
KEITH A. DYLEWSKI, PE
16 A. J. C.

ONLY APPROVED SIGNED PLANS
BY THE CITY ENGINEER ARE TO
BE USED FOR CONSTRUCTION.

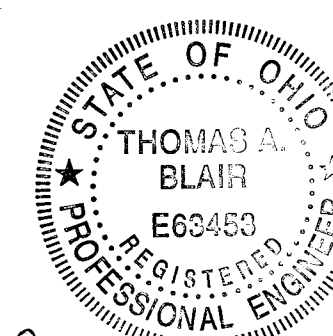


Thomas A. Blair
Expires 12/31/2008

REV	DATE	BY	DESCRIPTION	SCALE	CLIENT
3	03/06/08	TAB	REVISED CITY SUBMITTAL: DOCKS, SAN SEWER		PEPSI AMERICAS MASSILLON PARKING IMPROVEMENTS MASSILLON, OHIO
2	02/12/08	TAB	ADDENDUM #1-FENCES, FLAG POLE, LIGHTS, SIGNS		
1	12/12/07	LES	RESUBMITTAL #1 TO CITY OF MASSILLON	DESIGNED: LES/WWL	TITLE: COVER SHEET
0	11/21/07	LES	SUBMITTAL TO CITY OF MASSILLON	DRAWN: HHS CHECKED: TAB	
				940 E. Diehl Rd, Suite 150 Naperville, IL 60563 (630) 637-9470	
				SHEET: 1 OF 14 SHEETS	



HARD HAT SERVICES™
Engineering, Construction and Management Solutions

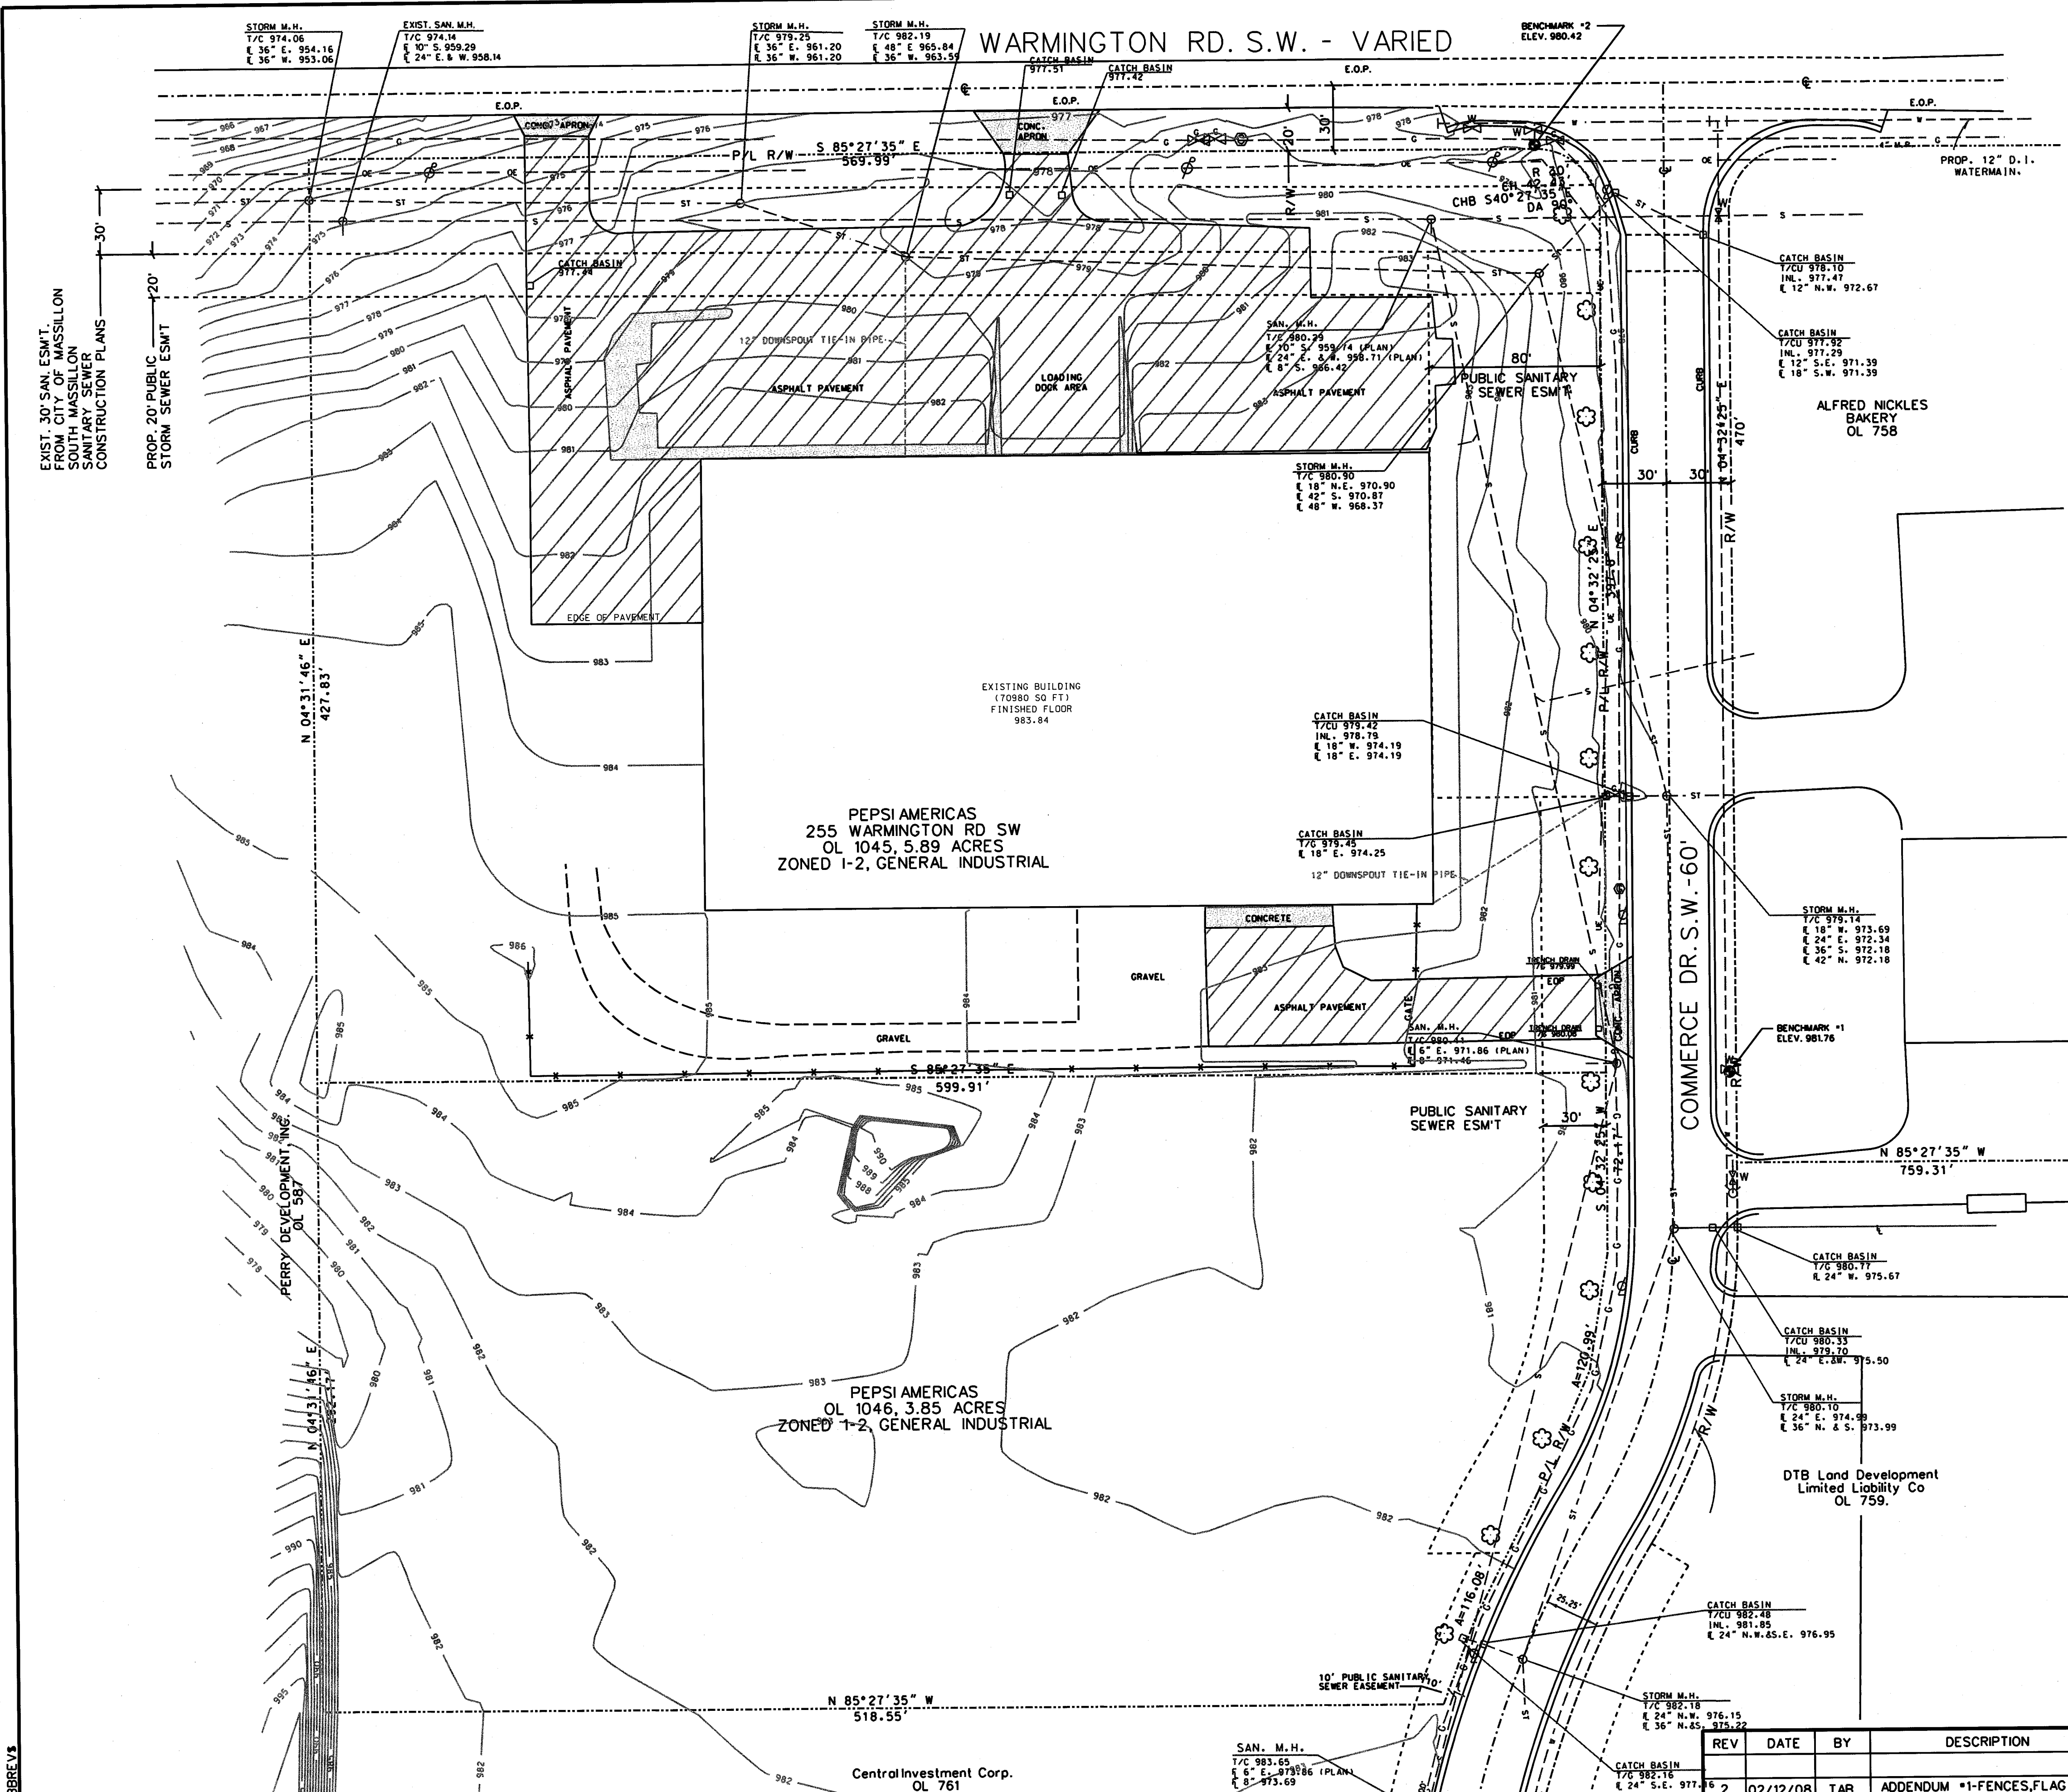

- LEGEND:**
- CONCRETE SURFACE
 - ASPHALT SURFACE
 - SURFACE CONTOUR (1 FT. INTERVAL)
 - UTILITY EASEMENT
 - PROPERTY LINE
 - R/W RIGHT-OF-WAY
 - W WATER LINE
 - S SANITARY SEWER LINE
 - ST STORM SEWER LINE
 - G GAS LINE
 - UE UNDERGROUND ELECTRIC
 - OE OVERHEAD ELECTRIC
 - FENCE
 - DOWNSPOUT TIE-IN
 - GAS LINE MARKER
 - WATER LINE MARKER
 - POWER POLE
 - GENERAL POLE
 - LIGHT POLE
 - ANCHOR
 - SIGN
 - CATCH BASIN (C.B.)
 - MAN HOLE (AS LABELED)
 - FIRE HYDRANT
 - VALVE
 - EOP EDGE OF PAVEMENT
 - LOT LINE
 - CENTERLINE
 - BENCHMARK
 - TREE

- NOTES:**
- UTILITY LOCATIONS SHOWN WERE COMPILED FROM PLAN INFORMATION AND/OR FIELD LOCATION OF SURFACE UTILITY STRUCTURES. EXACT LOCATIONS OF UNDERGROUND UTILITIES ARE UNKNOWN.
 - SITE FEATURES DERIVED FROM SURVEY BY HAMMONTREE & ASSOCIATES, LIMITED, 8/26/98.
 - BENCHMARK *1: "X" CHISEL IN NORTH FLANGE BOLT OF FIRE HYDRANT, 27' EAST OF THE CENTERLINE OF COMMERCE DR. S.W., 460' SOUTH OF THE CENTERLINE OF WARMINGTON ROAD S.W. ELEVATION = 981.76
 - BENCHMARK *2: "X" CHISEL IN NORTH FLANGE BOLT OF FIRE HYDRANT, AT THE SOUTHWEST CORNER OF WARMINGTON ROAD S.W., AND COMMERCE DR. S.W. ELEVATION = 980.42
 - NO ENTRANCE DRIVES ARE LOCATED ON THE NORTH SIDE OF WARMINGTON ROAD.
 - SITE AND SURROUNDING PROPERTIES ARE ZONED I-2 GENERAL INDUSTRIAL.
 - ALL EASEMENTS SHOWN ARE TAKEN FROM STARK COUNTY RECORDER VOLUME 64, PAGE 74.


REV	DATE	BY	DESCRIPTION	SCALE:	CLIENT:
0				0 40 80 SCALE IN FEET	PEPSI AMERICAS MASSILLON PARKING IMPROVEMENTS MASSILLON, OHIO
1	02/12/08	TAB	ADDENDUM *1-FENCES, FLAG POLE, LIGHTS, SIGNS	DESIGNED: LES/MWL	TITLE: EXISTING CONDITIONS
2	12/12/07	LES	RESPONSE TO CITY OF MASSILLON COMMENTS	DRAWN: HHSI	
0	11/21/07	LES	SUBMITTAL TO CITY OF MASSILLON	CHECKED: TAB	

**HARD HAT SERVICES**™
Engineering, Construction and Management Solutions

940 E. Diehl Rd, Suite 150
Naperville, IL 60563
(630) 637-9470

SHEET:
2
OF 14 SHEETS

WARMINGTON RD. S.W. - VARIED

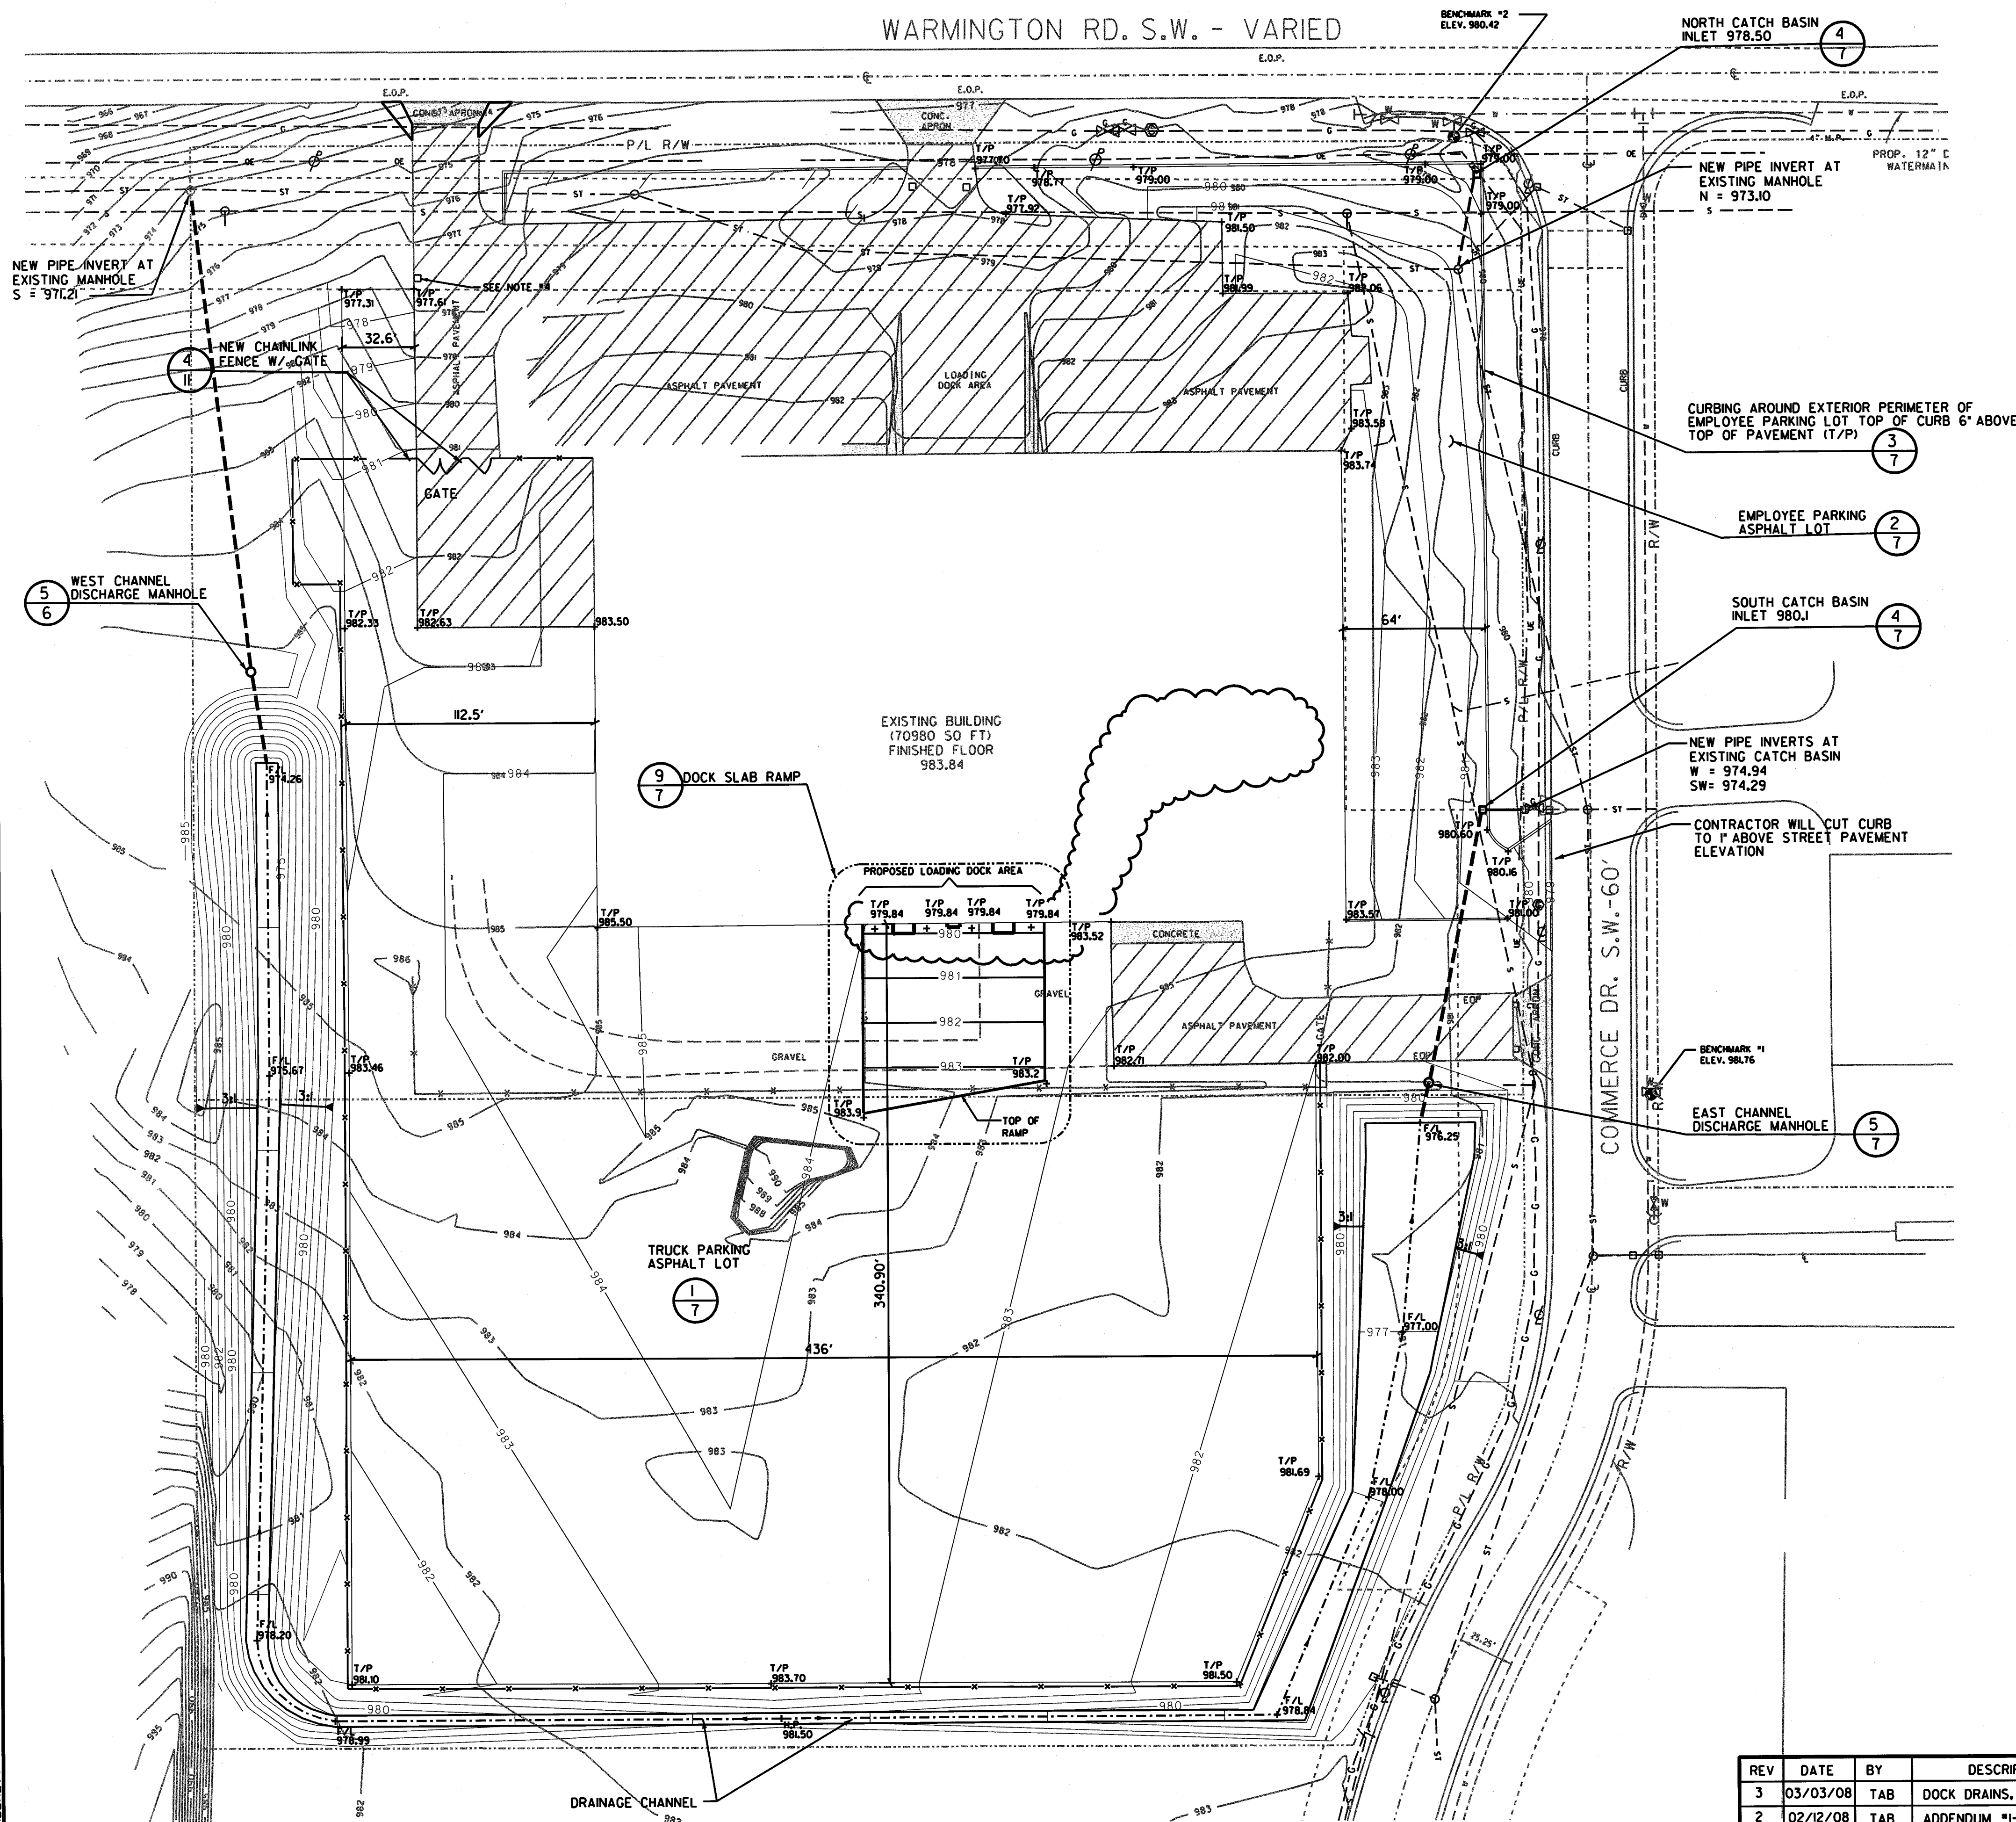

LEGEND:

- EXISTING ASPHALT SURFACE
- NEW ASPHALT SURFACE
- NEW SURFACE CONTOUR
- 980.60+ NEW SURFACE GRADE ELEVATION
- T/P TOP OF PAVEMENT
- F/L FLOW LINE OF CHANNEL
- H.P. HIGH POINT OF FLOW LINE
- NEW CHAINLINK FENCE
- EXISTING SURFACE CONTOUR

NOTE:

1. SEE SHEET 2 FOR EXISTING CONDITIONS LEGEND.
2. ACCORDING TO FEMA MAP #3907800100B THE PROPERTY IS LABELED ZONE 'C' AND IS NOT IN A FLOOD PLAIN.
3. NO ENTRANCE DRIVES ARE LOCATED ON THE NORTH SIDE OF WARMINGTON ROAD.
4. AREA AROUND EXISTING NORTHWEST CATCH BASIN WILL BE GROUND DOWN AND RESURFACED WITH ASPHALT TO SLOPE TO THE CATCH BASIN. CATCH BASIN CASTING ELEVATION WILL BE DROPPED 0.4 FEET TO 977.04.

REV	DATE	BY	DESCRIPTION
3	03/03/08	TAB	DOCK DRAINS, SANITARY
2	02/12/08	TAB	ADDENDUM #1-FENCES, FLAG POLE, LIGHTS, SIGNS
1	12/12/07	LES	RESUBMITTAL #1 TO CITY OF MASSILLON
4	03/06/08	TAB	RESUBMITTAL #2 TO CITY OF MASSILLON

SCALE:	0	40	80
	SCALE IN FEET		
DESIGNED:	LES/MWL		
DRAWN:	HHSI		
CHECKED:	TAB		

CLIENT: PEPSI AMERICAS
MASSILLON PARKING IMPROVEMENTS
MASSILLON, OHIO

GRADING PLAN

940 E. Diehl Rd, Suite 150
Naperville, IL 60563
(630) 637-9470




HARD HAT SERVICES™
Engineering, Construction and Management Solutions

SHEET:

4

OF 14 SHEETS

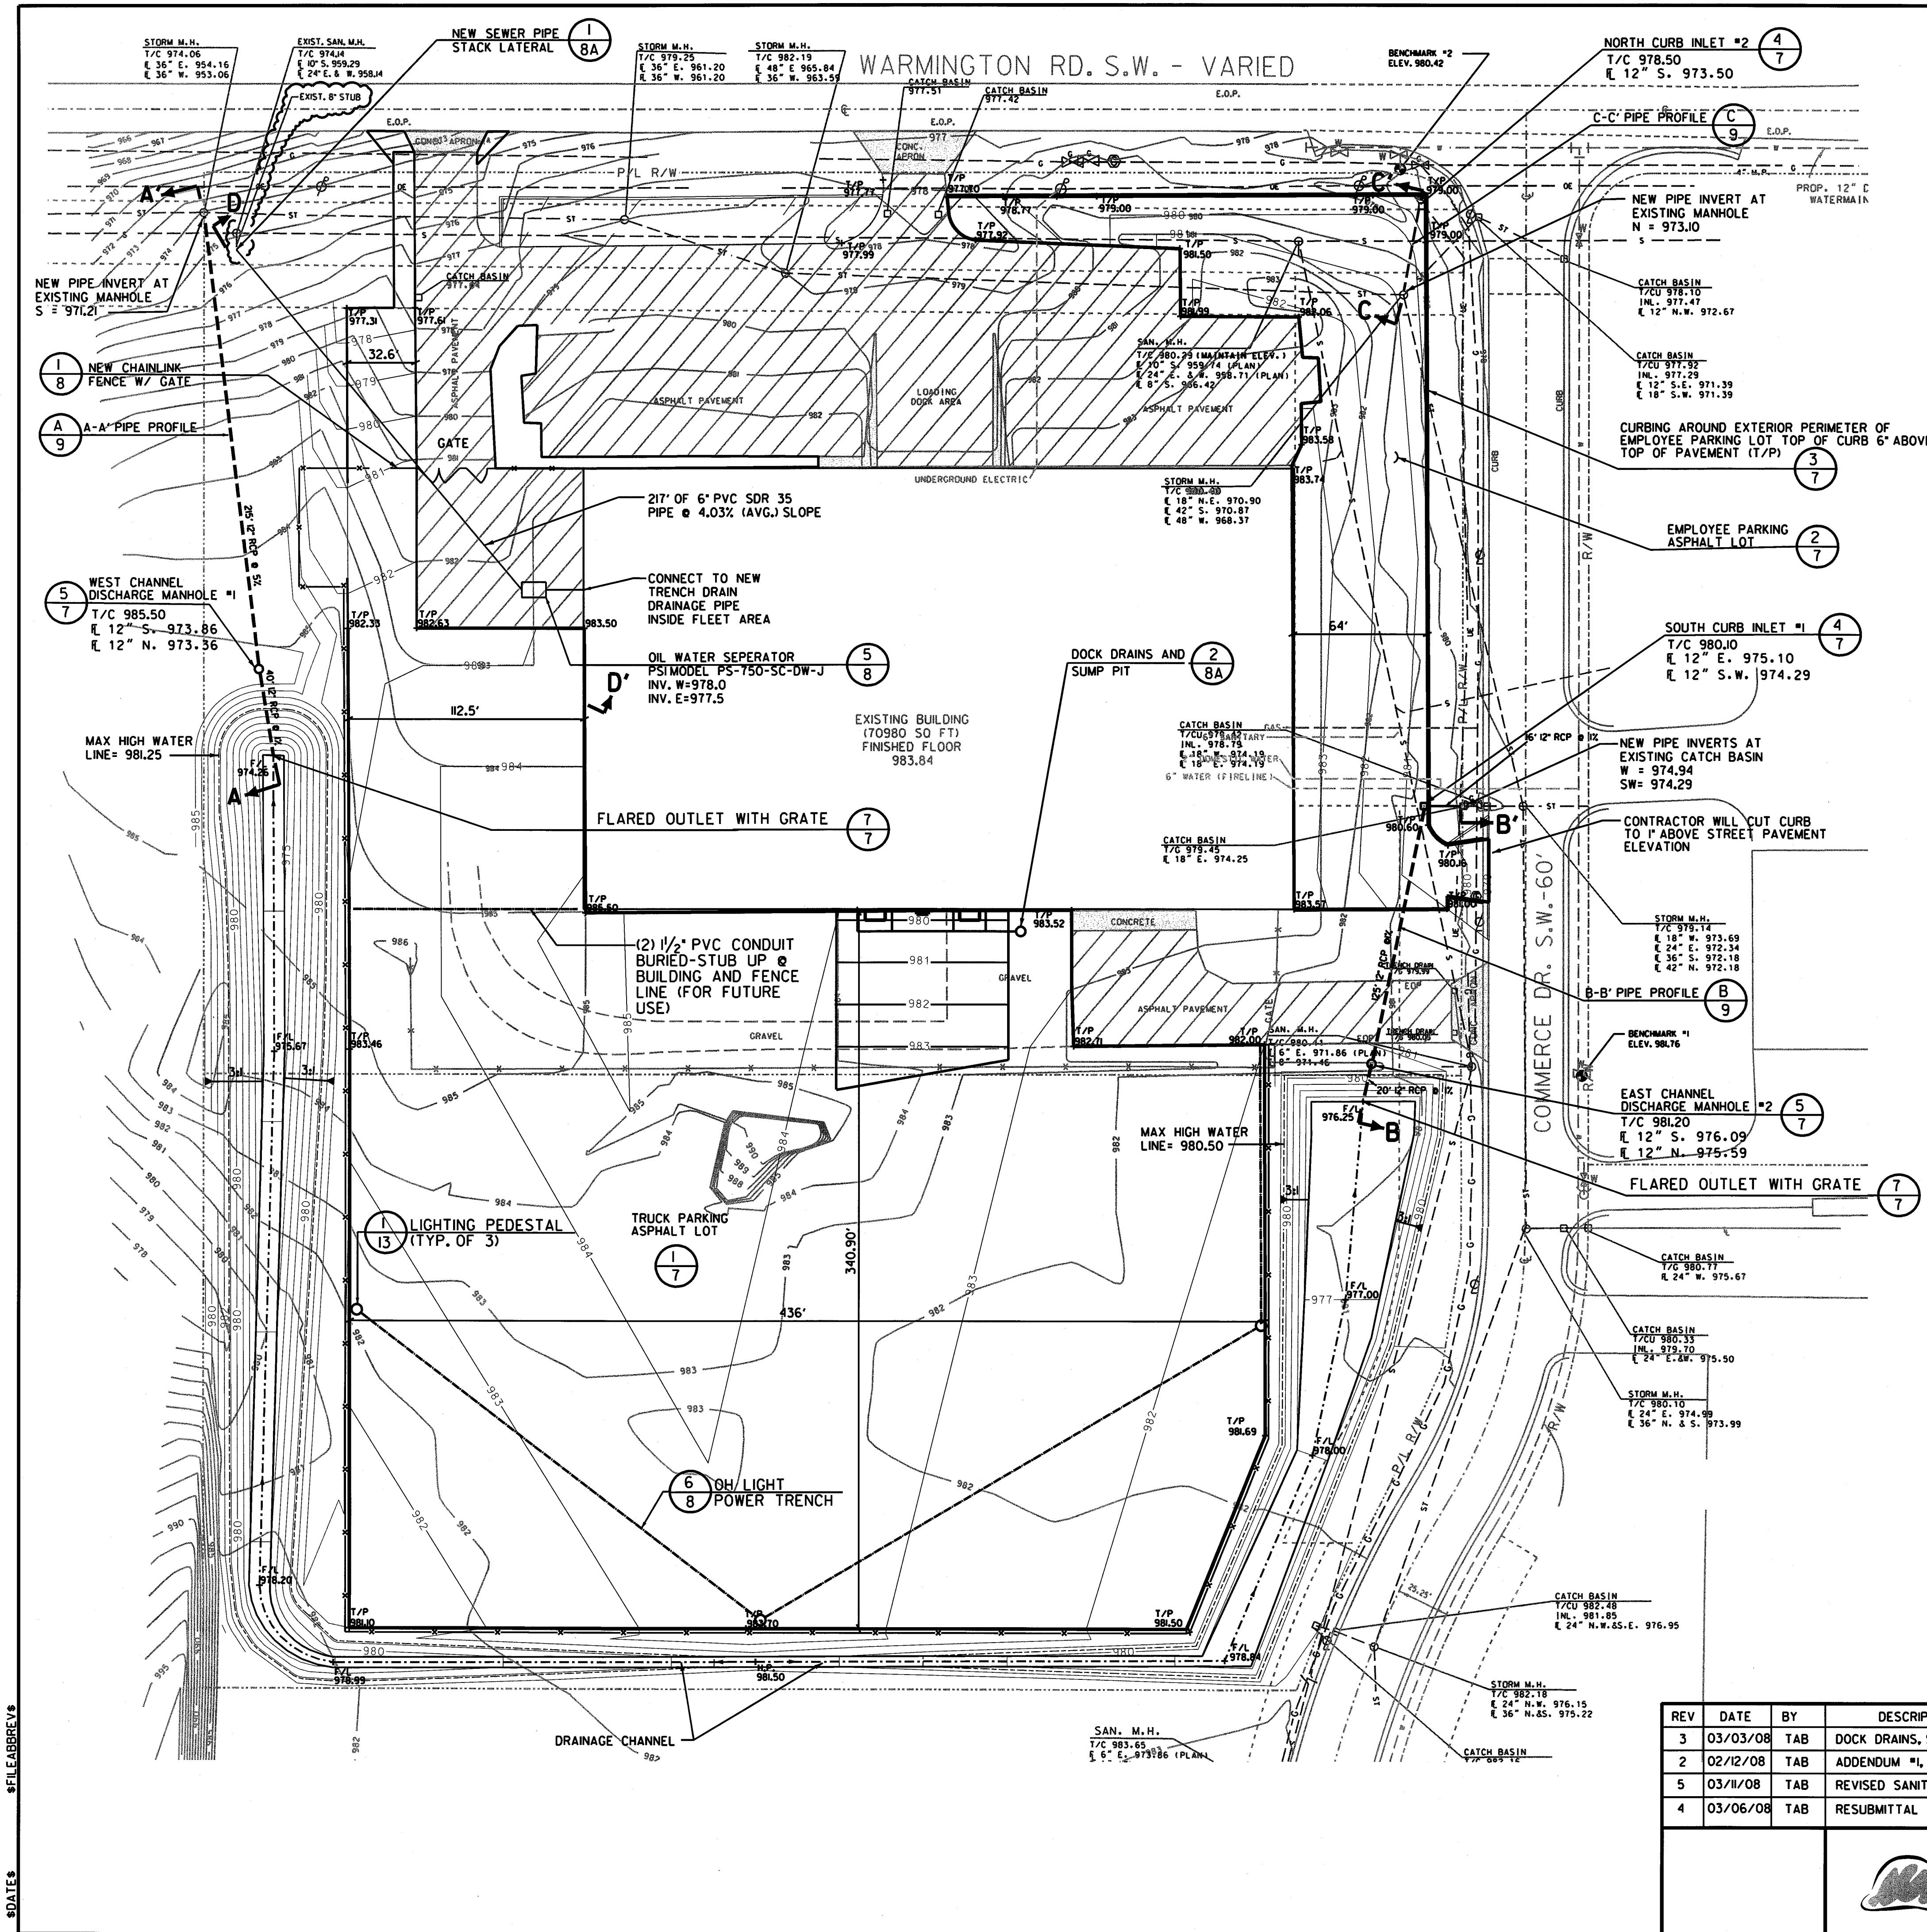

LEGEND:

- EXISTING ASPHALT SURFACE
- NEW ASPHALT SURFACE
- NEW SURFACE CONTOUR
- NEW SURFACE GRADE ELEVATION
- TOP OF PAVEMENT
- FLOW LINE OF CHANNEL
- HIGH POINT OF FLOW LINE
- NEW CHAINLINK FENCE
- EXISTING SURFACE CONTOUR
- UTILITY EASEMENT
- PROPERTY LINE
- RIGHT-OF-WAY
- WATER LINE
- SANITARY SEWER LINE
- STORM SEWER LINE
- GAS LINE
- UNDERGROUND ELECTRIC
- OVERHEAD ELECTRIC
- FENCE
- GAS LINE MARKER
- WATER LINE MARKER
- POWER POLE
- GENERAL POLE
- LIGHT POLE
- ANCHOR
- SIGN
- CATCH BASIN (C.B.)
- MAN HOLE (AS LABELED)
- FIRE HYDRANT
- VALVE
- EDGE OF PAVEMENT
- LOT LINE
- CENTERLINE
- BENCHMARK
- TREE

NOTE:


- SEE SHEET 2 FOR EXISTING CONDITIONS LEGEND.
- ACCORDING TO FEMA MAP #3907800100B THE PROPERTY IS LABELED ZONE 'C' AND IS NOT IN A FLOOD PLAIN.
- NO ENTRANCE DRIVES ARE LOCATED ON THE NORTH SIDE OF WARMINGTON ROAD.
- ALL CONNECTIONS TO EXISTING MANHOLES ARE TO BE CORE DRILLED AND SEALED APPROPRIATELY.

REV	DATE	BY	DESCRIPTION	SCALE: 0 40 80 SCALE IN FEET	CLIENT: PEPSI AMERICAS MASSILLON PARKING IMPROVEMENTS MASSILLON, OHIO
3	03/03/08	TAB	DOCK DRAINS, SANITARY	DESIGNED: LES/MWL	TITLE: UTILITY PLAN
2	02/12/08	TAB	ADDENDUM #1, FENCES, FLAG POLE, LIGHTS, SIGNS	DRAWN: HHSI	
5	03/11/08	TAB	REVISED SANITARY TIE-IN	CHECKED: TAB	
4	03/06/08	TAB	RESUBMITTAL #2 TO CITY OF MASSILLON		

**HARD HAT SERVICES**™
Engineering, Construction and Management Solutions

940 E. Diehl Rd, Suite 150
Naperville, IL 60563
(630) 637-9470

SHEET: 5
OF 14 SHEETS

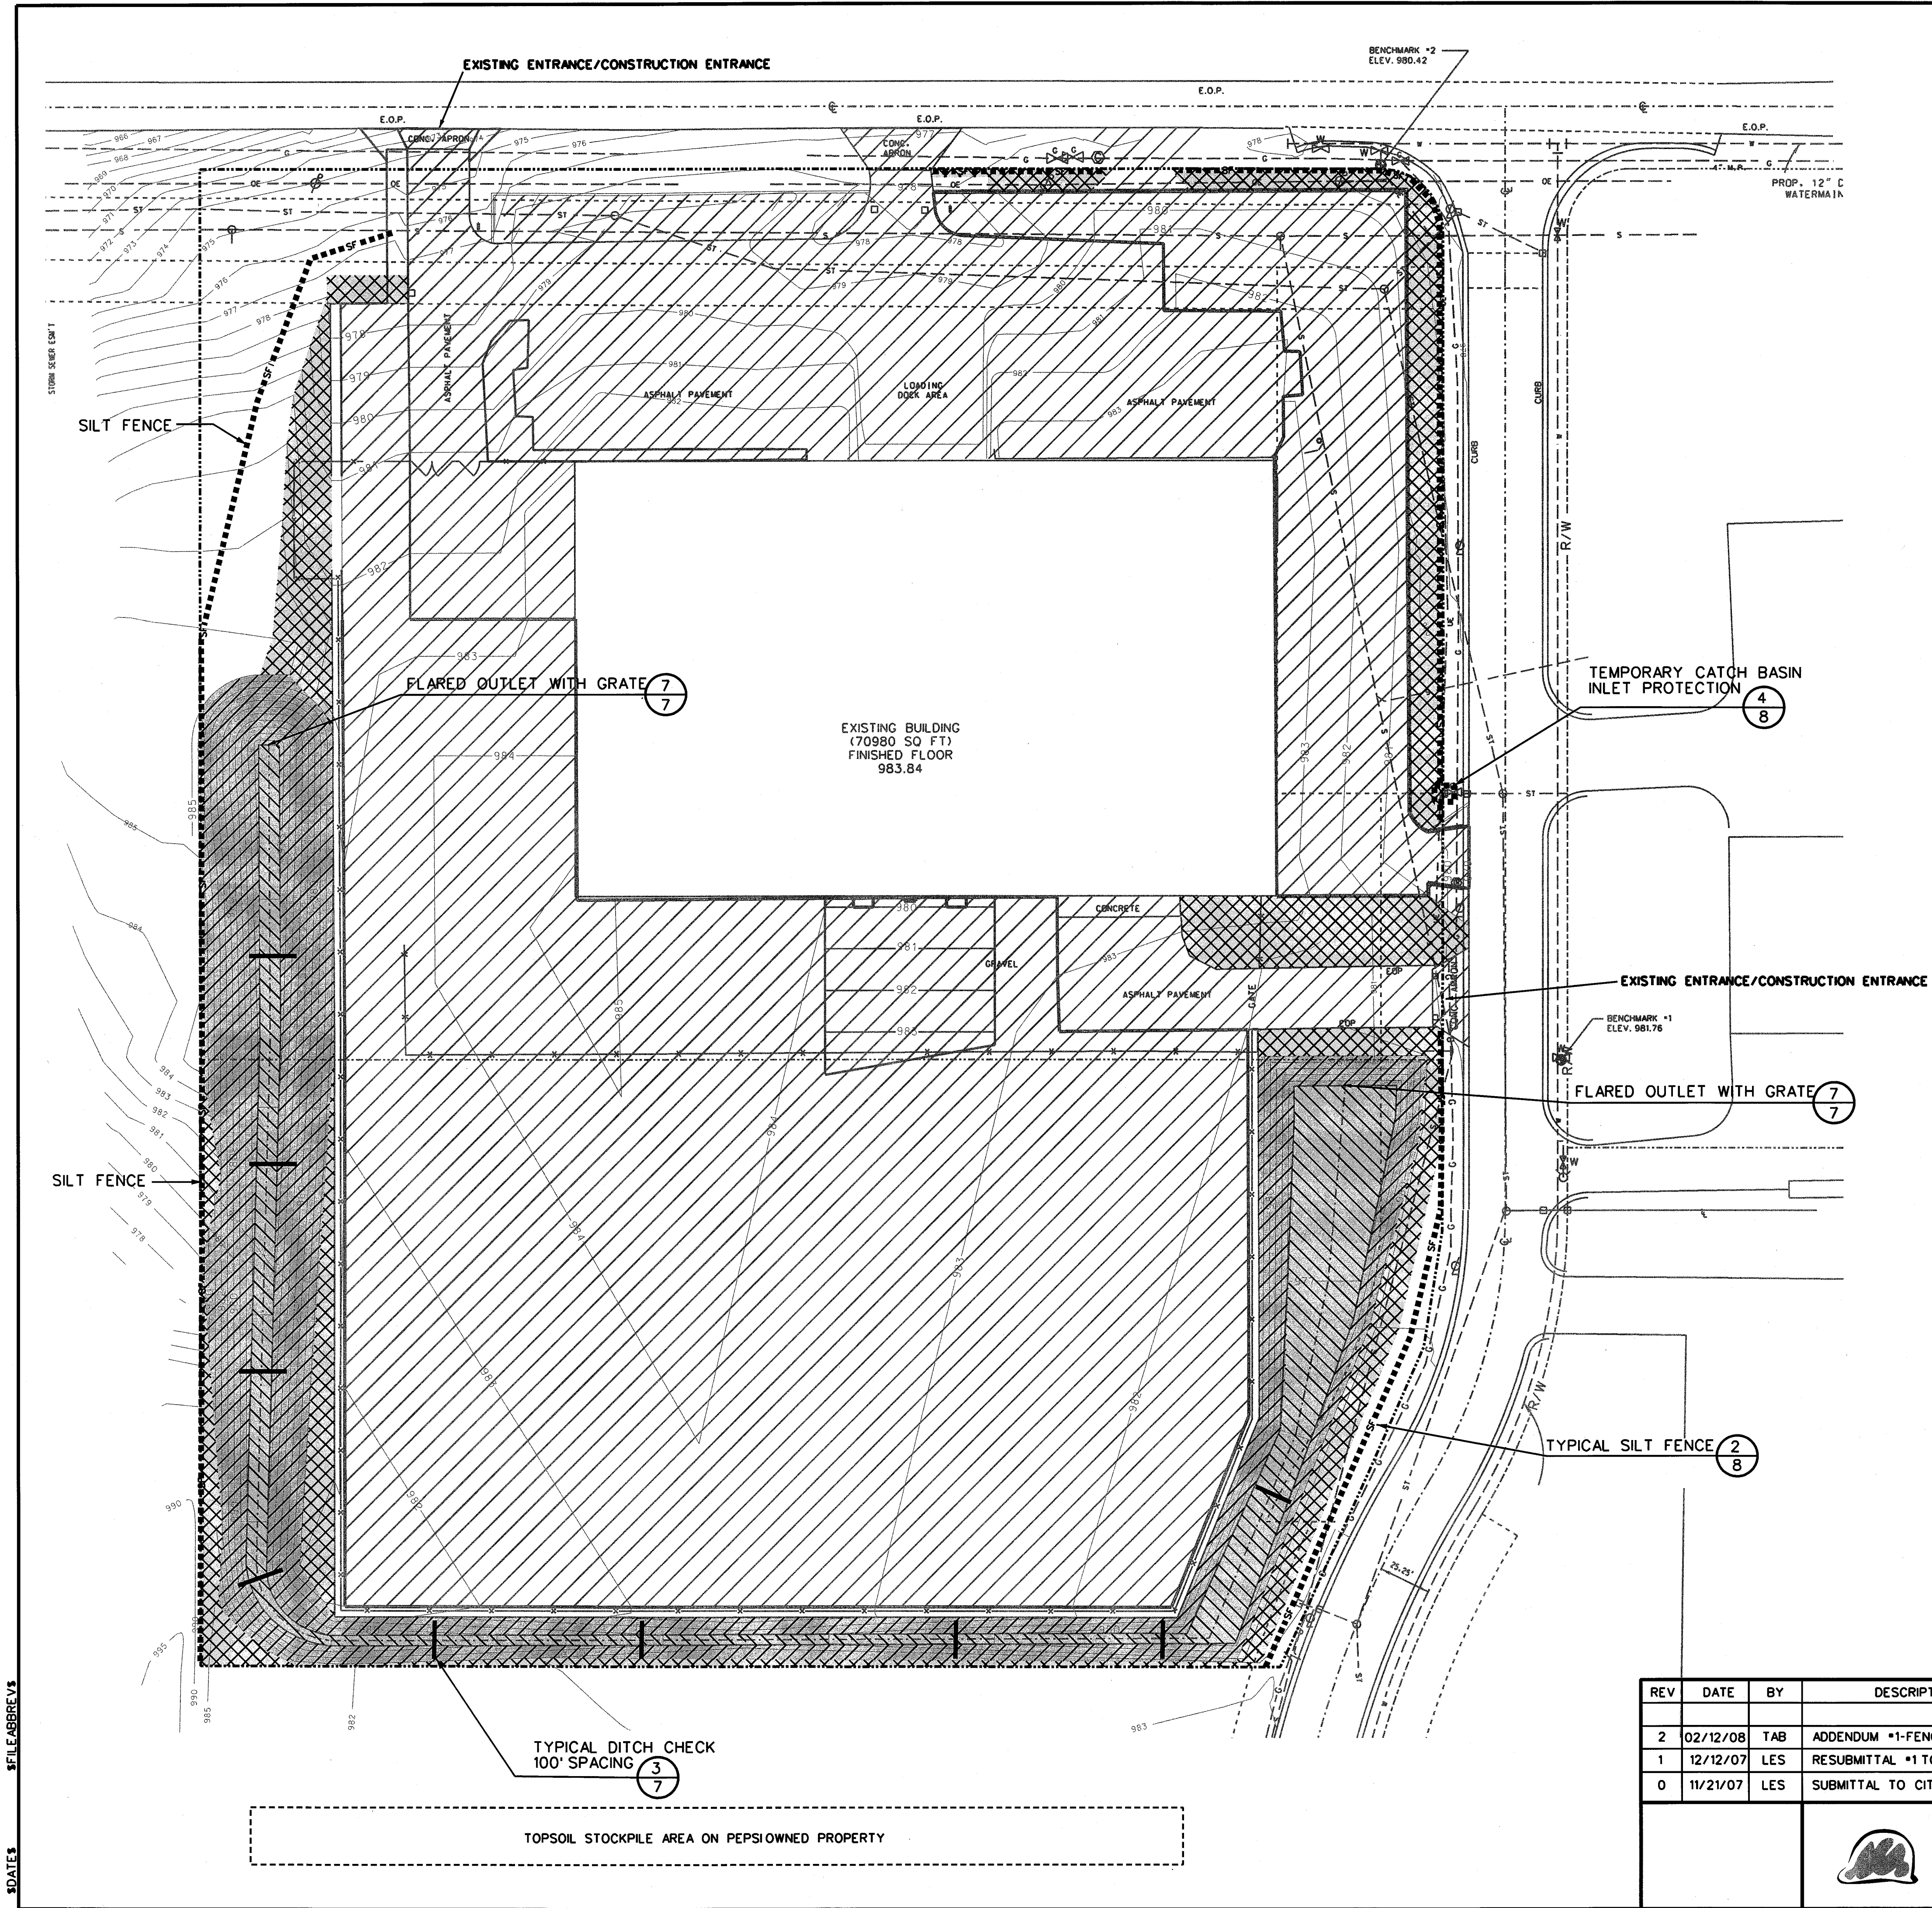

LEGEND:

- S--- SILT FENCE
- DITCH CHECK
- [Hatched Box] EROSION MAT ON SIDESLOPES NORTH AMERICAN GREEN S150 OR EQUAL (~58,300 SQ FT)
- [Hatched Box] EROSION MAT IN SURFACE FLOW SWALES NORTH AMERICAN GREEN S150 OR EQUAL (~34,850 SQ FT)
- [Cross-hatched Box] SEED AND MULCH (NOTE 3) (~84,000 SQ FT)
- [Diagonal Hatched Box] ASPHALT SURFACE


NOTE:

- HYDROSEEDING MAY BE USED IN CONFORMANCE WITH PEPSIAMERICAS GENERAL SPECIFICATION 02900.
- EROSION MAT SHALL BE PLACED ACCORDING TO MANUFACTURES INSTRUCTIONS.
- THE CONTRACTOR SHALL PREVENT AND/OR REDUCE AND CONTROL SOIL EROSION RESULTING FROM THE PROPOSED IMPROVEMENTS. THE USE OF SILT FENCING, JUTE MATTING, TEMPORARY SEEDING, SILT CHECKS, INLET PROTECTION AROUND ALL CATCH BASINS, STABILIZED CONSTRUCTION ENTRANCE(S), ETC. WILL BE REQUIRED. SEDIMENT CONTROL STRUCTURES/ DEVICES SHALL BE INSTALLED IN ACCORDANCE WITH THE LATEST EDITION OF THE MANUAL RAINWATER AND LAND DEVELOPMENT - OHIO'S STANDARDS FOR STORMWATER MANAGEMENT LAND DEVELOPMENT AND URBAN STREAM PROTECTION. SEDIMENT CONTROL DEVICES MUST BE INSTALLED PRIOR TO BEGINNING ANY CONSTRUCTION ACTIVITY. THE CONTRACTOR SHALL BE RESPONSIBLE FOR CONTINUED INSPECTION AND MAINTENANCE OF ALL SEDIMENT CONTROL DEVICES. THE CONTRACTOR SHALL FOLLOW THE REQUIREMENTS SET FORTH ON THE APPROVED STORMWATER POLLUTION PREVENTION PLAN IF APPLICABLE, OR AS DETAILED ON THE CONSTRUCTION PLANS, AS SPECIFIED BY THE CITY OF MASSILLON.
- SPOIL AND STOCKPILES WILL BE LOCATED ON THE ADJACENT SOUTHERN PROPERTY, OWNED BY PEPSIAMERICAS, AS NEEDED.
- THERE ARE NO LAKES, PONDS, WETLANDS, OR SPRINGS LOCATED WITHIN 1000 FEET OF THE SITE.
- TOTAL DISTURBED AREA - 4.76 ACRES

FILE ABBREVS
DATES


REV	DATE	BY	DESCRIPTION	SCALE: 0 40 80 SCALE IN FEET	CLIENT: PEPSIAMERICAS MASSILLON PARKING IMPROVEMENTS MASSILLON, OHIO
2	02/12/08	TAB	ADDENDUM #1-FENCES, FLAG POLE, LIGHTS, SIGNS	DESIGNED: LES/MWL	TITLE: EROSION CONTROL PLAN
1	12/12/07	LES	RESUBMITTAL #1 TO CITY OF MASSILLON	DRAWN: HHS	
0	11/21/07	LES	SUBMITTAL TO CITY OF MASSILLON	CHECKED: TAB	
				940 E. Diehl Rd, Suite 150 Naperville, IL 60563 (630) 637-9470	
				SHEET: 6 OF 14 SHEETS	

**HARD HAT SERVICES**™
Engineering, Construction and Management Solutions

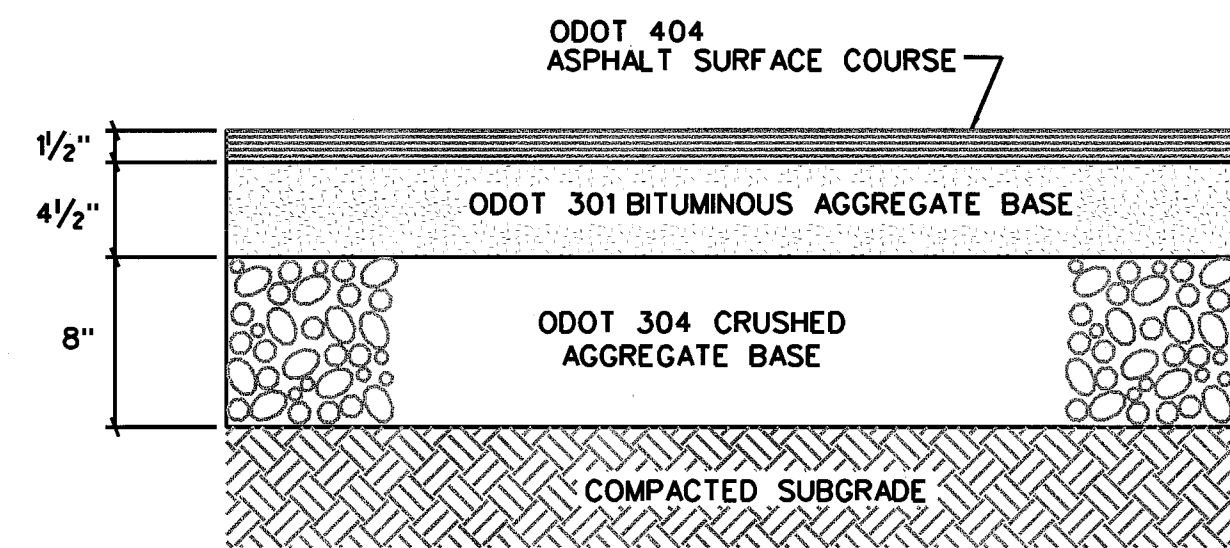


NOTE:
SEE PEPSI AMERICAS STANDARD SPECIFICATIONS
FOR SUBGRADE COMPACTION AND ASPHALT
PLACEMENT REQUIREMENTS.

TYPICAL TRUCK PARKING ASPHALT 1
NTS 7

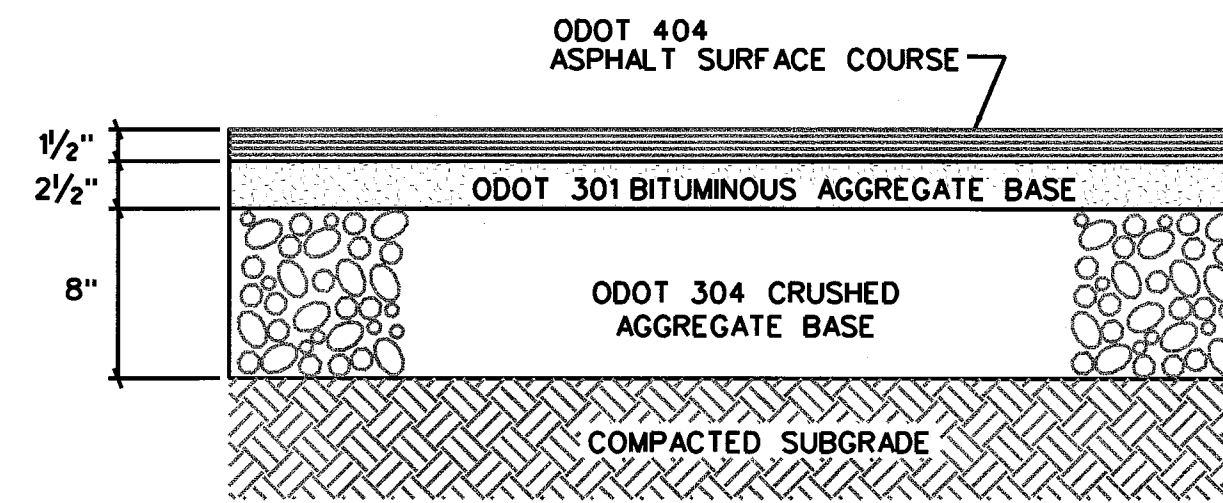


NOTE:
SEE PEPSI AMERICAS STANDARD SPECIFICATIONS
FOR SUBGRADE COMPACTION AND ASPHALT
PLACEMENT REQUIREMENTS.

TYPICAL EMPLOYEE PARKING ASPHALT 2
NTS 7

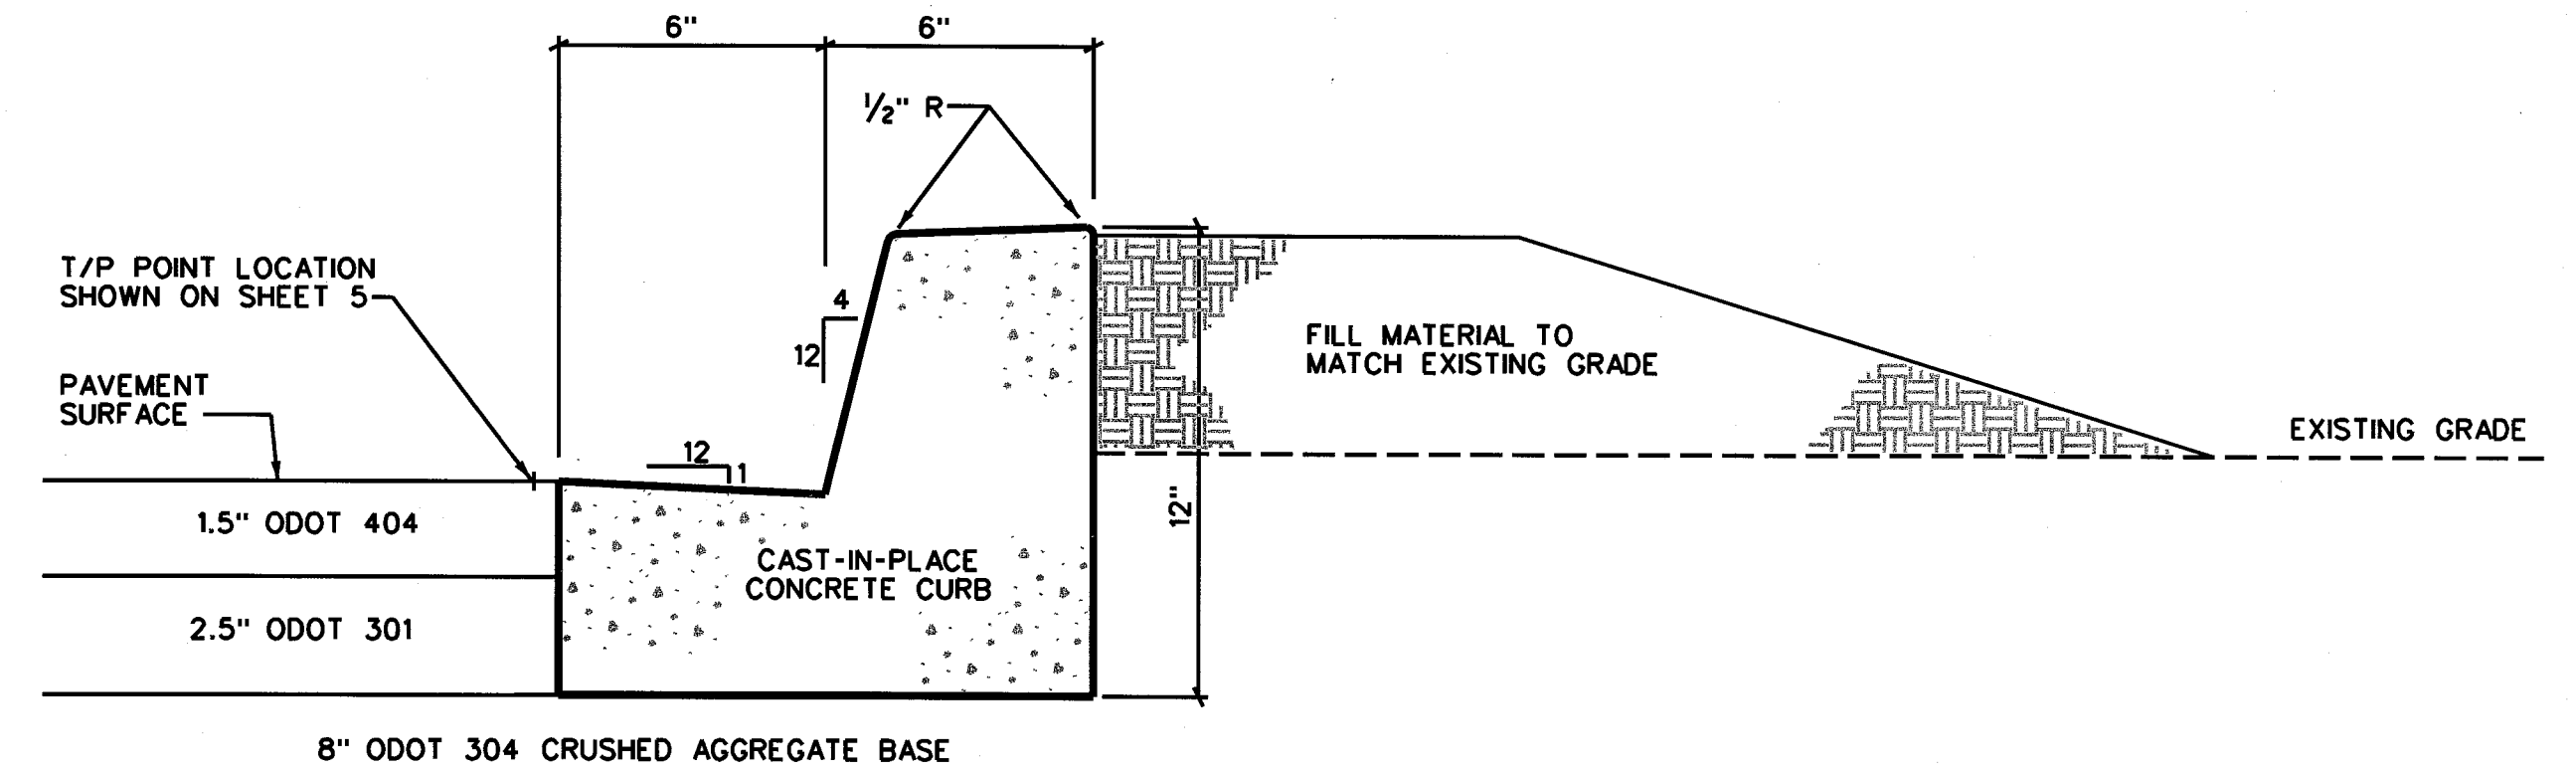


CONCRETE CURB AND GUTTER 3
NTS 7

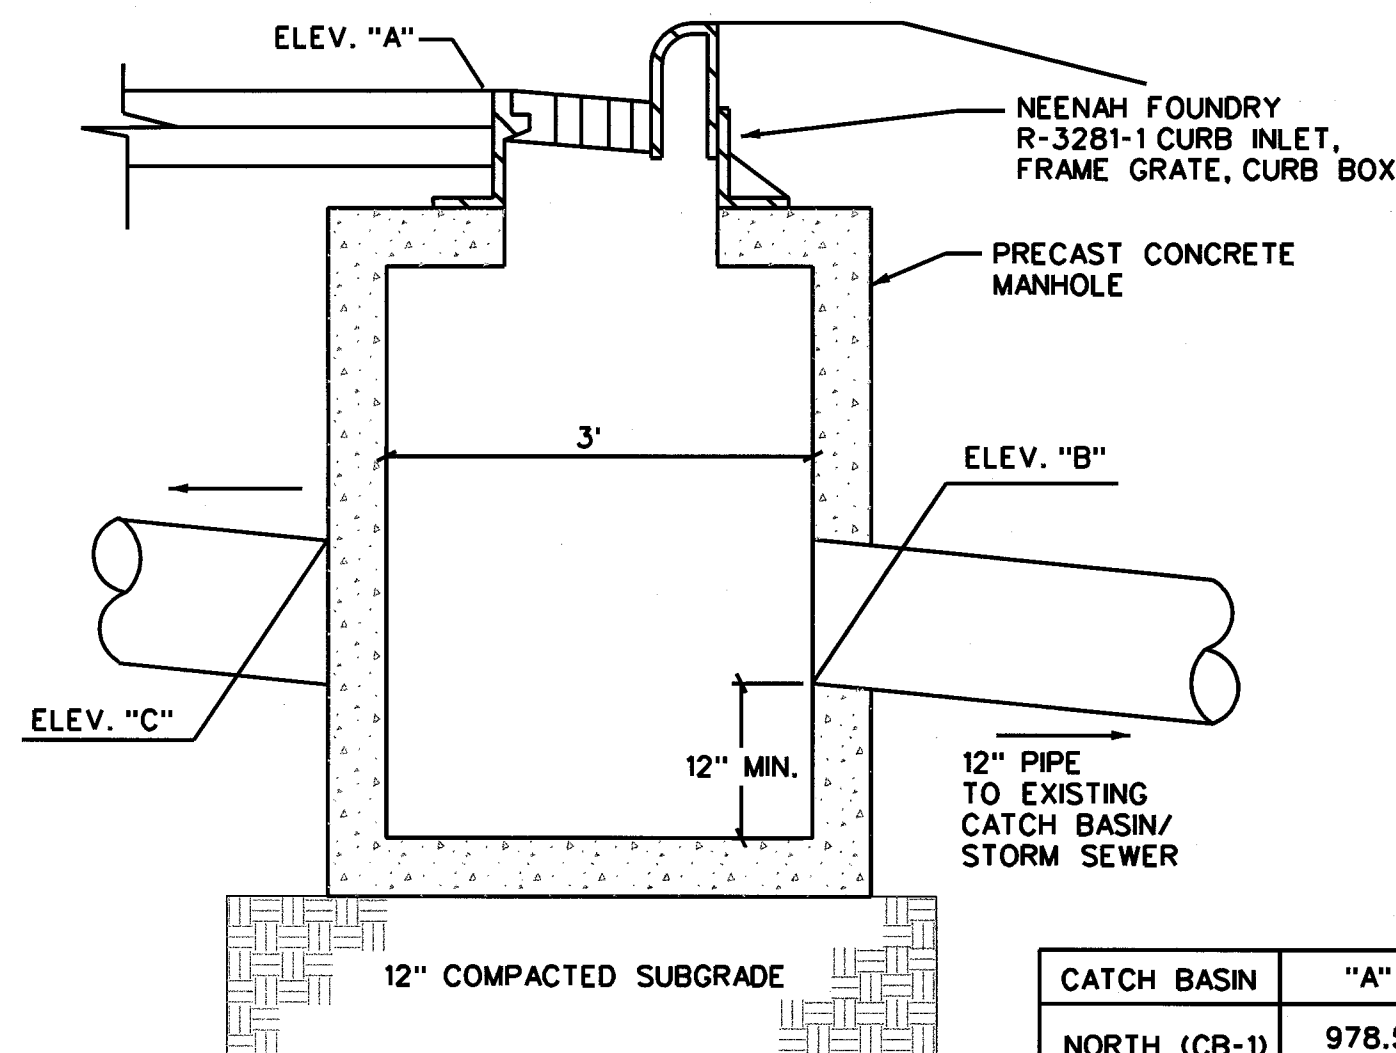


CATCH BASIN	"A"	"B"	"C"
NORTH (CB-1)	978.5	973.5	NA
SOUTH (CB-2)	980.1	974.39	974.39

CATCH BASIN W/ CURB INLET 4
NTS 7

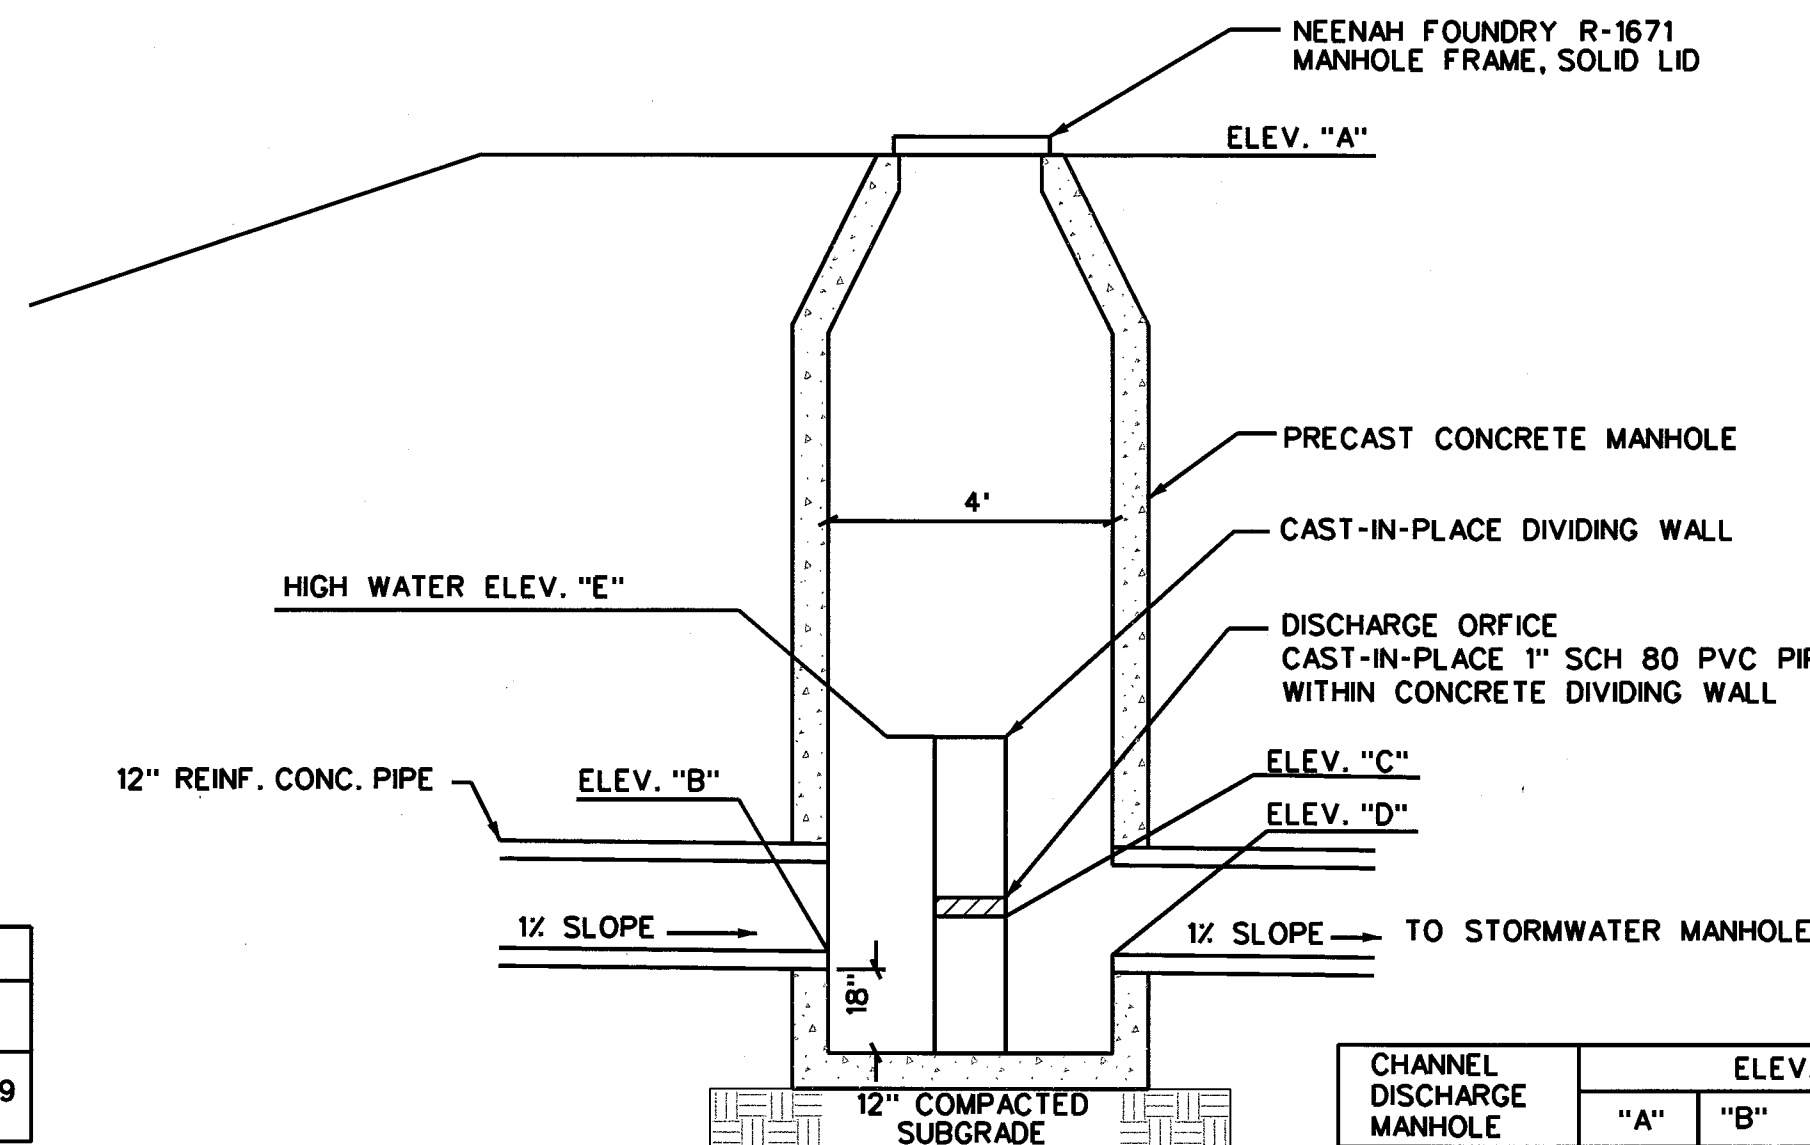


CHANNEL DISCHARGE MANHOLE	ELEVATIONS				
	"A"	"B"	"C"	"D"	"E"
WEST (MH-1)	985.50	973.86	973.86	973.36	981.25
EAST (MH-2)	981.20	976.09	976.09	975.59	980.50

CHANNEL DISCHARGE MANHOLES 6
NTS 7

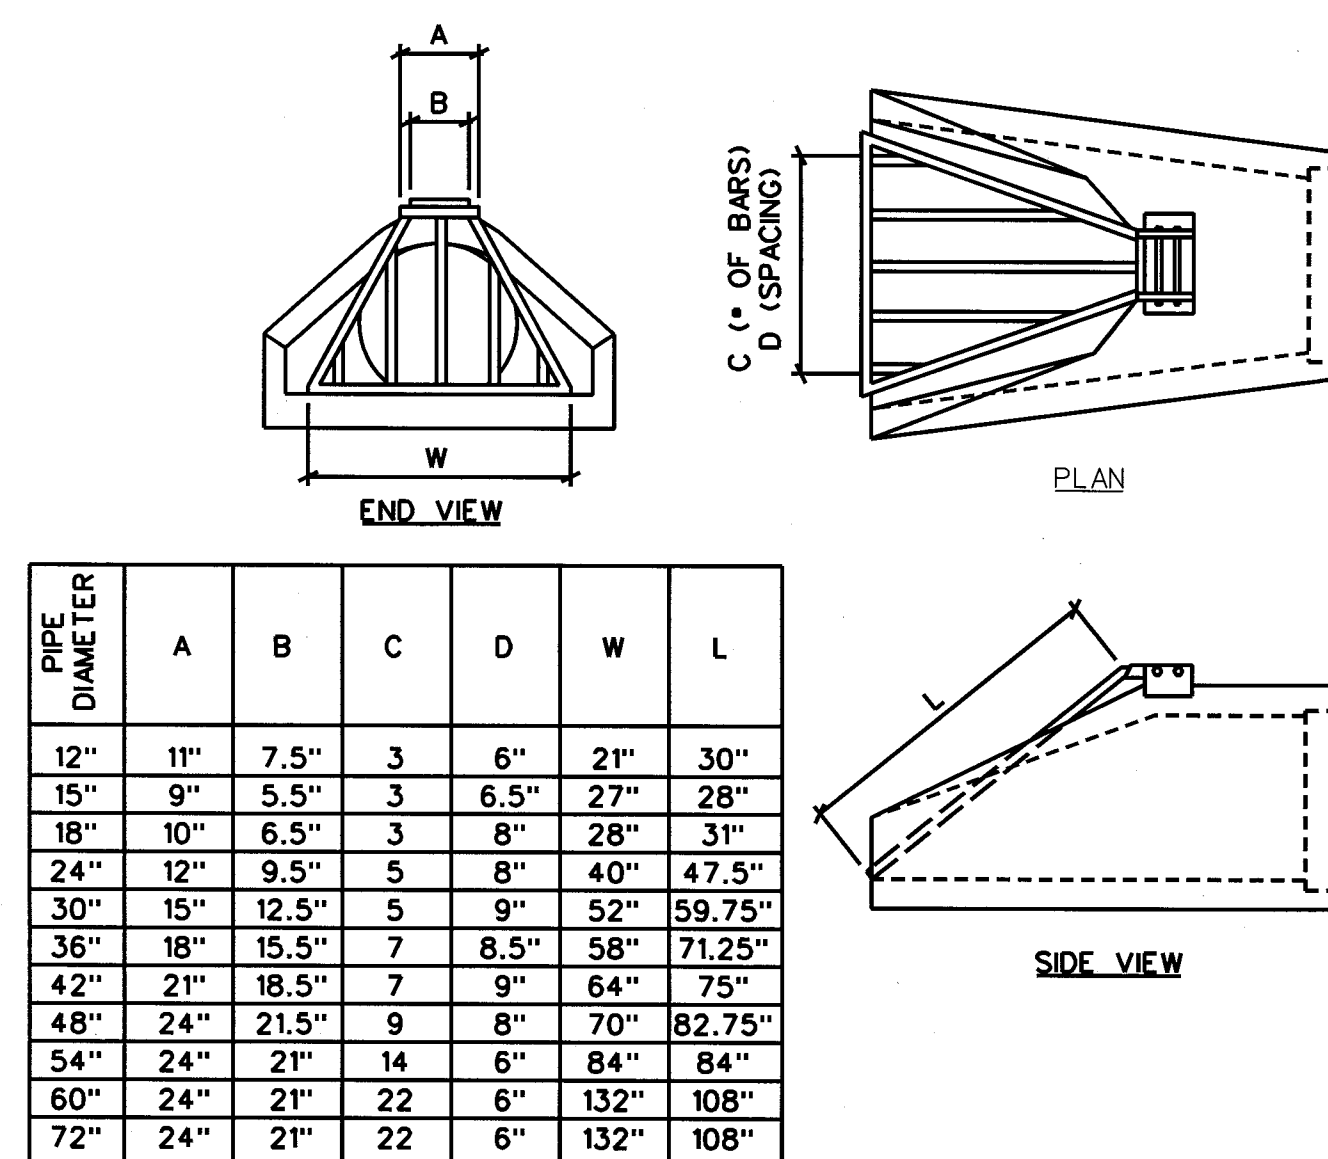


PIPE DIAMETER	A	B	C	D	W	L
12"	11"	7.5"	3	6"	21"	30"
15"	9"	5.5"	3	6.5"	27"	28"
18"	10"	6.5"	3	8"	28"	31"
24"	12"	9.5"	5	8"	40"	47.5"
30"	15"	12.5"	5	9"	52"	59.75"
36"	18"	15.5"	7	8.5"	58"	71.25"
42"	21"	18.5"	7	9"	64"	75"
48"	24"	21.5"	9	8"	70"	82.75"
54"	24"	21"	14	6"	84"	84"
60"	24"	21"	22	6"	132"	108"
72"	24"	21"	22	6"	132"	108"

FLARED END SECTION WITH GRATE 7
NTS 7

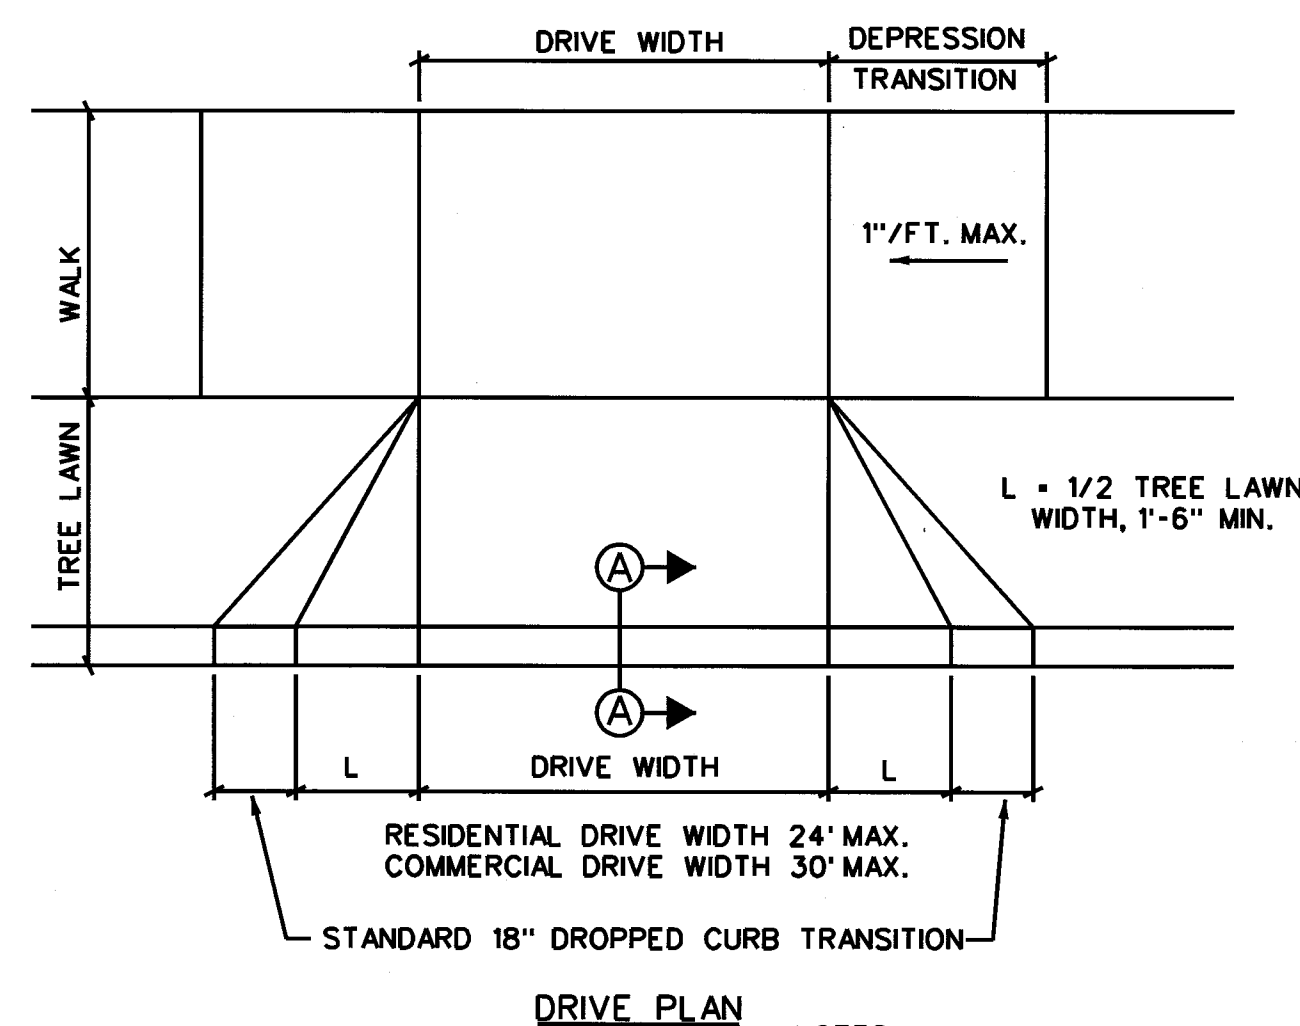


DRIVEWAY APPROACH DETAIL 8
NTS 7

- NOTES:
- ANY DEVIATION FROM THIS MUST BE APPROVED BY THE CITY ENGINEER.
 - CONCRETE SHALL BE 4000 PSICLASS C.
 - WHERE SIDEWALK DOESN'T EXIST, MAKE UNIFORM TRANSITION FROM APPROACH TO NEW PARKING LOT PAVEMENT.
 - WHERE CURB DOESN'T EXIST, MAKE UNIFORM TRANSITION TO EXISTING ROAD PAVEMENT.

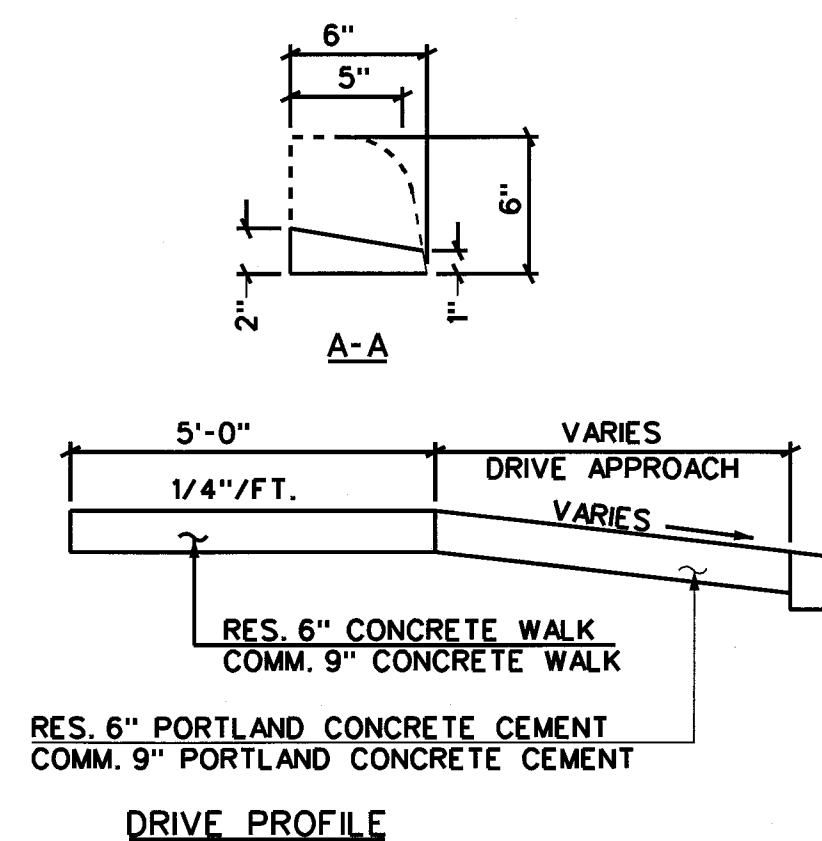


DRIVE PROFILE

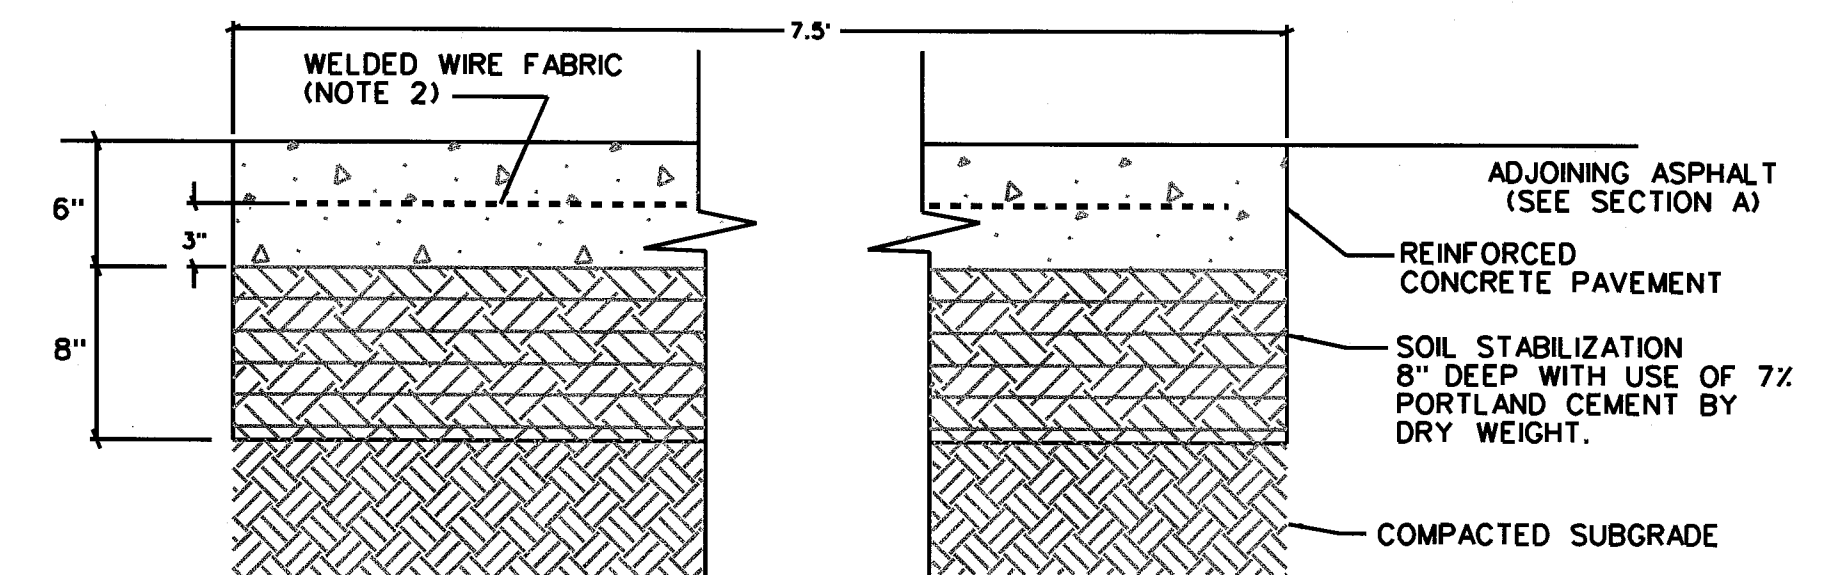

- NOTE:
- SEE PEPSI AMERICAS STANDARD SPECIFICATIONS 02700 FOR CONCRETE MIX, PLACEMENT, AND SUBGRADE COMPACTION REQUIREMENTS.
 - THE CONCRETE SHOULD HAVE 2/0 OR (W2.9) WELDED WIRE FABRIC WITH A 6-INCH SPACING IN THE LONGITUDINAL DIRECTION AND 6-INCH SPACING IN THE TRANSVERSE DIRECTION OF THE CONCRETE PAVEMENT STRIP. THE FABRIC SHOULD BE SET ON CHAIRS THAT SUPPORT THE FABRIC AT APPROXIMATELY 3-INCHES FROM THE BASE OF THE SLAB.
 - LANDING STRIPS TO BE LOCATED THROUGHOUT PROPOSED ASPHALT PAVEMENT. ACTUAL LOCATIONS OF LANDING STRIPS TO BE DETERMINED LATER WITH PARKING LAYOUT DESIGN.

TYPICAL LANDING STRIP SECTION 9
NTS 7

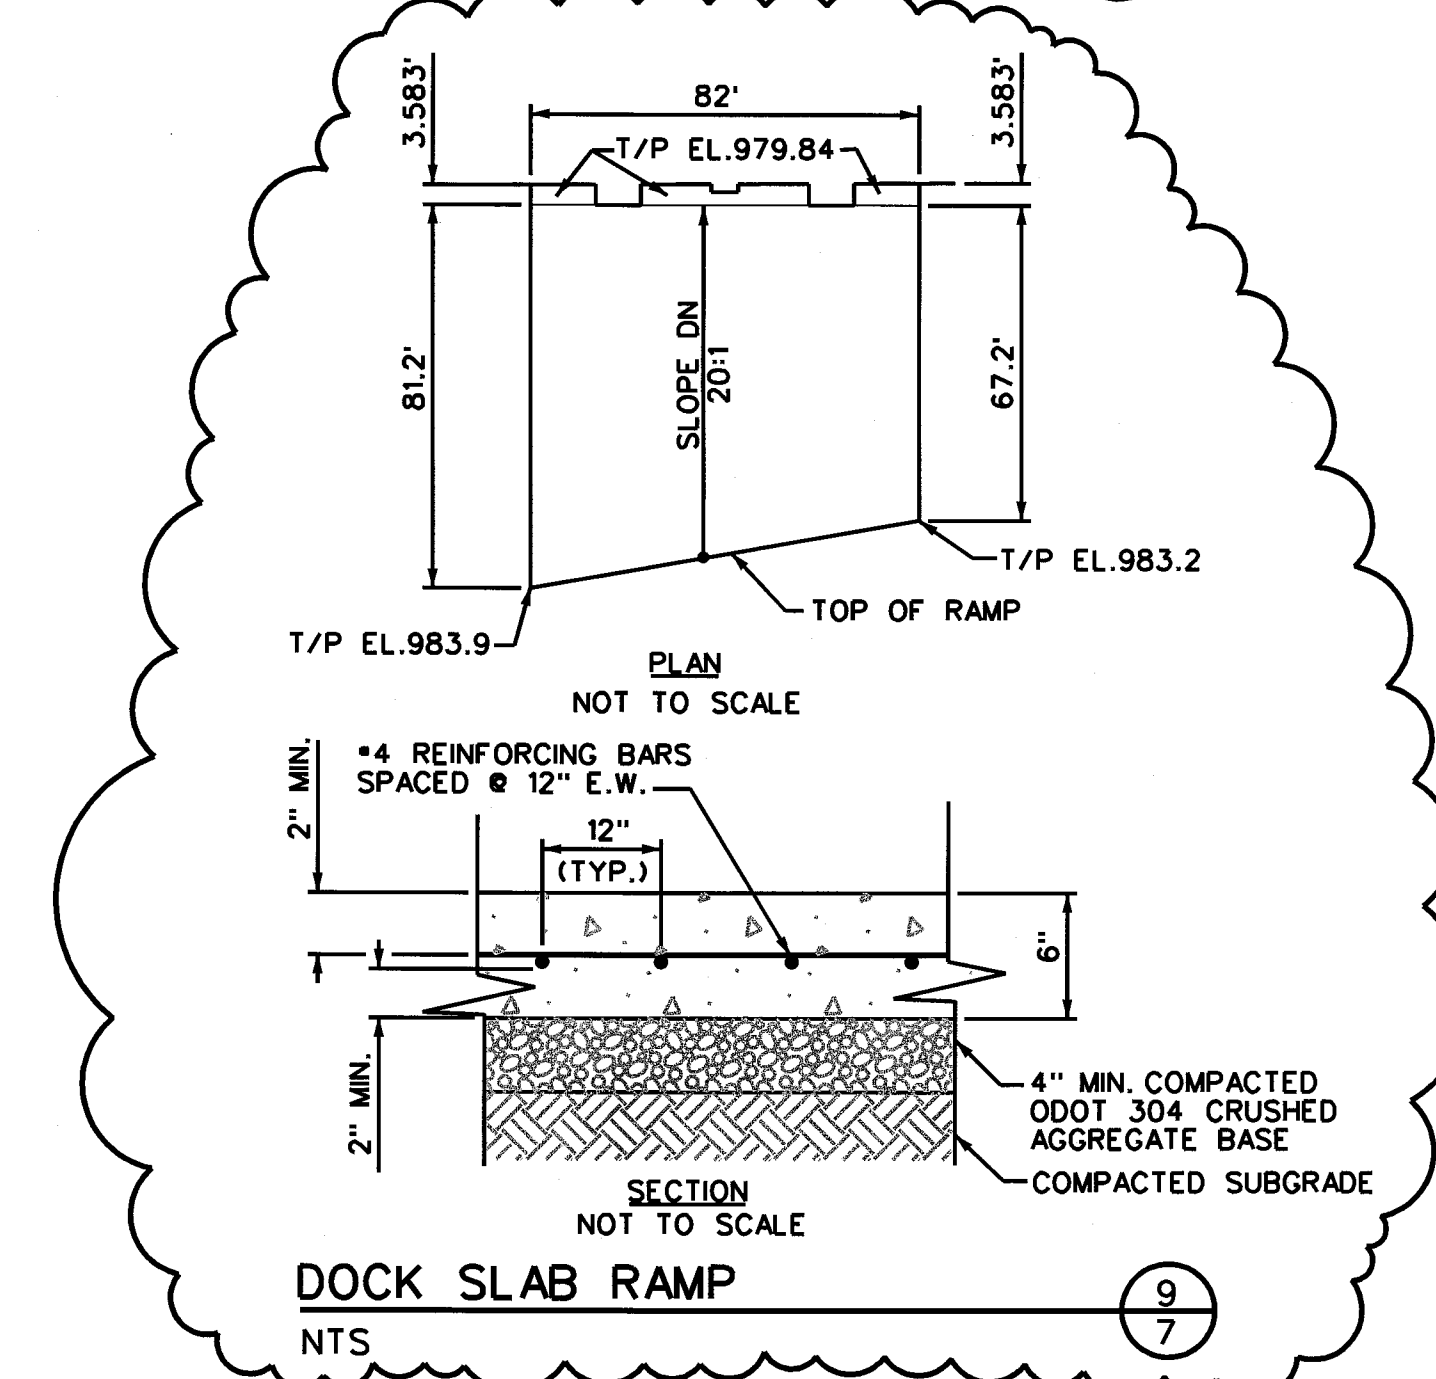


DOCK SLAB RAMP 9
NTS 7

REV	DATE	BY	DESCRIPTION	SCALE:	CLIENT:
2	02/12/08	TAB	ADDENDUM #1-FENCES, FLAG POLE, LIGHTS, SIGNS	AS SHOWN	PEPSI AMERICAS
1	12/12/07	LES	RESUBMITTAL #1 TO CITY OF MASSILLON	DESIGNED: LES/MWL	MASSILLON PARKING IMPROVEMENTS
0	11/21/07	LES	SUBMITTAL TO CITY OF MASSILLON	DRAWN: HHSI	MASSILLON, OHIO
				CHECKED: TAB	TITLE:
					DETAIL SHEET
					940 E. Diehl Rd, Suite 150 SHEET:
					Naperville, IL 60563 7
					(630) 637-9470 OF 14 SHEETS



HARD HAT SERVICES™
Engineering, Construction and Management Solutions

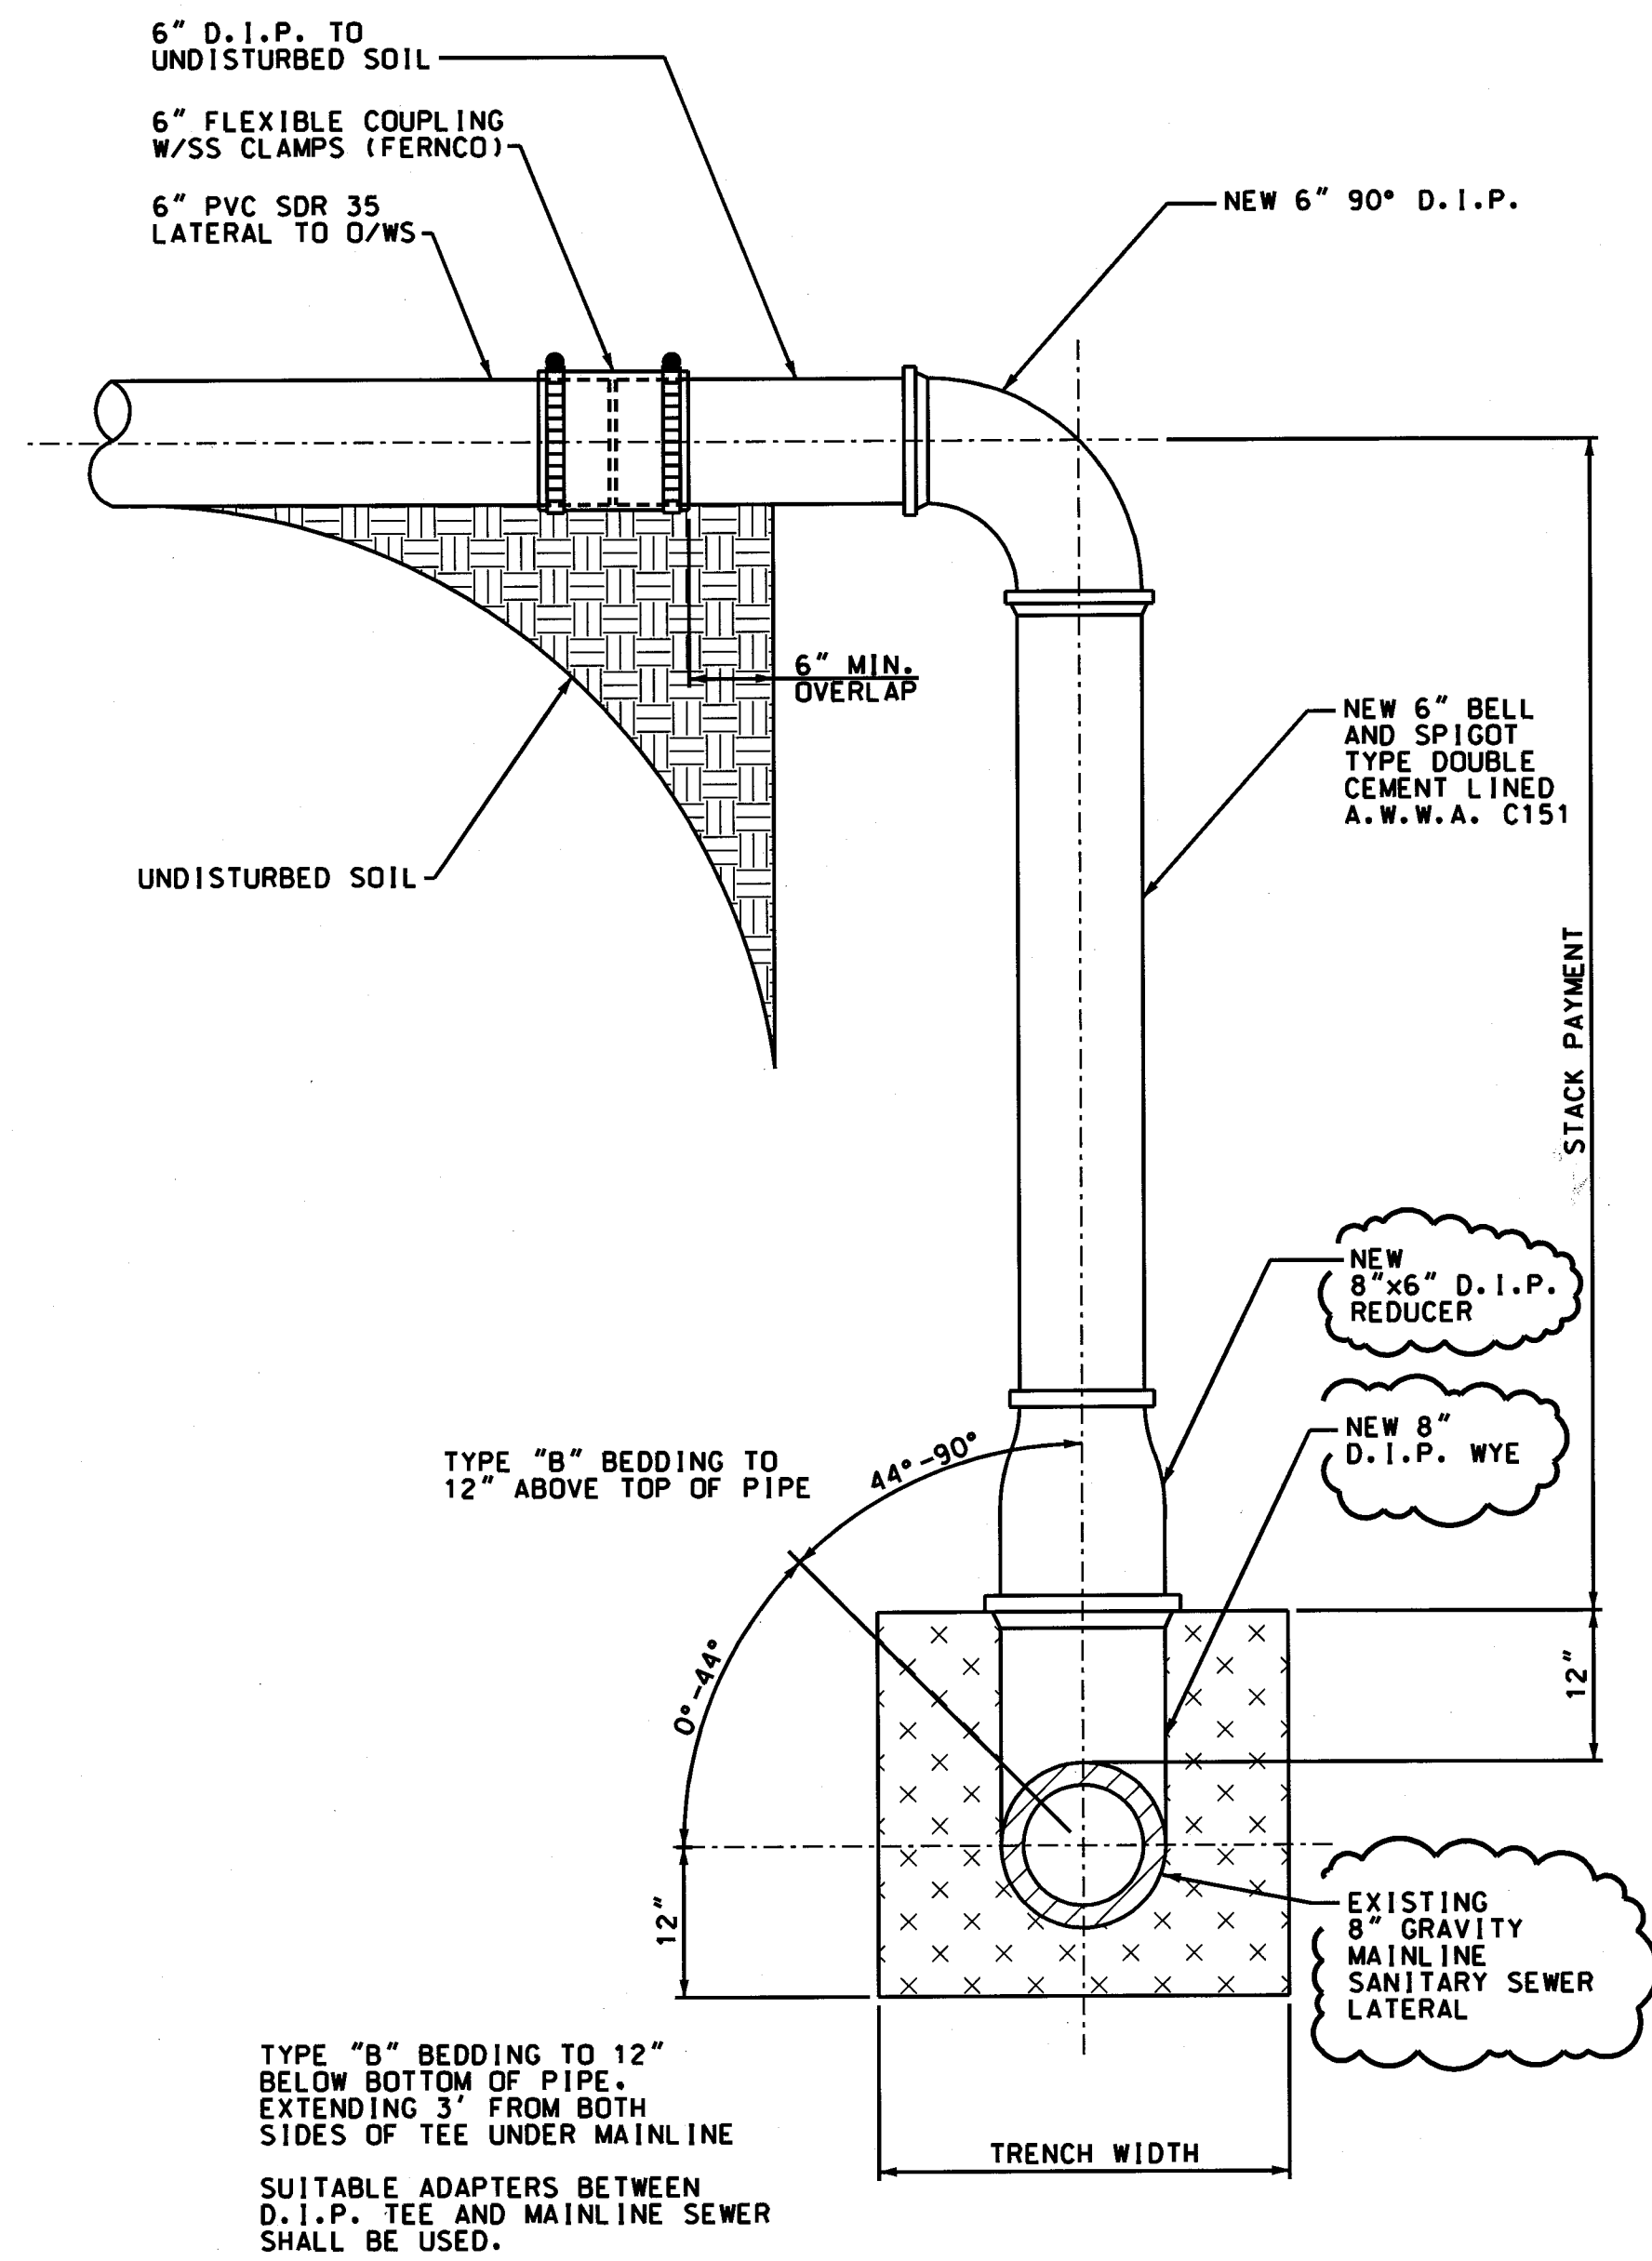


STACK LATERAL 1
NTS 8A


STACKS SHALL BE INSTALLED WHERE SHOWN ON PLANS OR AS REQUIRED BY ENGINEER

STACKS SHALL BE INSTALLED VERTICALLY UNLESS THE CITY ENGINEER APPROVES INSTALLATION FROM 44°-90°

WHERE SERVICE SEWER ENTERS MAINLINE FROM 0°-44° NO DUCTILE IRON PIPE AND FITTINGS ARE REQUIRED.

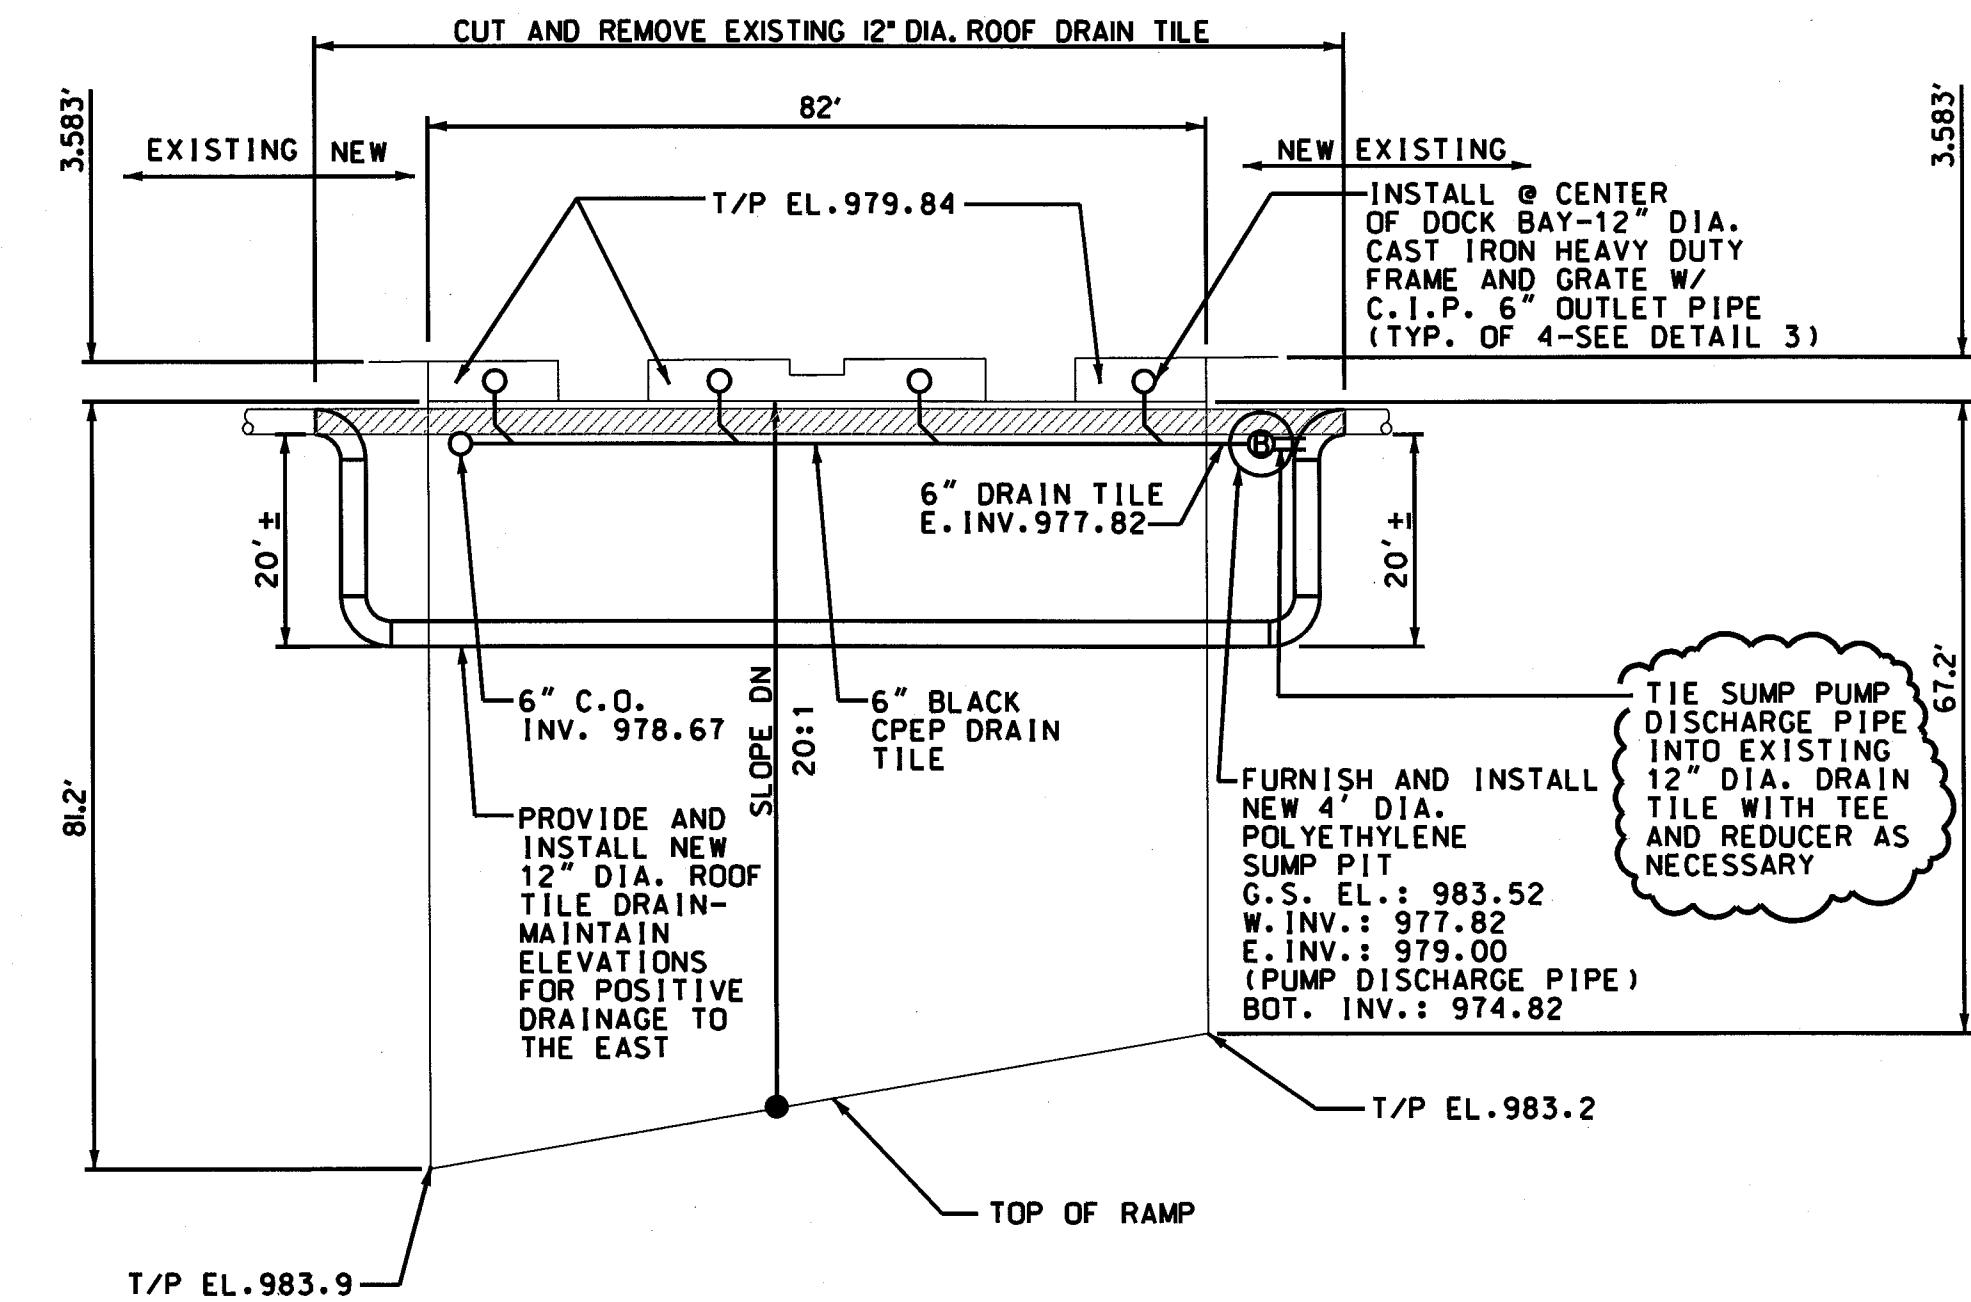

DOCK DRAINS AND SUMP PIT 2
NTS 8A

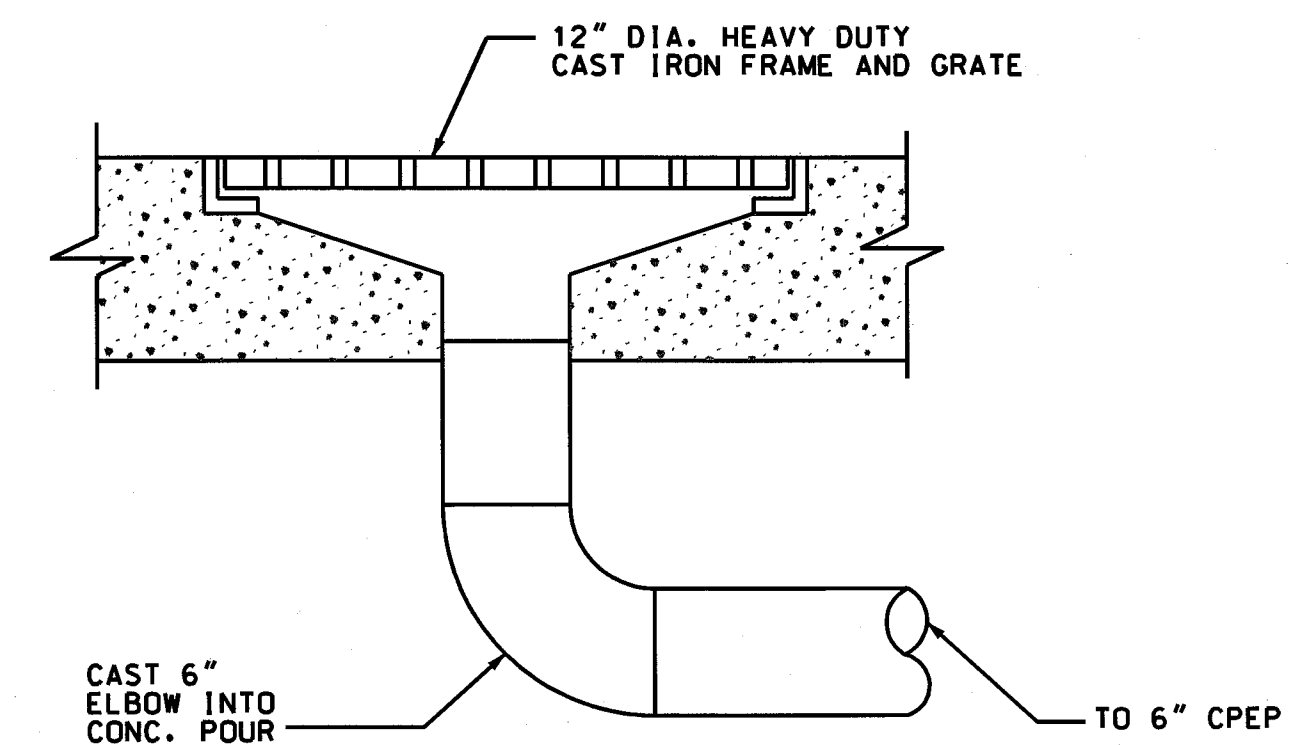

FRAME AND GRATE 3
NTS 8A


REV	DATE	BY	DESCRIPTION	SCALE:	CLIENT:
3	03/03/08	TAB	DOCK DRAINS, SANITARY	AS SHOWN	PEPSI AMERICAS
2	02/12/08	TAB	ADDENDUM #1-FENCES, FLAG POLE, LIGHTS, SIGNS		MASSILLON PARKING IMPROVEMENTS
1	12/12/07	LES	RESUBMITTAL #1 TO CITY OF MASSILLON	DESIGNED: LES/MWL	MASSILLON, OHIO
4	03/06/08	TAB	RESUBMITTAL #2 TO CITY OF MASSILLON	DRAWN: HHSI	
				CHECKED: TAB	
				TITLE: DETAIL SHEET	
				940 E. Diehl Rd, Suite 150 SHEET: 8A	
				Naperville, IL 60563	
				(630) 637-9470	
				OF 14 SHEETS	




HARD HAT SERVICES™
Engineering, Construction and Management Solutions

940 E. Diehl Rd, Suite 150
Naperville, IL 60563
(630) 637-9470


SHEET: 8A
OF 14 SHEETS

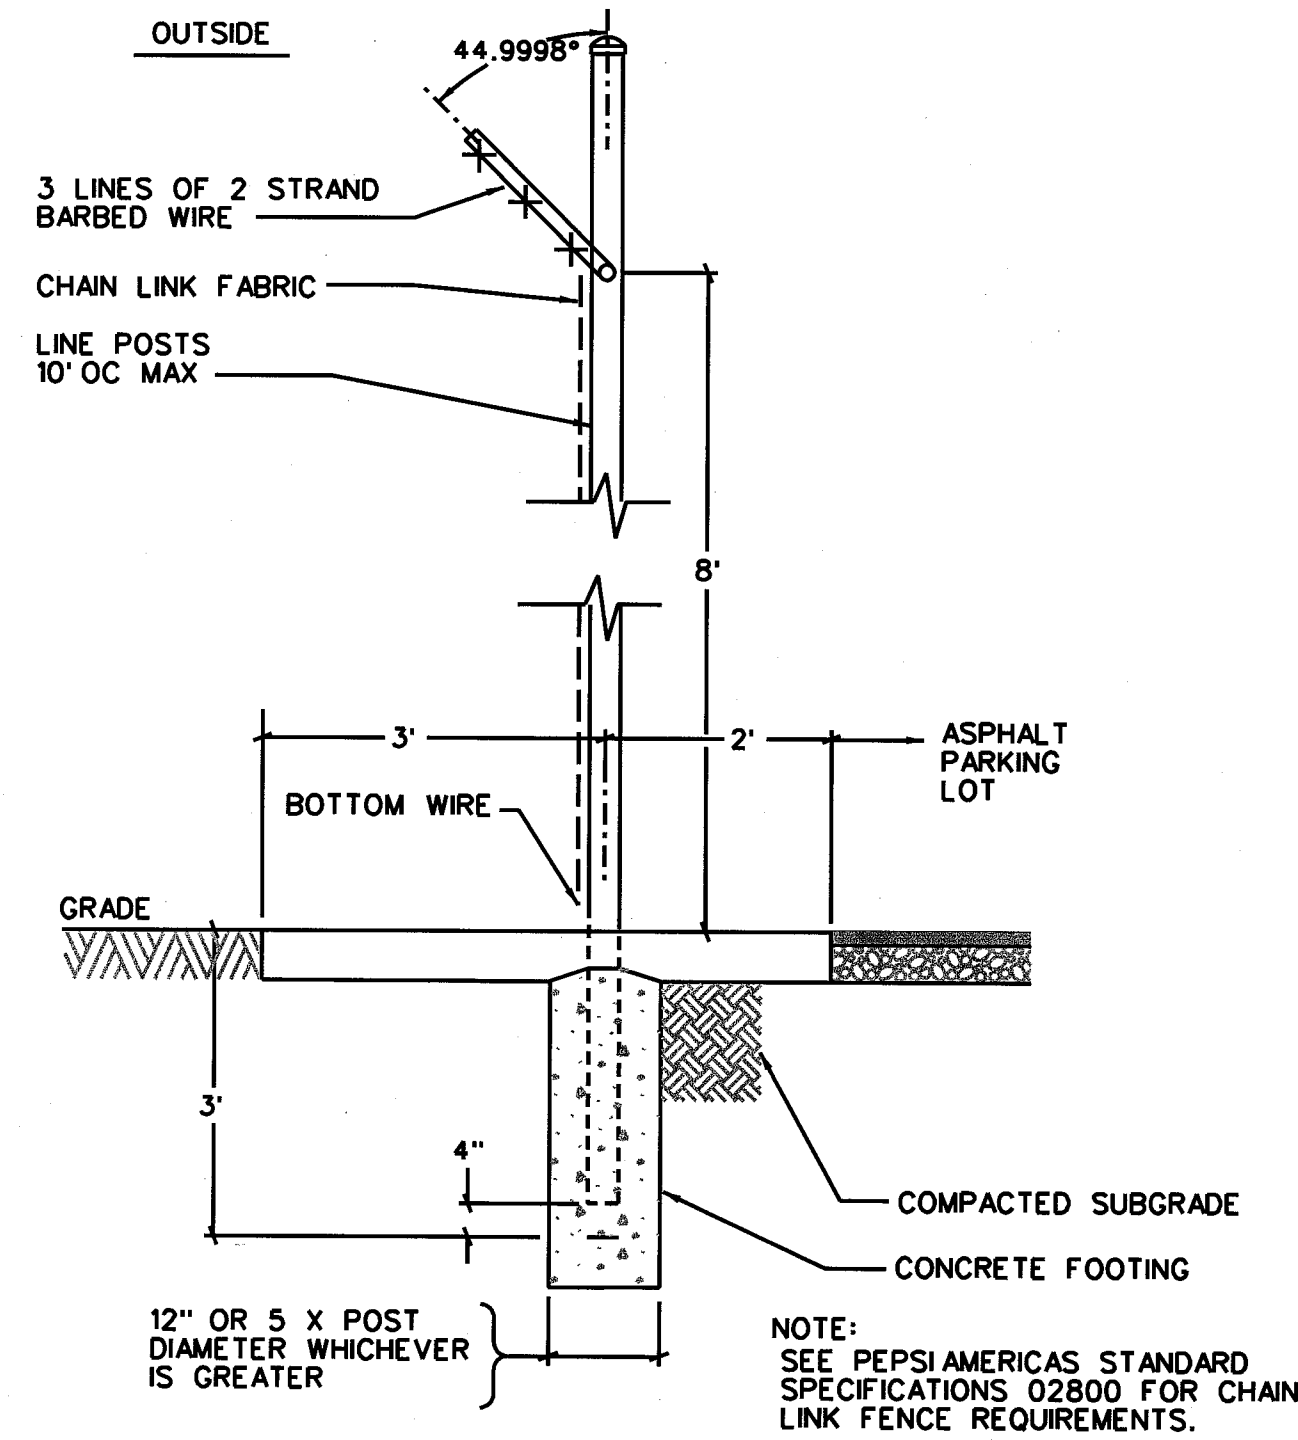


CHAIN LINK FENCE
NTS

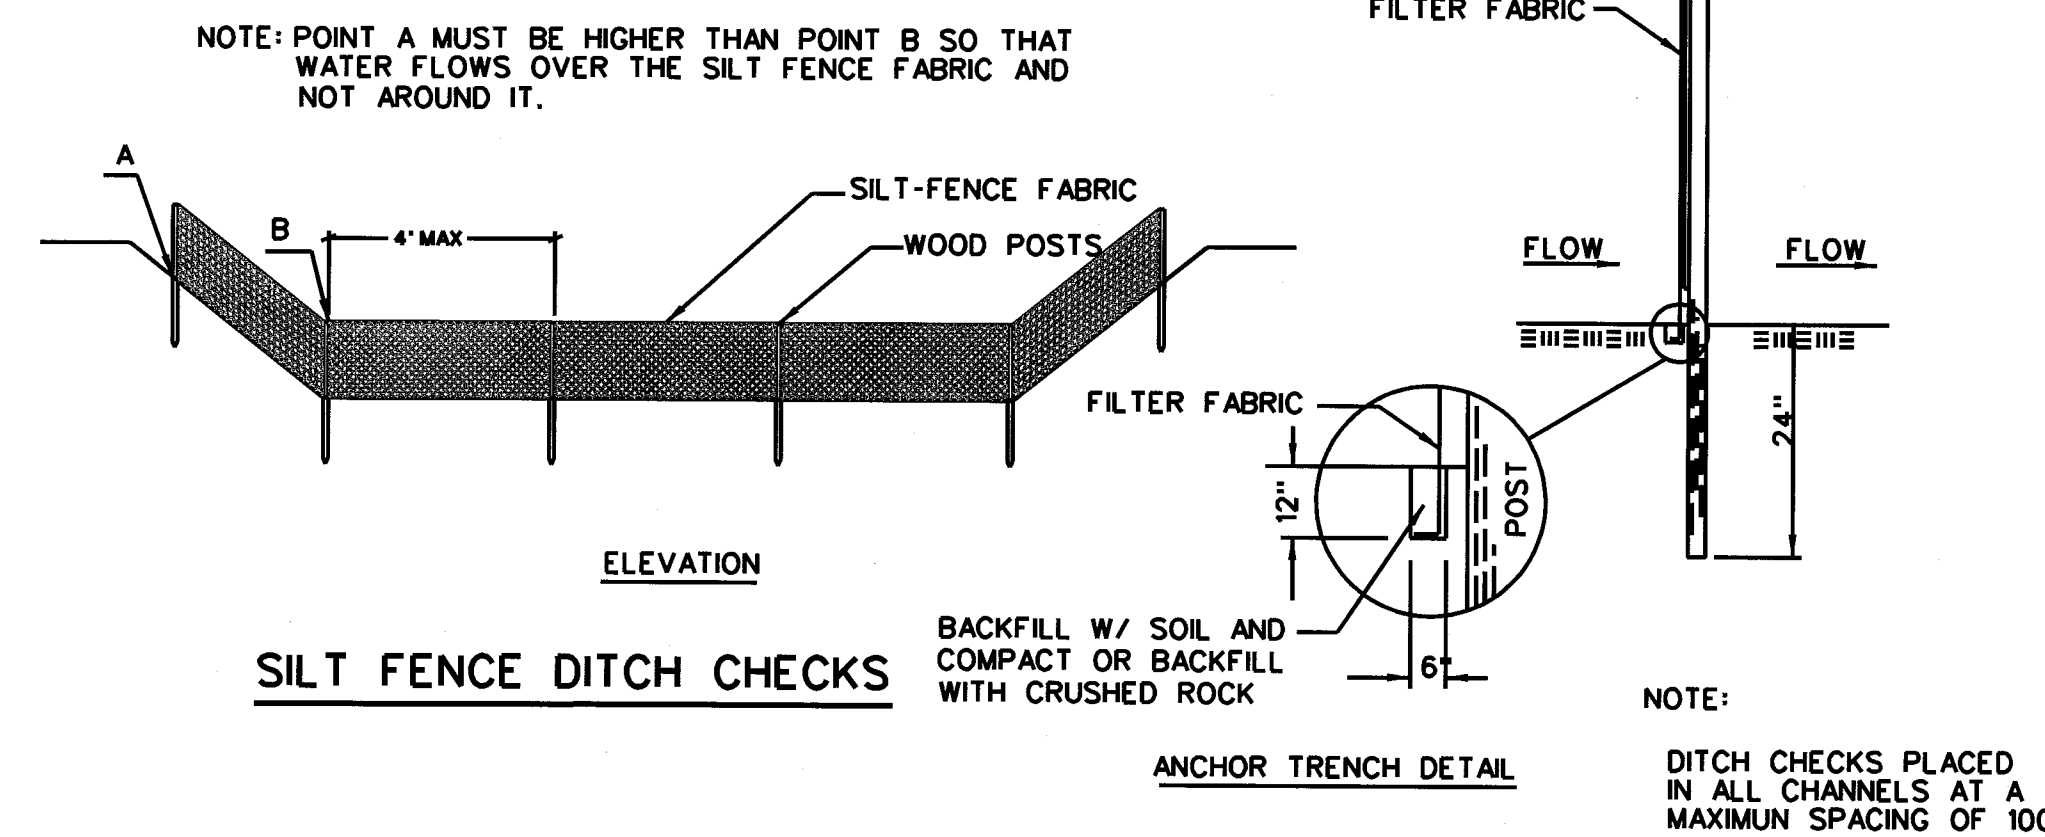


DITCH CHECK DETAILS
NTS

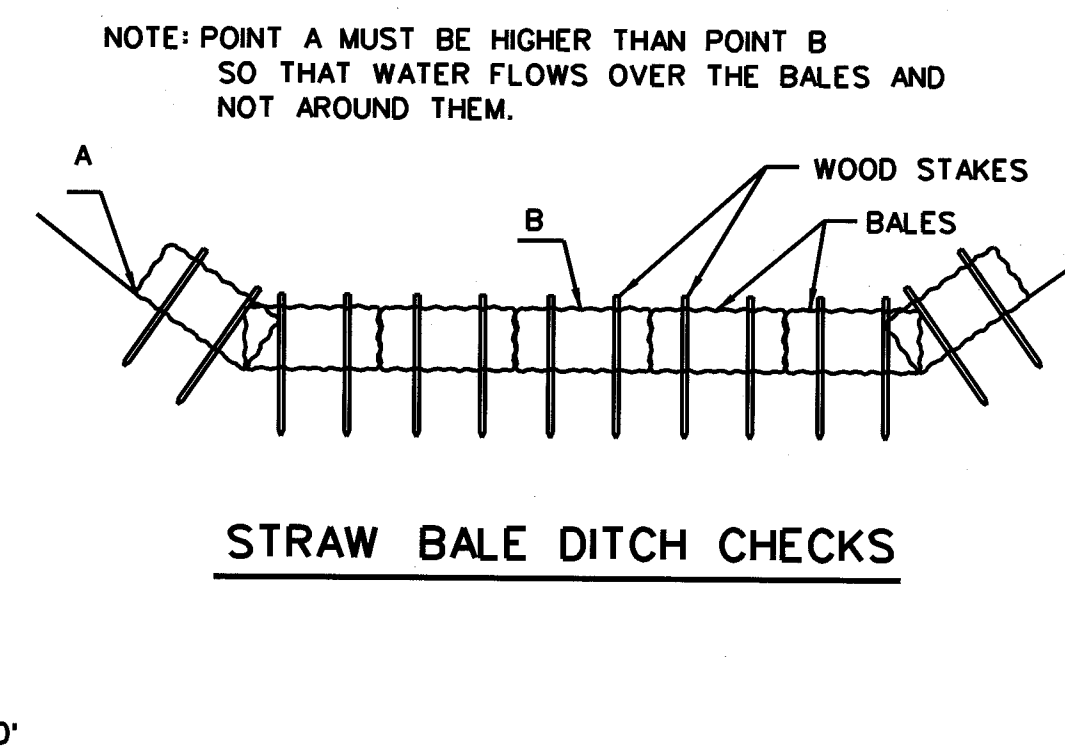


STRAW BALE DITCH CHECKS

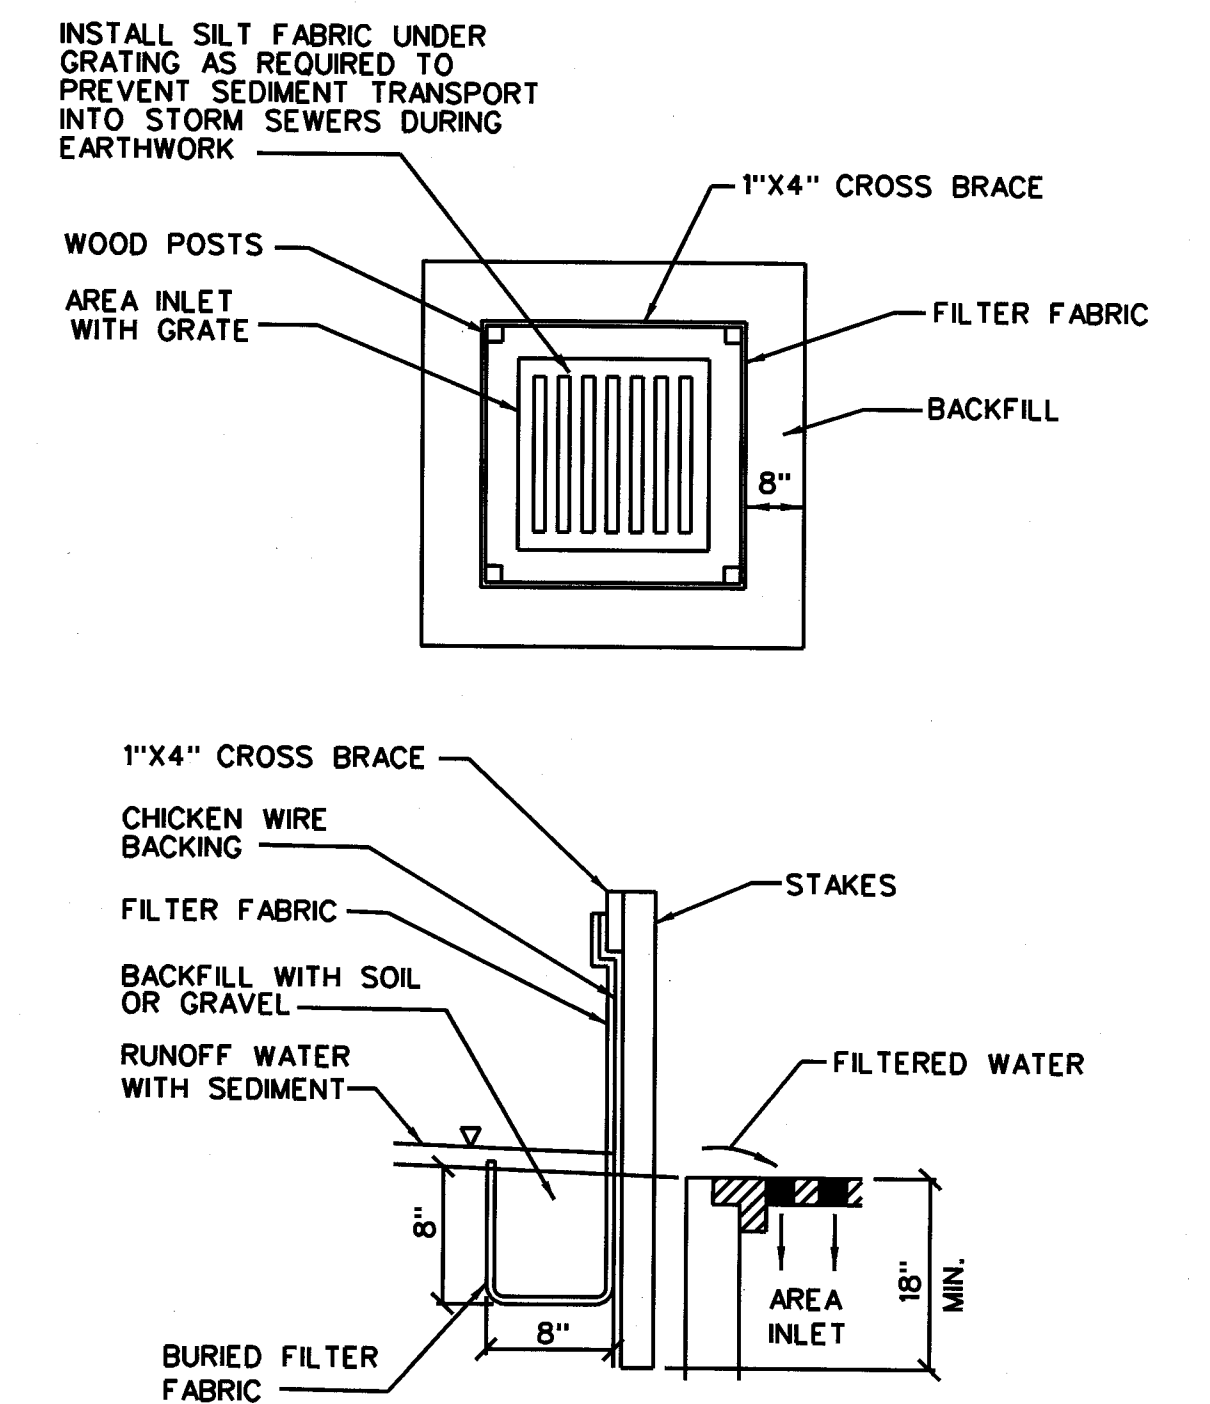


AREA INLET PROTECTION
NTS

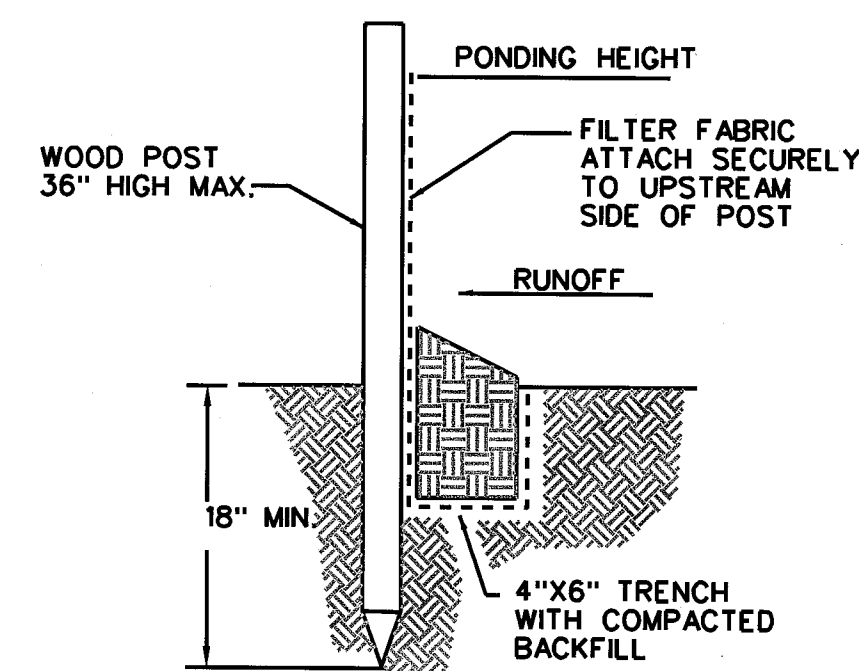


SILT FENCE BARRIERS

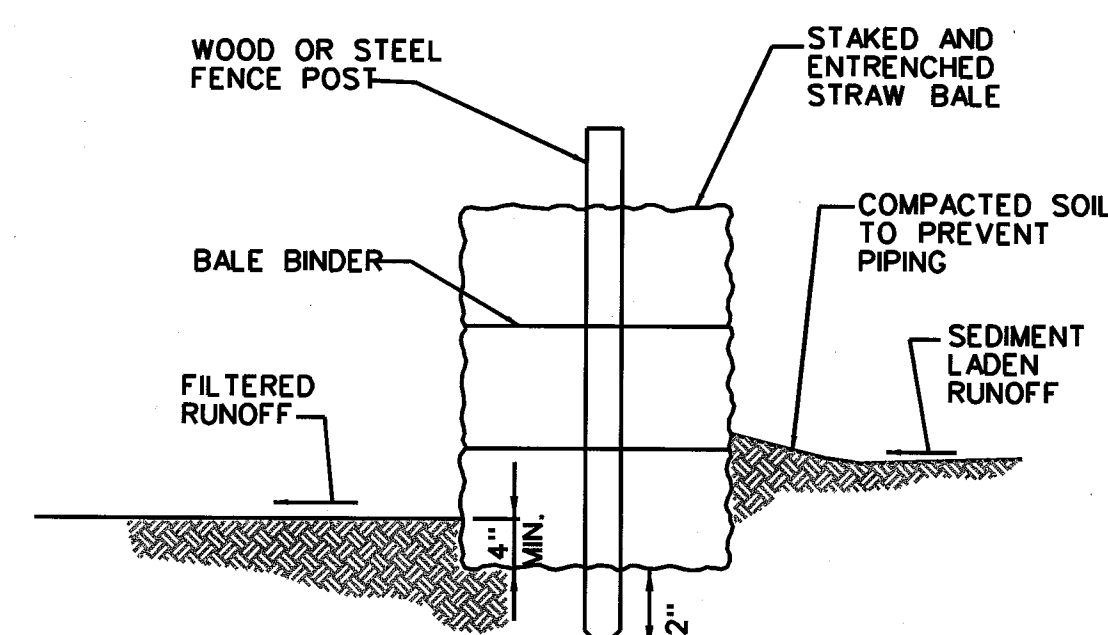

STRAW BALE BARRIERS

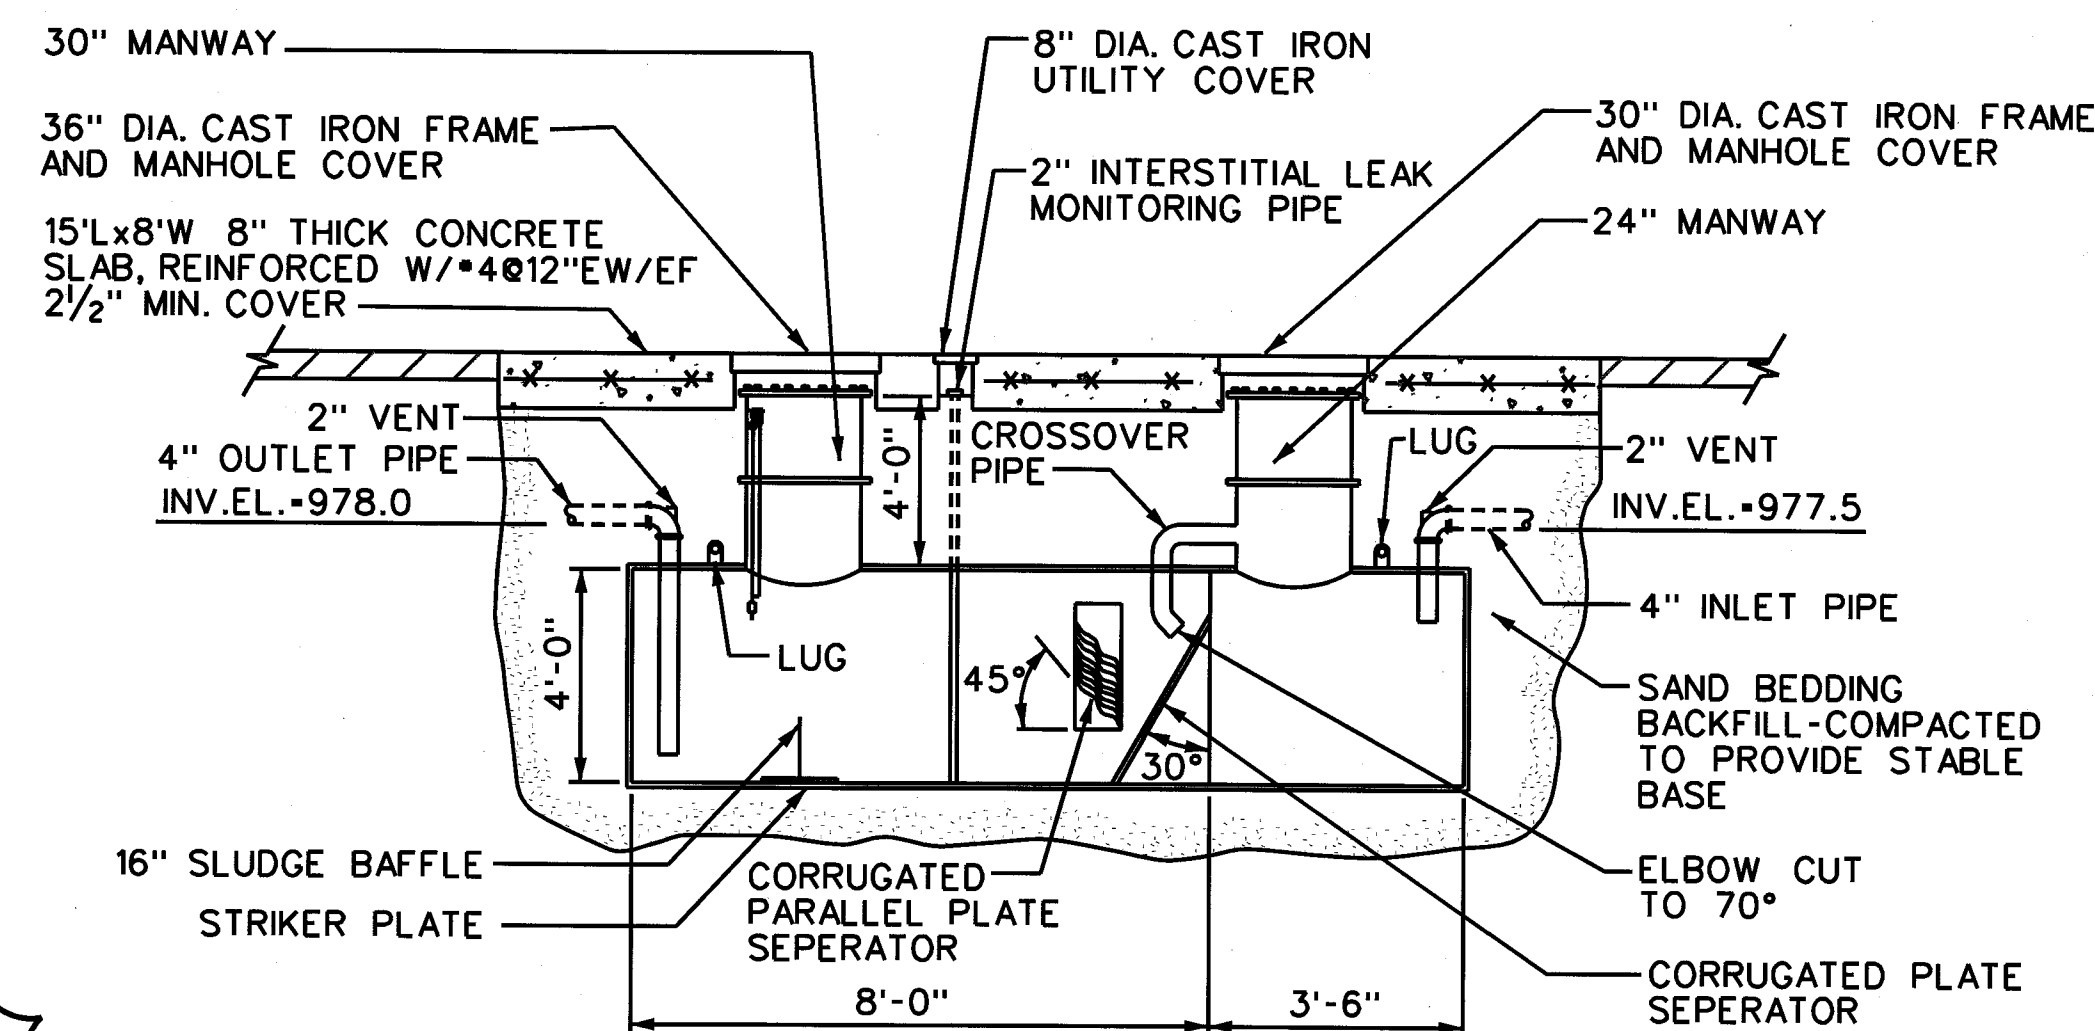

OIL WATER SEPARATOR
NOT TO SCALE

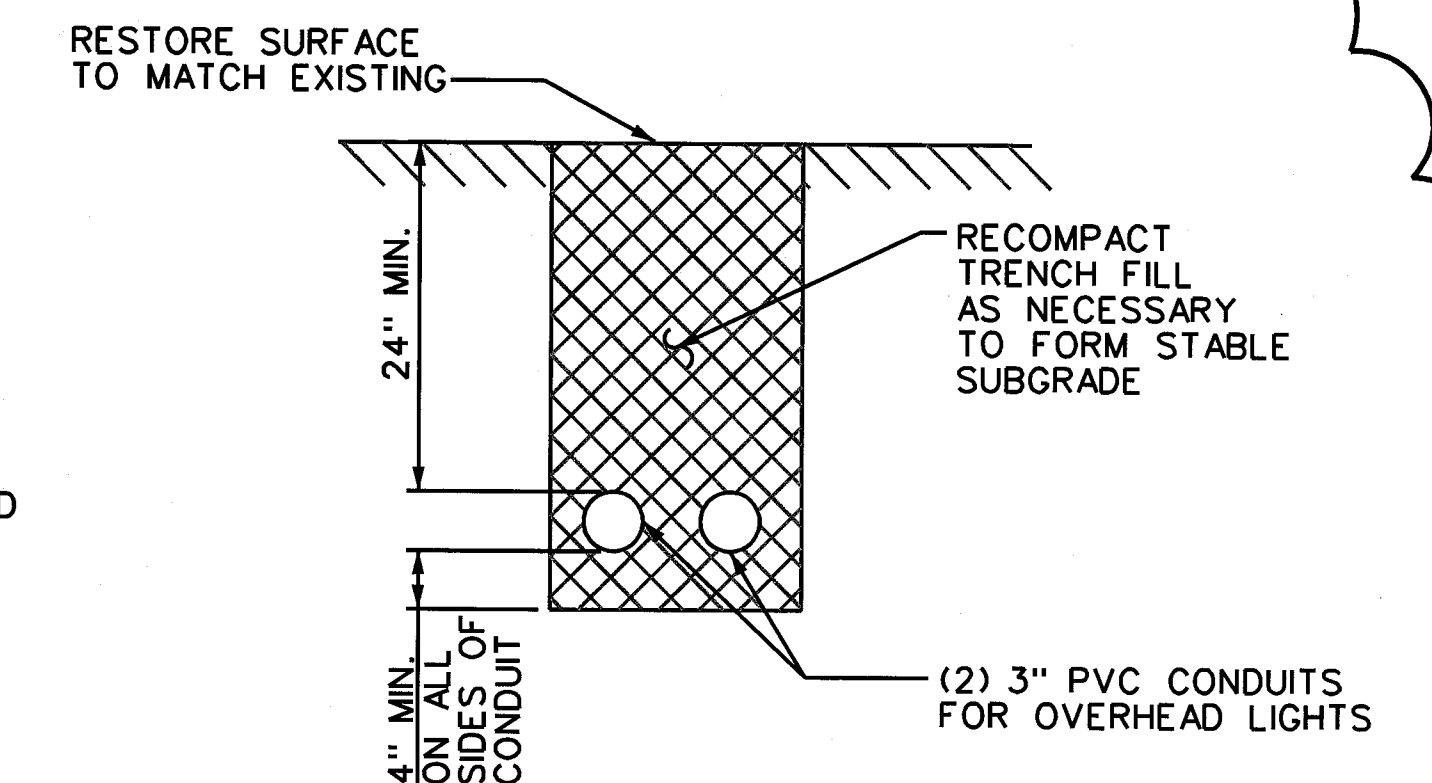

OVERHEAD LIGHT POWER TRENCH
NOT TO SCALE

SILT FENCE DETAILS
NTS





REV	DATE	BY	DESCRIPTION	SCALE:	CLIENT:
				AS SHOWN	PEPSI AMERICAS MASSILLON PARKING IMPROVEMENTS MASSILLON, OHIO
2	02/12/08	TAB	ADDENDUM #1-FENCES, FLAG POLE, LIGHTS, SIGNS	DESIGNED: LES/MWL	TITLE:
1	12/12/07	LES	RESUBMITTAL #1 TO CITY OF MASSILLON	DRAWN: HHSI	DETAIL SHEET
0	11/21/07	LES	SUBMITTAL TO CITY OF MASSILLON	CHECKED: TAB	



HARD HAT SERVICES™
Engineering, Construction and Management Solutions

940 E. Diehl Rd, Suite 150
Naperville, IL 60563
(630) 637-9470

SHEET:
8
OF 14 SHEETS

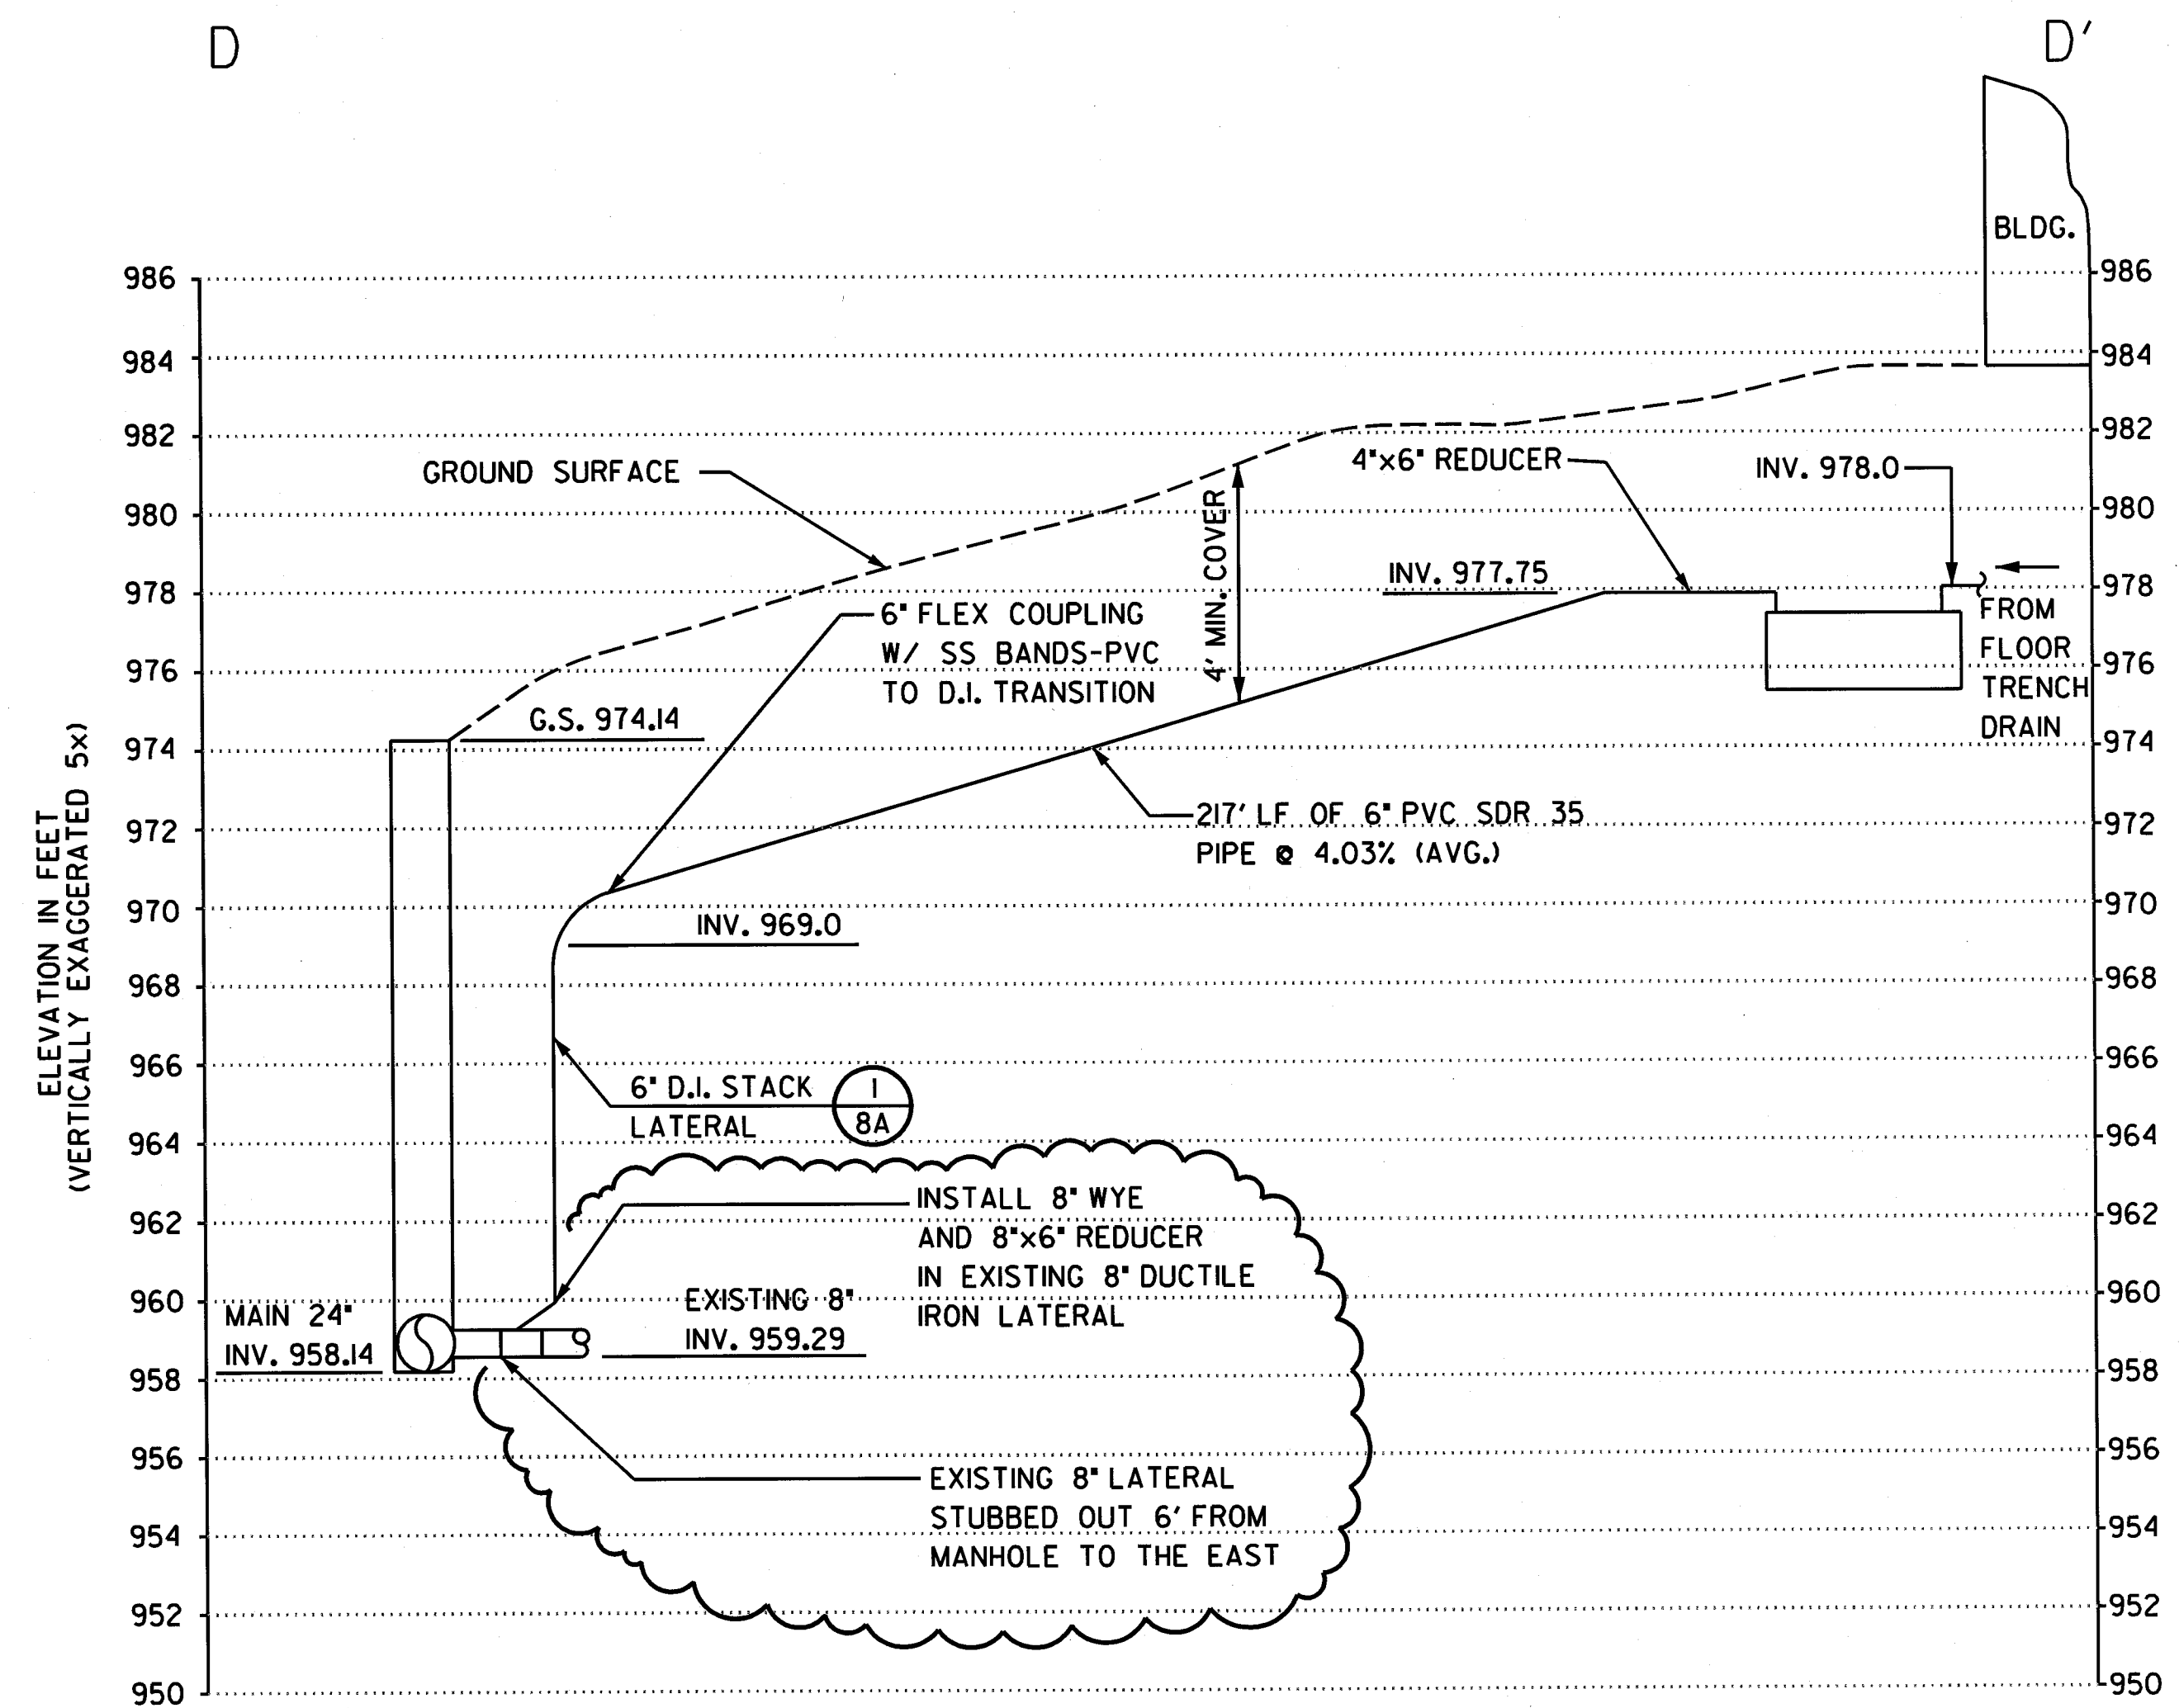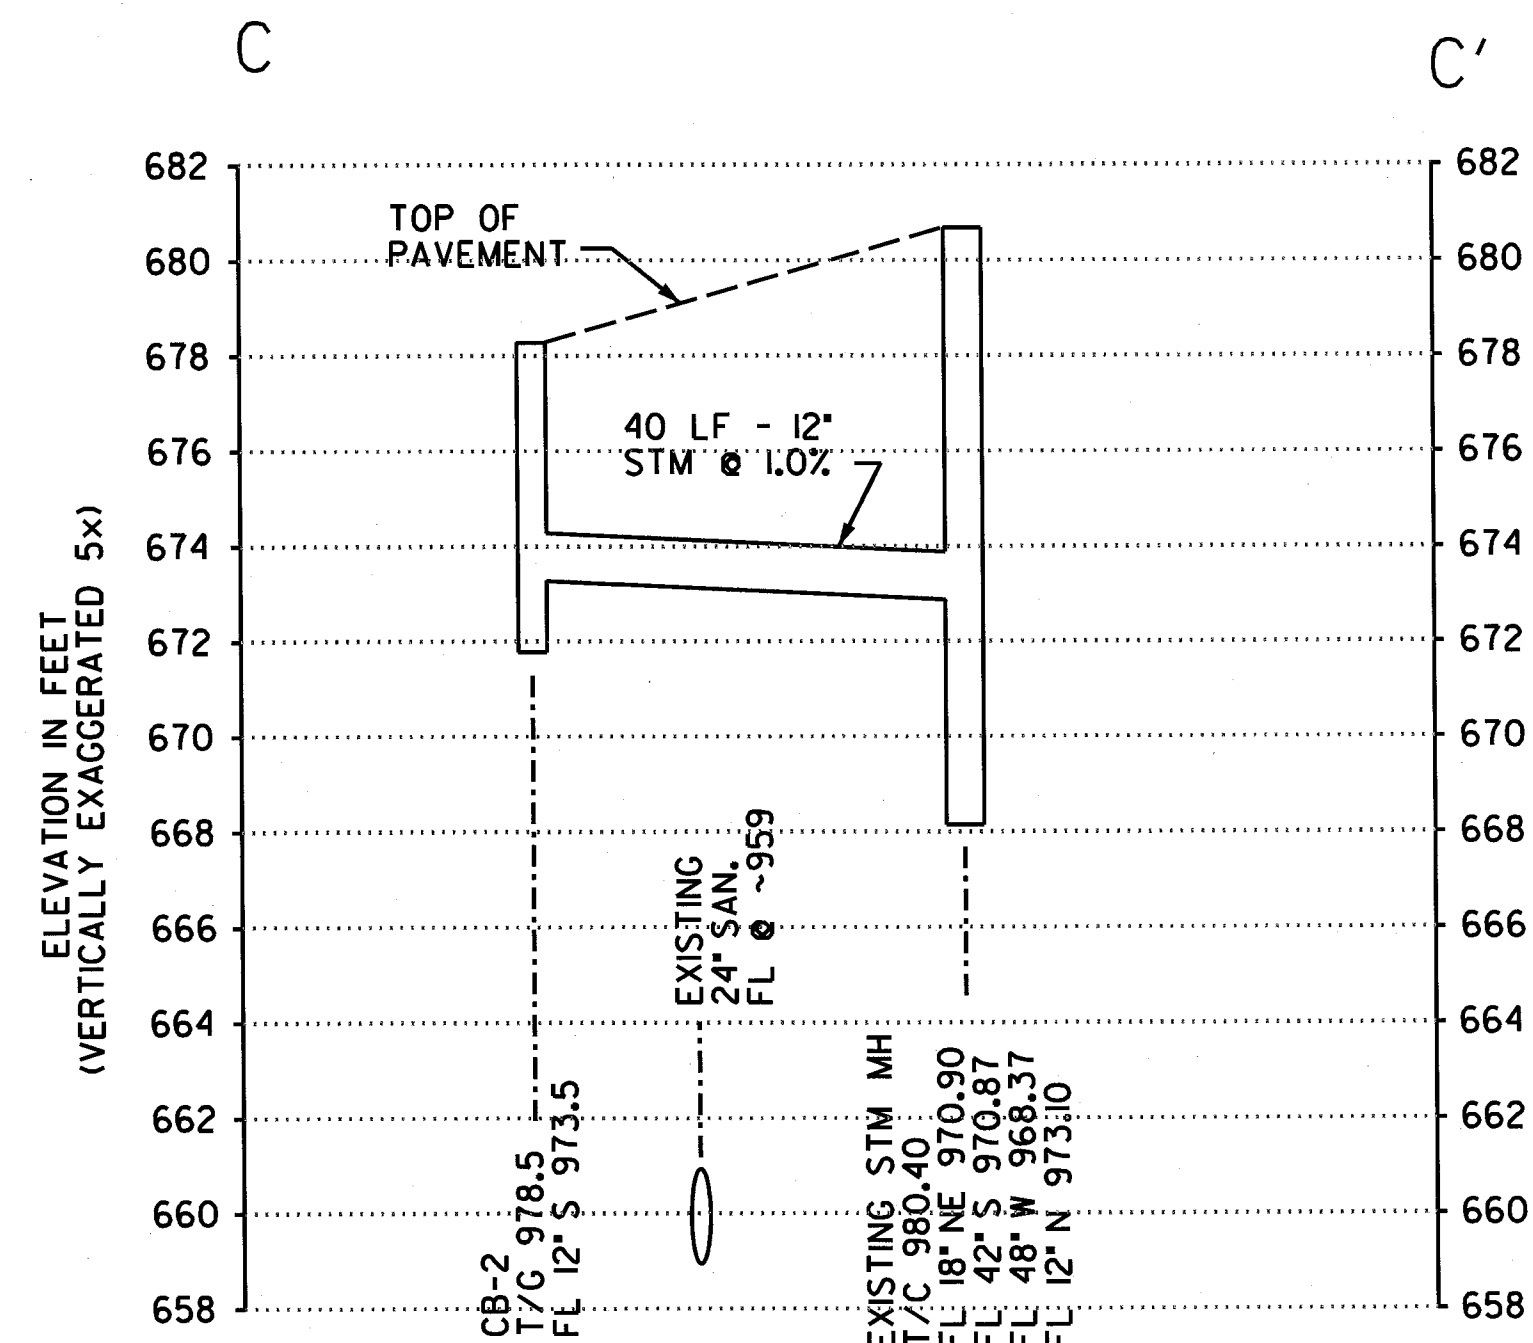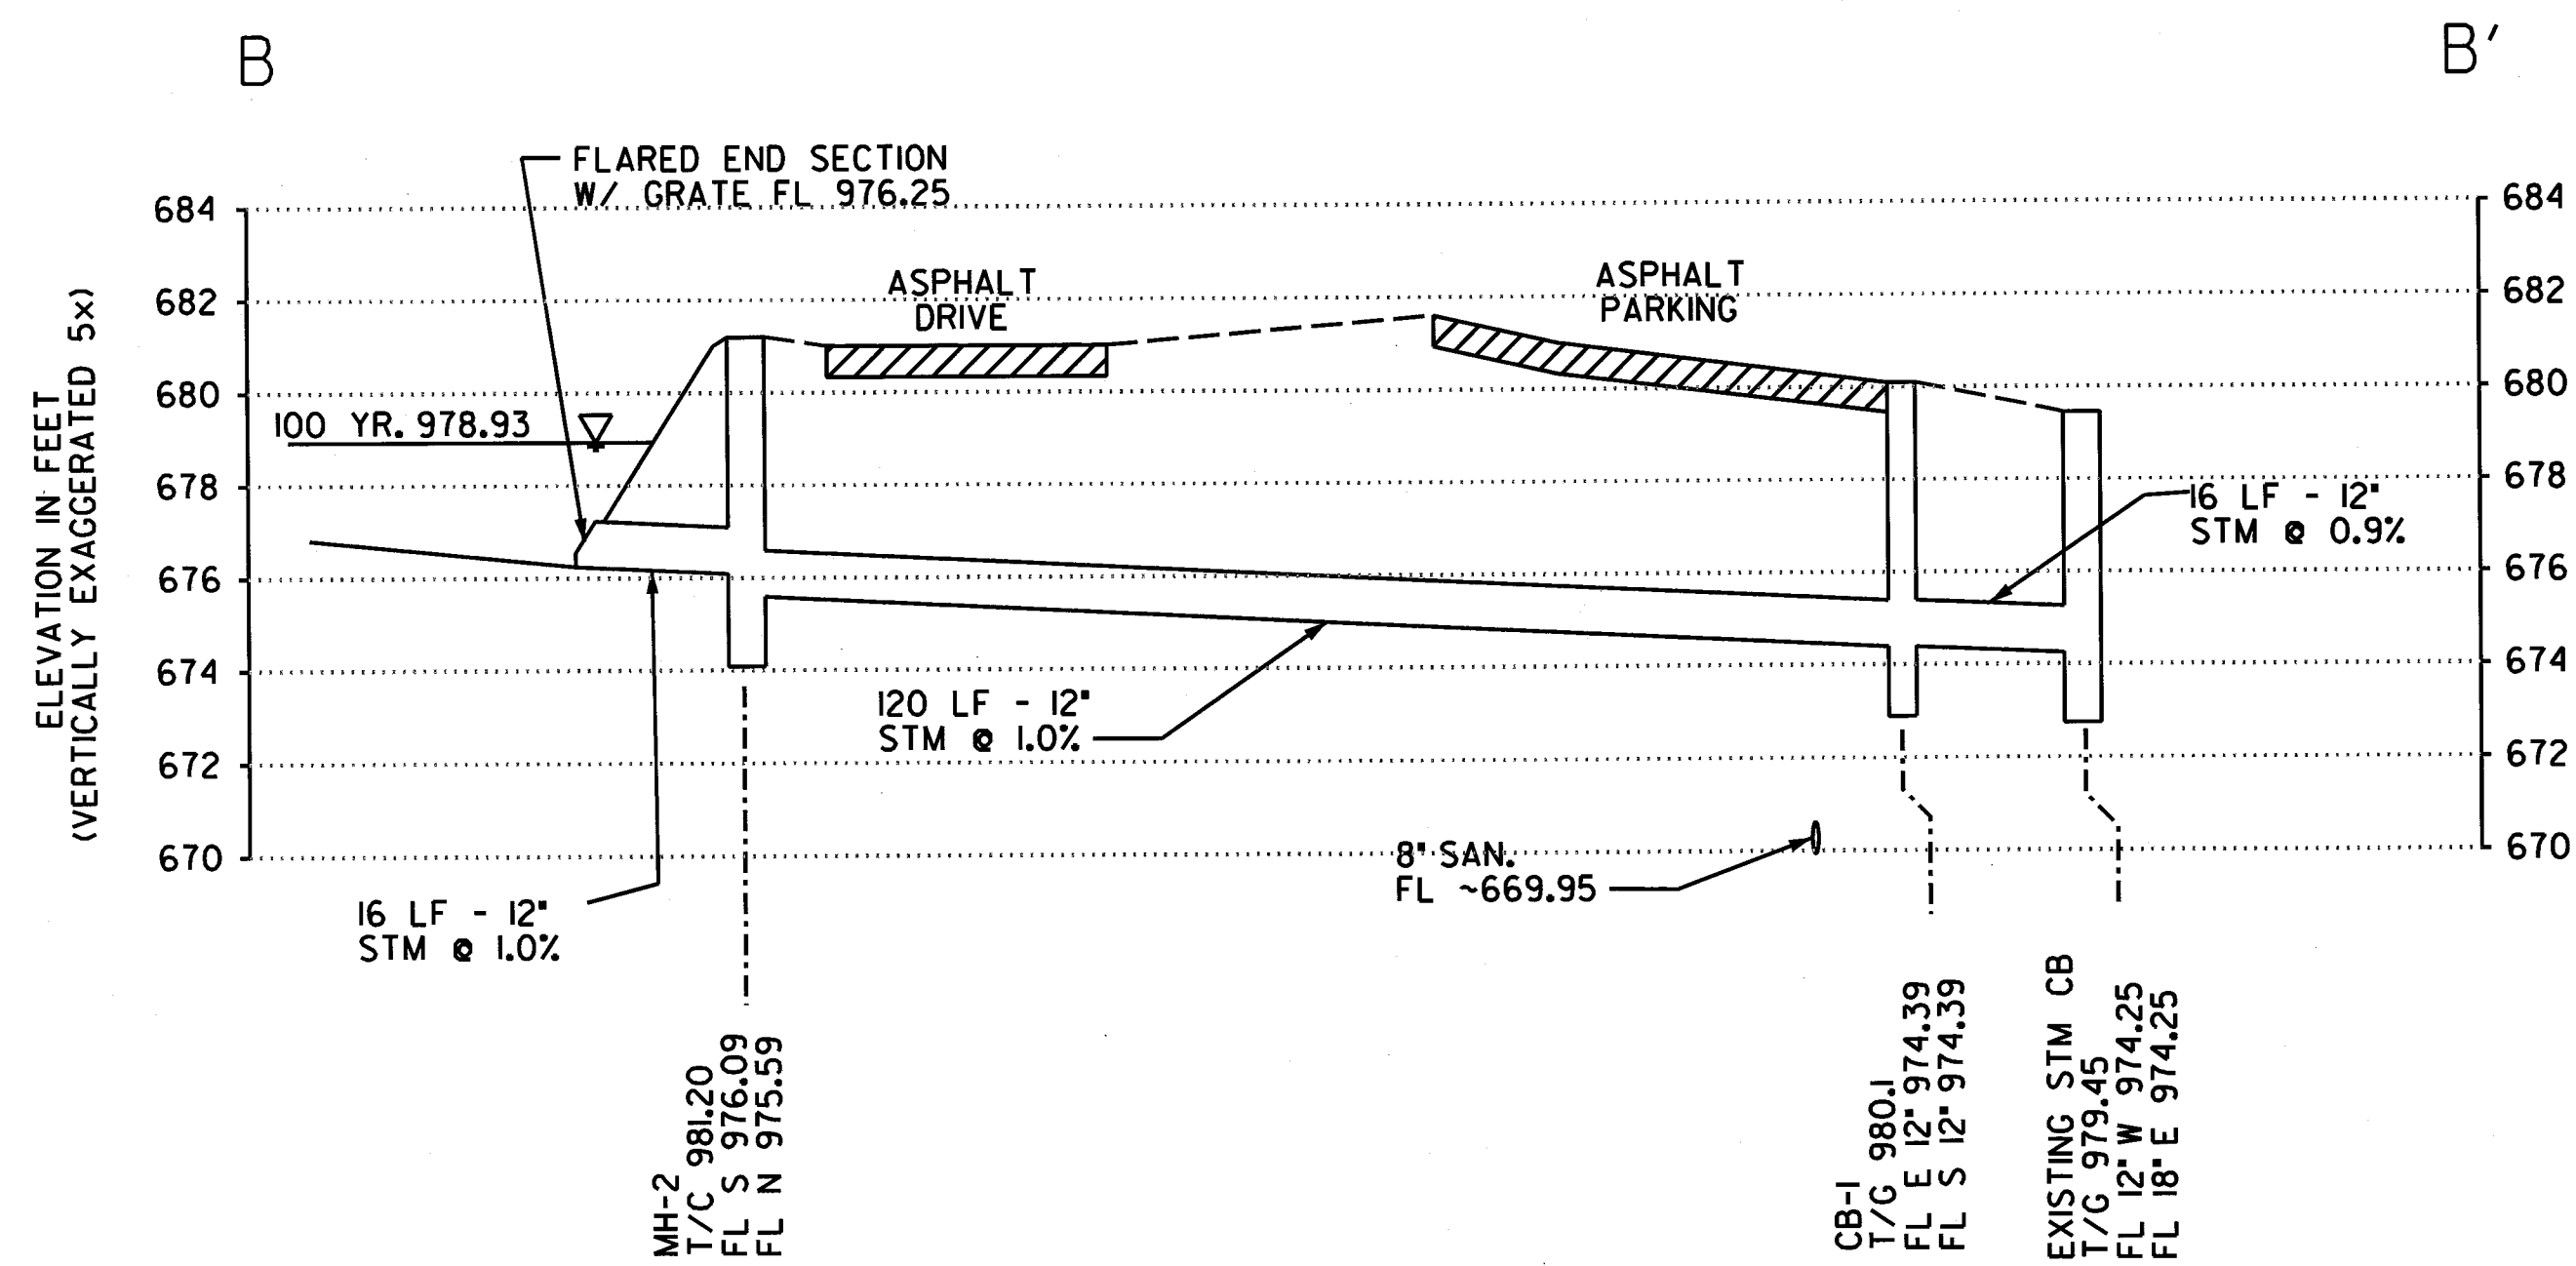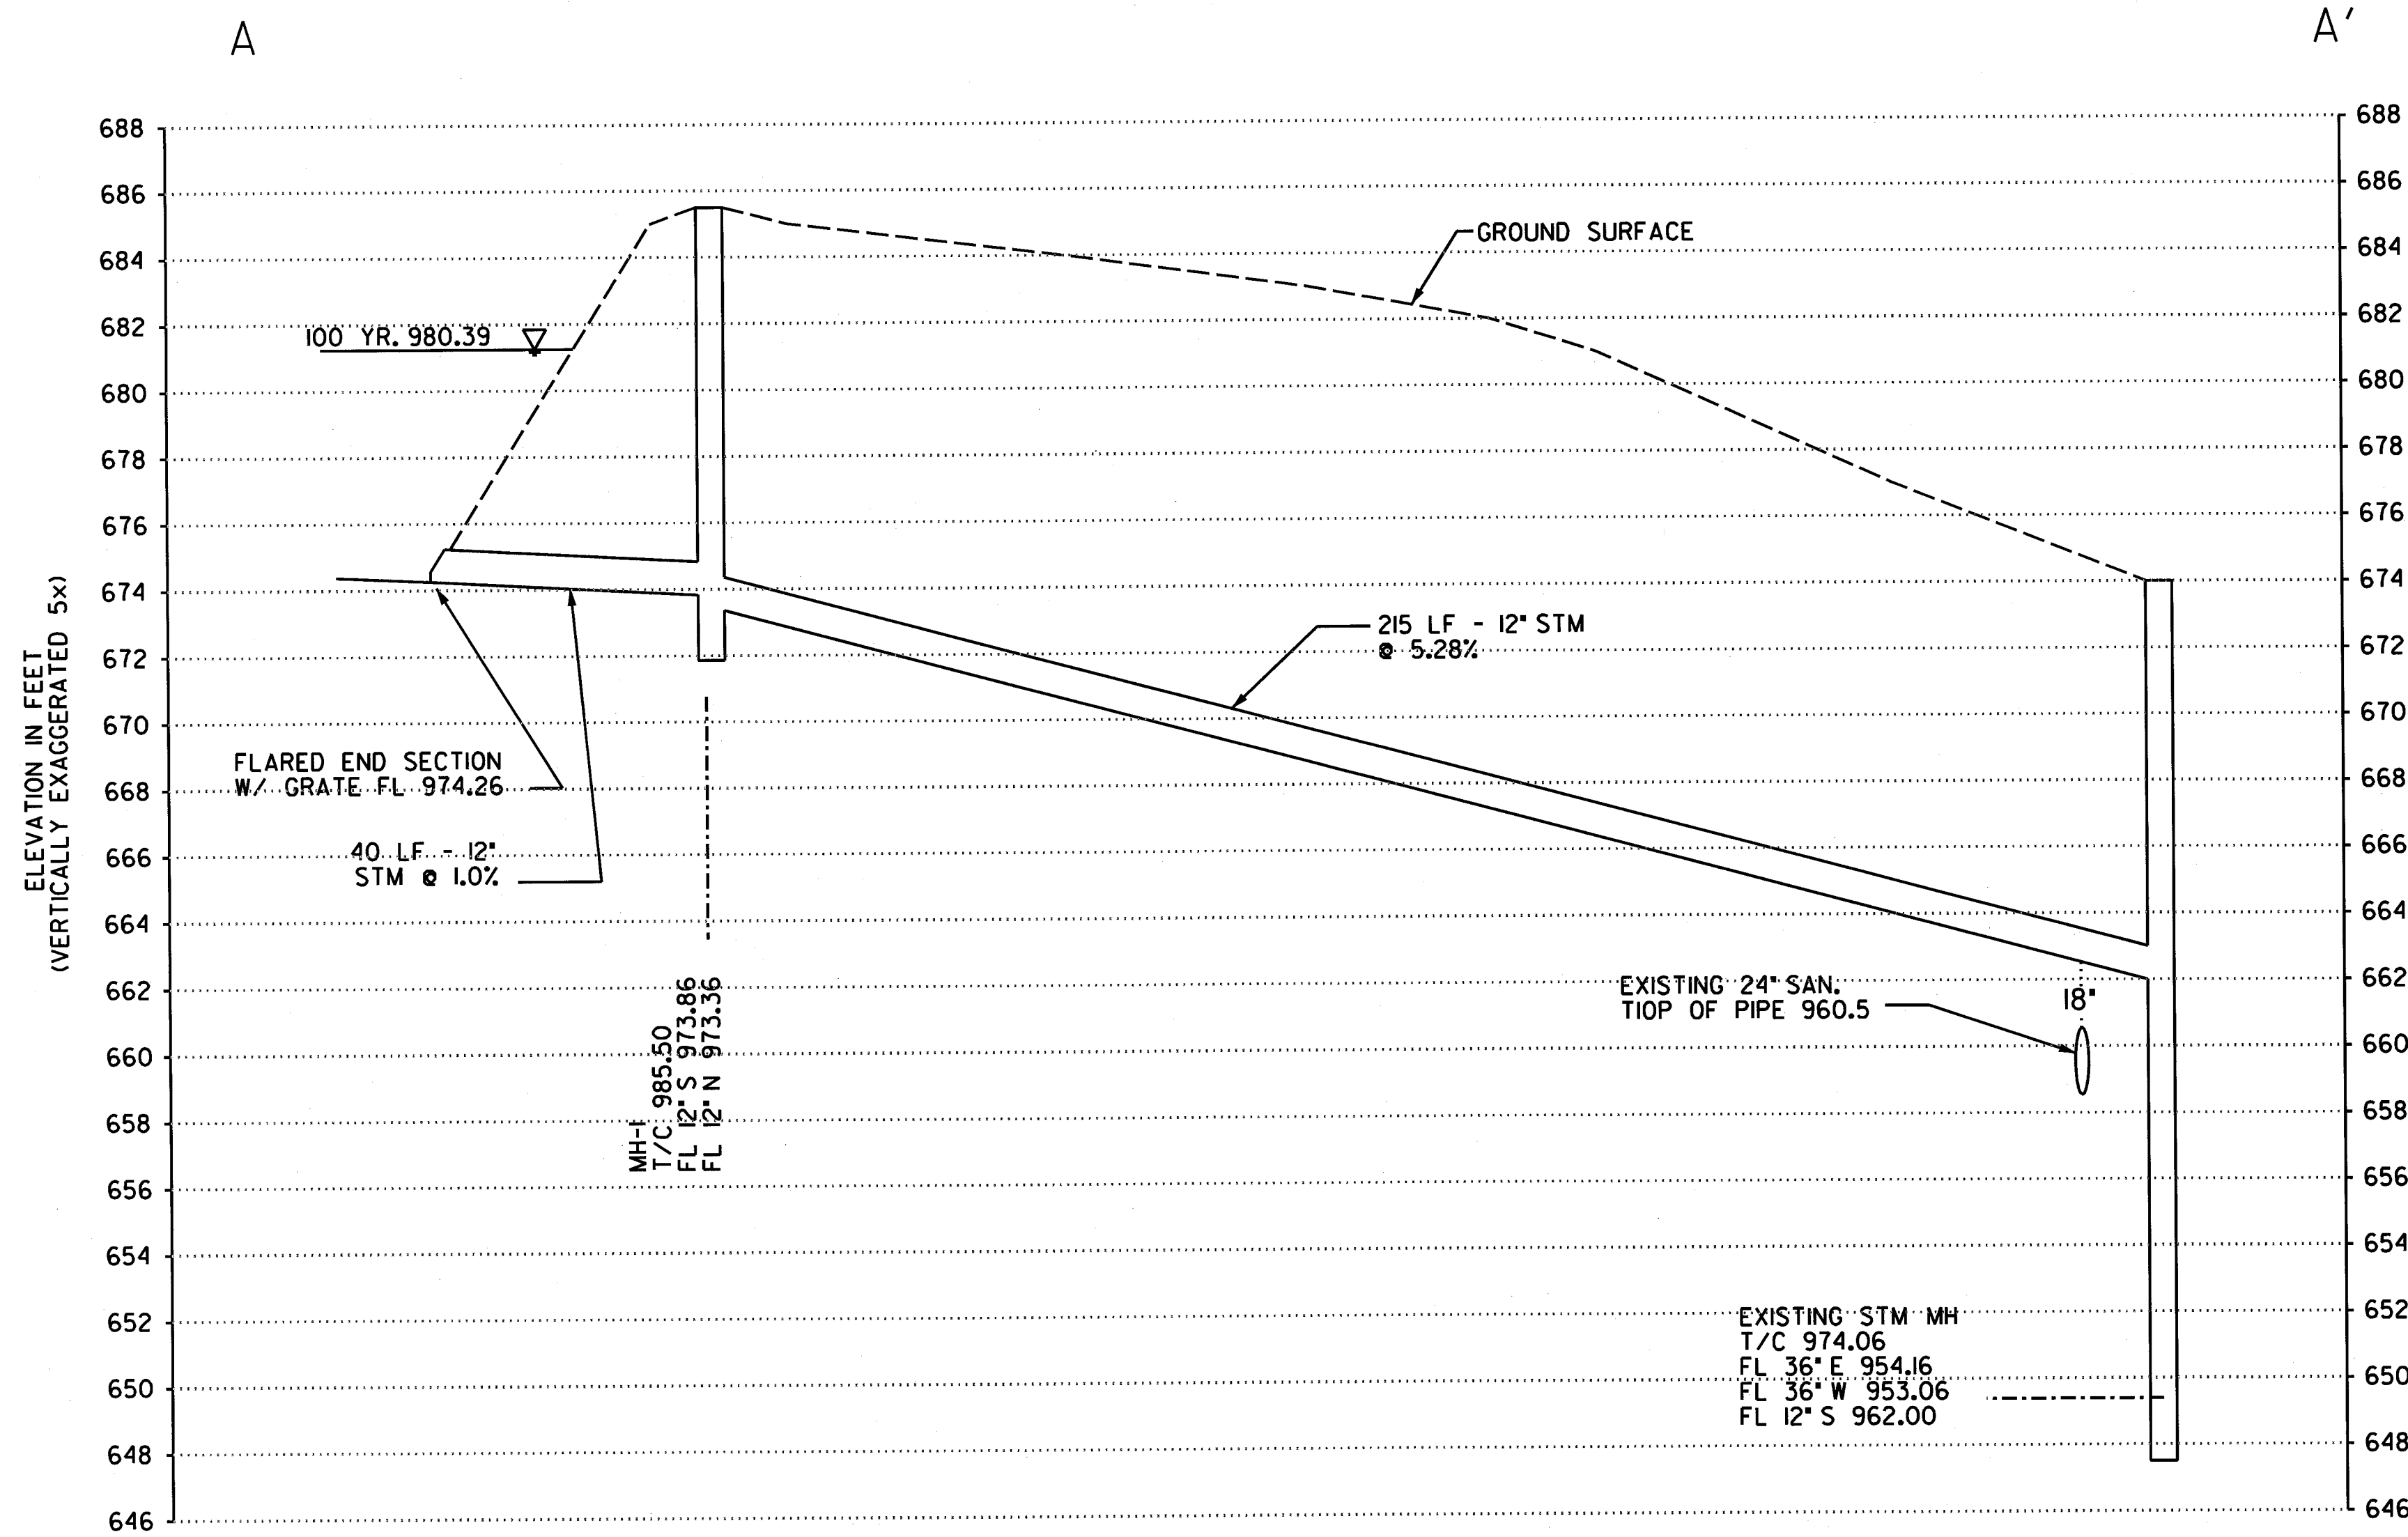

REV	DATE	BY	DESCRIPTION	SCALE:	CLIENT:
3	03/03/08	TAB	DOCK DRAINS, SANITARY	0 20 40	PEPSI AMERICAS
2	02/12/08	TAB	ADDENDUM #1 - FENCES, FLAG POLE, LIGHTS, SIGNS	HORIZONTAL SCALE IN FEET	MASSILLON PARKING IMPROVEMENTS
1	12/12/07	LES	RESUBMITTAL #1 TO CITY OF MASSILLON	DESIGNED: LES/MMML	MASSILLON, OHIO
4	03/06/08	TAB	RESUBMITTAL #2 TO CITY OF MASSILLON	DRAWN: HRSI	TITLE: STORM AND SANITARY
				CHECKED: TAB	PIPE PROFILES




HARD HAT SERVICES™
Engineering, Construction and Management Solutions

940 E. Diehl Rd, Suite 150
Naperville, IL 60563
(630) 637-9470

SHEET:
9
OF 14 SHEETS

NEW CONCRETE "WINGS" TO BE
DOWELED INTO EXISTING CONCRETE
APRON WITH 1" DOWELS CENTERED
IN SLAB AND SPACED EVERY 24"

WARMINGTON RD. S.W. - VARIED

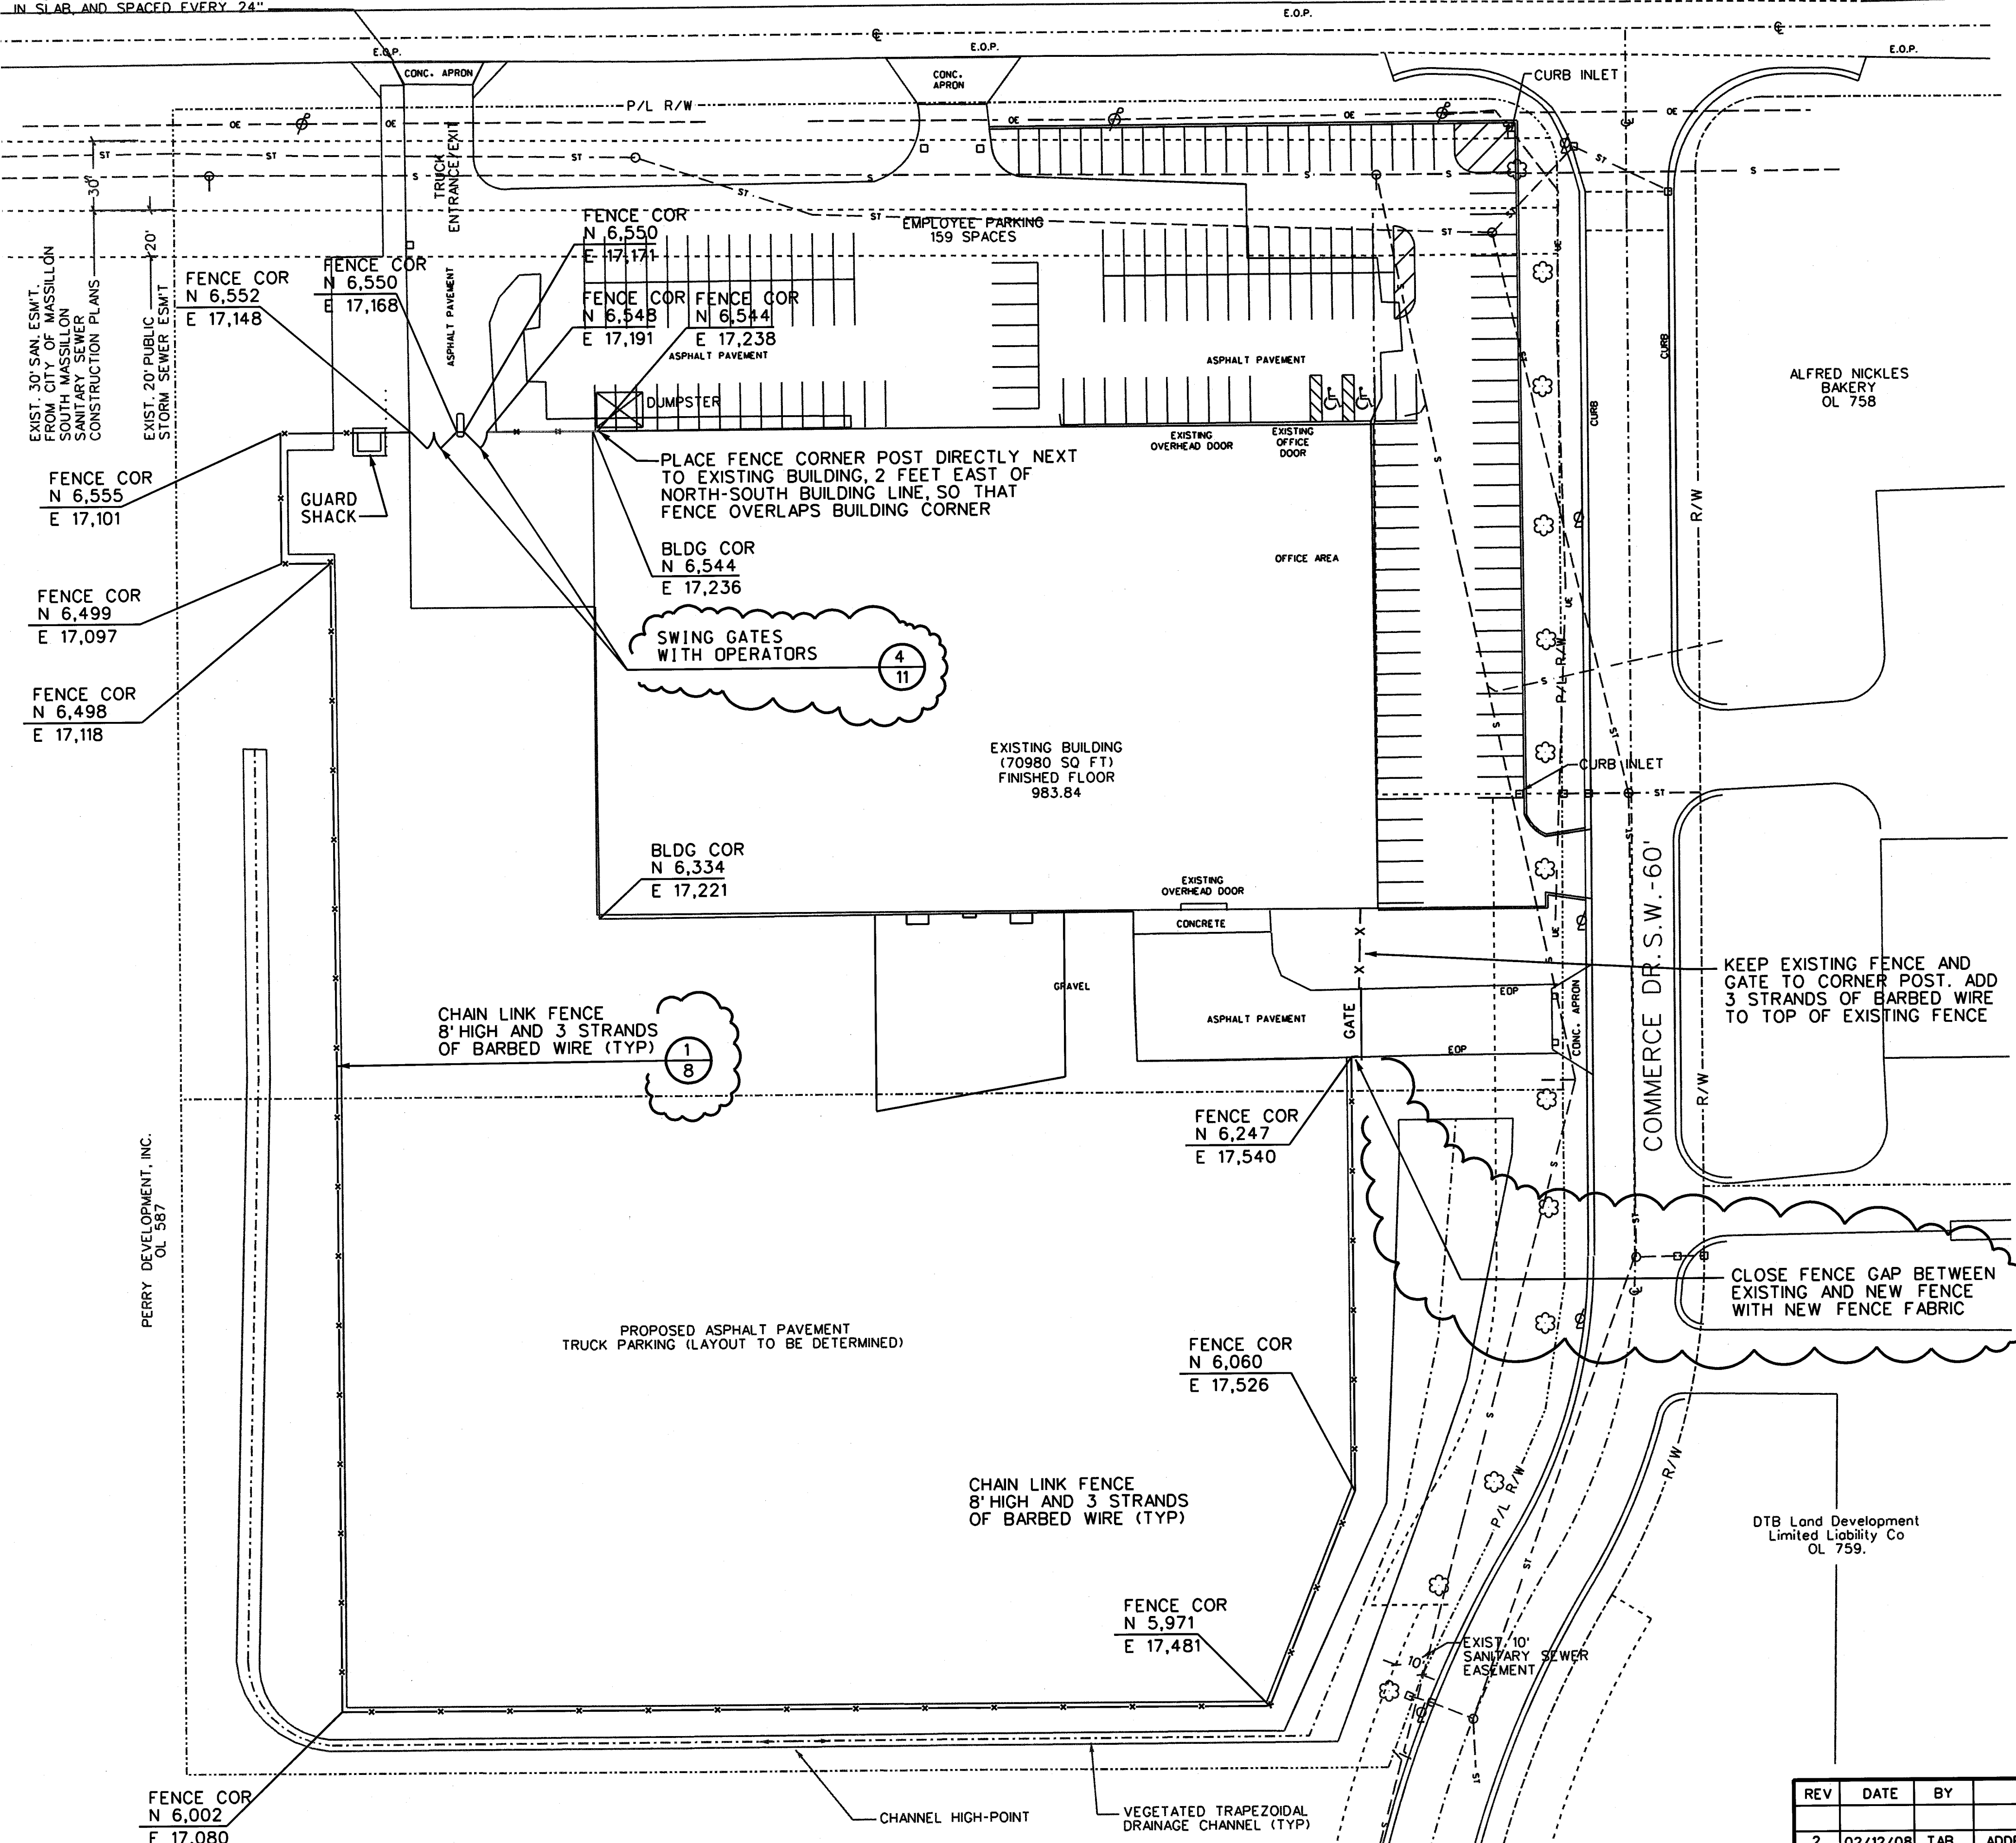

LEGEND:

NEW CHAINLINK FENCE

NOTE:

1. COORDINATES BASED ON ASSUMED
BUILDING CORNER COORDINATES.

DATE: 11/21/07

REV	DATE	BY	DESCRIPTION
2	02/12/08	TAB	ADDENDUM #1-FENCES, FLAG POLE, LIGHTS, SIGNS
1	12/12/07	LES	RESUBMITTAL #1 TO CITY OF MASSILLON
0	11/21/07	LES	SUBMITTAL TO CITY OF MASSILLON

SCALE:	0	40	80
	SCALE IN FEET		
DESIGNED:	LES/MWL		
DRAWN:	HHSI		
CHECKED:	TAB		

CLIENT: PEPSI AMERICAS
MASSILLON PARKING IMPROVEMENTS
MASSILLON, OHIO

TITLE: FENCING PLAN





HARD HAT SERVICES™
Engineering, Construction and Management Solutions

940 E. Diehl Rd, Suite 150
Naperville, IL 60563
(630) 637-9470


SHEET:

10


OF 14 SHEETS

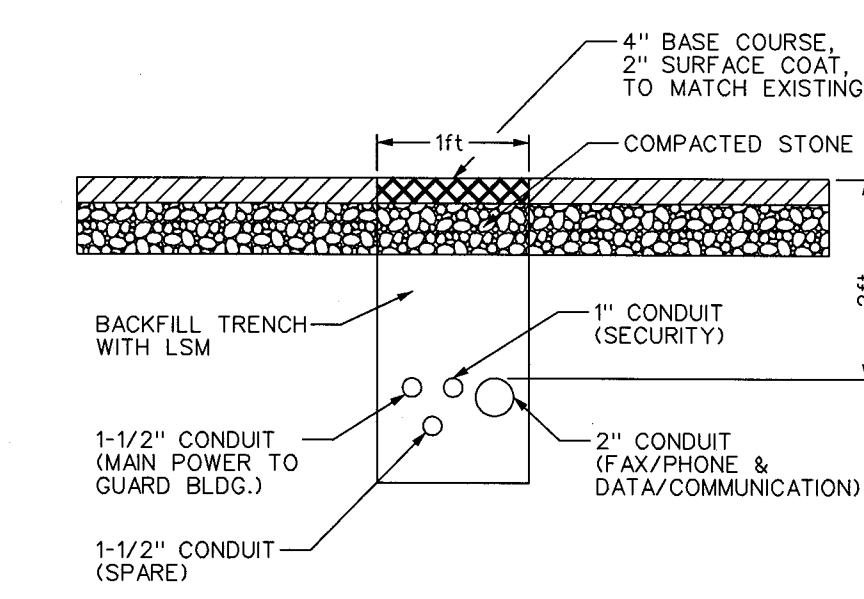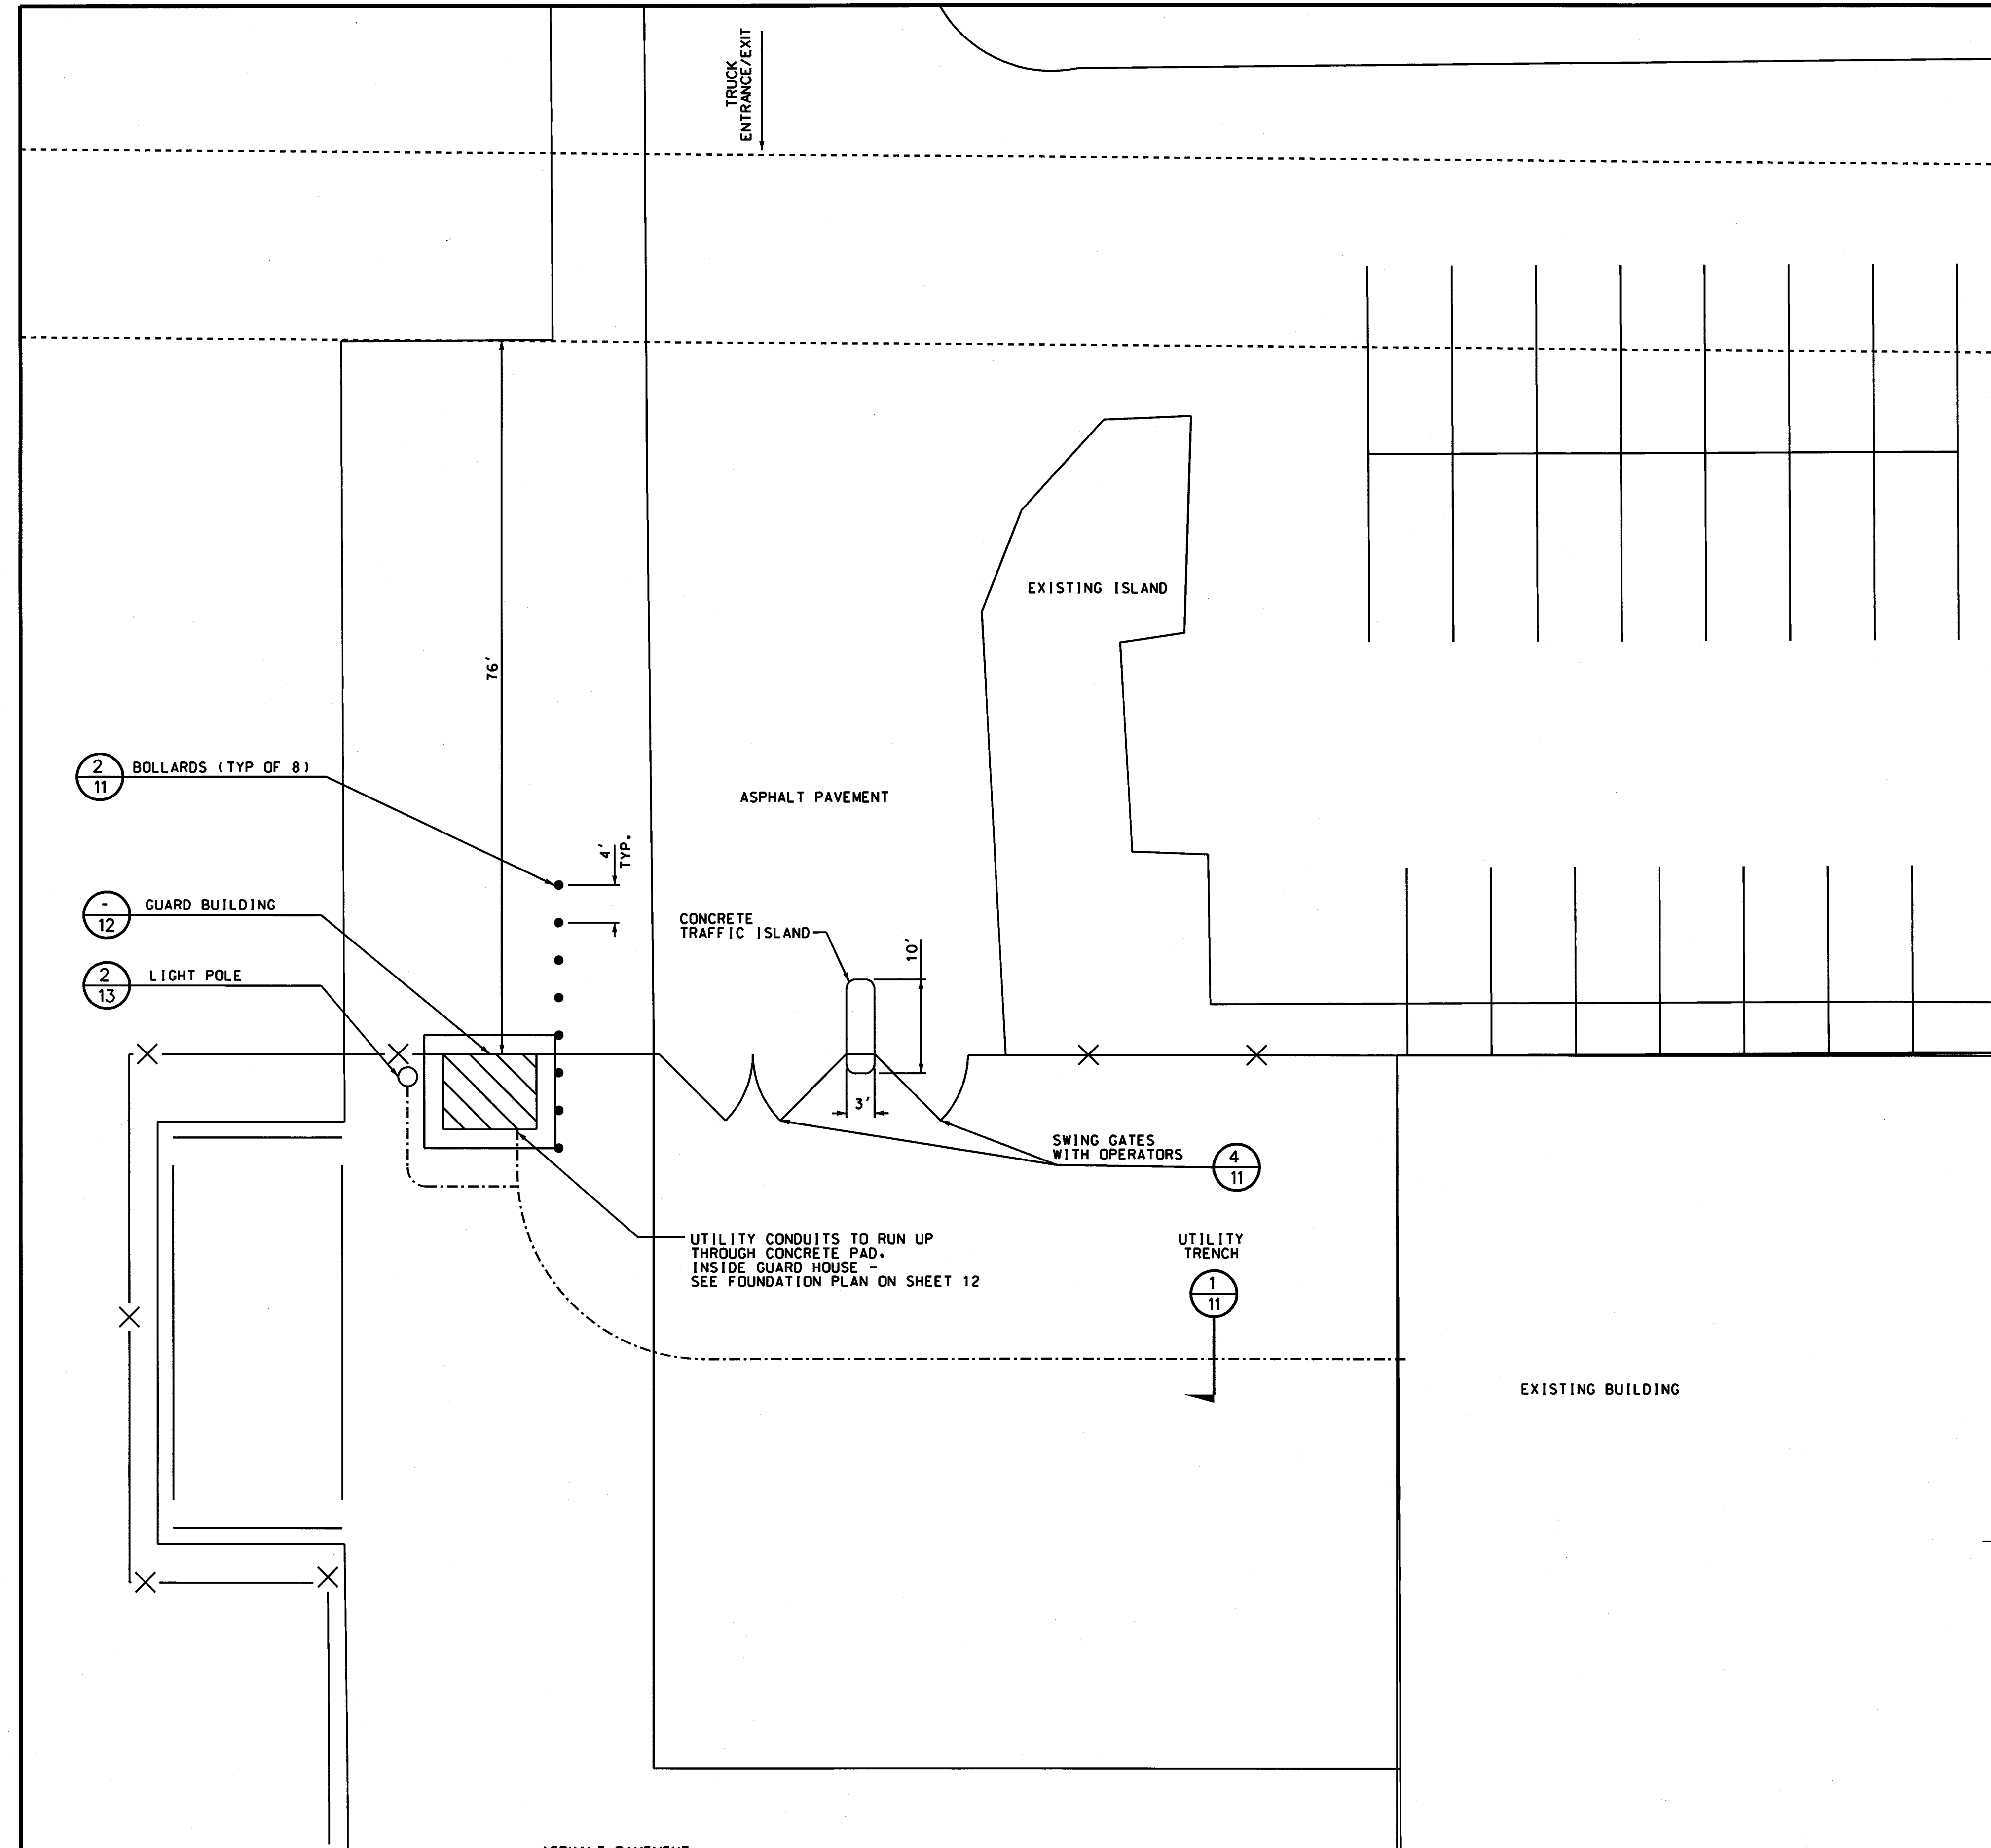


UTILITY TRENCH DETAIL 1
N.T.S.

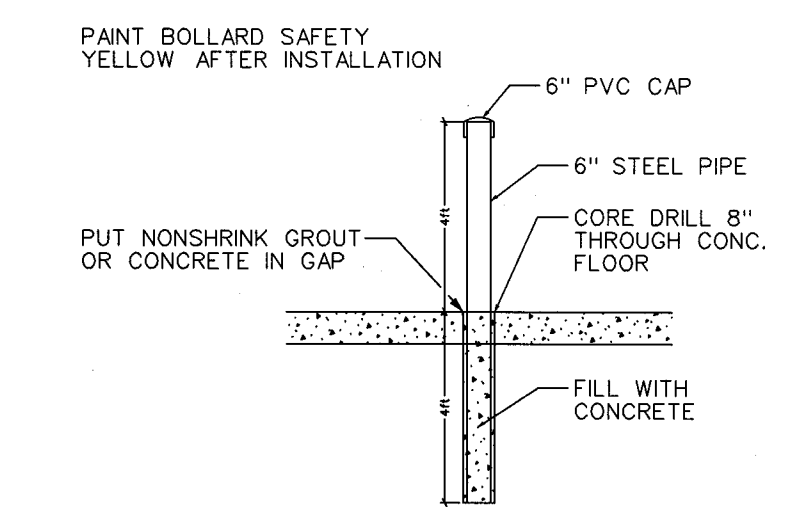

BOLLARD DETAIL 2
N.T.S.

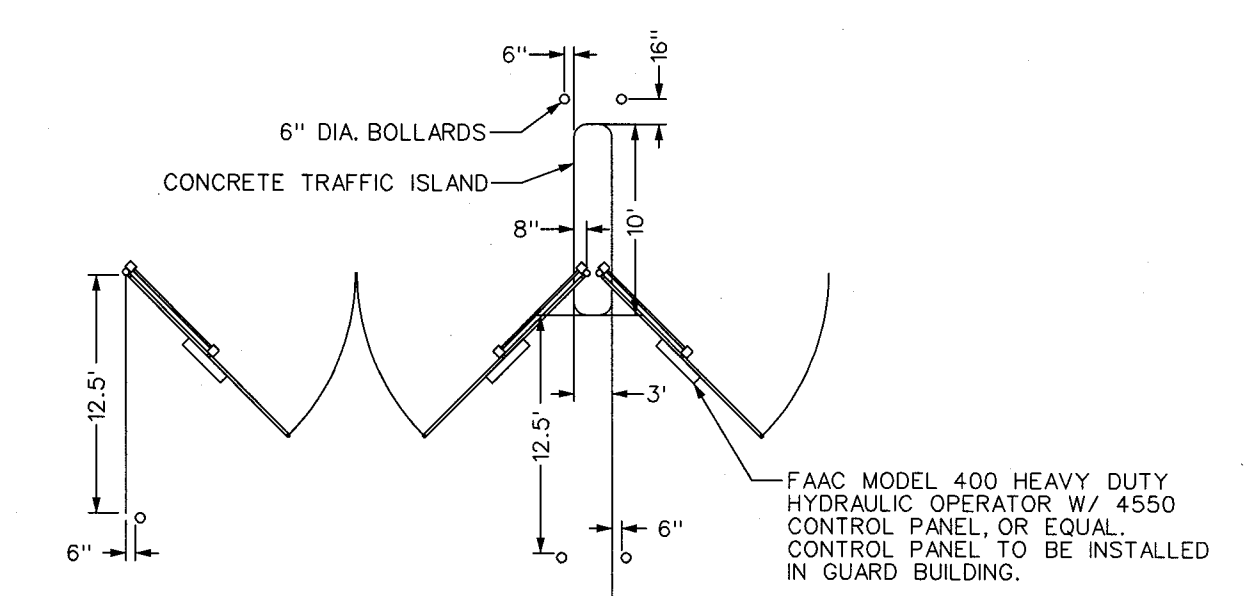

GATES PLAN VIEW DETAIL 3
N.T.S.

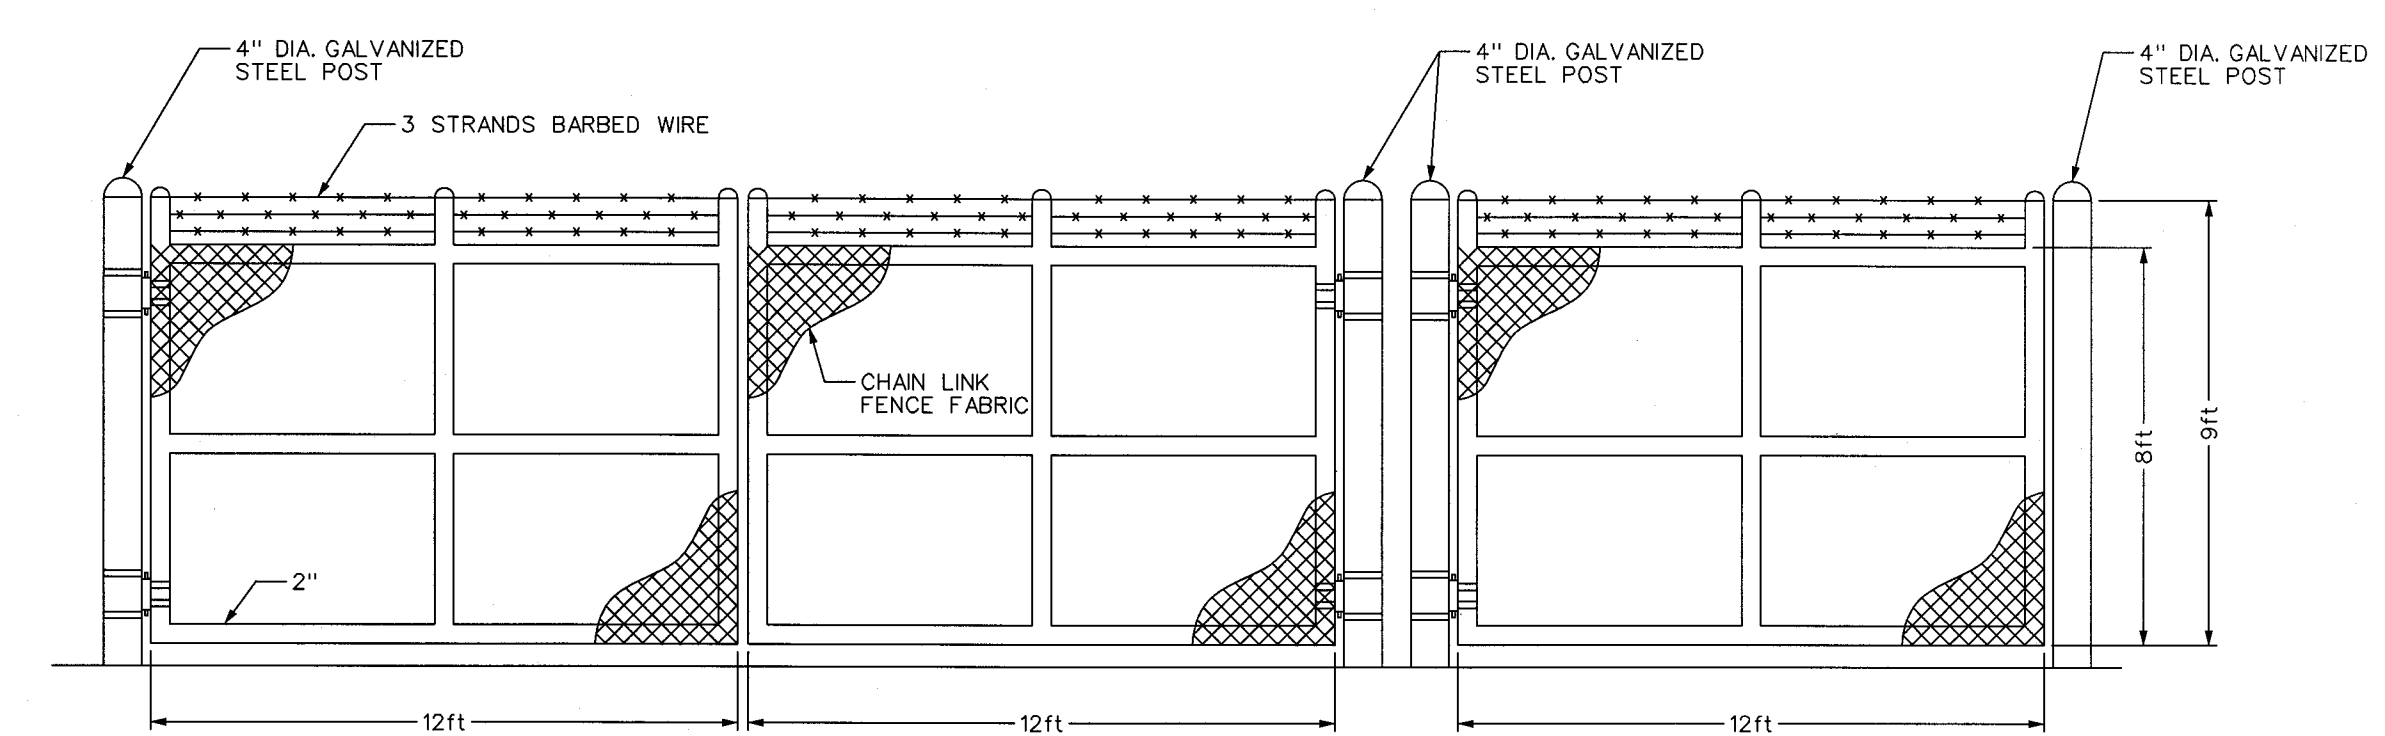

GATES-CROSS SECTION DETAIL 4
N.T.S.

DATE: 11/21/07
SCALE: AS SHOWN


REV	DATE	BY	DESCRIPTION	SCALE:	CLIENT:
2	02/12/08	TAB	ADDENDUM #1-FENCES, FLAG POLE, LIGHTS, SIGNS	0 10 20 SCALE IN FEET	PEPSI AMERICAS MASSILLON PARKING IMPROVEMENTS MASSILLON, OHIO
1	12/21/07	LES	RESUBMITTAL #1 TO THE CITY OF MASSILLON	DESIGNED: LES/MWL	TITLE: GUARD HOUSE AREA PLAN
0	11/21/07	LES	SUBMITTAL TO CITY OF MASSILLON	DRAWN: HHSI CHECKED: TAB	




HARD HAT SERVICES™
Engineering, Construction and Management Solutions

940 E. Diehl Rd, Suite 150
Naperville, IL 60563
(630) 637-9470

SHEET: 11
OF 14 SHEETS

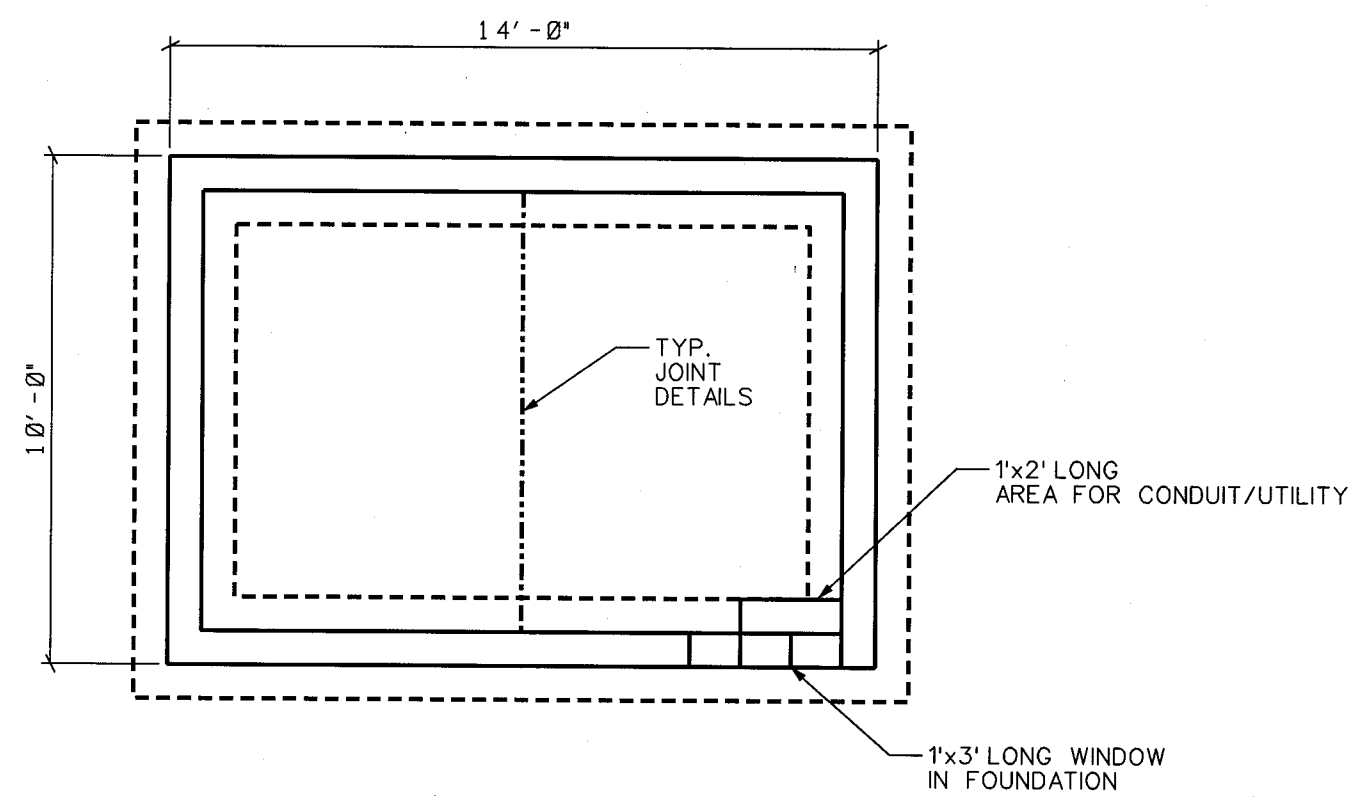


FOUNDATION PLAN
SCALE 1/4" = 1'-0"
NORTH

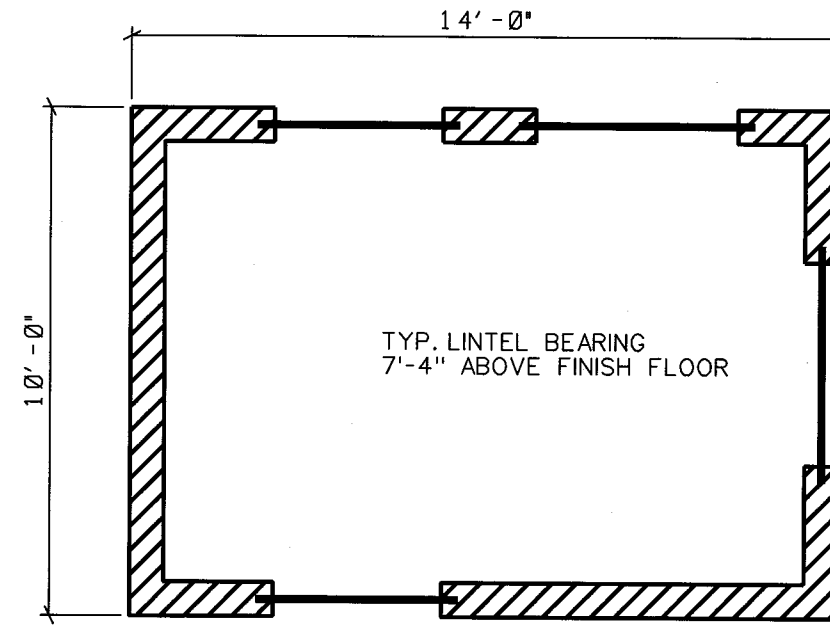


LINTEL PLAN
SCALE 1/4" = 1'-0"
NORTH

NOTE: VERTICAL REINFORCEMENT -
#4 @ 32" O.C. FULL HEIGHT; GROUT
FULL HEIGHT; PROVIDE 4-#4 (2 PER
CELL) AT EACH SIDE / JAMBS OF ALL
OPENINGS (DOORS, WINDOWS, ETC.)

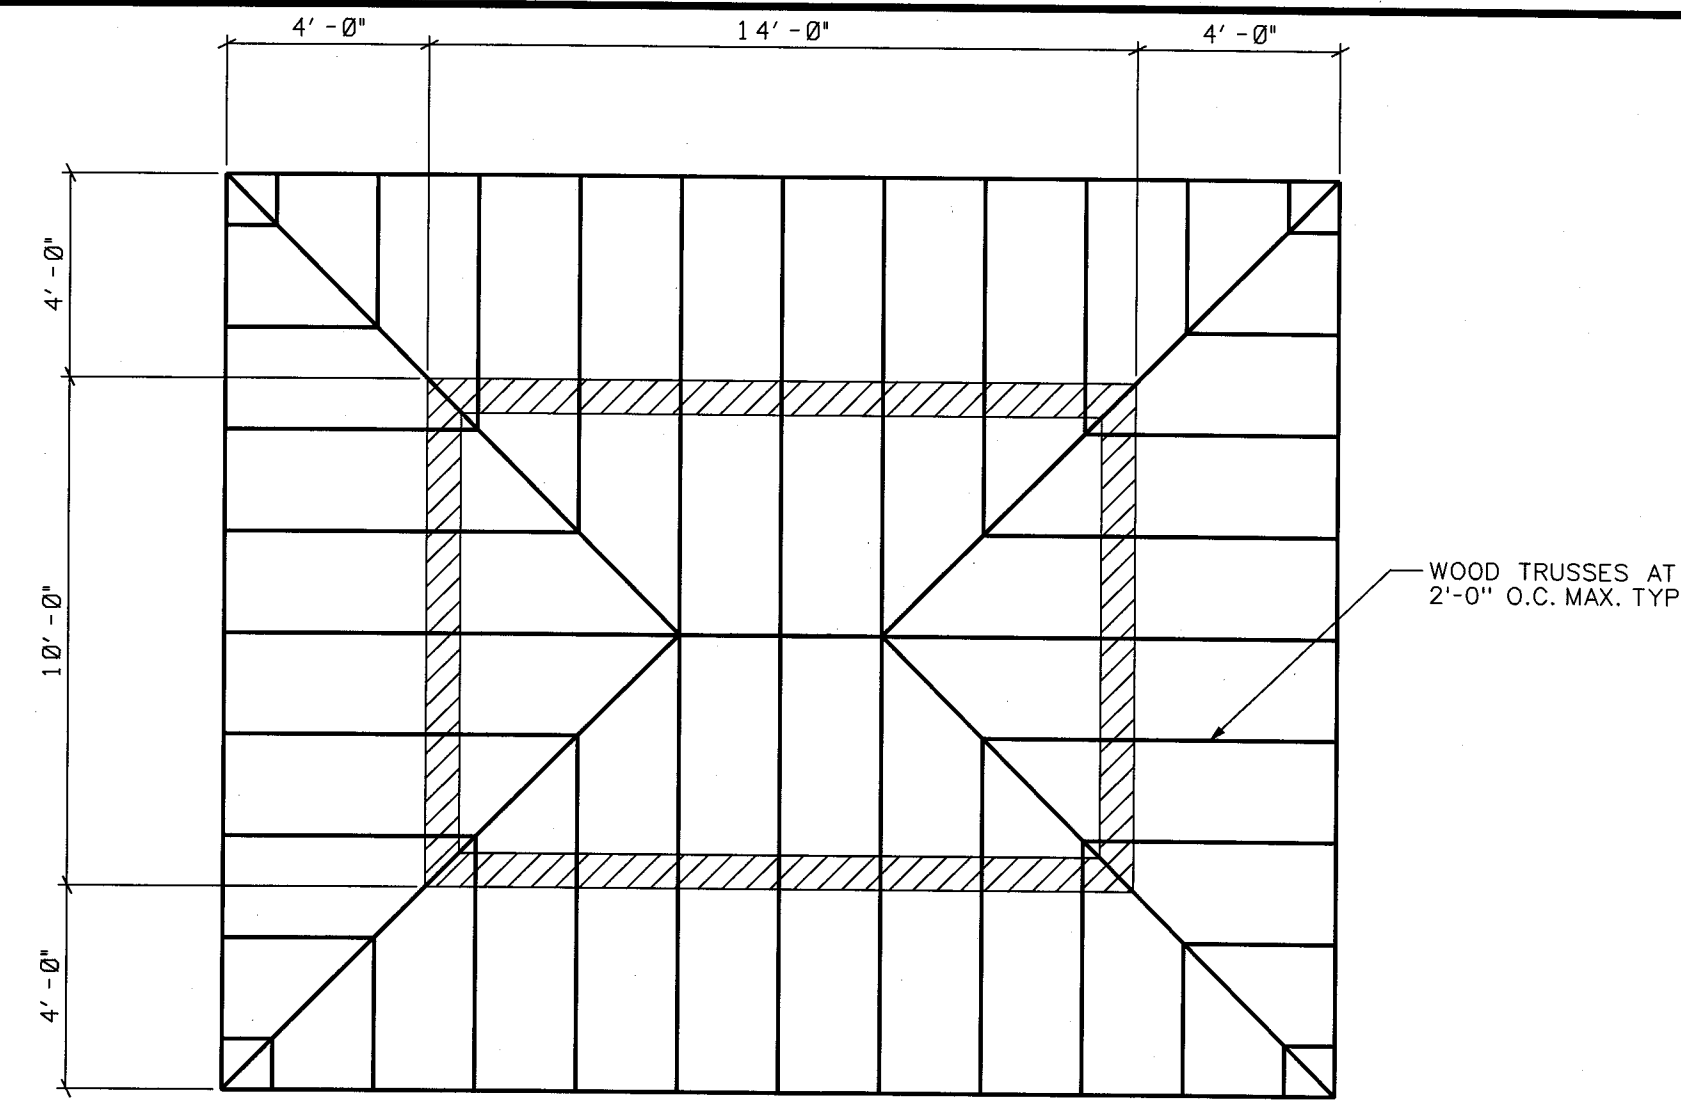


ROOF FRAMING PLAN
SCALE 1/4" = 1'-0"
NORTH


NOTE: ALL TRUSSES ANCHOR TO DOUBLE TOP PLATE
WITH SIMPSON HANCHORS. TOP PLATE ANCHORED
WITH ADA ANCHOR BOLTS AT 2'-0" O.C.
TRUSS BEARING ELEVATION = 9'-7" ABOVE FINISH FLOOR.

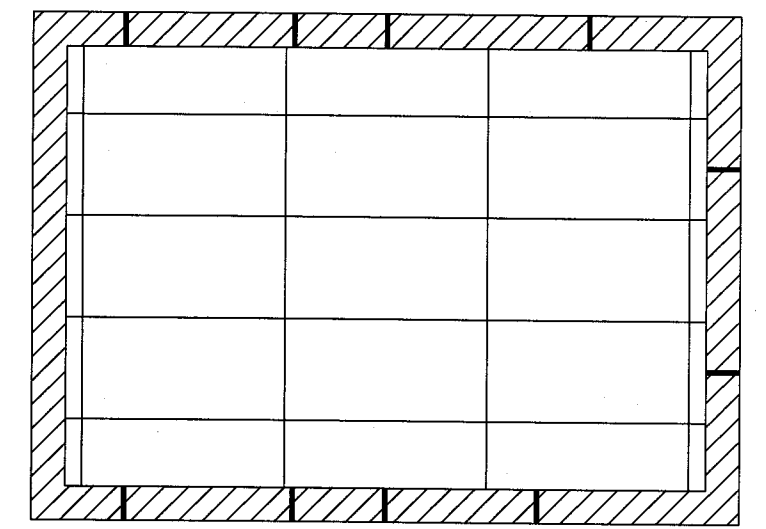


REFLECTED CEILING PLAN
SCALE 1/4" = 1'-0"
NORTH

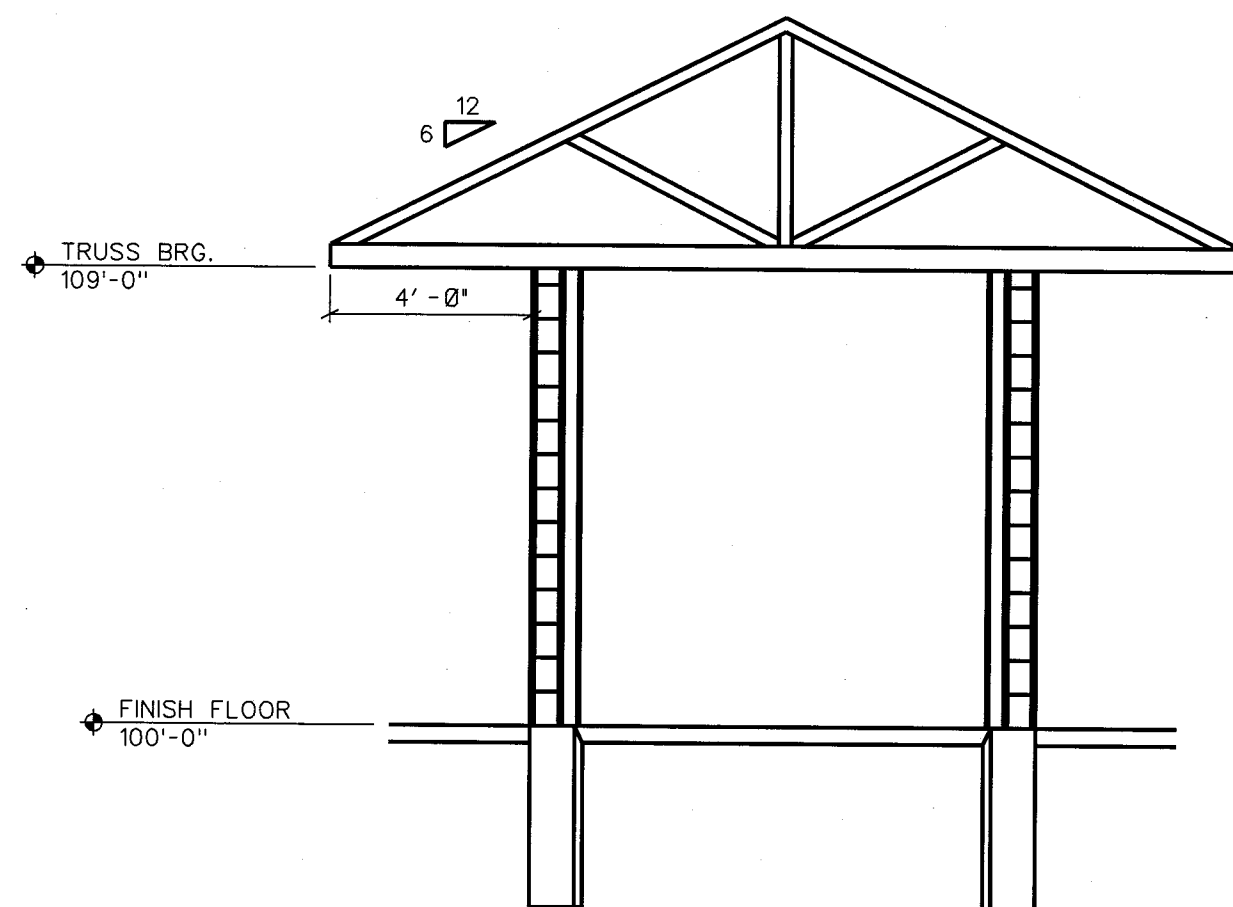


BUILDING SECTION
SCALE 1/4" = 1'-0"

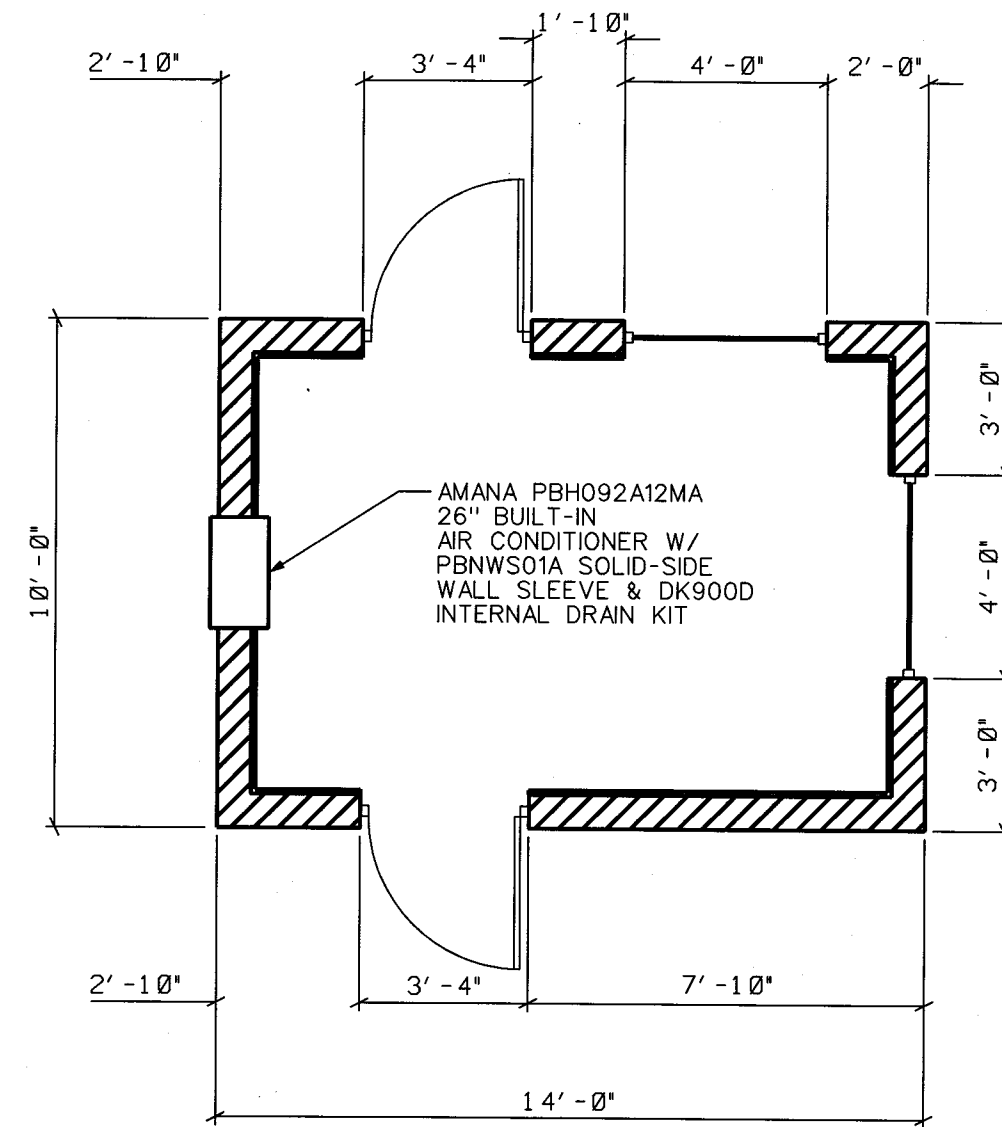


FLOOR PLAN
SCALE 1/4" = 1'-0"
NORTH

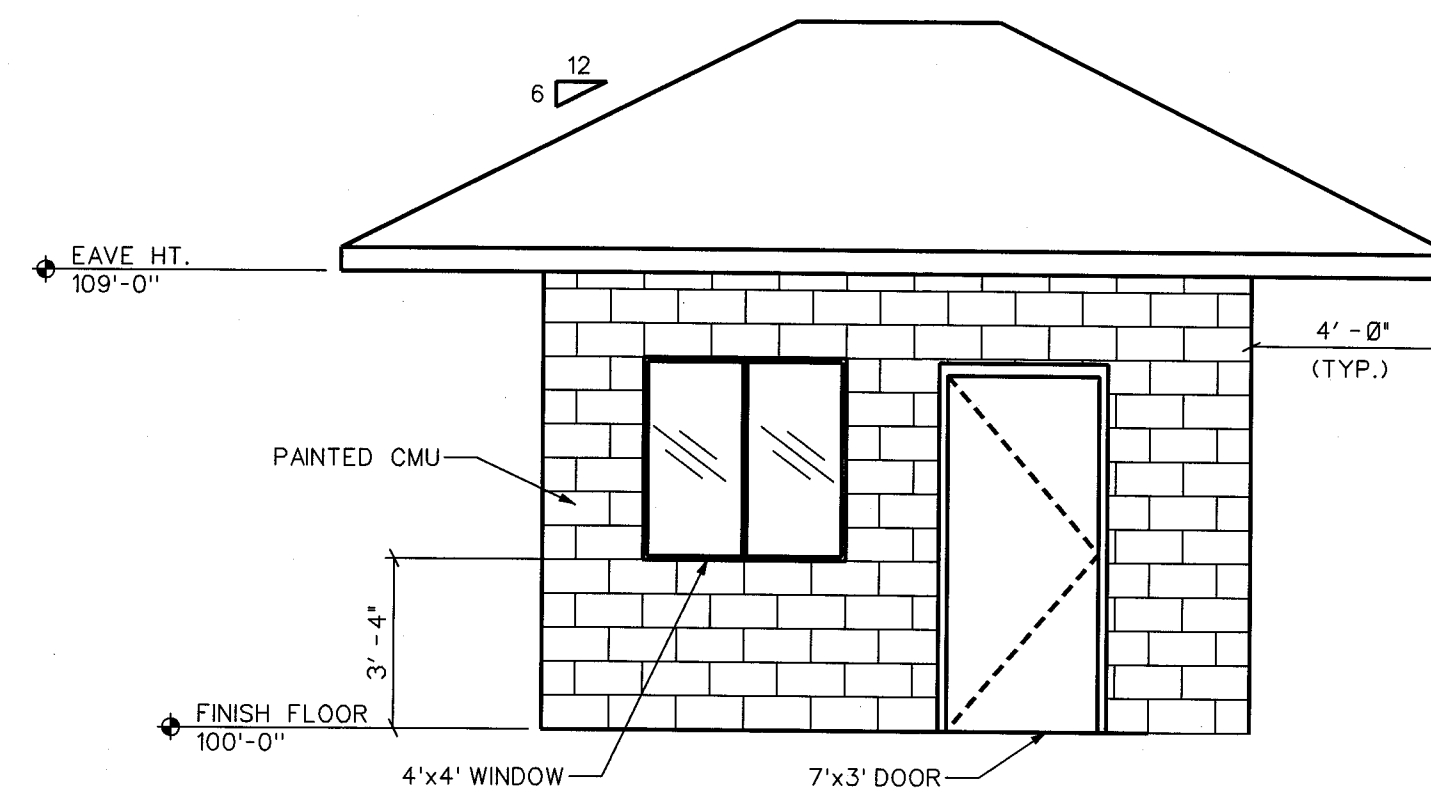


NORTH ELEVATION
SCALE 1/4" = 1'-0"

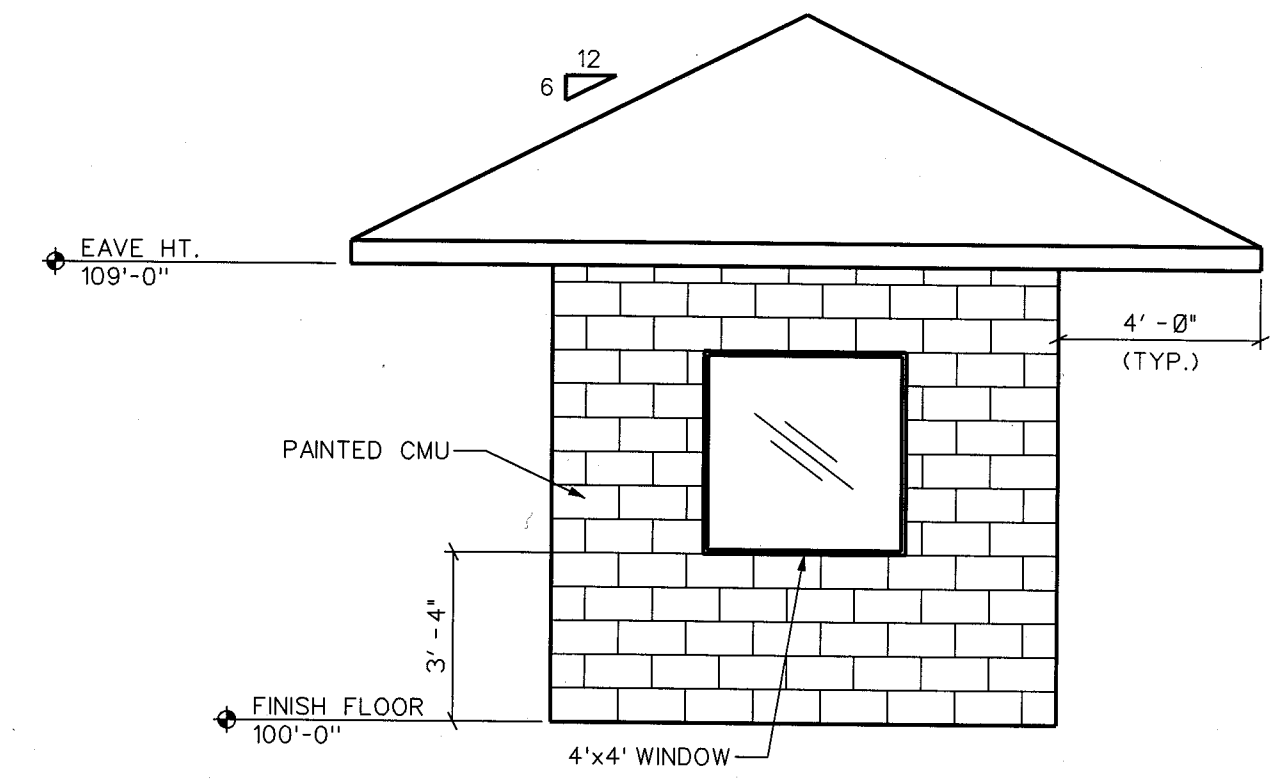


EAST ELEVATION
SCALE 1/4" = 1'-0"

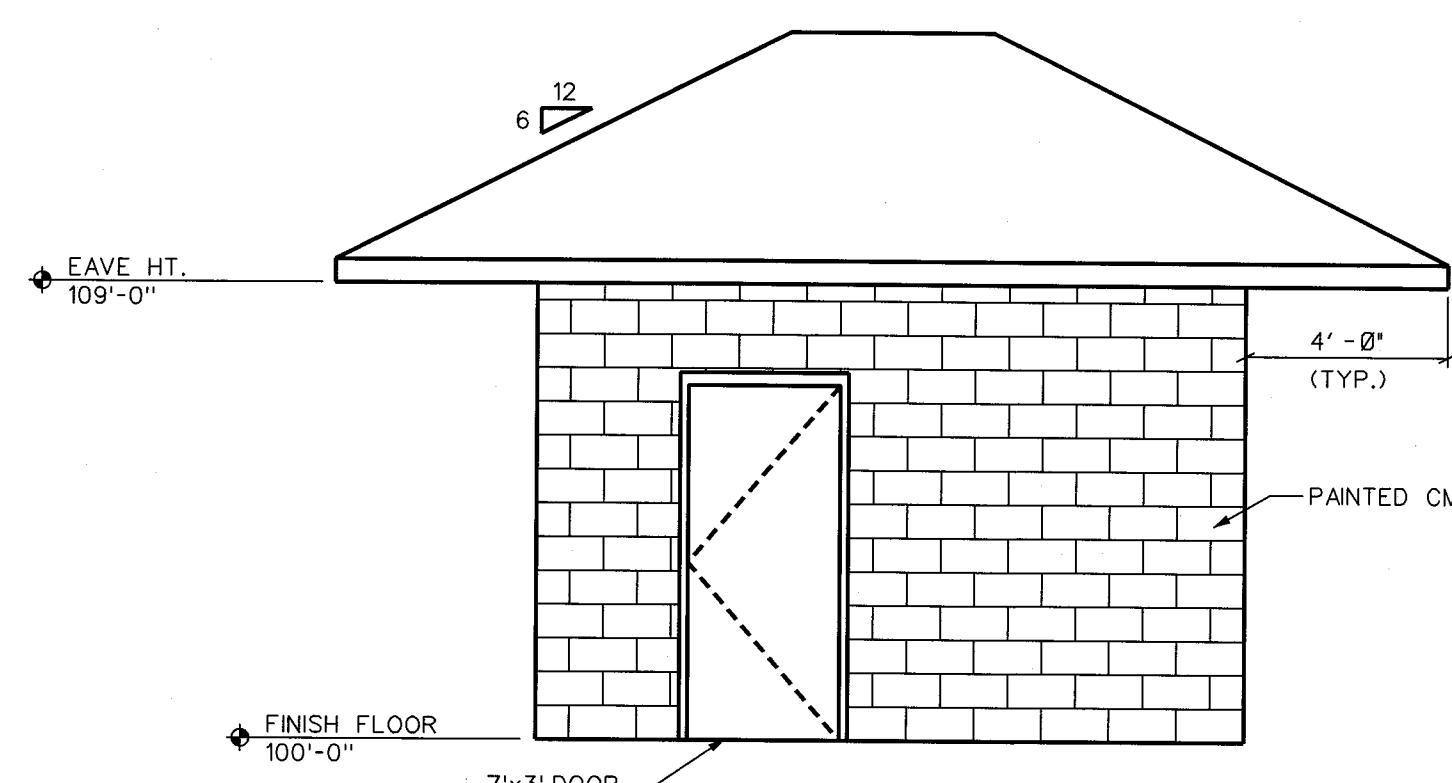


SOUTH ELEVATION
SCALE 1/4" = 1'-0"

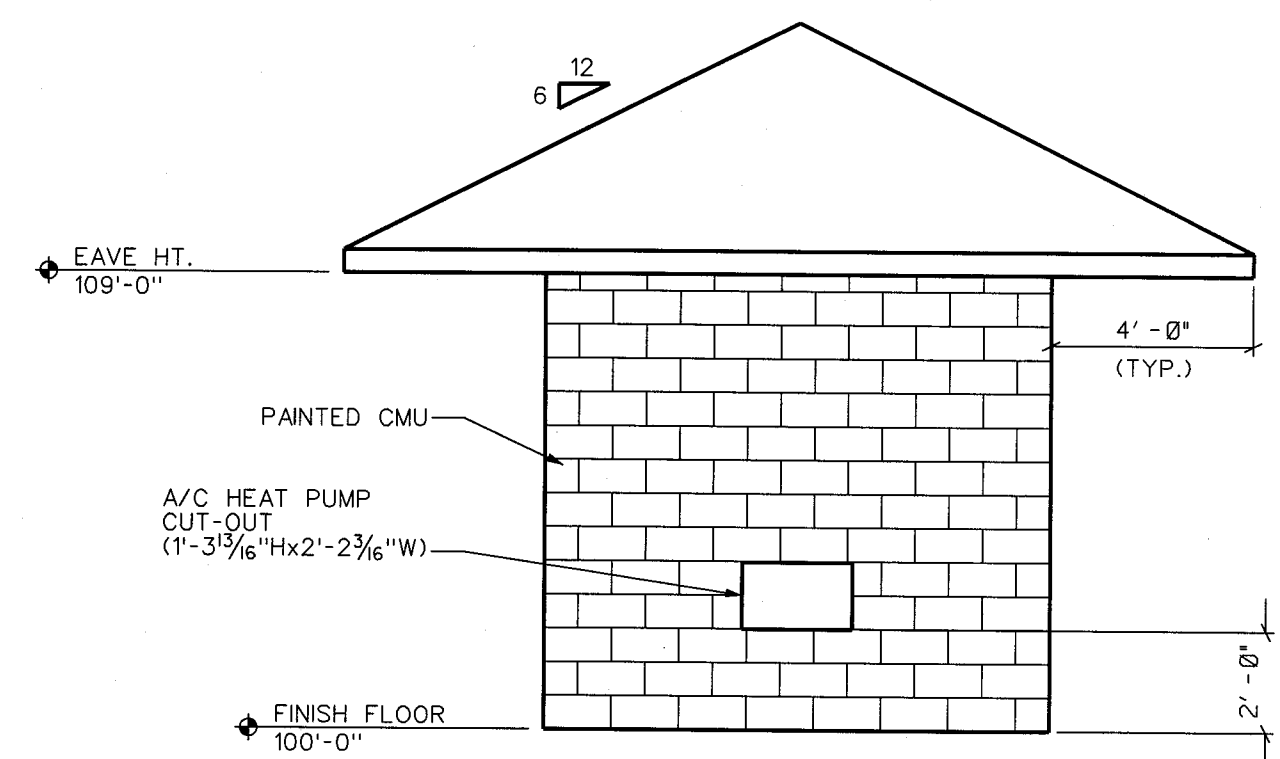

WEST ELEVATION
SCALE 1/4" = 1'-0"

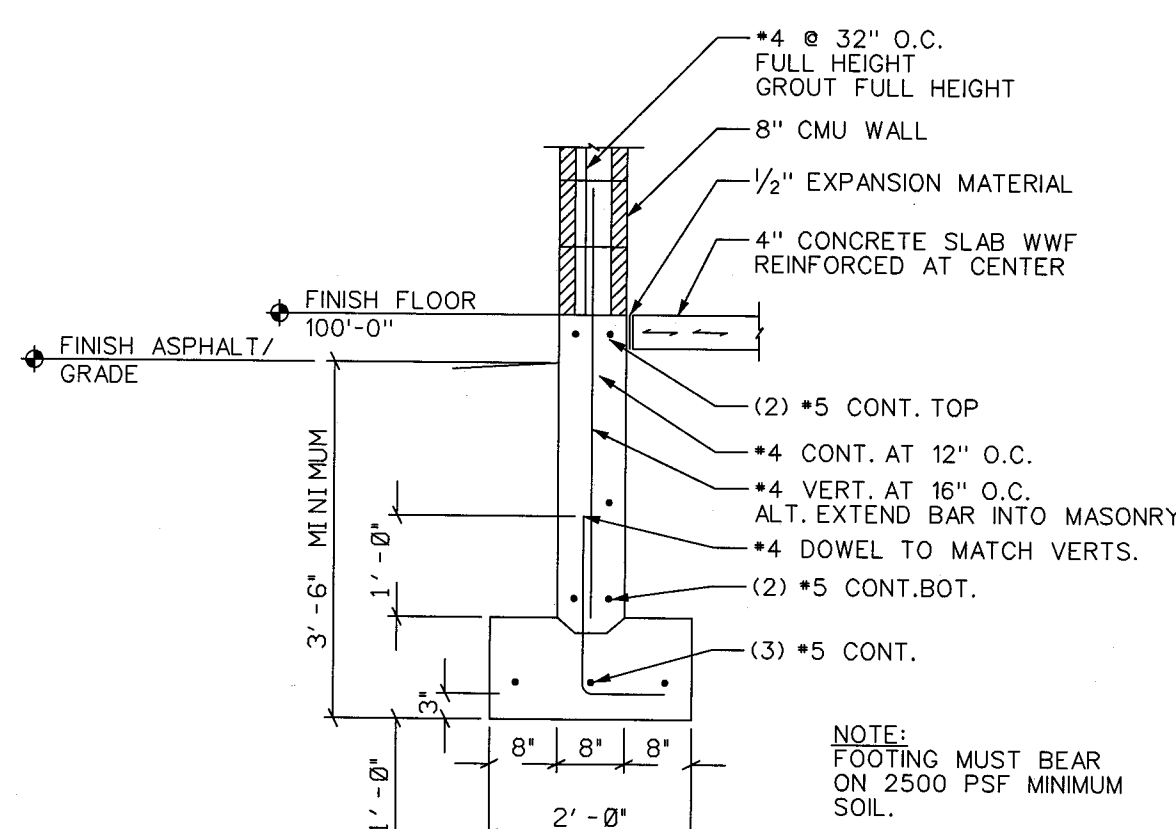

FOUNDATION SECTION
SCALE 1/2" = 1'-0"

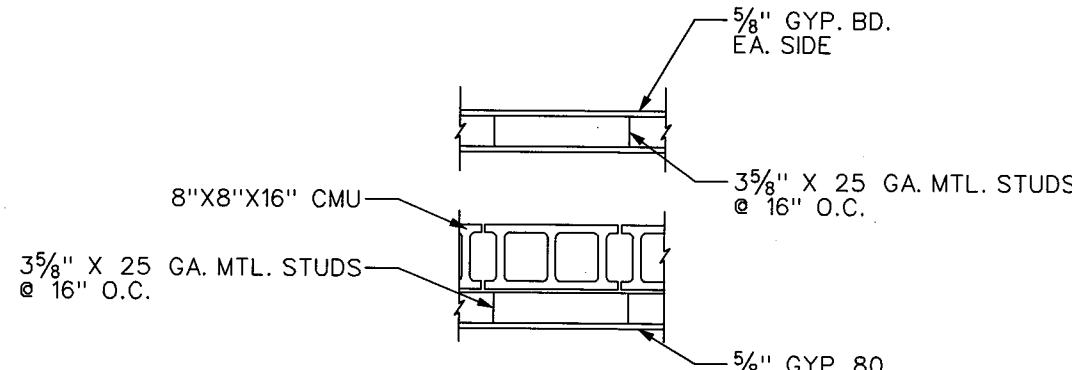

WALL TYPES
SCALE 1/2" = 1'-0"

REV	DATE	BY	DESCRIPTION	SCALE: 1/4" = 1'	CLIENT: PEPSI AMERICAS MASSILLON PARKING IMPROVEMENTS MASSILLON, OHIO
2	02/12/08	TAB	ADDENDUM #1-FENCES, FLAG POLE, LIGHTS, SIGNS	DESIGNED: LES/MWL	TITLE: GUARD HOUSE DETAILS
1	12/12/07	LES	RESUBMITTAL #1 TO CITY OF MASSILLON	DRAWN: HHSL	
0	11/21/07	LES	SUBMITTAL TO CITY OF MASSILLON	CHECKED: TAB	






HARD HAT SERVICES™
Engineering, Construction and Management Solutions

940 E. Diehl Rd, Suite 150
Naperville, IL 60563
(630) 637-9470

SHEET:
12
OF 14 SHEETS

WARMINGTON RD. S.W. - VARIED

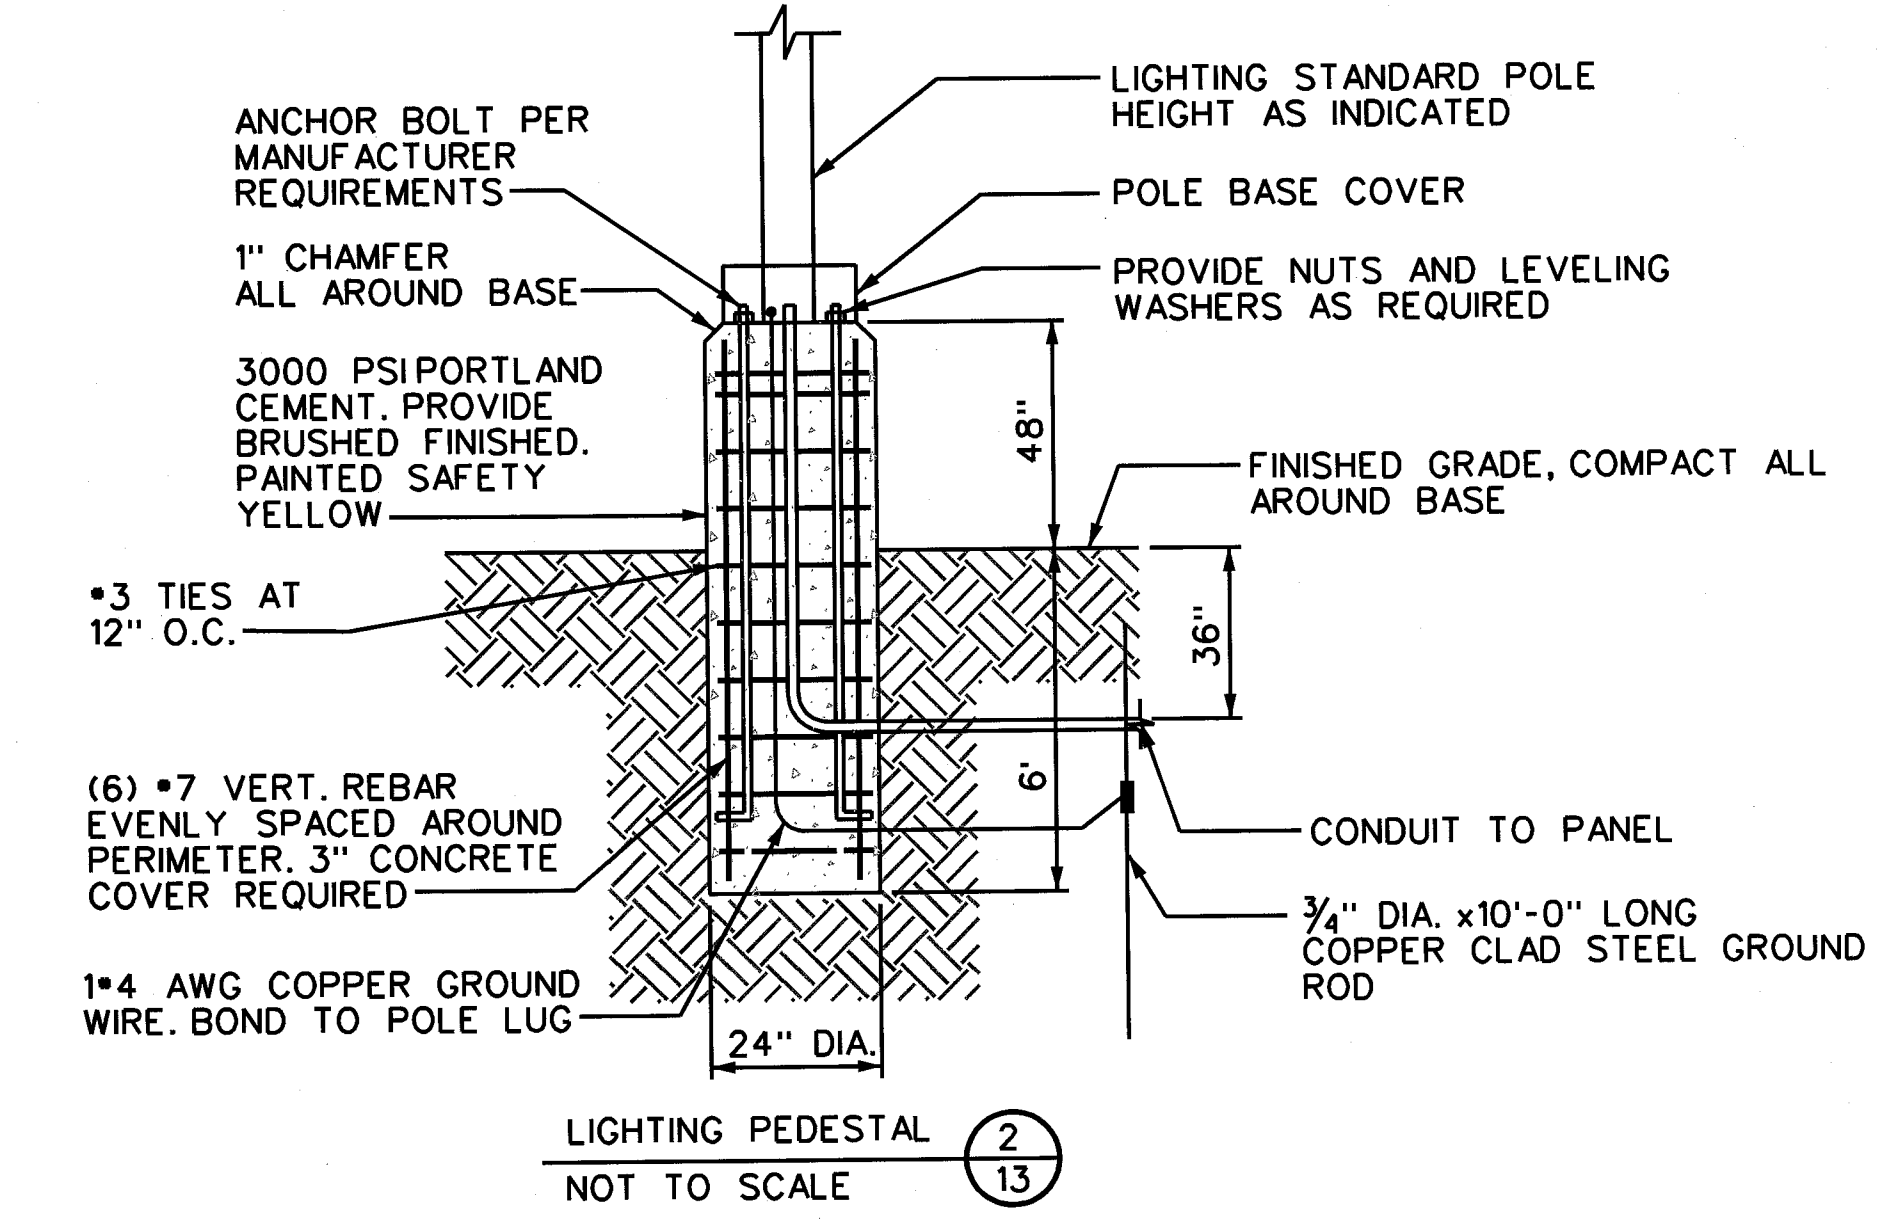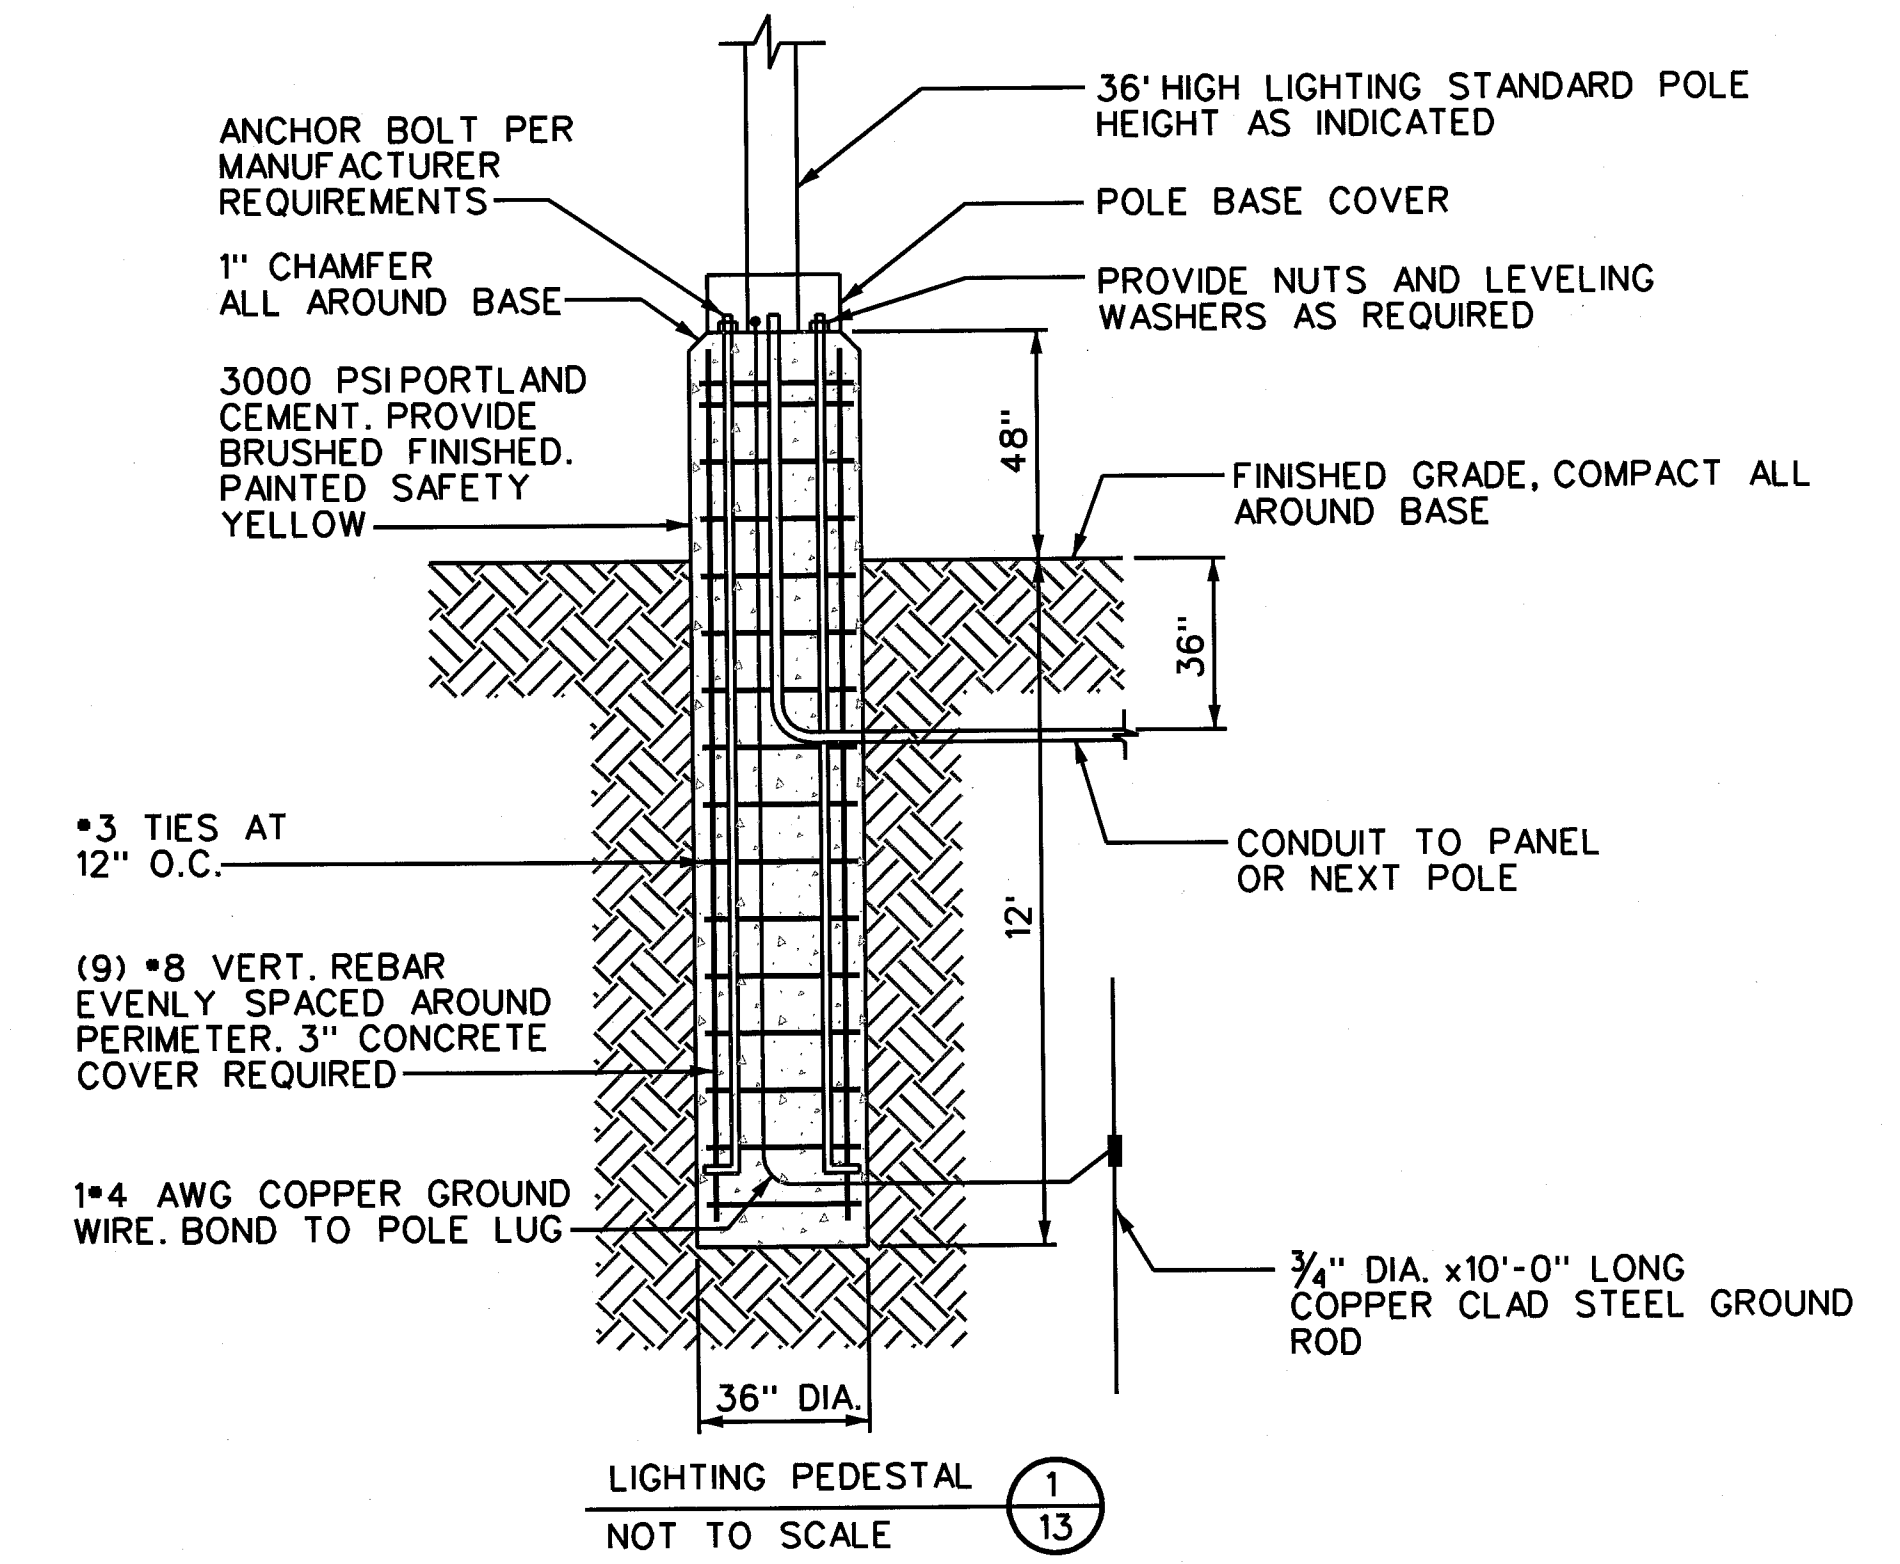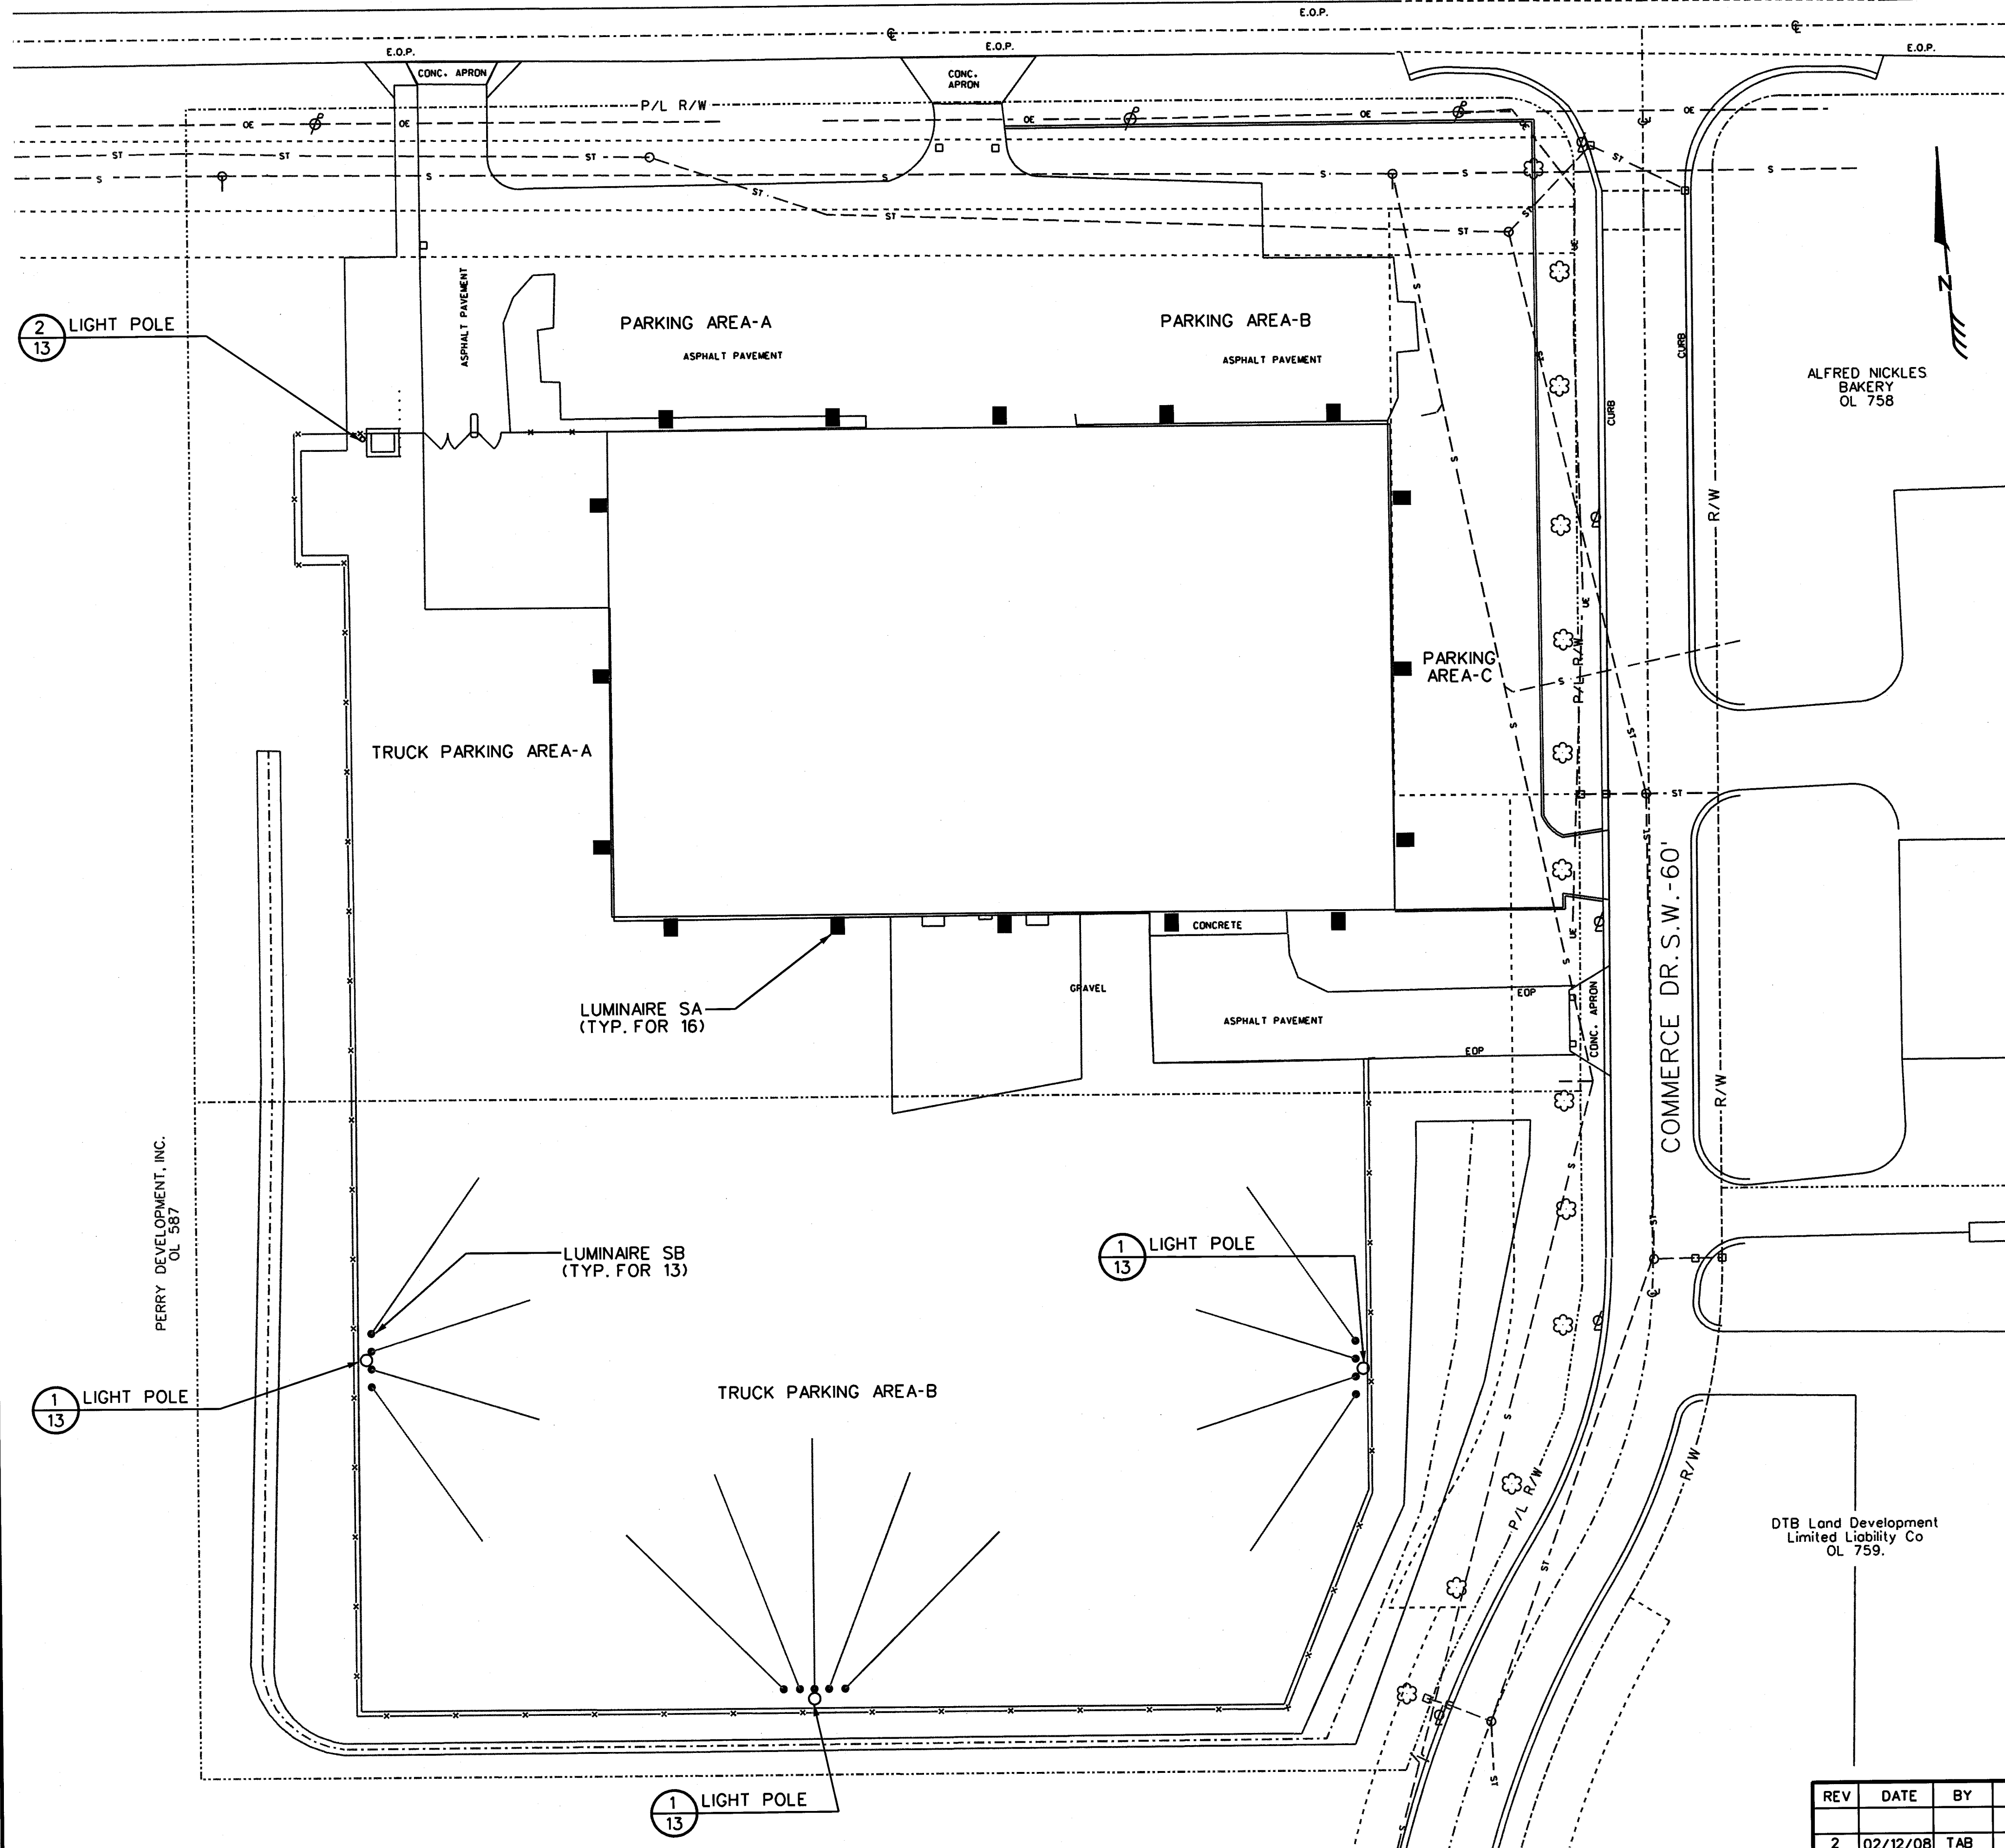

NOTES:
 1. POLE: U.L.S.:RTS-36-1207-T3-DB-VD
 2. TYPE SB OVERALL MOUNTING HEIGHT: 36' POLE + 4' CONCRETE BASE=40' A.F.G.
 3. FLOODLIGHTING BRACKET: U.L.S.:PTB-530-3" KENON-MOD FOR 5 IN LINE

STATISTICAL AREA SUMMARY					
LABEL	AVG.	MAX.	MIN.	AVG./MIN.	MAX./MIN.
PARKING AREA-A	5.20	15.5	1.1	4.73	14.09
PARKING AREA-B	3.43	13.9	0.3	11.43	46.33
PARKING AREA-C	3.43	12.1	2.7	2.18	4.48
TRUCK PARKING AREA-A	3.43	14.5	0.7	6.93	20.71
TRUCK PARKING AREA-B	3.43	16.2	0.6	6.10	27.00


LUMINAIRE SCHEDULE						TOTAL WATTS	POLE & BRACKETS
SYMBOL	QUANTITY	LABEL	LUMENS	LLF	DESCRIPTION		
■	16	SA	107800	0.750	KIM LIGHTING: 1W/STX4/1000PMHXXX/DB-P/(EYE LT'G:M1000B/U/PS/BT37 CLEAR)/(WALL MT'D 30' A.F.G.)	1080	SEE NOTES
●	13	SB	107800	0.750	KIM LIGHTING: AXF34/1000PMHXXX/DB-P/(EYE LT'G:M1000B/U/PS/BT37 CLEAR)/(POLE MT'D 40' A.F.G.)	1080	SEE NOTES

REV	DATE	BY	DESCRIPTION	SCALE: 0 40 80 SCALE IN FEET	CLIENT: PEPSI AMERICAS MASSILLON PARKING IMPROVEMENTS MASSILLON, OHIO
2	02/12/08	TAB	ADDENDUM #1-FENCES, FLAG POLE, LIGHTS, SIGNS	DESIGNED: LES/MWL	TITLE: OVERHEAD PARKING LOT LIGHTS
1	12/12/07	LES	RESUBMITTAL #1 TO CITY OF MASSILLON	DRAWN: HHSI	
0	11/21/07	LES	SUBMITTAL TO CITY OF MASSILLON	CHECKED: TAB	


HARD HAT SERVICES TM
Engineering, Construction and Management Solutions

940 E. Diehl Rd, Suite 150
Naperville, IL 60563
(630) 637-9470


SHEET: 13
OF 14 SHEETS

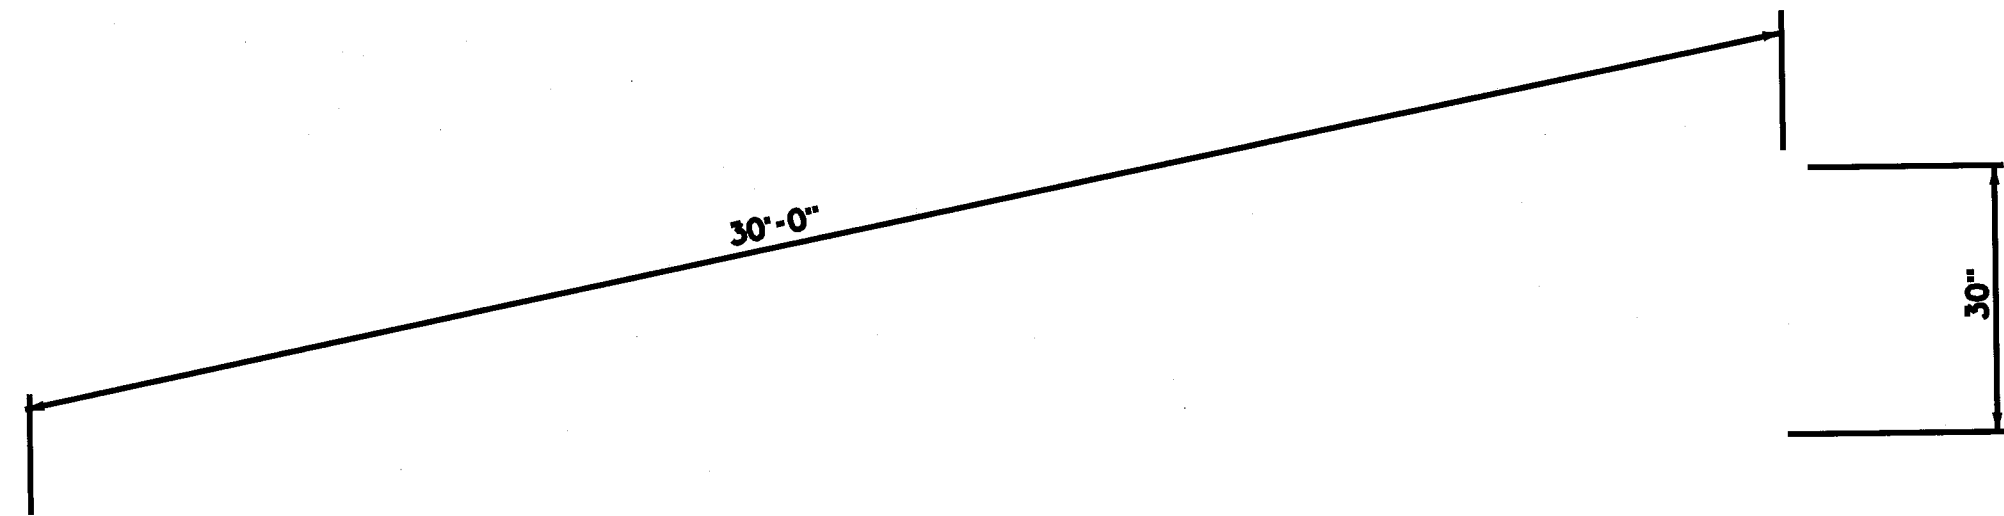

BUILDING SIGN
NTS

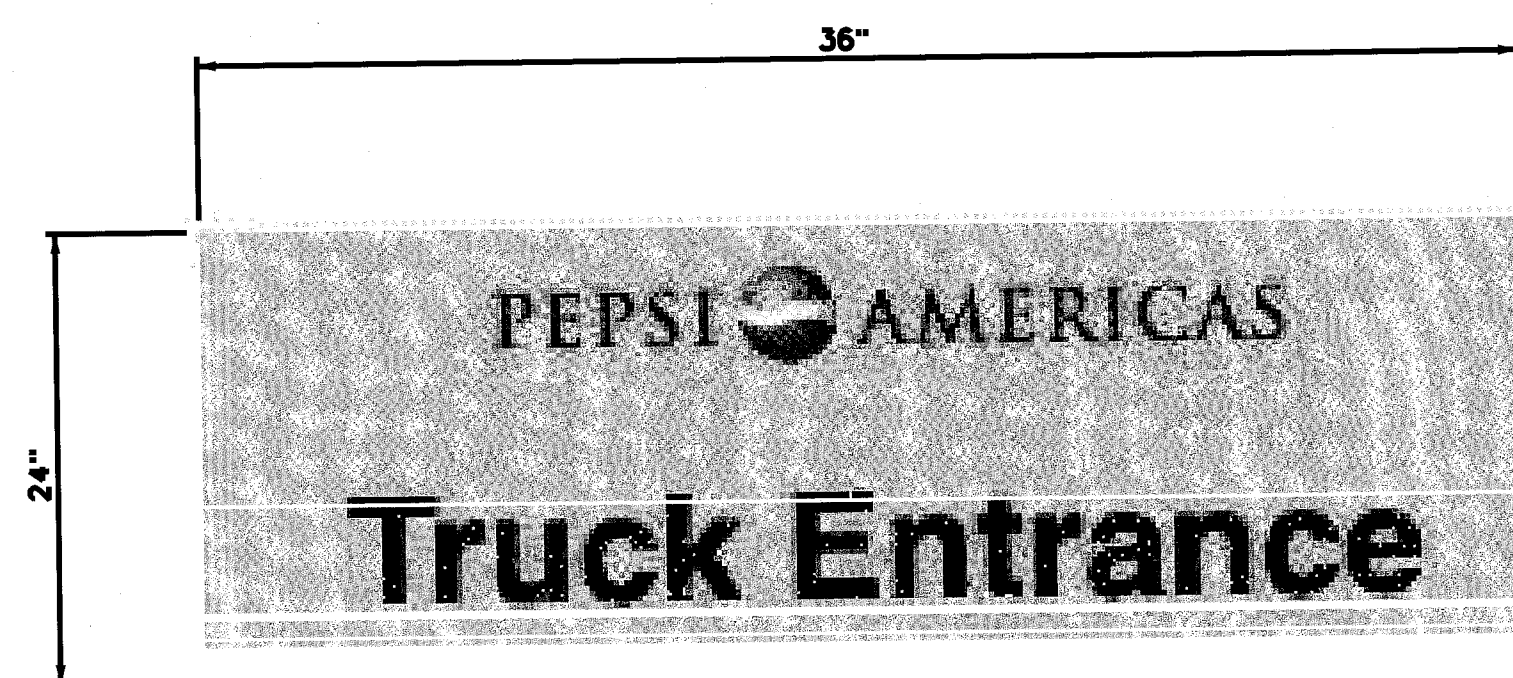


TRUCK ENTRANCE SIGN
NTS

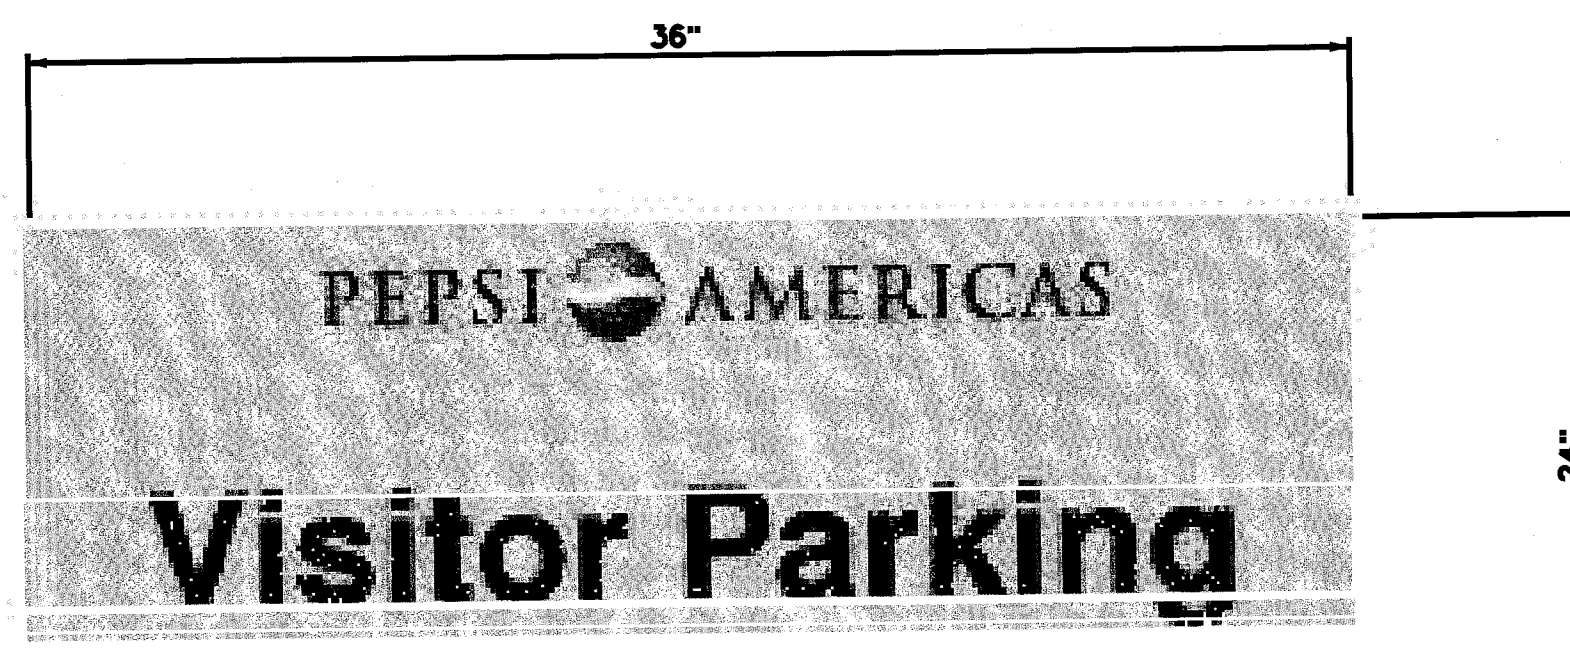

VISITOR/EMPLOYEE ENTRANCE SIGN
NTS

NOTE:
POST AND PANEL SIGNS ARE STANDARD PAS DIR-1 WITH COPY ON SINGLE FACE. SIZE IS 12"Hx36"W ON PANEL FACES, COPY HEIGHT IS 3" ON THE INFORMATIONAL PORTION. LOGOS/LETTERS ARE SIZED AT TOP AS THE SAME ON EACH PANEL.

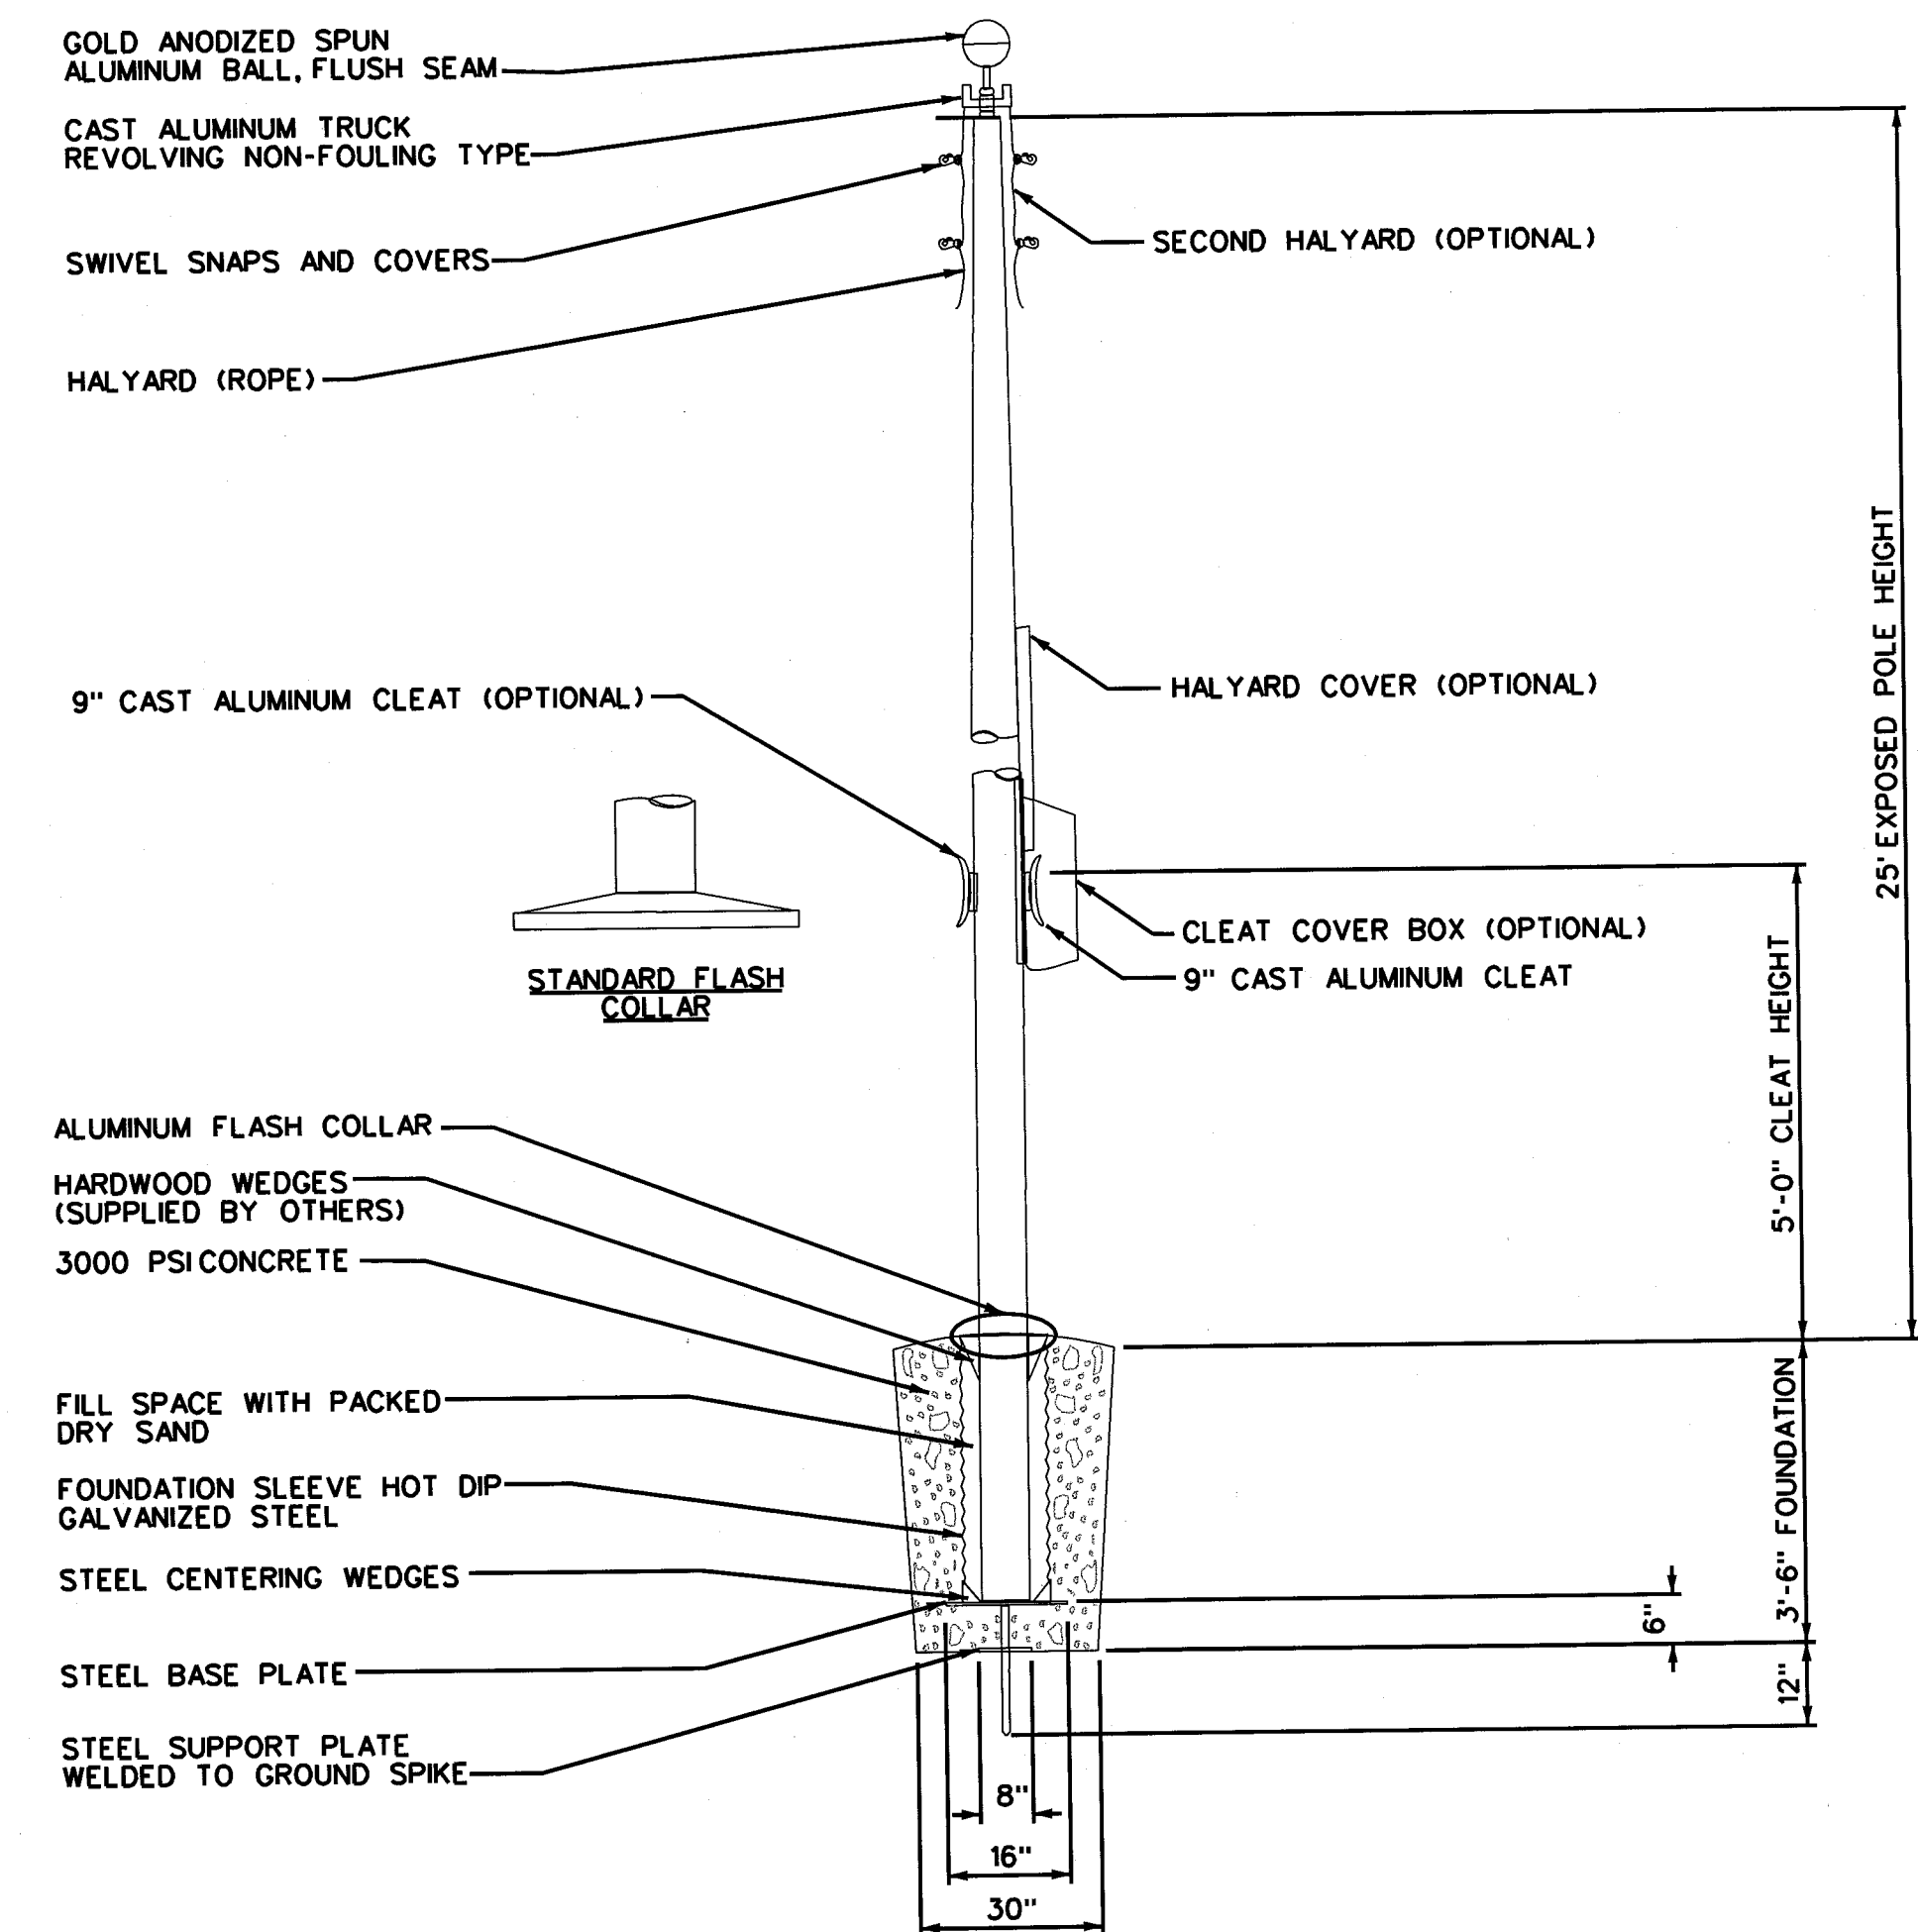

FLAG POLE DETAIL
NTS

REV	DATE	BY	DESCRIPTION	SCALE:	CLIENT:
				AS SHOWN	PEPSI AMERICAS MASSILLON PARKING IMPROVEMENTS MASSILLON, OHIO
2	02/12/08	TAB	ADDENDUM*1-FENCES, FLAG POLE, LIGHTS, SIGNS	DESIGNED: LES/MWL	TITLE: SIGNAGE PLAN AND DETAILS
1	12/12/07	LES	RESUBMITTAL *1 TO CITY OF MASSILLON	DRAWN: HHSI	
0	11/21/07	LES	SUBMITTAL TO CITY OF MASSILLON	CHECKED: TAB	
				940 E. Diehl Rd, Suite 150 Naperville, IL 60563 (630) 637-9470	
				HARD HAT SERVICES ™ Engineering, Construction and Management Solutions	
				SHEET: 14 OF 14 SHEETS	