

PLUMBING NOTES

1. ALL PLUMBING SHALL BE IN ACCORDANCE WITH THE 2015 INTERNATIONAL PLUMBING CODE (IPC) AND THE 2015 INTERNATIONAL MECHANICAL CODE (IMC).

2. ALL PLUMBING SHALL BE INSTALLED IN ACCORDANCE WITH THE 2015 INTERNATIONAL PLUMBING CODE (IPC) AND THE 2015 INTERNATIONAL MECHANICAL CODE (IMC).

3. ALL PLUMBING SHALL BE INSTALLED IN ACCORDANCE WITH THE 2015 INTERNATIONAL PLUMBING CODE (IPC) AND THE 2015 INTERNATIONAL MECHANICAL CODE (IMC).

4. ALL PLUMBING SHALL BE INSTALLED IN ACCORDANCE WITH THE 2015 INTERNATIONAL PLUMBING CODE (IPC) AND THE 2015 INTERNATIONAL MECHANICAL CODE (IMC).

5. ALL PLUMBING SHALL BE INSTALLED IN ACCORDANCE WITH THE 2015 INTERNATIONAL PLUMBING CODE (IPC) AND THE 2015 INTERNATIONAL MECHANICAL CODE (IMC).

6. ALL PLUMBING SHALL BE INSTALLED IN ACCORDANCE WITH THE 2015 INTERNATIONAL PLUMBING CODE (IPC) AND THE 2015 INTERNATIONAL MECHANICAL CODE (IMC).


7. ALL PLUMBING SHALL BE INSTALLED IN ACCORDANCE WITH THE 2015 INTERNATIONAL PLUMBING CODE (IPC) AND THE 2015 INTERNATIONAL MECHANICAL CODE (IMC).

8. ALL PLUMBING SHALL BE INSTALLED IN ACCORDANCE WITH THE 2015 INTERNATIONAL PLUMBING CODE (IPC) AND THE 2015 INTERNATIONAL MECHANICAL CODE (IMC).

9. ALL PLUMBING SHALL BE INSTALLED IN ACCORDANCE WITH THE 2015 INTERNATIONAL PLUMBING CODE (IPC) AND THE 2015 INTERNATIONAL MECHANICAL CODE (IMC).

10. ALL PLUMBING SHALL BE INSTALLED IN ACCORDANCE WITH THE 2015 INTERNATIONAL PLUMBING CODE (IPC) AND THE 2015 INTERNATIONAL MECHANICAL CODE (IMC).

This print is issued by mds & associates, inc. only upon representation that it will be retained in strict confidence by the person or corporation to whom it has been issued, neither to be duplicated nor exhibited except to facilitate the construction or maintenance of mds & associates, inc. projects.

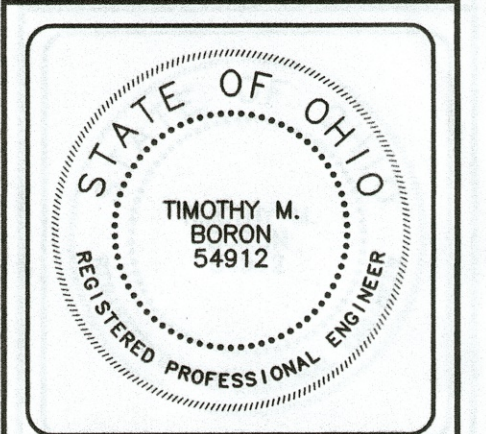

BUILDING ADDITION TO

DISCOUNT TIRE OUTLET


2034 SOUTHWAY STREET S.E.
MASSILLON, OHIO 44646

mds
& associates, inc.
consulting engineers
4125 HILLS & DALES ROAD, N.W.
SUITE 100
CANTON, OHIO 44708-1676
PHONE: 330.492.0874
FAX: 330.492.7054
e-mail: mds-michael@mds-global.net

JOB TITLE:
PLUMBING RENOVATIONS


JOB NO. 19-179
DATE 09/23/19
DWN. BY DEK/JAB
CHK. BY MRG/TMB

SHEET NO.
P-1

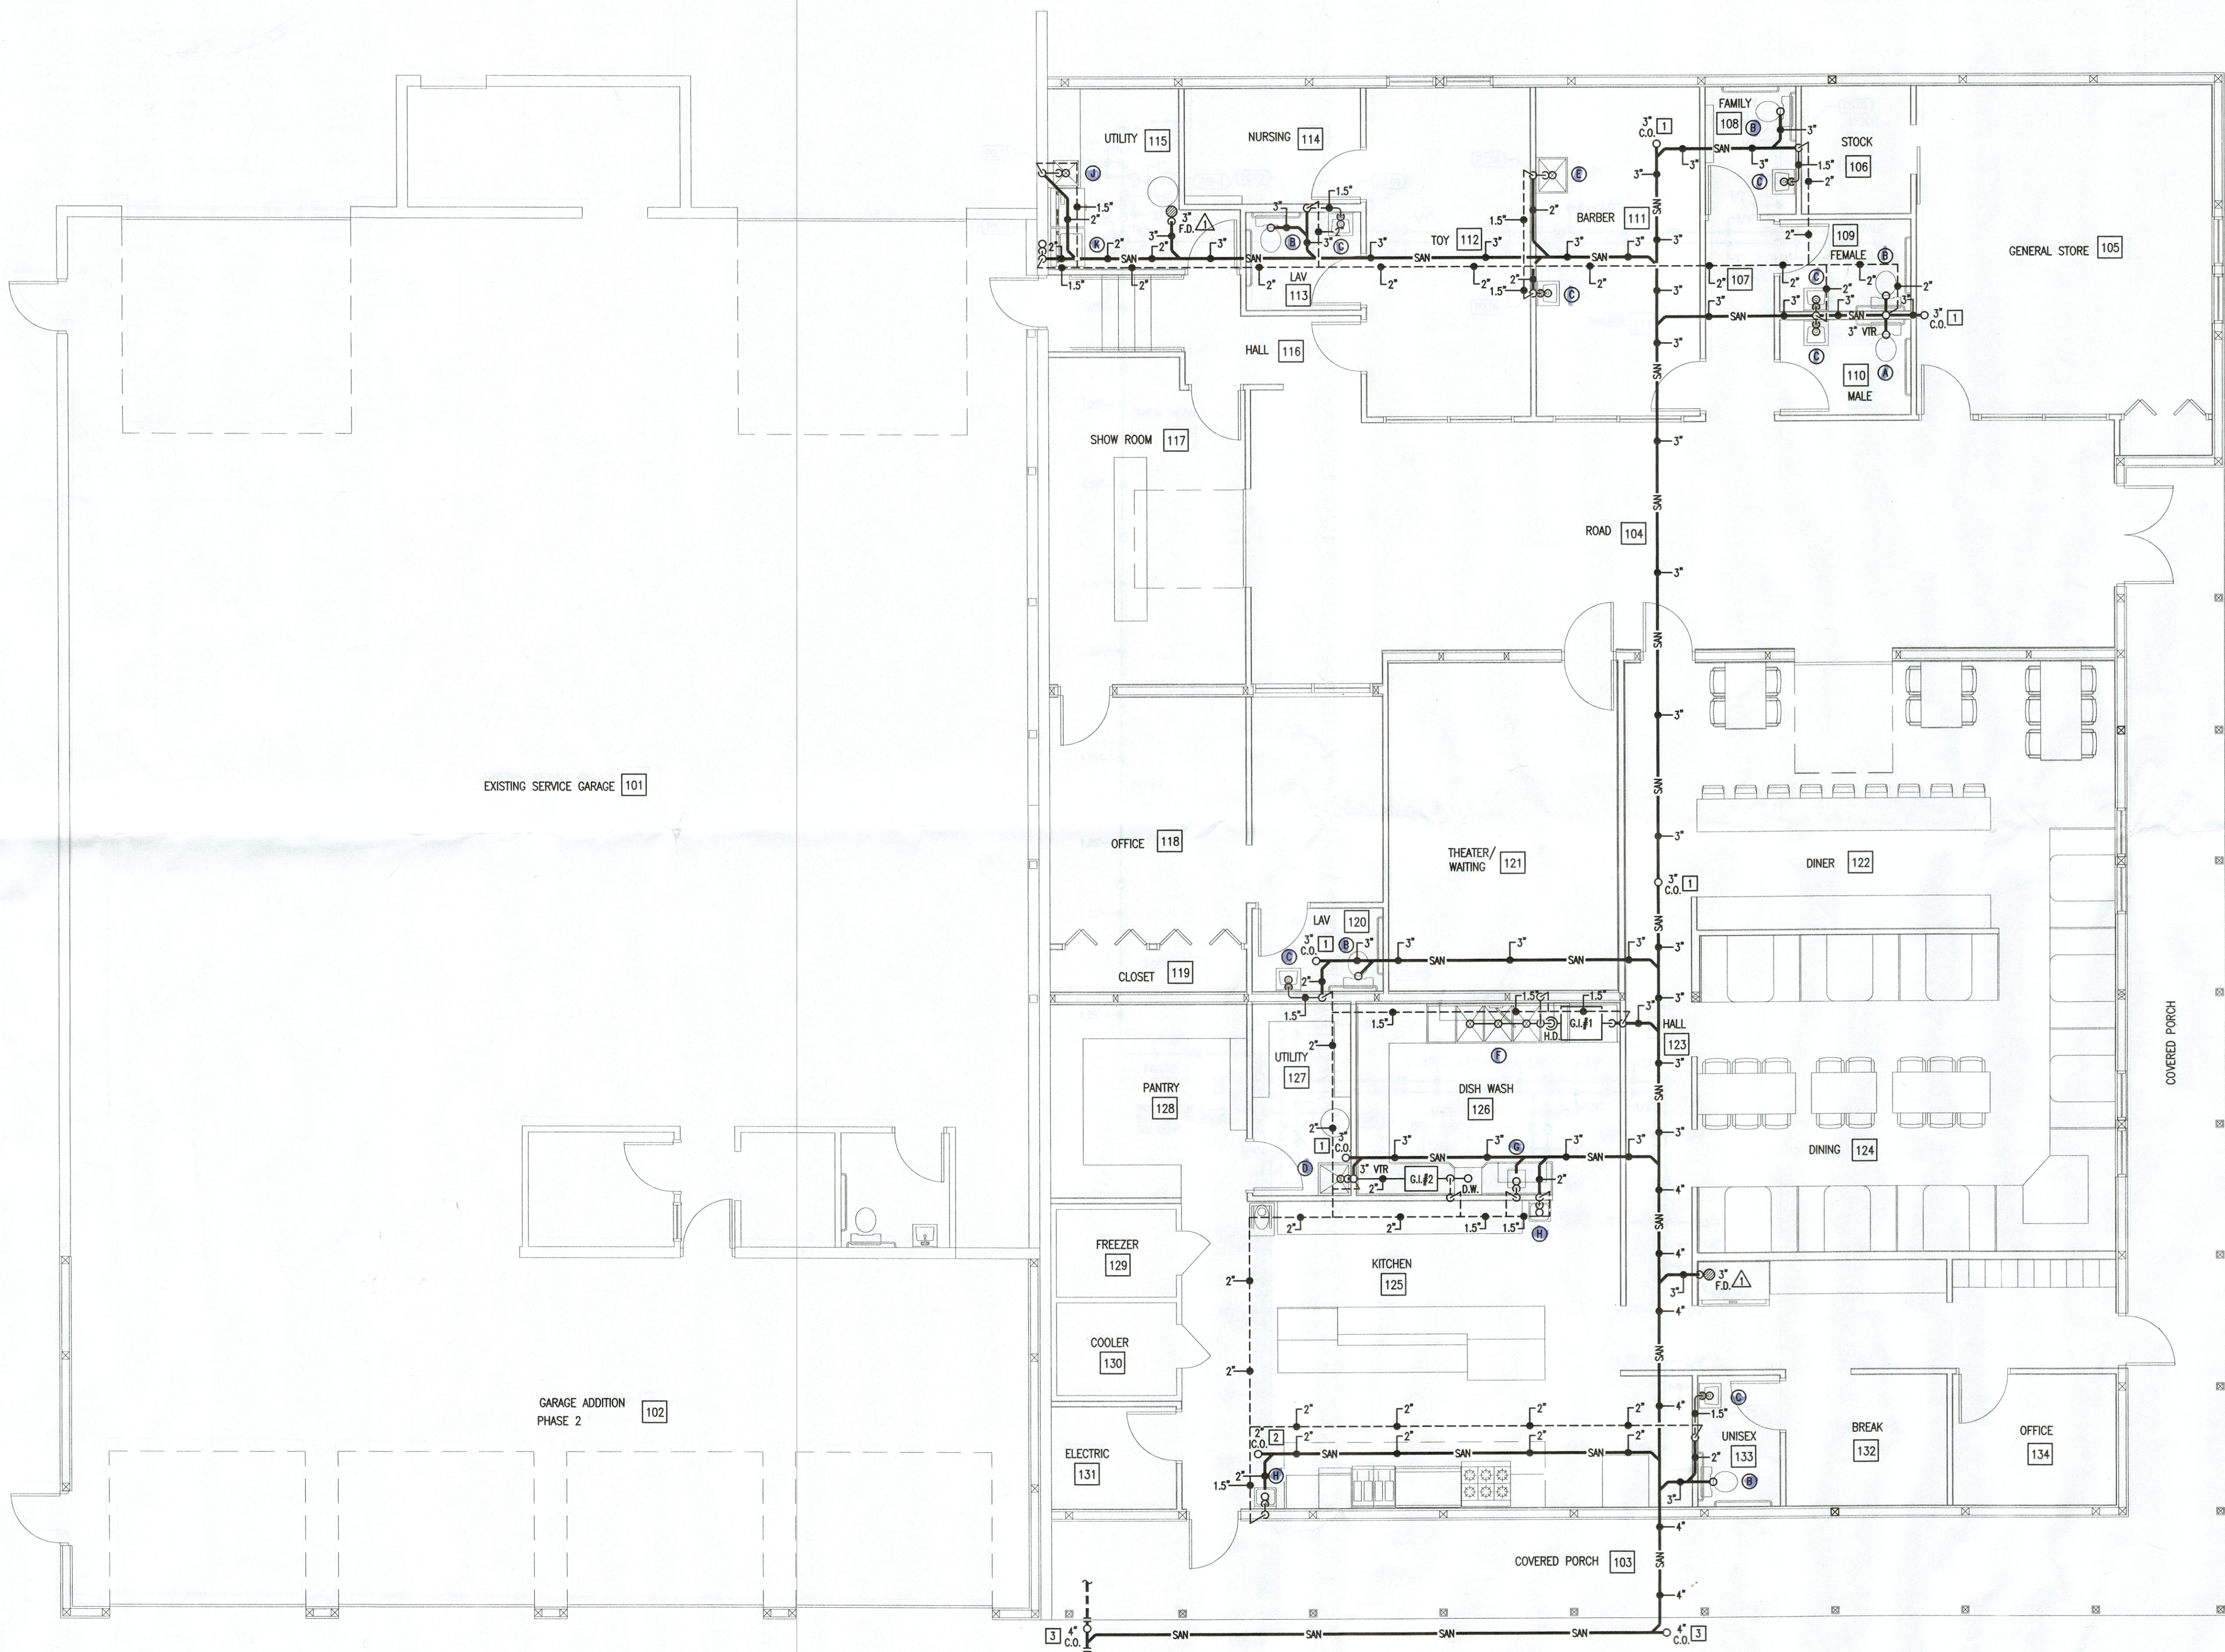

FLOOR PLAN - PLUMBING

SCALE - 3/16" = 1'-0"

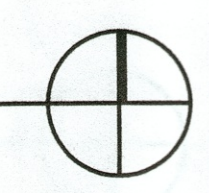

Revised 330 894 2530
D/E/T 330 832 4858

Sheet 00 of 05
19-179