


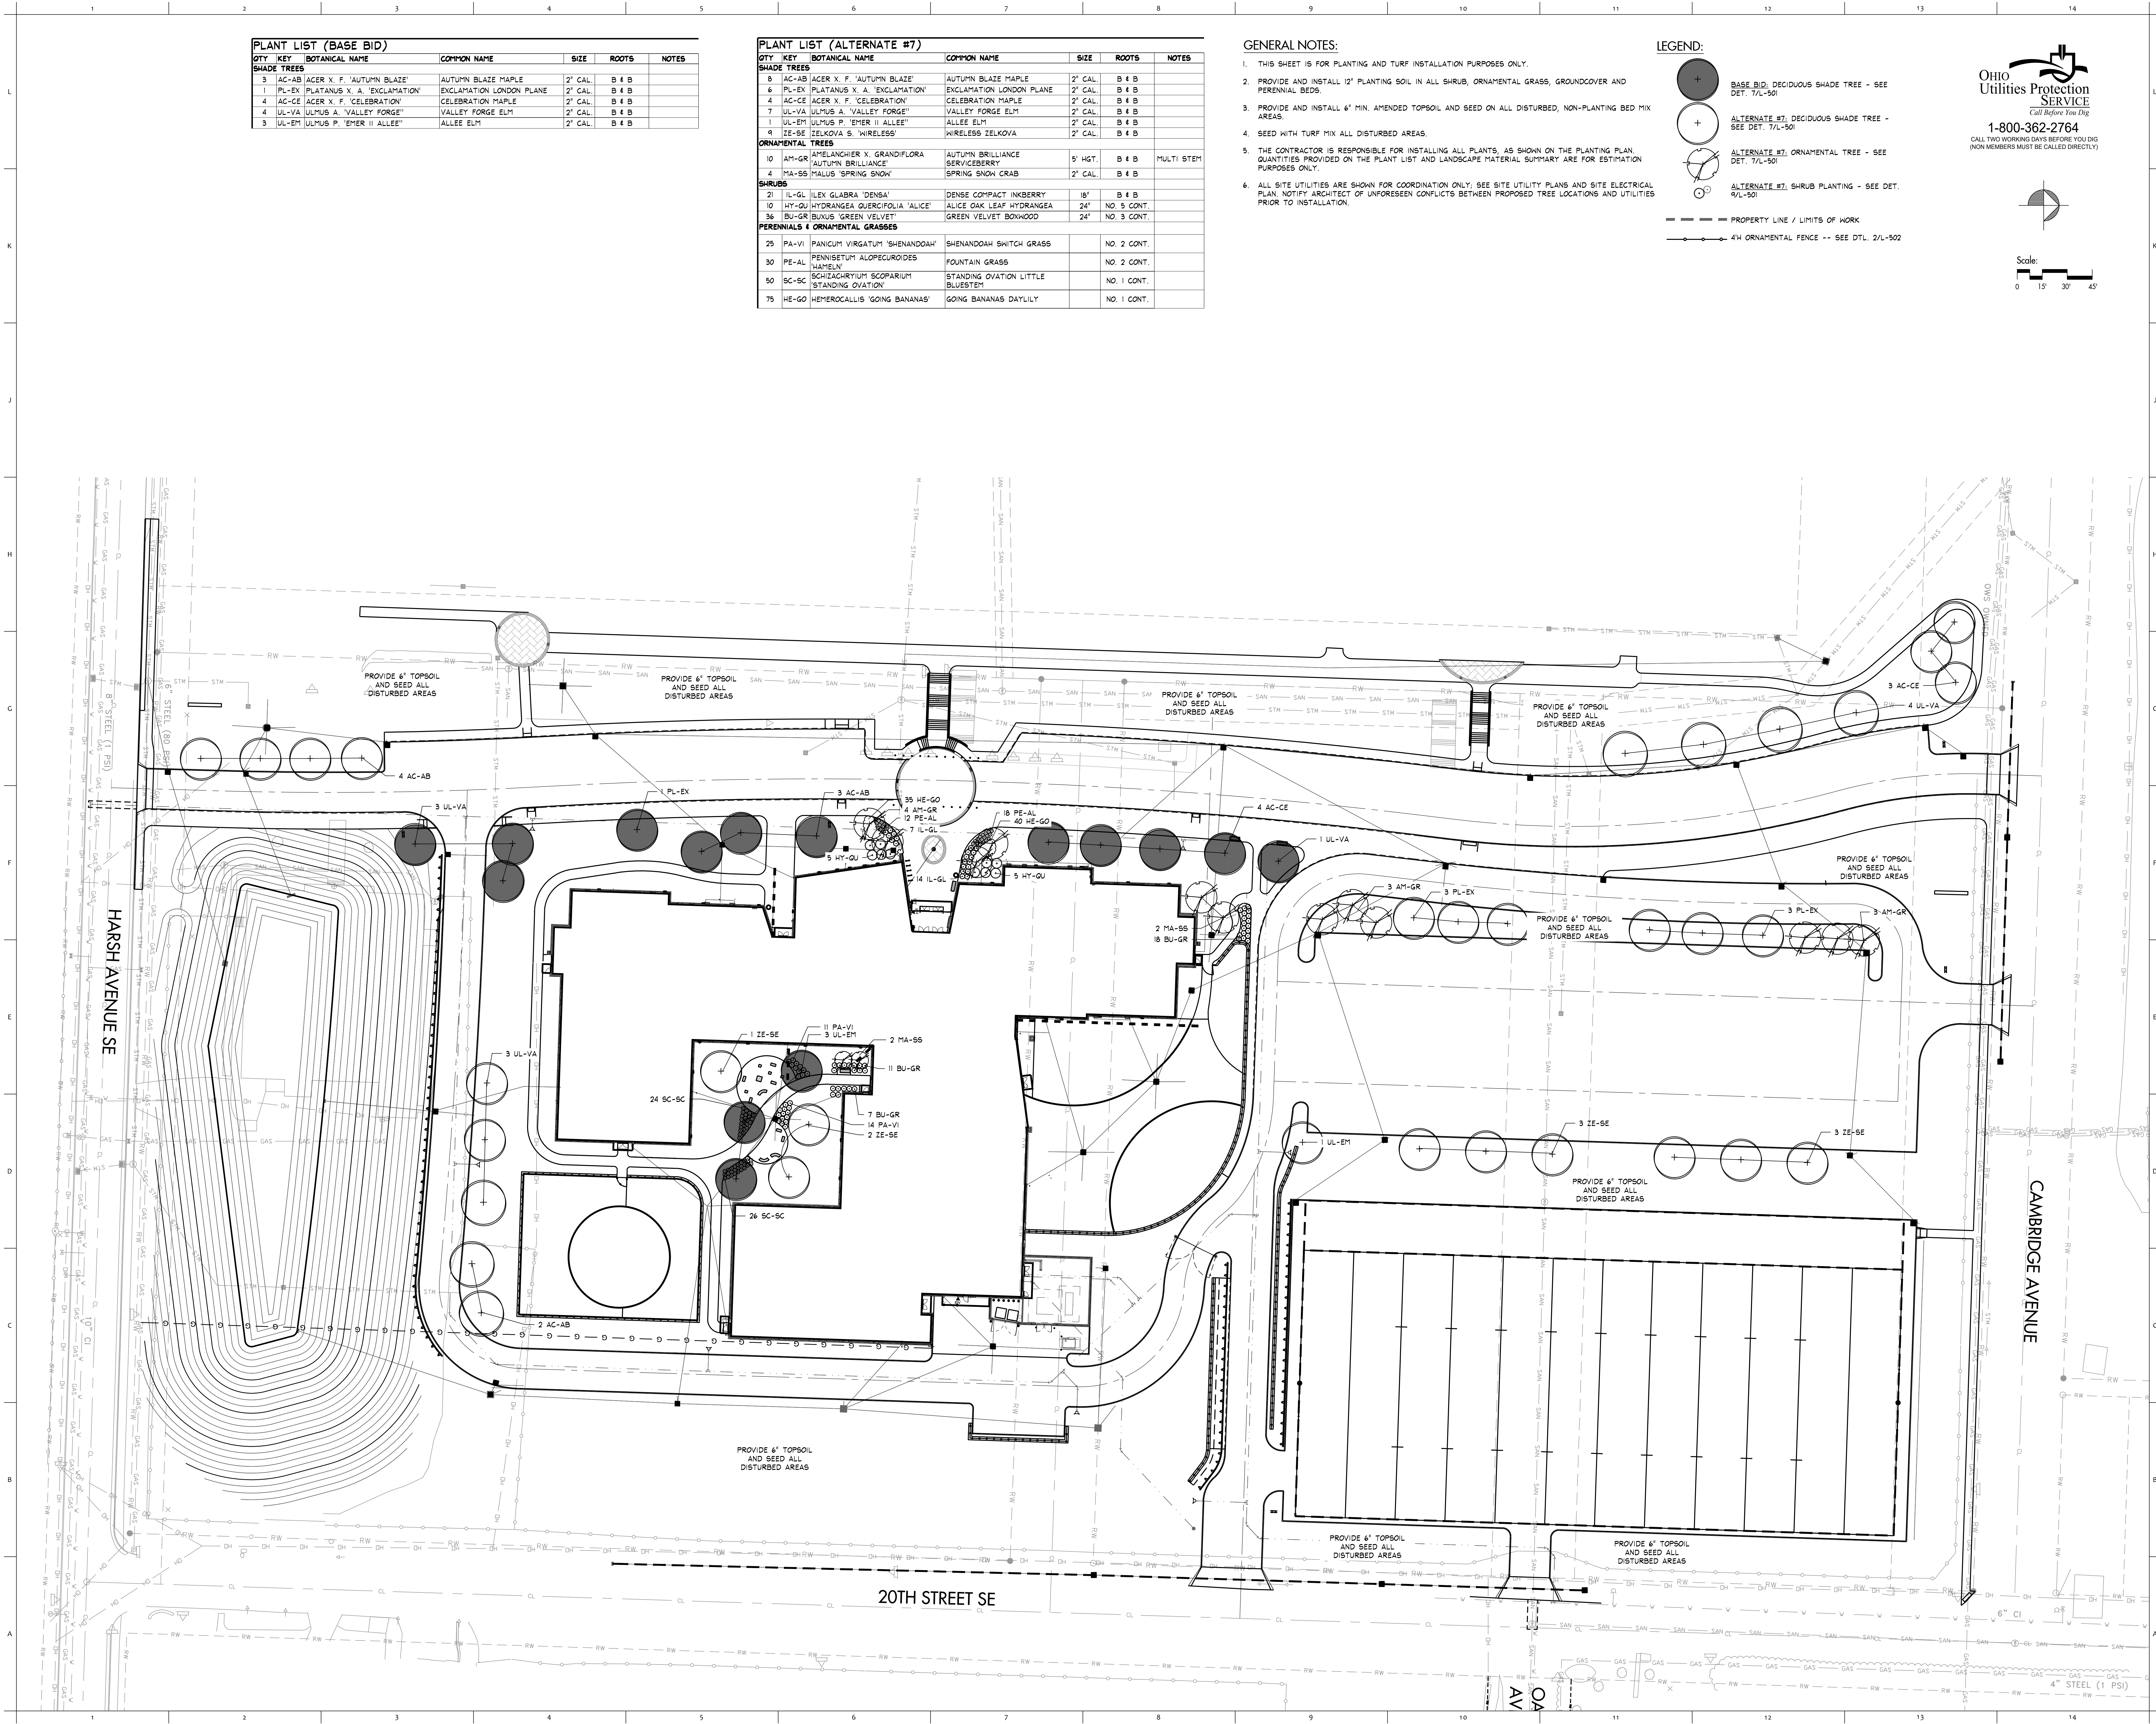

PLANT LIST (BASE BID)					
QTY	KEY	BOTANICAL NAME	COMMON NAME	SIZE	ROOTS
SHADE TREES					
3	AC-AB	ACER X. F. 'AUTUMN BLAZE'	AUTUMN BLAZE MAPLE	2" CAL.	B 4 B
1	PL-EX	PLATANUS X. A. 'EXCLAMATION'	EXCLAMATION LONDON PLANE	2" CAL.	B 4 B
4	AC-CE	ACER X. F. 'CELEBRATION'	CELEBRATION MAPLE	2" CAL.	B 4 B
4	UL-VA	ULMUS A. 'VALLEY FORGE'	VALLEY FORGE ELM	2" CAL.	B 4 B
3	UL-EM	ULMUS P. 'EMER II ALLEE'	ALLEE ELM	2" CAL.	B 4 B

PLANT LIST (ALTERNATE #7)					
QTY	KEY	BOTANICAL NAME	COMMON NAME	SIZE	ROOTS
SHADE TREES					
8	AC-AB	ACER X. F. 'AUTUMN BLAZE'	AUTUMN BLAZE MAPLE	2" CAL.	B 4 B
6	PL-EX	PLATANUS X. A. 'EXCLAMATION'	EXCLAMATION LONDON PLANE	2" CAL.	B 4 B
4	AC-CE	ACER X. F. 'CELEBRATION'	CELEBRATION MAPLE	2" CAL.	B 4 B
7	UL-VA	ULMUS A. 'VALLEY FORGE'	VALLEY FORGE ELM	2" CAL.	B 4 B
1	UL-EM	ULMUS P. 'EMER II ALLEE'	ALLEE ELM	2" CAL.	B 4 B
9	ZE-SE	ZELKOVA S. 'WIRELESS'	WIRELESS ZELKOVA	2" CAL.	B 4 B
ORNAMENTAL TREES					
10	AM-GR	AMELANCHIER X. GRANDIFLORA	AUTUMN BRILLIANCE SERVICEBERRY	5' HGT.	B 4 B
4	MA-SB	MALUS 'SPRING SNOW'	SPRING SNOW CRAB	2" CAL.	B 4 B
SHRUBS					
21	IL-GL	ILEX GLABRA 'DENSE'	DENSE COMPACT INKBERRY	18"	B 4 B
0	HY-QU	HYDRANGEA QUERCIFOLIA 'ALICE'	ALICE OAK LEAF HYDRANGEA	24"	NO. 5 CONT.
36	BU-GR	BUXUS 'GREEN VELVET'	GREEN VELVET BOXWOOD	24"	NO. 3 CONT.
PERENNIALS & ORNAMENTAL GRASSES					
25	PA-VI	PANICUM VIRGATUM 'SHENANDOAH'	SHENANDOAH SWITCH GRASS		NO. 2 CONT.
30	PE-AL	PENNISETUM ALOPECUROIDES 'HAMELN'	FOUNTAIN GRASS		NO. 2 CONT.
50	SC-SC	SCITACHRYTUM SCOPARIUM 'STANDING OVATION'	STANDING OVATION LITTLE BLUESTEM		NO. 1 CONT.
75	HE-GO	HEPEROCALLIS 'GOING BANANAS'	GOING BANANAS DAYLILY		NO. 1 CONT.

- GENERAL NOTES:
- THIS SHEET IS FOR PLANTING AND TURF INSTALLATION PURPOSES ONLY.
 - PROVIDE AND INSTALL 12" PLANTING SOIL IN ALL SHRUB, ORNAMENTAL GRASS, GROUNDCOVER AND PERENNIAL BEDS.
 - PROVIDE AND INSTALL 6" MIN. AMENDED TOPSOIL AND SEED ON ALL DISTURBED, NON-PLANTING BED MIX AREAS.
 - SEED WITH TURF MIX ALL DISTURBED AREAS.
 - THE CONTRACTOR IS RESPONSIBLE FOR INSTALLING ALL PLANTS, AS SHOWN ON THE PLANTING PLAN. QUANTITIES PROVIDED ON THE PLANT LIST AND LANDSCAPE MATERIAL SUMMARY ARE FOR ESTIMATION PURPOSES ONLY.
 - ALL SITE UTILITIES ARE SHOWN FOR COORDINATION ONLY. SEE SITE UTILITY PLANS AND SITE ELECTRICAL PLAN. NOTIFY ARCHITECT OF UNFORESEEN CONFLICTS BETWEEN PROPOSED TREE LOCATIONS AND UTILITIES PRIOR TO INSTALLATION.

LEGEND:

- BASE BID, DECIDUOUS SHADE TREE - SEE DET. 7/L-501
- ALTERNATE #7, DECIDUOUS SHADE TREE - SEE DET. 7/L-501
- ALTERNATE #7, ORNAMENTAL TREE - SEE DET. 7/L-501
- ALTERNATE #7, SHRUB PLANTING - SEE DET. 9/L-501
- PROPERTY LINE / LIMITS OF WORK
- 4" ORNAMENTAL FENCE -- SEE DET. 2/L-502

OHIO
Utilities Protection
SERVICE
Call Before You Dig
1-800-362-2764
CALL TWO WORKING DAYS BEFORE YOU DIG
(NON MEMBERS MUST BE CALLED DIRECTLY)

Scale:
0 15' 30' 45'

PROJECT NO
2203-2

ARCHITECTURAL VISION GROUP, LTD
PLANNERS
ARCHITECTS
23850 SPERRY DRIVE
CLEVELAND, OHIO 44145

MASSILLON CITY SCHOOL
EAST SIDE CAMPUS
1 Paul E Brown Dr SE Massillon, OH 44646

7/20/2023 FOR BID AND PERMIT
MARK DATE DESCRIPTION
ISSUED AS:

PROJECT NO 2203-1
DRAWN BY
CHECKED BY
DATE

SITE
PLANTING

SHEET NO
L-400

CONSULTANT
behnke
LANDSCAPE ARCHITECTURE
26885 Sycamore Road, Suite 2
P.O. Box 990 P.O. Box 990
E. Massillon, OH 44646

PROFESSIONAL SEAL
STATE OF OHIO
MADE WITH
DOWNSIDE
LANDSCAPE ARCHITECTURE
F. ARCHITECTS

ARCHITECTURAL VISION GROUP, LTD
PLANNERS
ARCHITECTS
23850 SPERRY DRIVE
CLEVELAND, OHIO 44145