


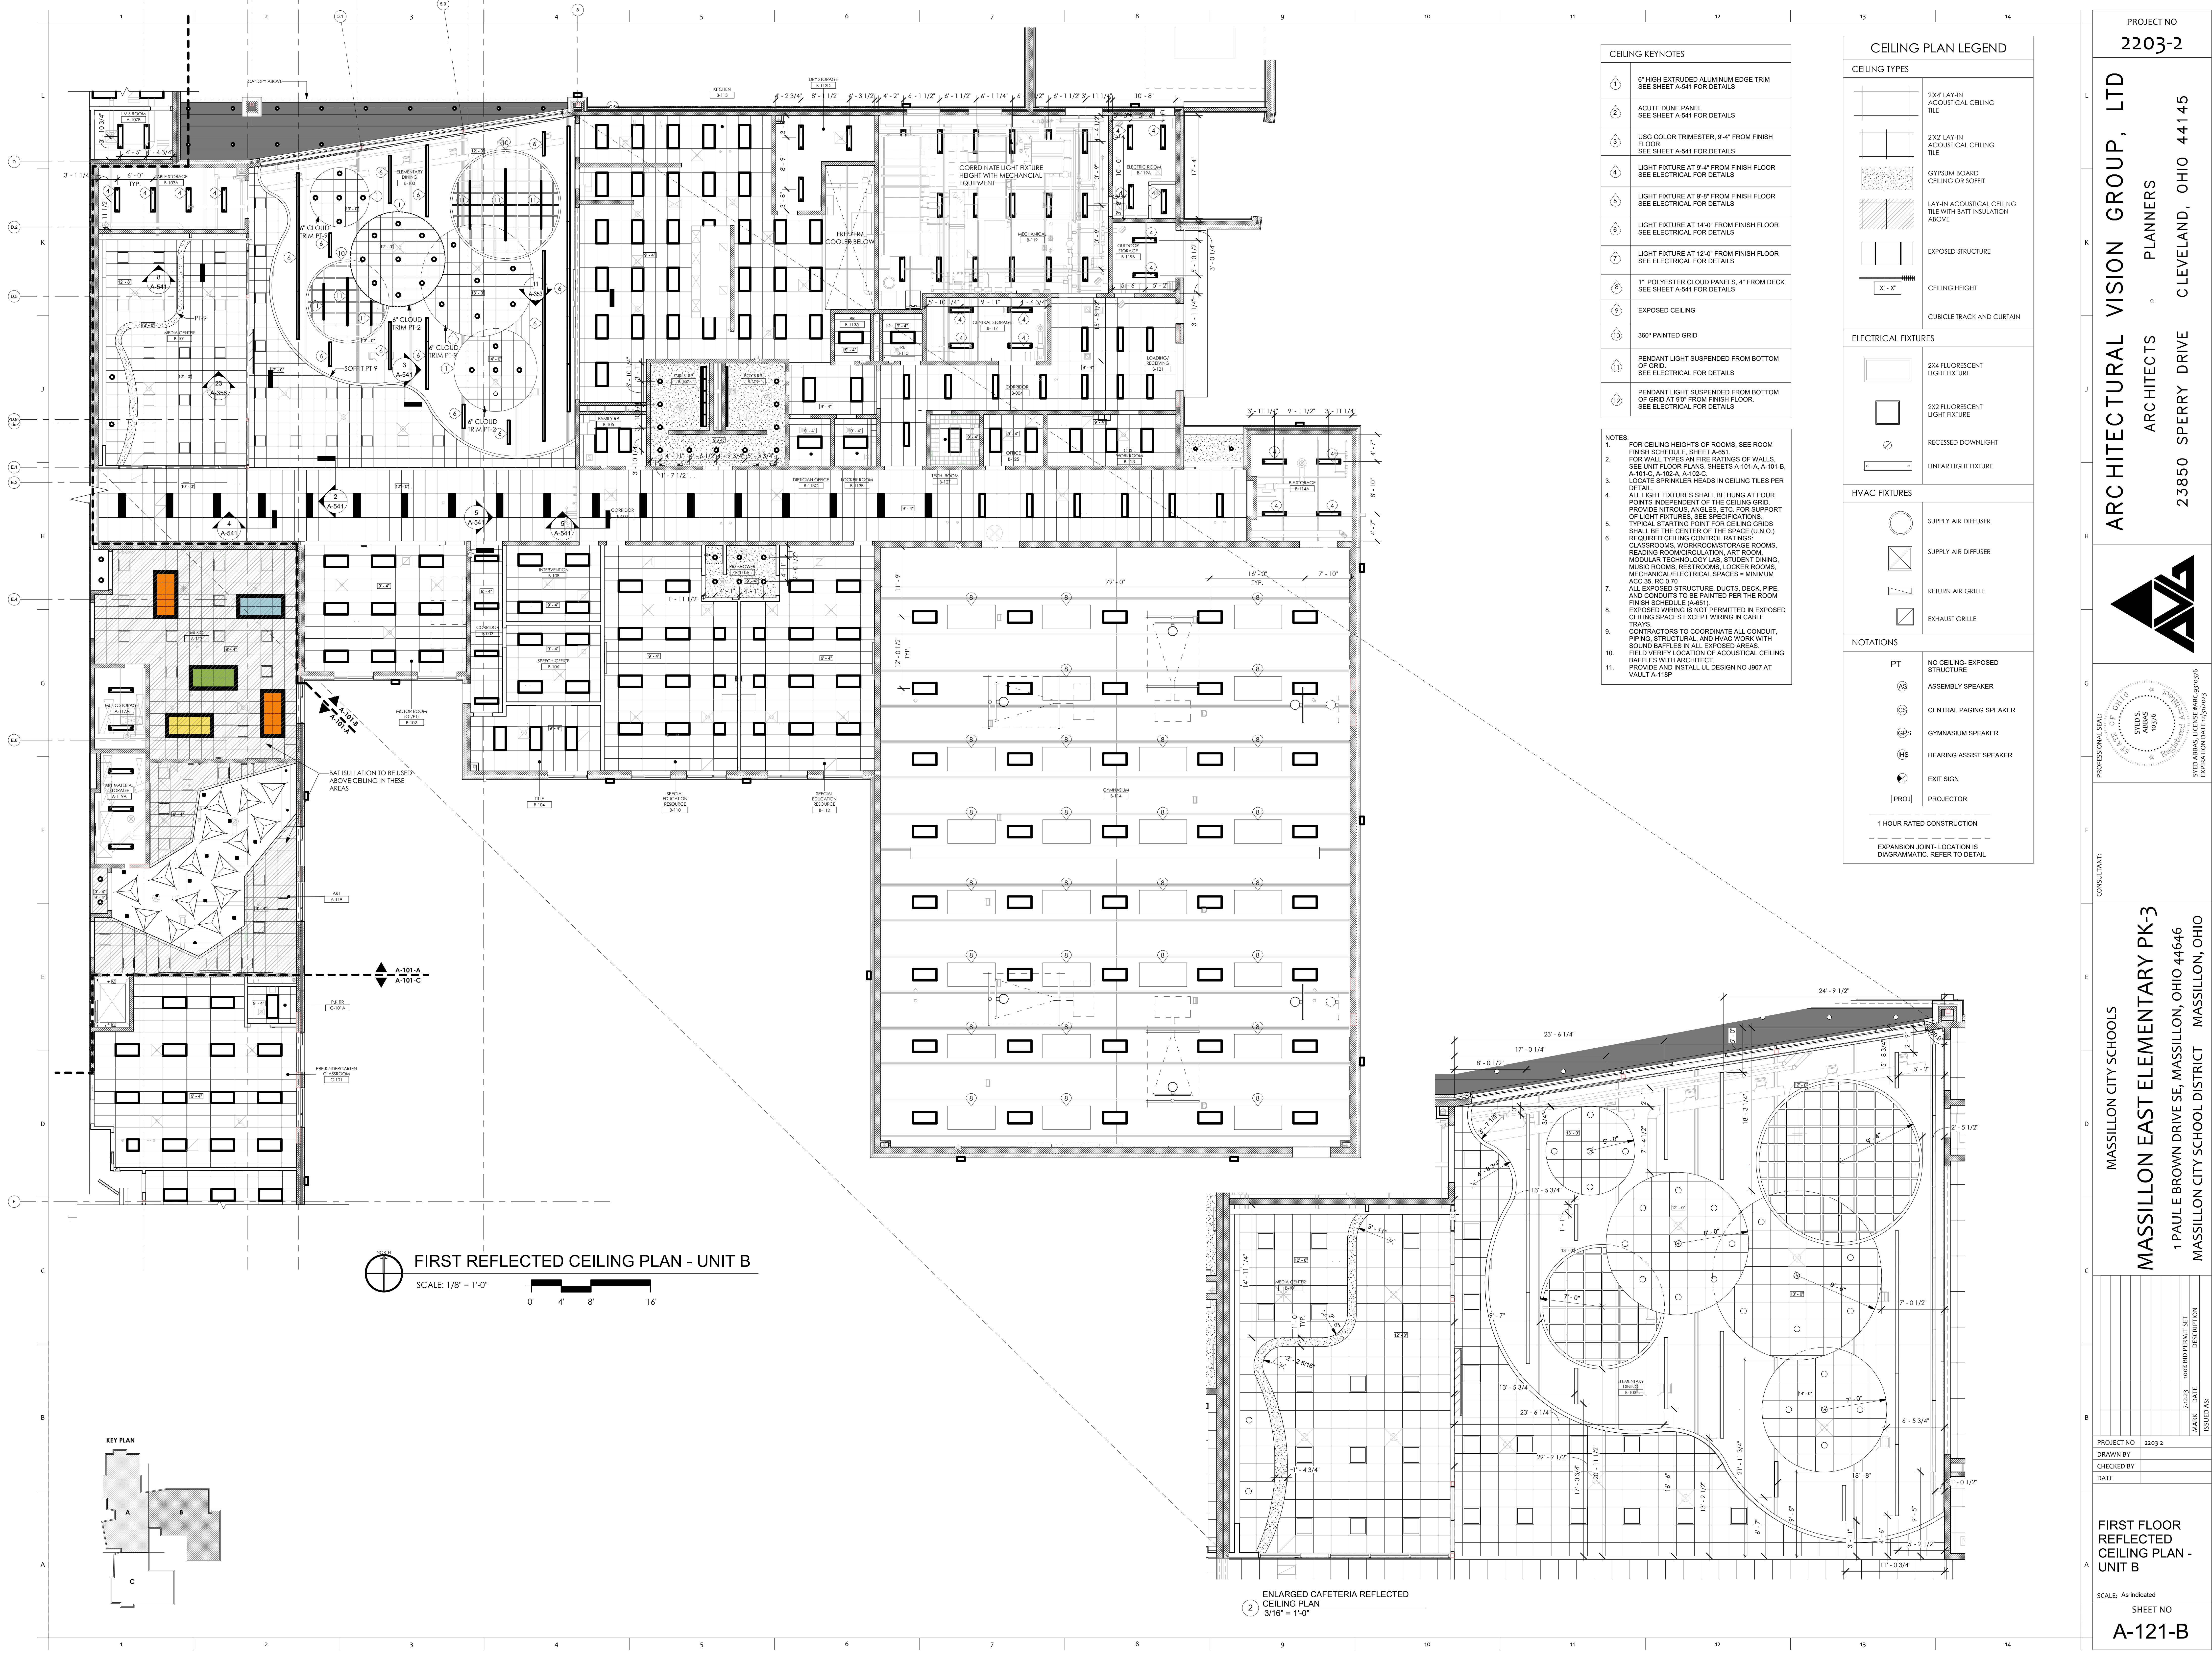

CEILING KEYNOTES	
1	6" HIGH EXTRUDED ALUMINUM EDGE TRIM SEE SHEET A-541 FOR DETAILS
2	ACUTE DUNE PANEL SEE SHEET A-541 FOR DETAILS
3	USG COLOR TRIMESTER, 9'-4" FROM FINISH FLOOR SEE SHEET A-541 FOR DETAILS
4	LIGHT FIXTURE AT 9'-4" FROM FINISH FLOOR SEE ELECTRICAL FOR DETAILS
5	LIGHT FIXTURE AT 9'-8" FROM FINISH FLOOR SEE ELECTRICAL FOR DETAILS
6	LIGHT FIXTURE AT 14'-0" FROM FINISH FLOOR SEE ELECTRICAL FOR DETAILS
7	LIGHT FIXTURE AT 12'-0" FROM FINISH FLOOR SEE ELECTRICAL FOR DETAILS
8	1" POLYESTER CLOUD PANELS, 4" FROM DECK SEE SHEET A-541 FOR DETAILS
9	EXPOSED CEILING
10	360° PAINTED GRID
11	PENDANT LIGHT SUSPENDED FROM BOTTOM OF GRID SEE ELECTRICAL FOR DETAILS
12	PENDANT LIGHT SUSPENDED FROM BOTTOM OF GRID AT 9" FROM FINISH FLOOR SEE ELECTRICAL FOR DETAILS

- NOTES:
- FOR CEILING HEIGHTS OF ROOMS, SEE ROOM FINISH SCHEDULE, SHEET A-651
 - FOR WALL TYPES AND FIRE RATINGS OF WALLS, SEE UNIT FLOOR PLANS, SHEETS A-101-A, A-101-B, A-101-C, A-102-A, A-102-B
 - LOCATE SPRINKLER HEADS IN CEILING TILES PER DETAIL
 - ALL LIGHT FIXTURES SHALL BE HUNG AT FOUR POINTS INDEPENDENT OF THE CEILING GRID. PROVIDE NITROGEN ANGLES, ETC. FOR SUPPORT OF LIGHT FIXTURES. SEE SPECIFICATIONS. TYPICAL STARTING POINT FOR CEILING GRIDS SHALL BE THE CENTER OF THE SPACE (U.N.O.) REQUIRED CEILING CONTROL RATINGS: CLASSROOMS, WORKROOMS, STORAGE ROOMS, READING ROOM/CIRCULATION, ART ROOM, MODULAR TECHNOLOGY LAB, STUDENT DINING, MUSIC ROOMS, RESTROOMS, LOCKER ROOMS, MECHANICAL/ELECTRICAL SPACES - MINIMUM ACC 35, RC 0.70
 - ALL EXPOSED STRUCTURE, DUCTS, DECK, PIPE, AND CONDUITS TO BE PAINTED PER THE ROOM FINISH SCHEDULE (A-651)
 - EXPOSED WIRING IS NOT PERMITTED IN EXPOSED CEILING SPACES EXCEPT WIRING IN CABLE TRAYS
 - CONTRACTORS TO COORDINATE ALL CONDUIT, PIPING, STRUCTURAL, AND HVAC WORK WITH SOUND BATTLES IN ALL EXPOSED AREAS
 - FIELD VERIFY LOCATION OF ACOUSTICAL CEILING BATTLES WITH ARCHITECT
 - PROVIDE AND INSTALL UL DESIGN NO J907 AT VAULT A-118P

CEILING PLAN LEGEND	
CEILING TYPES	
	2'x4' LAY-IN ACOUSTICAL CEILING TILE
	2'x2' LAY-IN ACOUSTICAL CEILING TILE
	GYPSUM BOARD CEILING OR SOFFIT
	LAY-IN ACOUSTICAL CEILING TILE WITH BATT INSULATION ABOVE
	EXPOSED STRUCTURE
	CEILING HEIGHT
	CUBICLE TRACK AND CURTAIN
ELECTRICAL FIXTURES	
	2'x4' FLUORESCENT LIGHT FIXTURE
	2'x2' FLUORESCENT LIGHT FIXTURE
	RECESSED DOWNLIGHT
	LINEAR LIGHT FIXTURE
HVAC FIXTURES	
	SUPPLY AIR DIFFUSER
	SUPPLY AIR DIFFUSER
	RETURN AIR GRILLE
	EXHAUST GRILLE
NOTATIONS	
PT	NO CEILING - EXPOSED STRUCTURE
AS	ASSEMBLY SPEAKER
CS	CENTRAL PAGING SPEAKER
GPS	GYMNASIUM SPEAKER
HAS	HEARING ASSIST SPEAKER
ES	EXIT SIGN
PROJ	PROJECTOR
1 HOUR RATED CONSTRUCTION	
EXPANSION JOINT - LOCATION IS DIAGRAMMATIC. REFER TO DETAIL	

PROJECT NO
2203-2

ARCHITECTURAL VISION GROUP, LTD
PLANNERS
ARCHITECTS
23850 SPERRY DRIVE
CLEVELAND, OHIO 44145

MASSILLON CITY SCHOOLS
MASSILLON EAST ELEMENTARY PK-3
1 PAULE BROWN DRIVE SE, MASSILLON, OHIO 44646
MASSILLON CITY SCHOOL DISTRICT
MASSILLON, OHIO

PROJECT NO	2203-2
DRAWN BY	
CHECKED BY	
DATE	

7/23/21	100% BID PERMIT SET
MASS	DATE
ISSUED AS	DESCRIPTION

FIRST FLOOR
REFLECTED
CEILING PLAN -
UNIT B

SCALE: As indicated
SHEET NO
A-121-B