



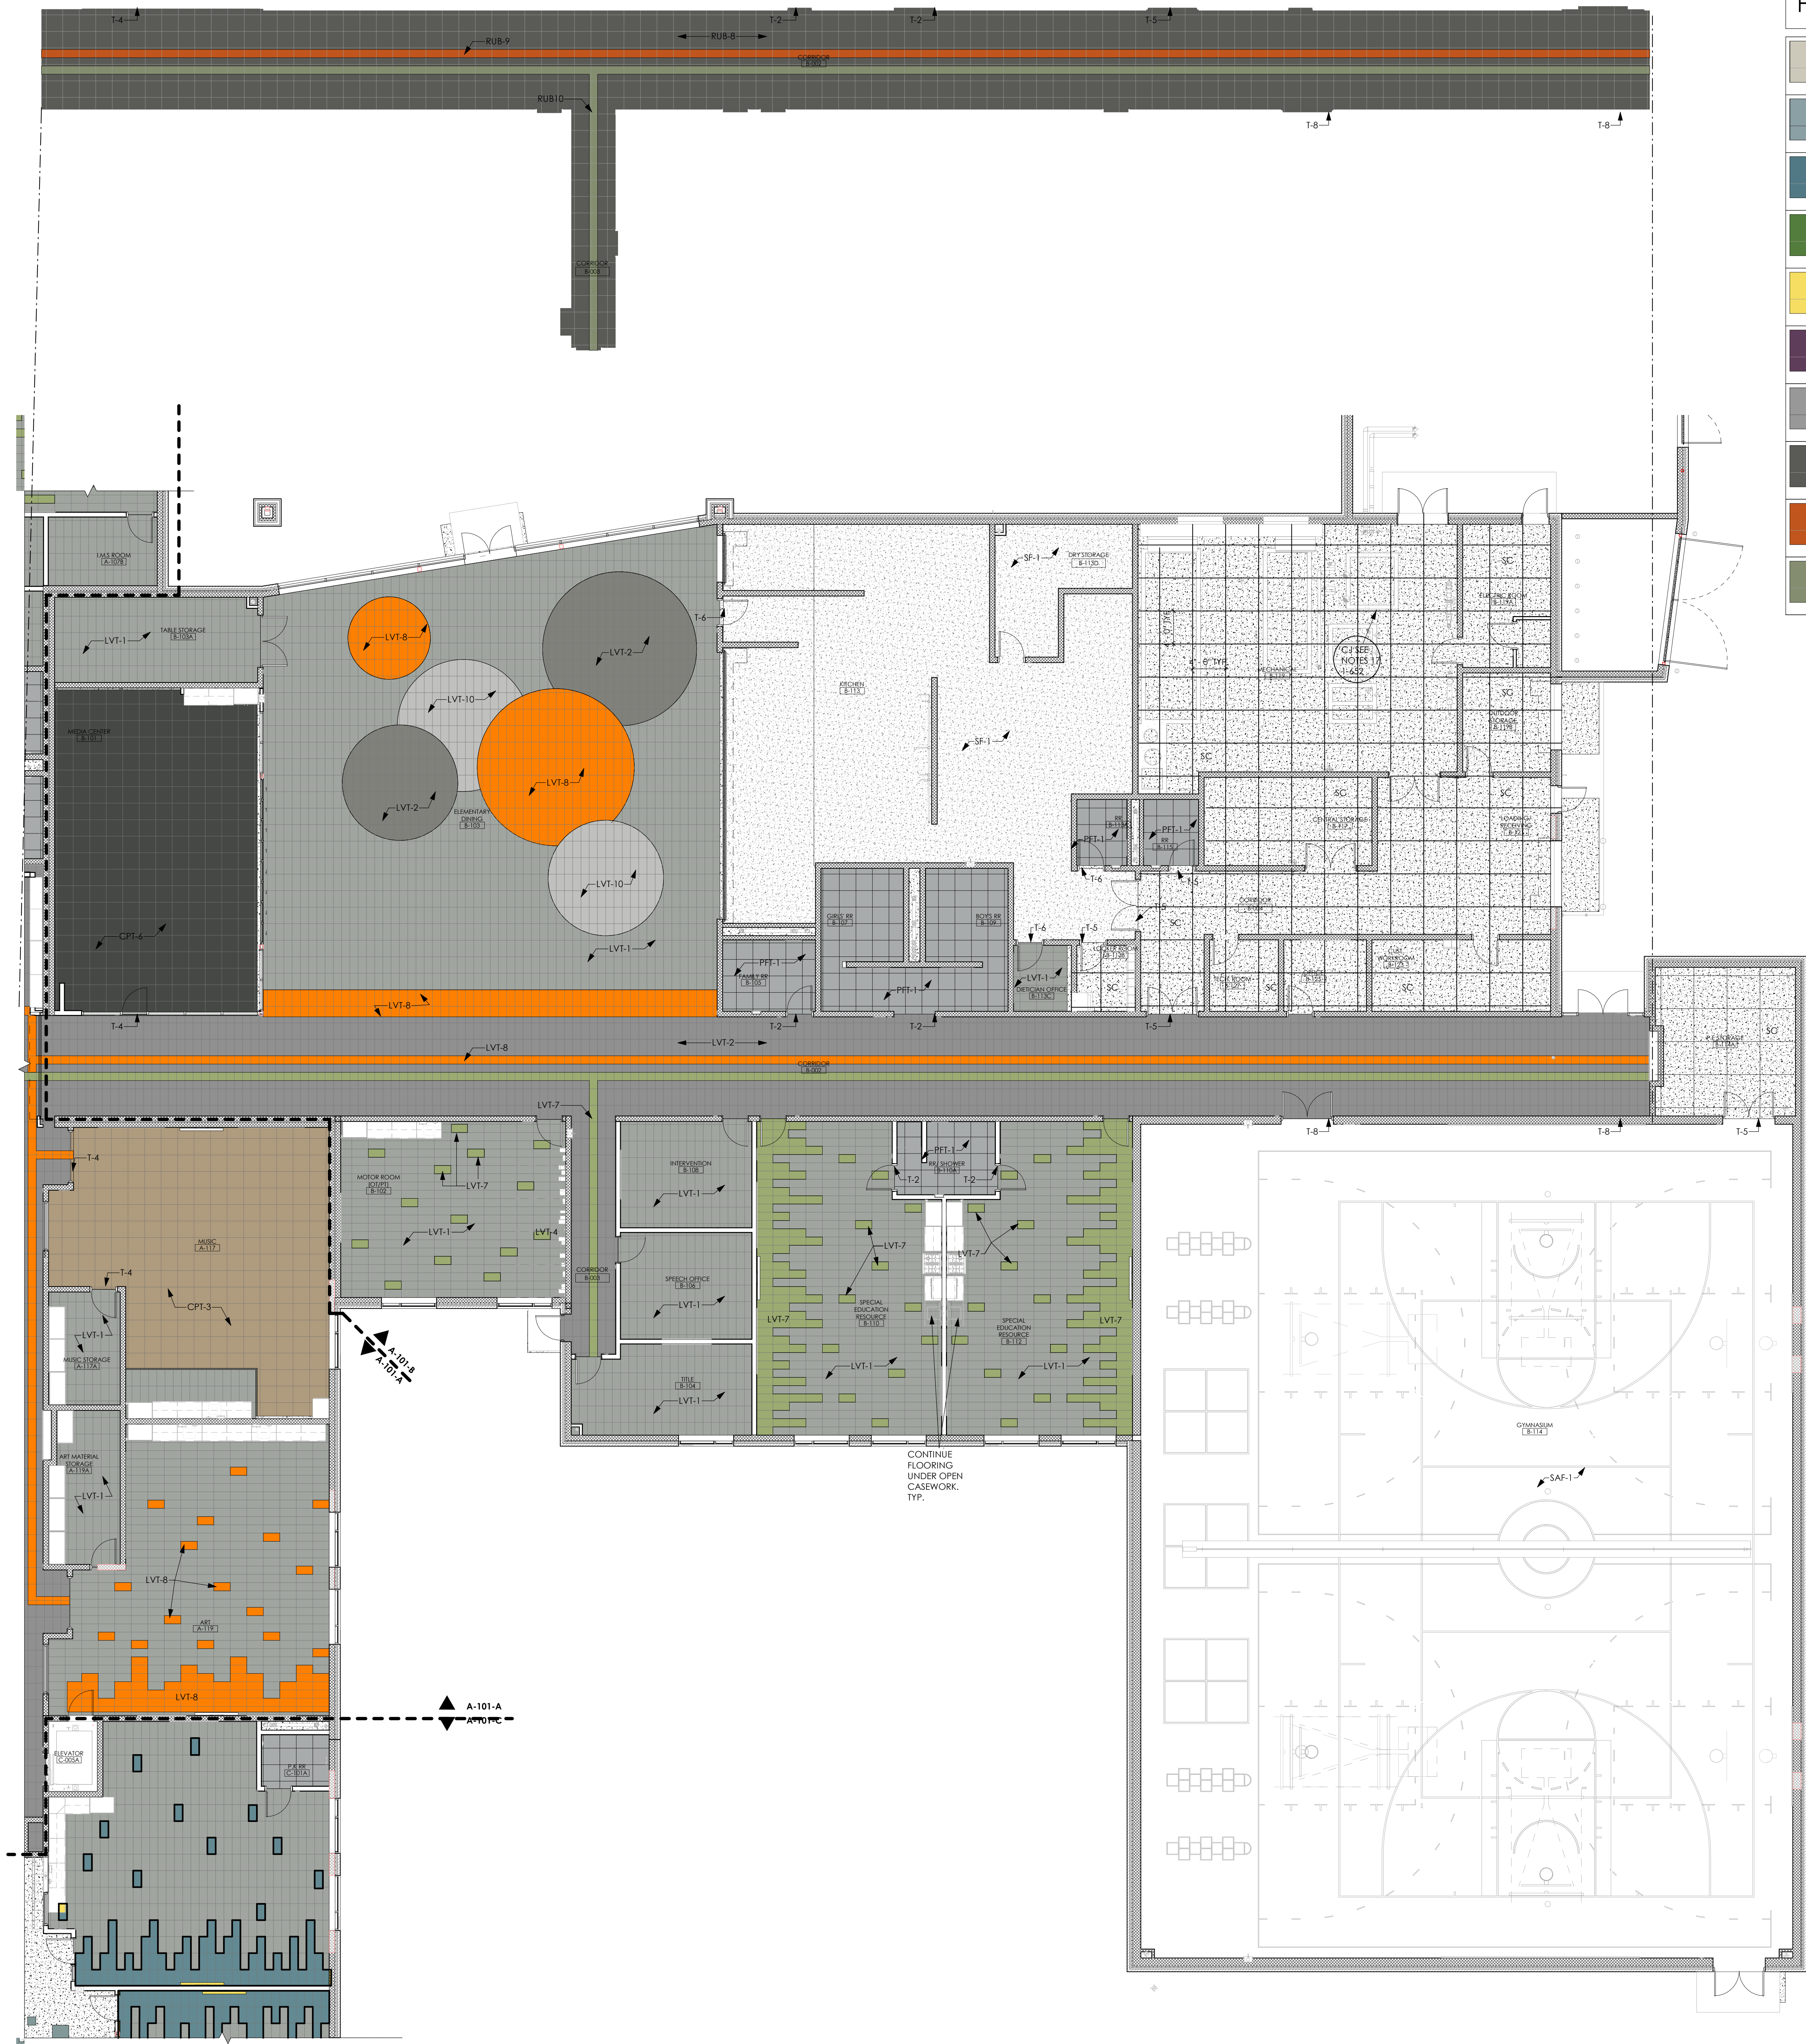

FLOORING LEGEND ALT 1		
	RUB-1	RUBBER TILE
	RUB-2	RUBBER TILE
	RUB-3	RUBBER TILE
	RUB-4	RUBBER TILE
	RUB-5	RUBBER TILE
	RUB-6	RUBBER TILE
	RUB-7	RUBBER TILE
	RUB-8	RUBBER TILE
	RUB-9	RUBBER TILE
	RUB-10	RUBBER TILE

FLOORING LEGEND		
	LVT-1	LUXURY VINYL TILE
	LVT-2	LUXURY VINYL TILE
	LVT-3	LUXURY VINYL TILE
	LVT-4	LUXURY VINYL TILE
	LVT-5	LUXURY VINYL TILE
	LVT-6	LUXURY VINYL TILE
	LVT-7	LUXURY VINYL TILE
	LVT-8	LUXURY VINYL TILE
	LVT-9	LUXURY VINYL TILE
	LVT-10	LUXURY VINYL TILE
	CPT-1	CARPET TILE
	CPT-2	CARPET TILE
	CPT-3	CARPET TILE
	CPT-4	CARPET TILE
	CPT-5	CARPET TILE
	CPT-6	CARPET TILE
	LIN-1	LINOLEUM
	LIN-2	LINOLEUM
	LIN-3	LINOLEUM
	LIN-4	LINOLEUM
	LIN-5	LINOLEUM
	LIN-6	LINOLEUM
	LIN-7	LINOLEUM
	LIN-8	LINOLEUM
	PFT-1	PORCELAIN FLOOR TILE
	CG	STAINLESS STEEL CORNER GUARD

- GENERAL FINISH NOTES
- ALL LVT MUST BE PROVIDED BY SAME MANUFACTURER TO KEEP A CONSISTENT MATERIAL PATTERN
 - ALL LINOLEUM MUST BE PROVIDED BY SAME MANUFACTURER TO KEEP A CONSISTENT MATERIAL PATTERN
 - SEE INTERIOR ELEVATIONS FOR ACCENT WALL LOCATIONS
 - SEE RESTROOM PLANS AND ELEVATIONS FOR WALL TILE PATTERN
 - SEE FINISH PLAN FOR FLOOR PATTERNS AND TRANSITION LOCATIONS
 - ALL EXPOSED SIDES OF WALL TILE TO BE FINISHED WITH 1/4" TRIM, SEE A-452
 - ALL PRODUCTS SHOWN ON MATERIAL SCHEDULE ARE SHOWN AS BASIS OF DESIGN. OTHER MANUFACTURERS THAT MEET SALES REQUIREMENTS MAY BE SUBSTITUTED PENDING ARCHITECT APPROVAL
 - SEE FINISH PLANS FOR SEALED CONCRETE CONTROL JOINTS
 - LINOLEUM SEAMS SHALL BE NET FIT SEAMS IN USE OF HEAT WELDED
 - SHOWER CLEARANCE MUST BE 36" MINIMUM FROM FINISH FACE TO FINISH FACE
 - PLUMBING FIXTURES AND RESTROOM ACCESSORIES MUST MAINTAIN ACCESSIBILITY REQUIREMENTS FROM FINISH DIMENSIONS
 - CONTRACTOR TO PROVIDE BLOCKING BEHIND STUD WALLS WHERE CASEWORK, SHELVING, TECHNOLOGY, RESTROOM ACCESSORIES, ETC. IS MOUNTED
 - WOOD DOOR COLOR TO BE SELECTED BY ARCHITECT FROM MANUFACTURER'S FULL RANGE OF COLORS DURING SHOP DRAWING PHASE
 - HOLLOW METAL DOOR AND FRAME COLOR TO BE PT-1 UNLESS NOTED OTHERWISE ON INTERIOR ELEVATIONS
 - CORNER GUARDS INDICATED ON FINISH PLAN AS 'CG'
 - ALL FLOOR CONTROL JOINTS AS INDICATED ON FINISH PLAN ARE TO BE 1/4" DEPTH OF SLAB THICKNESS. IF JOINT IS GREATER THAN 1/2" DEEP, FILL WITH FOAM BACKER ROD 1/8" WIDER THAN JOINT. FILL ALL JOINTS WITH 100% SOLIDS EPOXY FILLER COLOR MATCHED TO CONCRETE.
 - SEE A-651 FOR FINISH SCHEDULE
 - CONTRACTOR TO PROVIDE WALK OFF MATS AT ALL BUILDING ENTRANCES
 - SEE INTERIOR ELEVATIONS FOR GYPSUM CONTROL JOINT LOCATIONS. SEE A-652 FOR DETAIL.
 - CONTINUE FINISH FLOOR UNDER OPEN CASEWORK, TYP.
 - SEE A-652 FOR DETAILS REGARDING THE FLOORING MATERIAL

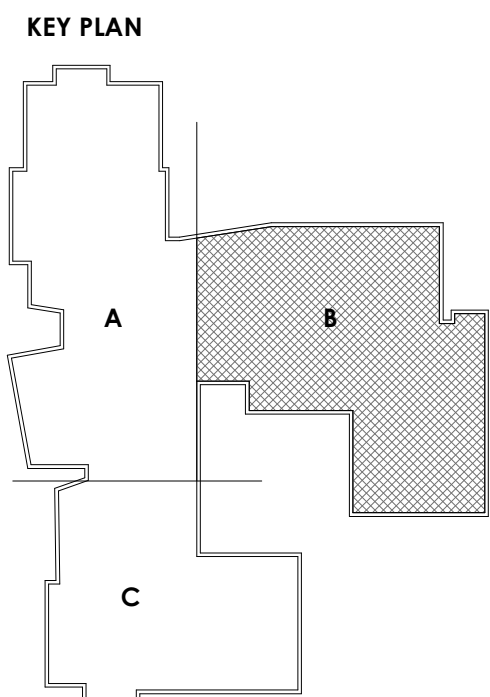

FIRST FLOOR FINISH PLAN - UNIT B
SCALE: 1/16" = 1'-0"

PROJECT NO
2203-2

ARCHITECTURAL VISION GROUP, LTD
PLANNERS
ARCHITECTS
23850 SPERRY DRIVE
CLEVELAND, OHIO 44145

PROFESSIONAL SEAL

STATE OF OHIO
SEAL
1979
EXPIRATION DATE 12/31/2023

MASSILLON CITY SCHOOLS
MASSILLON EAST ELEMENTARY PK-3
1 PAULE BROWN DRIVE SE, MASSILLON, OHIO 44646
MASSILLON CITY SCHOOL DISTRICT MASSILLON, OHIO

PROJECT NO	2203-2
DRAWN BY	Author
CHECKED BY	Checker
DATE	

MARK	DATE	DESCRIPTION
ISSUED AS		

PROJECT NO 2203-2
DRAWN BY Author
CHECKED BY Checker
DATE

FIRST FLOOR FINISH PLAN - UNIT B

SCALE: As indicated
SHEET NO
A-940-B