



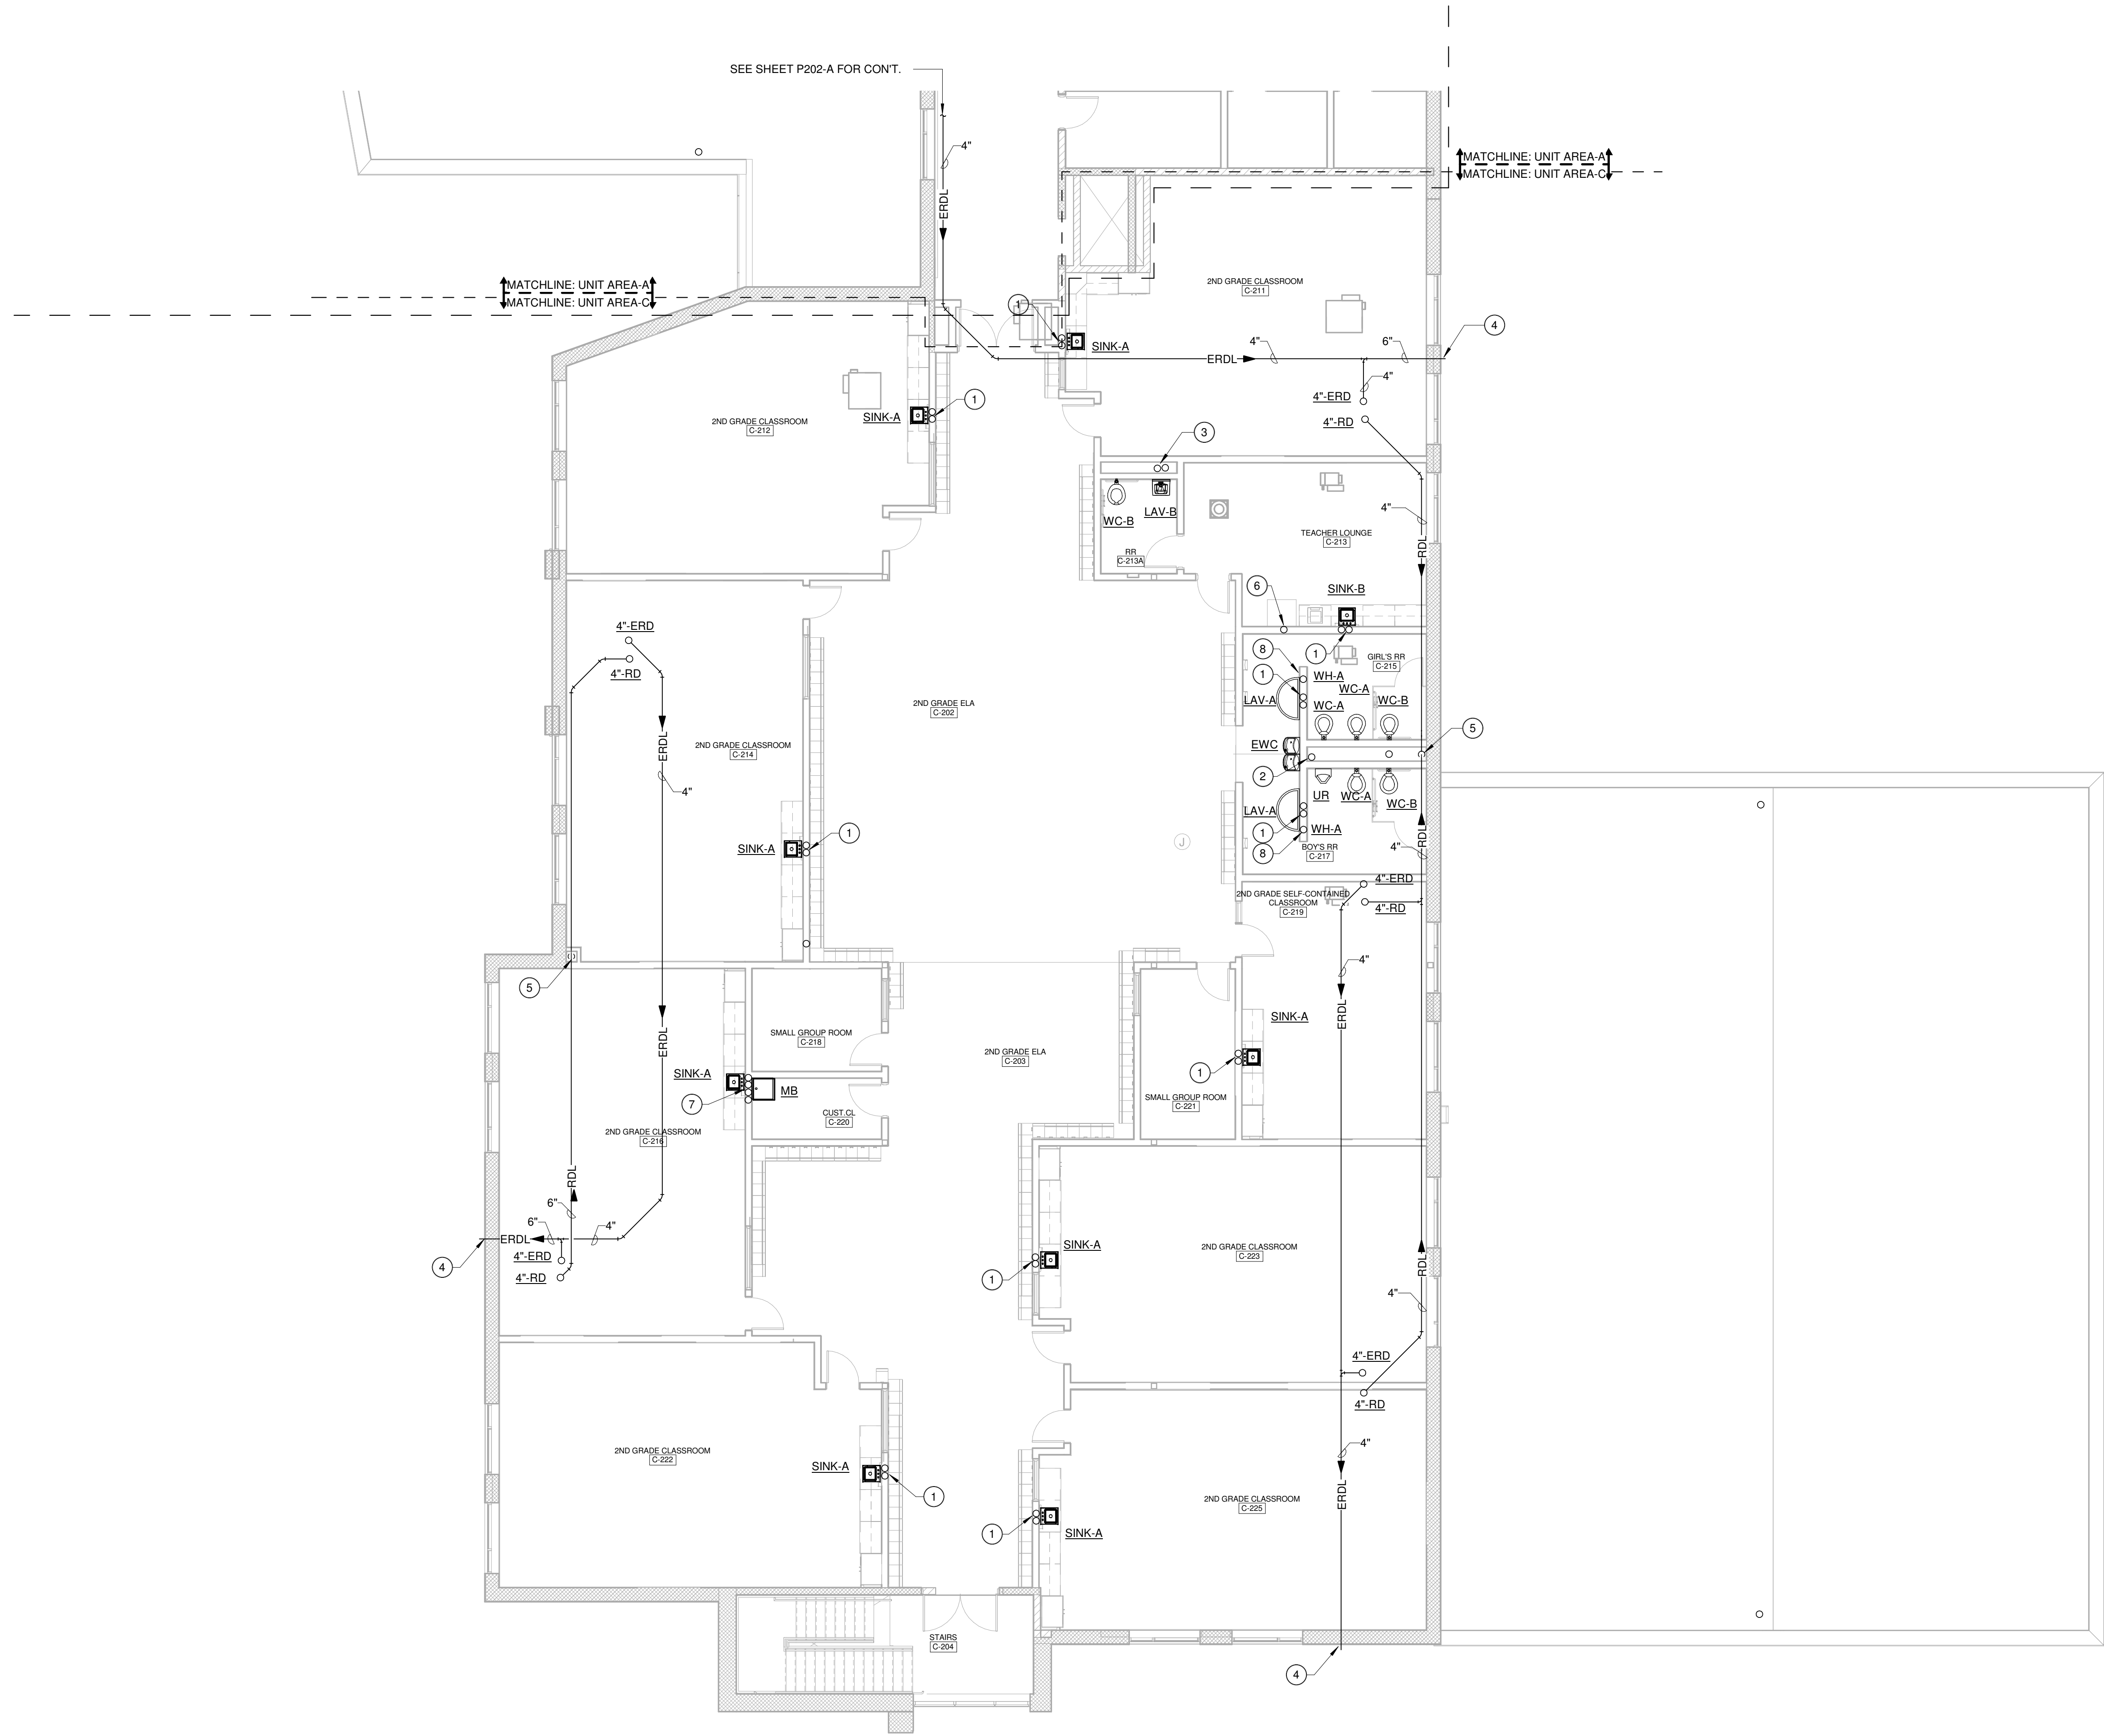

SECOND FLOOR PLAN - PLUMBING - AREA - C
SCALE: 1/8" = 1'-0"

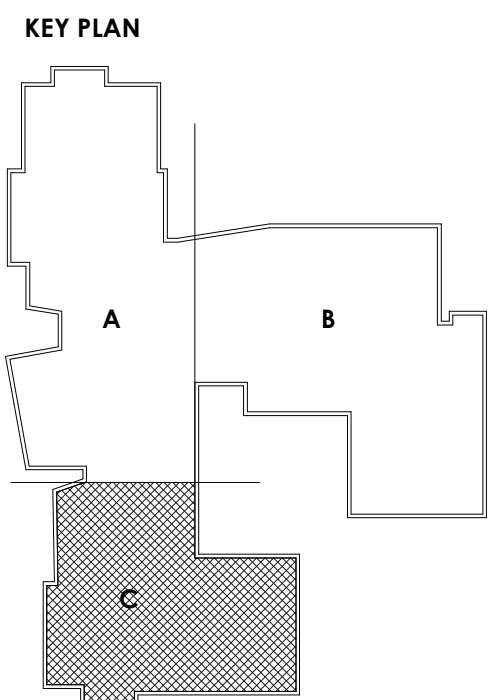

- CODED NOTES: SANITARY**
- 1/2" CW AND HW LINE FROM BELOW FOR CONNECTION TO FIXTURE. SEE SHEET P201-C FOR CONT.
 - 2" CW LINE FROM BELOW UP INTO CHASE AND HEADER FULL SIZE FOR CONNECTION TO FIXTURES WITH J.R. SMITH 5020 CW WATER HAMMER ARRESTER. ROUTE 1/2" CW LINE FROM CHASE TO EWC.
 - 1 1/4" CW AND 1/2" HW LINE FROM BELOW UP INTO CHASE AND HEADER FULL SIZE FOR CONNECTION TO FIXTURES WITH J.R. SMITH 5005 CW AND HW WATER HAMMER ARRESTER.
 - EMERGENCY ROOF DRAIN LEADER THRU WALL ABOVE CEILING WITH J.R. SMITH (WATTS OR ZURN) NO. 1770 DOWNSPOUT NOZZLE.
 - 6" RDL DOWN. SEE SHEET P201-C FOR CONT.
 - 1/2" CW LINE FROM BELOW TO WALL BOX AND SHUT OFF VALVE AT 4'-0" A.F.F. FOR CONNECTION TO REFRIGERATOR.
 - 3/4" CW AND HW LINE FROM BELOW. ROUTE 1/2" CW AND HW TO SINK AND MOP BASH. SEE SHEET P201-C FOR CONT.
 - 3/4" CW LINE FROM BELOW FOR CONNECTION TO WH @ 2'-0" A.F.F. SEE SHEET P201-C FOR CONT.

PROJECT NO
2203-2

ARCHITECTURAL VISION GROUP, LTD
PLANNERS
ARCHITECTS
23850 SPERRY DRIVE
CLEVELAND, OHIO 44145

MASSILLON CITY SCHOOLS
MASSILLON EAST ELEMENTARY PK-3
1 PAULE BROWN DRIVE SE, MASSILLON, OHIO 44646
MASSILLON CITY SCHOOL DISTRICT MASSILLON, OHIO

DATE	BY	DESCRIPTION
07/12/23	WMS	ISSUED FOR PERMITS
07/12/23	WMS	ISSUED AS

PROJECT NO 2203-2
DRAWN BY ADO
CHECKED BY WMS
DATE 07/12/23

SECOND FLOOR
PLAN -
PLUMBING -
AREA - C
SCALE: 1/8" = 1'-0"
SHEET NO
P202-C