


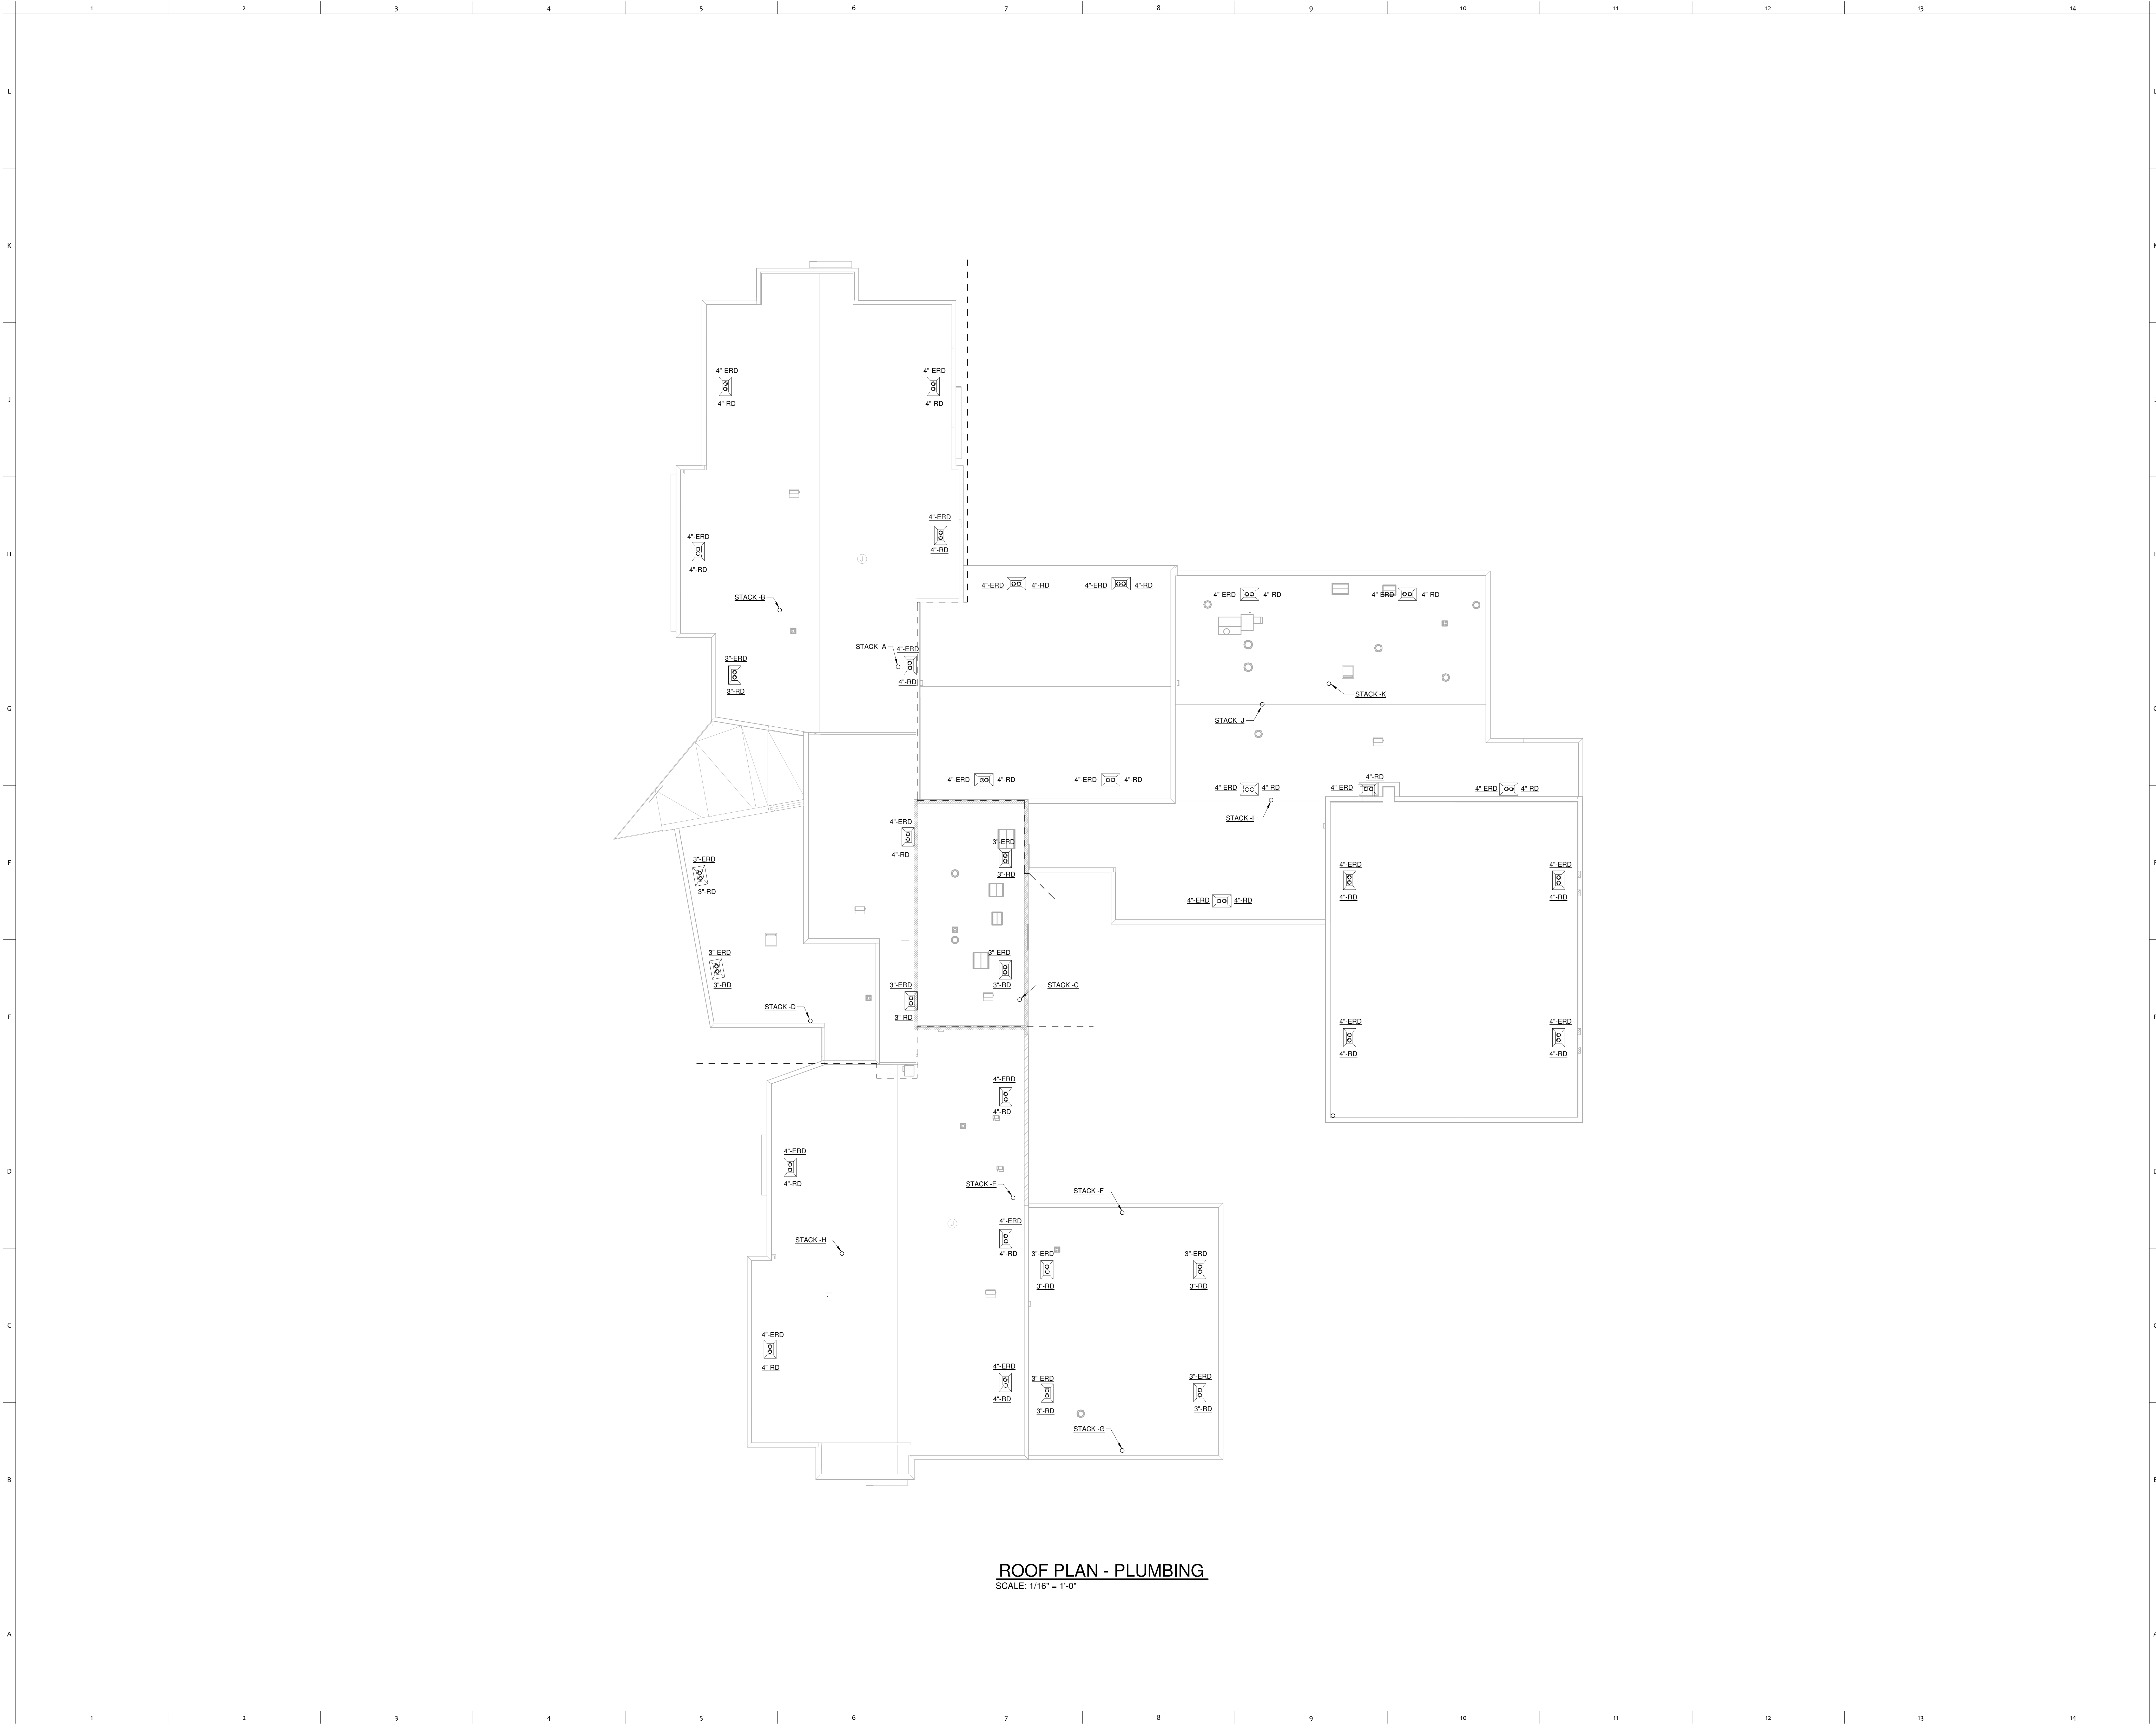

ROOF PLAN - PLUMBING
SCALE: 1/16" = 1'-0"

PROJECT NO
2203-2

ARCHITECTURAL VISION GROUP, LTD
ARCHITECTS
23850 SPERRY DRIVE
CLEVELAND, OHIO 44145

PLANNERS

CONSULTING ENGINEER
J.M. VERDOSTKO, INC.
1700 BALDWIN ROAD
COLUMBUS, OHIO 43260

MASSILLON CITY SCHOOLS
MASSILLON EAST ELEMENTARY PK-3
1 PAULE BROWN DRIVE SE, MASSILLON, OHIO 44646
MASSILLON CITY SCHOOL DISTRICT MASSILLON, OHIO

NO.	DATE	ISSUED FOR	DESCRIPTION
07/12/23		ISSUED FOR PERMITS SET	

PROJECT NO 2203-2
DRAWN BY ADO
CHECKED BY WMS
DATE 07/12/23

ROOF PLAN - PLUMBING

SCALE: 1/16" = 1'-0"
SHEET NO
P501