


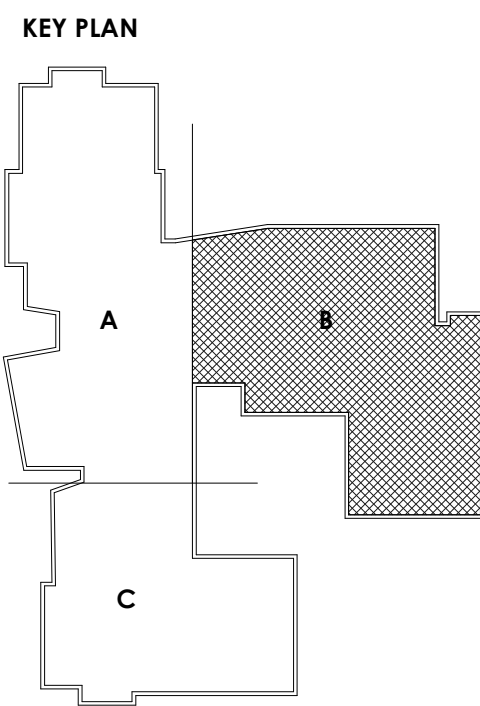

- CODED NOTES: FIRE PROTECTION**
- 1 SITE WATER LINE BY SITE UTILITIES CONTRACTOR.
 - 2 FINAL CONNECTION TO SITE WATER LINE BY FIRE SPRINKLER CONTRACTOR.
 - 3 INCOMING FIRE SERVICE WITH 6" BFP. SEE DETAIL ON SHEET FP000.
 - 4 4" FIRE LINE DOWN AND ROUTED TO FDC. SEE SHEET FP000 FOR DETAILS AND SEE CIVIL PLANS FOR LOCATION.
 - 5 6" FIRE LINE UP.



FIRST FLOOR PLAN - FIRE PROTECTION - AREA - B
SCALE: 1/8" = 1'-0"

PROJECT NO
2203-2

ARCHITECTURAL VISION GROUP, LTD
ARCHITECTS
23850 SPERRY DRIVE
CLEVELAND, OHIO 44145

MASSILLON CITY SCHOOLS
MASSILLON EAST ELEMENTARY PK-3
1 PAULE BROWN DRIVE SE, MASSILLON, OHIO 44646
MASSILLON CITY SCHOOL DISTRICT MASSILLON, OHIO

DATE	ISSUED AS	DESCRIPTION
07/12/23	ISSUED AS	ISSUED AS

PROJECT NO 2203-2
DRAWN BY ADO
CHECKED BY WMS
DATE 07/12/23

FIRST FLOOR
PLAN - FIRE
PROTECTION -
AREA - B

SCALE: 1/8" = 1'-0"
SHEET NO
FP101-B