


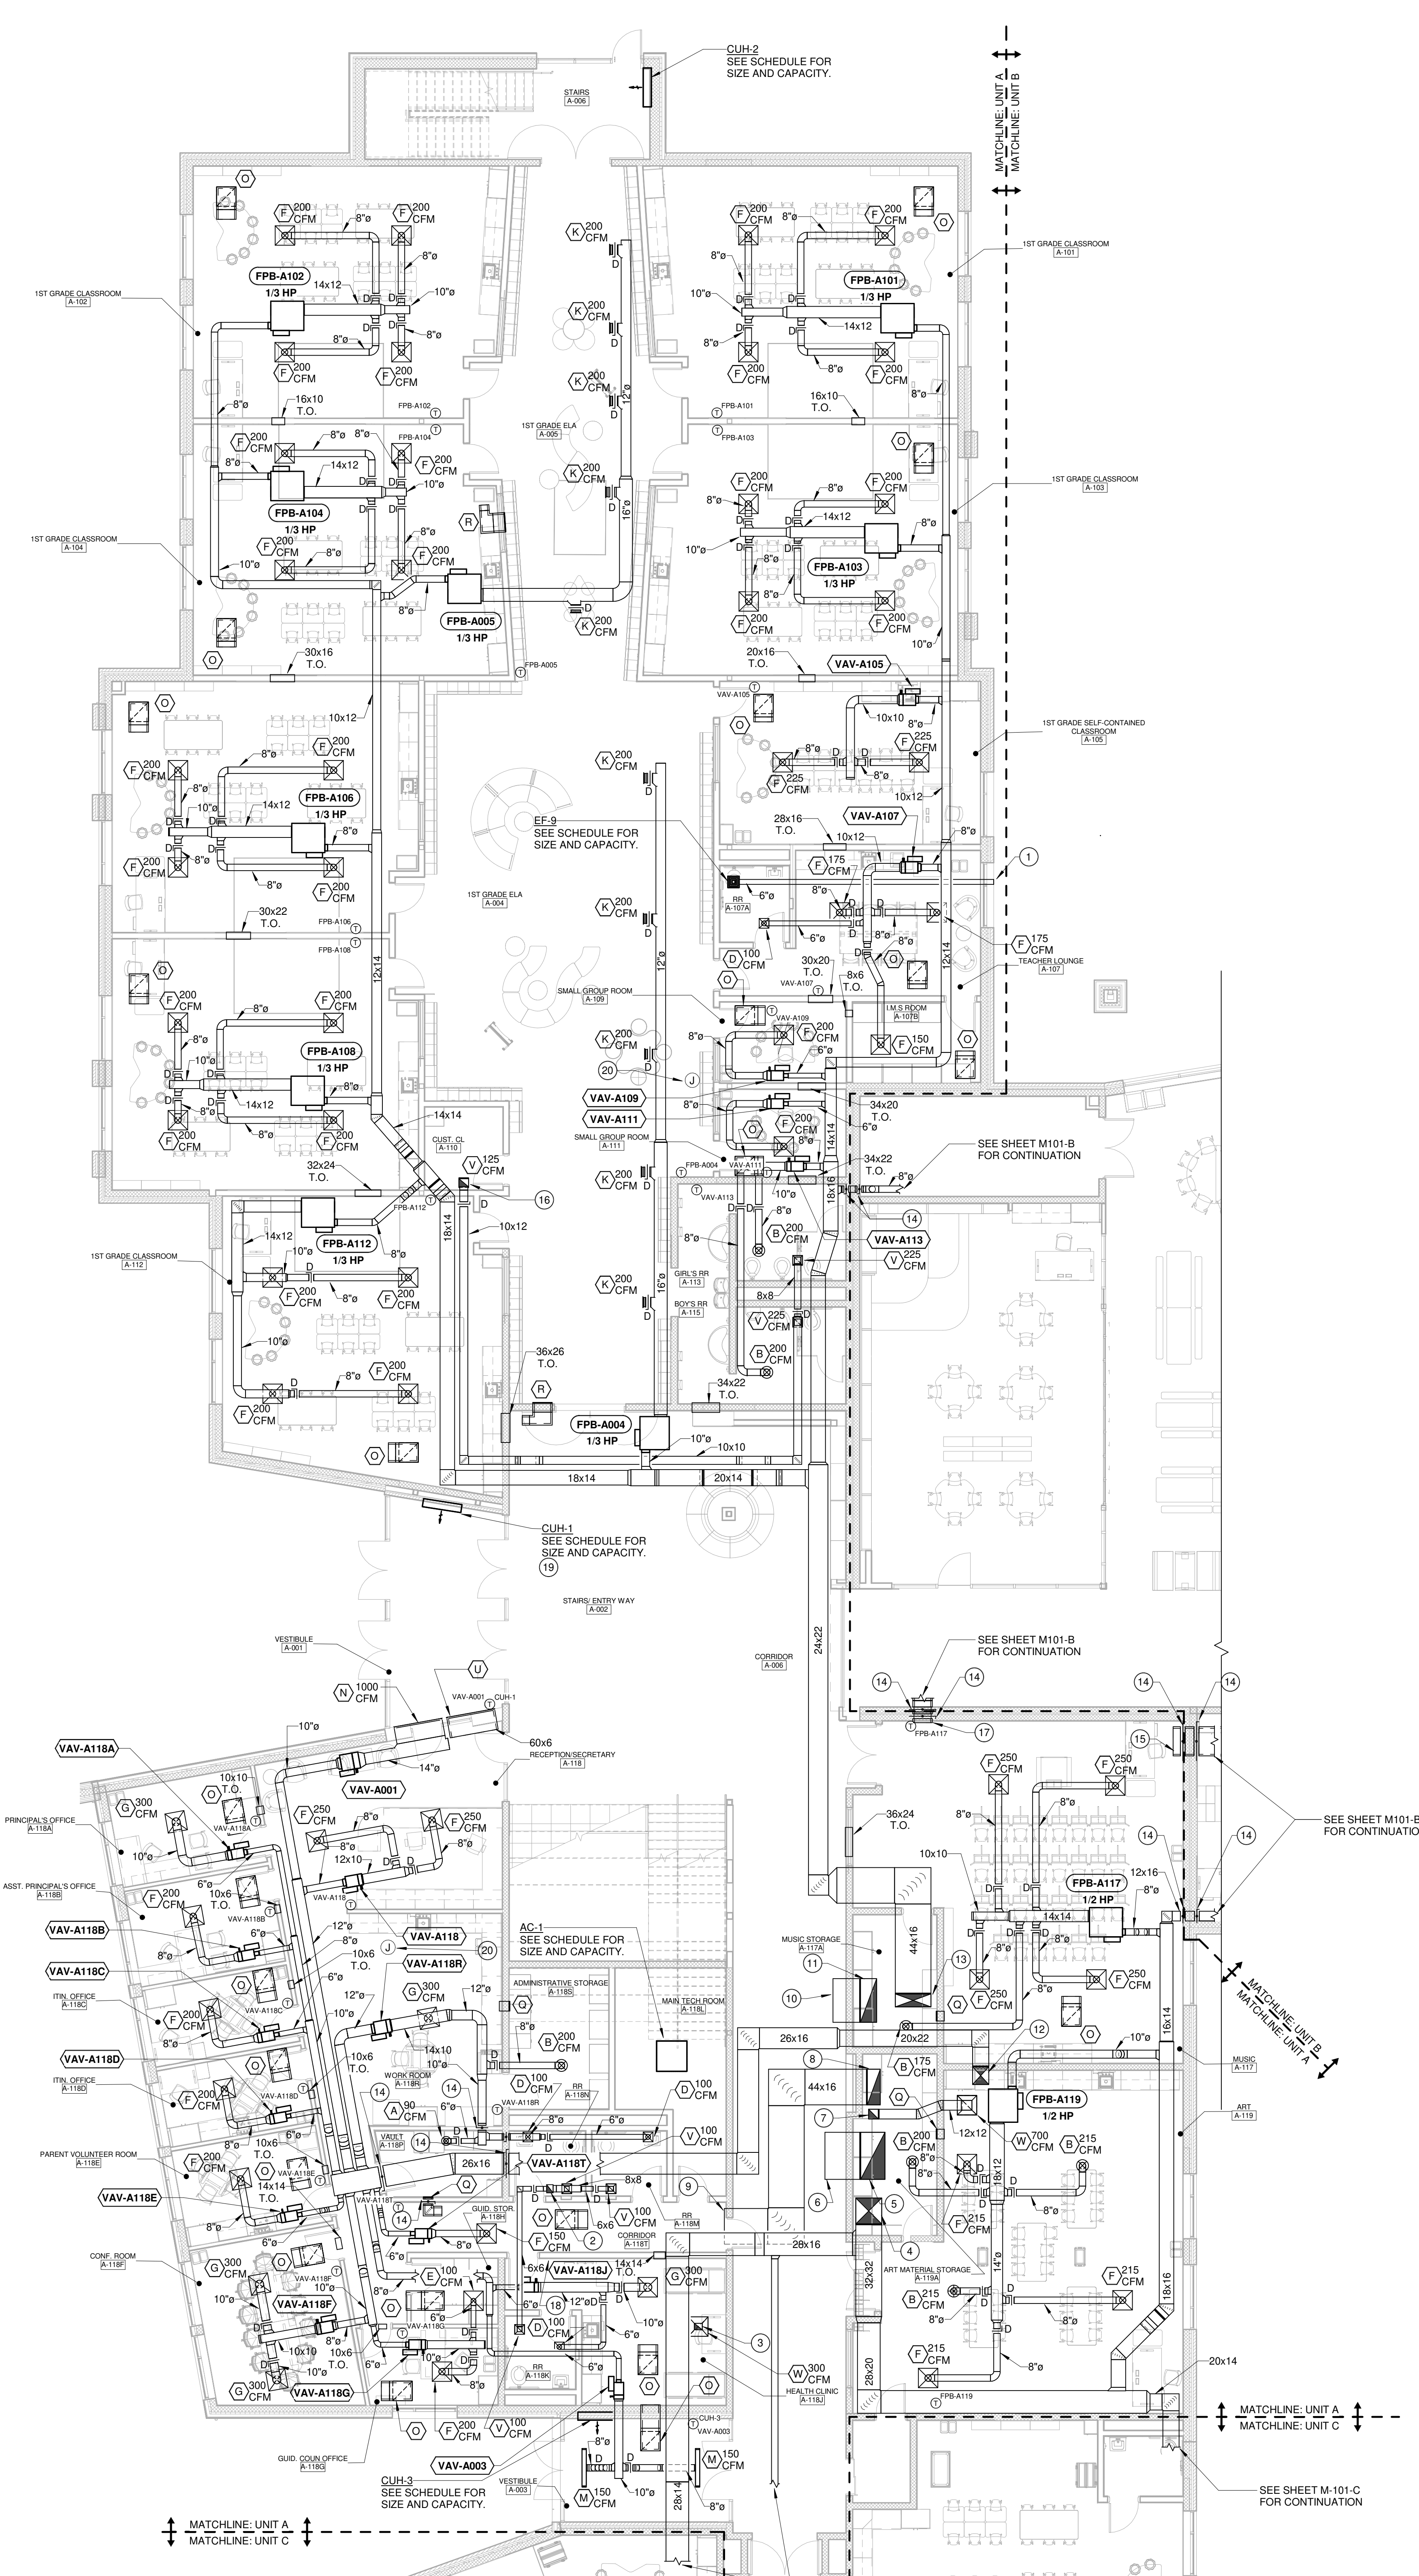


FIRST FLOOR PLAN - HVAC - UNIT A
SCALE: 1/8" = 1'-0"

CODED NOTES:



- 6" E.A. DUCT FROM EF-3. EXTEND AND TERMINATE WITH BRICK VENT.
- 10x8 E.A. DUCT UP THROUGH ROOF. TRANSITION FOR CONNECTION TO EF-2 ON ROOF.
- 10x8 E.A. DUCT UP THROUGH ROOF. TRANSITION FOR CONNECTION TO EF-3 ON ROOF.
- 32x32 S.A. DUCT DOWN FROM FLOOR ABOVE. SEE SHEET M201-A FOR CONTINUATION.
- 58x30 R.A. DUCT UP TO FLOOR ABOVE. SEE SHEET M201-A FOR CONTINUATION.
- 58x30 R.A. DUCT UP TO FLOOR ABOVE. COVER OPENING WITH 1" x 1" WIRE SCREEN.
- 12x12 E.A. DUCT UP TO FLOOR ABOVE. SEE SHEET M201-A FOR CONTINUATION.
- 44x16 R.A. DUCT UP TO FLOOR ABOVE. SEE SHEET M201-A FOR CONTINUATION.
- 44x16 R.A. DUCT UP TO FLOOR ABOVE. COVER OPENING WITH 1" x 1" WIRE SCREEN.
- 54x20 R.A. DUCT UP TO FLOOR ABOVE. COVER OPENING WITH 1" x 1" WIRE SCREEN.
- 54x20 R.A. DUCT UP TO FLOOR ABOVE. SEE SHEET M201-A FOR CONTINUATION.
- 20x22 S.A. DUCT DOWN FROM FLOOR ABOVE. SEE SHEET M201-A FOR CONTINUATION.
- 44x18 S.A. DUCT DOWN FROM FLOOR ABOVE. SEE SHEET M201-A FOR CONTINUATION.
- INSTALL 1.5 HOUR FIRE DAMPER WITH ACCESS DOOR IN DUCT AT WALL PENETRATION.
- 36x12 R.A. DUCT OPENING ABOVE CEILING. COVER OPENING WITH 1" x 1" WIRE SCREEN.
- TRANSITION FROM CONNECTION TO E.G. IN SPACE TO 12X12 EA UP TO FLOOR ABOVE.
- 24x12 RA OPENING ABOVE CEILING. COVER OPENING WITH 1"x1" WIRE SCREEN.
- SPRING WOUND TIMER INTERLOCKED WITH EF-3.
- CUH TO BE INSTALLED IN CASEWORK WITH RECESSED INSTALLATION KIT.
- JUNCTION BOX WITH 120V CIRCUIT WIRING FOR USE BY TEMPERATURE CONTROLS CONTRACTOR.

KEY PLAN

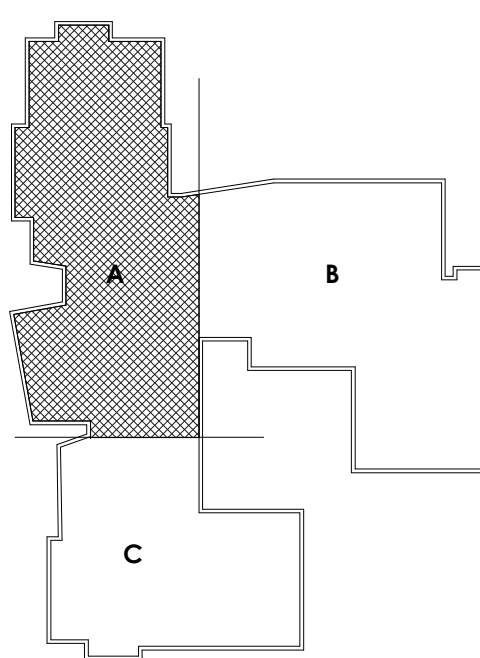

PROJECT NO
2203-2

ARCHITECTURAL VISION GROUP, LTD
PLANNERS
ARCHITECTS
23850 SPERRY DRIVE
CLEVELAND, OHIO 44145

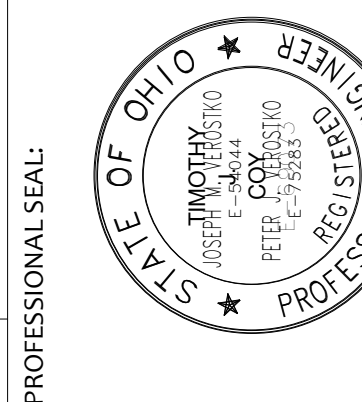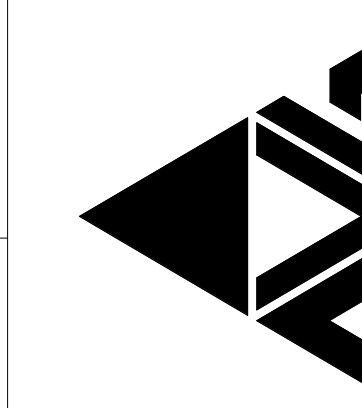

MASSILLON CITY SCHOOLS
MASSILLON EAST ELEMENTARY PK-3
1 PAULE BROWN DRIVE SE, MASSILLON, OHIO 44646
MASSILLON CITY SCHOOL DISTRICT MASSILLON, OHIO

NO.	DATE	DESCRIPTION
1	07/12/23	ISSUED FOR PERMITS
2	07/12/23	ISSUED FOR PERMITS
3	07/12/23	ISSUED FOR PERMITS
4	07/12/23	ISSUED FOR PERMITS
5	07/12/23	ISSUED FOR PERMITS
6	07/12/23	ISSUED FOR PERMITS
7	07/12/23	ISSUED FOR PERMITS
8	07/12/23	ISSUED FOR PERMITS
9	07/12/23	ISSUED FOR PERMITS
10	07/12/23	ISSUED FOR PERMITS
11	07/12/23	ISSUED FOR PERMITS
12	07/12/23	ISSUED FOR PERMITS
13	07/12/23	ISSUED FOR PERMITS
14	07/12/23	ISSUED FOR PERMITS
15	07/12/23	ISSUED FOR PERMITS
16	07/12/23	ISSUED FOR PERMITS
17	07/12/23	ISSUED FOR PERMITS
18	07/12/23	ISSUED FOR PERMITS
19	07/12/23	ISSUED FOR PERMITS
20	07/12/23	ISSUED FOR PERMITS

PROJECT NO 2203-2
DRAWN BY PH
CHECKED BY ARB
DATE 07/12/23

FIRST FLOOR
PLAN - HVAC -
UNIT A

SCALE: 1/8" = 1'-0"
SHEET NO
M-101-A