



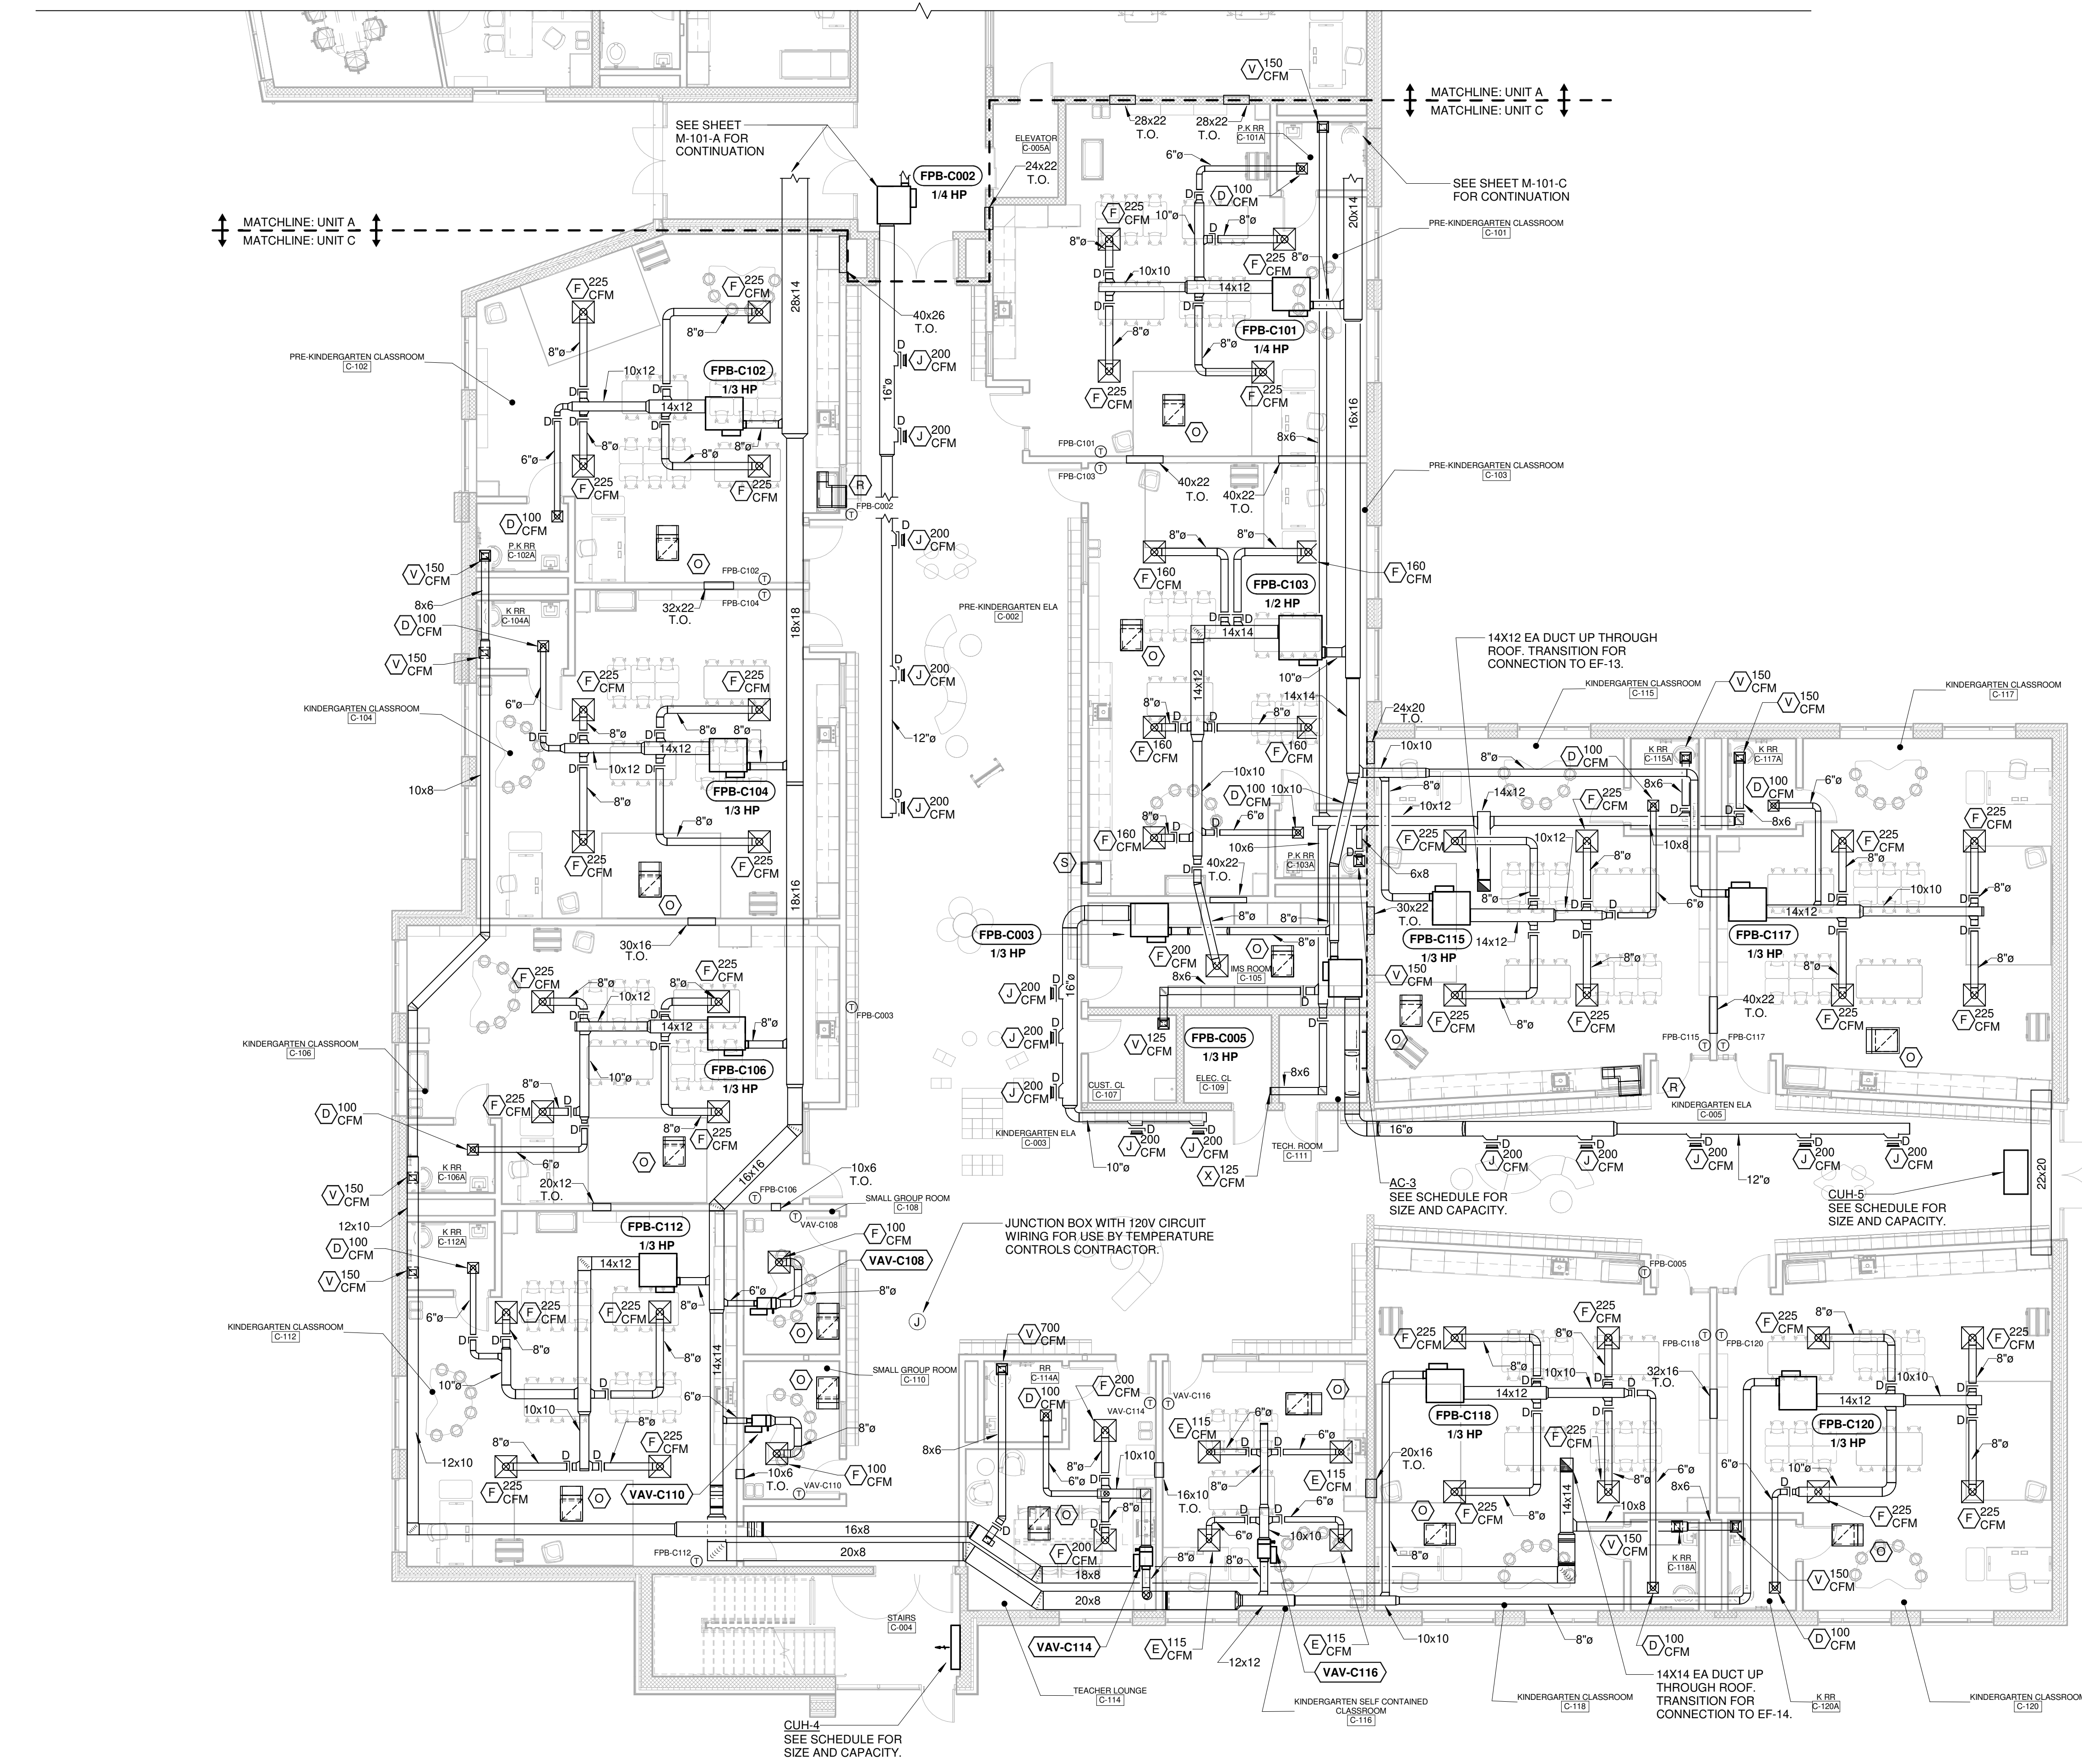

FIRST FLOOR PLAN - HVAC - UNIT C
SCALE: 1/8" = 1'-0"

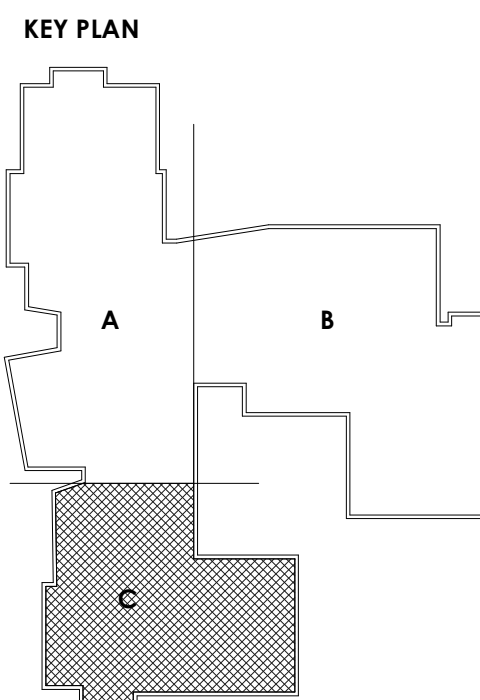

PROJECT NO
2203-2

ARCHITECTURAL VISION GROUP, LTD
PLANNERS
ARCHITECTS
23850 SPERRY DRIVE
CLEVELAND, OHIO 44145

PROFESSIONAL SEAL

STATE OF OHIO
JAMES VEROSTKIN, INC.
JAMES VEROSTKIN, INC.
REGISTERED PROFESSIONAL
MECHANICAL ENGINEER
NO. 10854
EXPIRATION DATE 12/31/2025

MASSILLON CITY SCHOOLS

MASSILLON EAST ELEMENTARY PK-3
1 PAULE BROWN DRIVE SE, MASSILLON, OHIO 44846
MASSILLON CITY SCHOOL DISTRICT MASSILLON, OHIO

NO.	DATE	ISSUED AS
1	07/12/23	ISSUED AS

PROJECT NO 2203-2
DRAWN BY PH
CHECKED BY ARB
DATE 07/12/23

FIRST FLOOR
PLAN - HVAC -
UNIT C
SCALE: 1/8" = 1'-0"
SHEET NO
M-101-C