

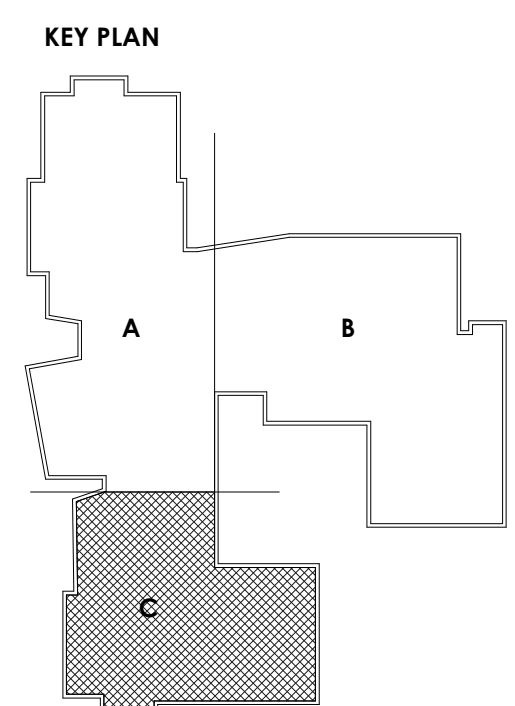
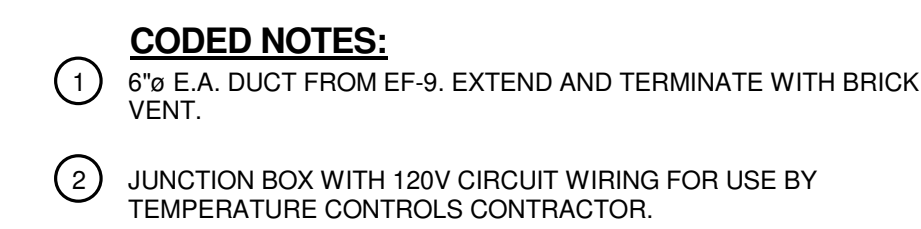
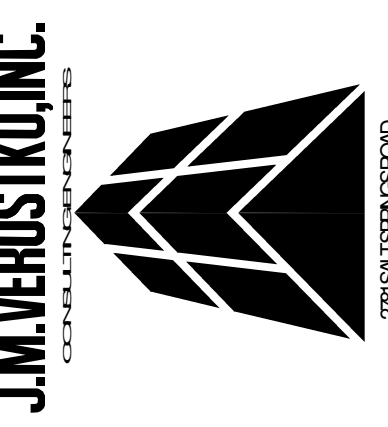


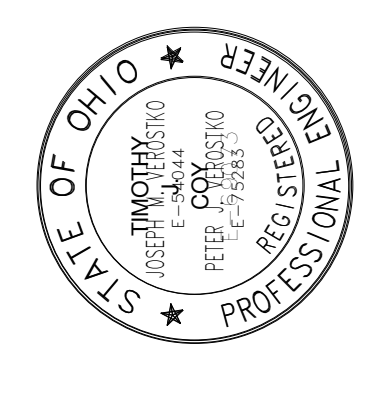

SECOND FLOOR PLAN - HVAC - UNIT C
SCALE: 1/8" = 1'-0"

ARCHITECTS • PLANNERS
23850 SPERRY DRIVE
CLEVELAND, OHIO 44145

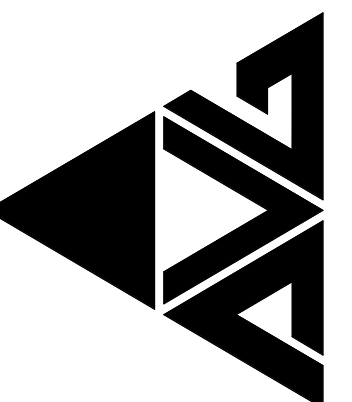

MASSILLON CITY SCHOOLS

MASSILLON EAST ELEMENTARY PK-3

1 PAUL E BROWN DRIVE SE, MASSILLON, OHIO 44646

MASSILLON CITY SCHOOL DISTRICT MASSILLON, OHIO

[illegible]

PROJECT NO	2203-2
AWN BY	PH
CHECKED BY	ARB
DATE	07/12/23

SECOND FLOOR
PLAN - HVAC -
UNIT C

SCALE: 1/8" = 1'-0"

SHEET NO
M-102-C