





FIRST FLOOR PLAN - HVAC PIPING - UNIT A
SCALE: 1/8" = 1'-0"

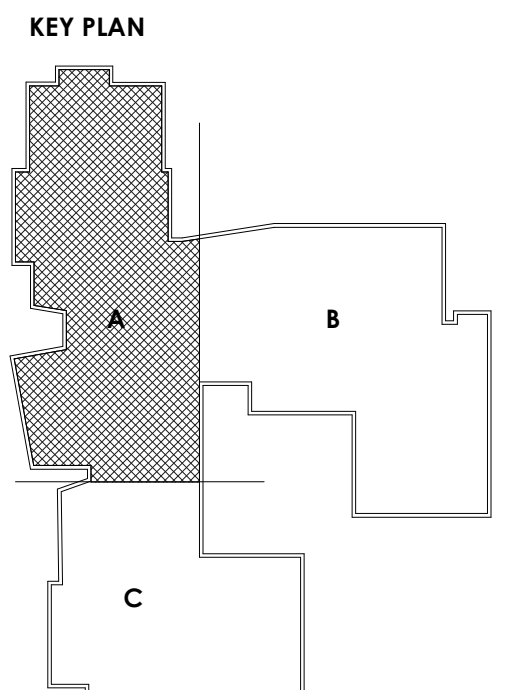


PROJECT NO
2203-2

ARCHITECTURAL VISION GROUP, LTD
ARCHITECTS
23850 SPERRY DRIVE
CLEVELAND, OHIO 44145

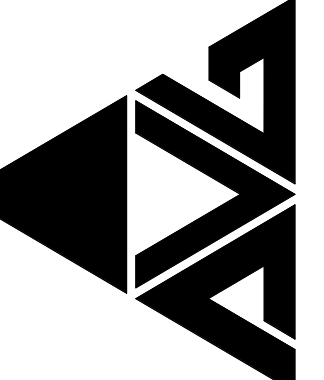



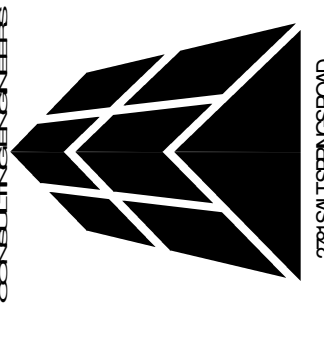

MASSILLON CITY SCHOOLS
MASSILLON EAST ELEMENTARY PK-3
1 PAULE BROWN DRIVE SE, MASSILLON, OHIO 44646
MASSILLON CITY SCHOOL DISTRICT MASSILLON, OHIO

DATE	DESCRIPTION
07/12/23	ISSUED AS

PROJECT NO
2203-2

DRAWN BY
PM

CHECKED BY
ARB

DATE
07/12/23

FIRST FLOOR
PLAN - HVAC
PIPING - UNIT A

SCALE: 1/8" = 1'-0"

SHEET NO
M-201-A