
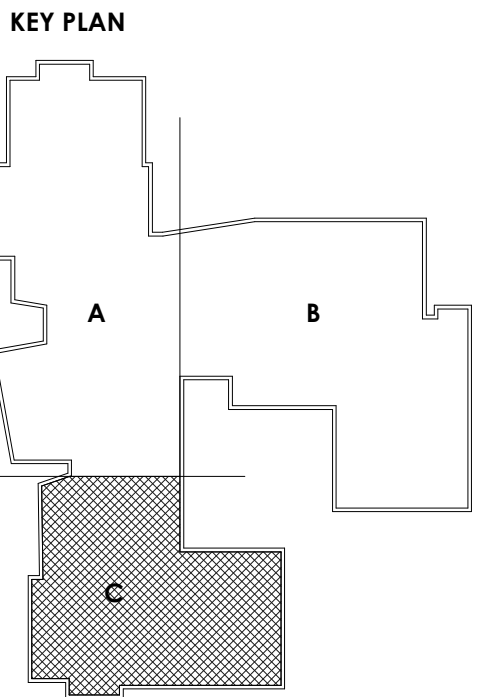


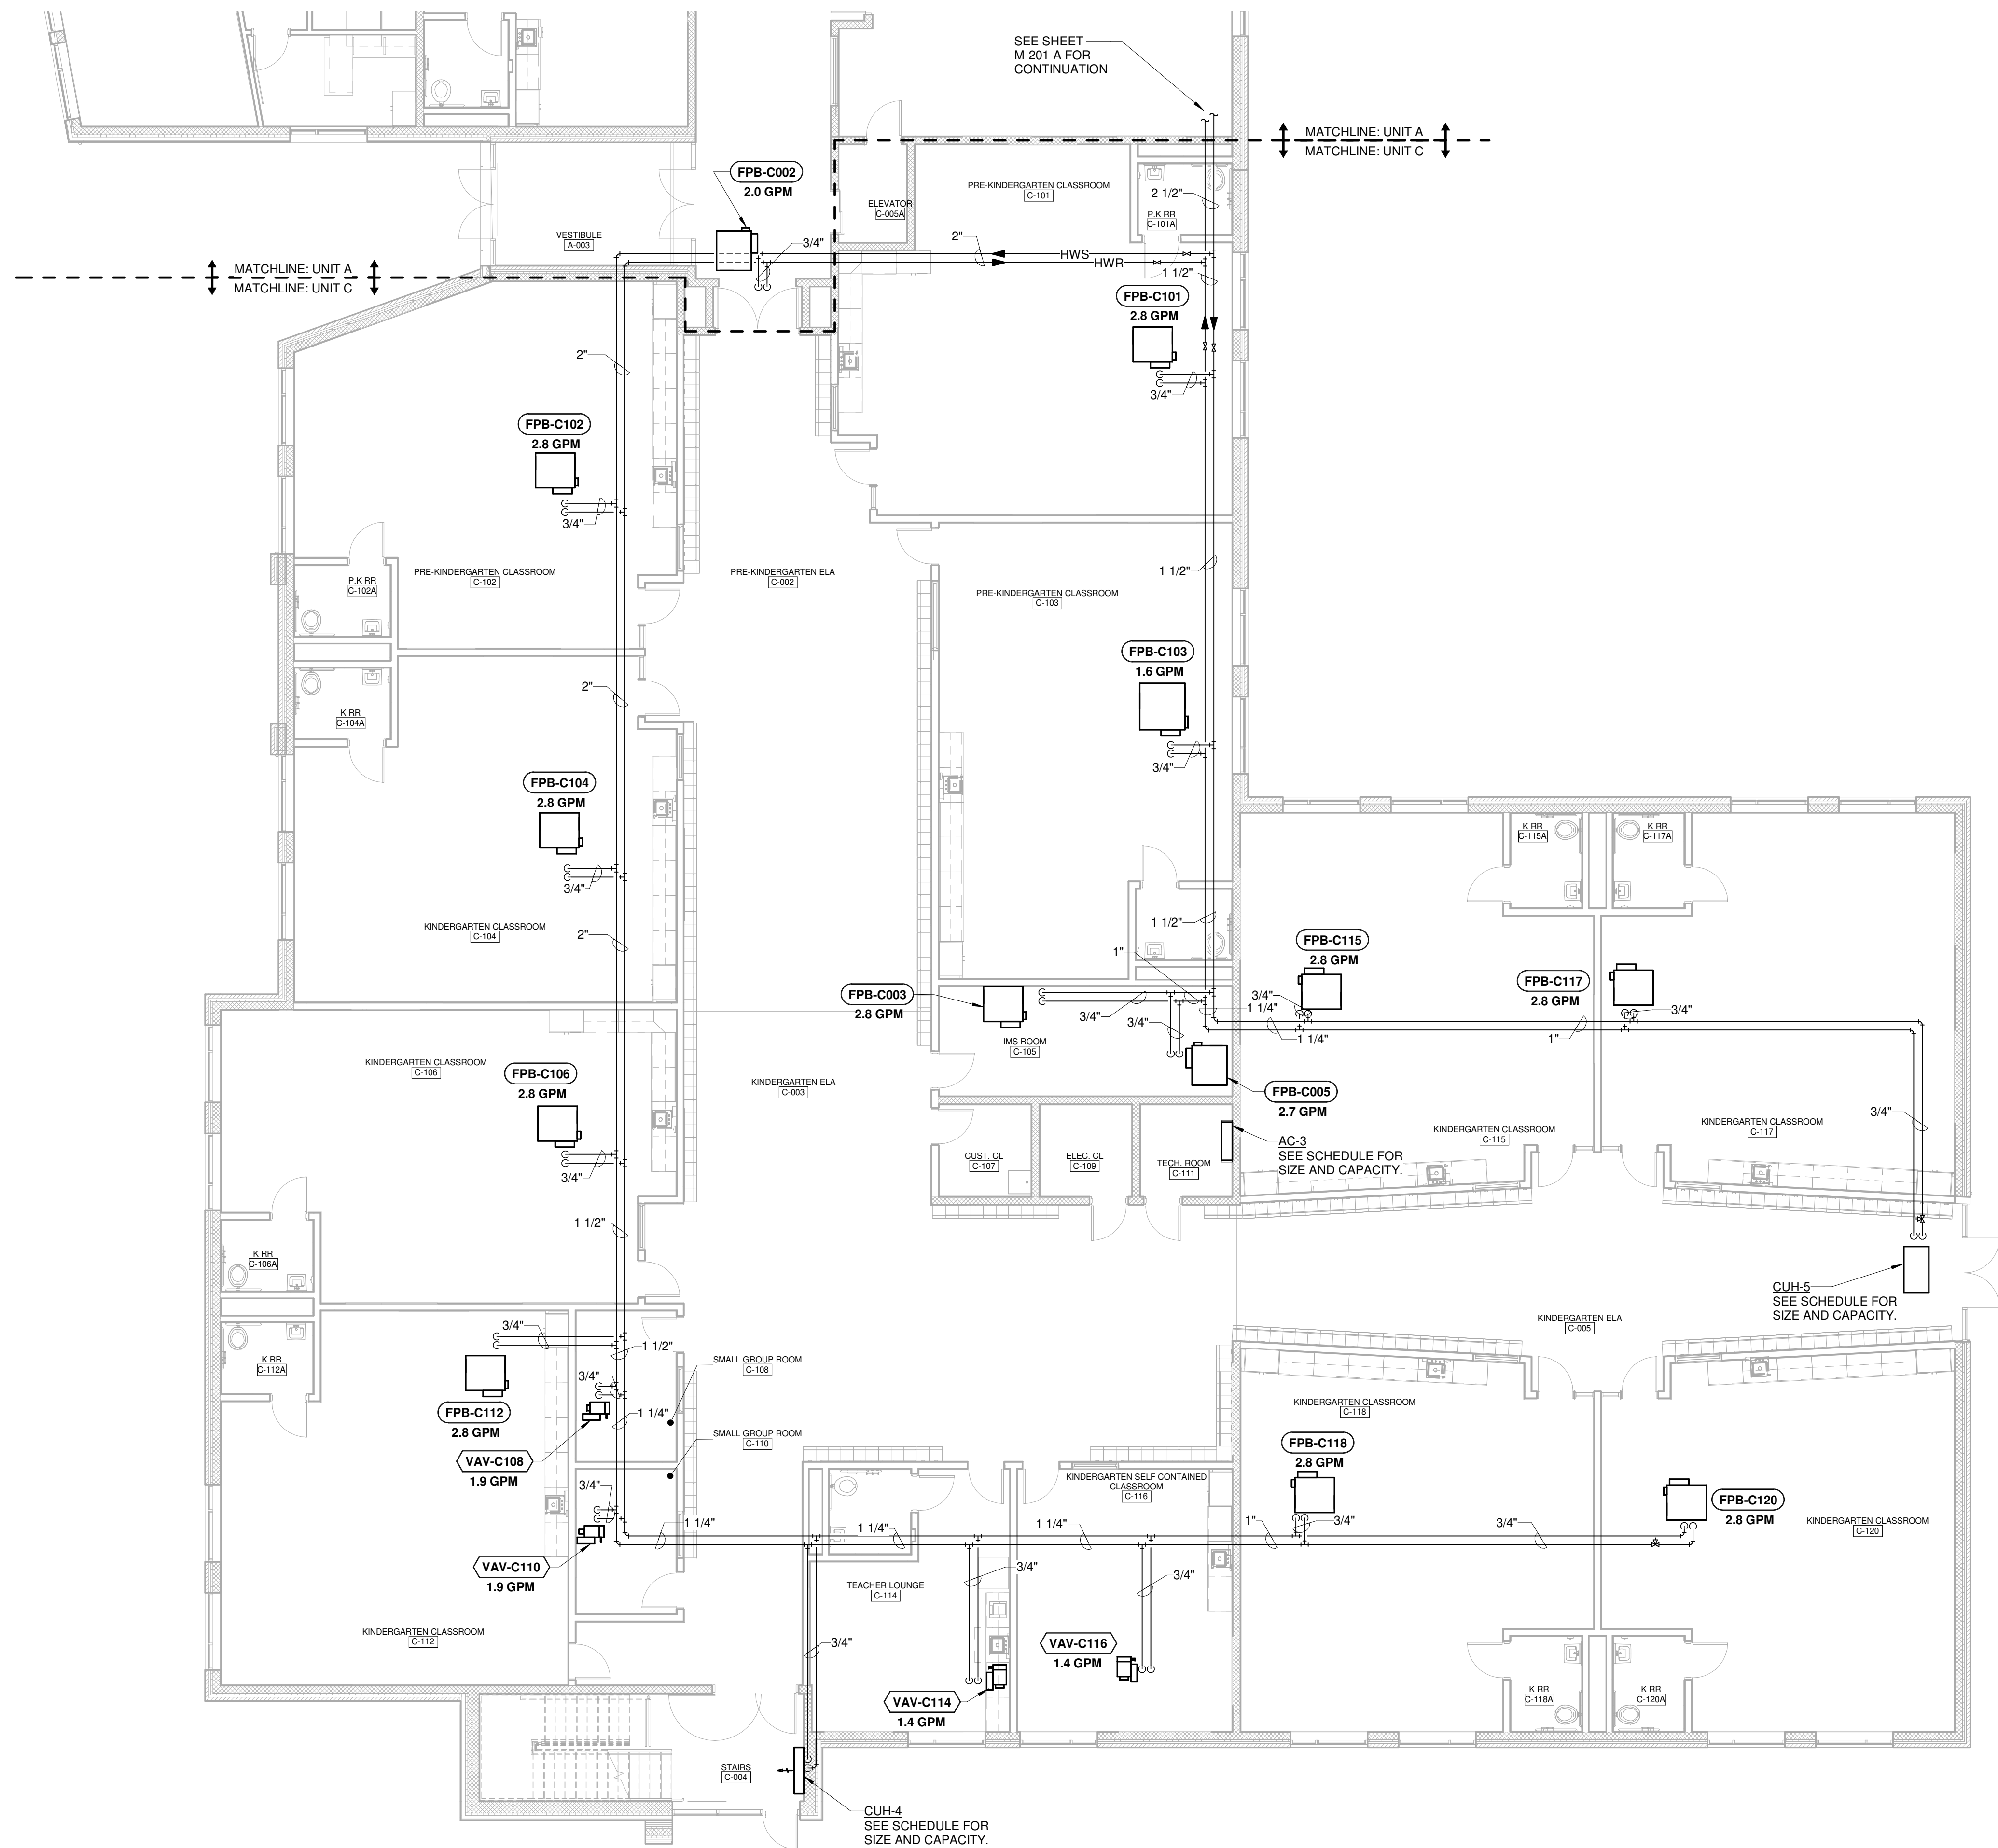


FIRST FLOOR PLAN - HVAC PIPING - UNIT C


SCALE: 1/8" = 1'-0"


PROJECT NO
2203-2

ARCHITECTURAL VISION GROUP, LTD
ARCHITECTS
23850 SPERRY DRIVE
CLEVELAND, OHIO 44145

PLANNERS

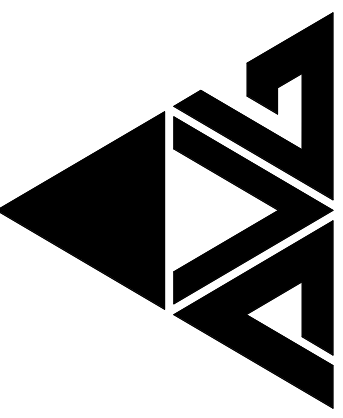

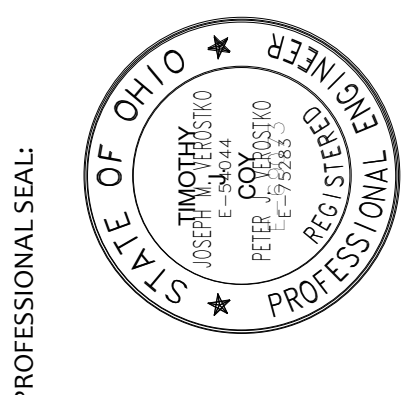

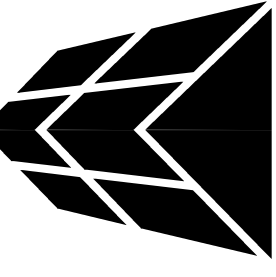

MASSILLON CITY SCHOOLS

MASSILLON EAST ELEMENTARY PK-3
1 PAULE BROWN DRIVE SE, MASSILLON, OHIO 44646
MASSILLON CITY SCHOOL DISTRICT MASSILLON, OHIO

NO.	DATE	ISSUED AS
1	07/12/23	ISSUED AS

PROJECT NO
2203-2

DRAWN BY
PH

CHECKED BY
ARH

DATE
07/12/23

FIRST FLOOR
PLAN - HVAC
PIPING - UNIT C

SCALE: 1/8" = 1'-0"

SHEET NO
M-201-C