



PARTIAL FIRST FLOOR PLAN - ENLARGED MECH ROOM B-119 - HVAC PIPING
SCALE: 1/4" = 1'-0"

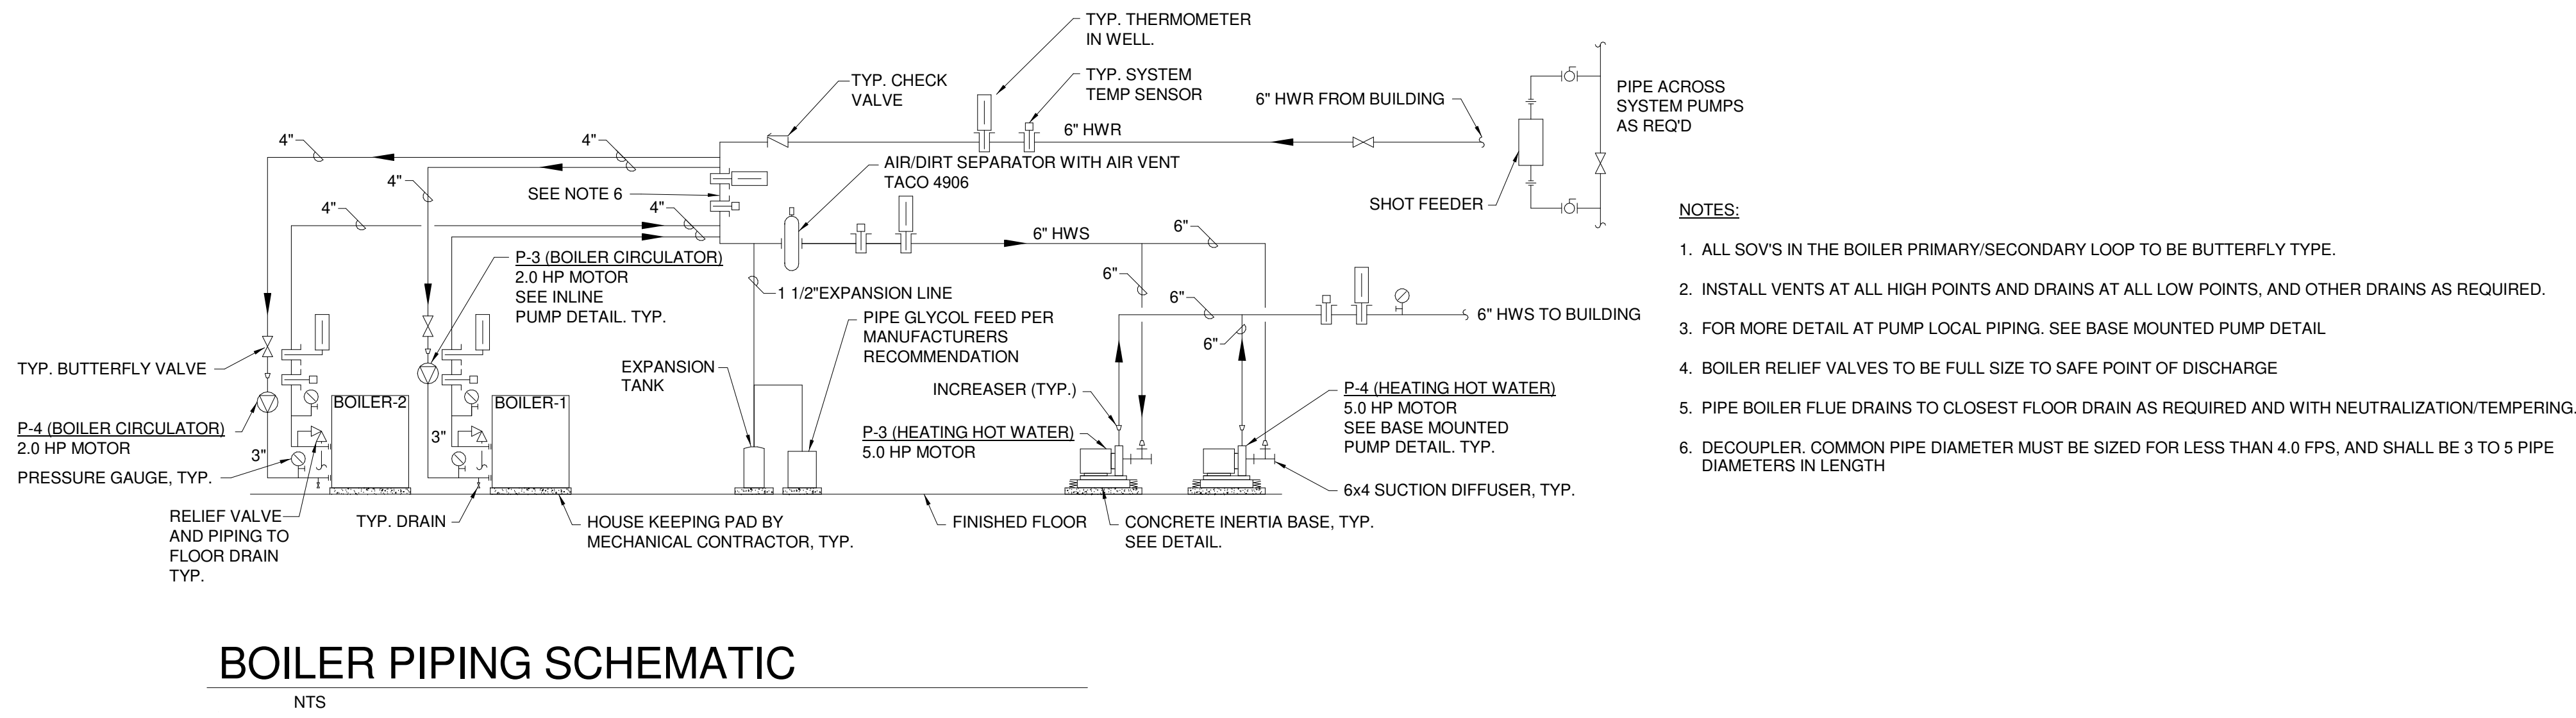


BOILER PIPING SCHEMATIC
NTS

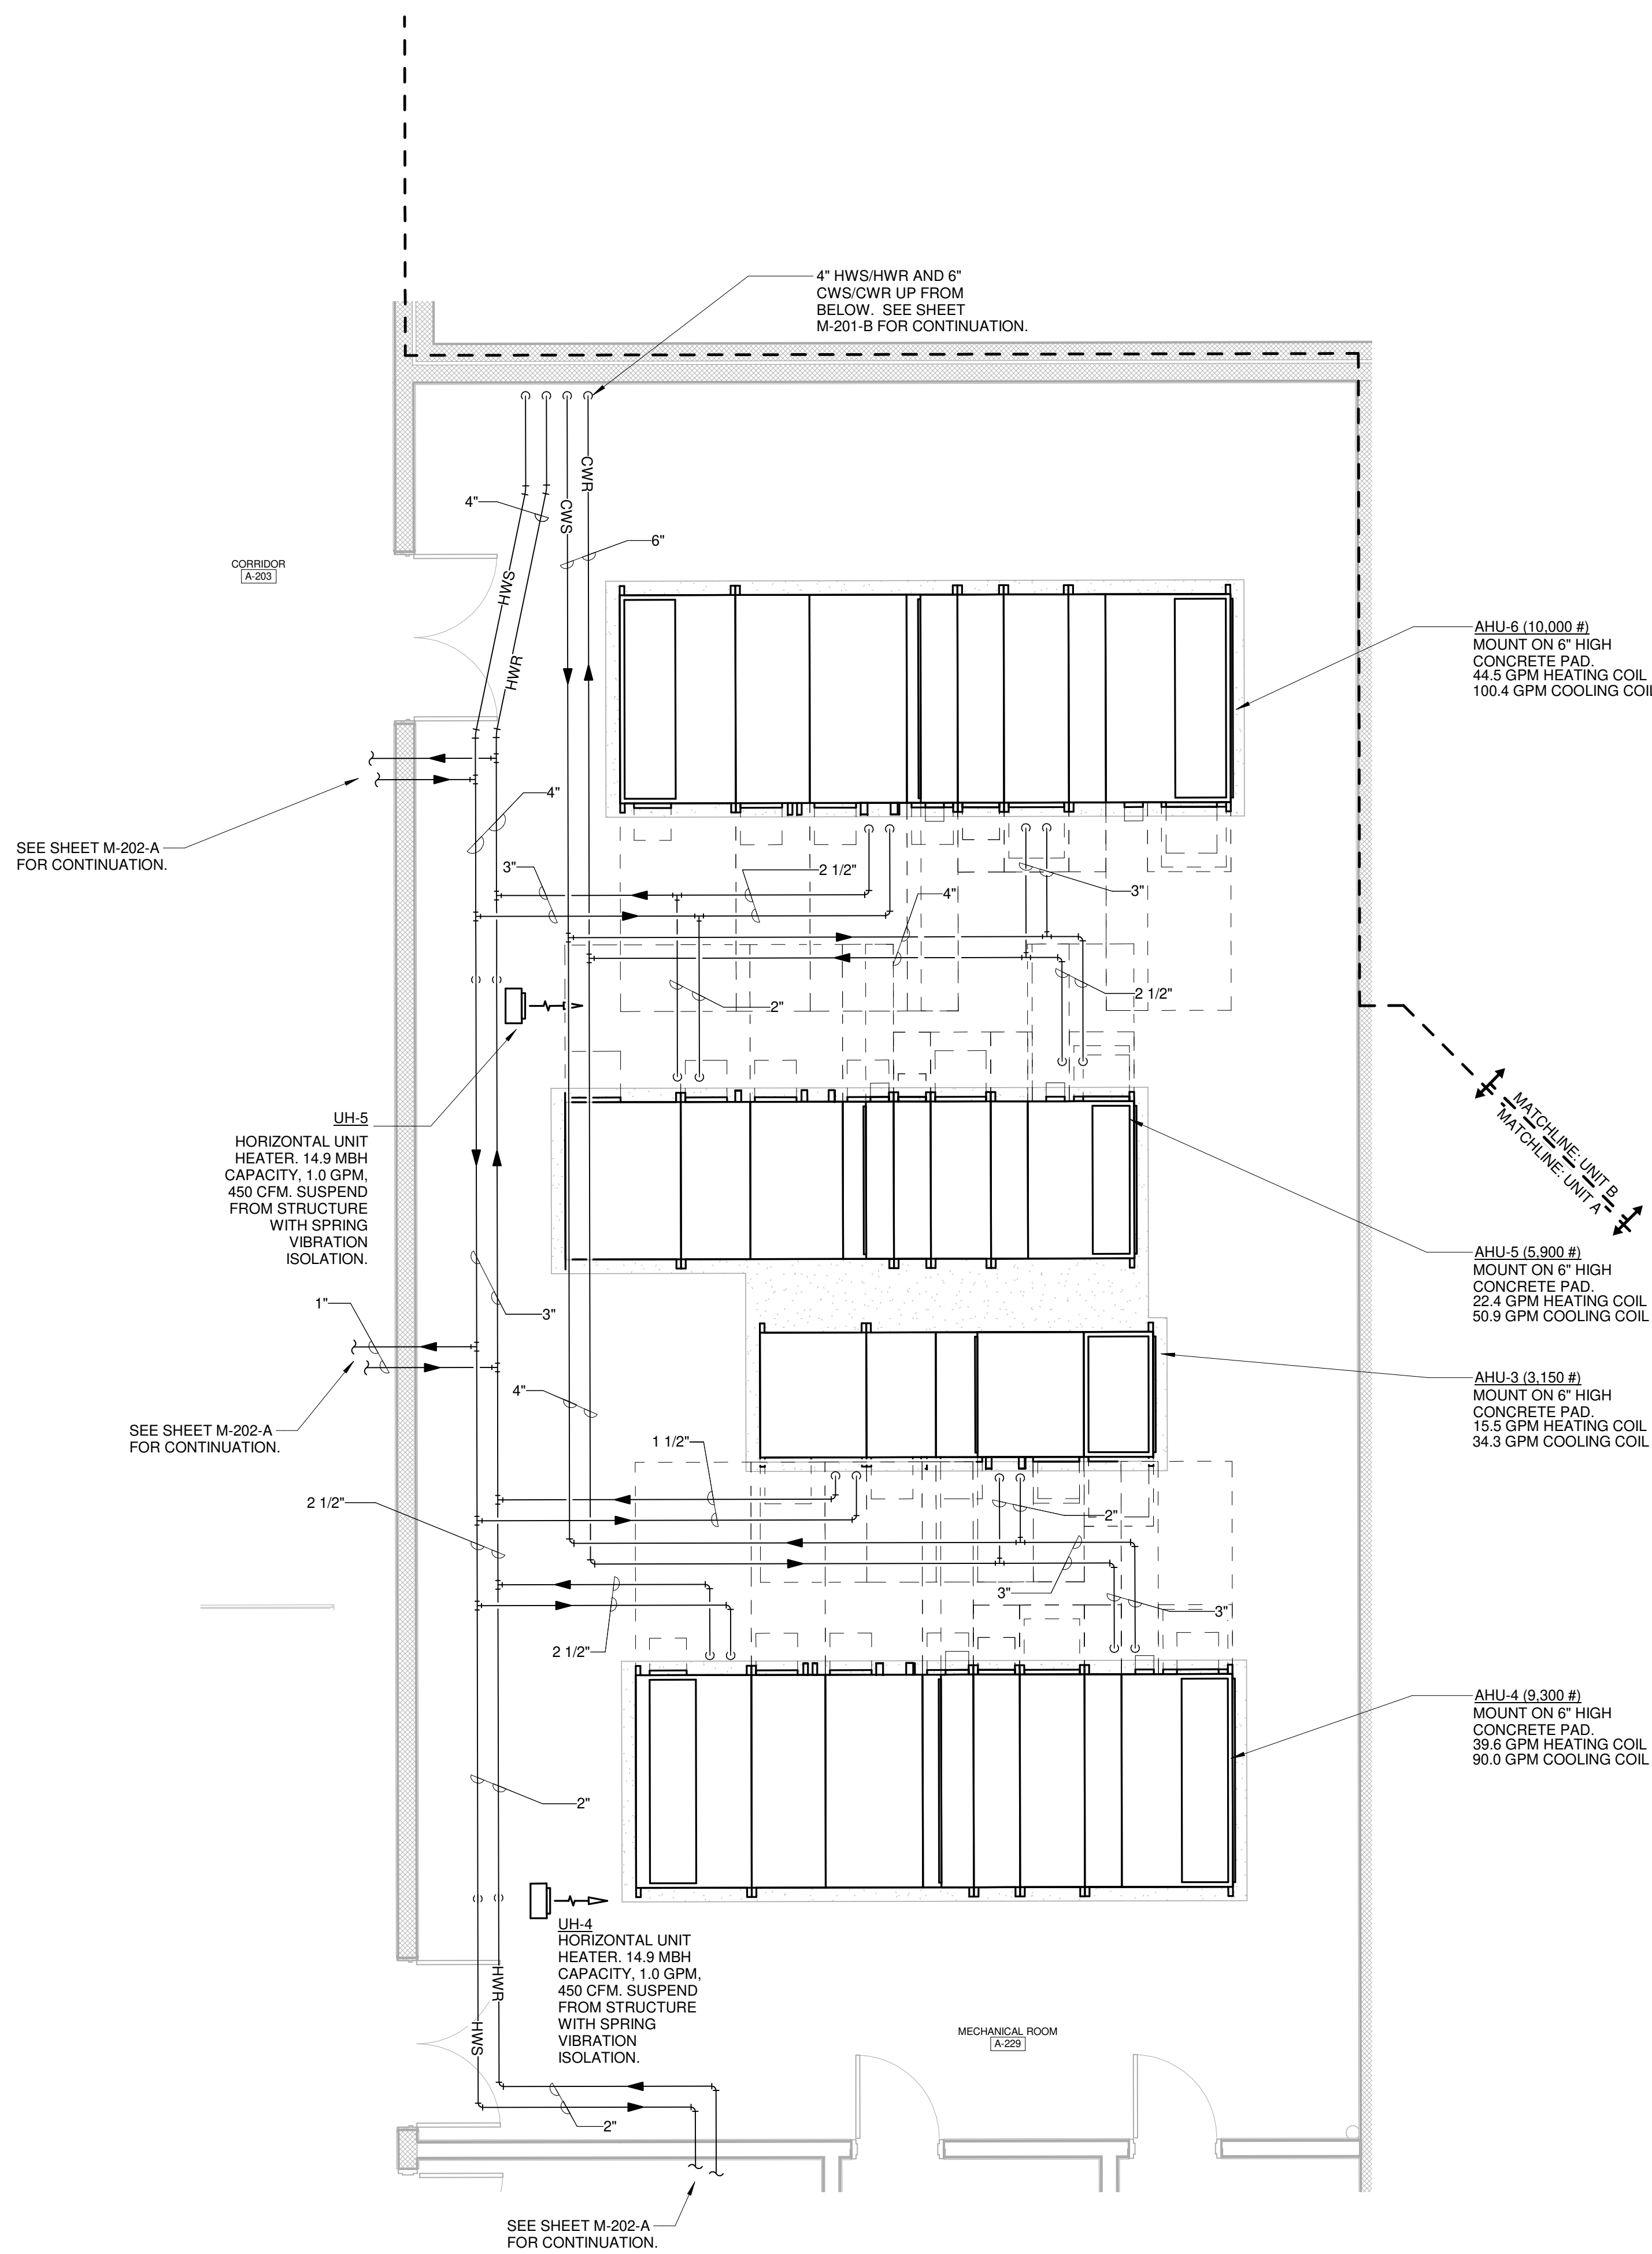


PARTIAL SECOND FLOOR PLAN - ENLARGED MECH ROOM A-229 - HVAC PIPING
SCALE: 1/4" = 1'-0"


PROJECT NO
2203-2

ARCHITECTURAL VISION GROUP, LTD
PLANNERS
ARCHITECTS
23850 SPERRY DRIVE
CLEVELAND, OHIO 44145

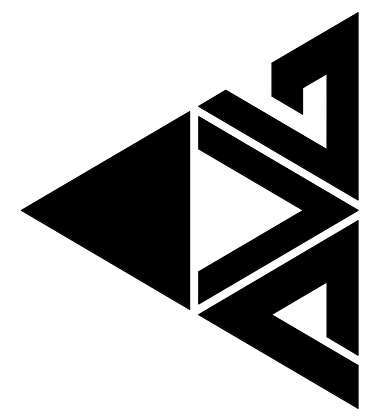



CONSULTING
J.M. VERDOSTKO, INC.
ARCHITECTS

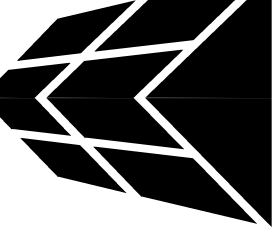

MASSILLON CITY SCHOOLS
MASSILLON EAST ELEMENTARY PK-3
1 PAULE BROWN DRIVE SE, MASSILLON, OHIO 44646
MASSILLON CITY SCHOOL DISTRICT MASSILLON, OHIO

NO.	DATE	ISSUED AS
1	07/12/23	ISSUED AS

ENLARGED
MECHANICAL
ROOMS

SCALE: As indicated
SHEET NO
M-203