



NOTES:  
1. LATCHES SHALL BE OF THE WEDGE TYPE TO CLOSE DOORS TIGHTLY.  
2. HINGES ON THE ACCESS DOORS SHALL HAVE NON-CORROSIVE PINS.  
3. SEE SMACNA 300, FIGURE 3-15.

**ACCESS PANEL AND DOOR**  
NOT TO SCALE

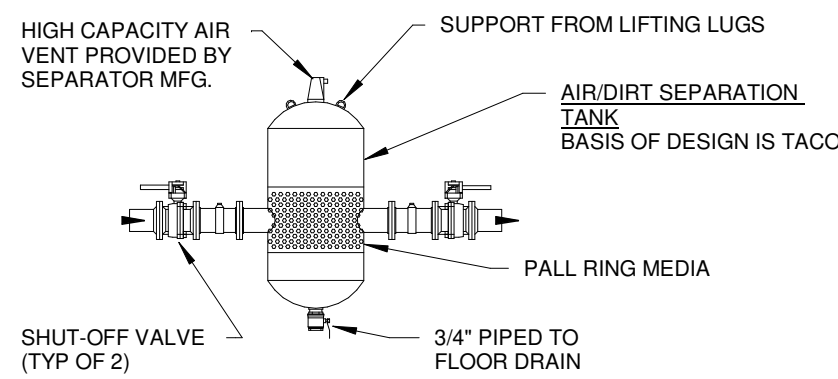


**AIR AND DIRT SEPARATOR**  
NOT TO SCALE

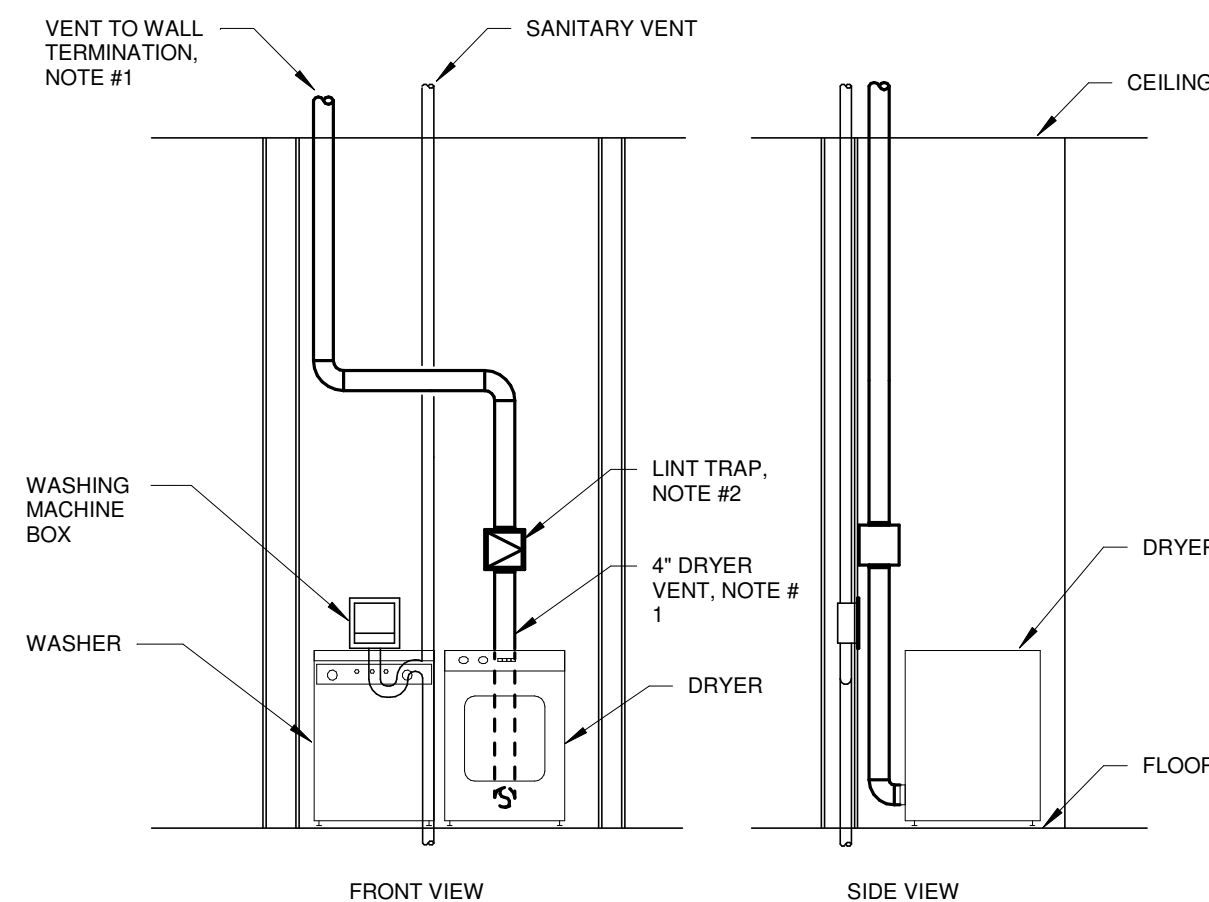


DETAIL NOTES:  
1. DRYER VENT - TO BE CONSTRUCTED OF NON-CORRODING SHEET METAL (STAINLESS OR ALUMINUM). USE NO SCREWS OR OTHER FASTENERS THAT EXTEND INTO DUCT. DRYER VENT TO BE TERMINATED WITH DRYER VENT WALL CAP.

**DRYER VENT & LINT TRAP**  
SCALE: 1/8" = 1'-0"

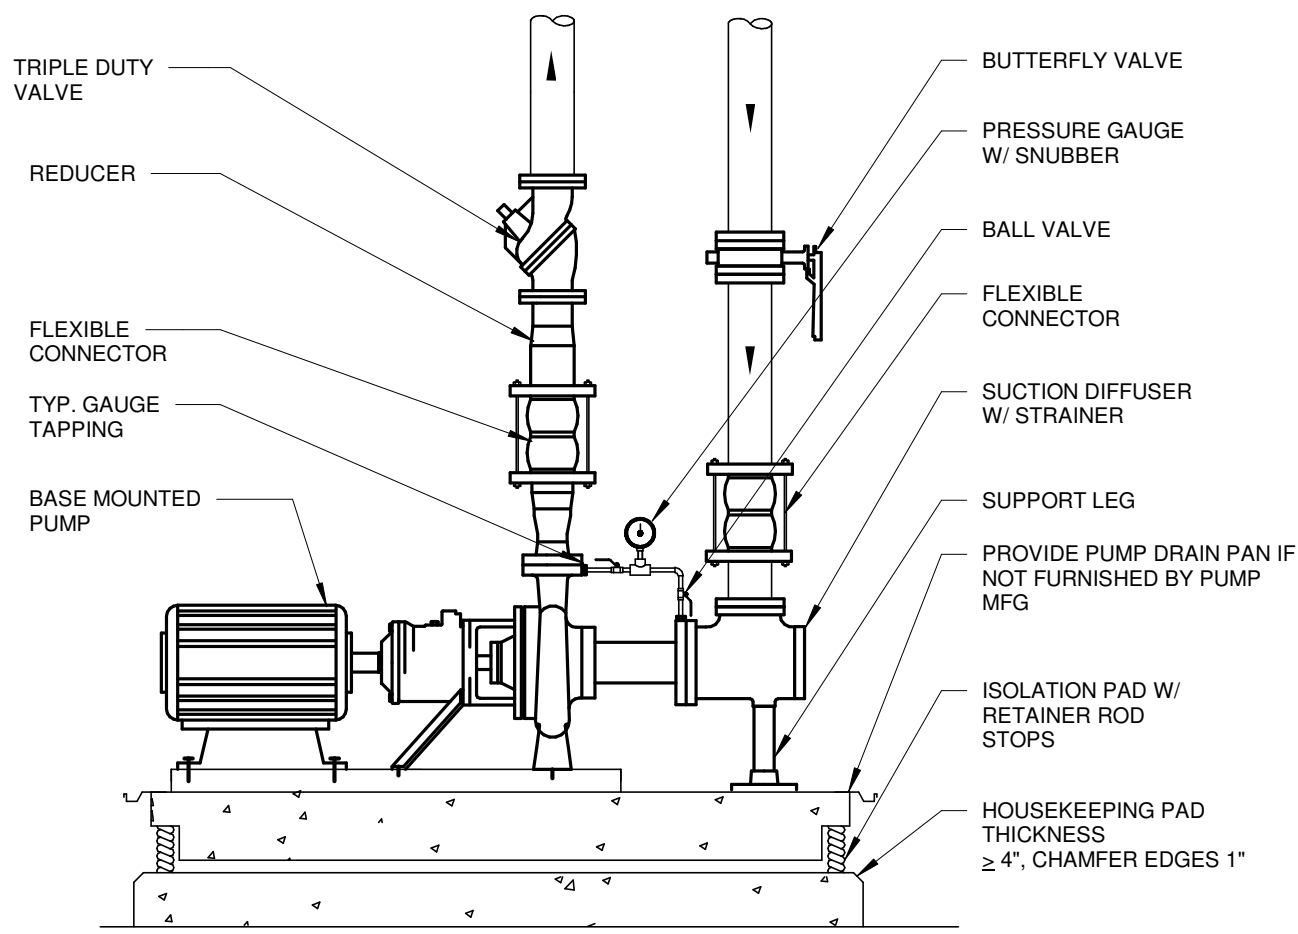


**END SUCTION PUMP DETAIL**  
NOT TO SCALE

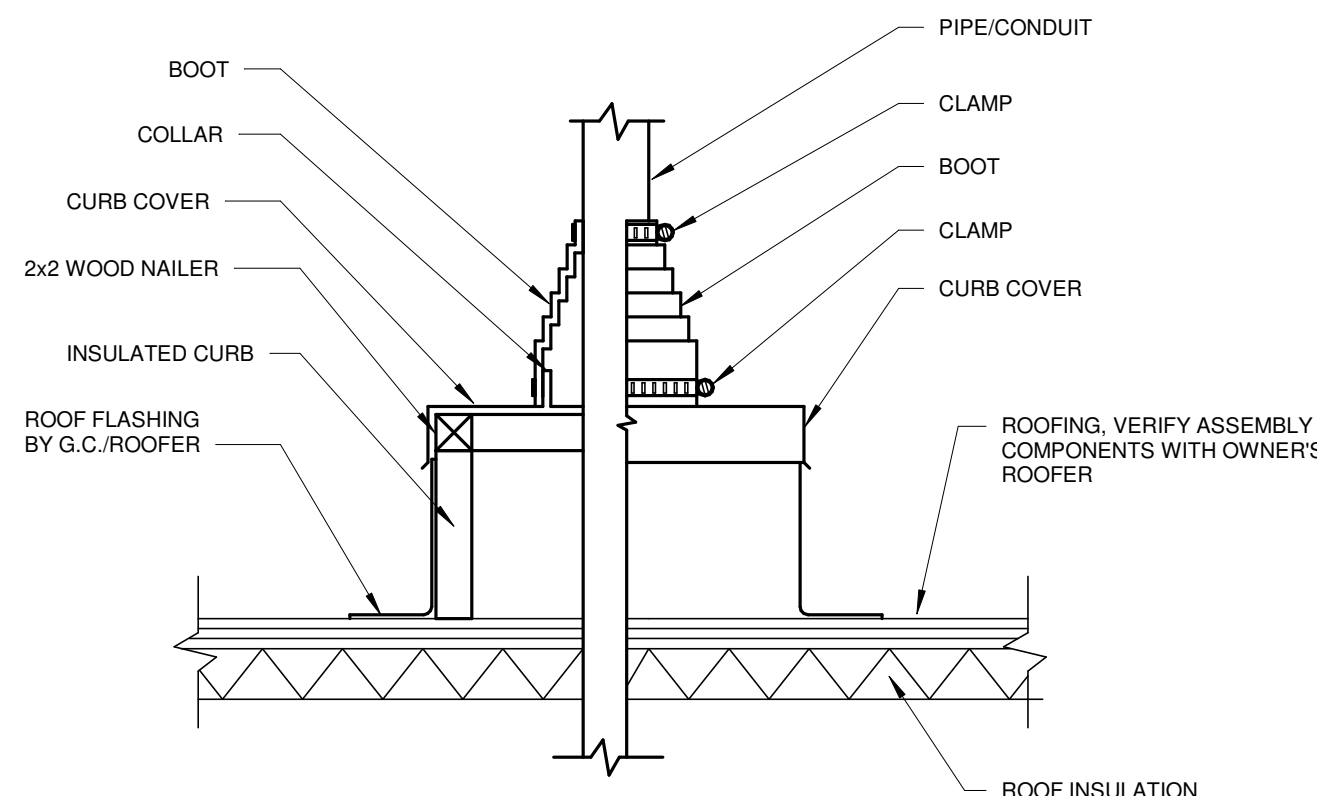

NOTES:  
1. REFER TO MANUFACTURERS INSTALLATION REQUIREMENTS.  
2. ONE PIPE/CONDUIT PER BOOT.




**PIPE/CONDUIT CURB**  
NOT TO SCALE

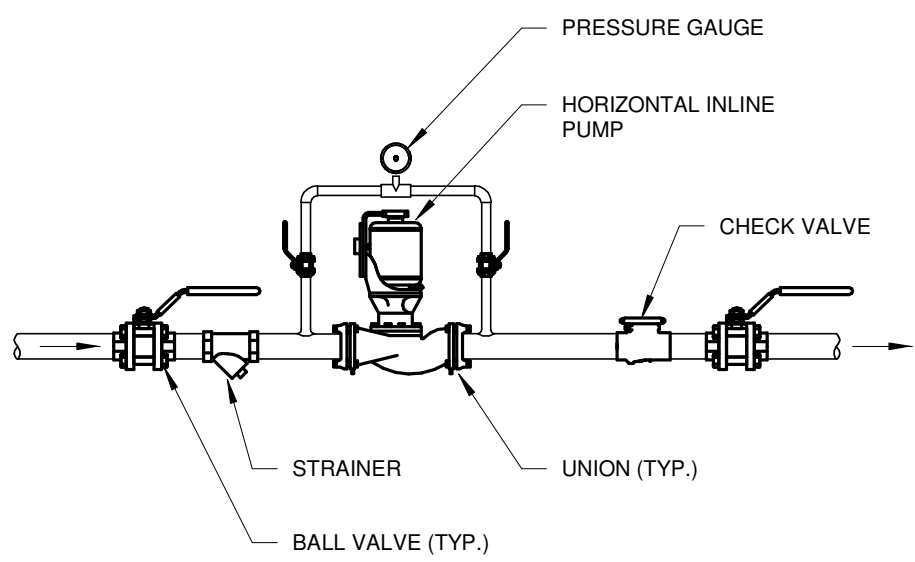

**HORIZONTAL INLINE PUMP CONNECTION (TYPE 2)**  
NOT TO SCALE

PROJECT NO  
2203-2

ARCHITECTURAL VISION GROUP, LTD  
PLANNERS  
ARCHITECTS  
23850 SPERRY DRIVE  
CLEVELAND, OHIO 44145

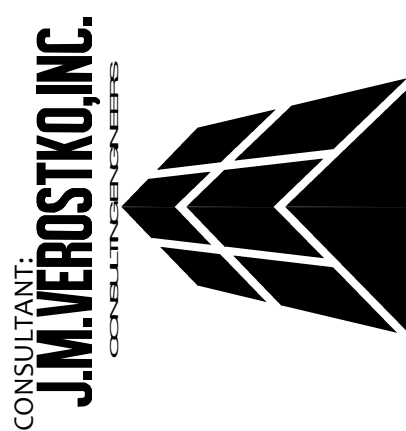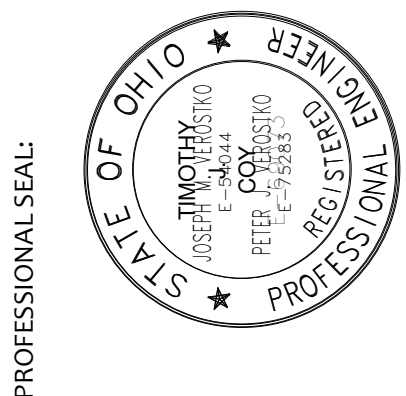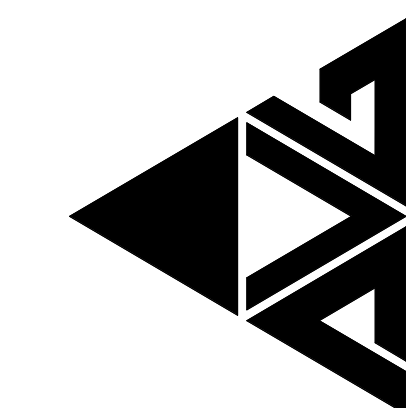

MASSILLON CITY SCHOOLS  
MASSILLON EAST ELEMENTARY PK-3  
1 PAULE BROWN DRIVE SE, MASSILLON, OHIO 44646  
MASSILLON CITY SCHOOL DISTRICT MASSILLON, OHIO

NO.	DATE	DESCRIPTION
1	07/12/23	ISSUED AS
2		
3		
4		
5		
6		
7		
8		
9		
10		
11		
12		
13		
14		

PROJECT NO 2203-2  
DRAWN BY PH  
CHECKED BY ARB  
DATE 07/12/23

HVAC DETAILS  
SCALE: 1/8" = 1'-0"  
SHEET NO  
M-403