


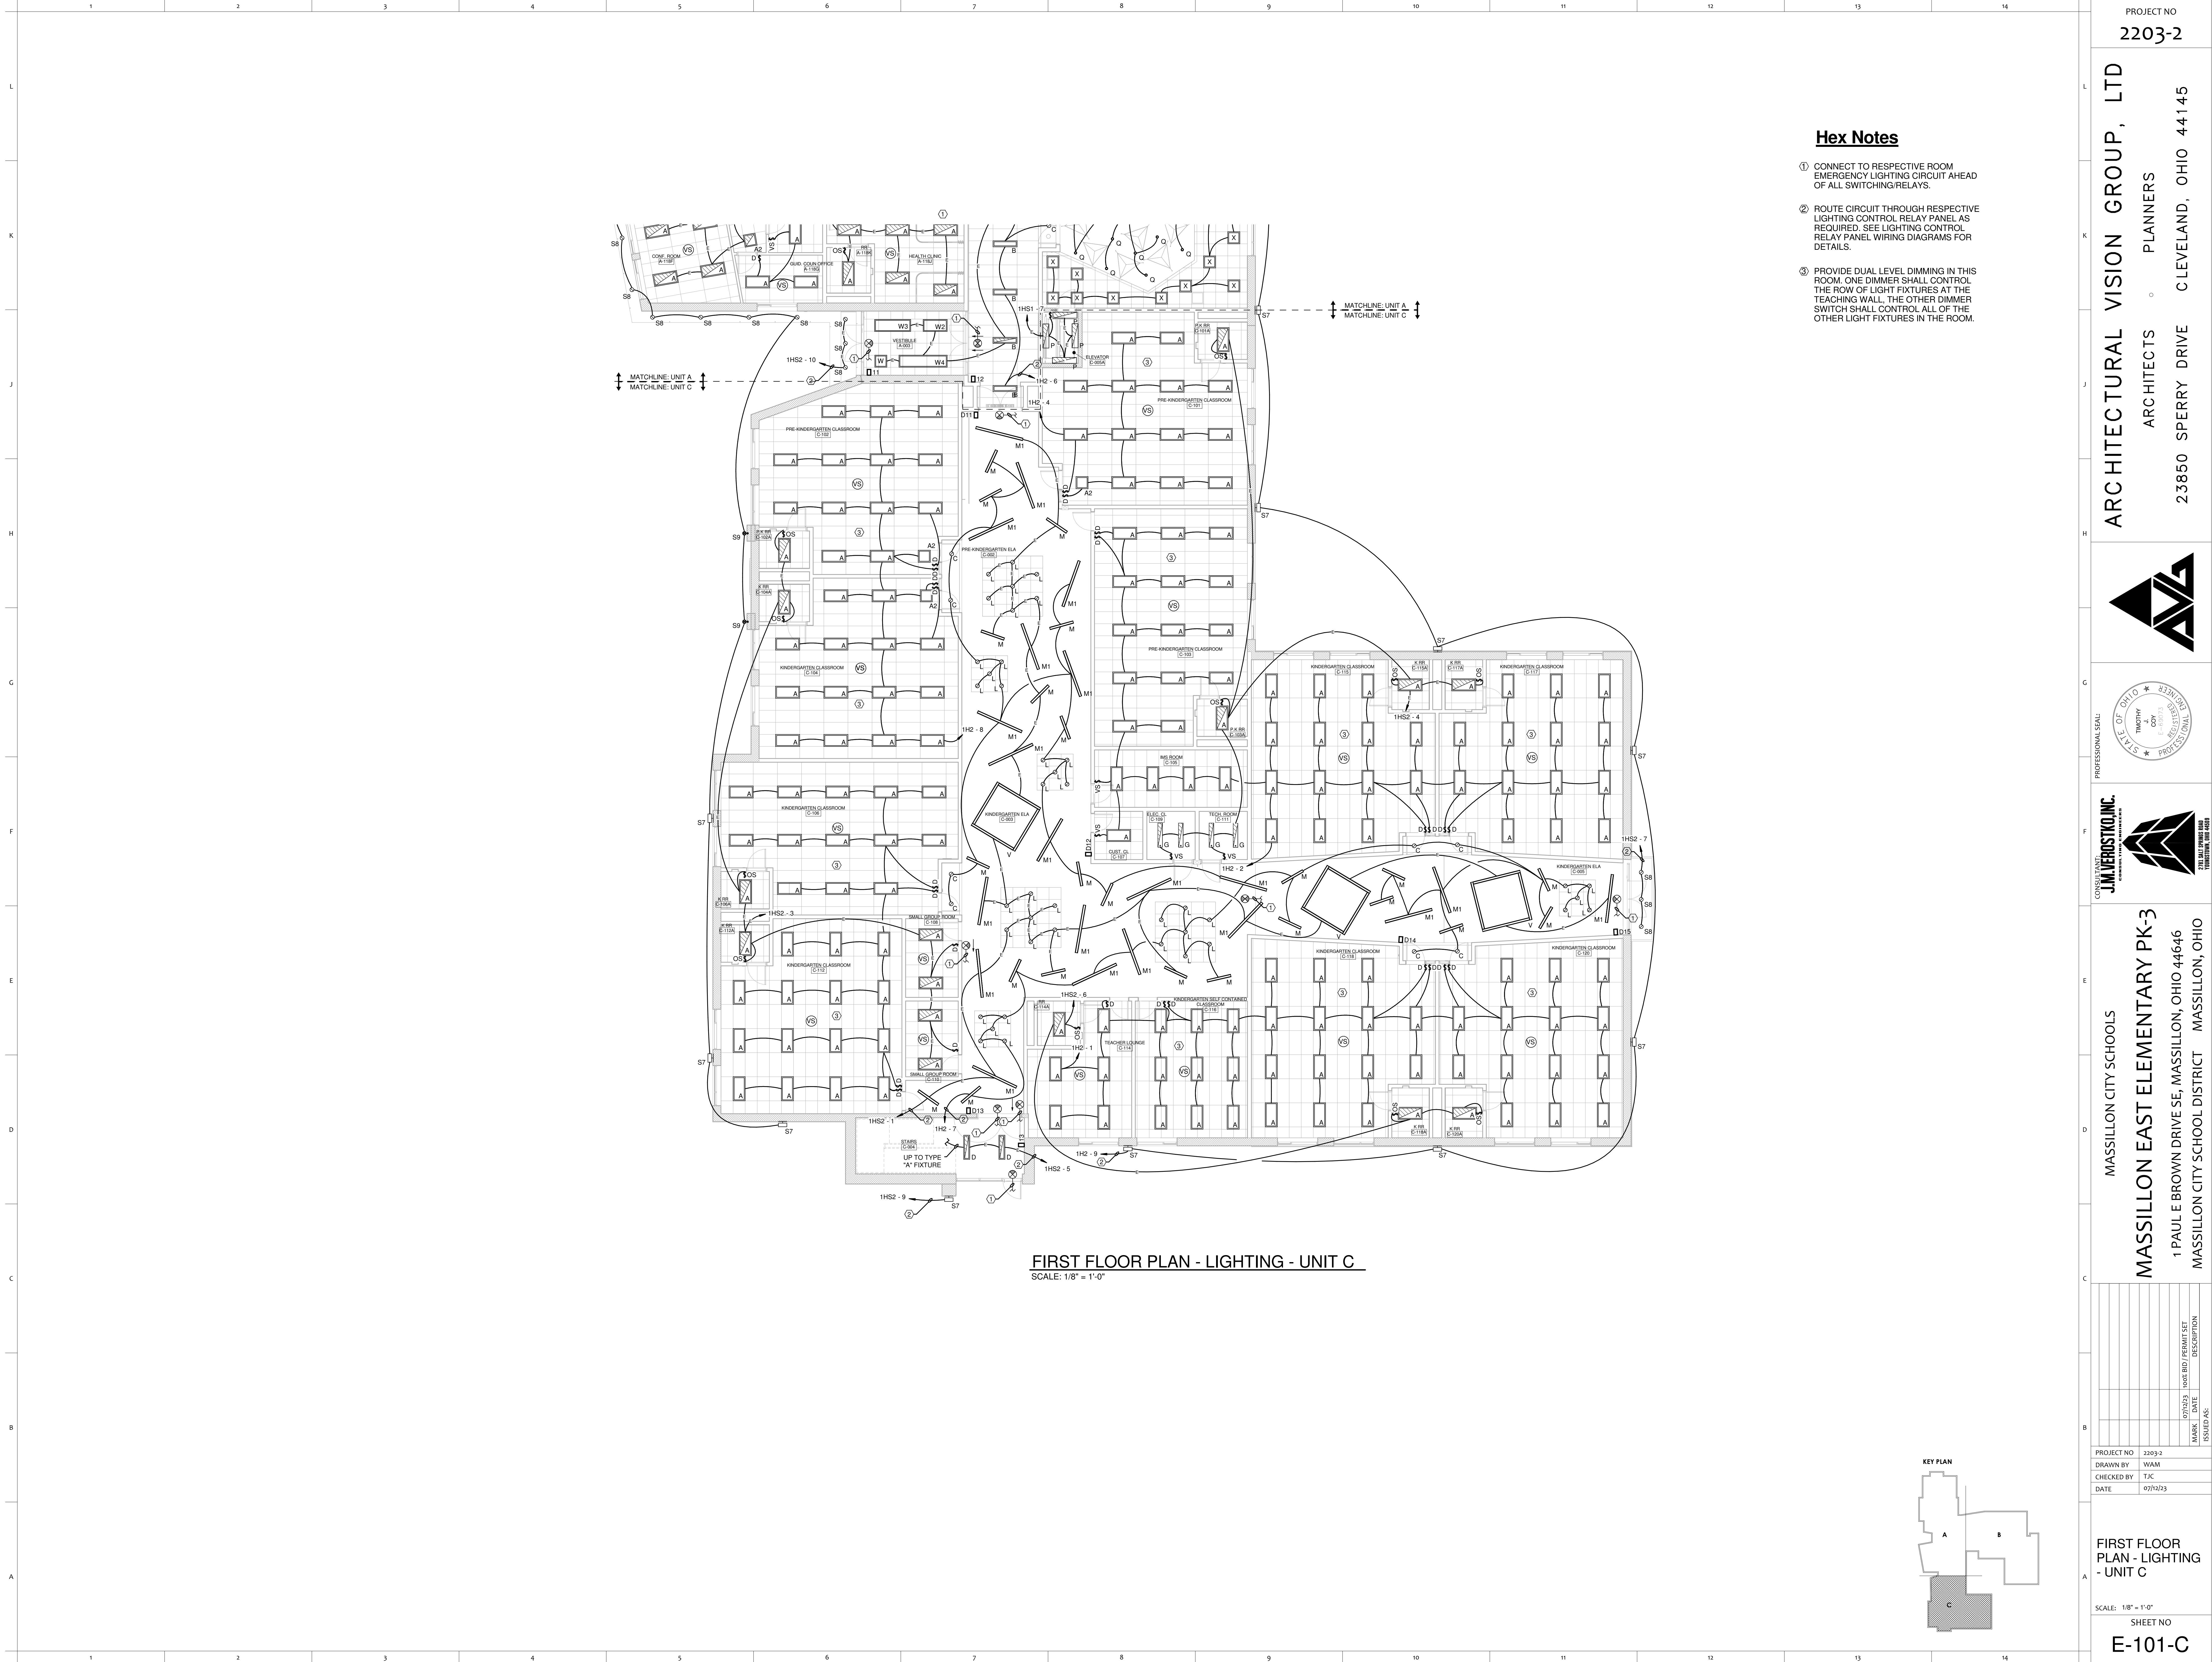

FIRST FLOOR PLAN - LIGHTING - UNIT C
SCALE: 1/8" = 1'-0"



Hex Notes

- 1 CONNECT TO RESPECTIVE ROOM EMERGENCY LIGHTING CIRCUIT AHEAD OF ALL SWITCHING RELAYS.
- 2 ROUTE CIRCUIT THROUGH RESPECTIVE LIGHTING CONTROL RELAY PANEL AS REQUIRED. SEE LIGHTING CONTROL RELAY PANEL WIRING DIAGRAMS FOR DETAILS.
- 3 PROVIDE DUAL LEVEL DIMMING IN THIS ROOM. ONE DIMMER SHALL CONTROL THE ROW OF LIGHT FIXTURES AT THE TEACHING WALL. THE OTHER DIMMER SWITCH SHALL CONTROL ALL OF THE OTHER LIGHT FIXTURES IN THE ROOM.

PROJECT NO
2203-2

ARCHITECTURAL VISION GROUP, LTD
PLANNERS
CLEVELAND, OHIO 44145

ARCHITECTS
23850 SPERRY DRIVE

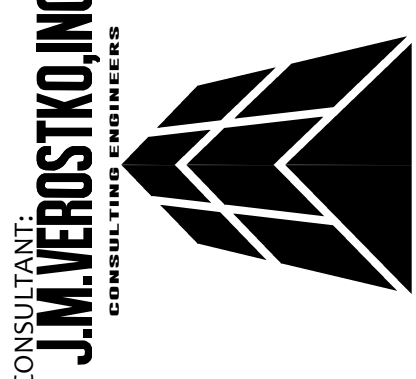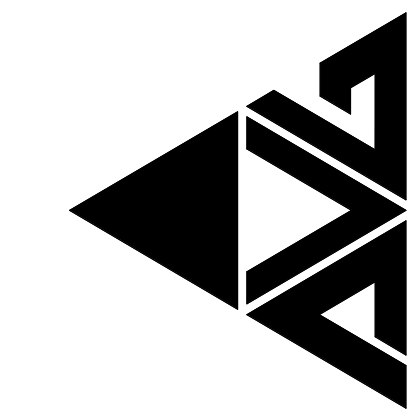

MASSILLON CITY SCHOOLS
MASSILLON EAST ELEMENTARY PK-3
1 PAULE BROWN DRIVE SE, MASSILLON, OHIO 44646
MASSILLON CITY SCHOOL DISTRICT MASSILLON, OHIO

DATE	ISSUED BY	DESCRIPTION
07/12/23	WAM	ISSUED FOR PERMITS
07/12/23	TJC	ISSUED FOR CONSTRUCTION

PROJECT NO 2203-2
DRAWN BY WAM
CHECKED BY TJC
DATE 07/12/23

FIRST FLOOR
PLAN - LIGHTING
- UNIT C
SCALE: 1/8" = 1'-0"
SHEET NO
E-101-C