



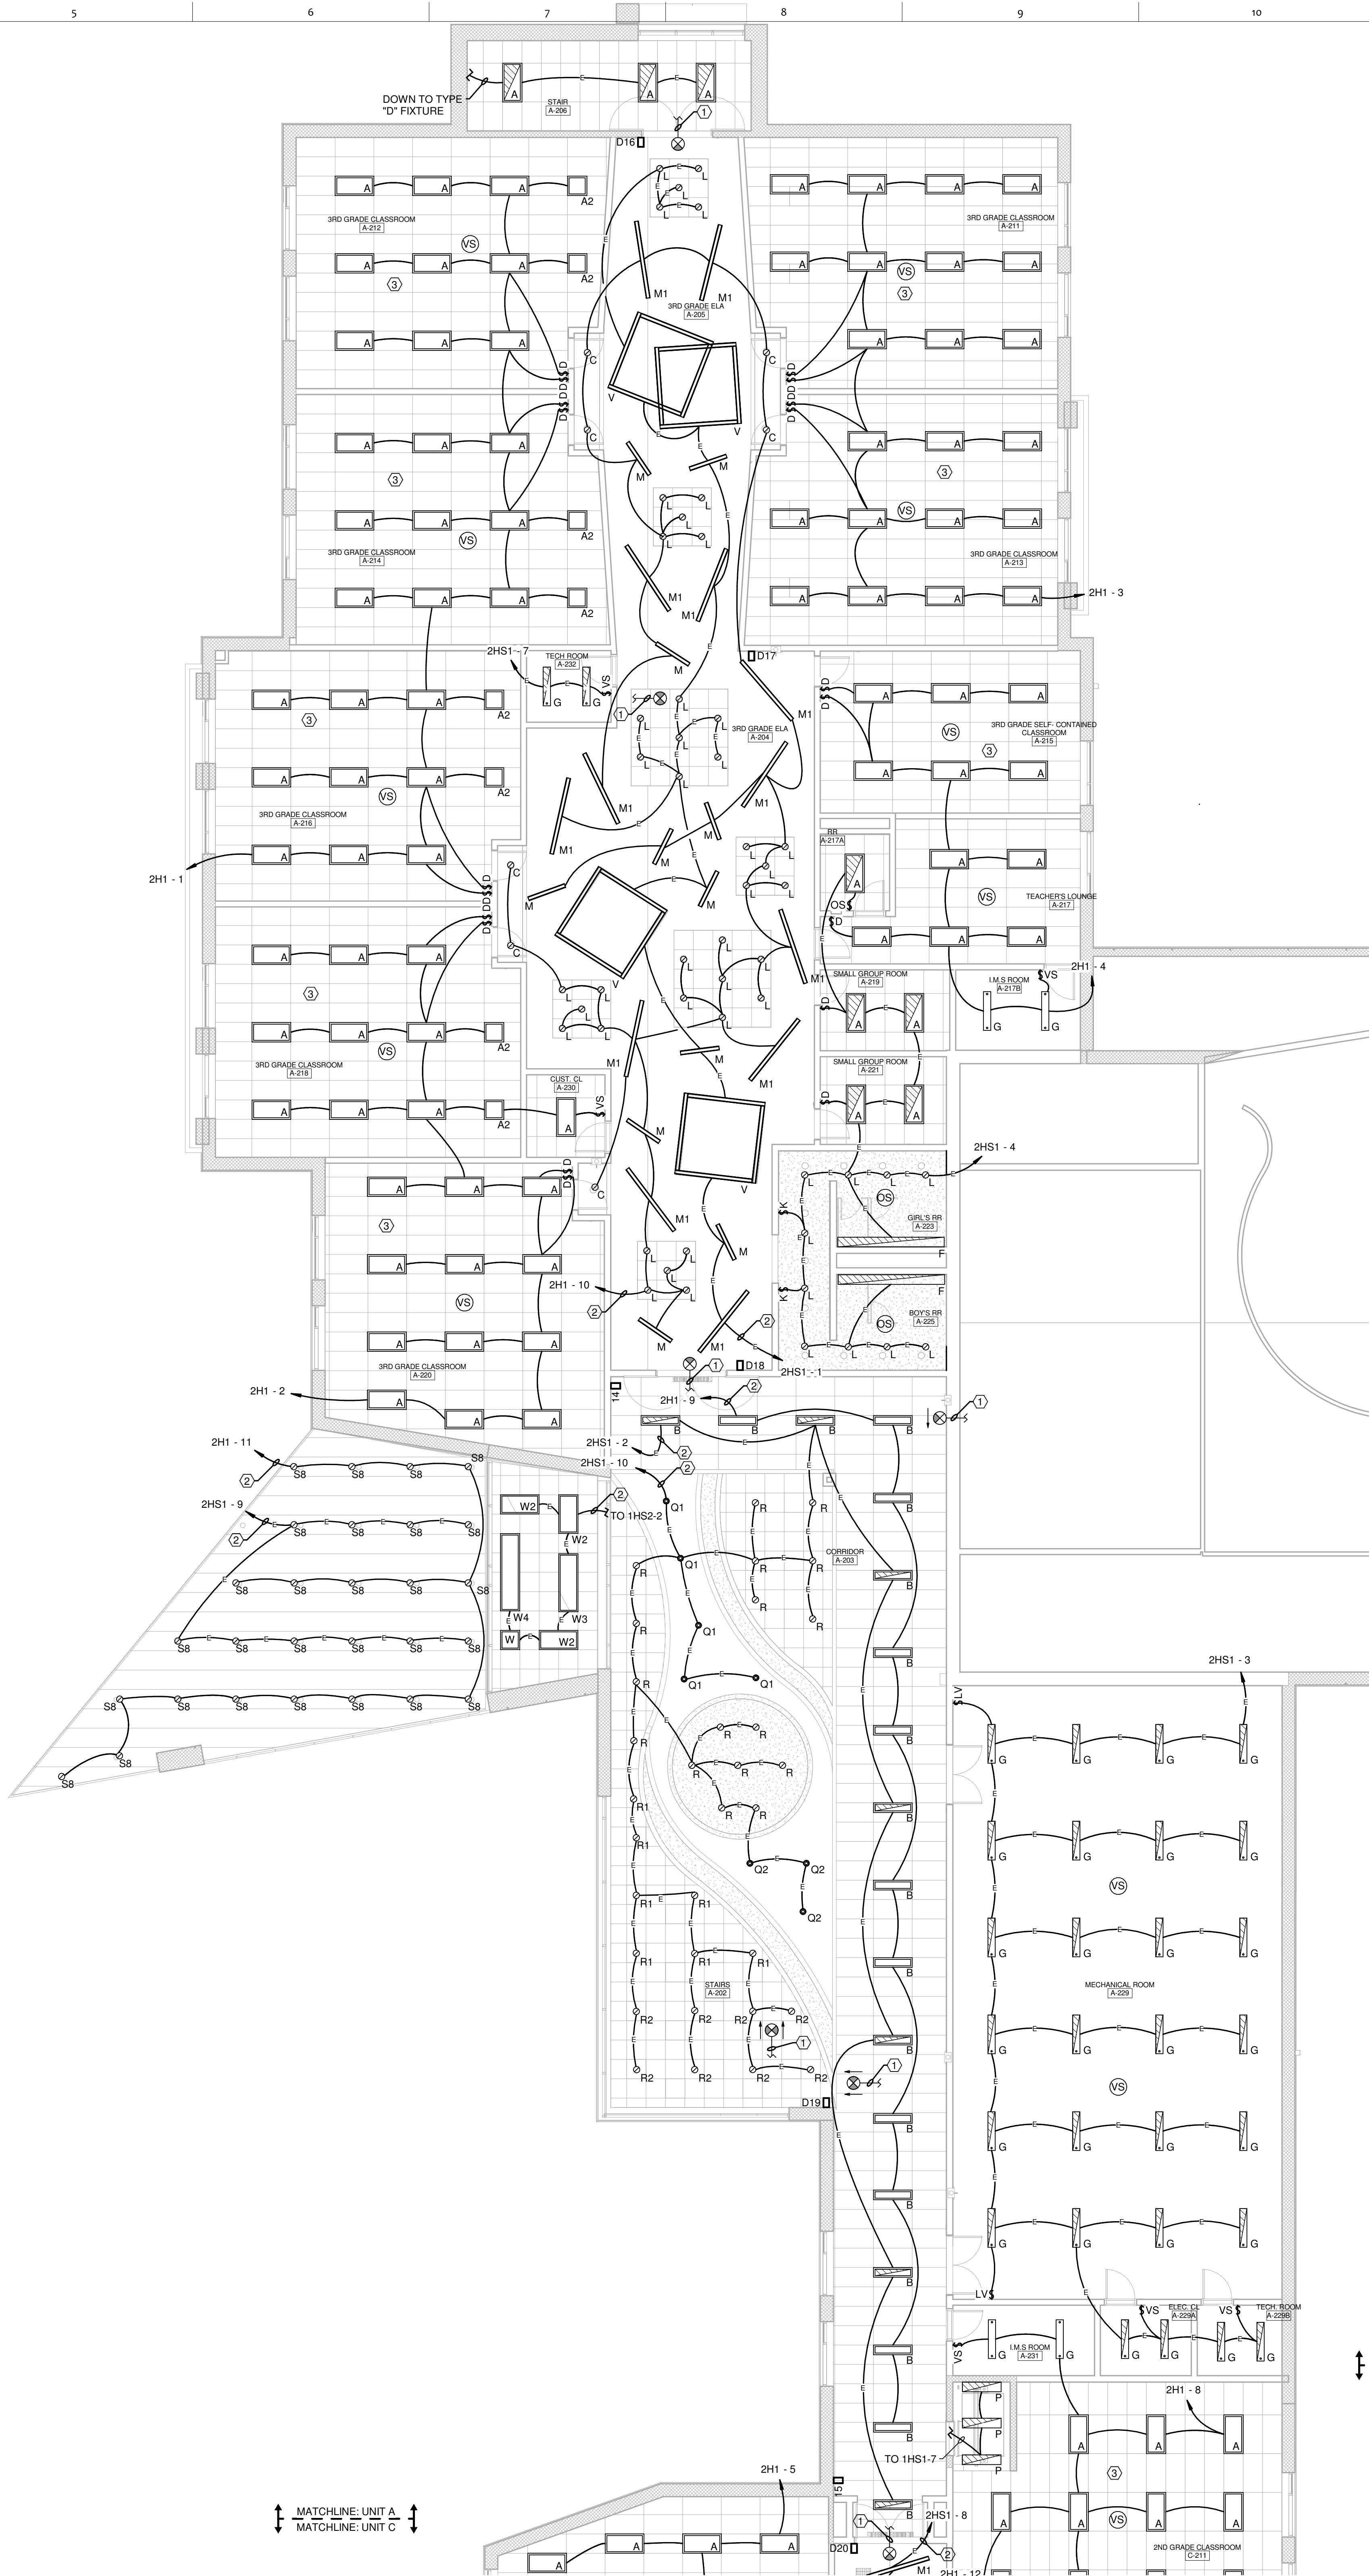

SECOND FLOOR PLAN - LIGHTING - UNIT A
SCALE: 1/8" = 1'-0"


Hex Notes


- ① CONNECT TO RESPECTIVE ROOM EMERGENCY LIGHTING CIRCUIT AHEAD OF ALL SWITCHING RELAYS.
- ② ROUTE CIRCUIT THROUGH RESPECTIVE LIGHTING CONTROL RELAY PANEL AS REQUIRED. SEE LIGHTING CONTROL RELAY PANEL WIRING DIAGRAMS FOR DETAILS.
- ③ PROVIDE DUAL LEVEL DIMMING IN THIS ROOM. ONE DIMMER SHALL CONTROL THE ROW OF LIGHT FIXTURES AT THE TEACHING WALL, THE OTHER DIMMER SWITCH SHALL CONTROL ALL OF THE OTHER LIGHT FIXTURES IN THE ROOM.

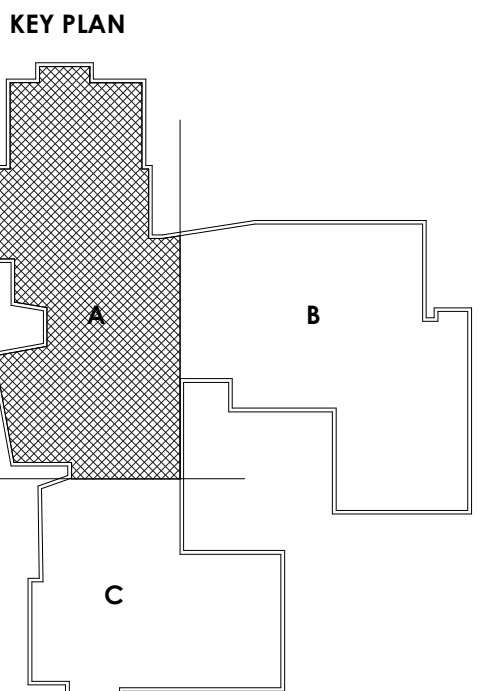

PROJECT NO
2203-2

ARCHITECTURAL VISION GROUP, LTD
ARCHITECTS
23850 SPERRY DRIVE
CLEVELAND, OHIO 44145

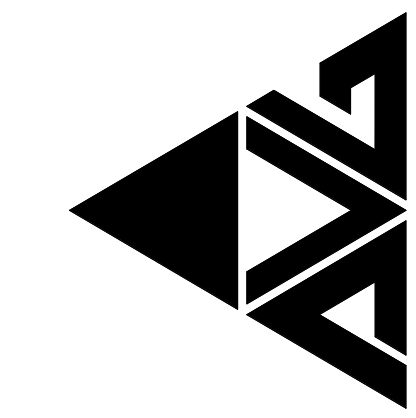

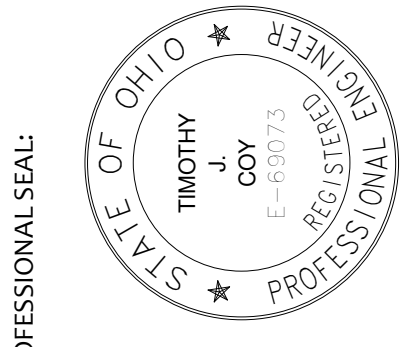



MASSILLON CITY SCHOOLS
MASSILLON EAST ELEMENTARY PK-3
1 PAULE BROWN DRIVE SE, MASSILLON, OHIO 44846
MASSILLON CITY SCHOOL DISTRICT MASSILLON, OHIO

DATE	ISSUED AS	DESCRIPTION
07/12/23	ISSUED AS	ISSUED AS

PROJECT NO 2203-2
DRAWN BY WAM
CHECKED BY TJC
DATE 07/12/23

SECOND FLOOR
PLAN - LIGHTING
- UNIT A

SCALE: 1/8" = 1'-0"
SHEET NO
E-102-A