


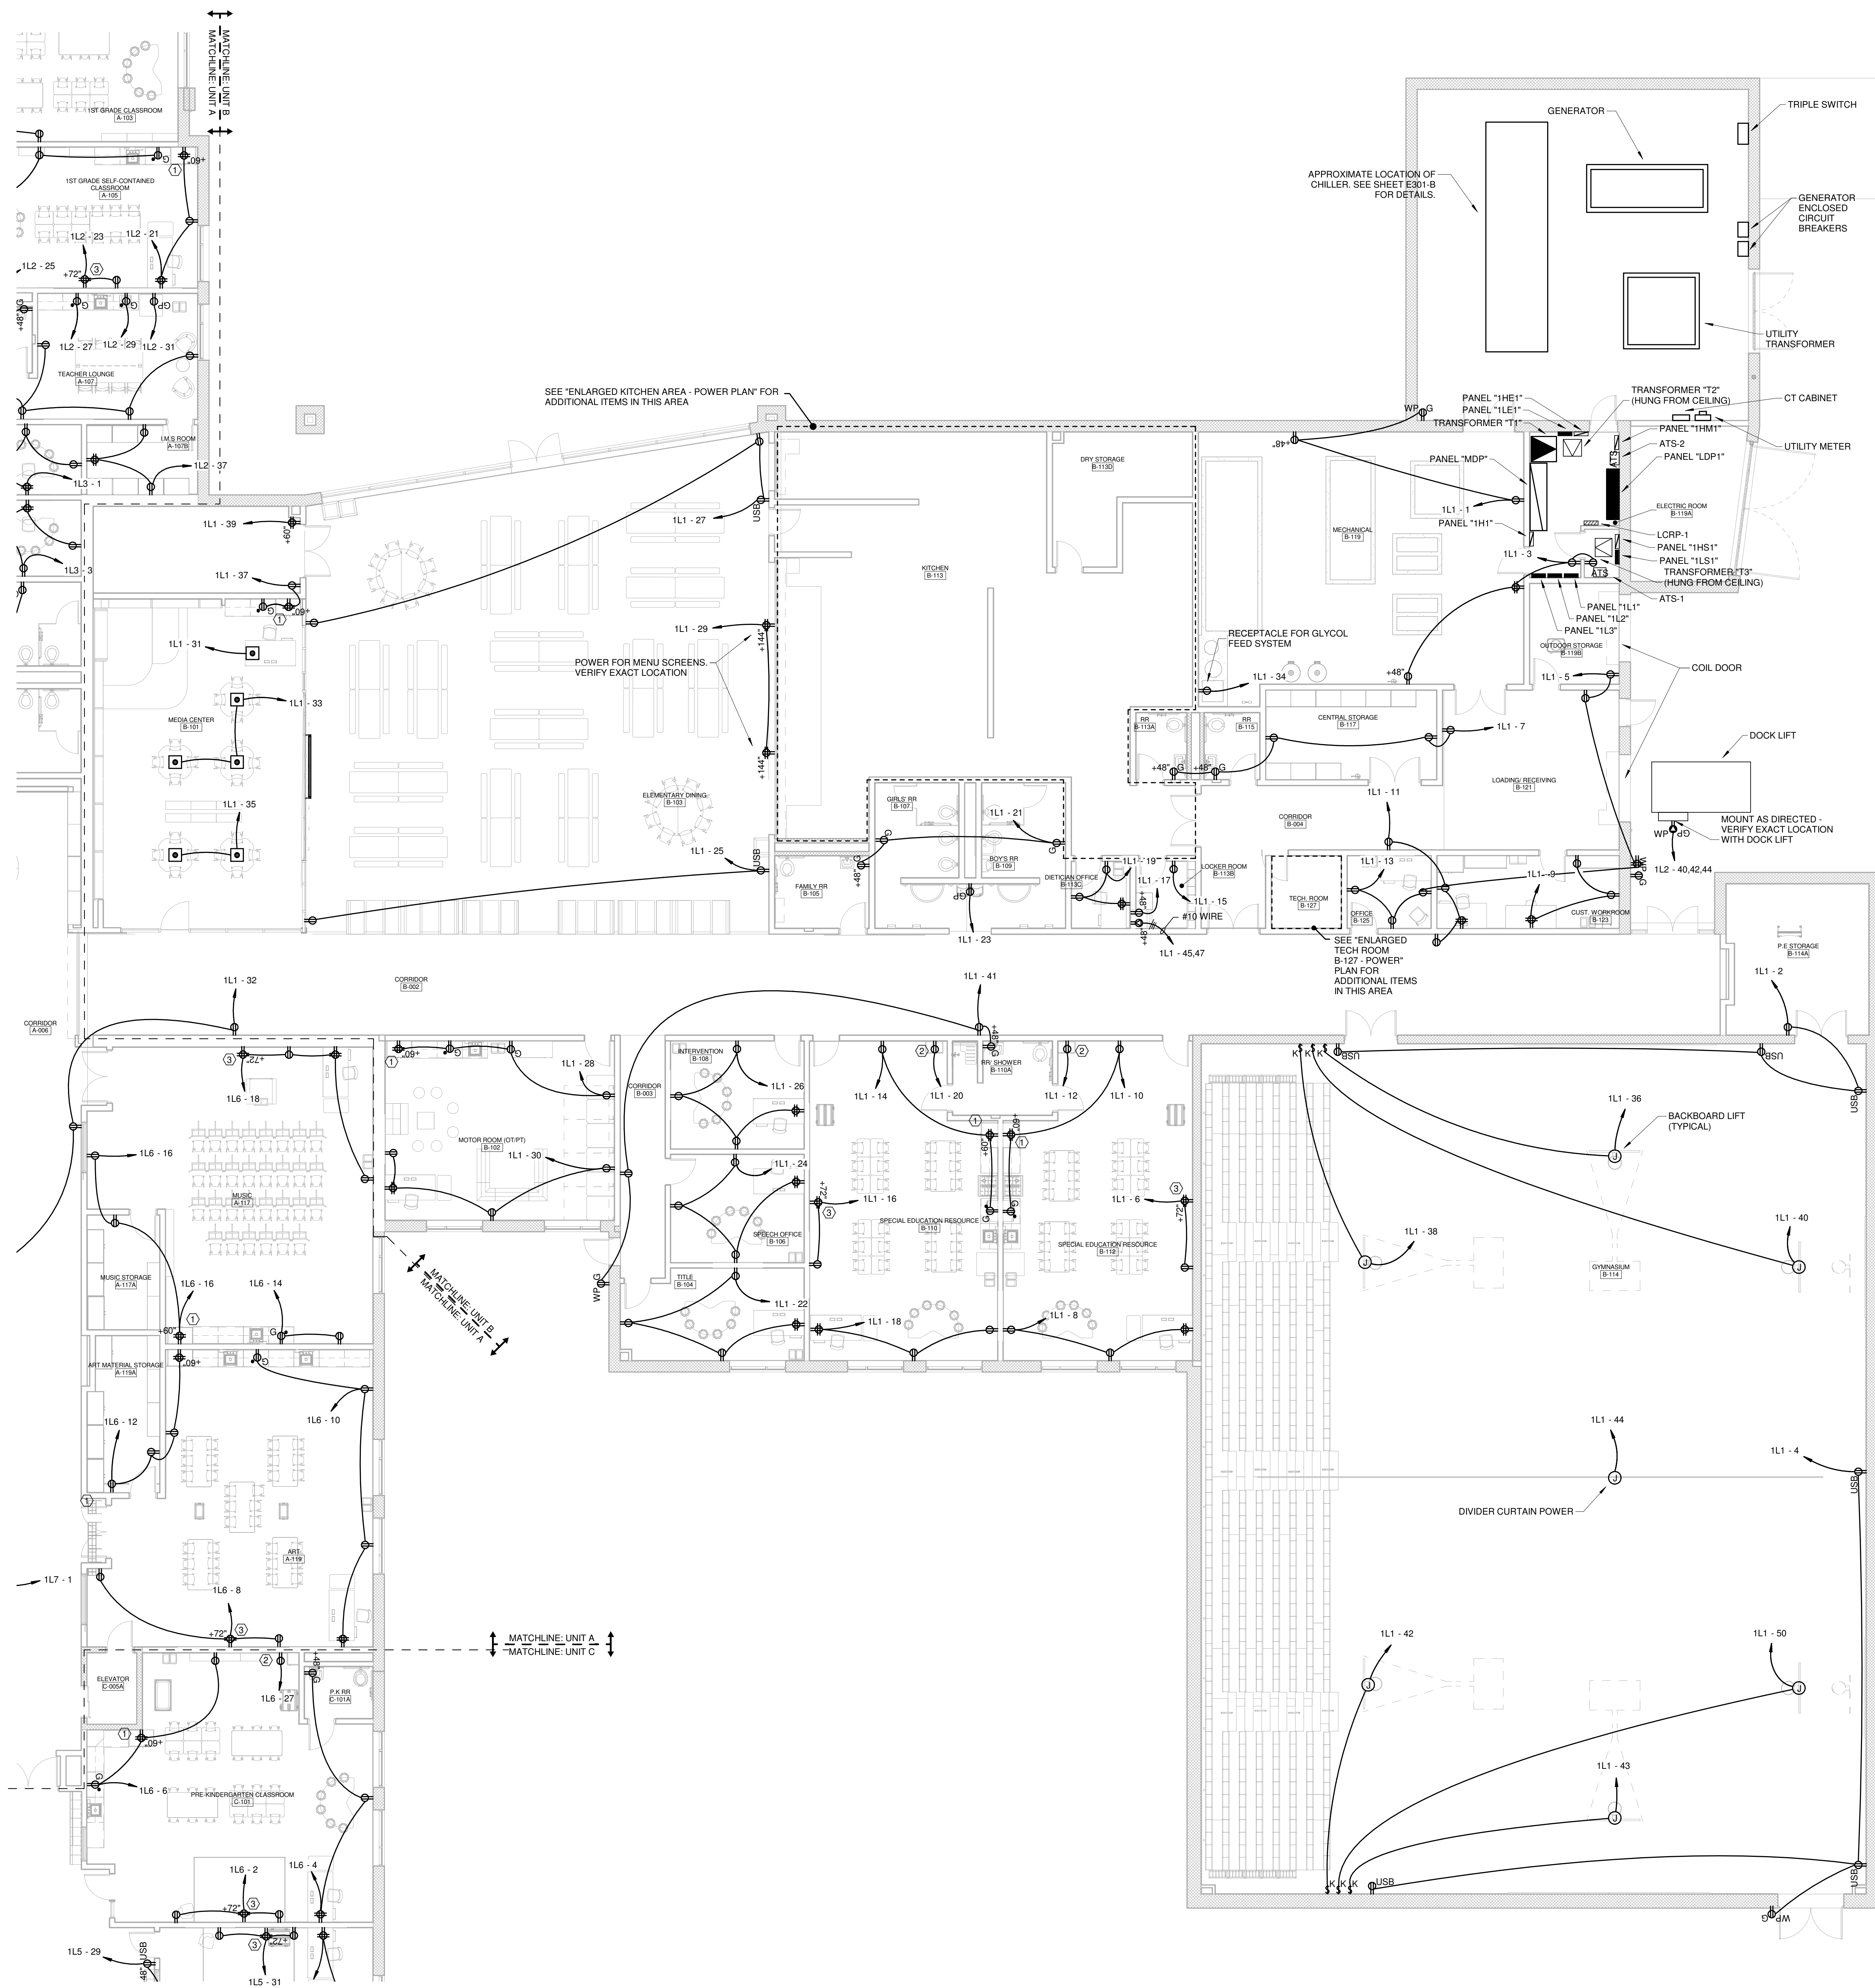

ENLARGED TECH ROOM B-127 - POWER  
SCALE: 1/4" = 1'-0"

Hex Notes

- ① MOUNT INSIDE TEACHERS CABINET AT APPROXIMATELY 60" AFF. COORDINATE LOCATION.
- ② RECEPTACLE FOR CHARGING CART. VERIFY EXACT LOCATION PRIOR TO ROUGH-IN
- ③ RECEPTACLE FOR WALL MOUNTED TELEVISION. VERIFY EXACT HEIGHT AND LOCATION PRIOR TO ROUGH-IN SO THAT RECEPTACLE IS HIDDEN BEHIND TELEVISION.

FIRST FLOOR PLAN - POWER - UNIT B  
SCALE: 1/8" = 1'-0"

PROJECT NO  
2203-2

ARCHITECTURAL VISION GROUP, LTD  
PLANNERS  
ARCHITECTS  
CLEVELAND, OHIO 44145  
23850 SPERRY DRIVE

PROFESSIONAL SEAL  
STATE OF OHIO  
TIMOTHY  
PROFESSIONAL

J.M. VERSTOLK, INC.  
CONSULTING ENGINEERS  
1700 BALTIMORE ROAD  
COLUMBUS, OHIO 43260

MASSILLON CITY SCHOOLS  
MASSILLON EAST ELEMENTARY PK-3  
1 PAULE BROWN DRIVE SE, MASSILLON, OHIO 44646  
MASSILLON CITY SCHOOL DISTRICT MASSILLON, OHIO

| DATE     | ISSUED FOR | DESCRIPTION |
|----------|------------|-------------|
| 07/12/23 | ISSUED FOR | ISSUED FOR  |

PROJECT NO  
2203-2  
DRAWN BY  
WAM  
CHECKED BY  
TJC  
DATE  
07/12/23

FIRST FLOOR  
PLAN - POWER -  
UNIT B  
SCALE: As Indicated  
SHEET NO  
E-201-B