



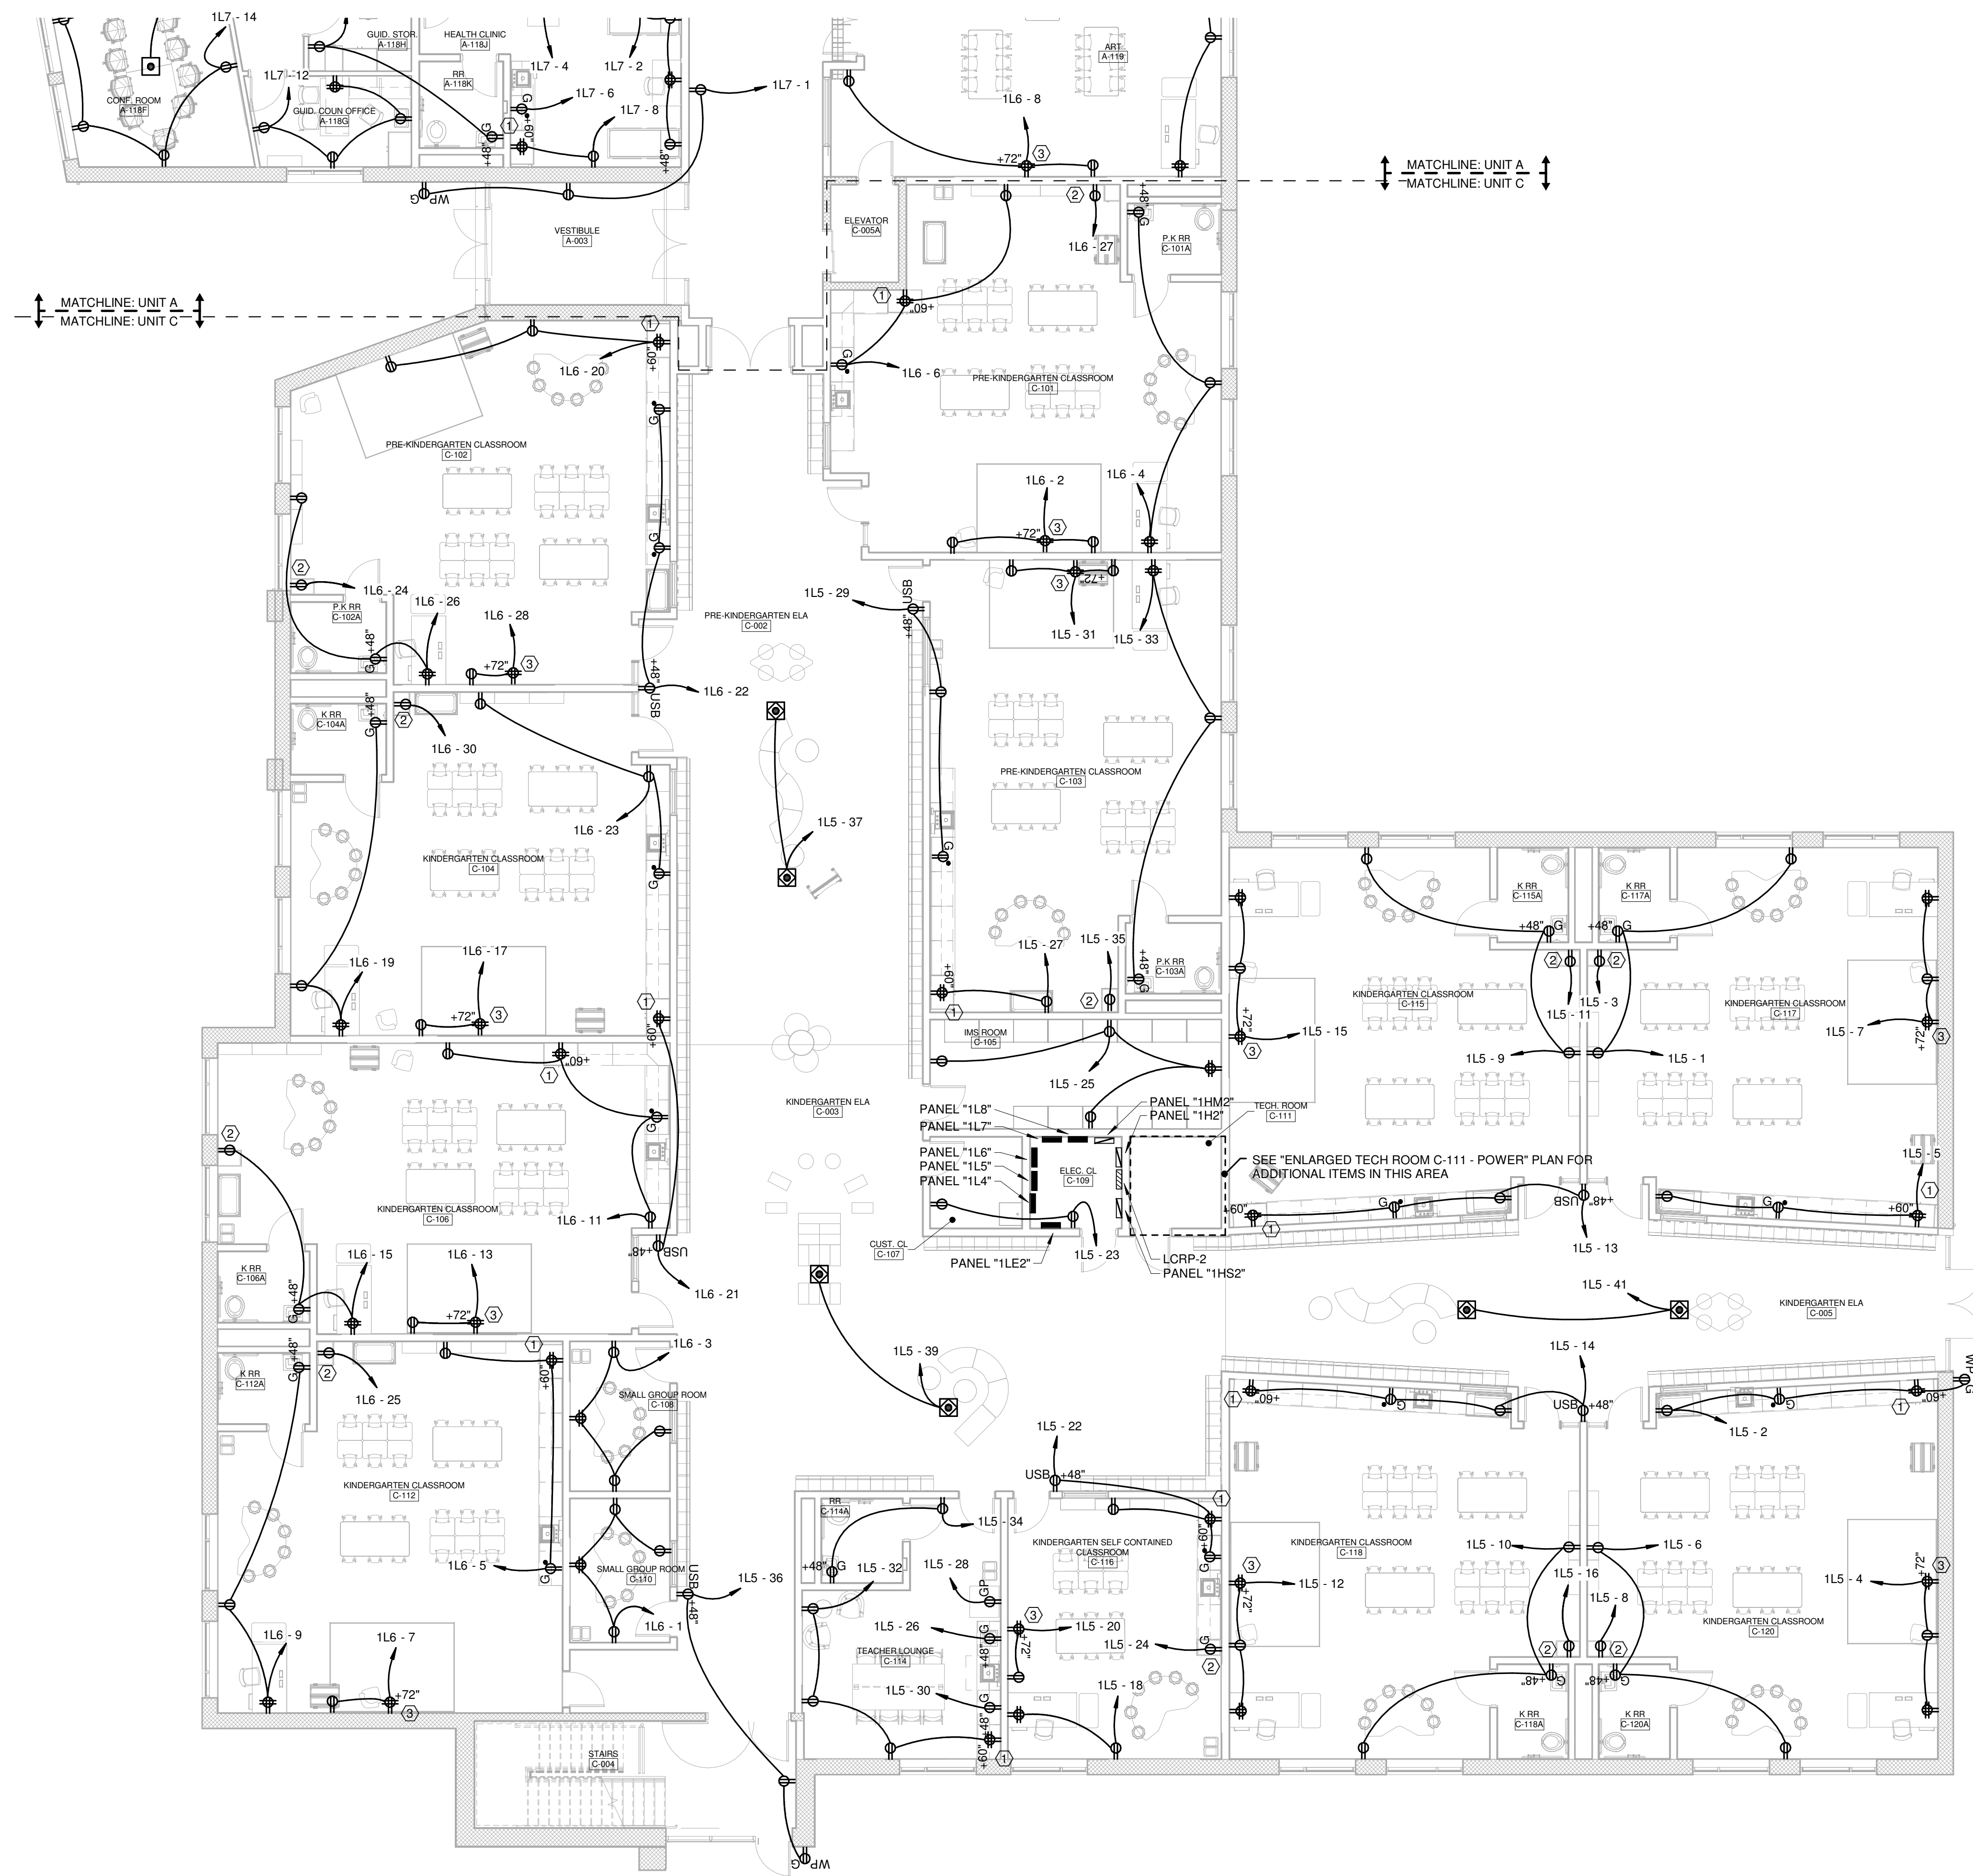


FIRST FLOOR PLAN - POWER - UNIT C
SCALE: 1/8" = 1'-0"

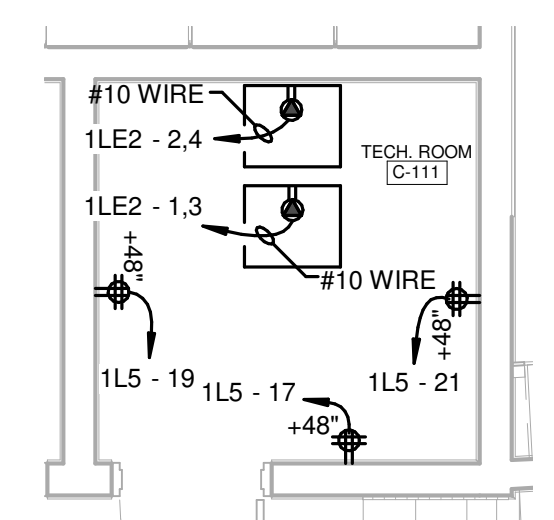

ENLARGED TECH ROOM C-111 - POWER
SCALE: 1/4" = 1'-0"


Hex Notes

- ① MOUNT INSIDE TEACHERS CABINET AT APPROXIMATELY 60" AFF. COORDINATE LOCATION.
- ② RECEPTACLE FOR CHARGING CART. VERIFY EXACT LOCATION PRIOR TO ROUGH-IN
- ③ RECEPTACLE FOR WALL MOUNTED TELEVISION. VERIFY EXACT HEIGHT AND LOCATION PRIOR TO ROUGH-IN SO THAT RECEPTACLE IS HIDDEN BEHIND TELEVISION.

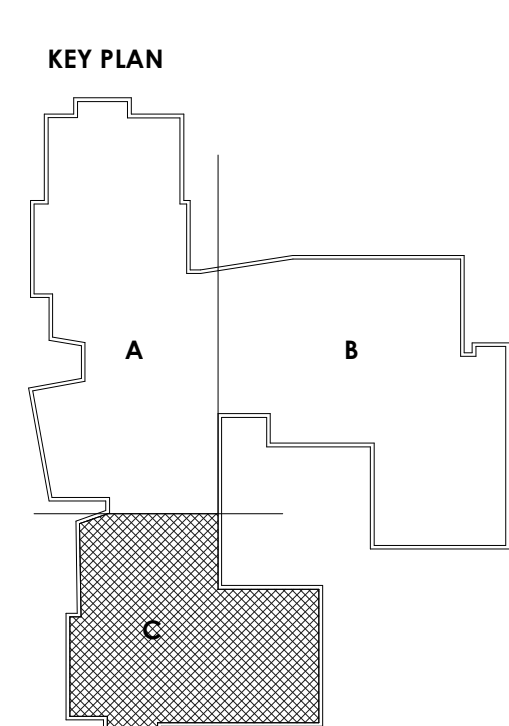

PROJECT NO
2203-2

ARCHITECTURAL VISION GROUP, LTD
ARCHITECTS
23850 SPERRY DRIVE
CLEVELAND, OHIO 44145

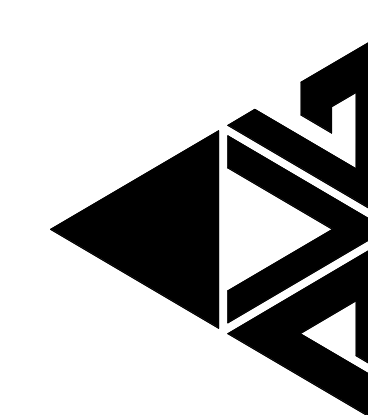

STATE OF OHIO
TIMOTHY
PROFESSIONAL

MASSILLON CITY SCHOOLS
MASSILLON EAST ELEMENTARY PK-3
1 PAULE BROWN DRIVE SE, MASSILLON, OHIO 44646
MASSILLON CITY SCHOOL DISTRICT MASSILLON, OHIO

DATE	ISSUED BY	DESCRIPTION
07/12/23	WAM	ISSUED AS

PROJECT NO
2203-2
DRAWN BY
WAM
CHECKED BY
TJC
DATE
07/12/23

FIRST FLOOR
PLAN - POWER -
UNIT C
SCALE: As indicated
SHEET NO
E-201-C