


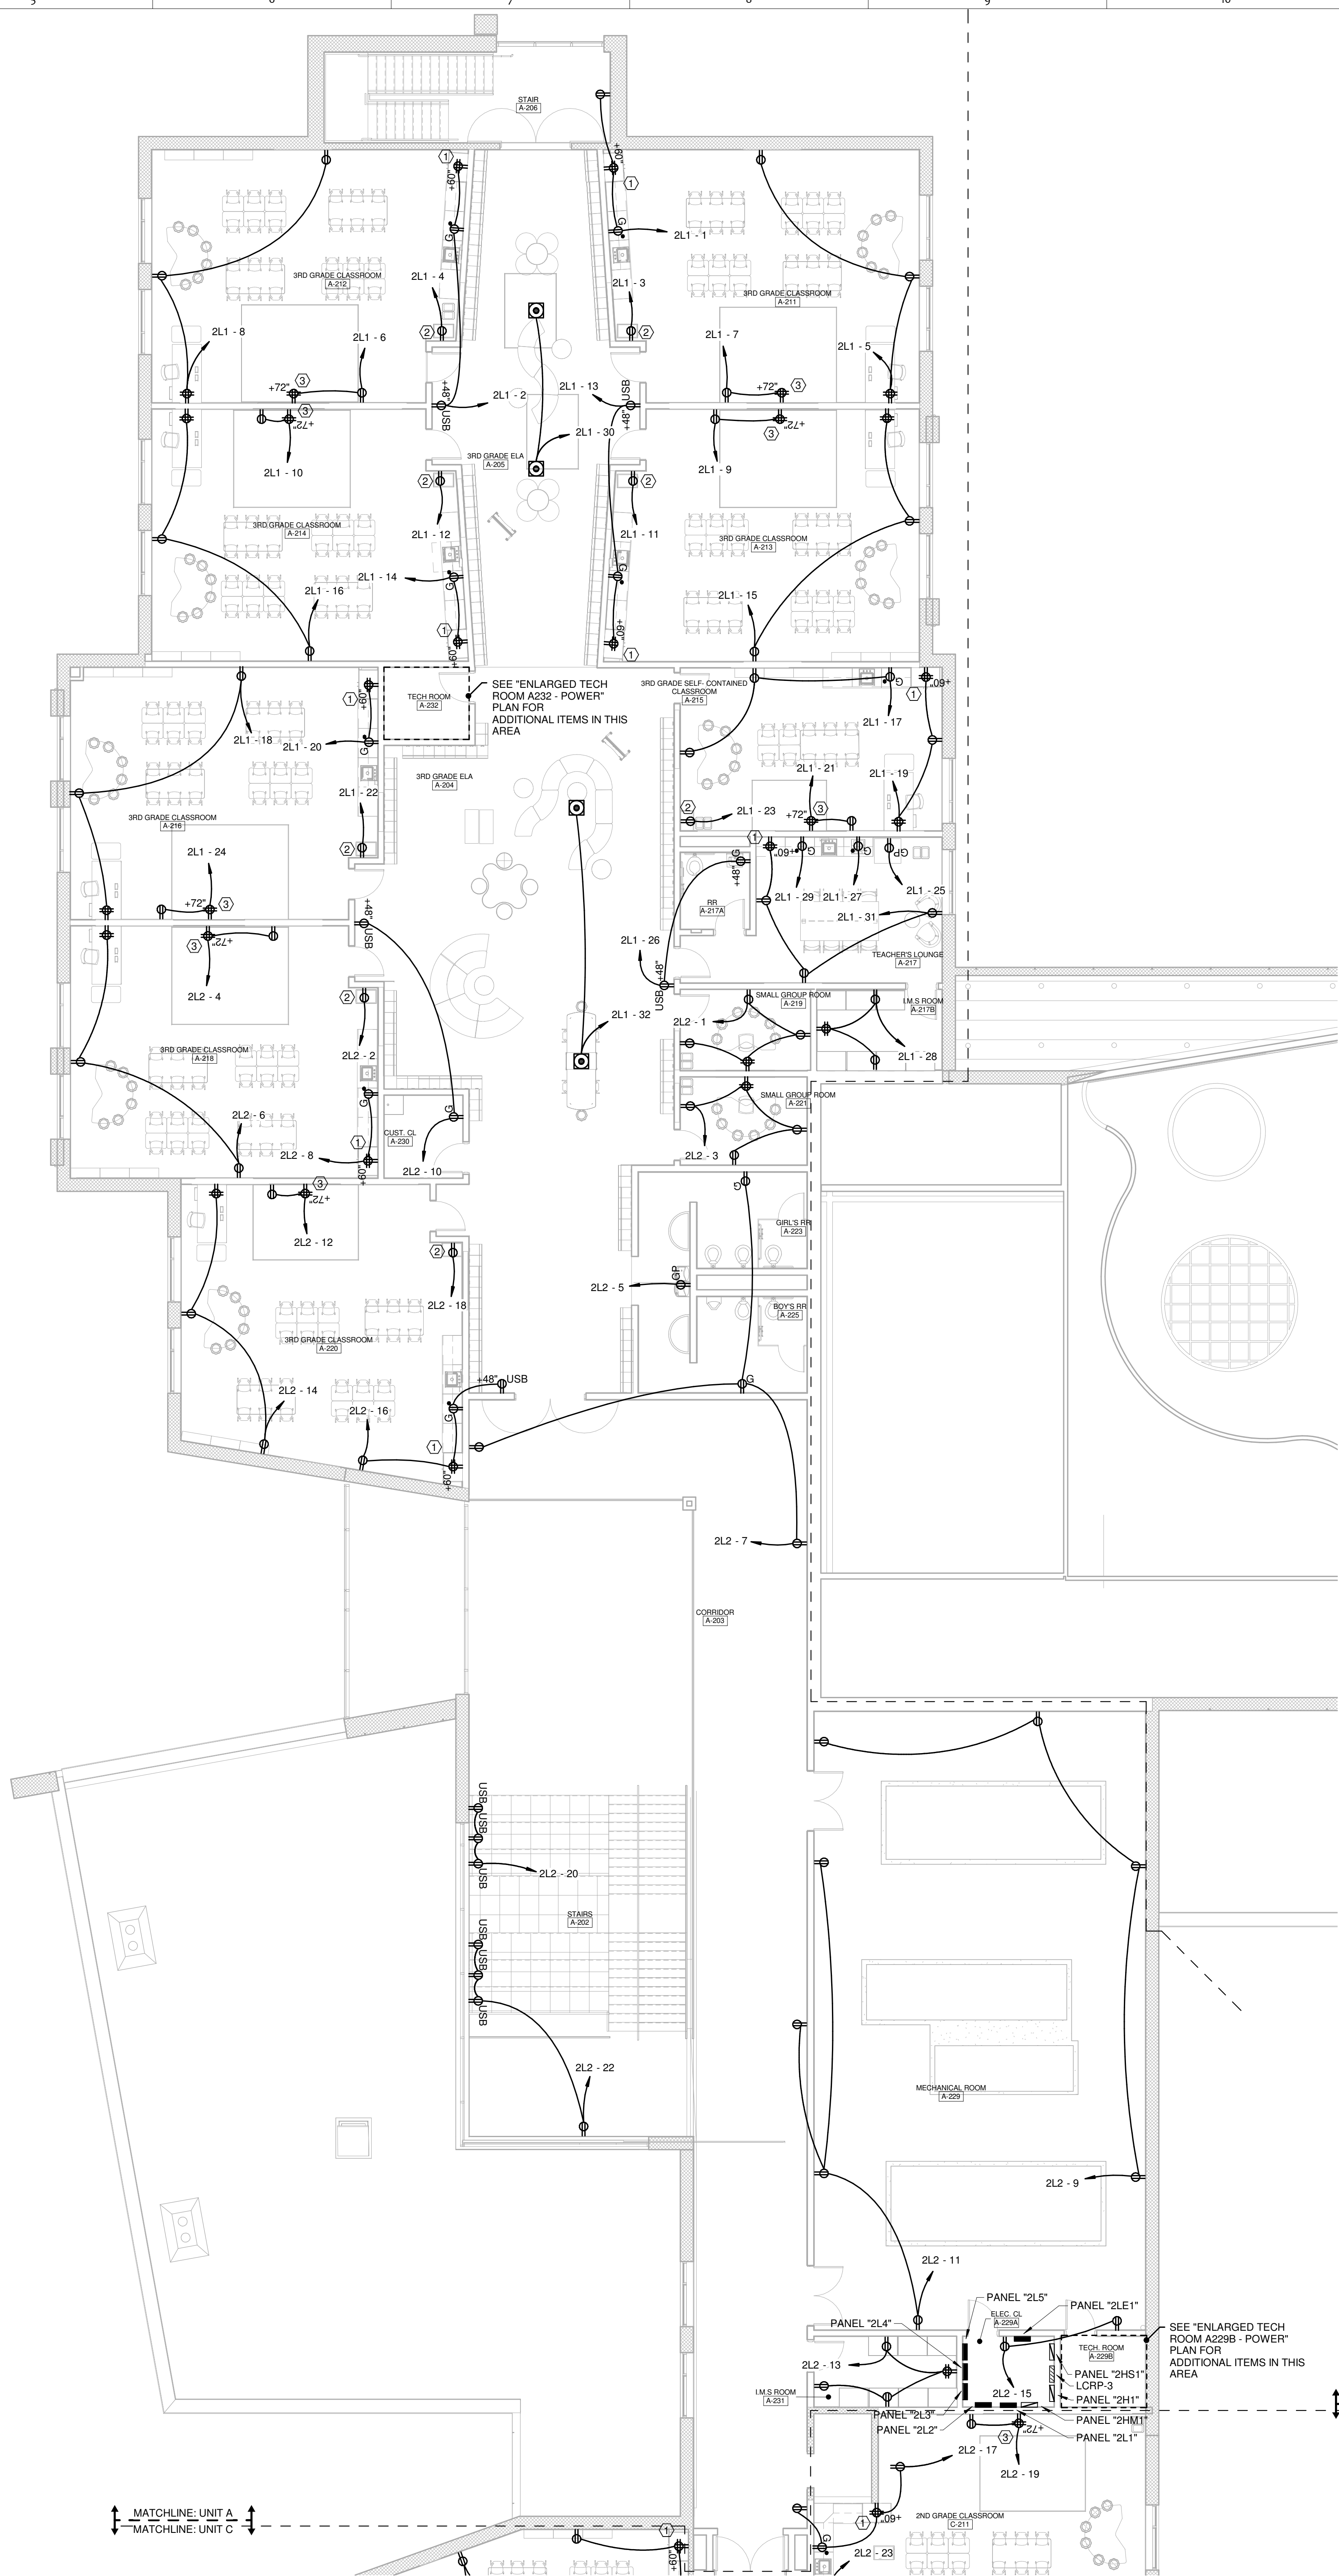

SECOND FLOOR PLAN - POWER - UNIT A
SCALE: 1/8" = 1'-0"


ENLARGED TECH ROOM A-229B - POWER
SCALE: 1/4" = 1'-0"

ENLARGED TECH ROOM A-232 - POWER
SCALE: 1/4" = 1'-0"

Hex Notes

- ① MOUNT INSIDE TEACHERS CABINET AT APPROXIMATELY 60" AFF. COORDINATE LOCATION.
- ② RECEPTACLE FOR CHARGING CART. VERIFY EXACT LOCATION PRIOR TO ROUGH-IN
- ③ RECEPTACLE FOR WALL MOUNTED TELEVISION. VERIFY EXACT HEIGHT AND LOCATION PRIOR TO ROUGH-IN SO THAT RECEPTACLE IS HIDDEN BEHIND TELEVISION.

KEY PLAN

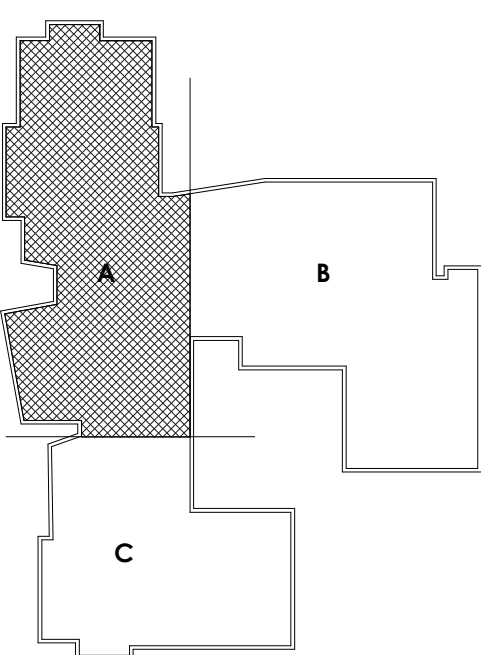

PROJECT NO
2203-2

ARCHITECTURAL VISION GROUP, LTD
ARCHITECTS
23850 SPERRY DRIVE
CLEVELAND, OHIO 44145

PLANNERS

PROFESSIONAL SEAL
STATE OF OHIO
TIMOTHY COV
ELECTRICAL
PROFESSIONAL

J.M. VEROSTKINE, INC.
CONSULTING ENGINEERS
1700 BALTIMORE ROAD
TOLEDO, OHIO 44115

MASSILLON CITY SCHOOLS
MASSILLON EAST ELEMENTARY PK-3
1 PAULE BROWN DRIVE SE, MASSILLON, OHIO 44646
MASSILLON CITY SCHOOL DISTRICT MASSILLON, OHIO

DATE	ISSUED BY	DESCRIPTION
07/12/23	WAM	ISSUED AS

PROJECT NO
2203-2
DRAWN BY
WAM
CHECKED BY
TJC
DATE
07/12/23

SECOND FLOOR
PLAN - POWER-
UNIT A
SCALE: As Indicated
SHEET NO
E-202-A