



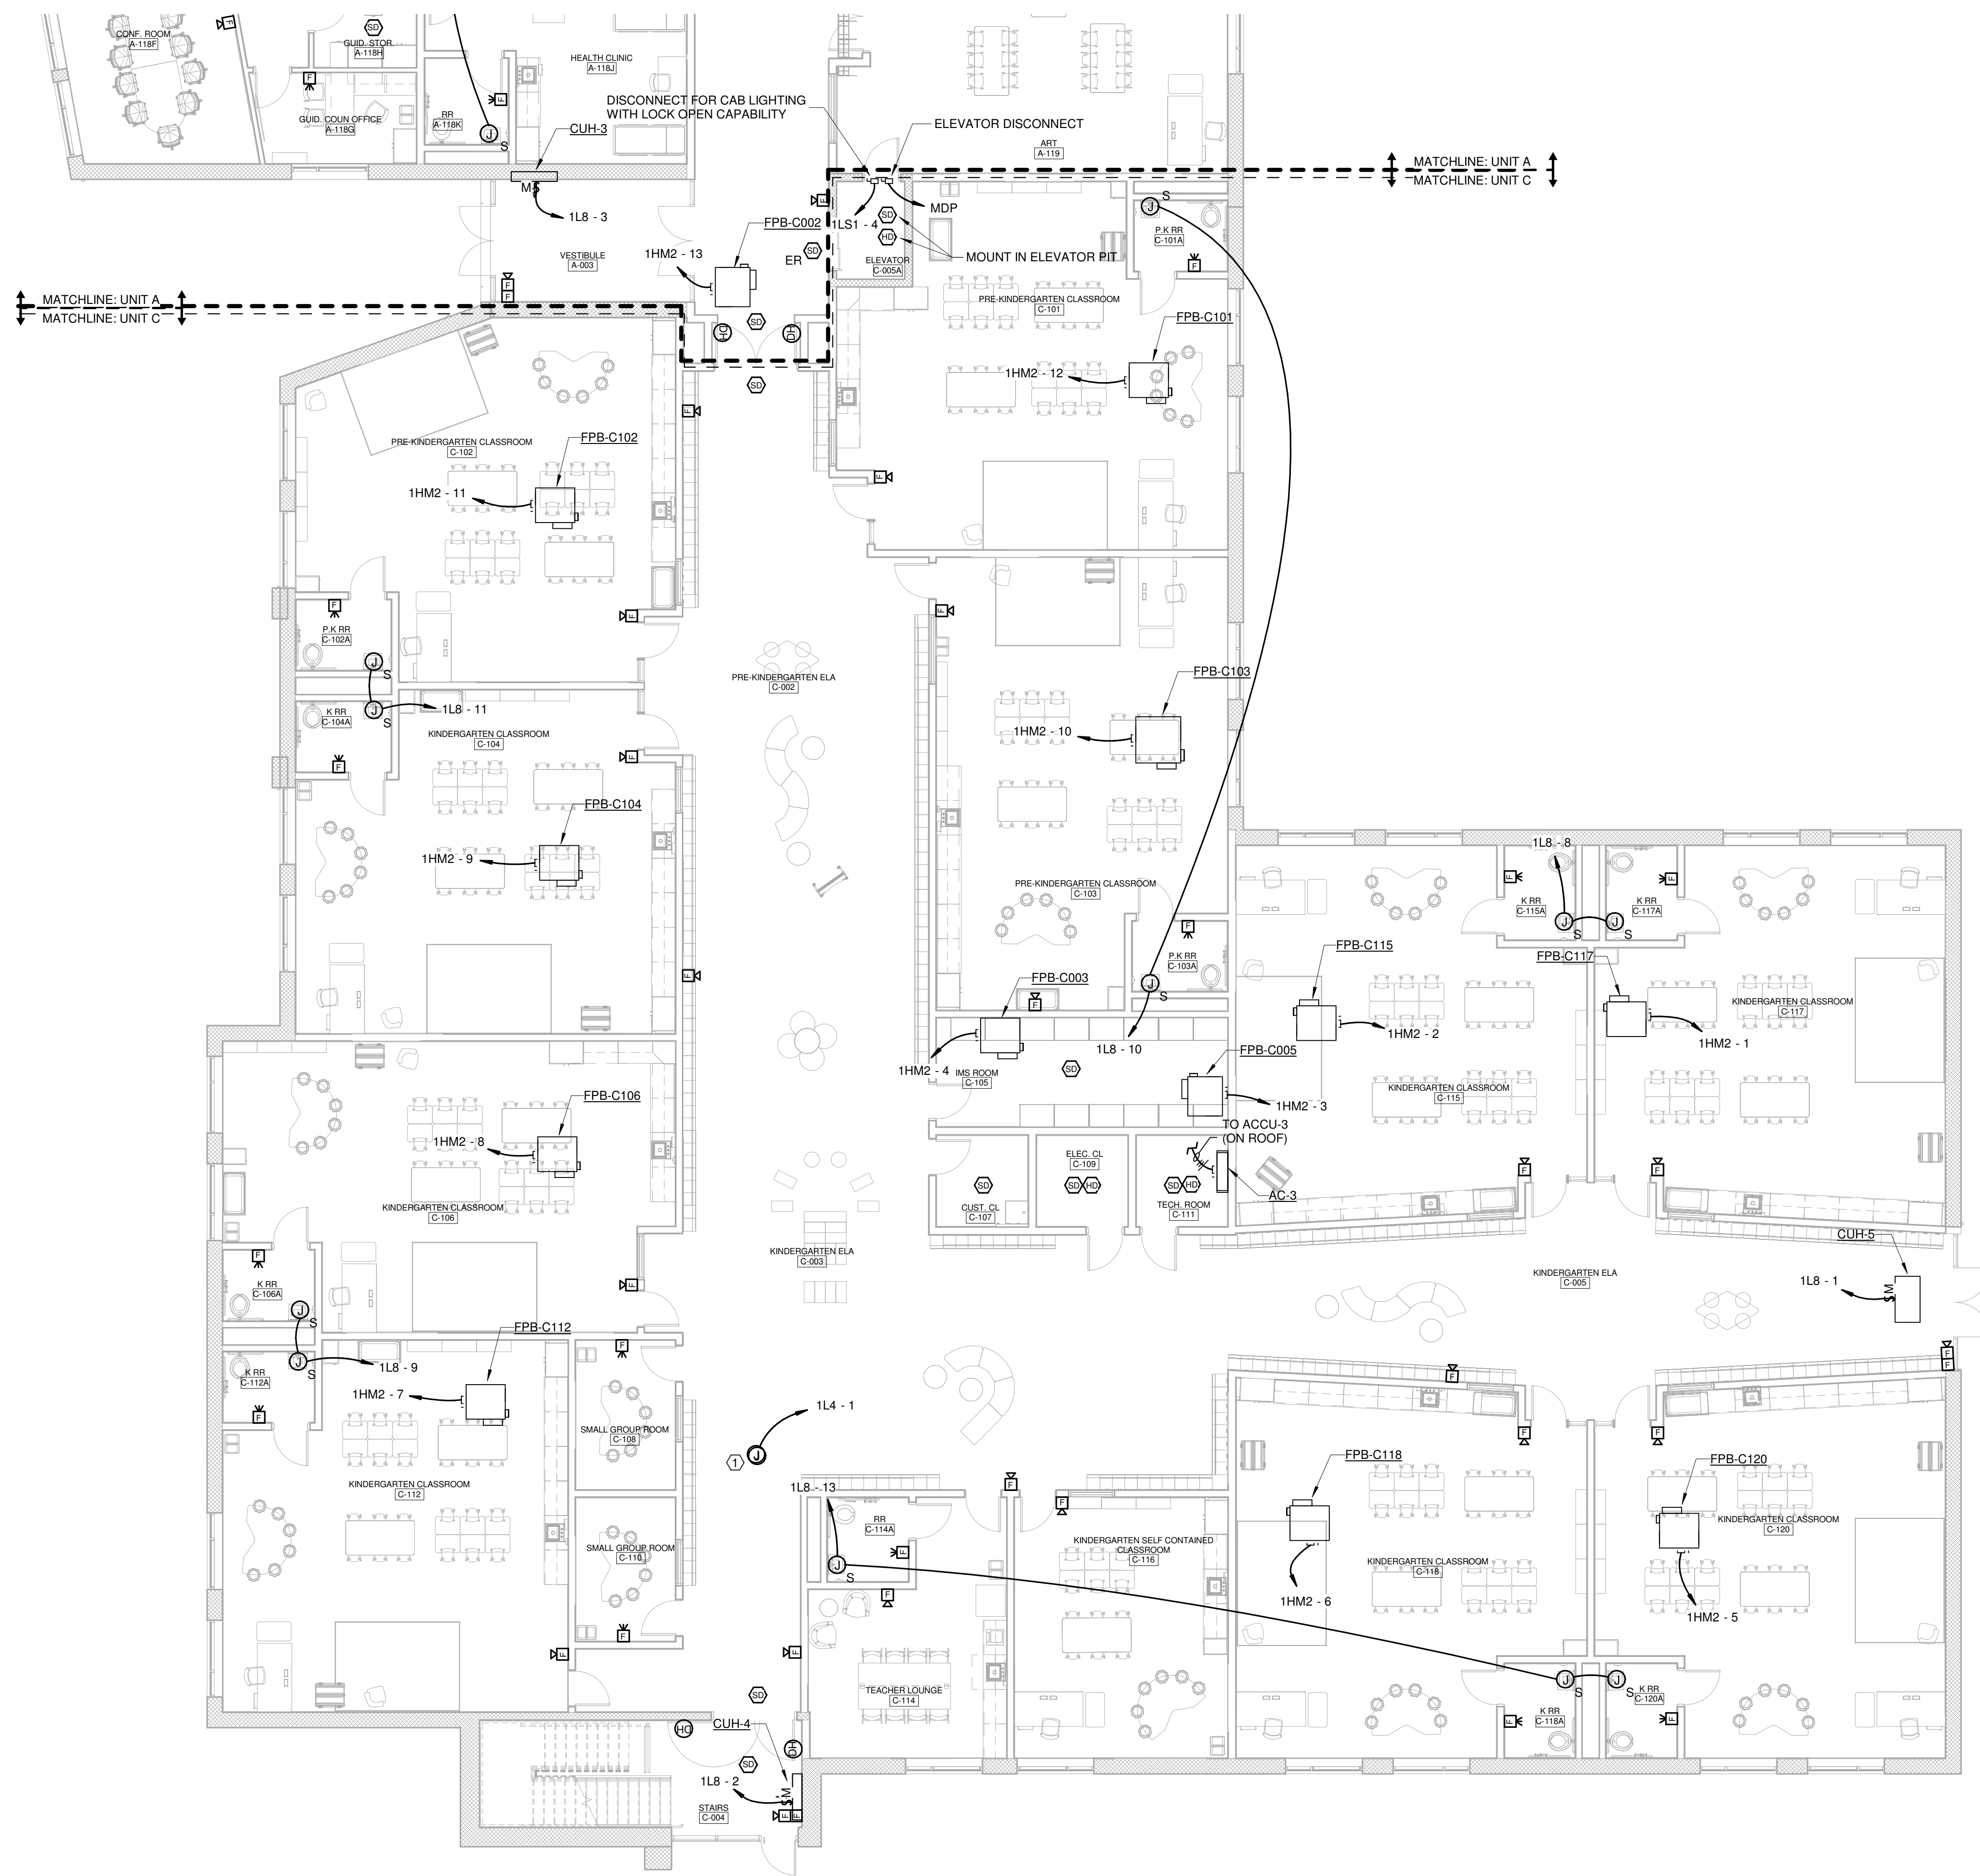

FIRST FLOOR PLAN - SYSTEMS - UNIT C
SCALE: 1/8" = 1'-0"



Hex Notes

- ① JUNCTION BOX ABOVE ACCESSIBLE
CEILING FOR TEMPERATURE CONTROL
CONTRACTOR'S USE.

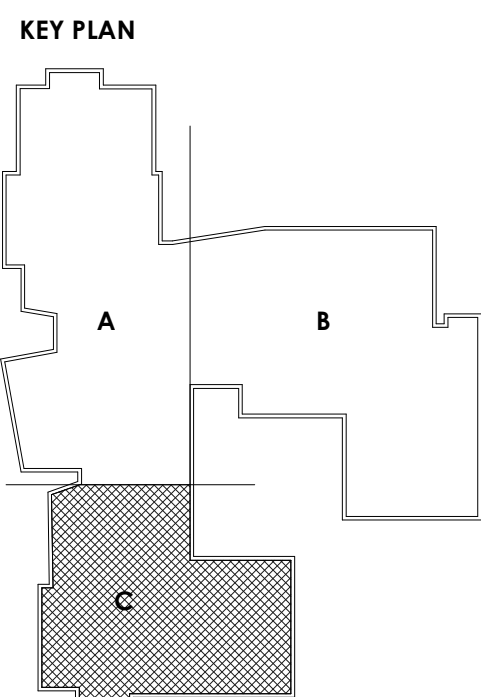

PROJECT NO
2203-2

ARCHITECTURAL VISION GROUP, LTD
ARCHITECTS
PLANNERS
23850 SPERRY DRIVE
CLEVELAND, OHIO 44145

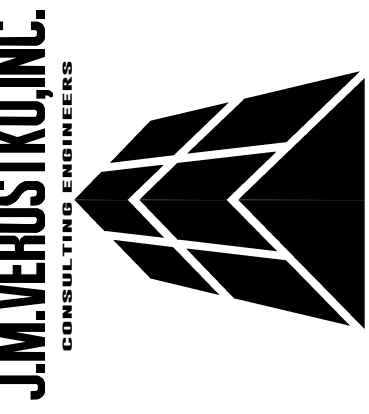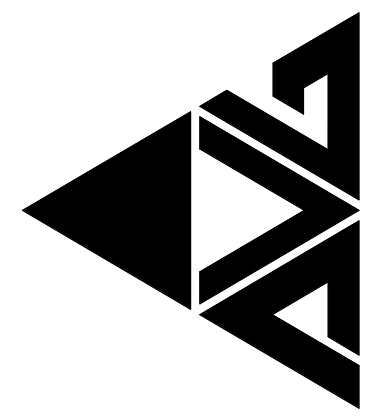

MASSILLON CITY SCHOOLS
MASSILLON EAST ELEMENTARY PK-3
1 PAULE BROWN DRIVE SE, MASSILLON, OHIO 44846
MASSILLON CITY SCHOOL DISTRICT MASSILLON, OHIO

NO.	DATE	DESCRIPTION
07/12/23	ISSUE BID / PERMITS SET	
07/12/23	ISSUED AS:	

PROJECT NO 2203-2
DRAWN BY WAM
CHECKED BY TJC
DATE 07/12/23

FIRST FLOOR
PLAN - SYSTEMS
- UNIT C
SCALE: 1/8" = 1'-0"
SHEET NO
E-301-C