

GENERAL SHEET NOTES


1. REFER TO DRAWING T-001 FOR ADDITIONAL INFORMATION.

CODED PLAN NOTES

1. APPROXIMATE LOCATION OF OWNER PROVIDED LU PROJECTOR AND ASSOCIATED SOUND SYSTEM (WIC PART OF DISTRICT LFL).
2. APPROXIMATE LOCATION OF FACEPLATE FOR PROJECTOR CPU (HEART). CONTRACTOR SHALL VERIFY EXACT LOCATION IN FIELD WITH OWNER AND OWNERS LU PROJECTOR CONTRACTOR PRIOR TO ROUGH-IN. APPROXIMATE MOUNTING HEIGHT - 12' AFF.
3. FOR SCORERS TABLE. CONTRACTOR SHALL PROVIDE A RETRACTABLE CABLING REEL TO ALLOW THE ASSOCIATED CABLING TO MOVE FREELY WHEN THE MOVABLE BLEACHERS OPEN AND CLOSE.
4. LOCATION OF GYM AV CABINET. REFER TO T-600 SERIES DRAWINGS FOR ADDITIONAL INFORMATION.
5. PROVIDE PENDANT MOUNT FOR SPEAKER.
6. PROVIDE PROJECTOR AND ASSOCIATED CEILING MOUNTED SCISSOR LIFT ATTACHED TO STRUCTURE ABOVE. VERIFY EXACT LOCATION IN FIELD WITH OTHER TRADES.

PROJECT NO
2203-2

ARCHITECTURAL VISION GROUP, LTD
PLANNERS
ARCHITECTS
23850 SPERRY DRIVE
CLEVELAND, OHIO 44145

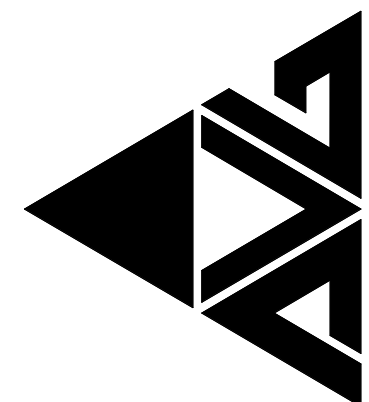


MASSILLON CITY SCHOOL DISTRICT
MASSILLON EAST ELEMENTARY PK-3
1 PAULE BROWN DRIVE SE, MASSILLON, OHIO 44646
MASSILLON CITY SCHOOL DISTRICT MASSILLON, OHIO

DATE	ISSUED AS	DESCRIPTION
07/12/23	100% BID PERMIT SET	

PROJECT NO	2203-2
DRAWN BY	DRK
CHECKED BY	AMW
DATE	07/12/23

FIRST FLOOR
TECHNOLOGY
PLAN - UNIT B

SCALE: 1/8" = 1'-0"
SHEET NO
T-201B

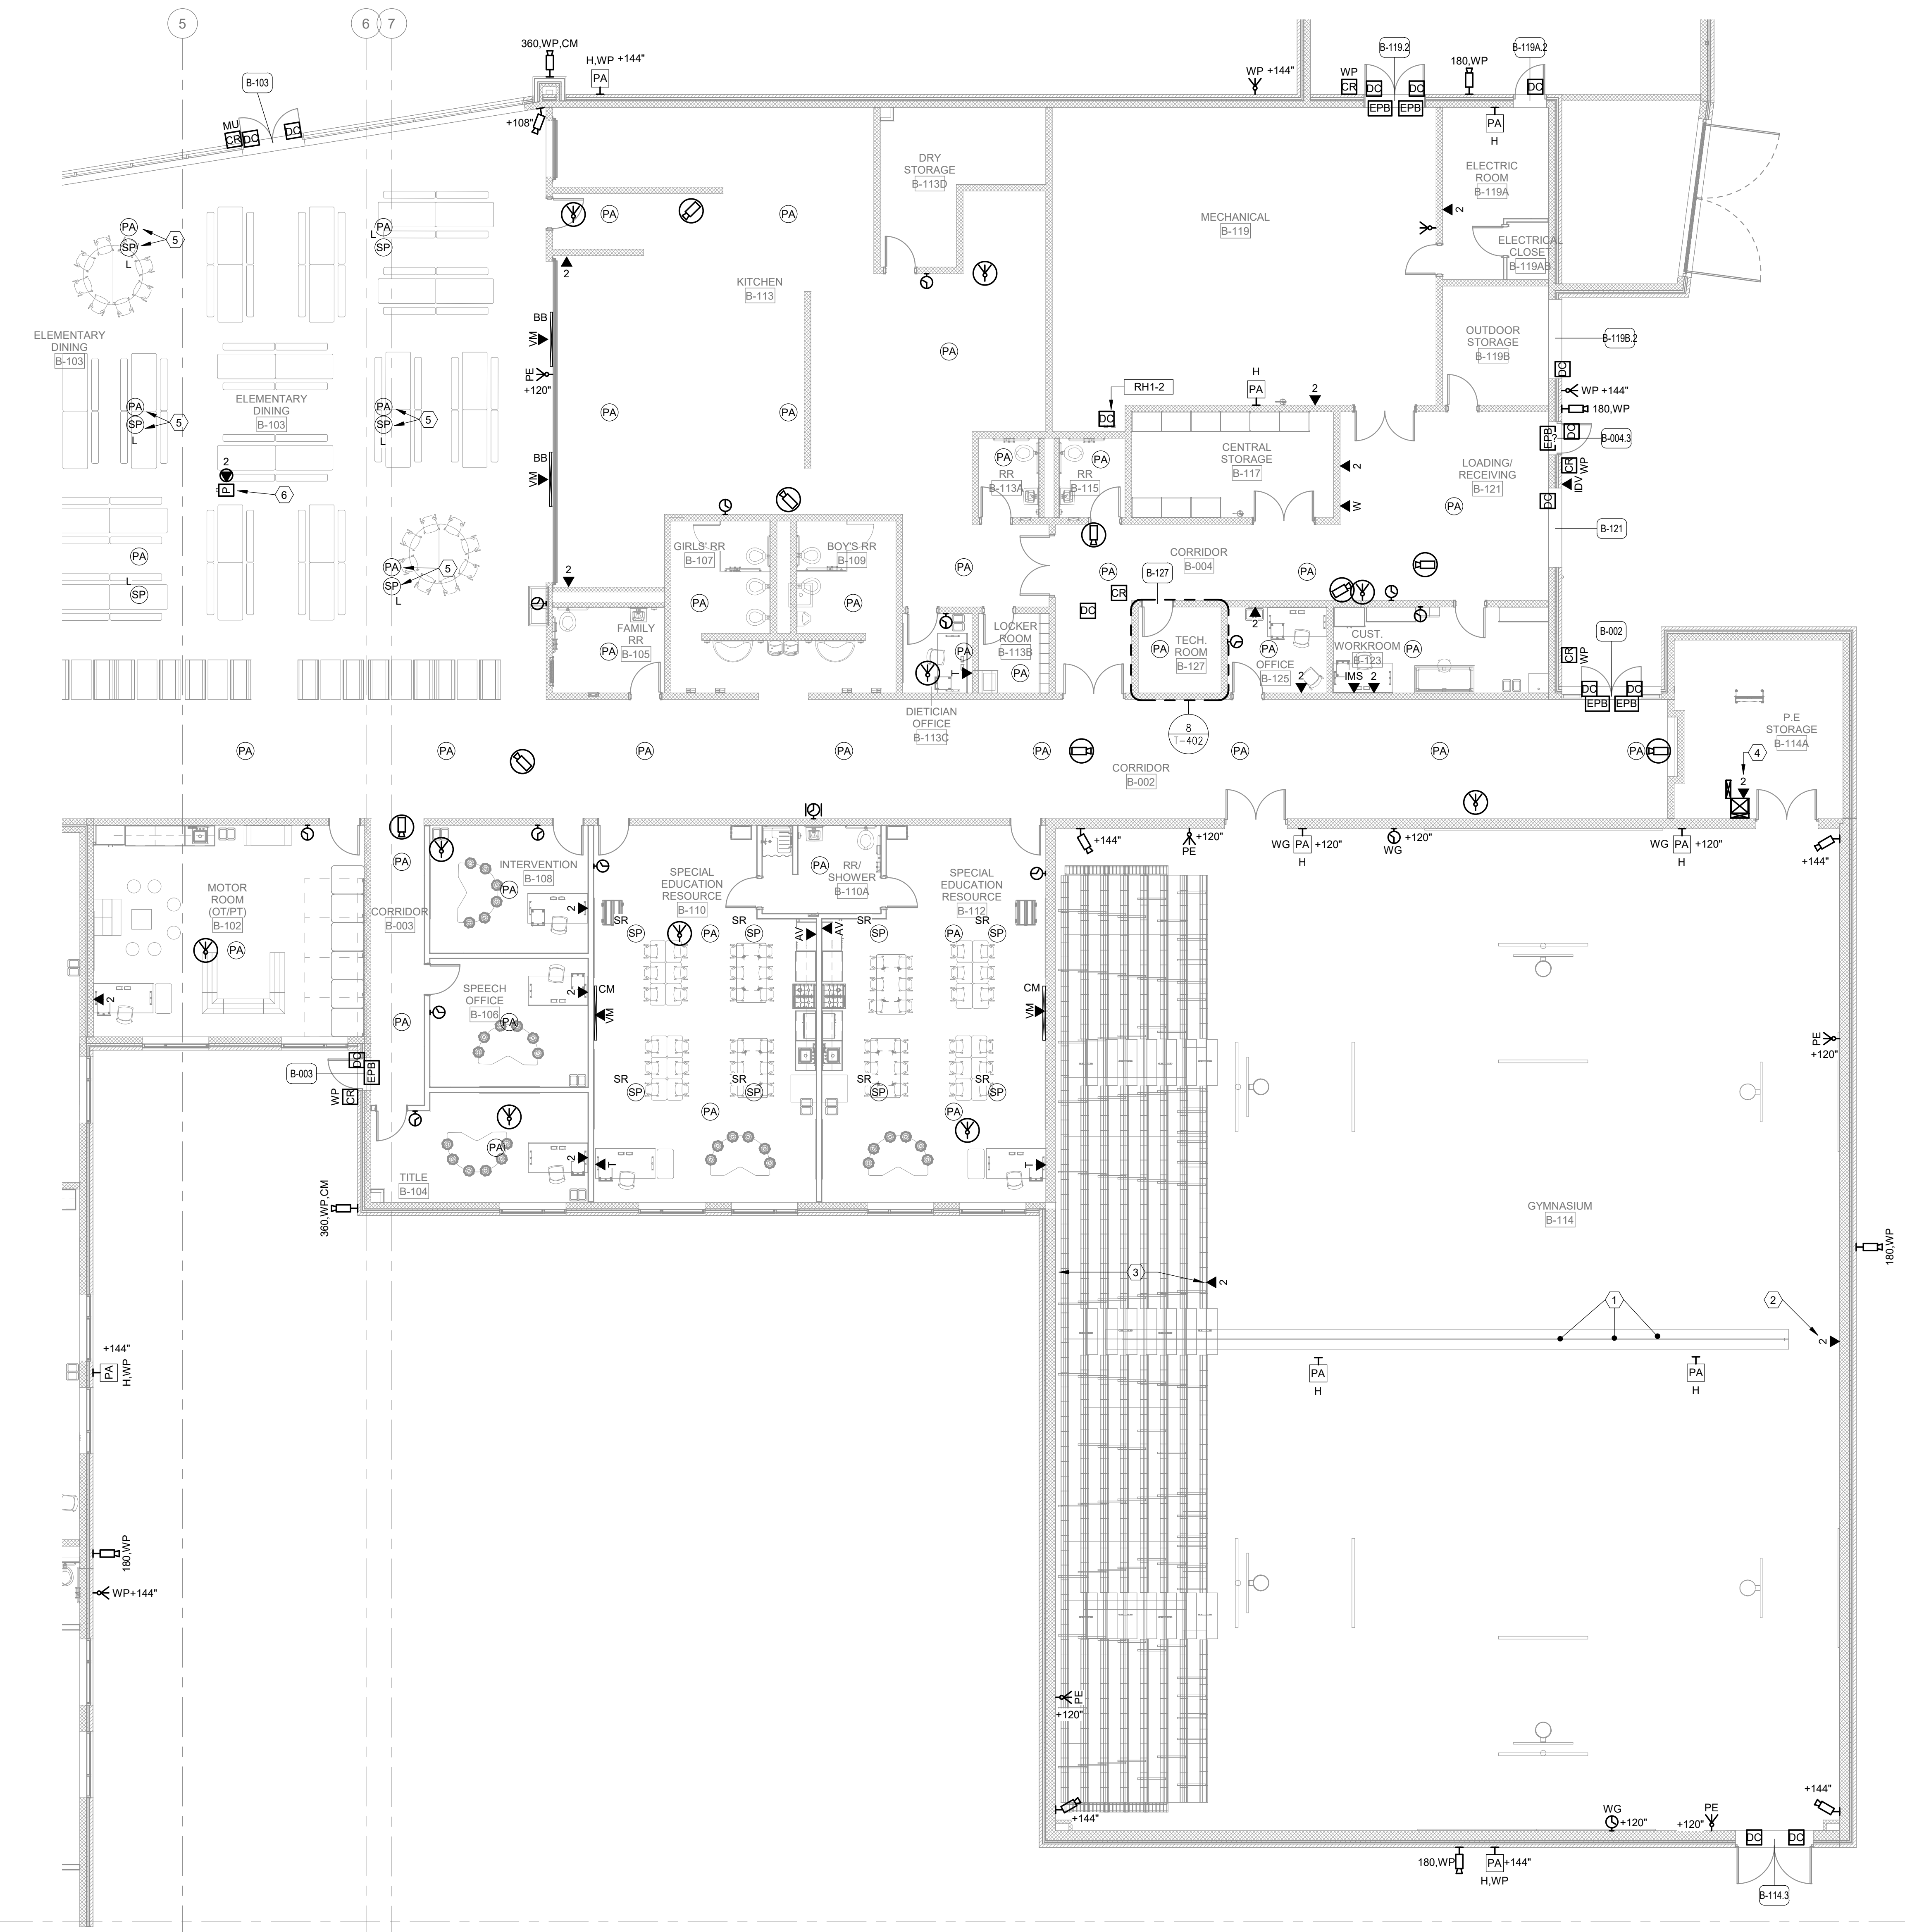

1 LEVEL 1 - TECHNOLOGY PLAN - UNIT B
SCALE: 1/8" = 1'-0"

