


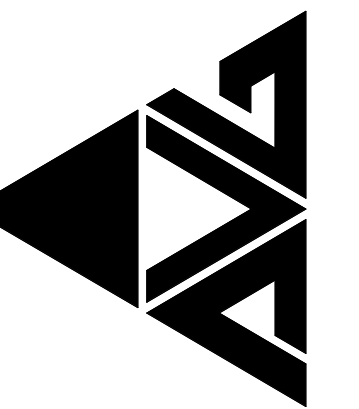

OSBORN
ENGINEERING
1100 Superior Avenue • Suite 300 | Cleveland, OH 44114
216.867.2020 www.osborn-eng.com

MASSILLON EAST ELEMENTARY PK-3
MASSILLON CITY SCHOOL DISTRICT

1 PAUL E BROWN DRIVE SE, MASSILLON, OHIO 44646

MASSILLON CITY SCHOOL DISTRICT MASSILLON, OHIO


[illegible]

PROJECT NO	2203-2
DRAWN BY	DRK
CHECKED BY	AMW
DATE	07/12/23

FIRST FLOOR
TECHNOLOGY
LAN - UNIT C

SCALE: 1/8" = 1'-0"

SHEET NO
T-201C

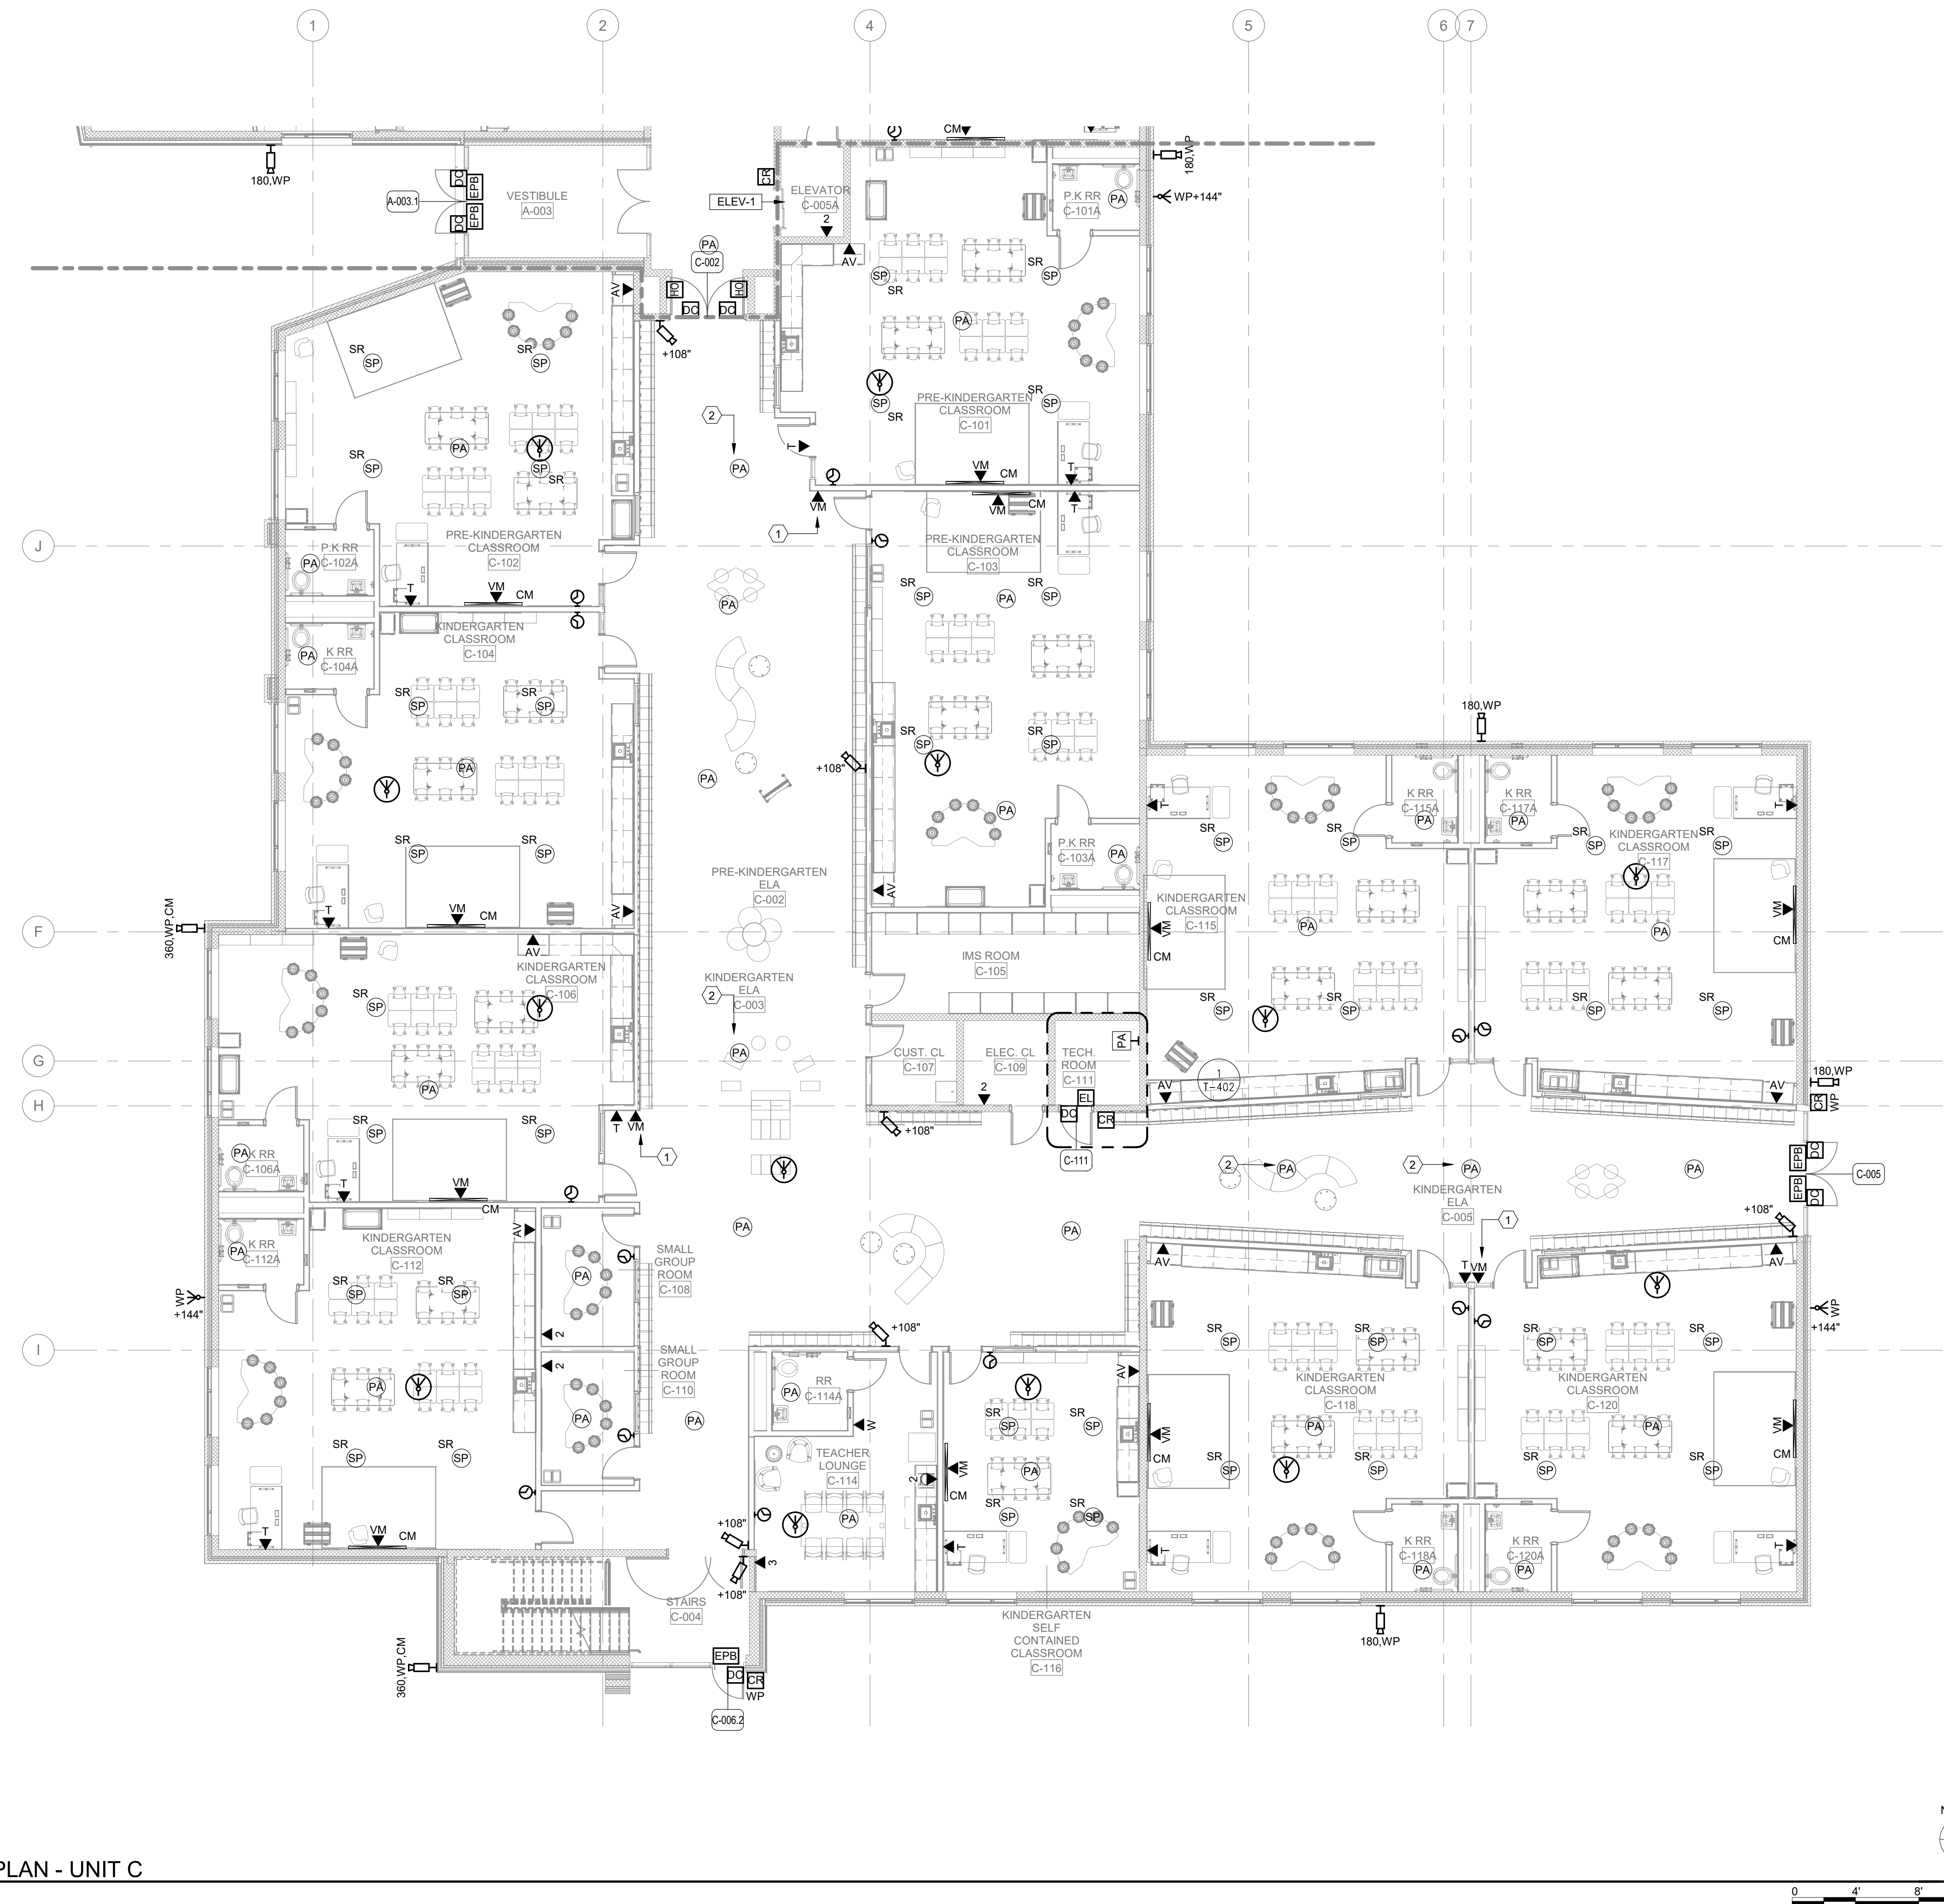

1 LEVEL 1 - TECHNOLOGY PLAN - UNIT C
SCALE: 1/8" = 1'-0"

