


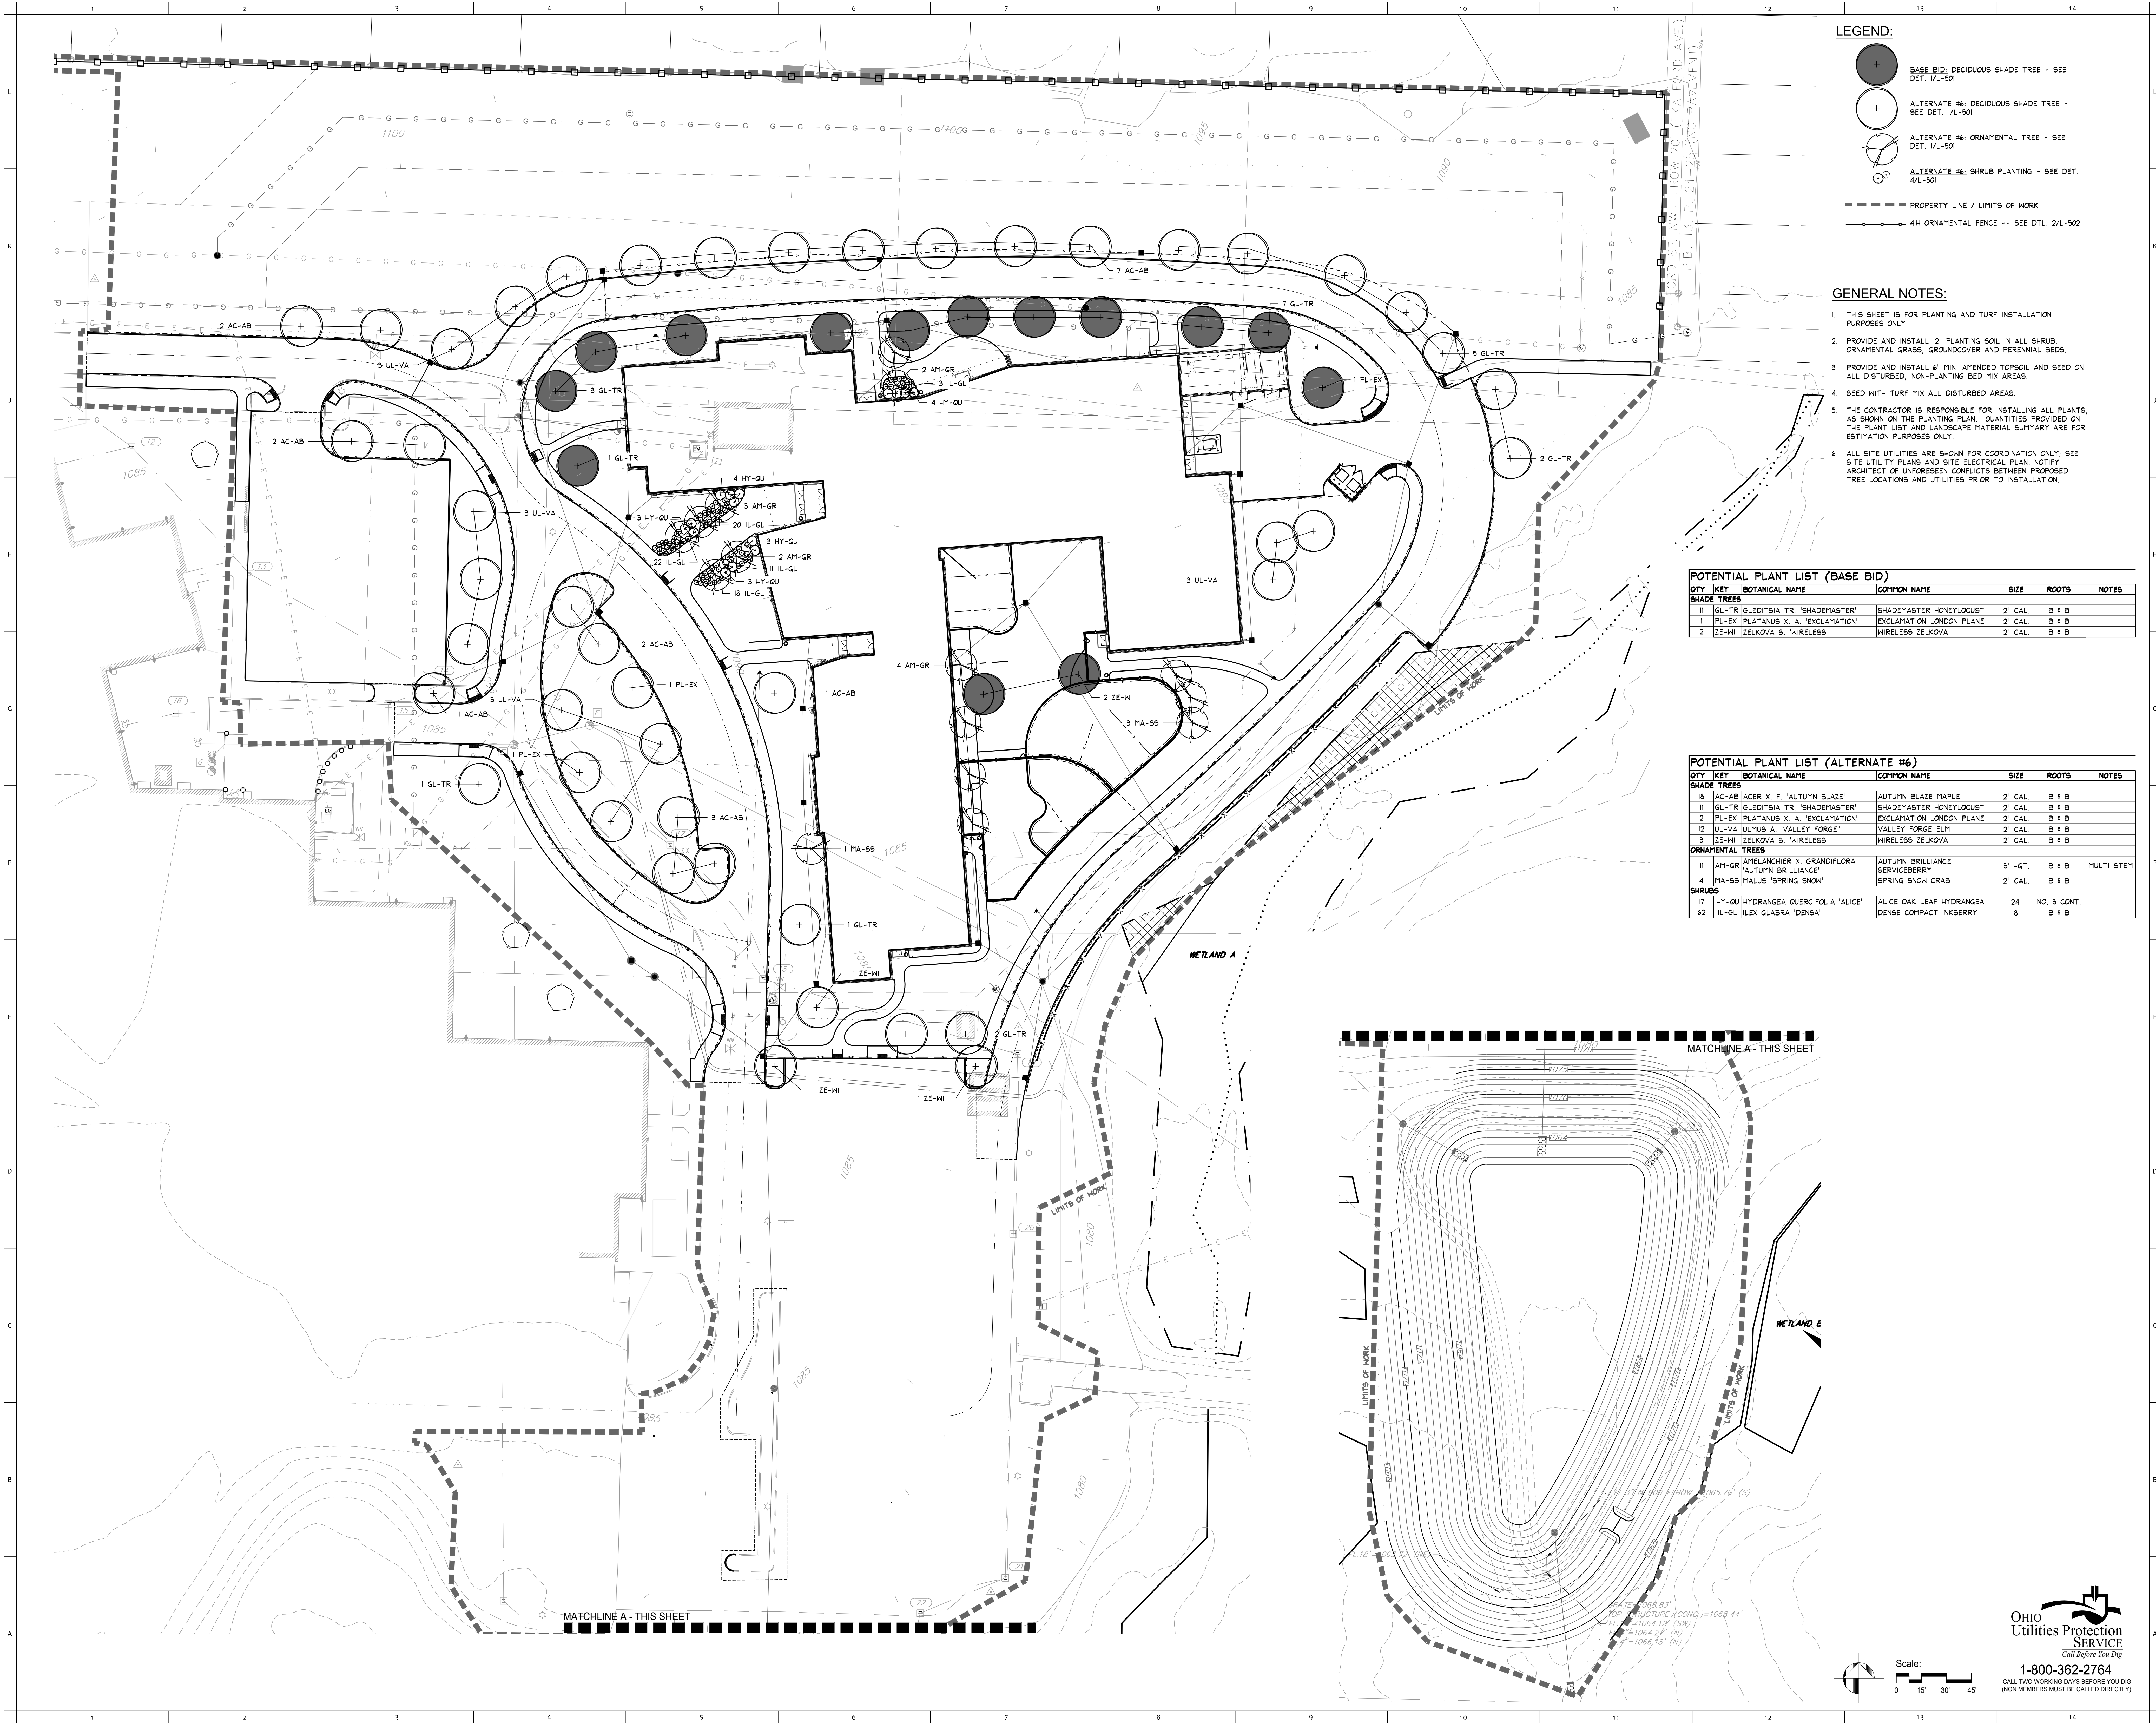

LEGEND:

- BASE BID: DECIDUOUS SHADE TREE - SEE DET. 1/L-501
- ALTERNATE #6: DECIDUOUS SHADE TREE - SEE DET. 1/L-501
- ALTERNATE #6: ORNAMENTAL TREE - SEE DET. 1/L-501
- ALTERNATE #6: SHRUB PLANTING - SEE DET. 4/L-501
- PROPERTY LINE / LIMITS OF WORK
- 4" ORNAMENTAL FENCE -- SEE DTL. 2/L-502

GENERAL NOTES:


- THIS SHEET IS FOR PLANTING AND TURF INSTALLATION PURPOSES ONLY.
- PROVIDE AND INSTALL 12" PLANTING SOIL IN ALL SHRUB, ORNAMENTAL GRASS, GROUNDCOVER AND PERENNIAL BEDS.
- PROVIDE AND INSTALL 4" MIN. AMENDED TOPSOIL AND SEED ON ALL DISTURBED, NON-PLANTING BED MIX AREAS.
- SEED WITH TURF MIX ALL DISTURBED AREAS.
- THE CONTRACTOR IS RESPONSIBLE FOR INSTALLING ALL PLANTS, AS SHOWN ON THE PLANTING PLAN. QUANTITIES PROVIDED ON THE PLANT LIST AND LANDSCAPE MATERIAL SUMMARY ARE FOR ESTIMATION PURPOSES ONLY.
- ALL SITE UTILITIES ARE SHOWN FOR COORDINATION ONLY. SEE SITE UTILITY PLANS AND SITE ELECTRICAL PLAN. NOTIFY ARCHITECT OF UNFORESEEN CONFLICTS BETWEEN PROPOSED TREE LOCATIONS AND UTILITIES PRIOR TO INSTALLATION.

POTENTIAL PLANT LIST (BASE BID)

QTY	KEY	BOTANICAL NAME	COMMON NAME	SIZE	ROOTS	NOTES
SHADE TREES						
11	GL-TR	GLEDISIA TR. 'SHADEMASTER'	SHADEMASTER HONEYLOCUST	2" CAL.	B 4 B	
1	PL-EX	PLATANUS X. A. 'EXCLAMATION'	EXCLAMATION LONDON PLANE	2" CAL.	B 4 B	
2	ZE-WI	ZELKOVA S. 'WIRELESS'	WIRELESS ZELKOVA	2" CAL.	B 4 B	

POTENTIAL PLANT LIST (ALTERNATE #6)

QTY	KEY	BOTANICAL NAME	COMMON NAME	SIZE	ROOTS	NOTES
SHADE TREES						
18	AC-AB	ACER X. F. 'AUTUMN BLAZE'	AUTUMN BLAZE MAPLE	2" CAL.	B 4 B	
11	GL-TR	GLEDISIA TR. 'SHADEMASTER'	SHADEMASTER HONEYLOCUST	2" CAL.	B 4 B	
2	PL-EX	PLATANUS X. A. 'EXCLAMATION'	EXCLAMATION LONDON PLANE	2" CAL.	B 4 B	
12	UL-VA	ULMUS A. 'VALLEY FORGE'	VALLEY FORGE ELM	2" CAL.	B 4 B	
3	ZE-WI	ZELKOVA S. 'WIRELESS'	WIRELESS ZELKOVA	2" CAL.	B 4 B	
ORNAMENTAL TREES						
11	AM-GR	AMELANCHIER X. GRANDIFLORA	AUTUMN BRILLIANCE SERVICEBERRY	5' HGT.	B 4 B	MULTI STEM
4	MA-SS	MALUS 'SPRING SNOW'	SPRING SNOW CRAB	2" CAL.	B 4 B	
SHRUBS						
17	HY-QU	HYDRANGEA QUERCIFOLIA 'ALICE'	ALICE OAK LEAF HYDRANGEA	24"	NO. 5 CONT.	
62	IL-GL	ILEX GLABRA 'DENSE'	DENSE COMPACT INKBERRY	18"	B 4 B	

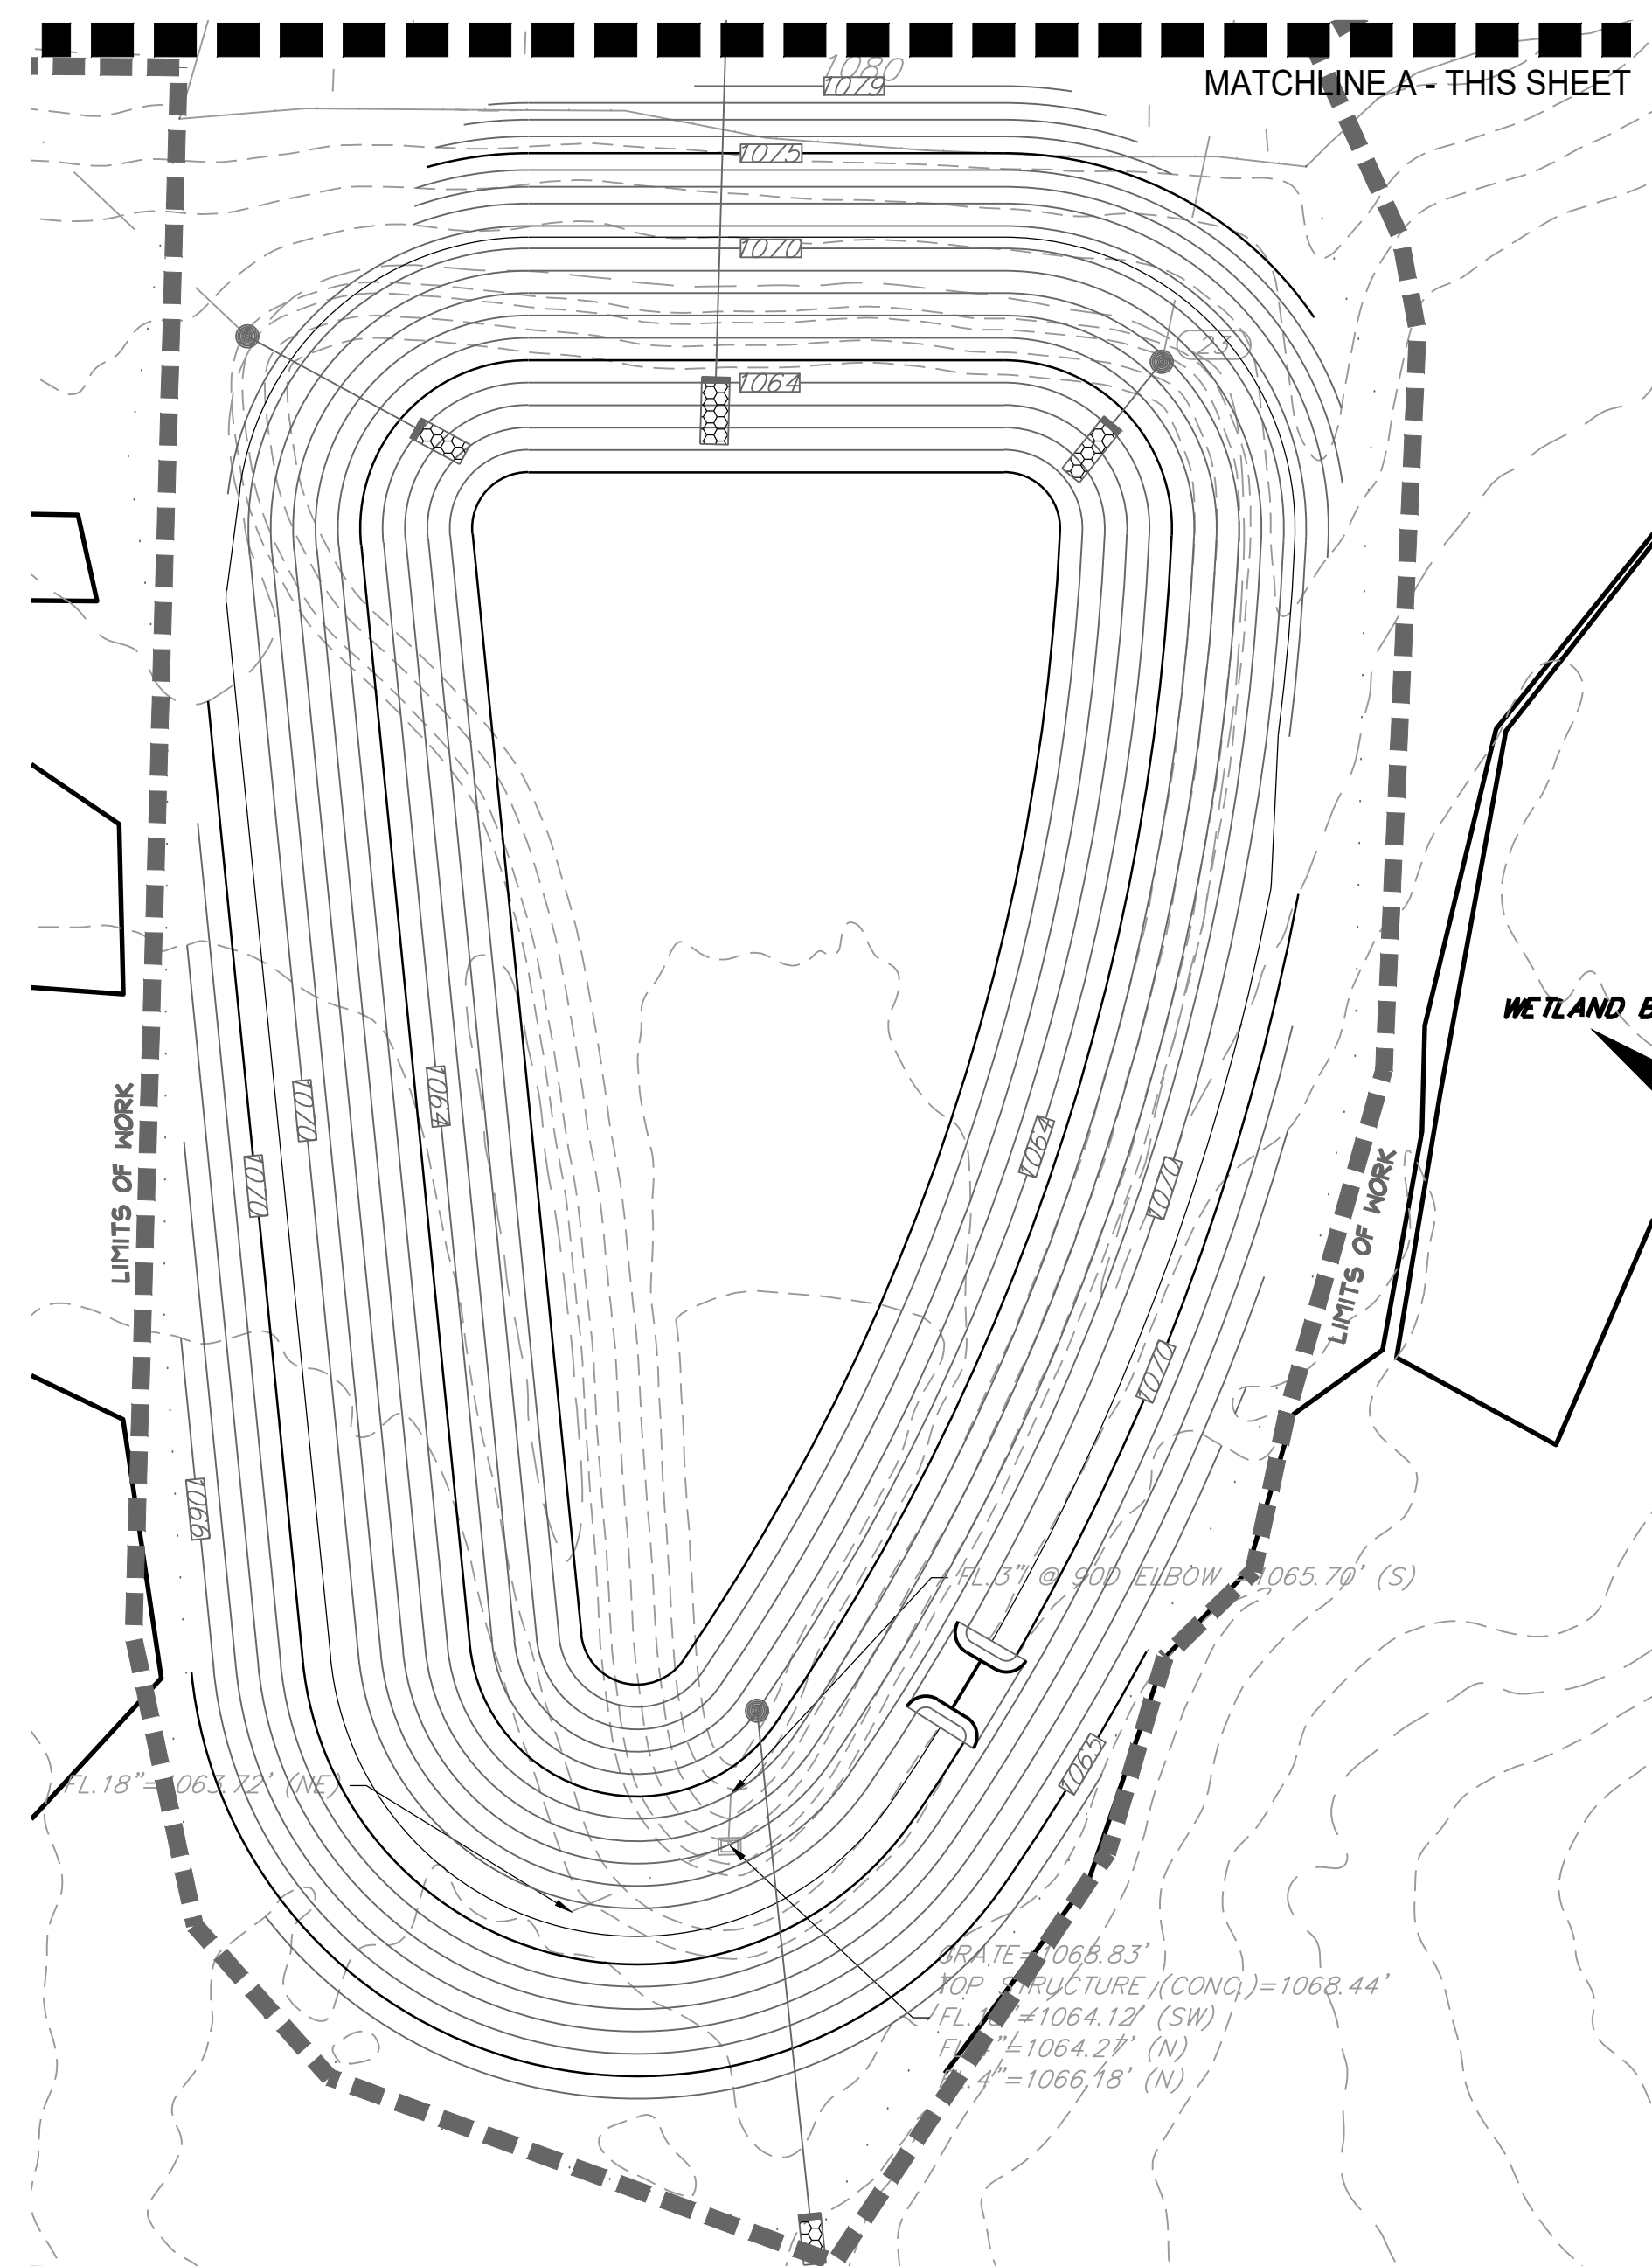

1-800-362-2764
CALL TWO WORKING DAYS BEFORE YOU DIG
(NON MEMBERS MUST BE CALLED DIRECTLY)

PROJECT NO
2203-1

ARCHITECTURAL VISION GROUP, LTD
ARCHITECTS • PLANNERS
23850 SPERRY DRIVE CLEVELAND, OHIO 44145

MASSILLON CITY SCHOOL
WEST SIDE CAMPUS
250 29th St NW, Massillon, OH 44647

PROJECT NO 2203-1
DRAWN BY
CHECKED BY
DATE

SITE
PLANTING

SHEET NO
L-400