 
 
 




 
 
 
 
 
 
 
 
 
 
 
 
 
 
 
 
 
 
 
 
 
 
 

	RUB-1	RUBBER TILE
	RUB-2	RUBBER TILE
	RUB-3	RUBBER TILE
	RUB-4	RUBBER TILE
	RUB-5	RUBBER TILE
	RUB-6	RUBBER TILE
	RUB-7	RUBBER TILE
	RUB-8	RUBBER TILE
	RUB-9	RUBBER TILE
	RUB-10	RUBBER TILE

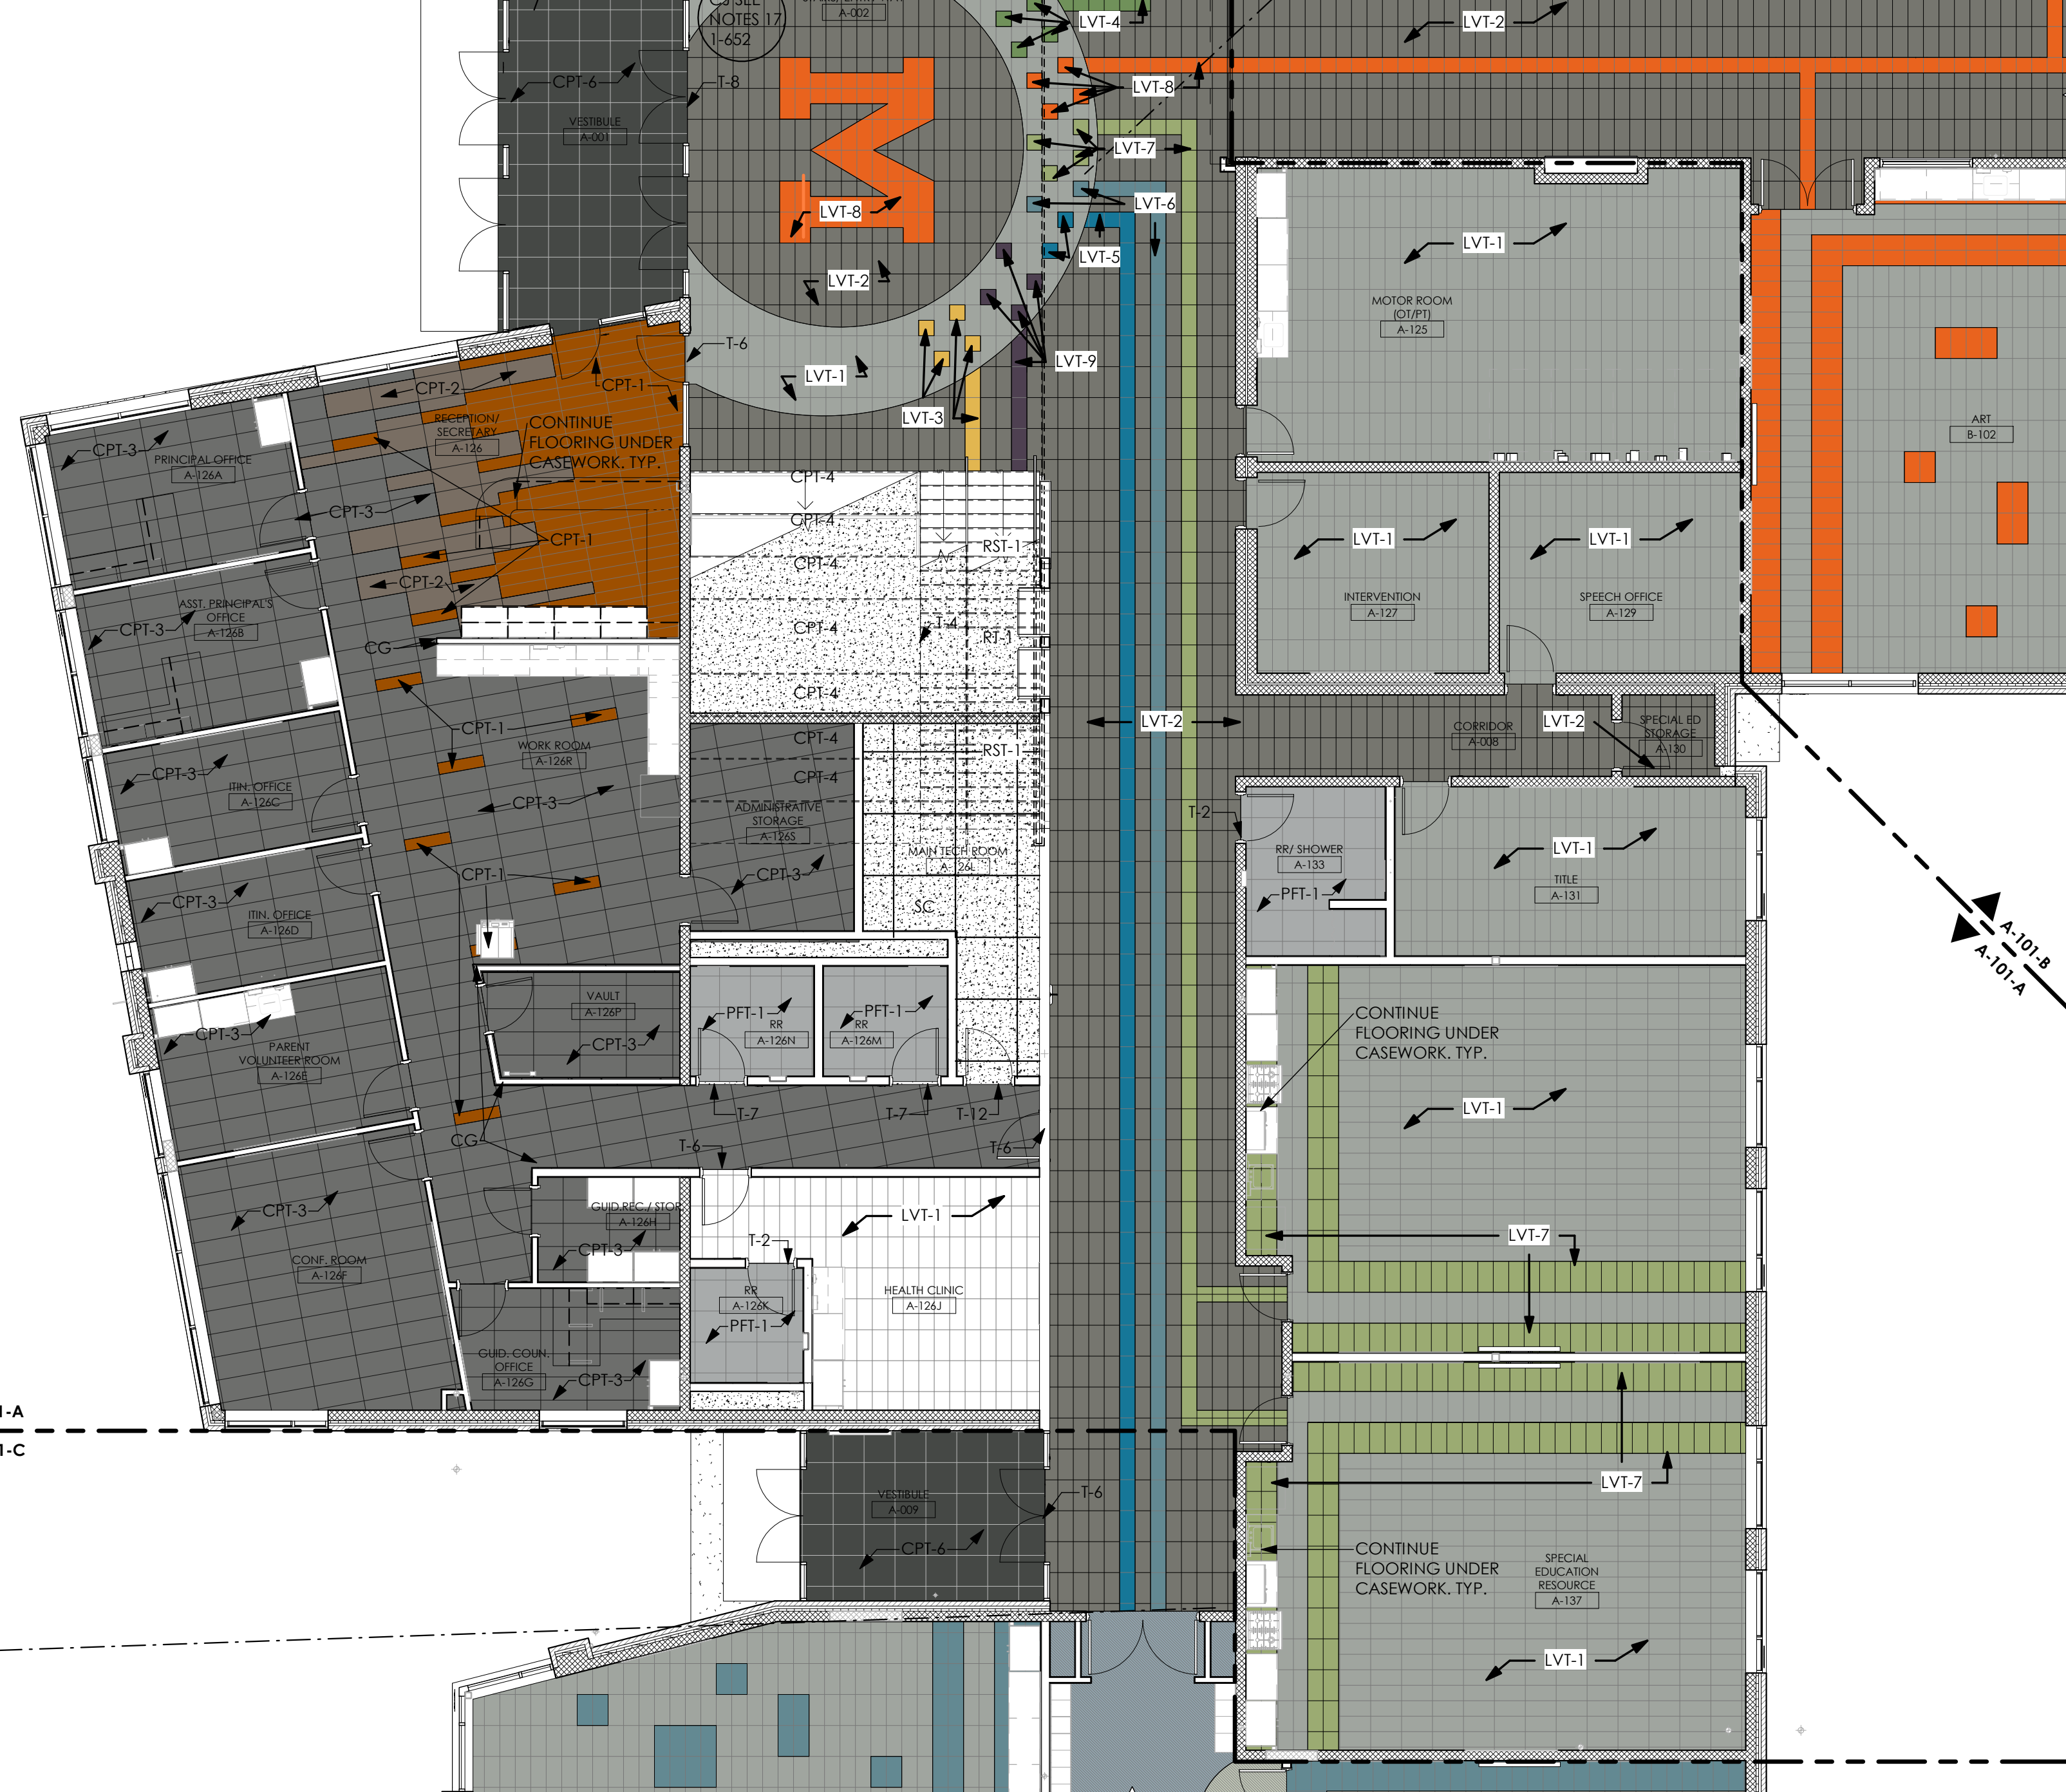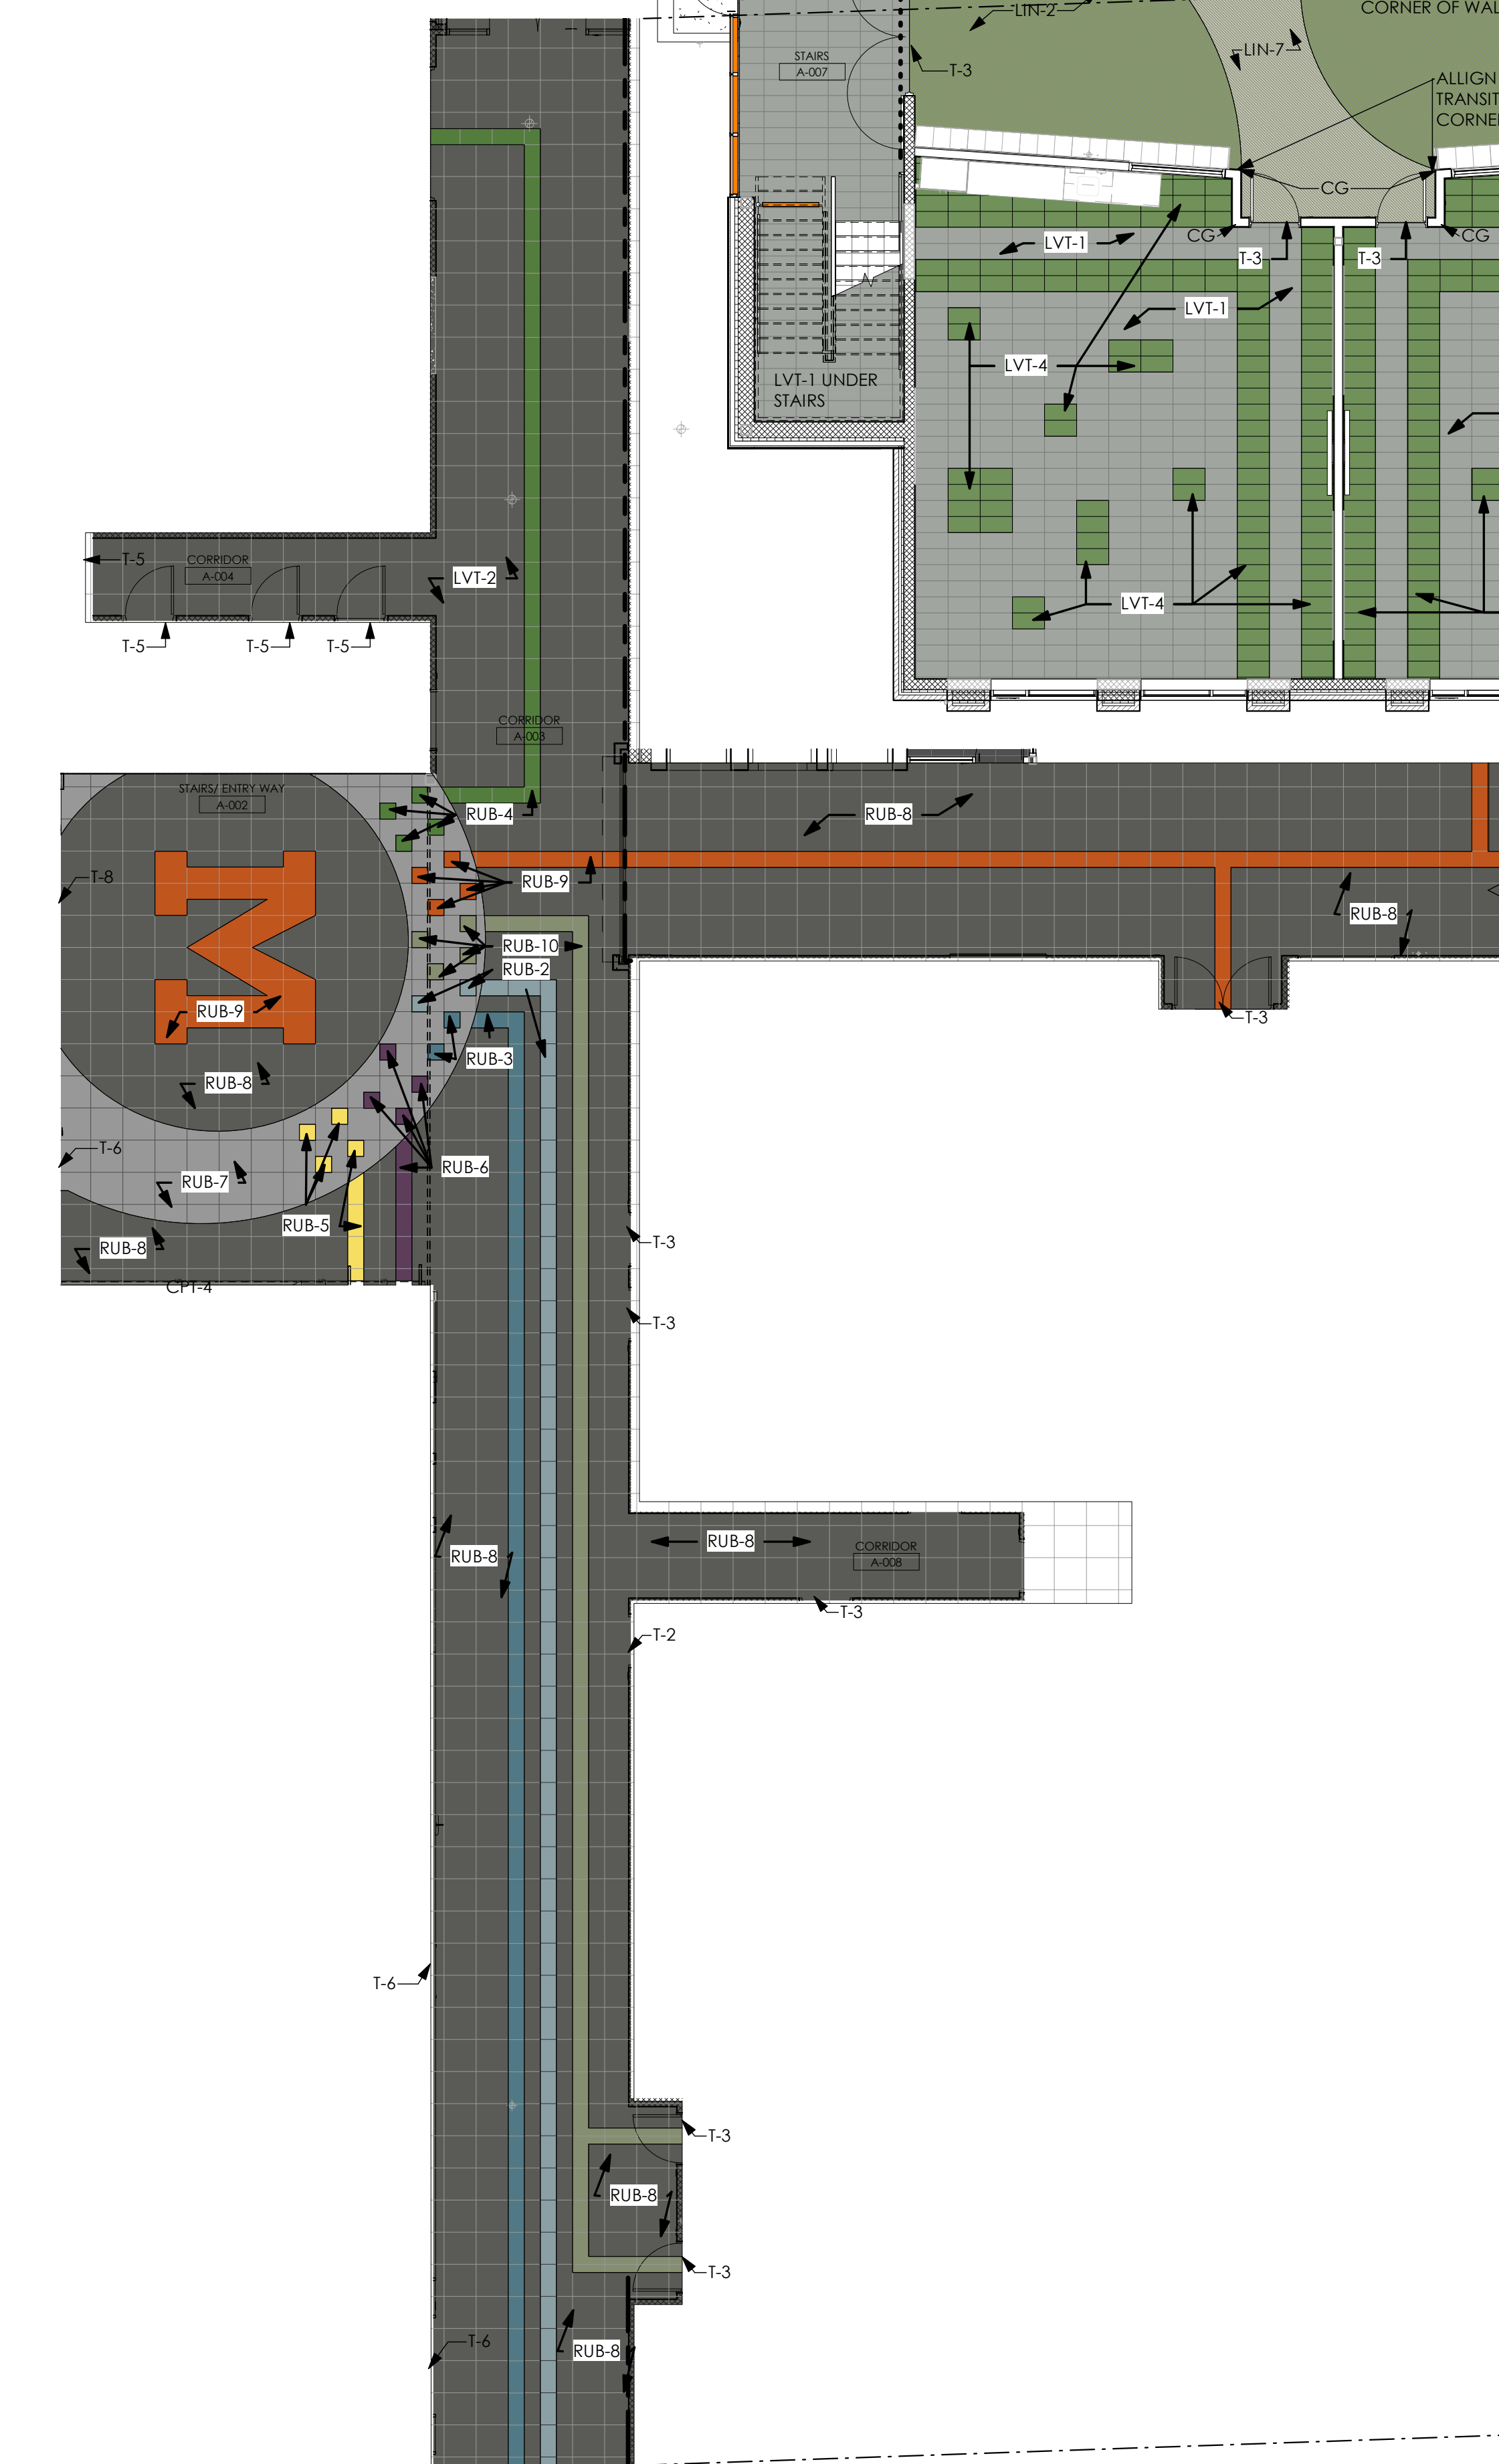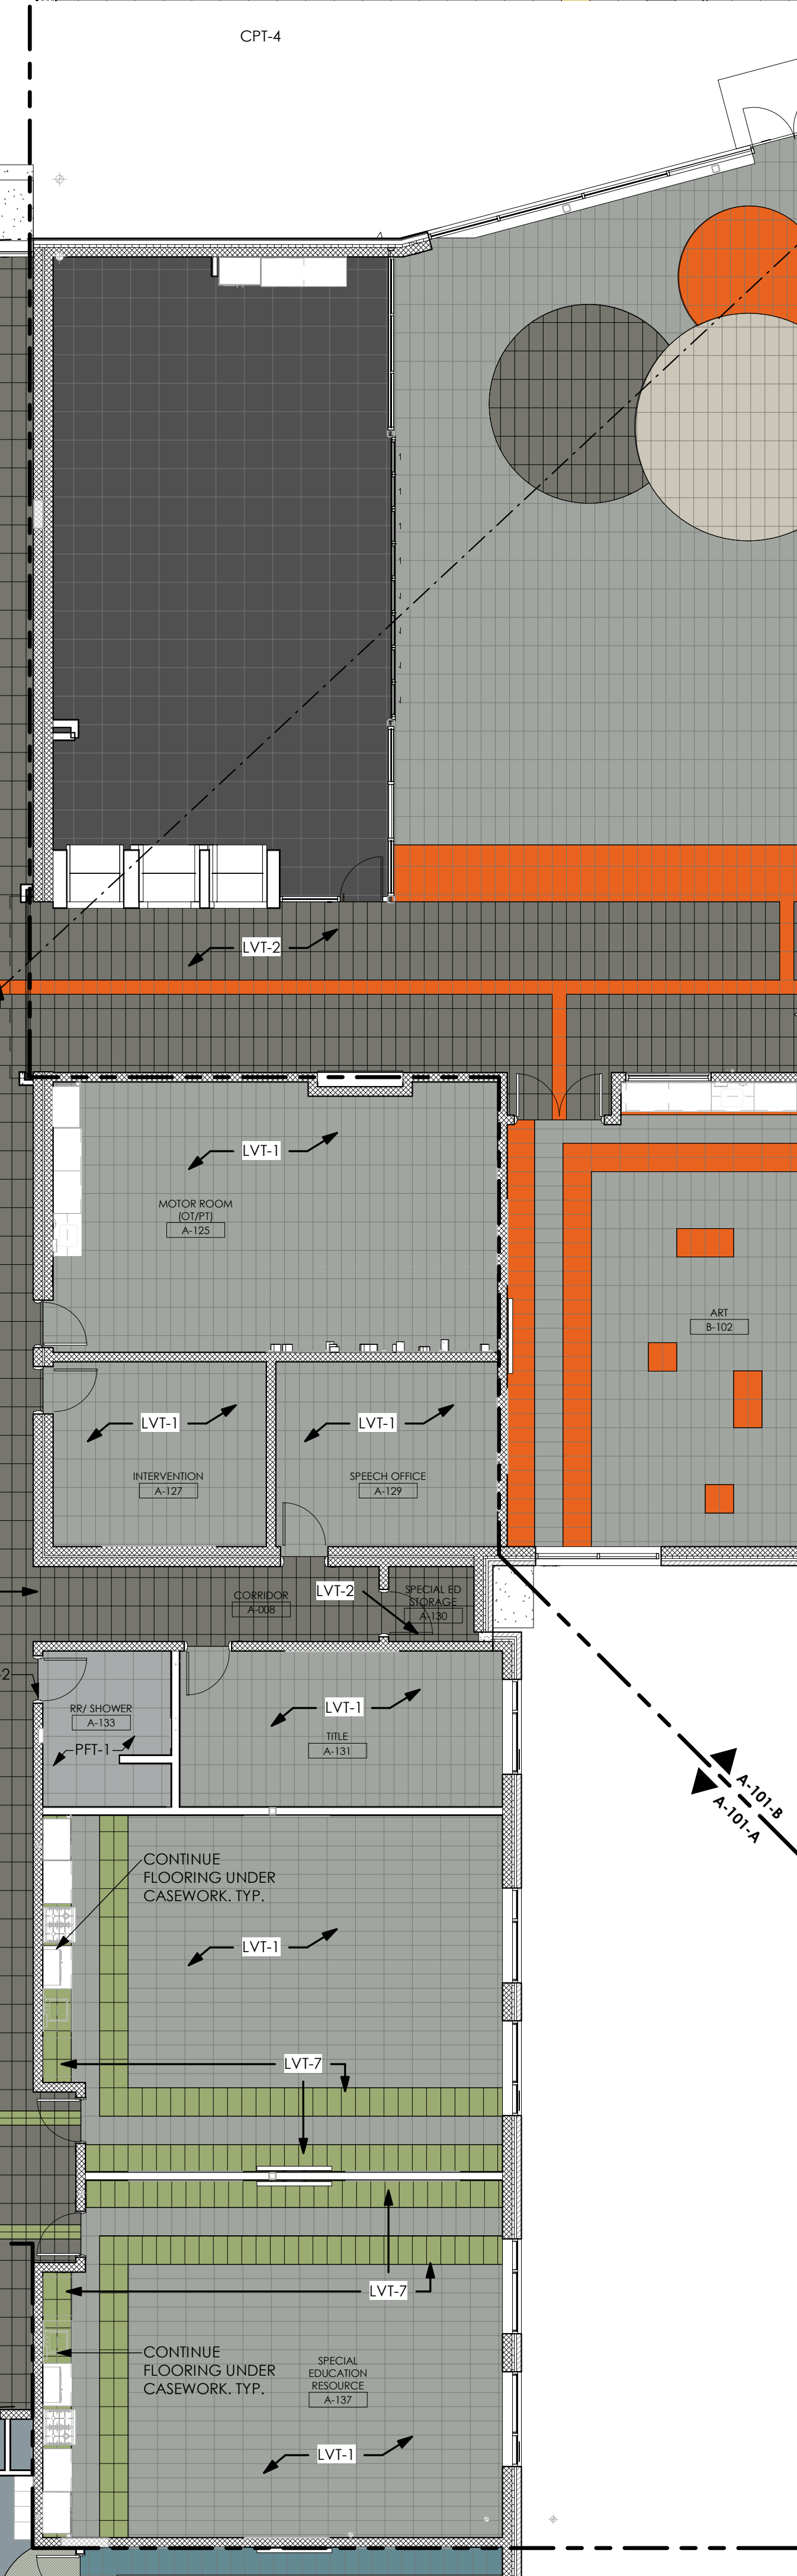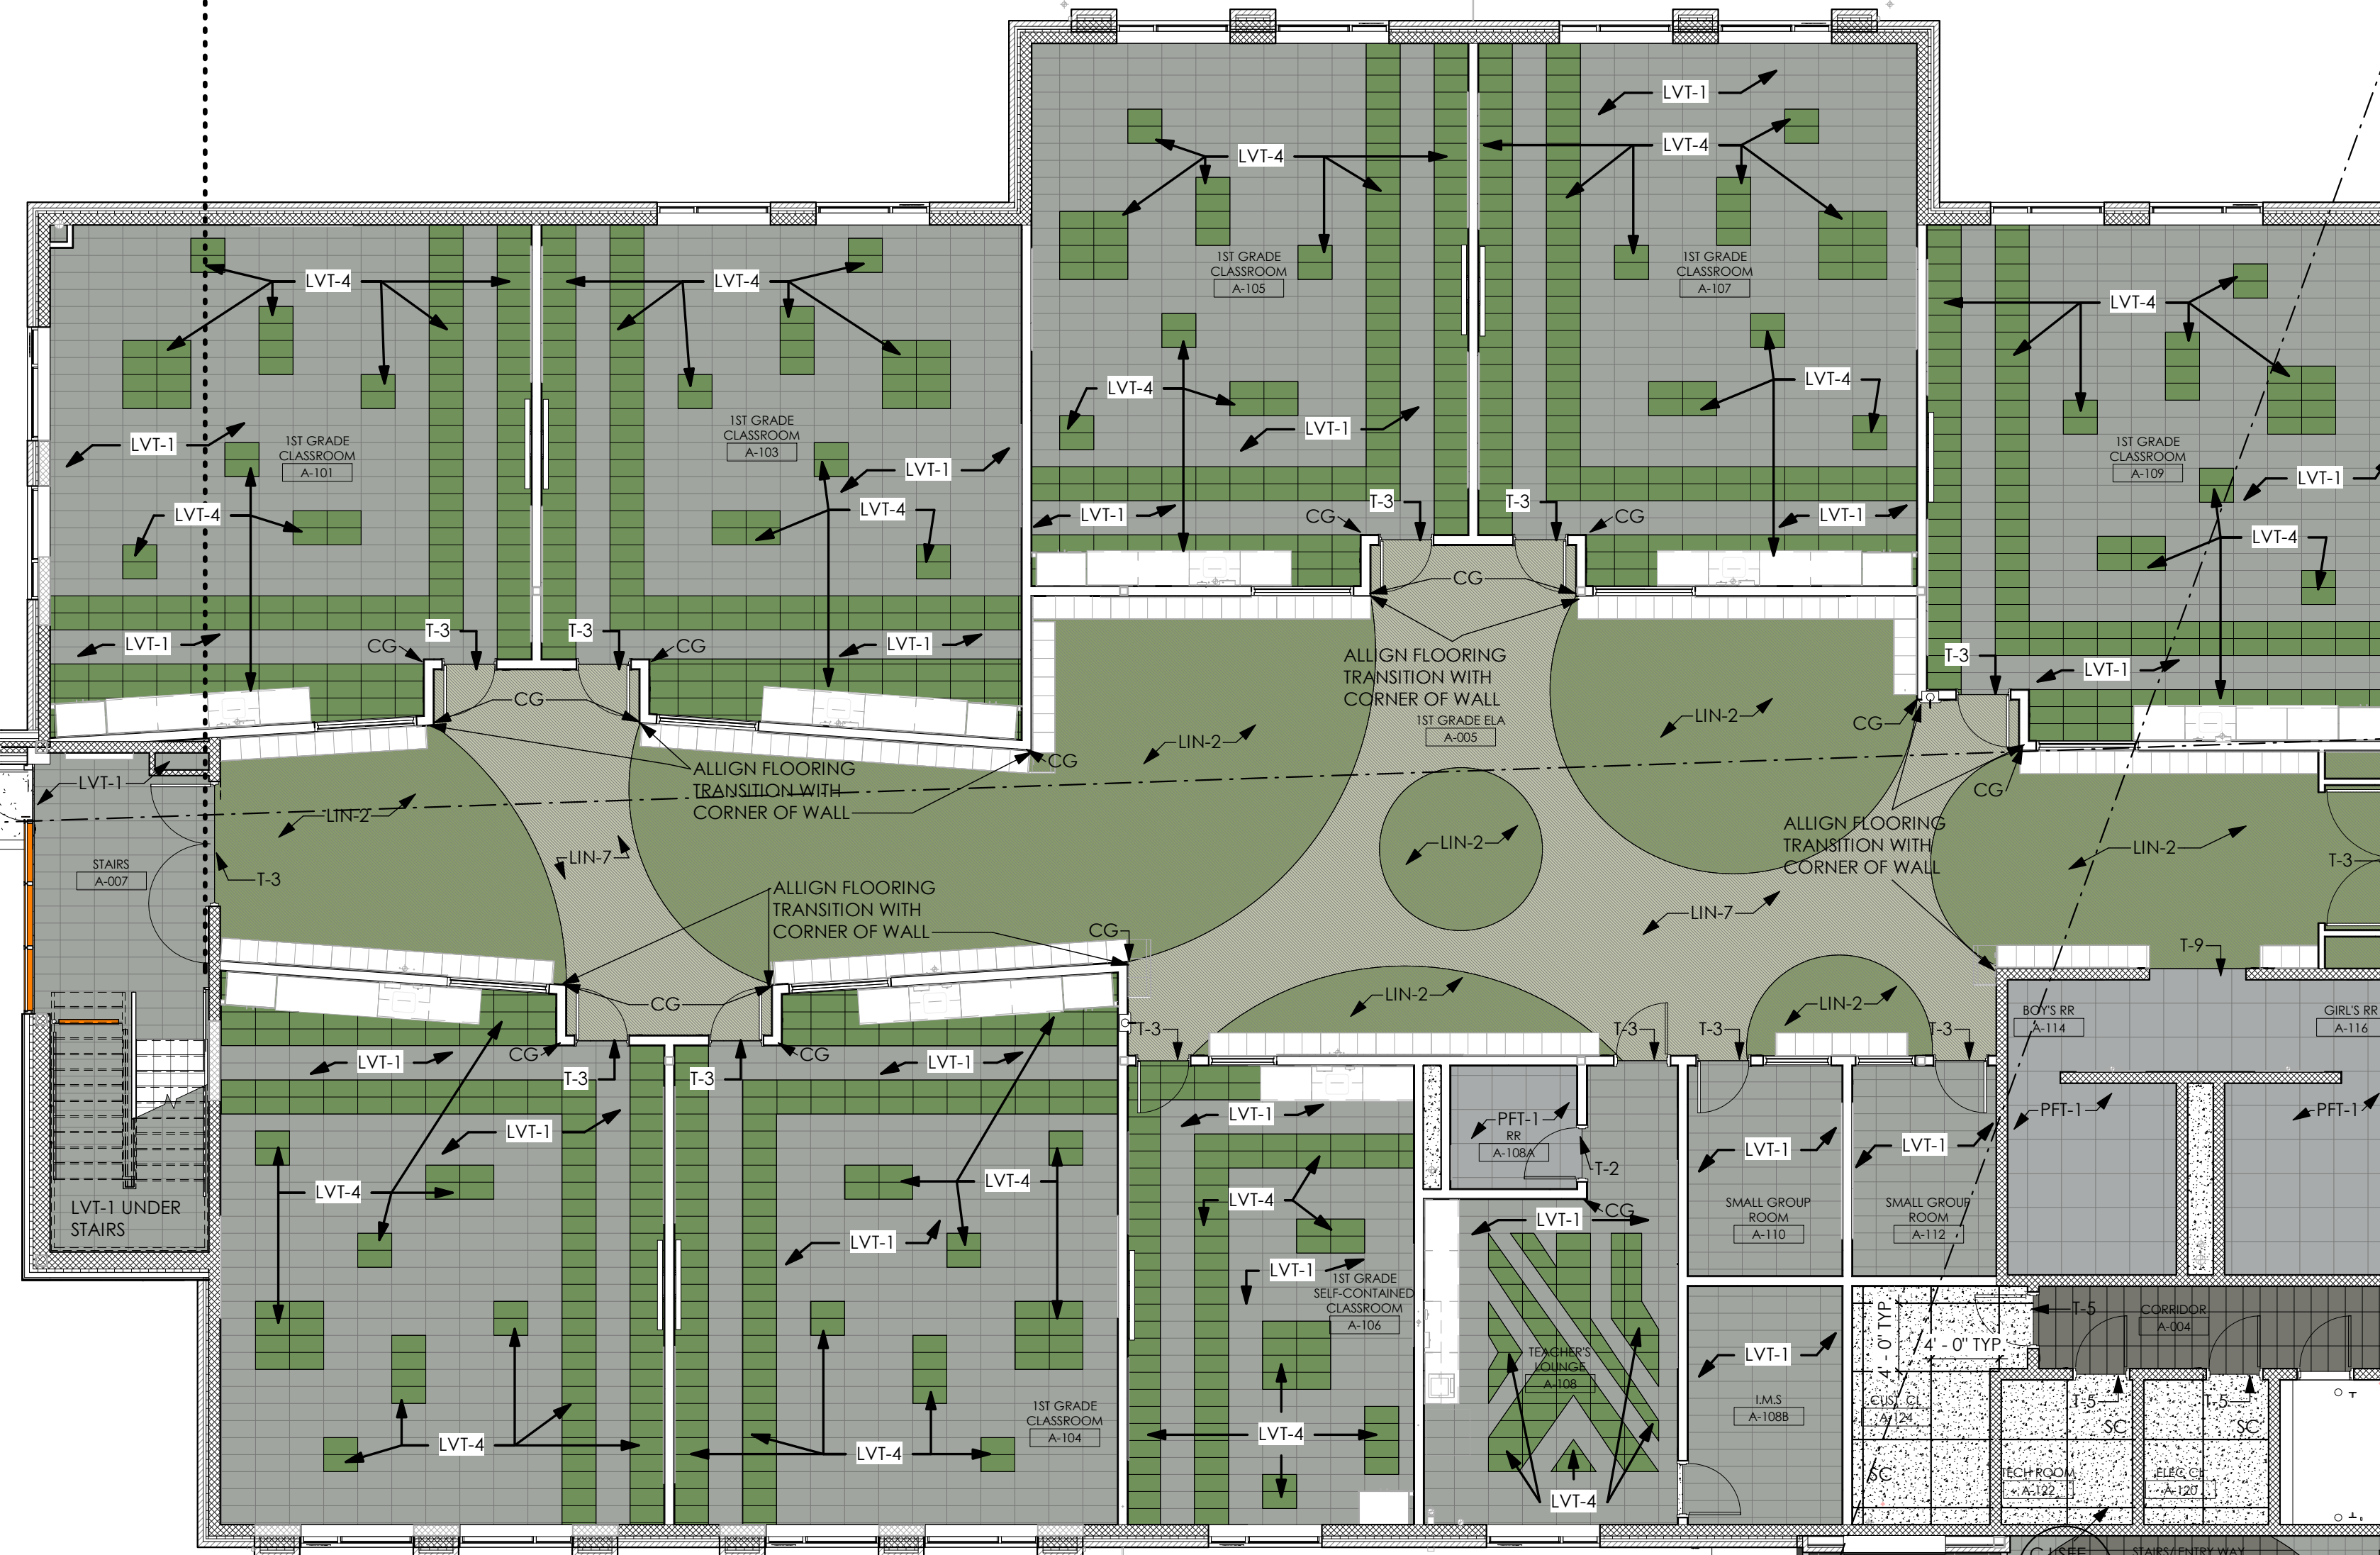

	LVT-1	LUXURY VINYL TILE
	LVT-2	LUXURY VINYL TILE
	LVT-3	LUXURY VINYL TILE
	LVT-4	LUXURY VINYL TILE
	LVT-5	LUXURY VINYL TILE
	LVT-6	LUXURY VINYL TILE
	LVT-7	LUXURY VINYL TILE
	LVT-8	LUXURY VINYL TILE
	LVT-9	LUXURY VINYL TILE
	LVT-10	LUXURY VINYL TILE
	CPT-1	CARPET TILE
	CPT-2	CARPET TILE
	CPT-3	CARPET TILE
	CPT-4	CARPET TILE
	CPT-5	CARPET TILE
	CPT-6	CARPET TILE
	LIN-1	LINOLEUM
	LIN-2	LINOLEUM
	LIN-3	LINOLEUM
	LIN-4	LINOLEUM
	LIN-5	LINOLEUM
	LIN-6	LINOLEUM
	LIN-7	LINOLEUM
	LIN-8	LINOLEUM
	PFT-1	PORCELAIN FLOOR TILE
	CG	STAINLESS STEEL CORNER GUARD

- GENERAL FINISH NOTES
1. ALL LVT MUST BE PROVIDED BY SAME MANUFACTURER TO KEEP A CONSISTENT MATERIAL PATTERN
 2. ALL LINOLEUM MUST BE PROVIDED BY SAME MANUFACTURER TO KEEP A CONSISTENT MATERIAL PATTERN
 3. SEE INTERIOR ELEVATIONS FOR ACCENT WALL LOCATIONS
 4. SEE RESTROOM PLANS AND ELEVATIONS FOR WALL TILE PATTERN
 5. SEE FINISH PLAN FOR FLOOR PATTERNS AND TRANSITION LOCATIONS
 6. ALL EXPOSED SIDS OF WALL TILE TO BE FINISHED WITH 1:1 GROUT. SEE A-652
 7. ALL PRODUCTS SHOWN ON MATERIAL SCHEDULE WILL BE SHOWN AS BASIS OF DESIGN. OTHER MANUFACTURERS THAT MEET SAME SPECIFICATIONS MAY BE USED WITH ARCHITECT'S PREVIOUS APPROVAL
 8. SEE FINISH PLANS FOR SEALED CONTROL JOINT LOCATIONS
 9. UNDEGRADED SEAMK SHALL BE NETT FIT SEAMS IN LINE WITH HEAT WELDED
 10. PROVIDE CLEARANCE MUST BE 36" MINIMUM TO ALL WALLS AND 30" MINIMUM TO FINISH FACE
 11. PLUMBING FIXTURES AND RESTROOM ACCESSORIES MUST MAINTAIN ACCESSIBILITY REQUIREMENTS FROM FINISH DIMENSIONS
 12. PROVIDE BLOCKING BLOCKING BEHIND STUD WALLS WHERE CASEWORK, SHELVING, TECHNOLOGY RESTROOM ACCESSORIES, ETC. IS MOUNTED
 13. WOOD DOOR COLOR TO BE SELECTED BY ARCHITECT FROM MANUFACTURER'S FULL RANGE OF COLORS
 14. CURTAIN SCHED DRIVING FINISH
 15. HOLLOW METAL DOOR AND FRAME COLOR TO BE C.P. UNLESS NOTED OTHERWISE ON INTERIOR ELEVATIONS
 16. CORNER GUARDS INDICATED ON FINISH PLAN AS TO GO
 17. CORNER GUARDS INDICATED ON FINISH PLAN AS TO GO
 18. ALL FINISHES SHALL BE 1/8" DEEPER THAN FINISH PLAN ARE TO BE 1/4" DEPTH OF SLAB THICKNESS. IF FINISH IS GREATER THAN 1/2" DEEP. FILL COLOR WITH FOAM BACKER BOARD 1/8" WIDER THAN JOINT. FILL ALL JOINTS WITH 100% SOLID WHITE EPXY FILL COLOR WITH FOAM BACKER BOARD 1/8" WIDER THAN JOINT.
 19. CONTRACTOR TO PROVIDE WALL PATTS AT ALL BUILDING ENTRANCES
 20. SEE A-651 FOR FINISH SCHEDULE
 21. SEE INTERIOR ELEVATIONS FOR OFFSPIN CONTROL JOINT LOCATIONS. SEE A-652 FOR DETAIL
 22. CONTINUE FINISH FLOOR UNDER OPEN CASEWORK, TYP.

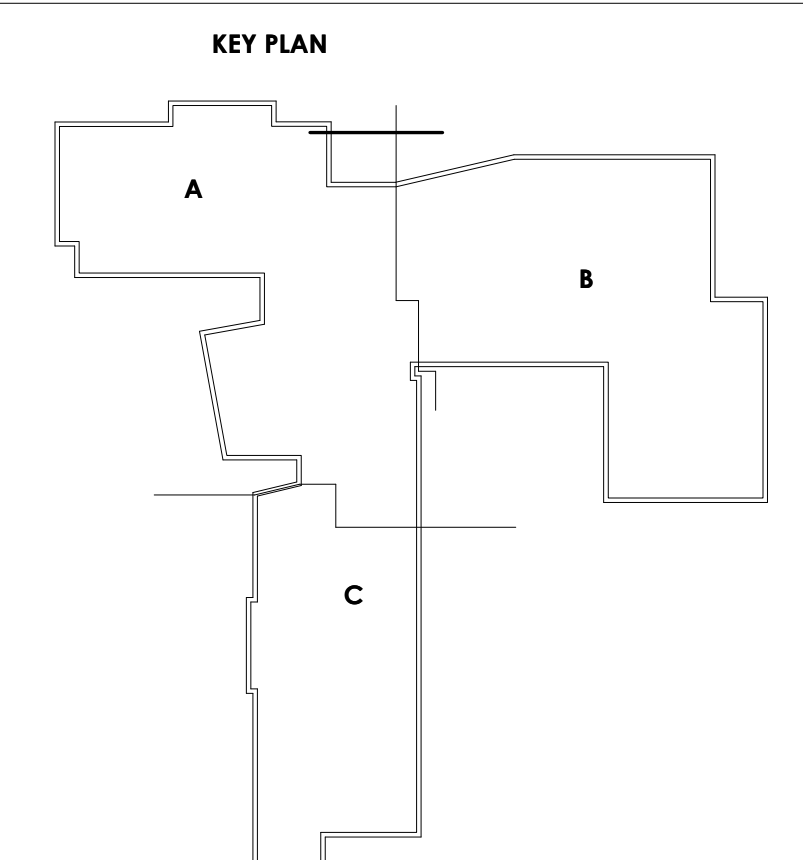

SCALE: $1/8" = 1'-0"$