



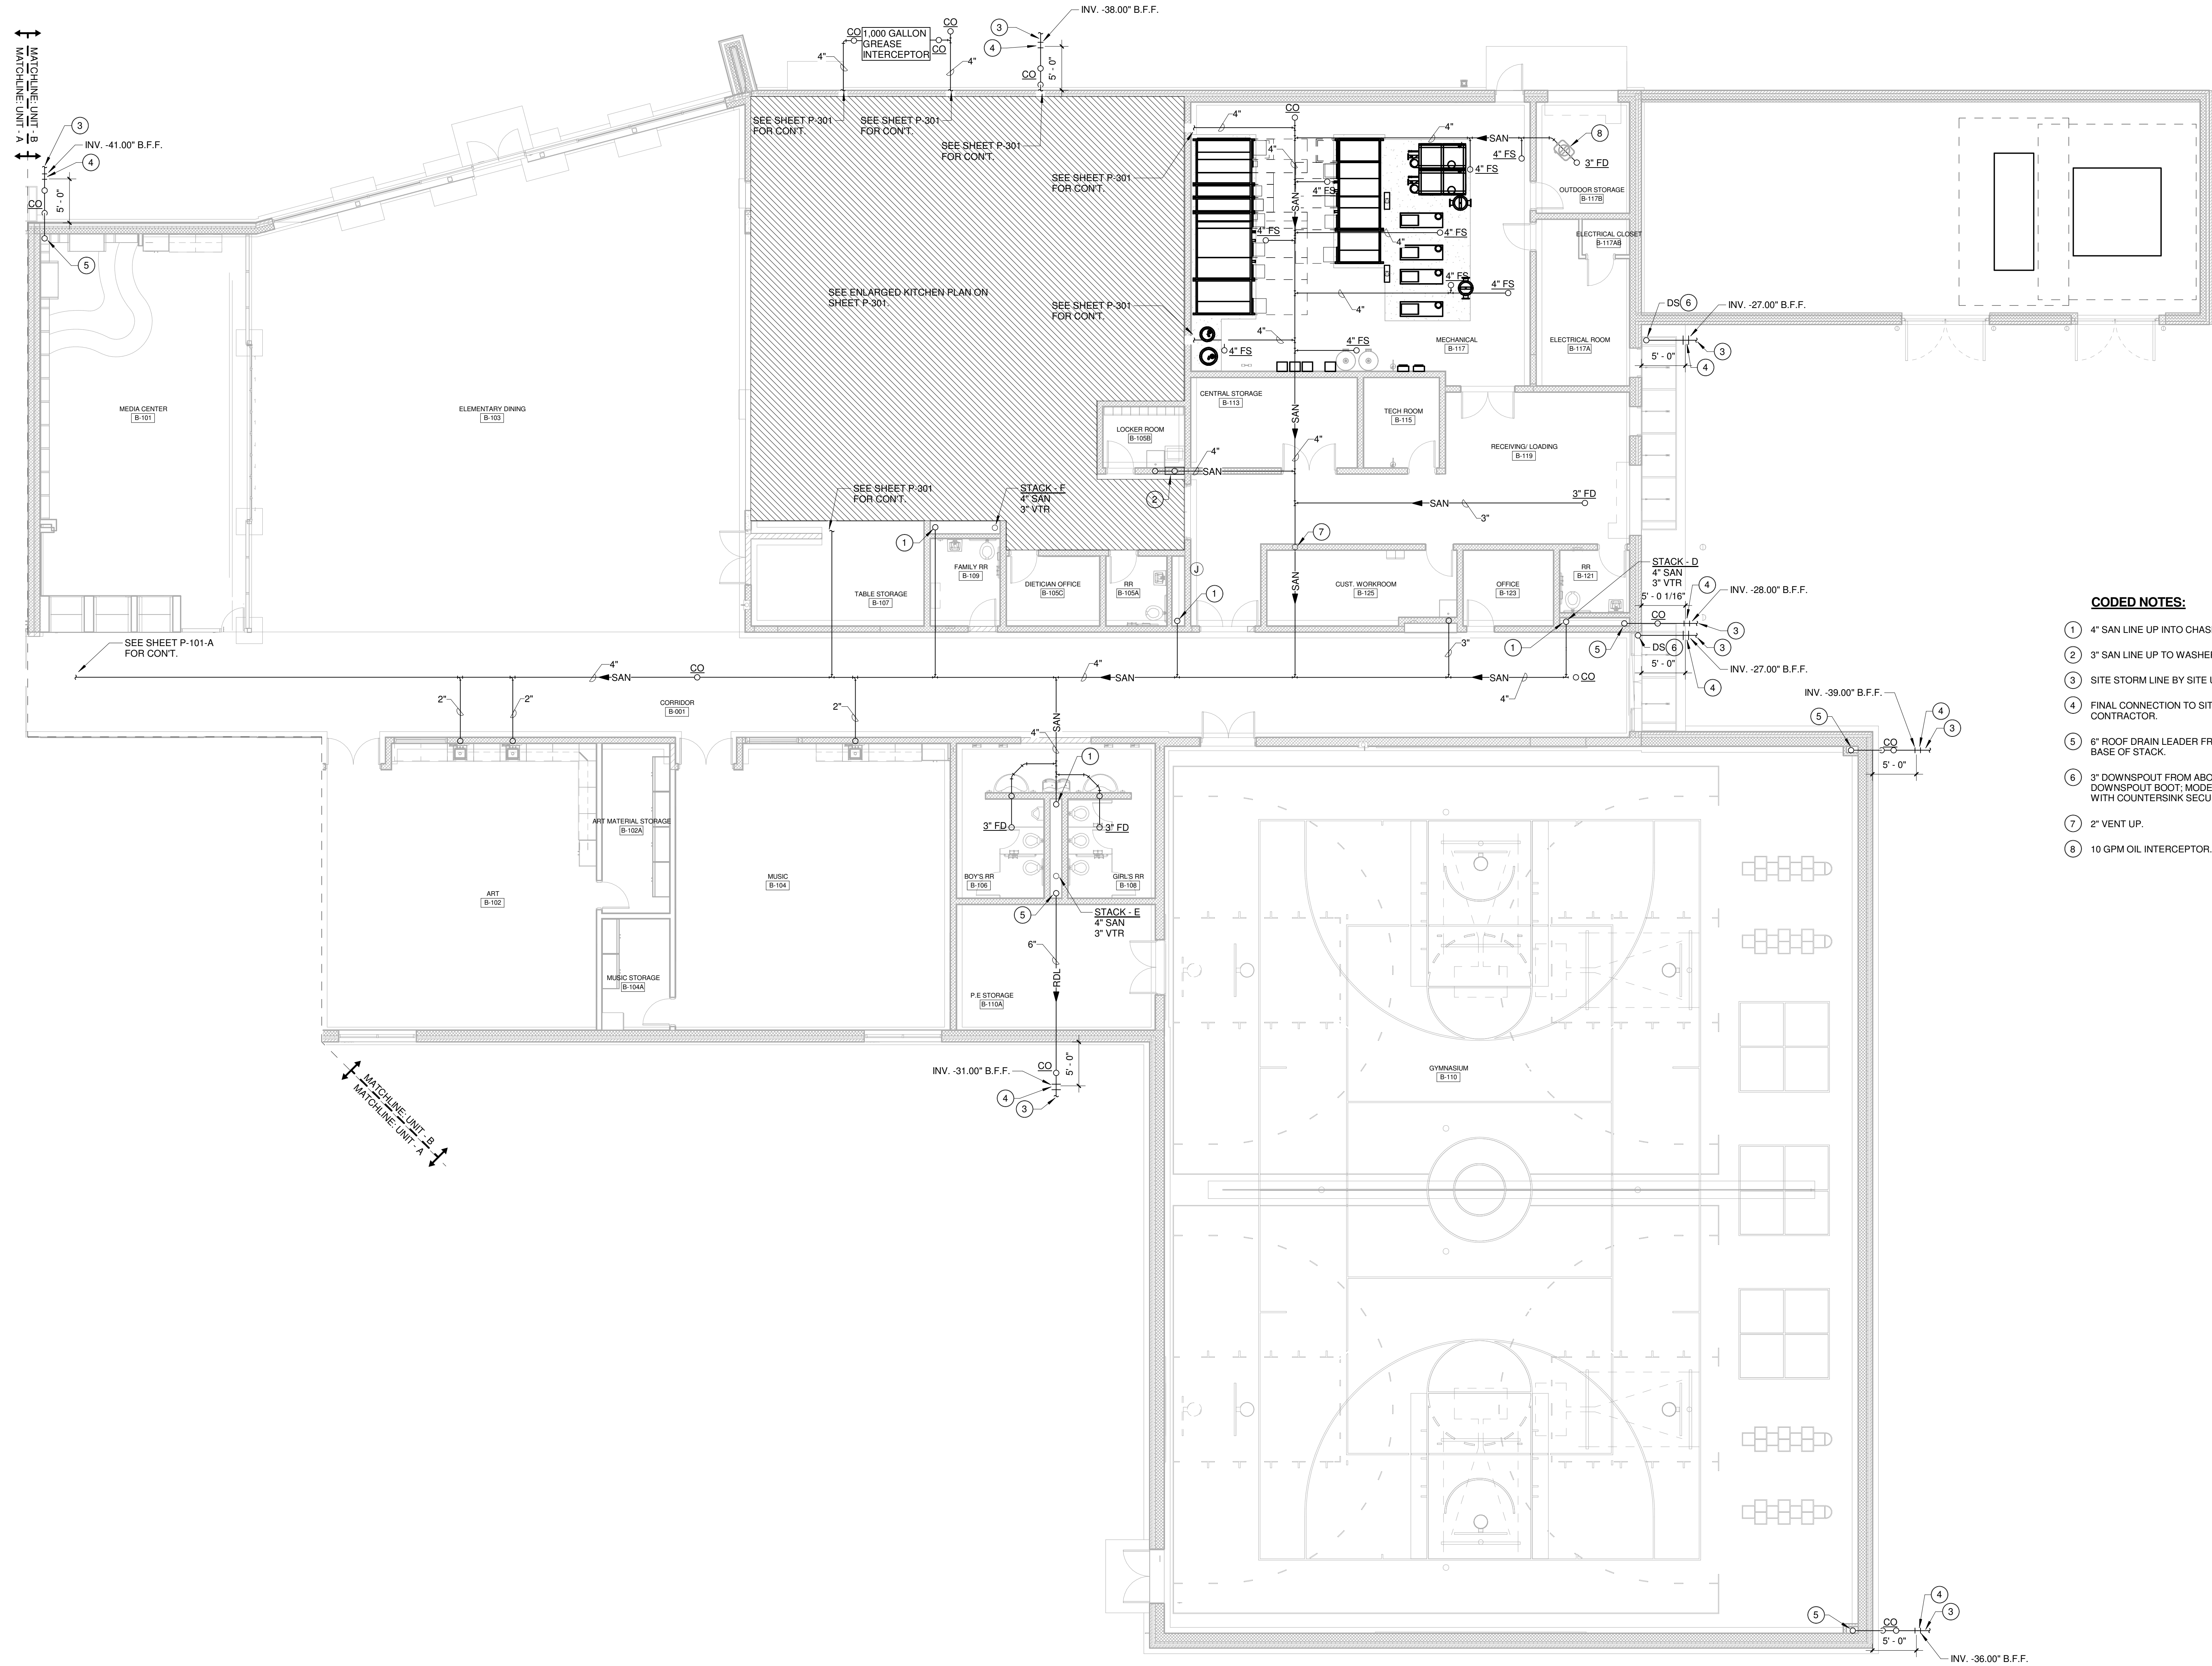

- CODED NOTES:**
- 1 4" SAN LINE UP INTO CHASE FOR CONNECTION TO FIXTURES.
 - 2 3" SAN LINE UP TO WASHER SUPPLY AND DRAIN CABINET.
 - 3 SITE STORM LINE BY SITE UTILITIES CONTRACTOR.
 - 4 FINAL CONNECTION TO SITE STORM LINE BY PLUMBING CONTRACTOR.
 - 5 8" ROOF DRAIN LEADER FROM ABOVE. PROVIDE CLEAN OUT AT BASE OF STACK.
 - 6 3" DOWNSPOUT FROM ABOVE AND DOWN TO WAITS DOWNSPOUT BOOT; MODEL RD 970, EPOXY COATED CAST IRON WITH COUNTERSINK SECURING STRAP.
 - 7 2" VENT UP.
 - 8 10 GPM OIL INTERCEPTOR. SEE SPECIFICATIONS.

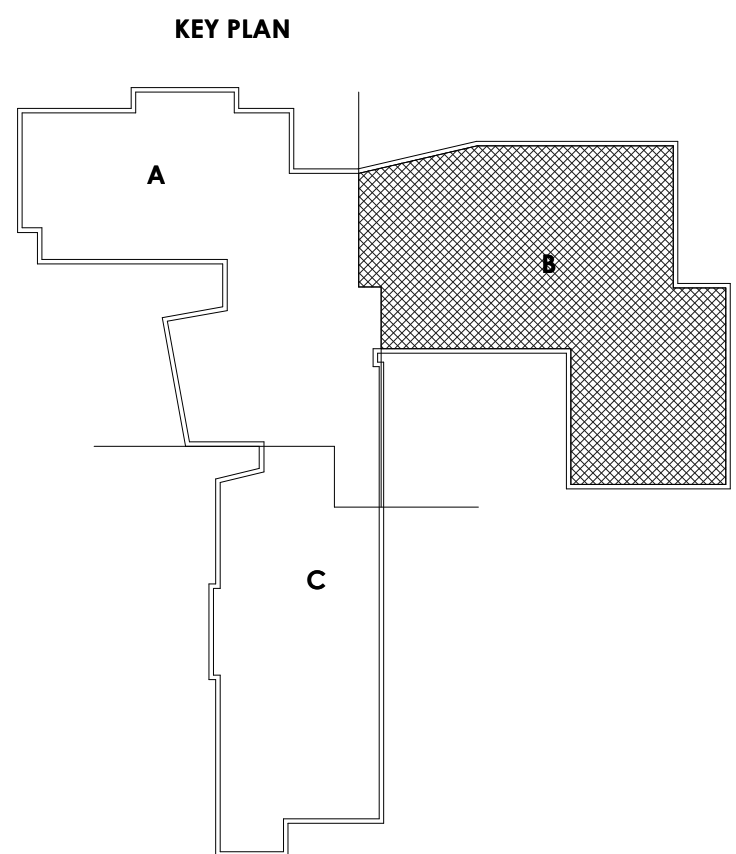

FIRST FLOOR PLAN - SANITARY PLAN - UNIT B
SCALE: 1/8" = 1'-0"

PROJECT NO
2203-1

ARCHITECTURAL VISION GROUP, LTD
ARCHITECTS
PLANNERS
23850 SPERRY DRIVE
CLEVELAND, OHIO 44145

MASSILLON CITY SCHOOL
MASSILLON WEST ELEMENTARY
PK-3
250 29TH STREET NW, MASSILLON, OHIO 44646

MARK	DATE	DESCRIPTION
ISSUED AS:		

FIRST FLOOR
PLAN - SANITARY
- UNIT B
SCALE: 1/8" = 1'-0"
SHEET NO
P-101-B