

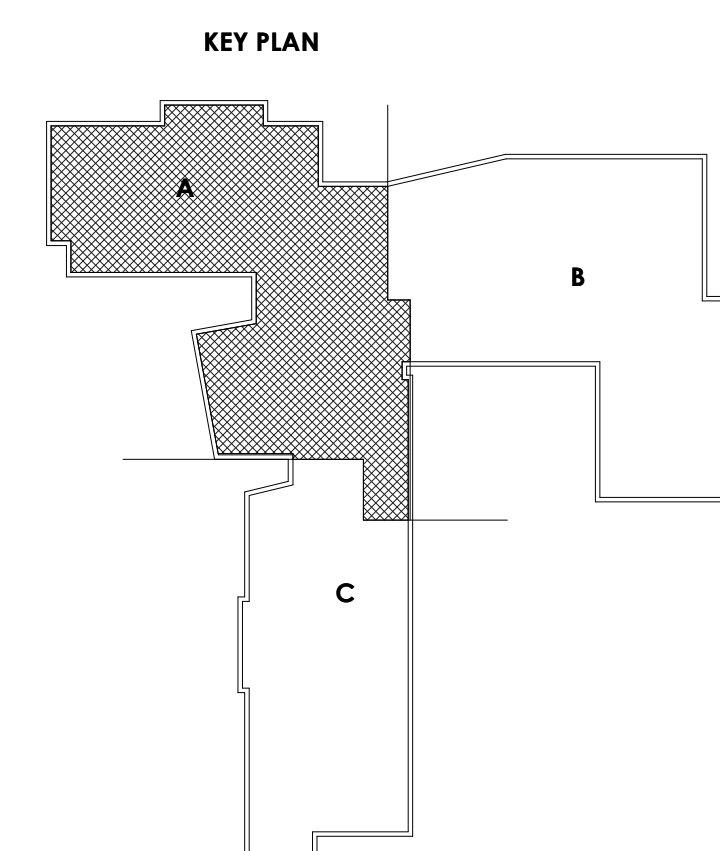
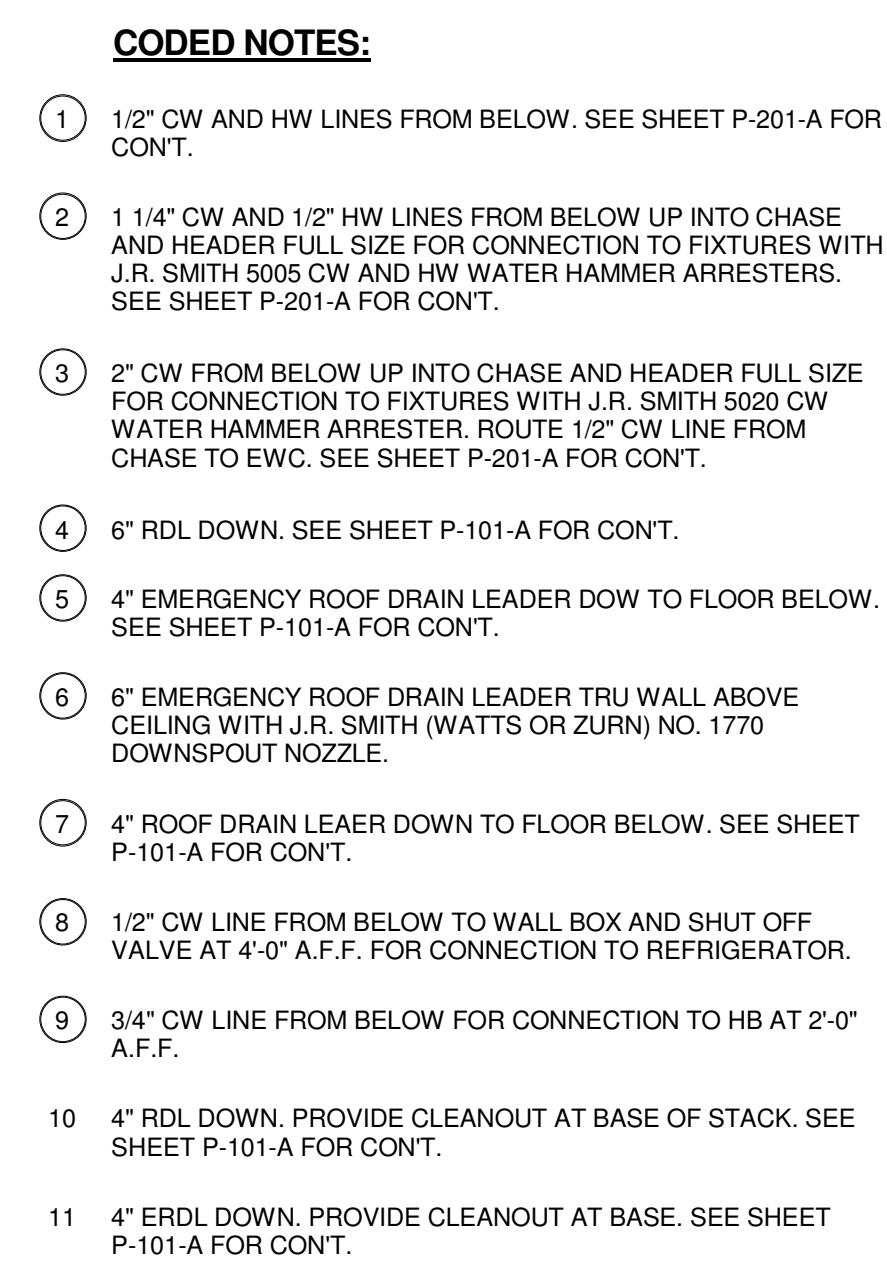


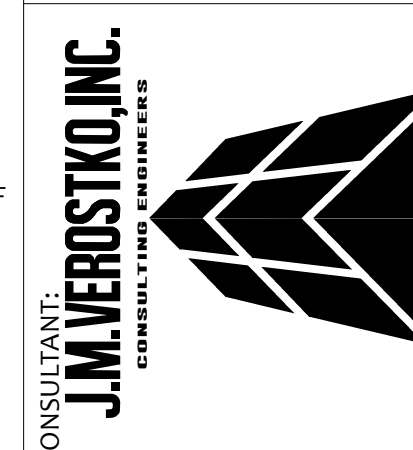

SECOND FLOOR PLAN - DOMESTIC PLUMBING PLAN - UNIT A
SCALE: 1/8" = 1'-0"

PROJECT NO
2203-1

ARCHITECTURAL VISION GROUP, LTD
ARCHITECTS • PLANNERS
23850 SPERRY DRIVE CLEVELAND, OHIO 44145

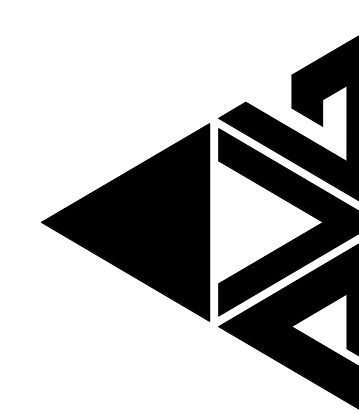

MASSILLON CITY SCHOOL
MASSILLON WEST ELEMENTARY
PK-3
250 29TH STREET NW, MASSILLON, OHIO 44646

[illegible]

PROJECT NO	2203-1
DRAWN BY	JRS
CHECKED BY	WMS
DATE	07/12/23

SECOND FLOOR
PLAN -
PLUMBING - UN
A

SCALE: 1/8" = 1'-0"

SHEET NO

P-202-A