



MATCHLINE - UNIT - A
MATCHLINE - UNIT - C

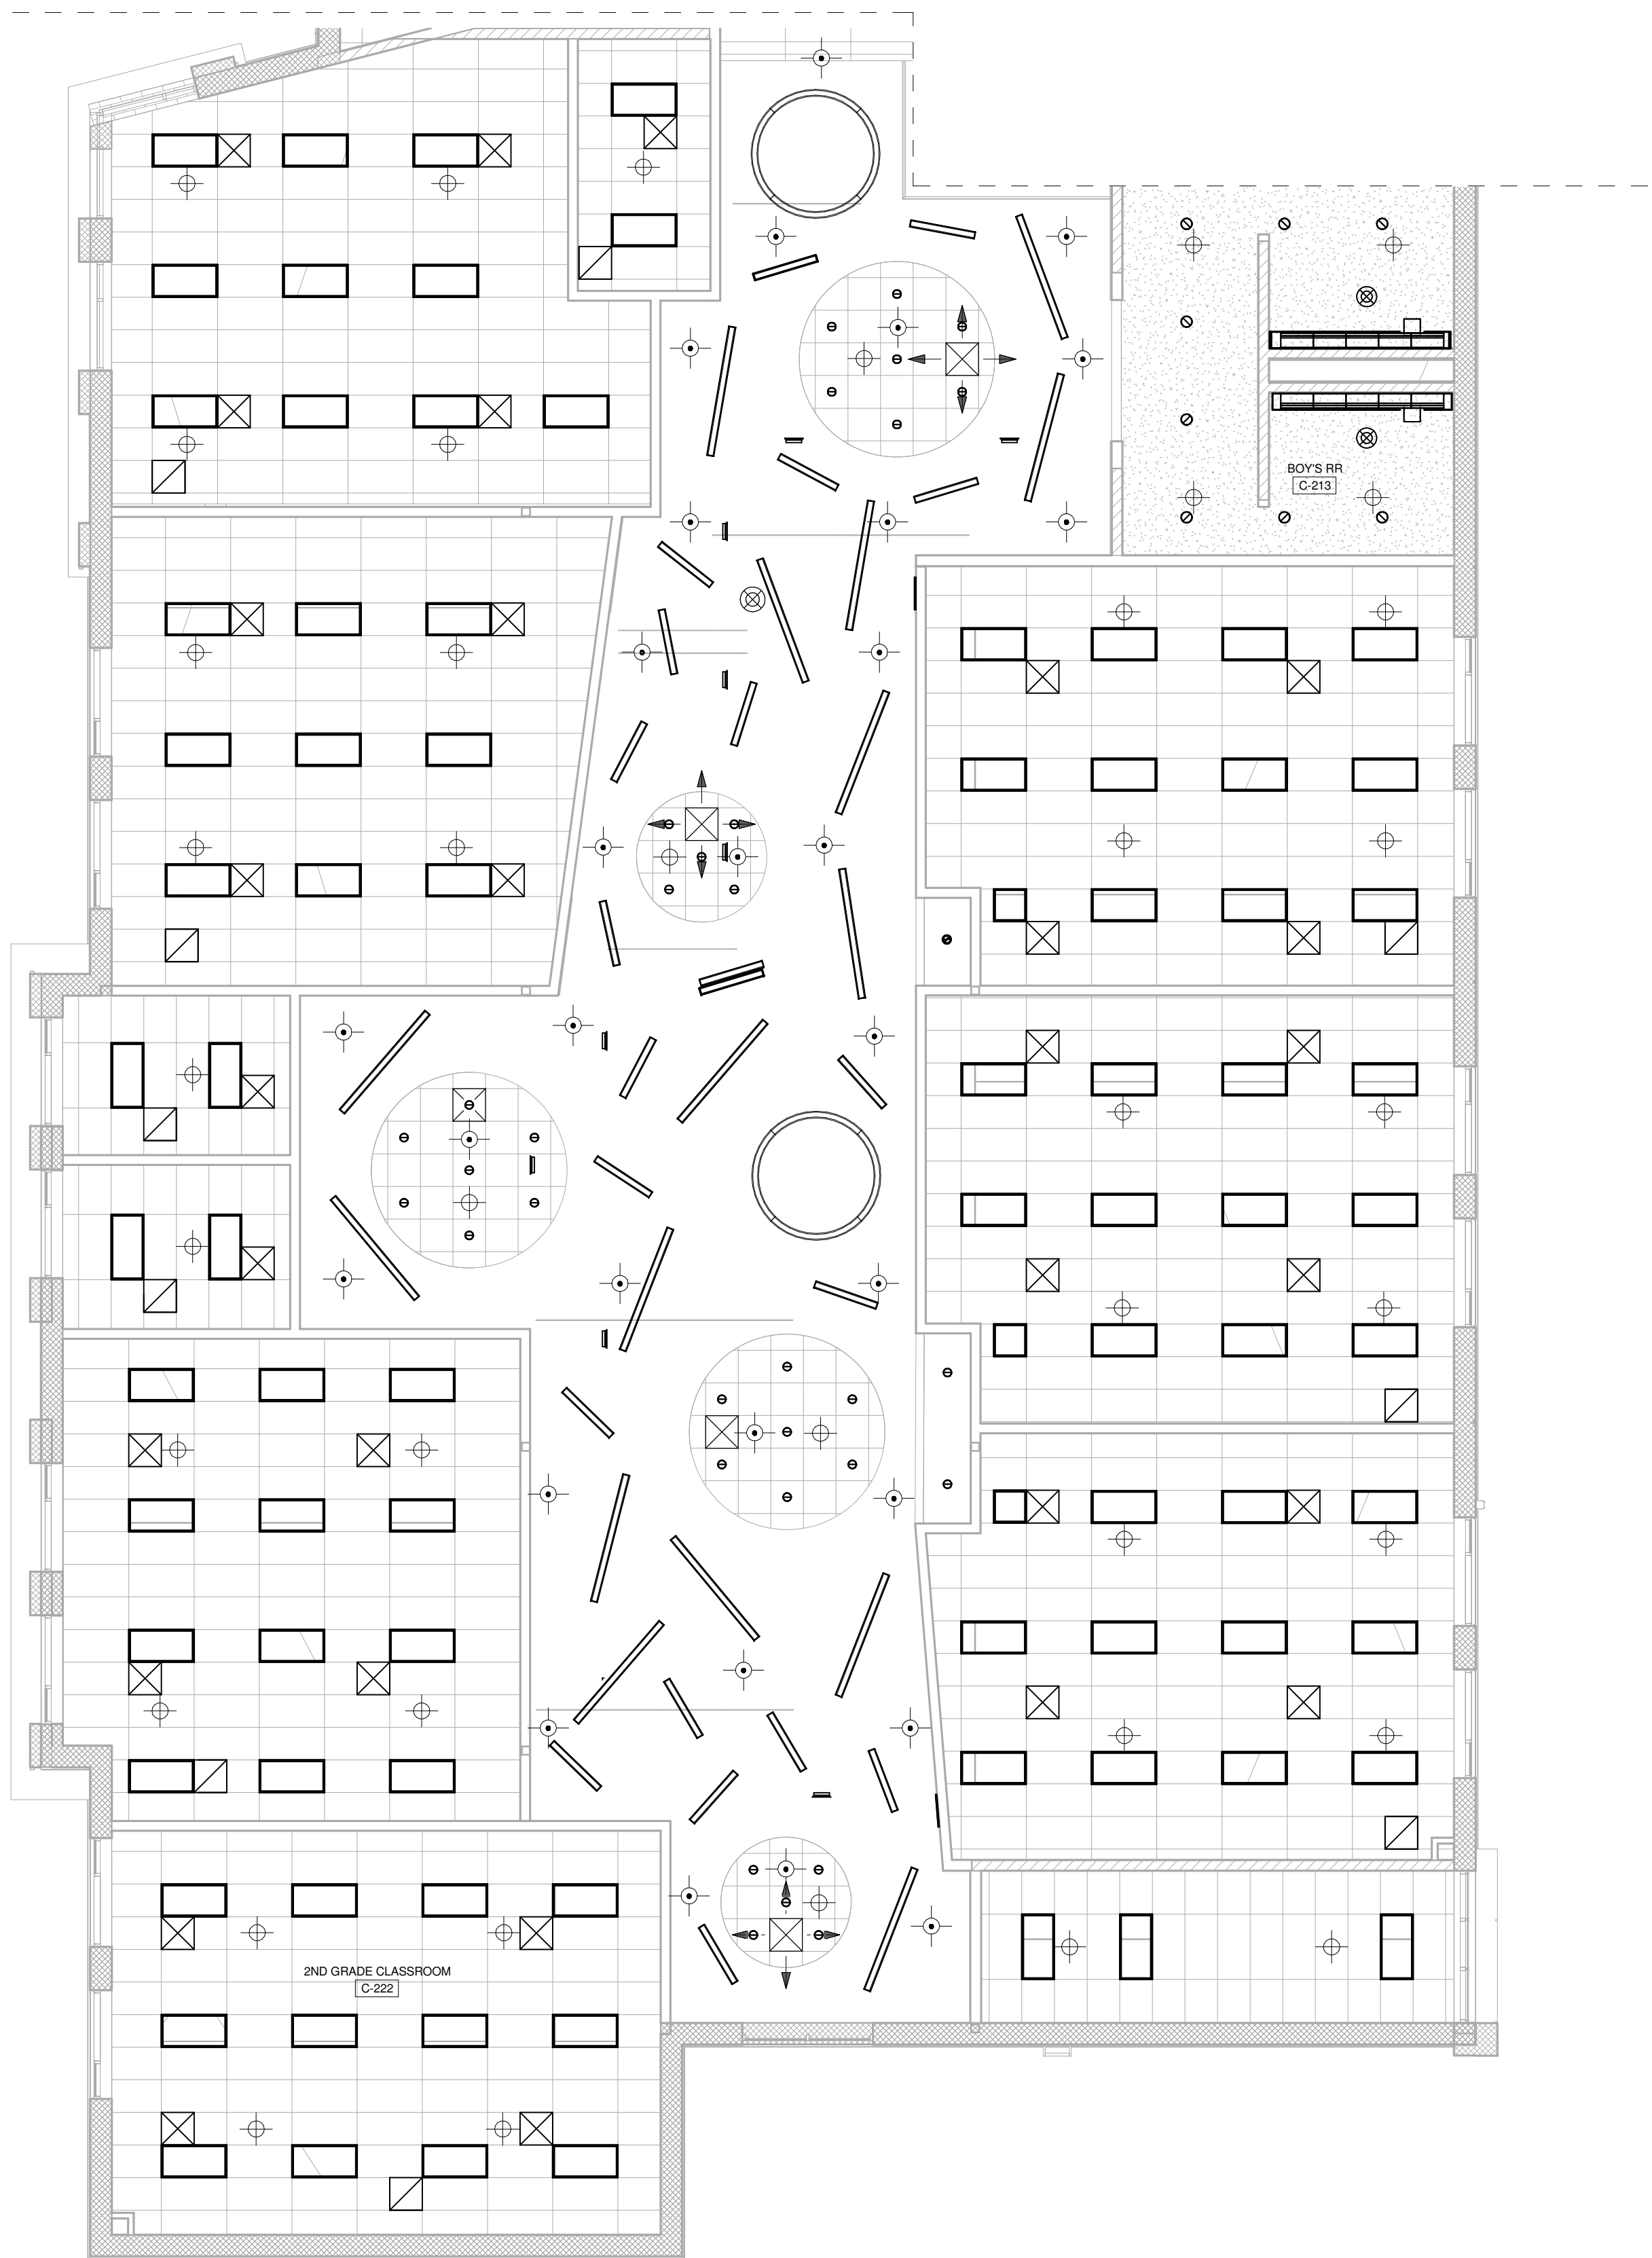

SECOND FLOOR PLAN - FIRE PROTECTION - UNIT C
SCALE: 1/8" = 1'-0"

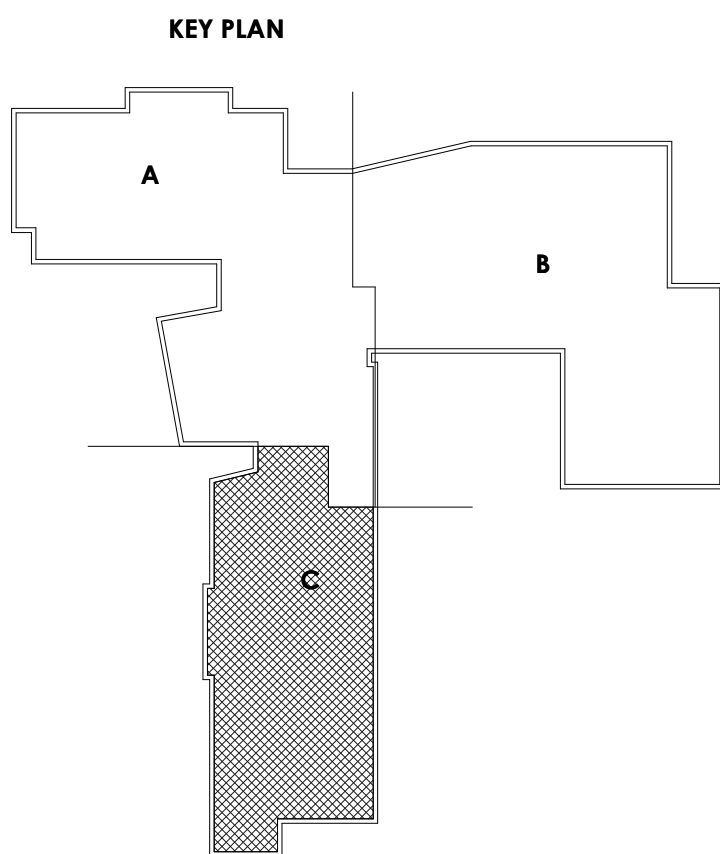

PROJECT NO
2203-1

ARCHITECTURAL VISION GROUP, LTD
ARCHITECTS
23850 SPERRY DRIVE
CLEVELAND, OHIO 44145

PLANNERS

PROFESSIONAL SEAL
STATE OF OHIO
JAMES VERSTO, INC.
CONSULTANT
JIM VERSTO, INC.
CONSULTANT
2700 S.W. 10TH AVE.
MIAMI, FL 33135

MASSILLON CITY SCHOOL
MASSILLON WEST ELEMENTARY
PK-3
250 29TH STREET NW, MASSILLON, OHIO 44646

ISSUED AS:
MARK
DATE
DESCRIPTION

PROJECT NO
2203-1
DRAWN BY
JRS
CHECKED BY
WMS
DATE
07/12/23

SECOND FLOOR
PLAN - FIRE
PROTECTION -
UNIT C
SCALE: 1/8" = 1'-0"
SHEET NO
FP-102-C