



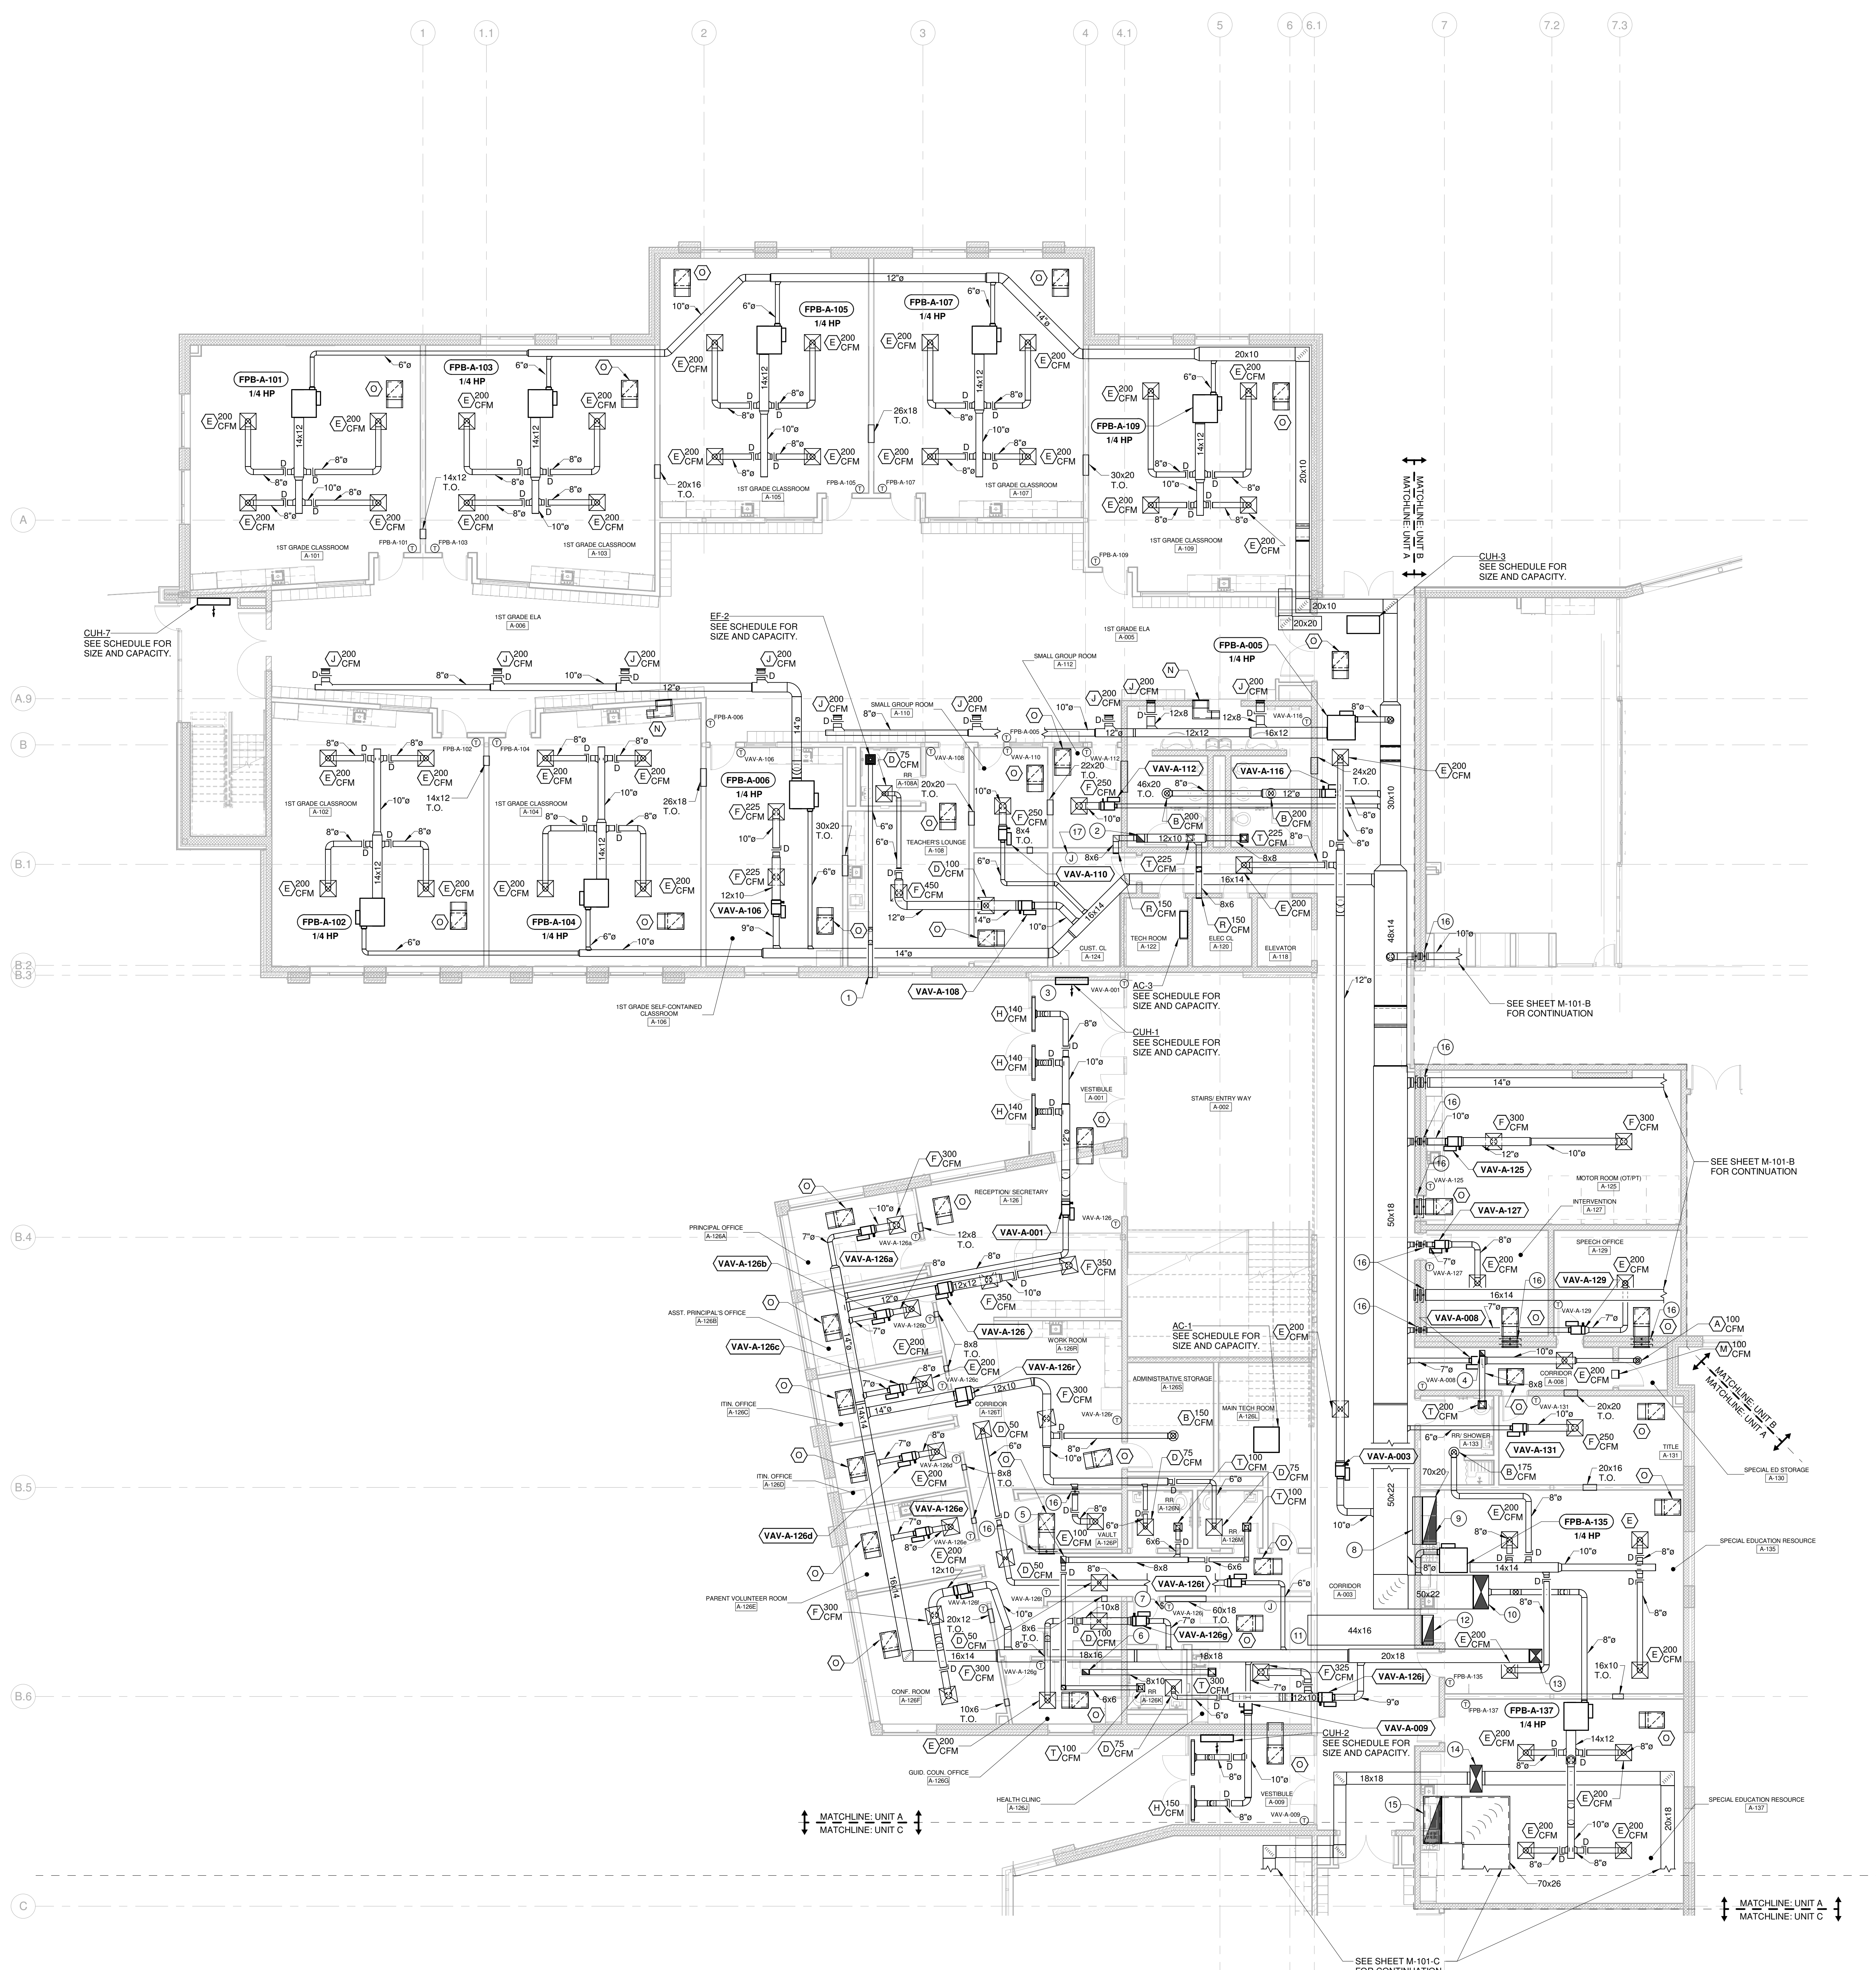

FIRST FLOOR PLAN - HVAC - UNIT A
SCALE: 1/8" = 1'-0"

- CODED NOTES:**
- 8"Ø EA DUCT FROM EF-2. EXTEND THROUGH WALL AND TERMINATE WITH BRICK VENT.
 - 12x12 EA DUCT UP THROUGH FLOOR. SEE SHEET M-102-A FOR CONTINUATION.
 - CUH TO BE INSTALLED WITHIN CASEWORK WITH RECESSED INSTALLATION KIT.
 - 8x8 EA DUCT UP THROUGH ROOF. TRANSITION FOR CONNECTION TO EF-4 ON ROOF.
 - 10x8 EA DUCT UP THROUGH ROOF. TRANSITION FOR CONNECTION TO EF-3.
 - 10x8 EA DUCT UP THROUGH ROOF. TRANSITION FOR CONNECTION TO EF-4.
 - SPRING WOUND TIMER INTERLOCKED WITH EF-4.
 - 70x20 RA OPENING ABOVE CEILING. COVER OPENING WITH 1"x1" WIRE SCREEN.
 - 70x20 RA UP TO SECOND FLOOR. SEE SHEET M-103-A FOR CONTINUATION.
 - 50x22 SA DOWN FROM FLOOR ABOVE. TRANSITION FROM CONNECTION TO UNIT AND ROUTE THROUGH FLOOR. BRANCH OFF 8"Ø BEFORE ELBOW.
 - 44x16 RA OPENING ABOVE CEILING. COVER OPENING WITH 1"x1" WIRE SCREEN.
 - 44x16 RA UP TO SECOND FLOOR. SEE SHEET M-103-A FOR CONTINUATION.
 - 20x18 SA DOWN FROM FLOOR ABOVE. TRANSITION FROM CONNECTION TO UNIT AND ROUTE THROUGH FLOOR.
 - 40x18 SA DOWN FROM FLOOR ABOVE. SPLIT INTO 18x18 AND 20x18 AS SHOWN.
 - 70x28 RA UP TO FLOOR ABOVE. SEE SHEET M-103-A FOR CONTINUATION.
 - INSTALL 1.5 HOUR RATED FIRE DAMPER IN DUCT AT EACH WALL PENETRATION. PROVIDE ACCESS DOORS IN DUCT.
 - JUNCTION BOX WITH 120V CIRCUIT WIRING FOR USE BY TEMPERATURE CONTROLS CONTRACTOR.

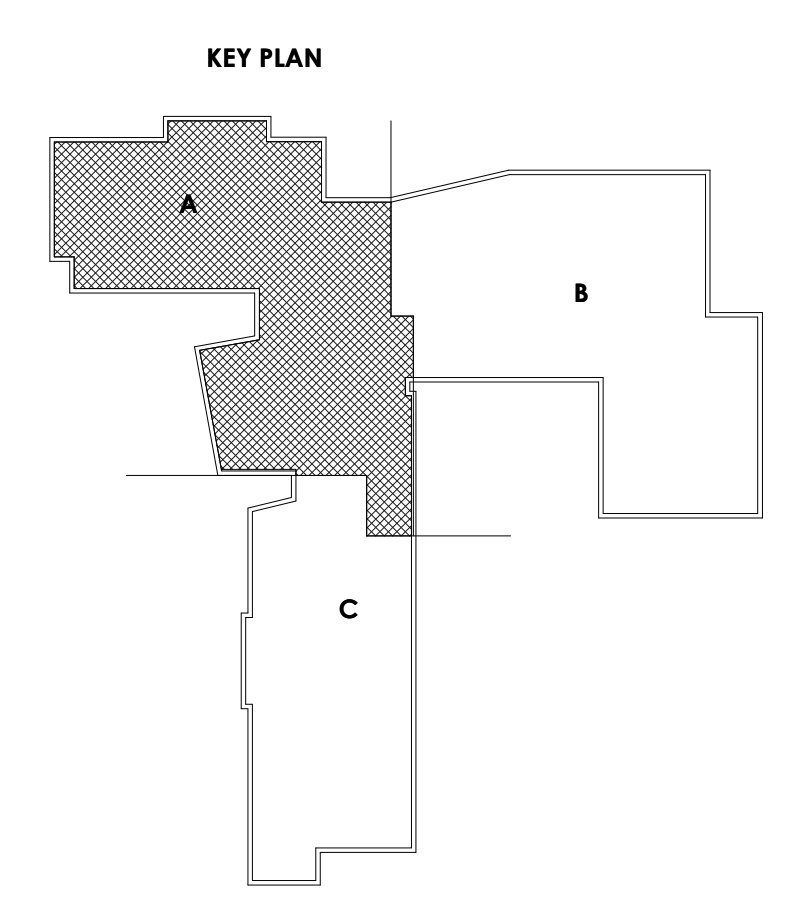

PROJECT NO
2203-1

ARCHITECTURAL VISION GROUP, LTD
PLANNERS
ARCHITECTS
23850 SPERRY DRIVE
CLEVELAND, OHIO 44145

MASSILLON CITY SCHOOL
MASSILLON WEST ELEMENTARY
PK-3
250 29TH STREET NW, MASSILLON, OHIO 44646

07/12/23
MAR 2024
ISSUED AS:

PROJECT NO 2203-1
DRAWN BY MAR
CHECKED BY ARB
DATE 07/12/23

FIRST FLOOR
PLAN - HVAC -
UNIT A

SCALE: 1/8" = 1'-0"
SHEET NO
M-101-A