
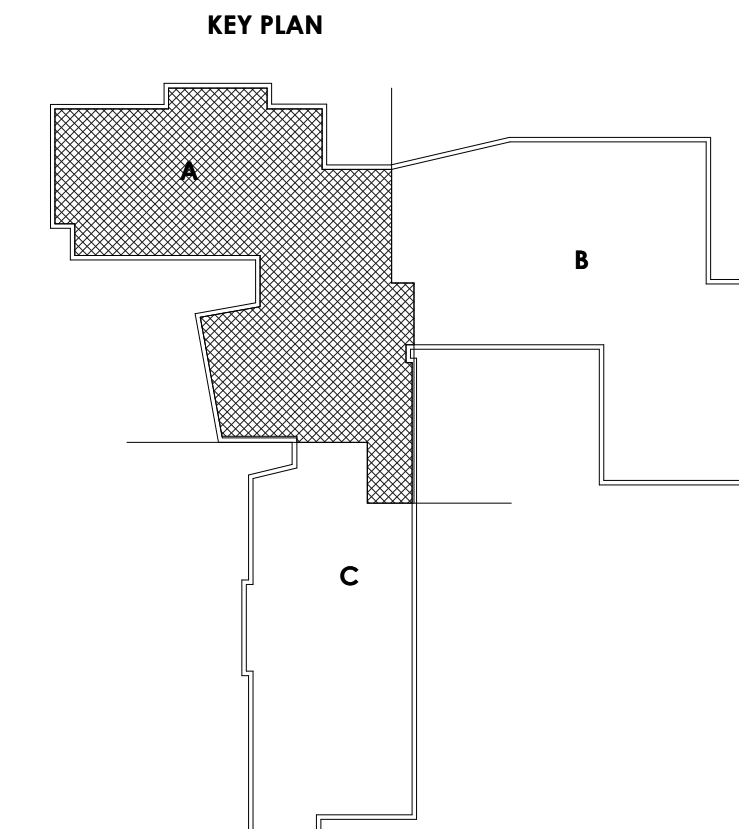



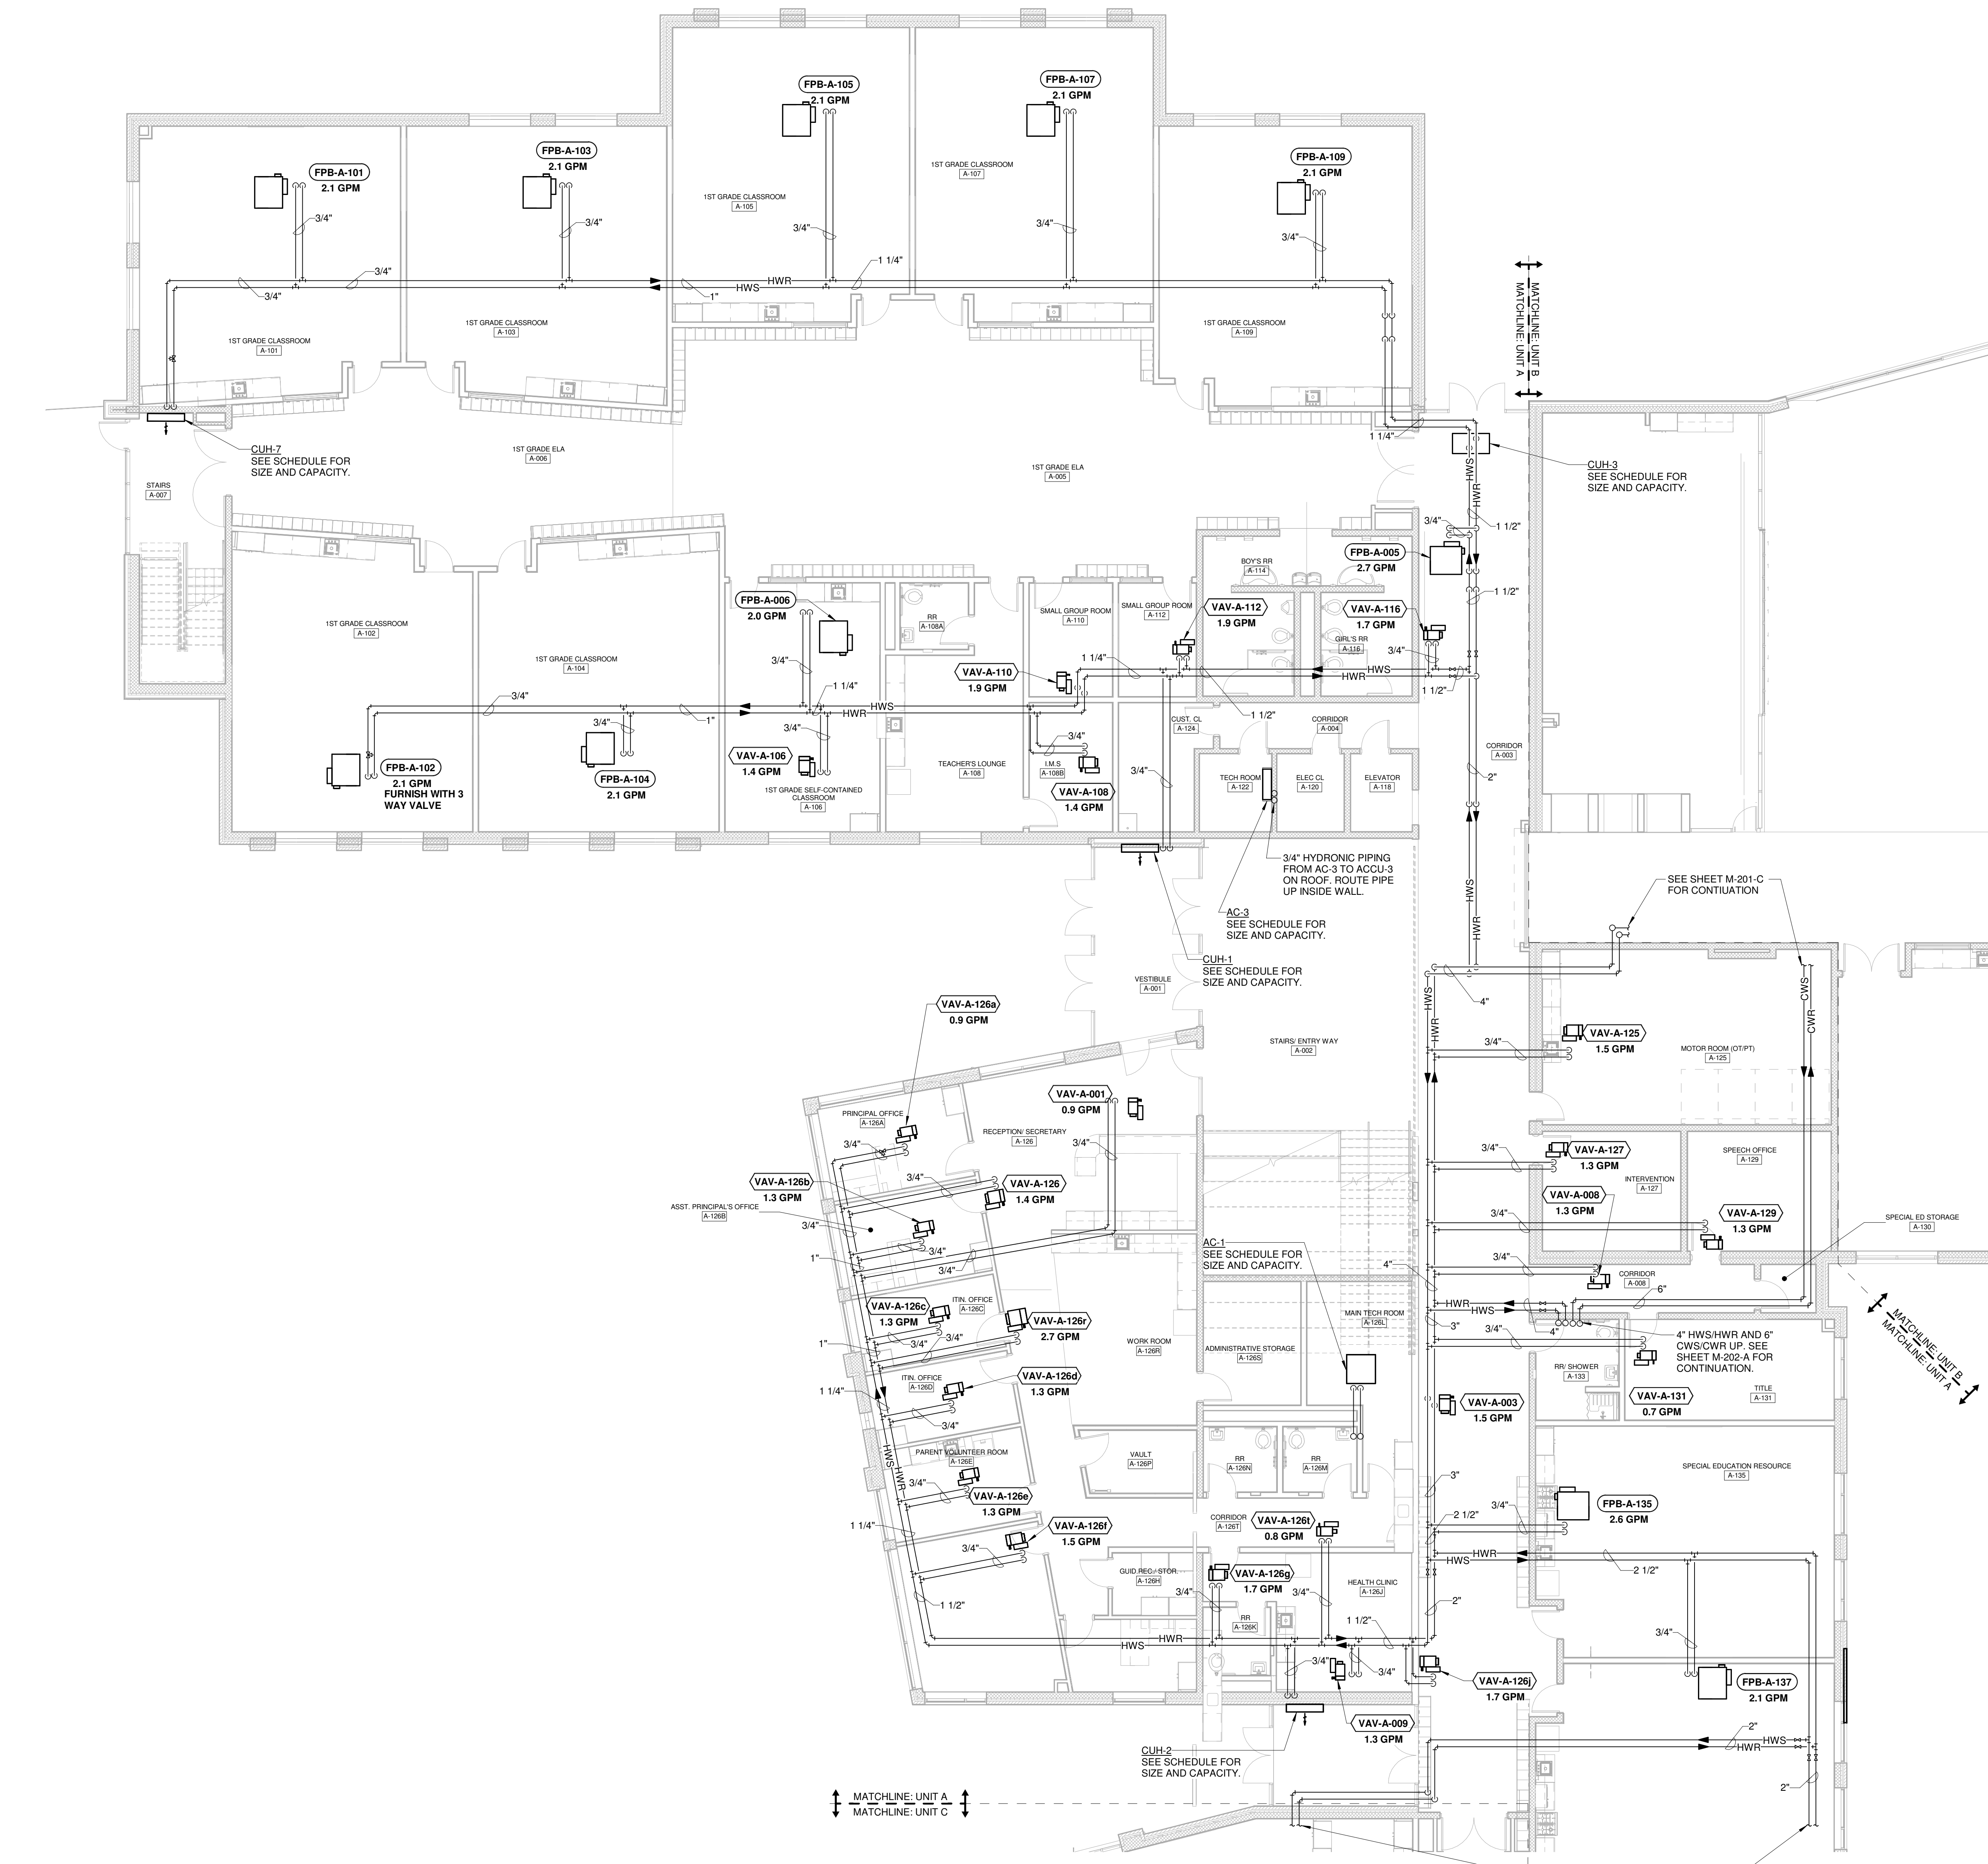


FIRST FLOOR PLAN - HVAC PIPING - UNIT A
SCALE: 1/8" = 1'-0"

PROJECT NO
2203-1

ARCHITECTURAL VISION GROUP, LTD
ARCHITECTS
23850 SPERRY DRIVE
CLEVELAND, OHIO 44145

PLANNERS

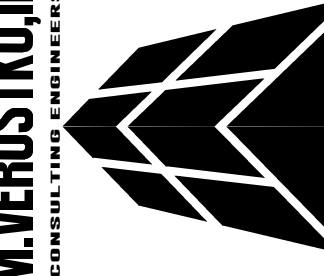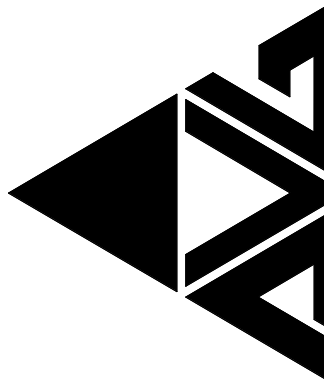

MASSILLON CITY SCHOOL
MASSILLON WEST ELEMENTARY
PK-3
250 29TH STREET NW, MASSILLON, OHIO 44646

07/15/23
100% BID PERMIT SET
ISSUED AS:

PROJECT NO 2203-1
DRAWN BY MAR
CHECKED BY ARB
DATE

FIRST FLOOR
PLAN - HVAC
PIPING - UNIT A

SCALE: 1/8" = 1'-0"
SHEET NO
M-201-A