


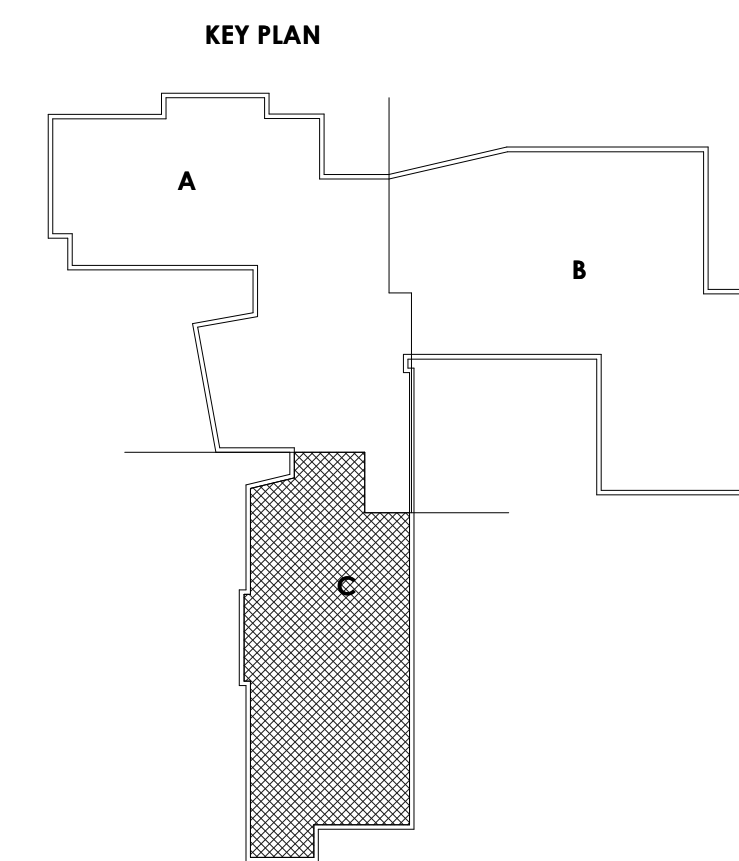

PROJECT NO 2203-1 ARCHITECTURAL VISION GROUP, LTD PLANNERS CLEVELAND, OHIO 44145													
													
 PROFESSIONAL SEAL													
CONSULTANT JWILVERSTROM, INC. AN IRVING-CLOUD COMPANY  JWILVERSTROM, INC. AN IRVING-CLOUD COMPANY													
MASSILLON CITY SCHOOL MASSILLON WEST ELEMENTARY PK-3 250 29TH STREET NW, MASSILLON, OHIO 44646 PROJECT NO 2203-1 DRAWN BY MAR CHECKED BY ARB DATE													
<table border="1" style="width: 100%; border-collapse: collapse;"> <thead> <tr> <th style="width: 10%;">MARK</th> <th style="width: 10%;">DATE</th> <th style="width: 10%;">REVISED / PERMIT SET</th> <th style="width: 70%;">DESCRIPTION</th> </tr> </thead> <tbody> <tr> <td> </td> <td> </td> <td>ISSUED AS:</td> <td> </td> </tr> </tbody> </table>						MARK	DATE	REVISED / PERMIT SET	DESCRIPTION			ISSUED AS:	
MARK	DATE	REVISED / PERMIT SET	DESCRIPTION										
		ISSUED AS:											
FIRST FLOOR PLAN - HVAC PIPING - UNIT C SCALE: 1/8" = 1'-0" SHEET NO M-201-C													

[illegible]

PROJECT NO	2209-1
DRAWN BY	MAR
CHECKED BY	ARB
DATE	

**FIRST FLOOR
PLAN - HVAC
PIPING - UNIT C**

SCALE: 1/8" = 1'-0"

SHEET NO

M-201-C