



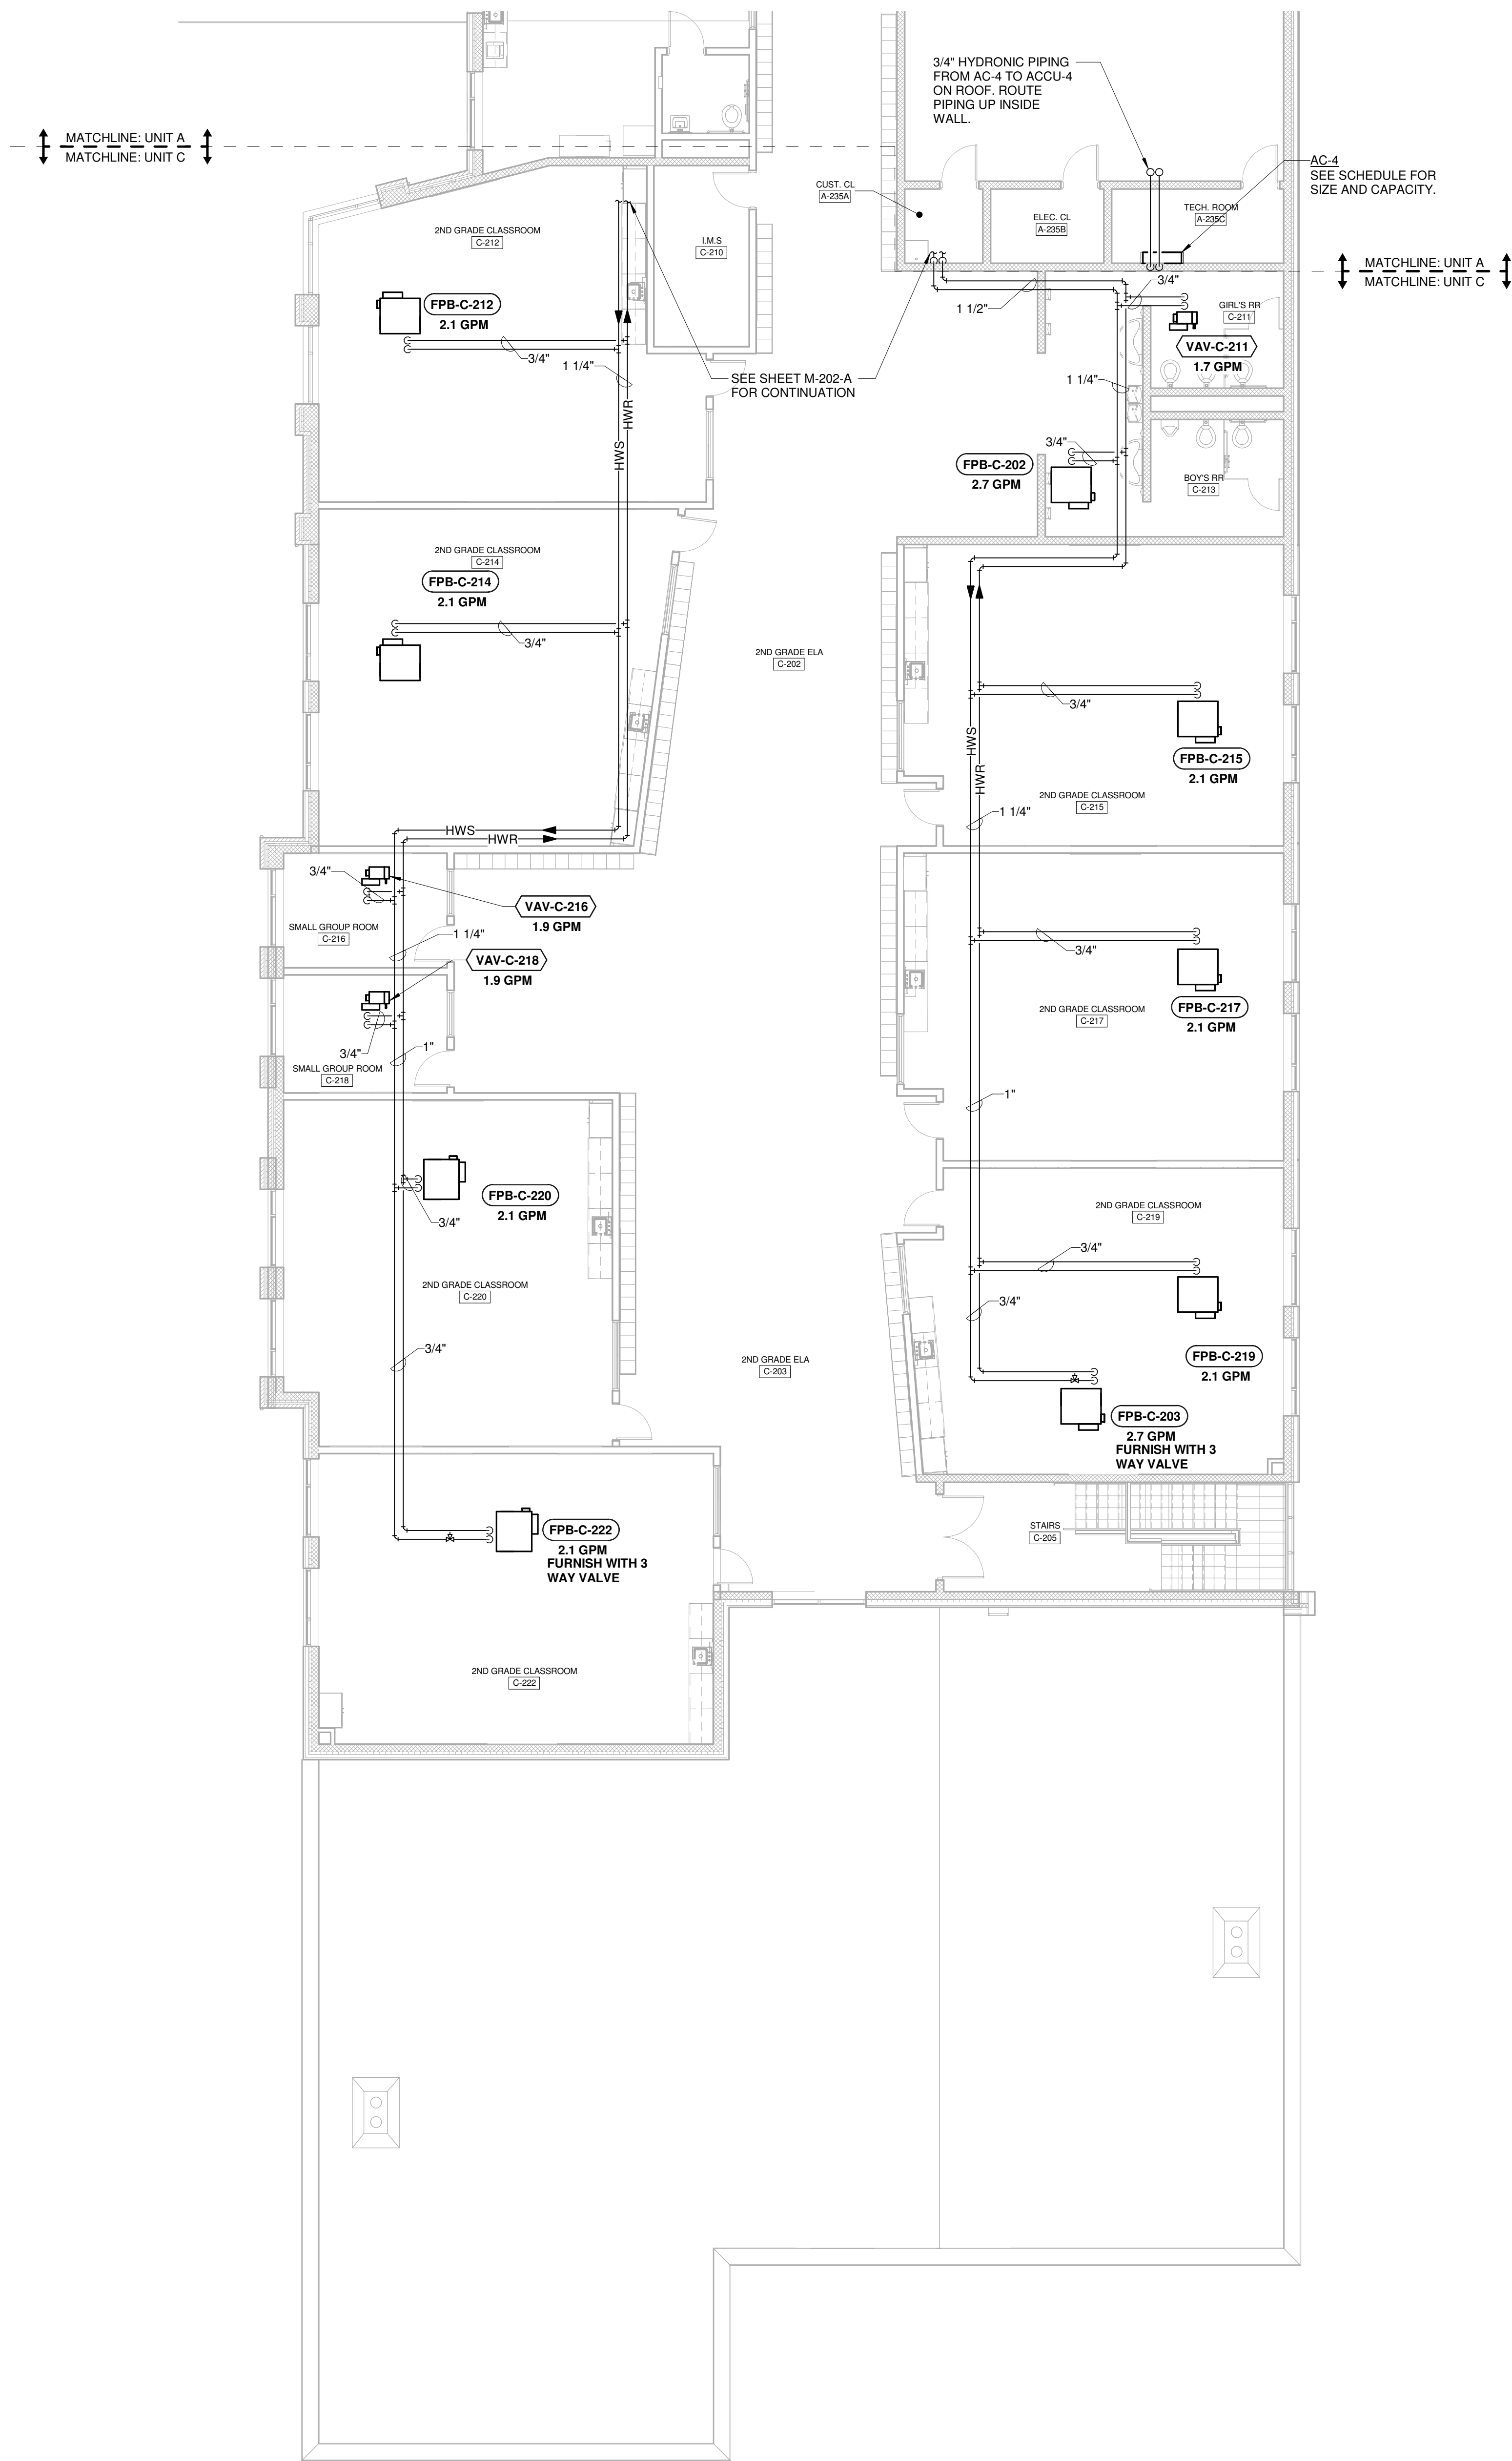



SECOND FLOOR PLAN - HVAC PIPING - UNIT C
SCALE: 1/8" = 1'-0"

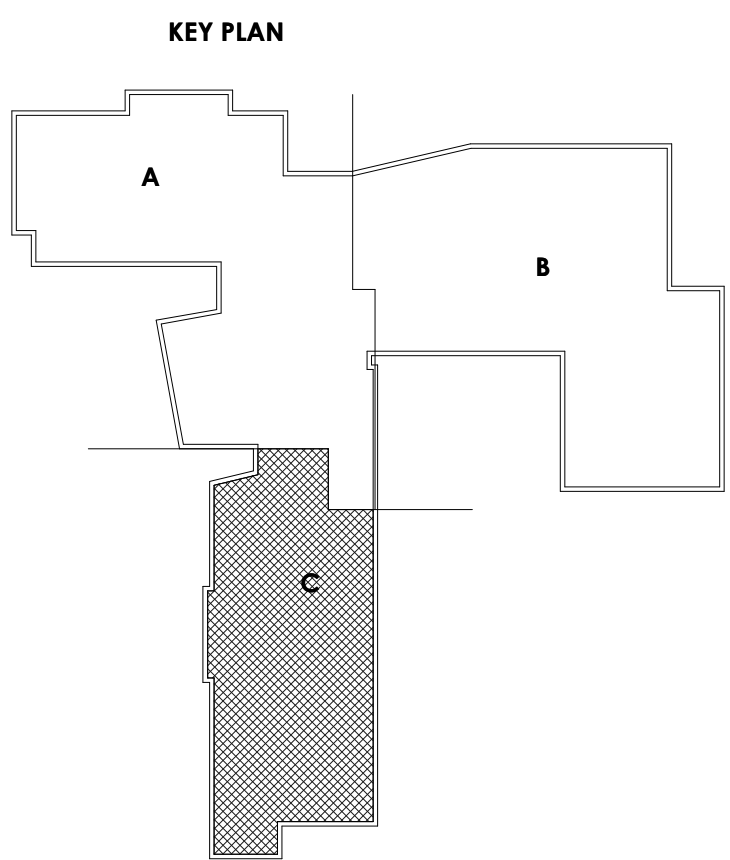


PROJECT NO
2203-1

ARCHITECTURAL VISION GROUP, LTD
ARCHITECTS
PLANNERS
23850 SPERRY DRIVE
CLEVELAND, OHIO 44145

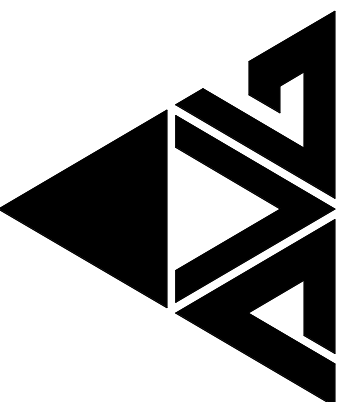

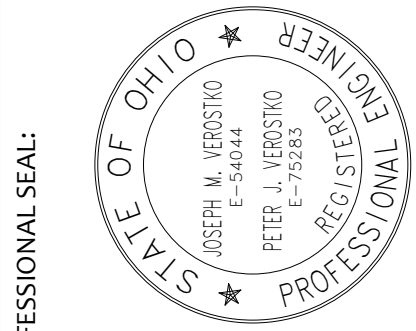

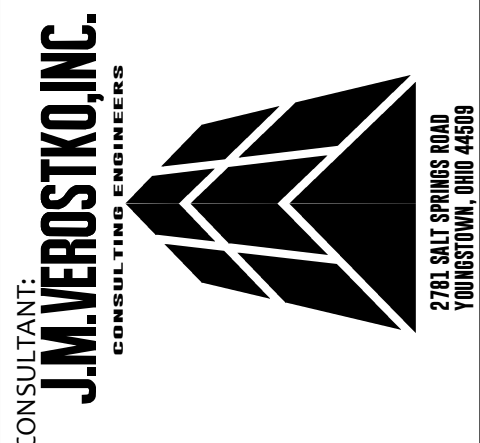

MASSILLON CITY SCHOOL
MASSILLON WEST ELEMENTARY
PK-3
250 29TH STREET NW, MASSILLON, OHIO 44646

DATE	ISSUED FOR	DESCRIPTION
07/12/23	100% BID PERMIT SET	
07/12/23	ISSUED FOR	

PROJECT NO 2203-1
DRAWN BY MAR
CHECKED BY ARB
DATE 07/12/23

SECOND FLOOR
PLAN - HVAC
PIPING - UNIT C
SCALE: 1/8" = 1'-0"
SHEET NO
M-202-C