




DETAIL OF ACOUSTICAL DUCT LINER
NOT TO SCALE

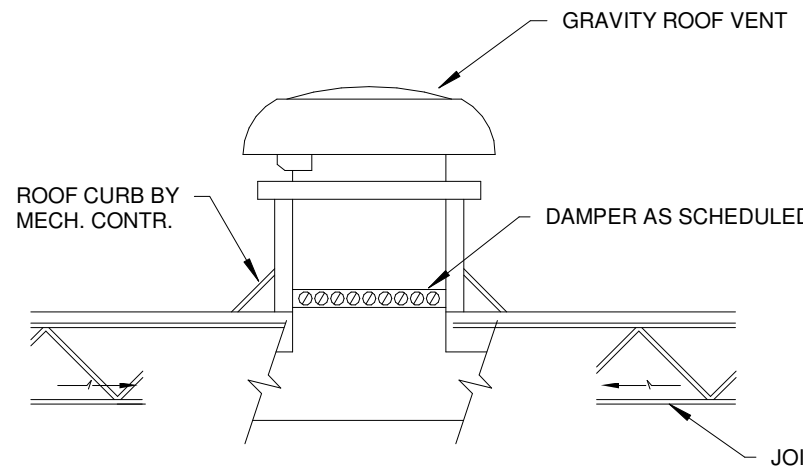

GRAVITY ROOF VENT (GRV) DETAIL
NOT TO SCALE

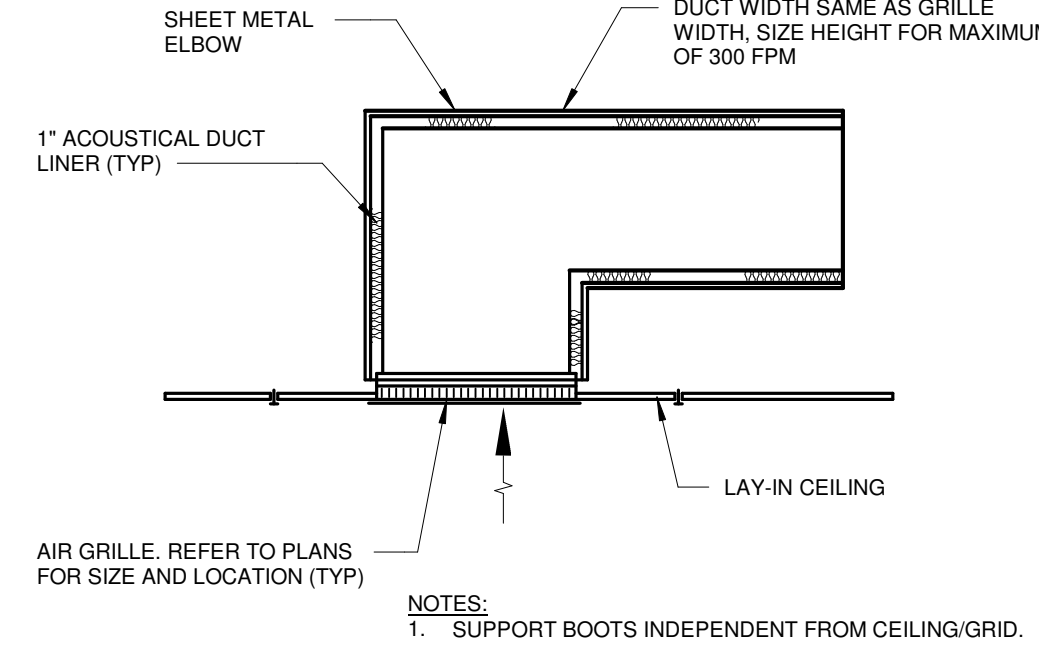


RETURN AIR BOOT
NOT TO SCALE

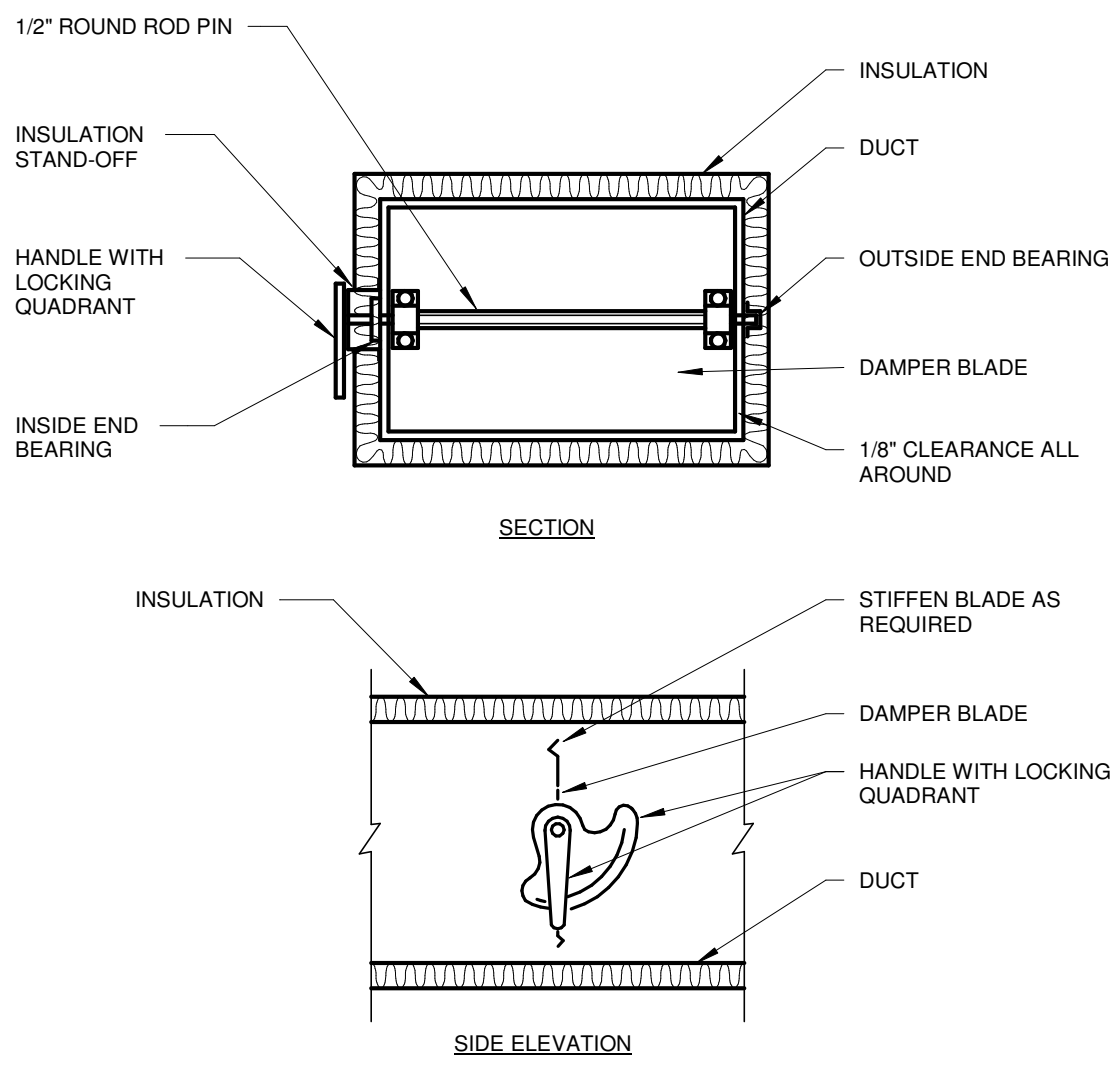


NOTES:
1. DELETE INSULATION STAND-OFF ON DUCTWORK WITHOUT EXTERIOR INSULATION.
DETAIL SHOWS SINGLE BLADE DAMPER. DAMPER INSULATION SHALL BE SIMILAR FOR MULTI-BLADE DAMPERS & ROUND DAMPERS.


VOLUME DAMPER
NOT TO SCALE

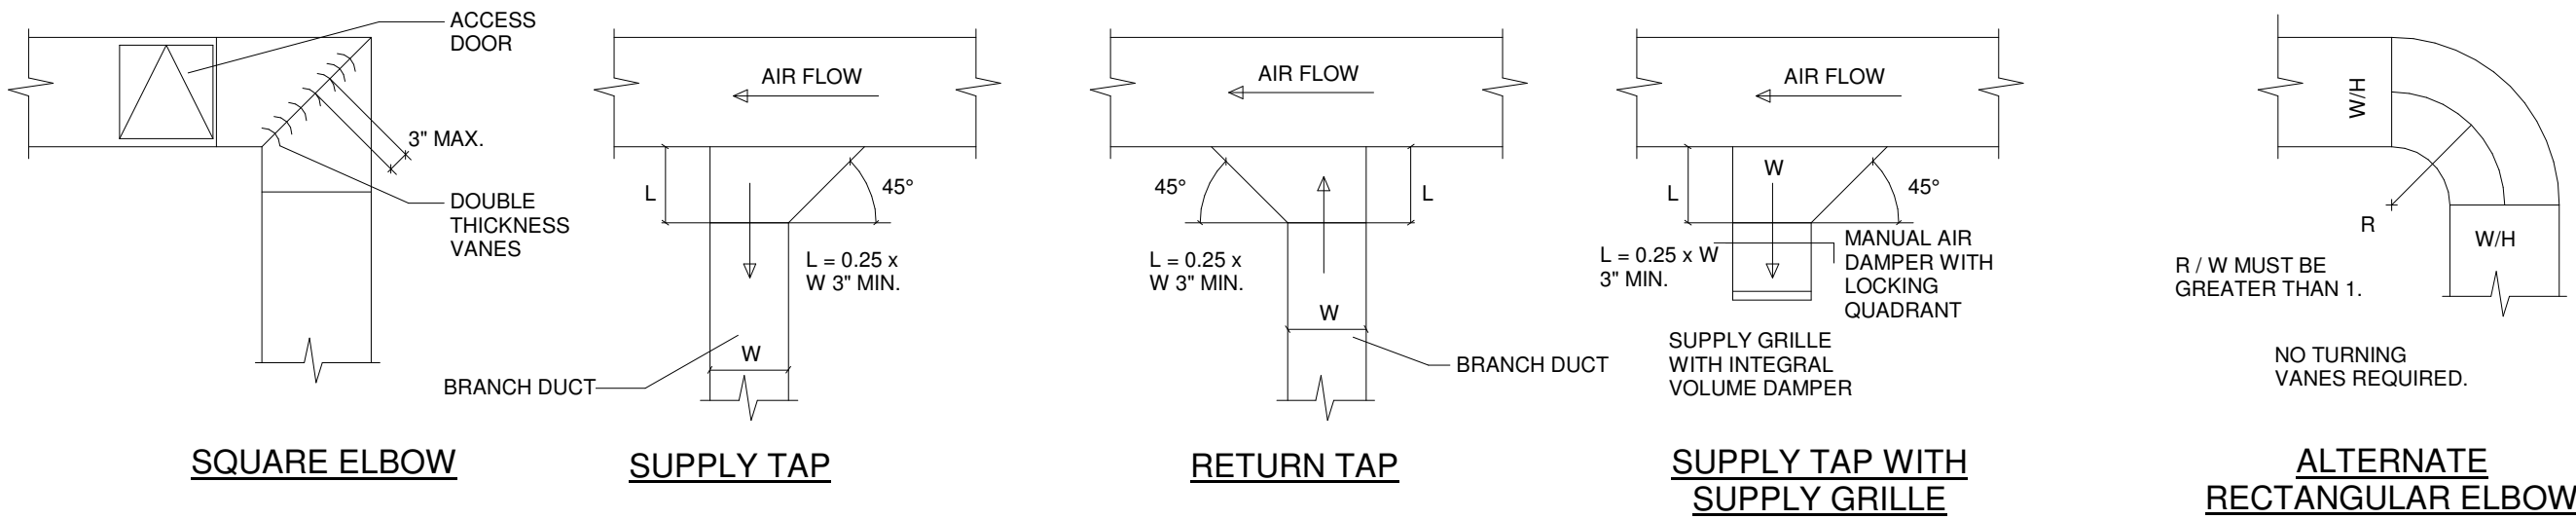


DUCTWORK DETAIL
NOT TO SCALE

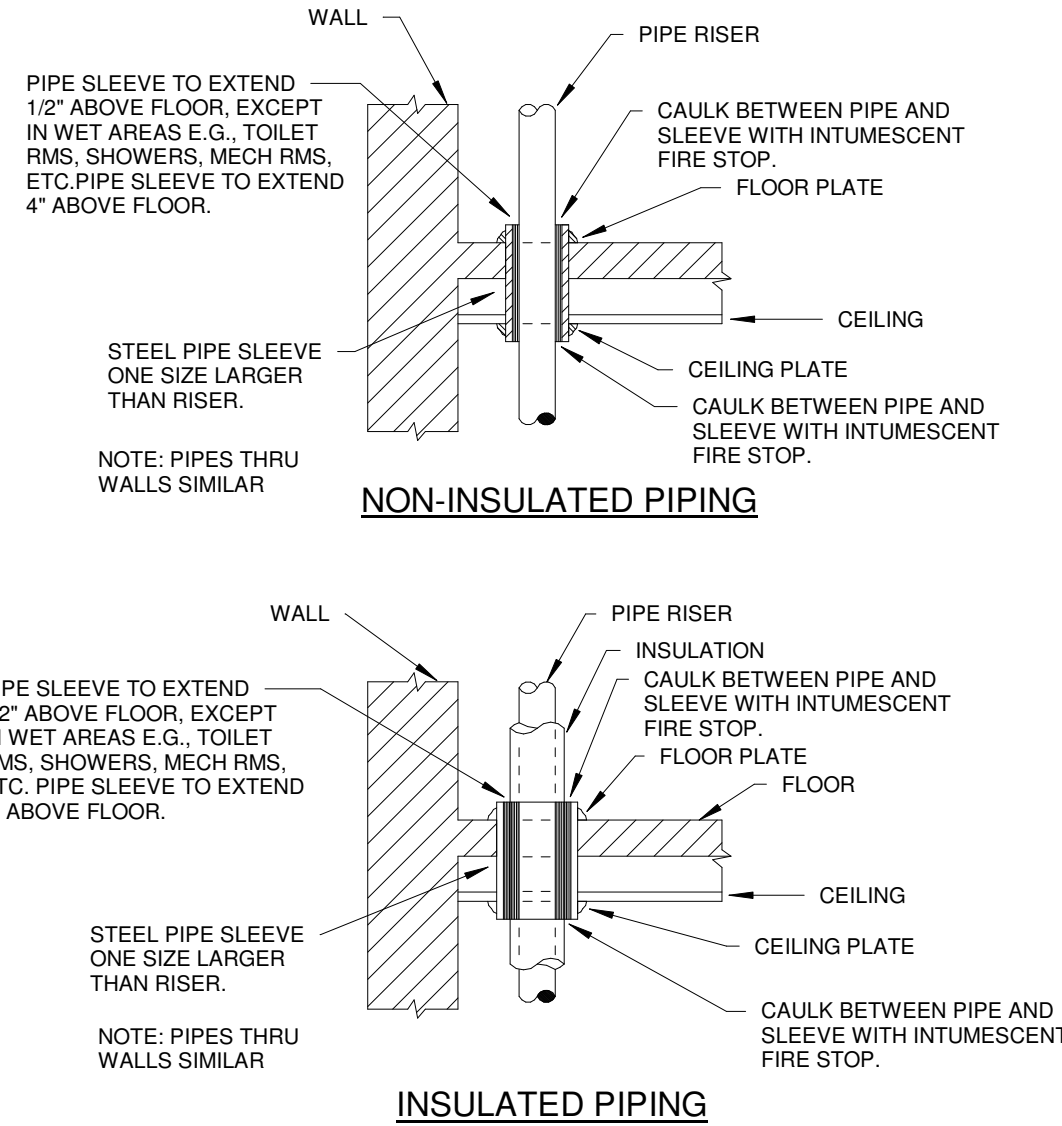


DETAIL OF PIPING PASSING THRU FLOORS
NOT TO SCALE

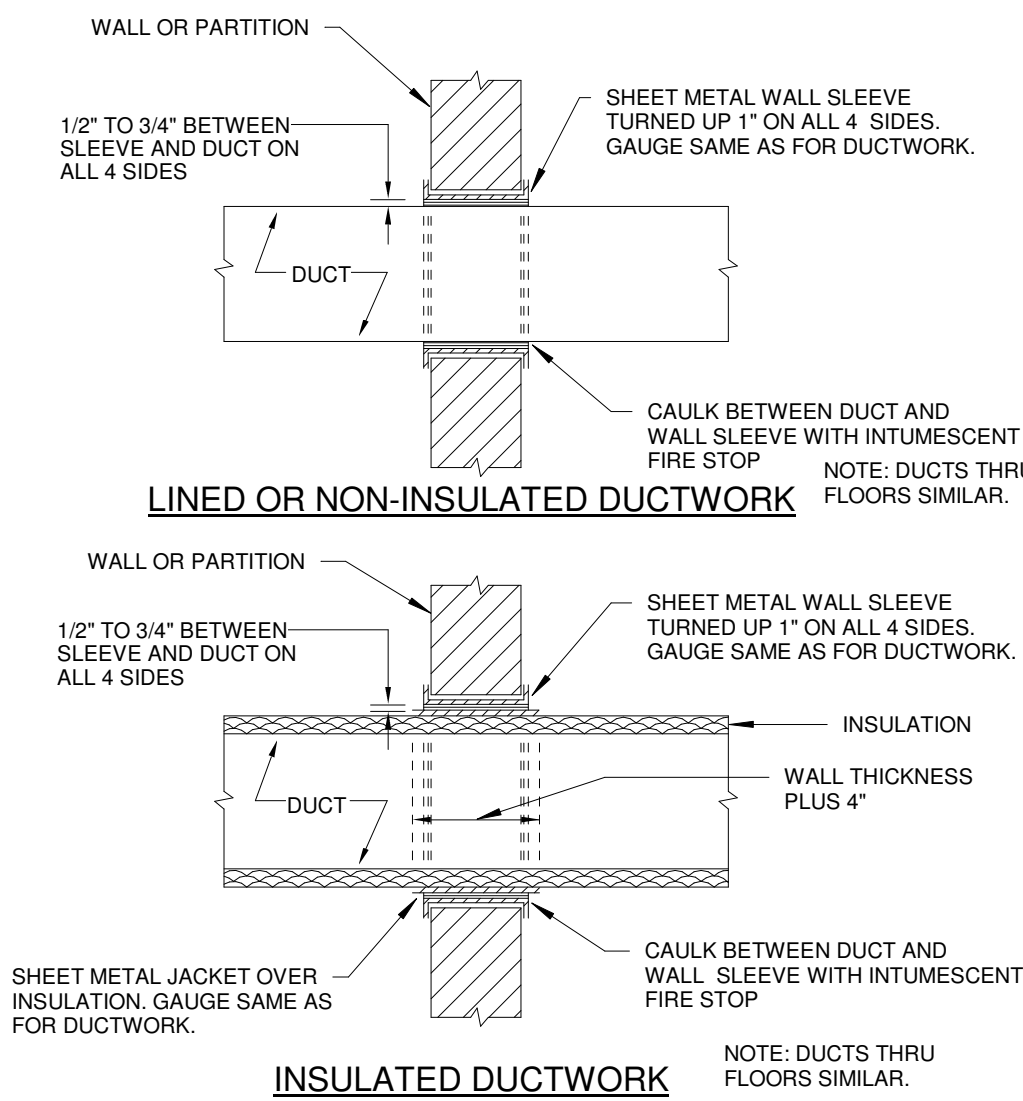

DETAIL OF DUCTS PASSING THRU WALLS OR PARTITIONS
NOT TO SCALE

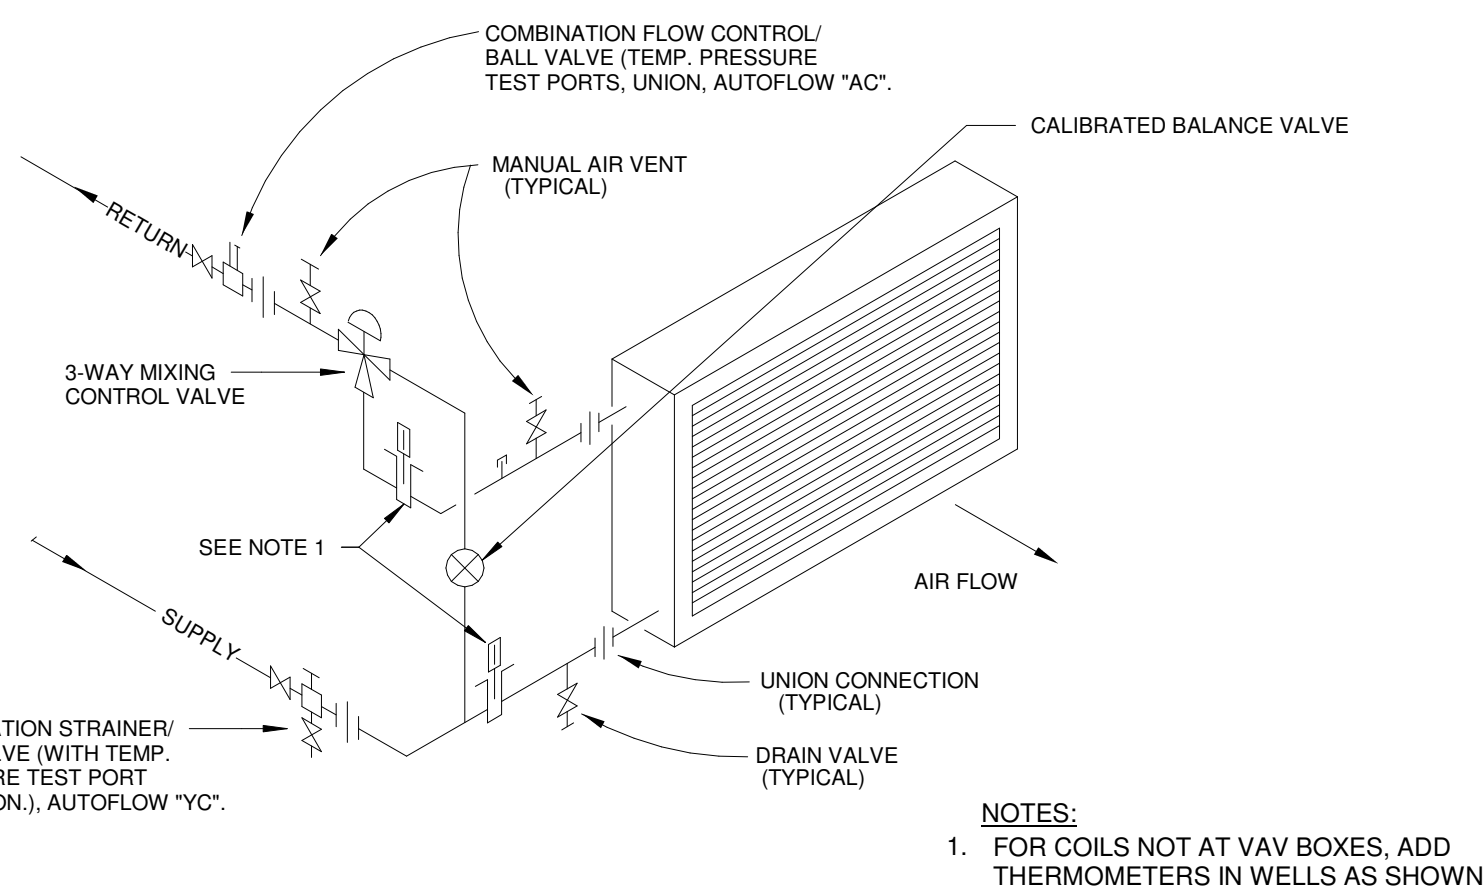




PIPING OF COIL WITH 3-WAY VALVE
NOT TO SCALE

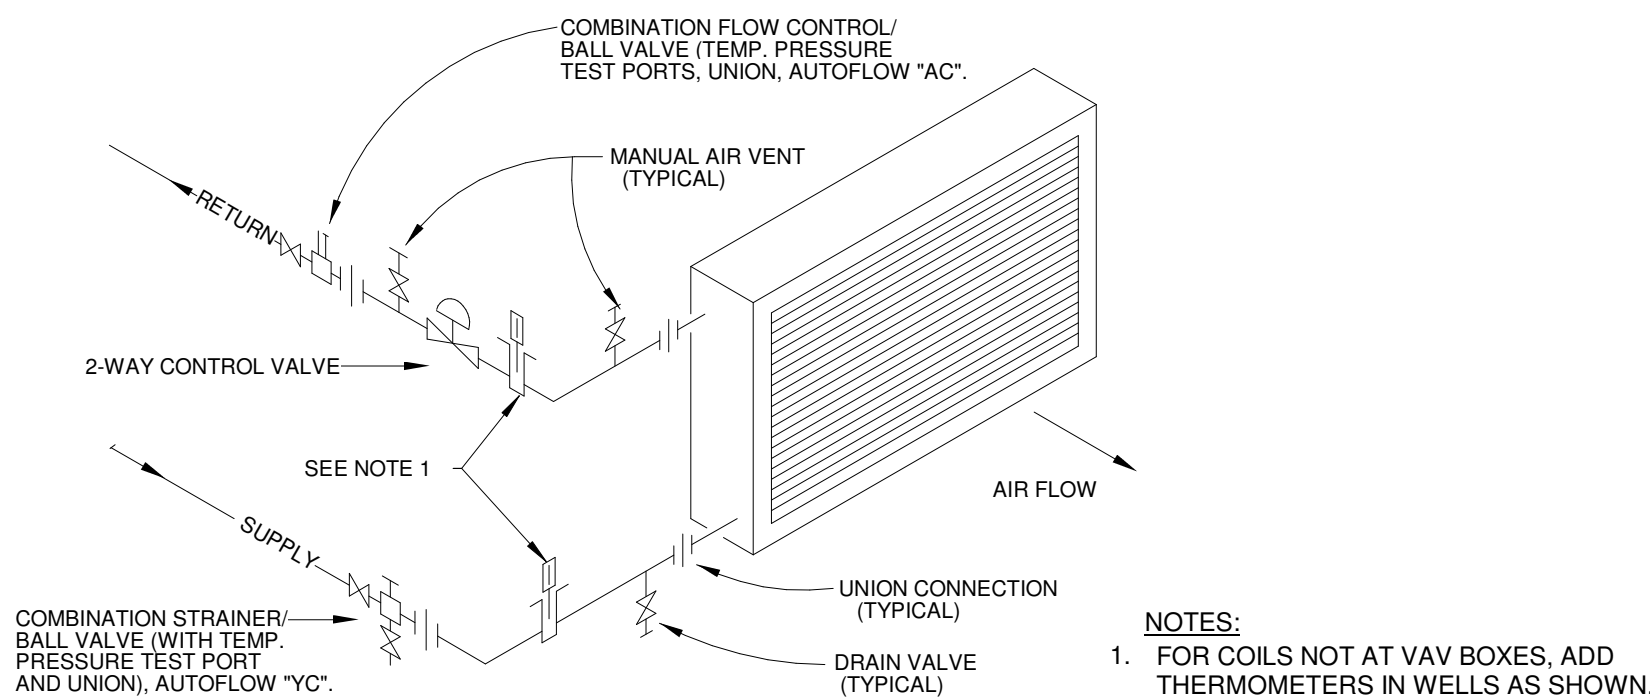

PIPING OF HEATING AND COOLING COIL WITH 2-WAY VALVE
NOT TO SCALE

PROJECT NO
2203-1

ARCHITECTURAL VISION GROUP, LTD
PLANNERS
ARCHITECTS
CLEVELAND, OHIO 44145
23850 SPERRY DRIVE

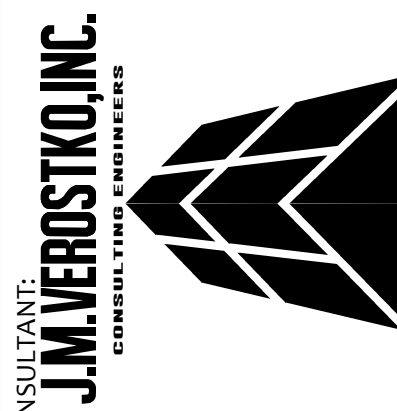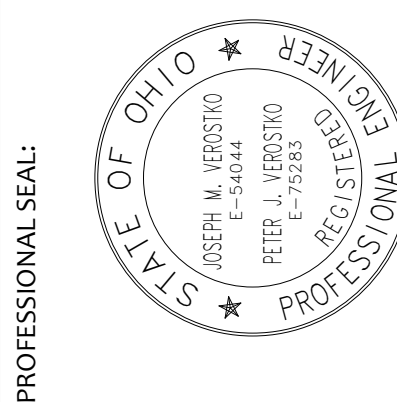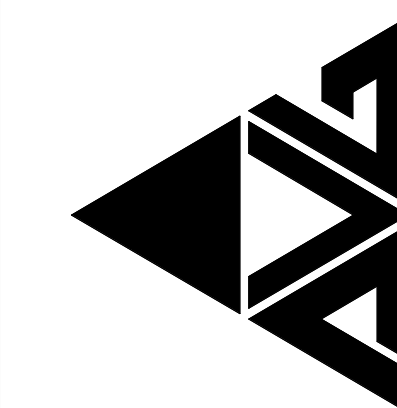

MASSILLON CITY SCHOOL
MASSILLON WEST ELEMENTARY
PK-3
250 29TH STREET NW, MASSILLON, OHIO 44646

DATE	ISSUED AS	DESCRIPTION
07/15/23	100% BID PERMIT SET	

PROJECT NO 2203-1
DRAWN BY MAR
CHECKED BY ARB
DATE

HVAC DETAILS

SCALE: As Indicated
SHEET NO
M-401