



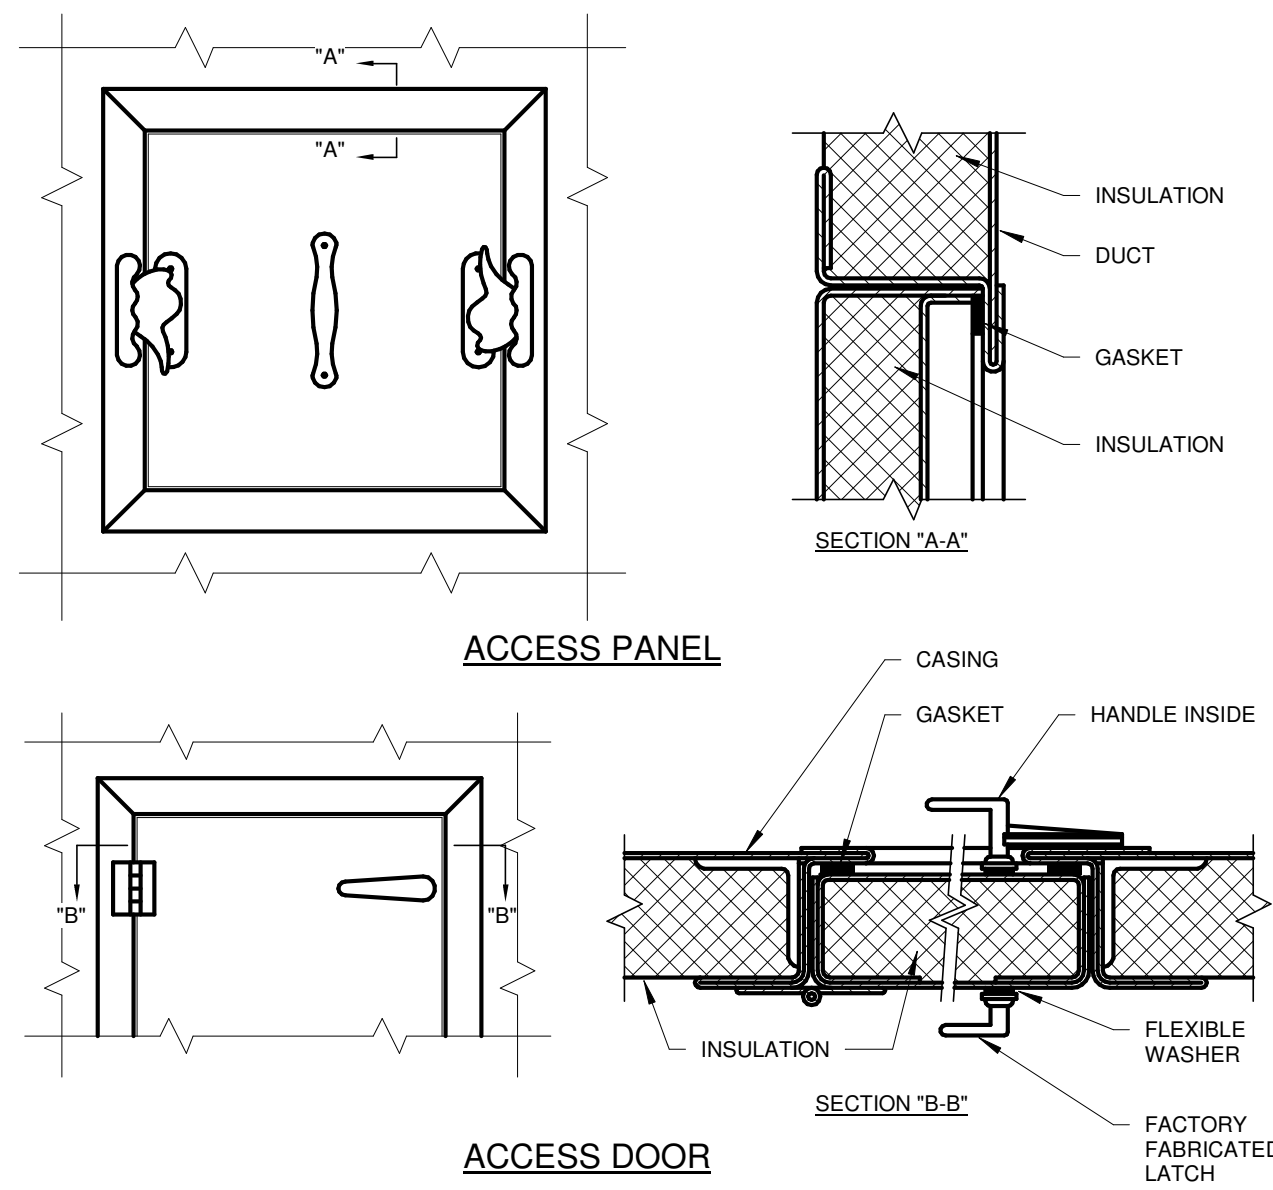


NOTES:
1. LATCHES SHALL BE OF THE WEDGE TYPE TO CLOSE DOORS TIGHTLY.
2. HINGES ON THE ACCESS DOORS SHALL HAVE NON CORROSIVE PINS.
3. SEE SMACNA 2005, FIGURE 9-15.

ACCESS PANEL AND DOOR
NOT TO SCALE

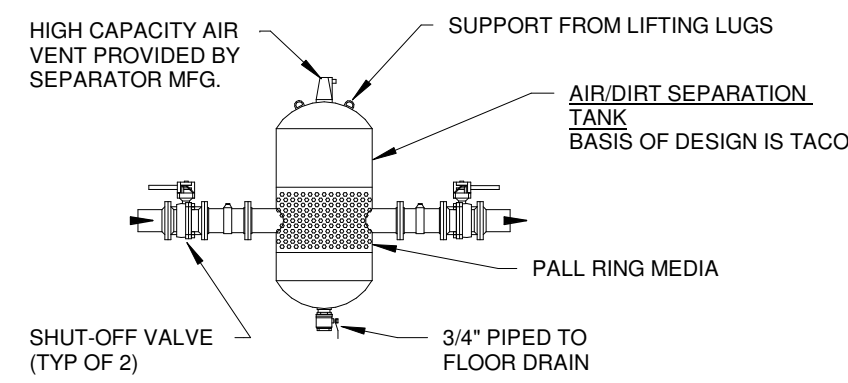


AIR AND DIRT SEPARATOR
NOT TO SCALE

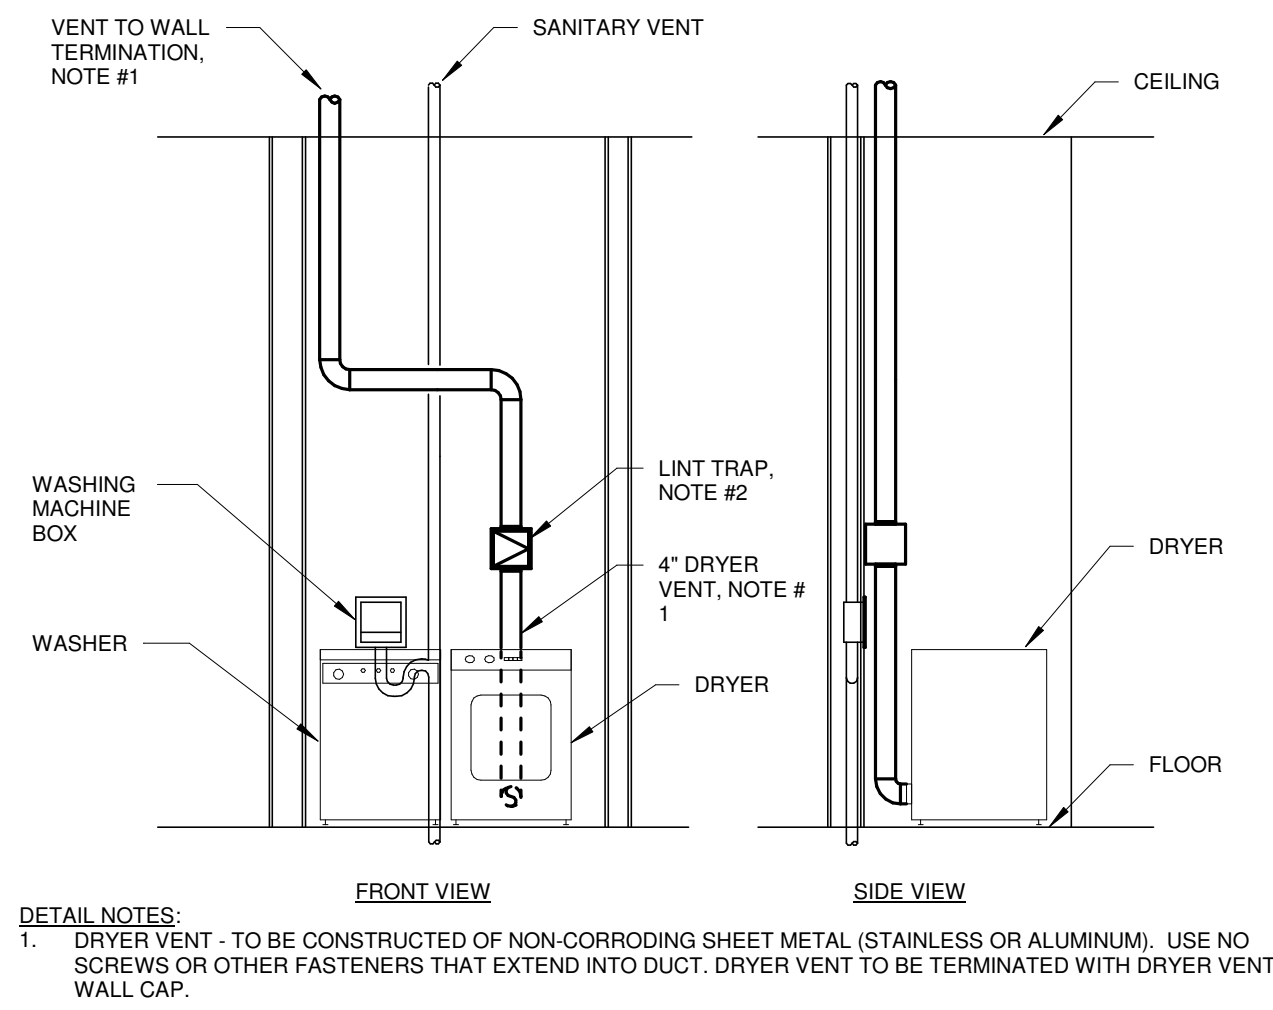


DETAIL NOTES:
1. DRYER VENT - TO BE CONSTRUCTED OF NON-CORRODING SHEET METAL (STAINLESS OR ALUMINUM). USE NO SCREWS OR OTHER FASTENERS THAT EXTEND INTO DUCT. DRYER VENT TO BE TERMINATED WITH DRYER VENT WALL CAP.

DRYER VENT & LINT TRAP
NOT TO SCALE

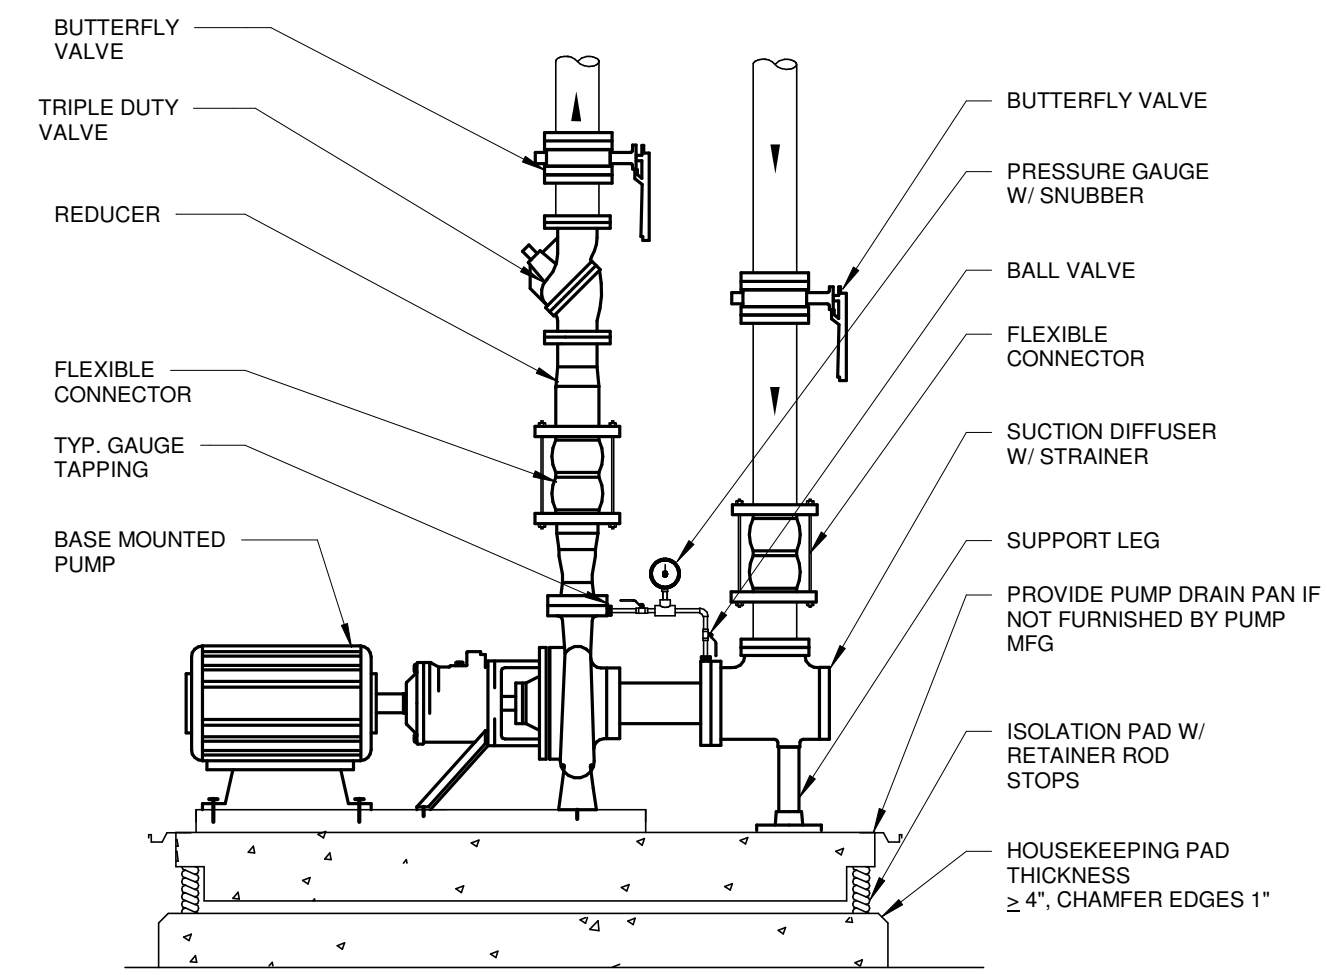


END SUCTION PUMP DETAIL
NOT TO SCALE

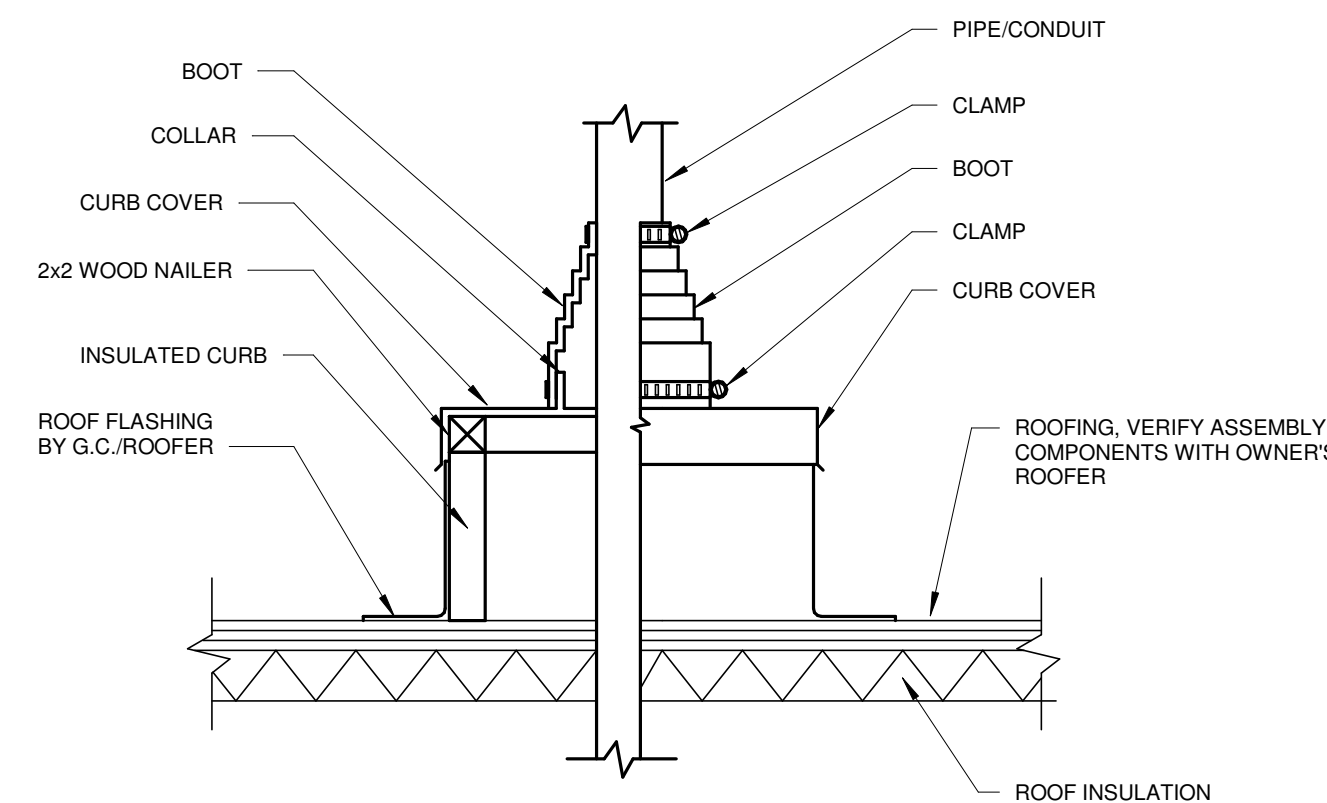


NOTES:
1. REFER TO MANUFACTURERS INSTALLATION REQUIREMENTS.
2. ONE PIPE/CONDUIT PER BOOT.

PIPE/CONDUIT CURB
NOT TO SCALE

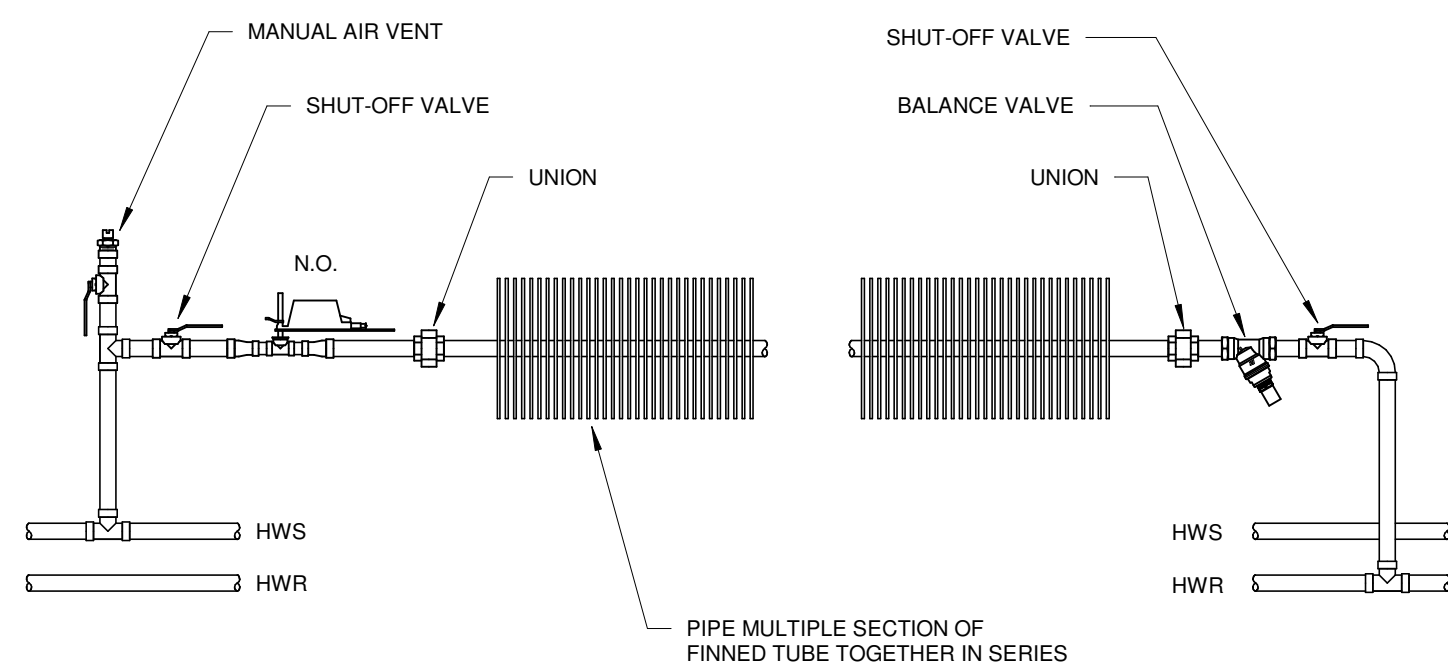

FINNED TUBE
SCALE: 1/8" = 1'-0"

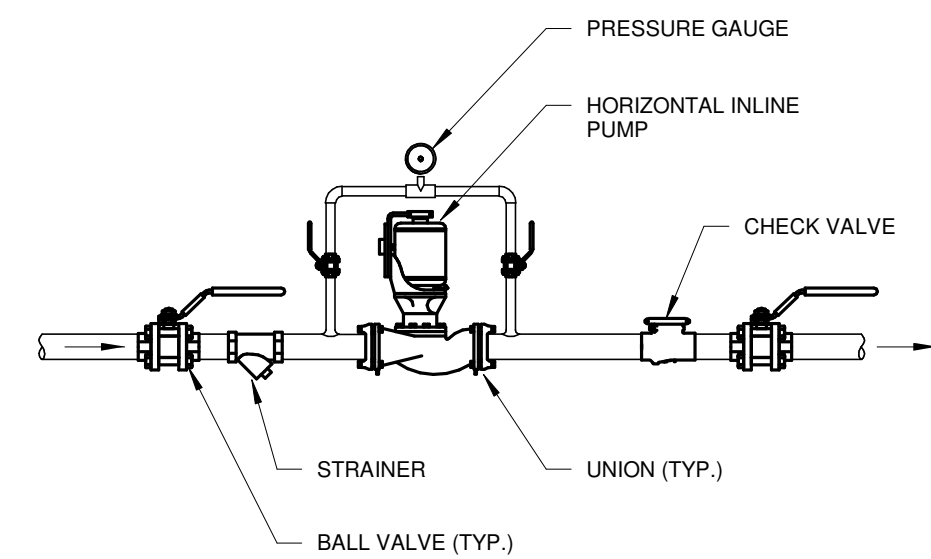

HORIZONTAL INLINE PUMP CONNECTION
SCALE: 1/8" = 1'-0"

PROJECT NO
2203-1

ARCHITECTURAL VISION GROUP, LTD
PLANNERS
ARCHITECTS
23850 SPERRY DRIVE
CLEVELAND, OHIO 44145

CONSULTANT
J.M. VERISTKO, INC.
GENERAL ENGINEERING

2718 BALL LIPPOW ROAD
PAINESVILLE, OHIO 44131

MASSILLON CITY SCHOOL
MASSILLON WEST ELEMENTARY
PK-3
250 29TH STREET NW, MASSILLON, OHIO 44646

DATE	BY	DESCRIPTION
07/15/23	100%	BID PERMIT SET
08/01/23	100%	ISSUED FOR AS-BUILT

PROJECT NO 2203-1
DRAWN BY MAR
CHECKED BY ARB
DATE

HVAC DETAILS
SCALE: 1/8" = 1'-0"
SHEET NO
M-403