



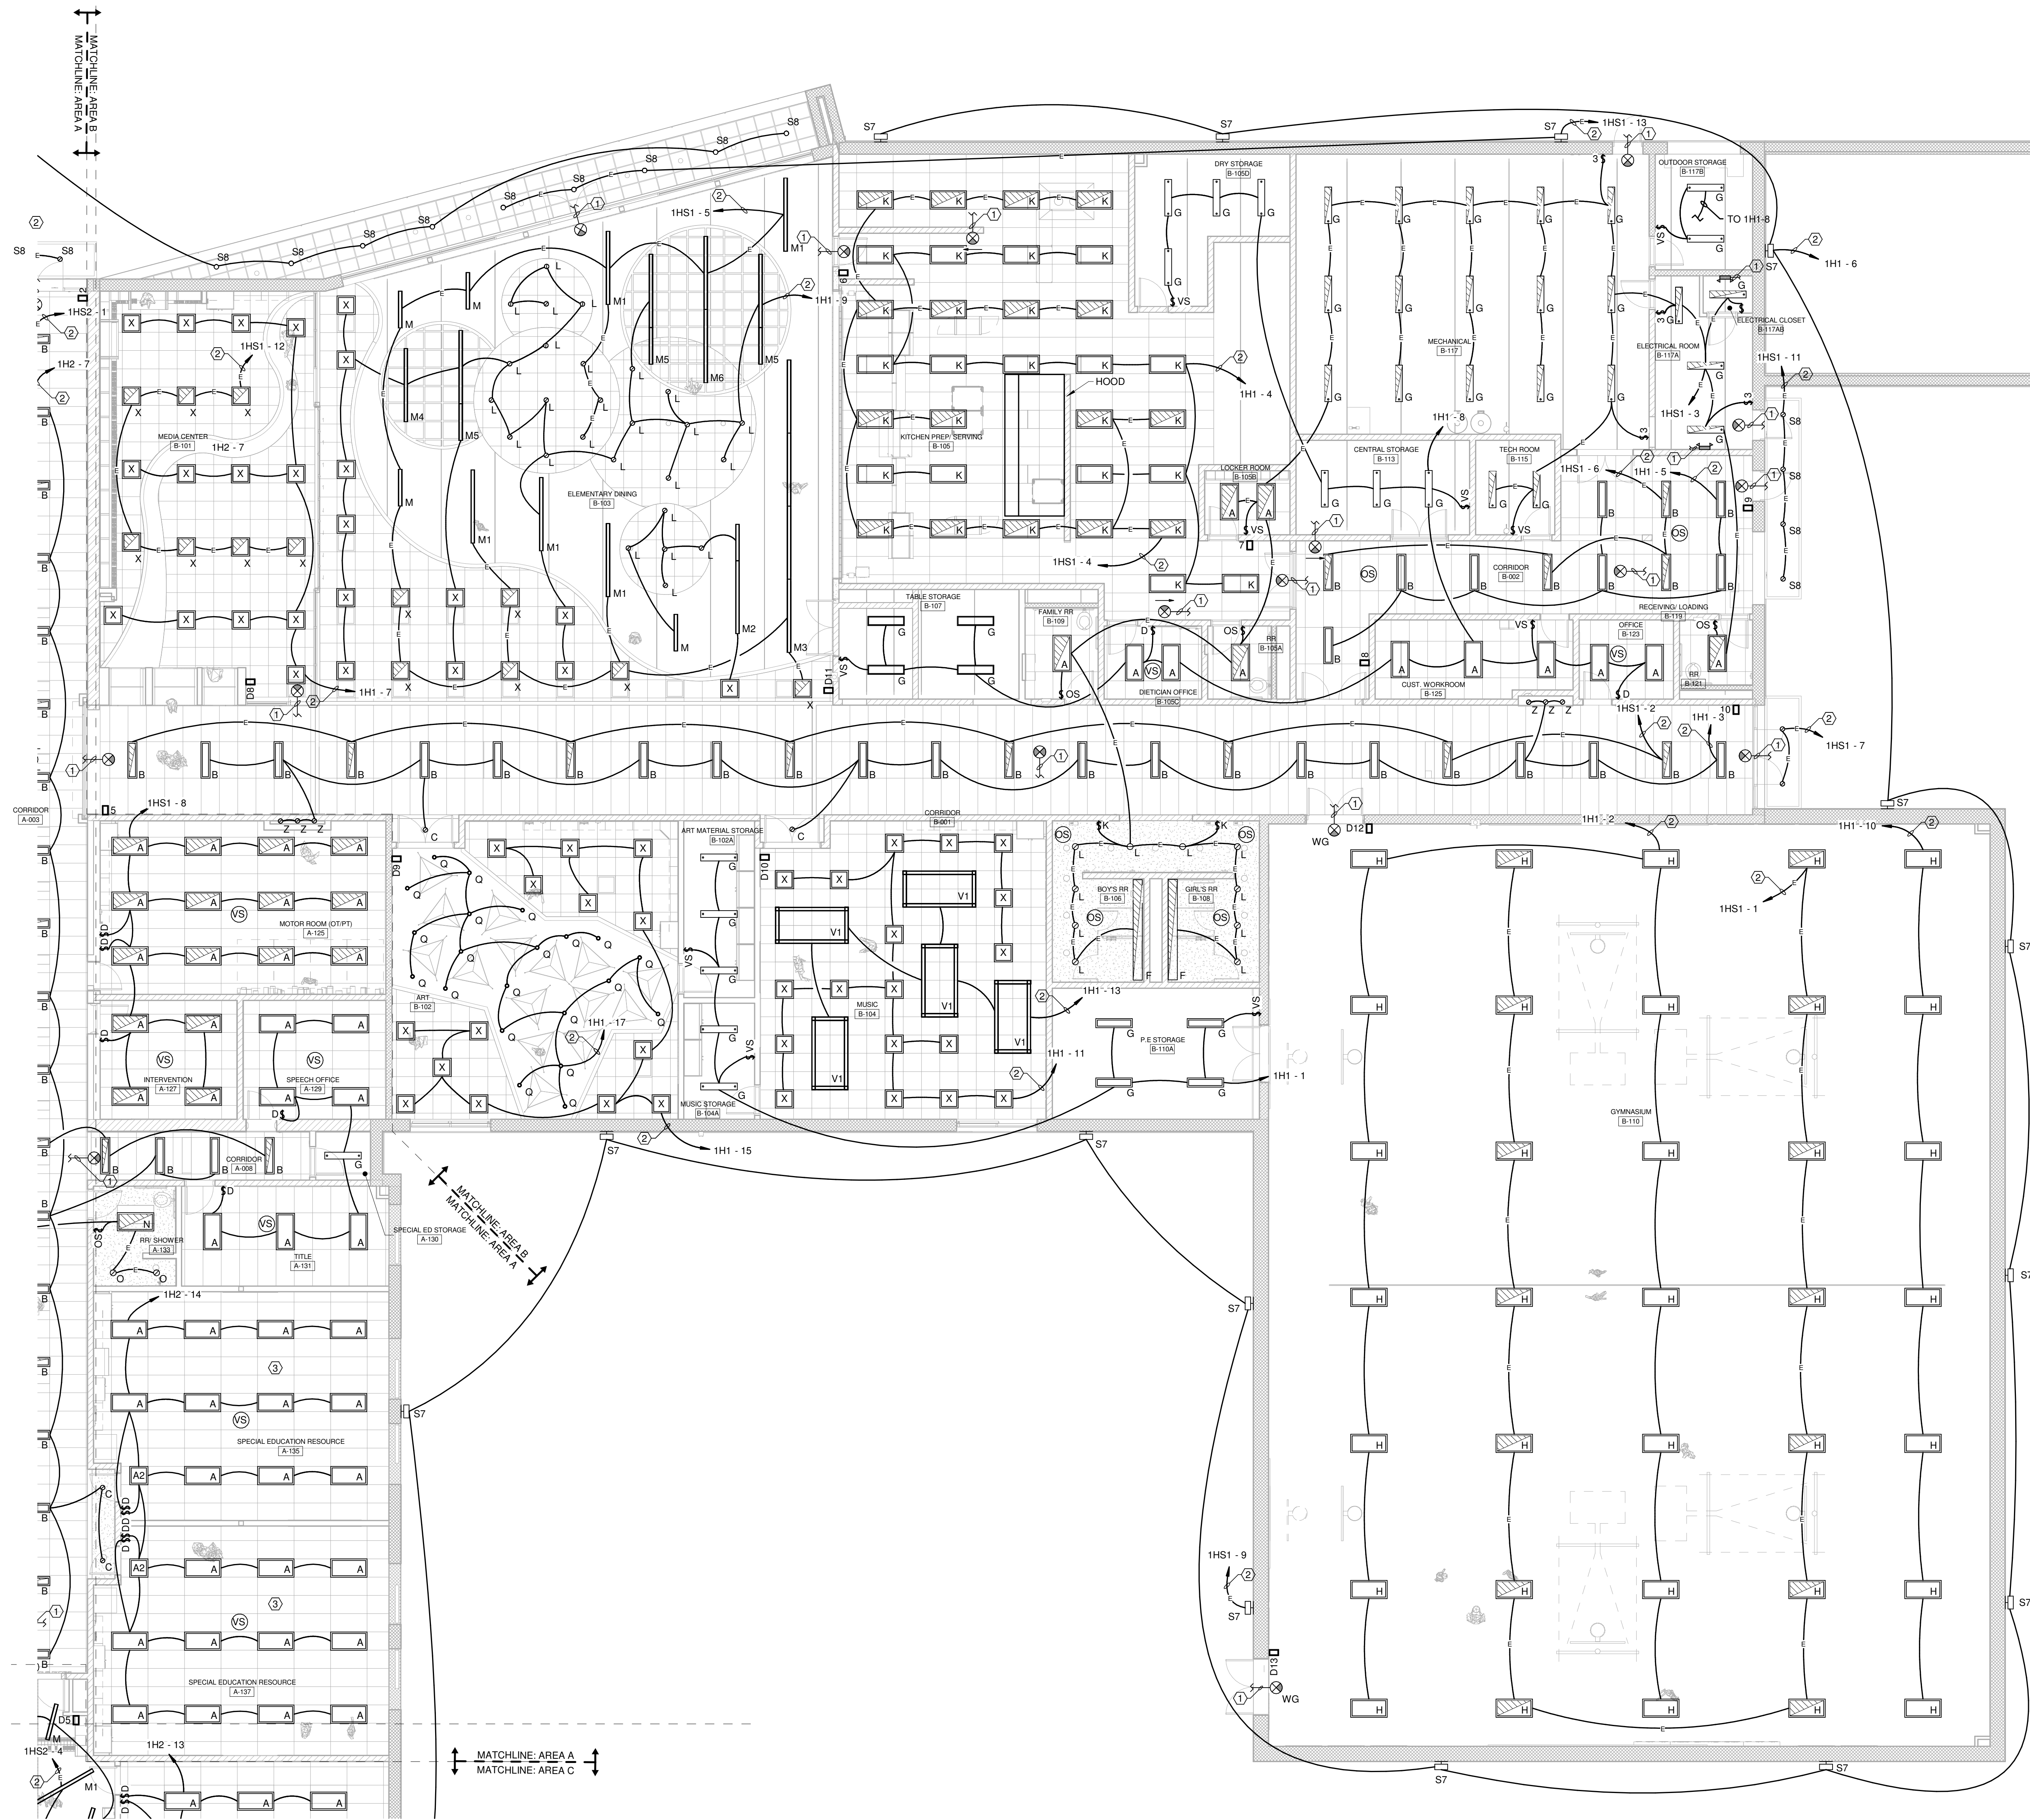


FIRST FLOOR PLAN - LIGHTING - UNIT B
SCALE: 1/8" = 1'-0"

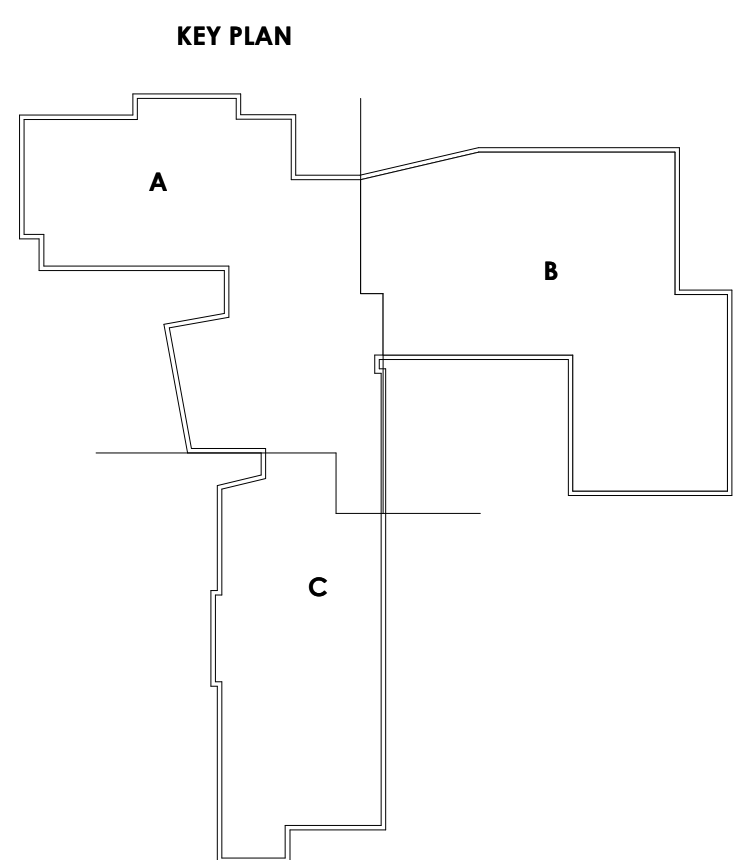


- Hex Notes**
- ① CONNECT TO RESPECTIVE ROOM EMERGENCY LIGHTING CIRCUIT AHEAD OF ALL SWITCHING/RELAYS.
 - ② ROUTE CIRCUIT THROUGH RESPECTIVE LIGHTING CONTROL RELAY PANEL AS REQUIRED. SEE LIGHTING CONTROL RELAY PANEL WIRING DIAGRAMS FOR DETAILS.

PROJECT NO
2203-1

ARCHITECTURAL VISION GROUP, LTD
ARCHITECTS
23850 SPERRY DRIVE
CLEVELAND, OHIO 44145

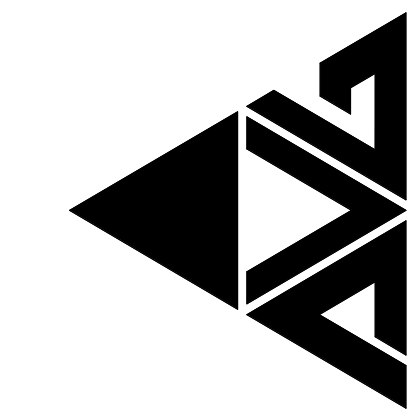

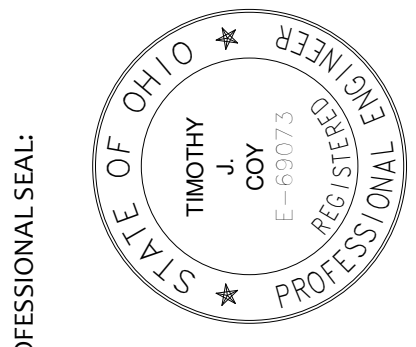



MASSILLON CITY SCHOOL
MASSILLON WEST ELEMENTARY
PK-3
250 29TH STREET NW, MASSILLON, OHIO 44646

DATE	ISSUED AS	DESCRIPTION
07/12/23	ISSUED	ISSUED

PROJECT NO
2203-1
DRAWN BY
WAM
CHECKED BY
TJC
DATE
07/12/23

FIRST FLOOR
PLAN - LIGHTING
- UNIT B
SCALE: 1/8" = 1'-0"
SHEET NO
E-101-B