


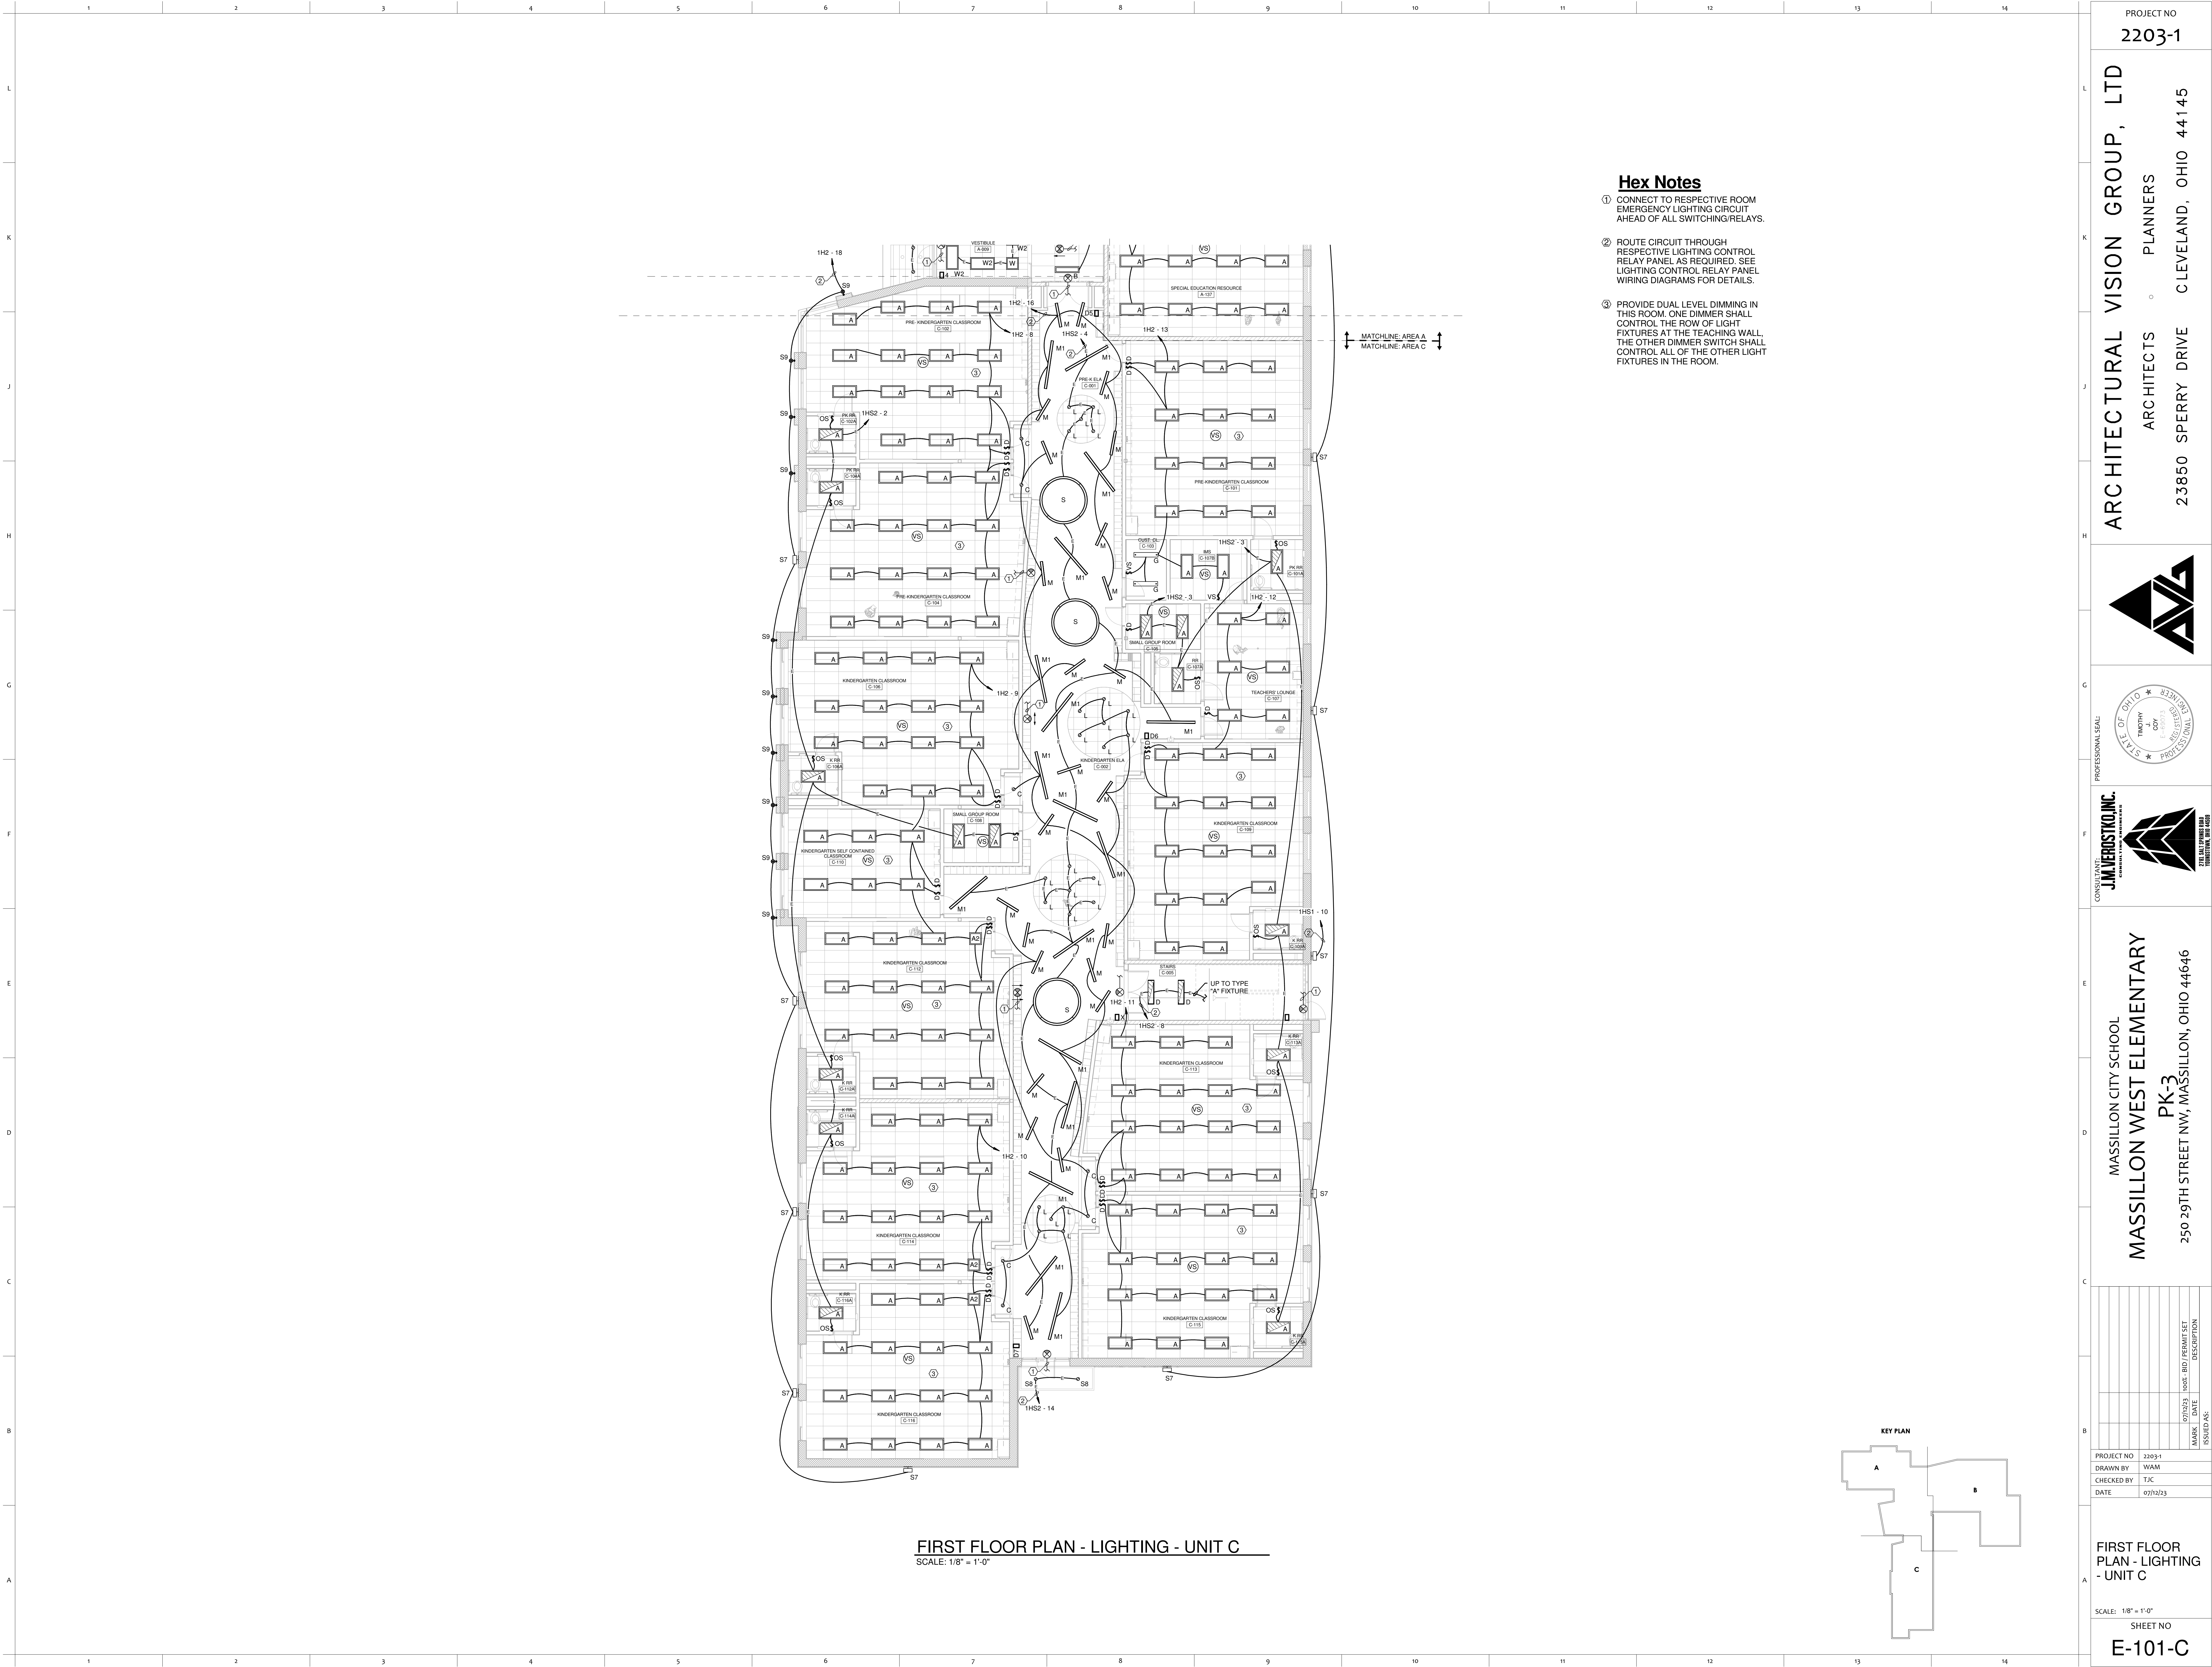




Hex Notes

- ① CONNECT TO RESPECTIVE ROOM EMERGENCY LIGHTING CIRCUIT AHEAD OF ALL SWITCHING/RELAYS.
- ② ROUTE CIRCUIT THROUGH RESPECTIVE LIGHTING CONTROL RELAY PANEL, AS REQUIRED. SEE LIGHTING CONTROL RELAY PANEL WIRING DIAGRAMS FOR DETAILS.
- ③ PROVIDE DUAL LEVEL DIMMING IN THIS ROOM. ONE DIMMER SHALL CONTROL THE ROW OF LIGHT FIXTURES AT THE TEACHING WALL. THE OTHER DIMMER SWITCH SHALL CONTROL ALL OF THE OTHER LIGHT FIXTURES IN THE ROOM.

FIRST FLOOR PLAN - LIGHTING - UNIT C
SCALE: 1/8" = 1'-0"

PROJECT NO
2203-1

ARCHITECTURAL VISION GROUP, LTD
ARCHITECTS
PLANNERS
23850 SPERRY DRIVE
CLEVELAND, OHIO 44145

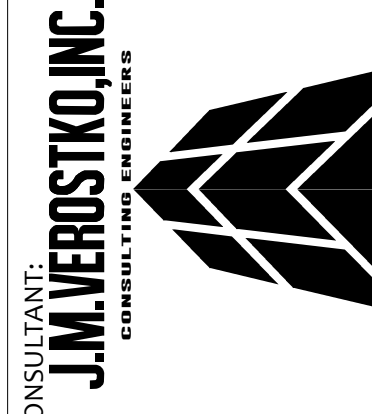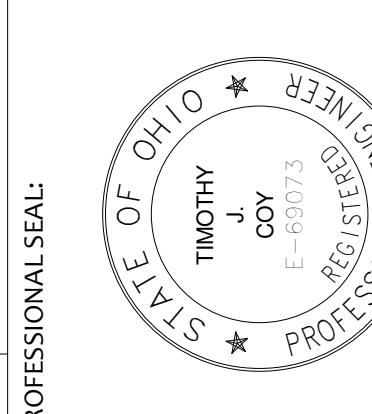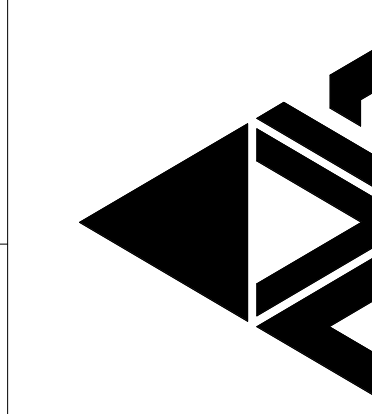

MASSILLON CITY SCHOOL
MASSILLON WEST ELEMENTARY
PK-3
250 29TH STREET NW, MASSILLON, OHIO 44646

DATE	ISSUED AS	DESCRIPTION
07/12/23	ISSUED AS	ISSUED AS

PROJECT NO 2203-1
DRAWN BY WAM
CHECKED BY TJC
DATE 07/12/23

FIRST FLOOR
PLAN - LIGHTING
- UNIT C

SCALE: 1/8" = 1'-0"
SHEET NO
E-101-C