



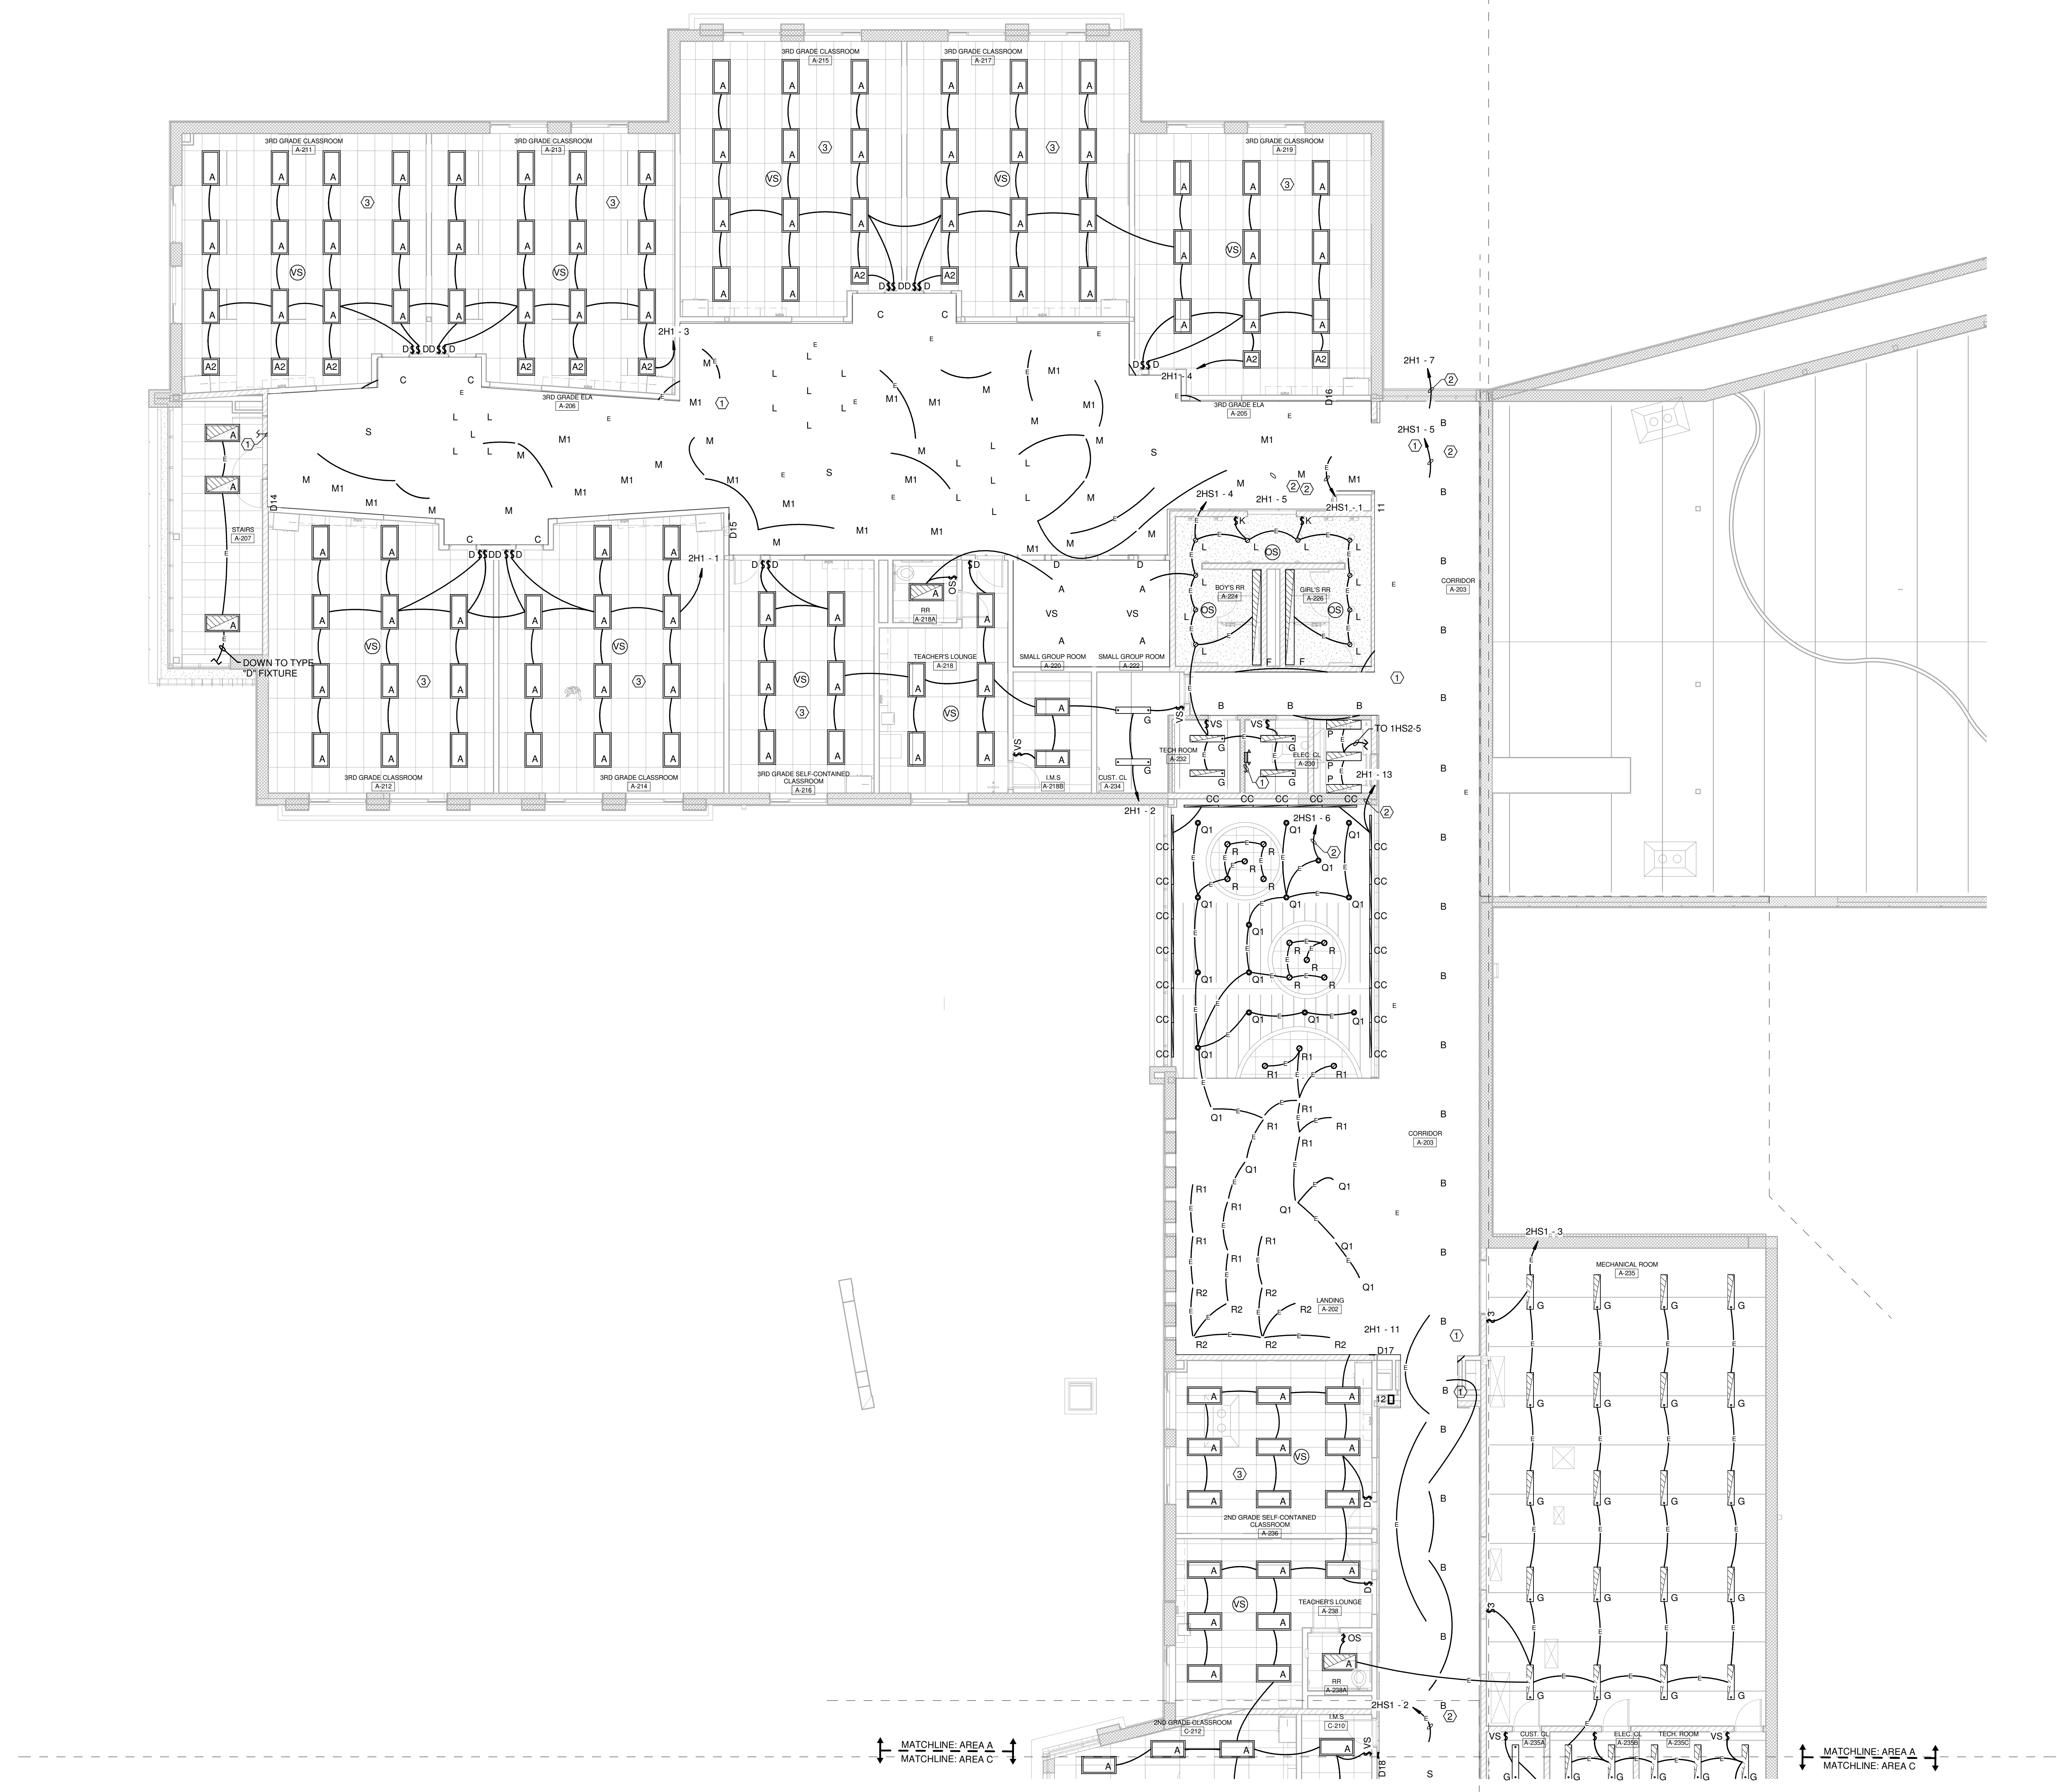


SECOND FLOOR PLAN - LIGHTING - UNIT A
SCALE: 1/8" = 1'-0"

- Hex Notes**
- ① CONNECT TO RESPECTIVE ROOM EMERGENCY LIGHTING CIRCUIT AHEAD OF ALL SWITCHING/RELAYS.
 - ② ROUTE CIRCUIT THROUGH RESPECTIVE LIGHTING CONTROL RELAY PANEL AS REQUIRED. SEE LIGHTING CONTROL RELAY PANEL WIRING DIAGRAMS FOR DETAILS.
 - ③ PROVIDE DUAL LEVEL DIMMING IN THIS ROOM. ONE DIMMER SHALL CONTROL THE ROW OF LIGHT FIXTURES AT THE TEACHING WALL. THE OTHER DIMMER SWITCH SHALL CONTROL ALL OF THE OTHER LIGHT FIXTURES IN THE ROOM.

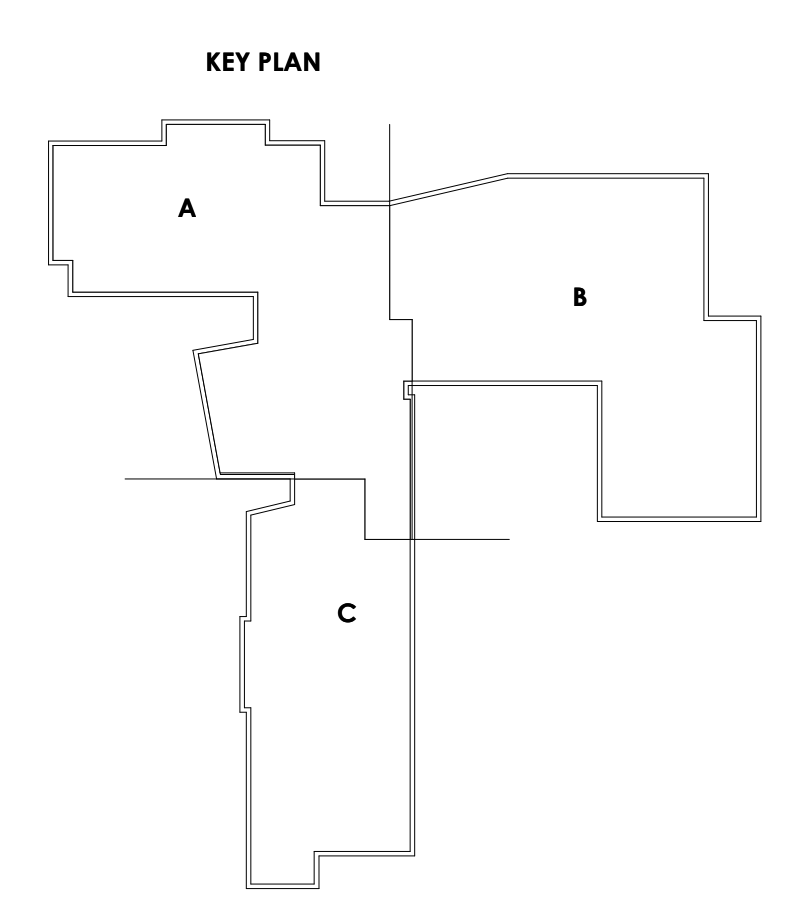


PROJECT NO
2203-1

ARCHITECTURAL VISION GROUP, LTD
ARCHITECTS
23850 SPERRY DRIVE
CLEVELAND, OHIO 44145

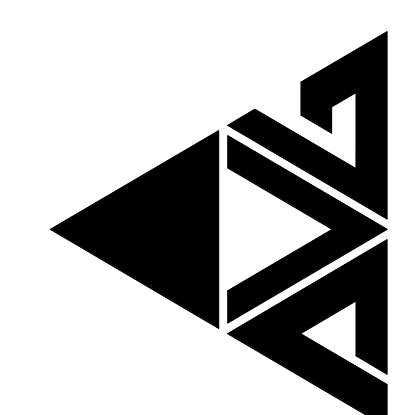



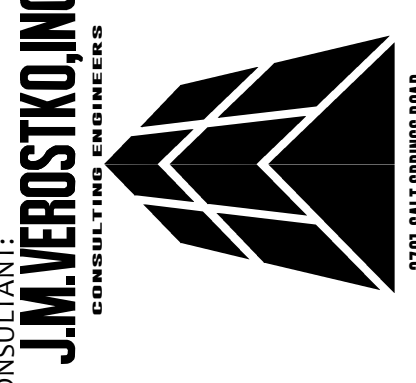

MASSILLON CITY SCHOOL
MASSILLON WEST ELEMENTARY
PK-3
250 29TH STREET NW, MASSILLON, OHIO 44646

DATE	ISSUED BY	DESCRIPTION
07/12/23	WAM	ISSUED AS

PROJECT NO
2203-1

DRAWN BY
WAM

CHECKED BY
TJC

DATE
07/12/23

SECOND FLOOR
PLAN - LIGHTING
- UNIT A

SCALE: 1/8" = 1'-0"

SHEET NO
E-102-A